




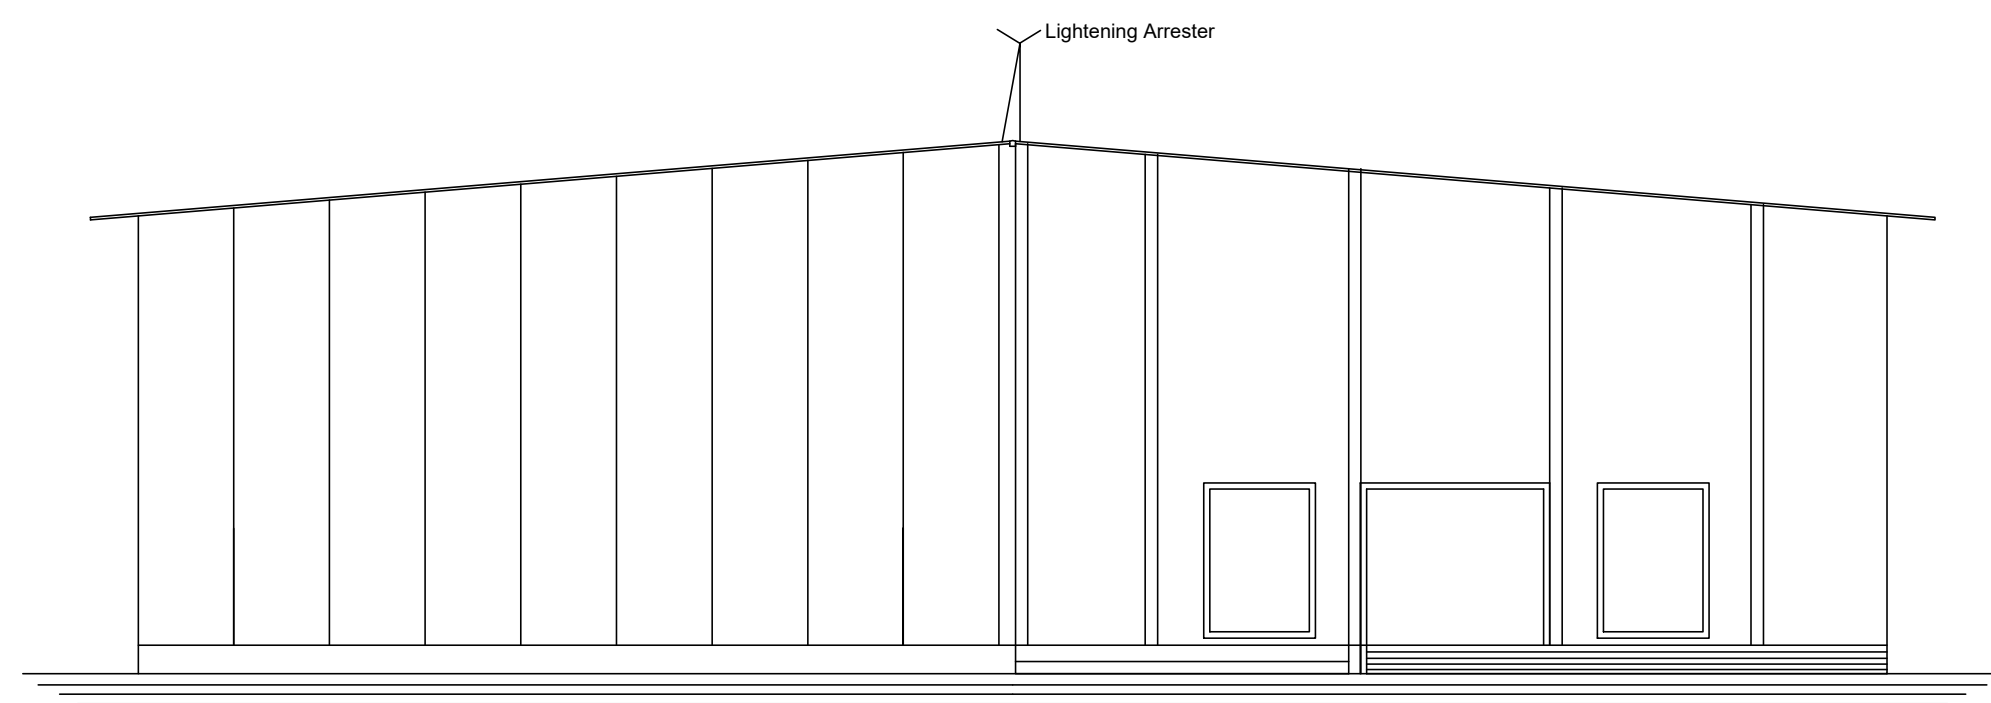


FRONT ELEVATION

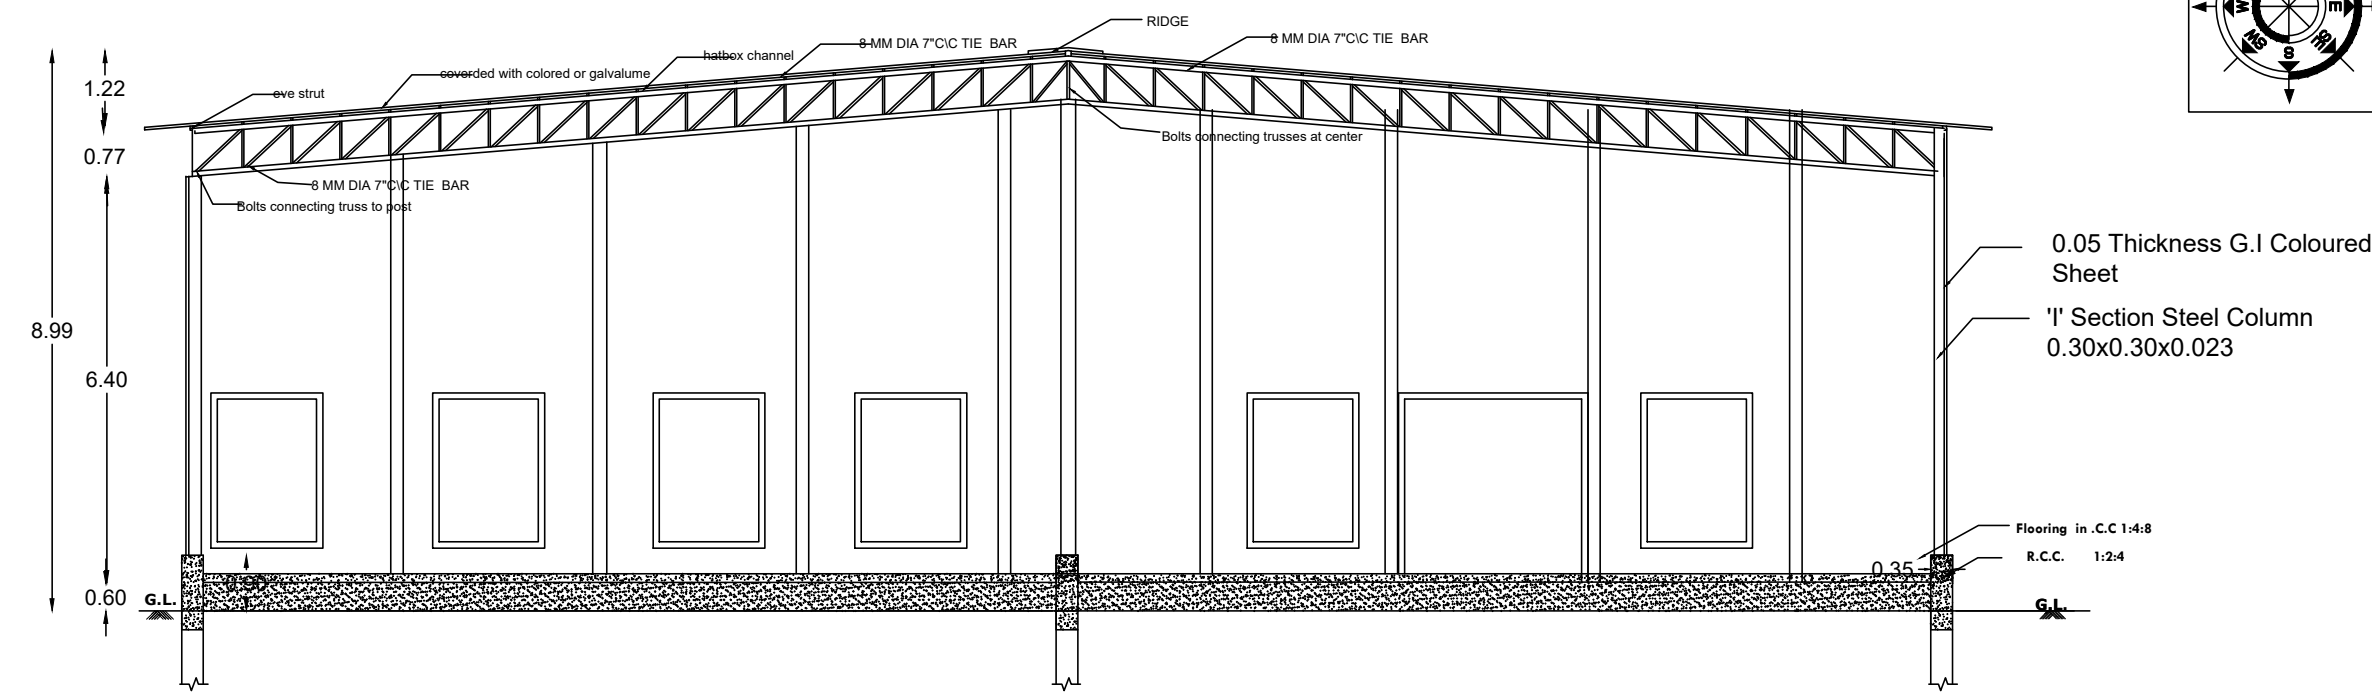

SECTION ON A-B

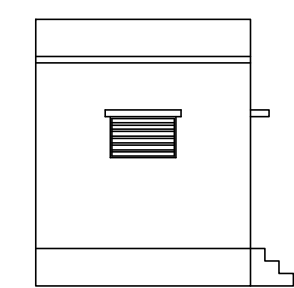


ELEVATION




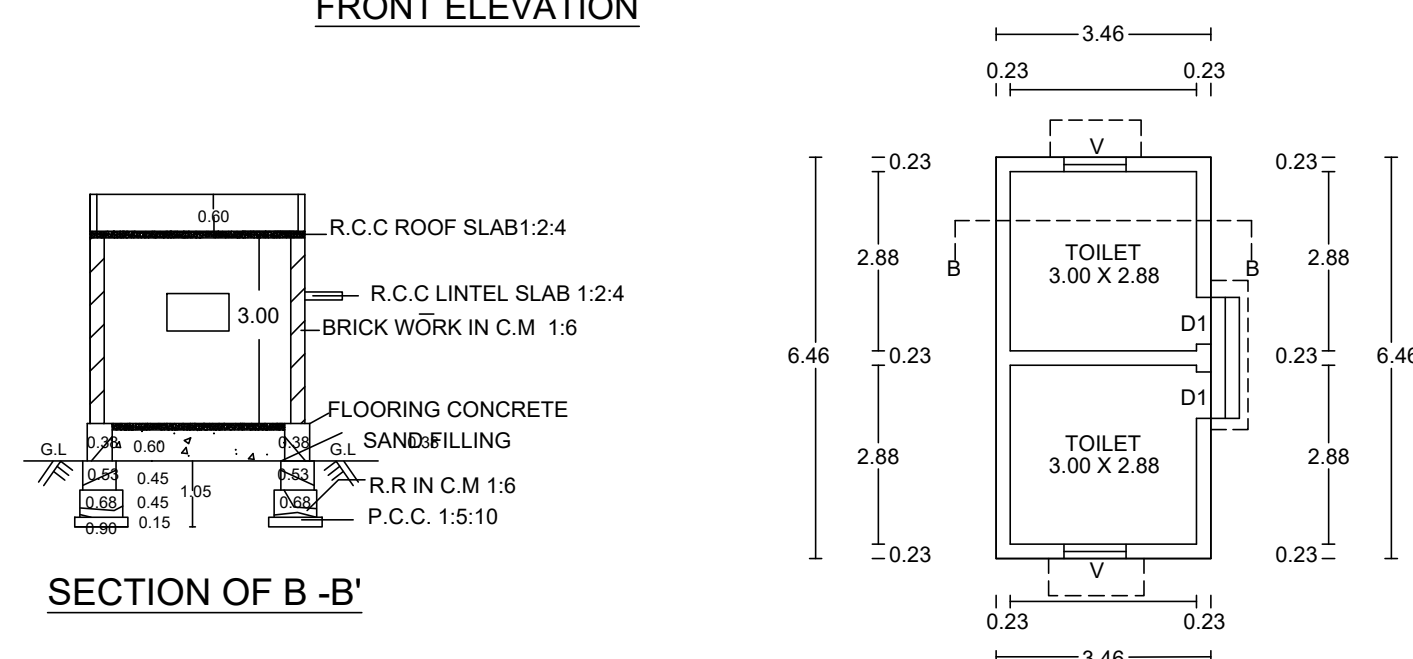


SECTION OF B-B'


GROUND FLOOR TOILET PLAN

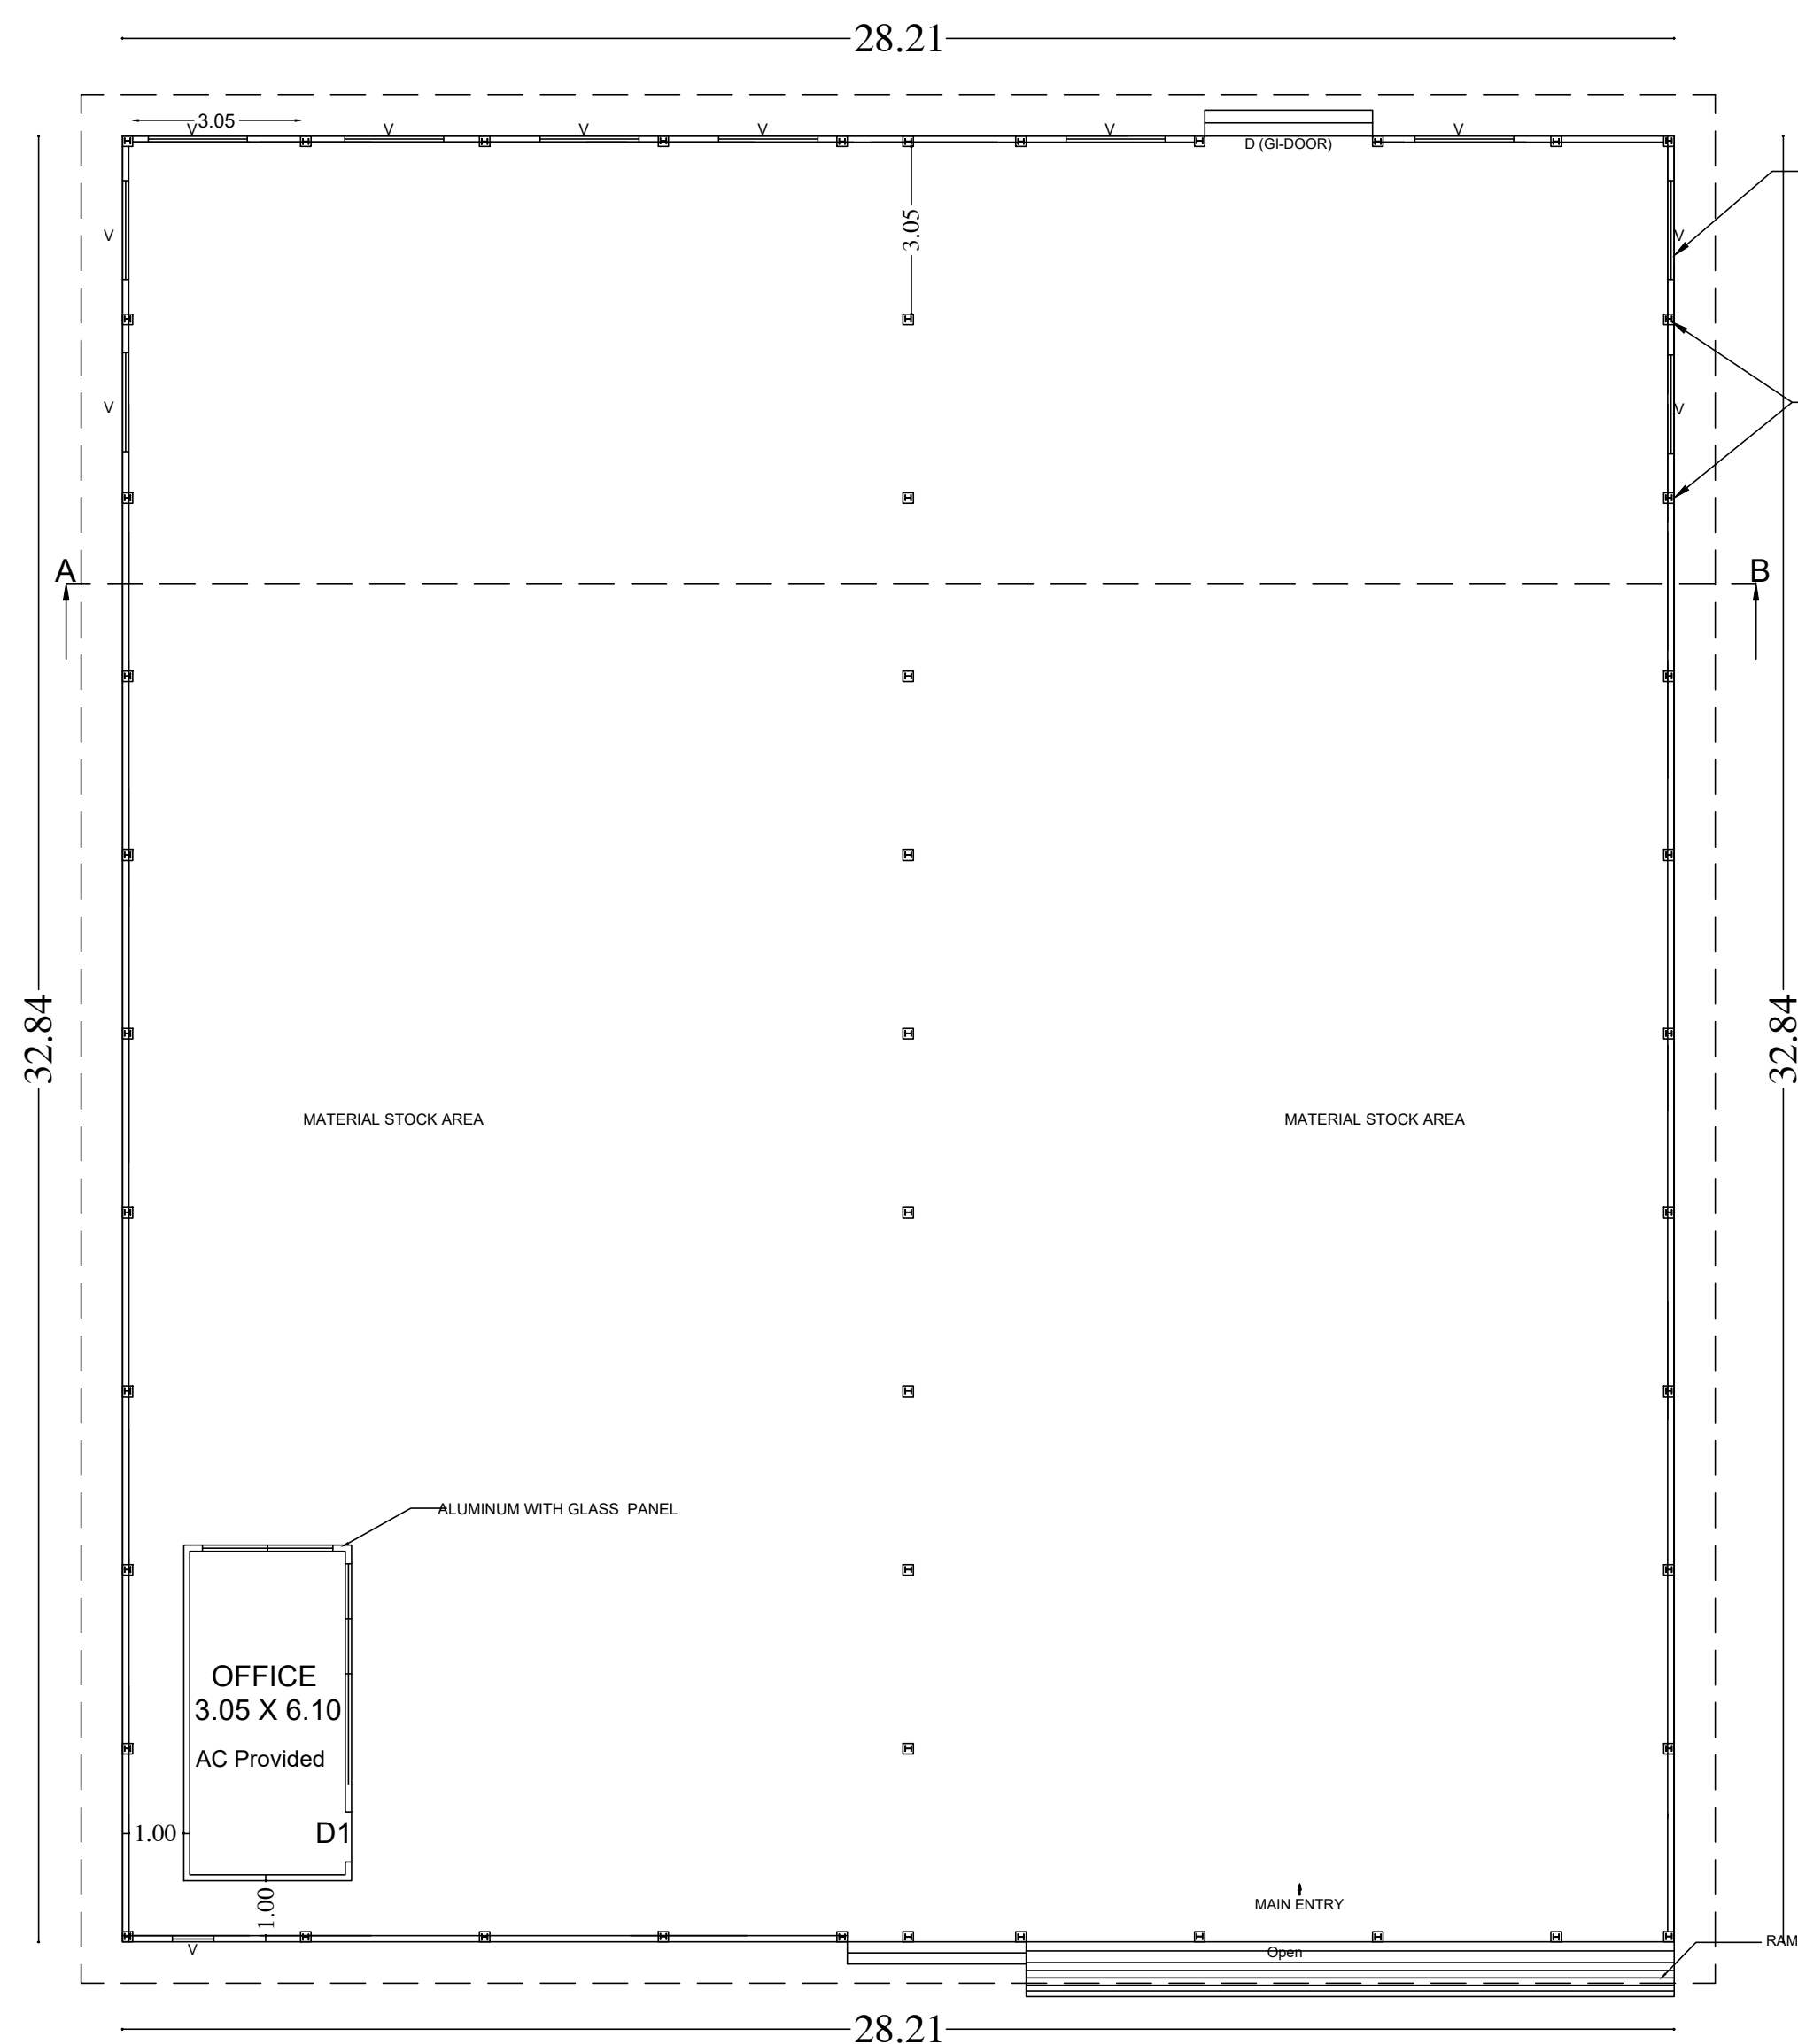

GROUND FLOOR PLAN

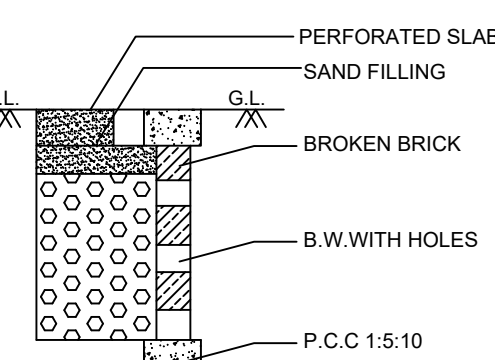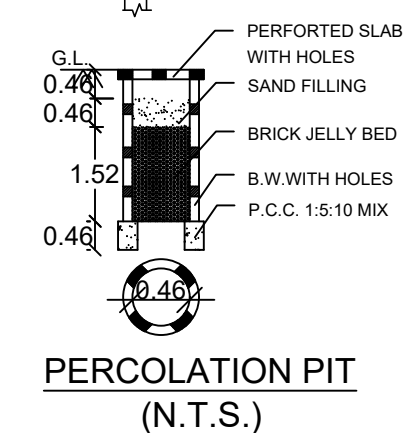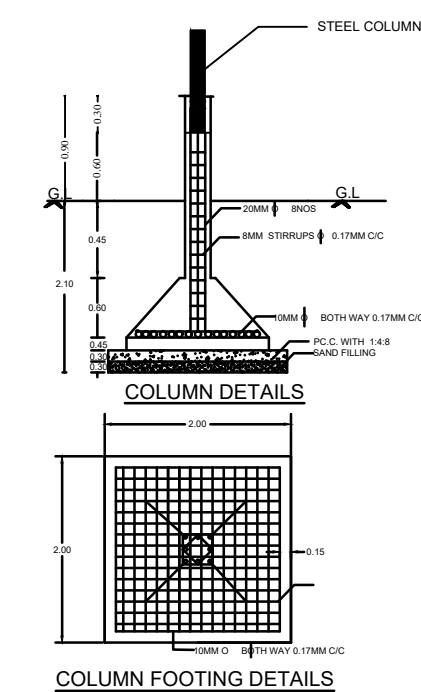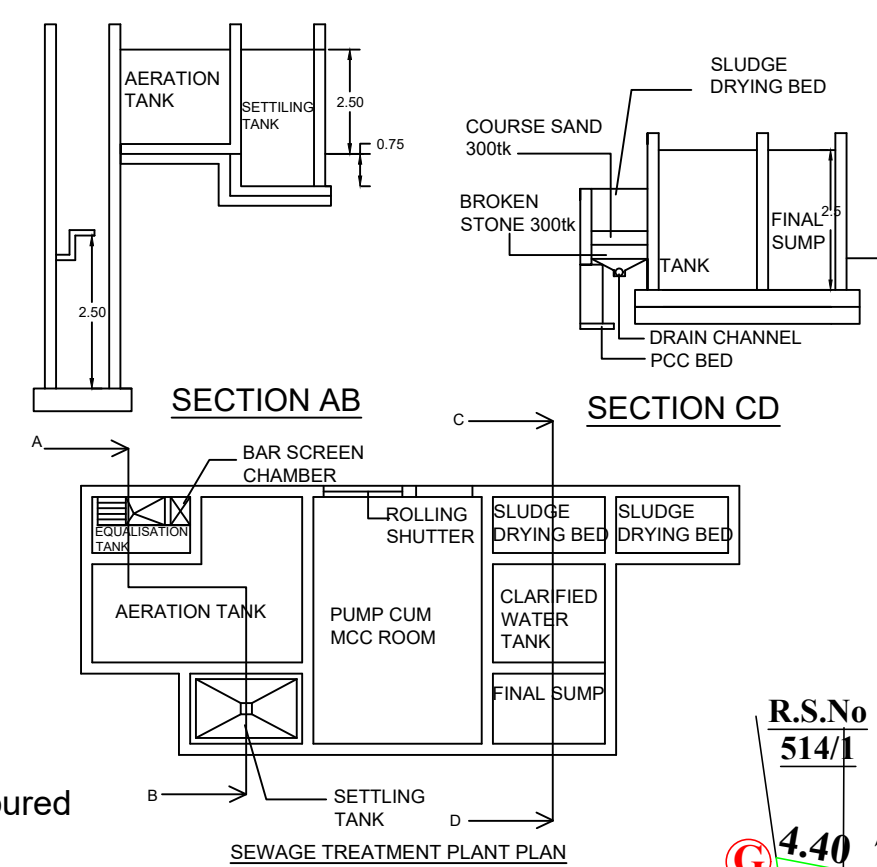

RAIN WATER PERCOLATION (N.T.S.)

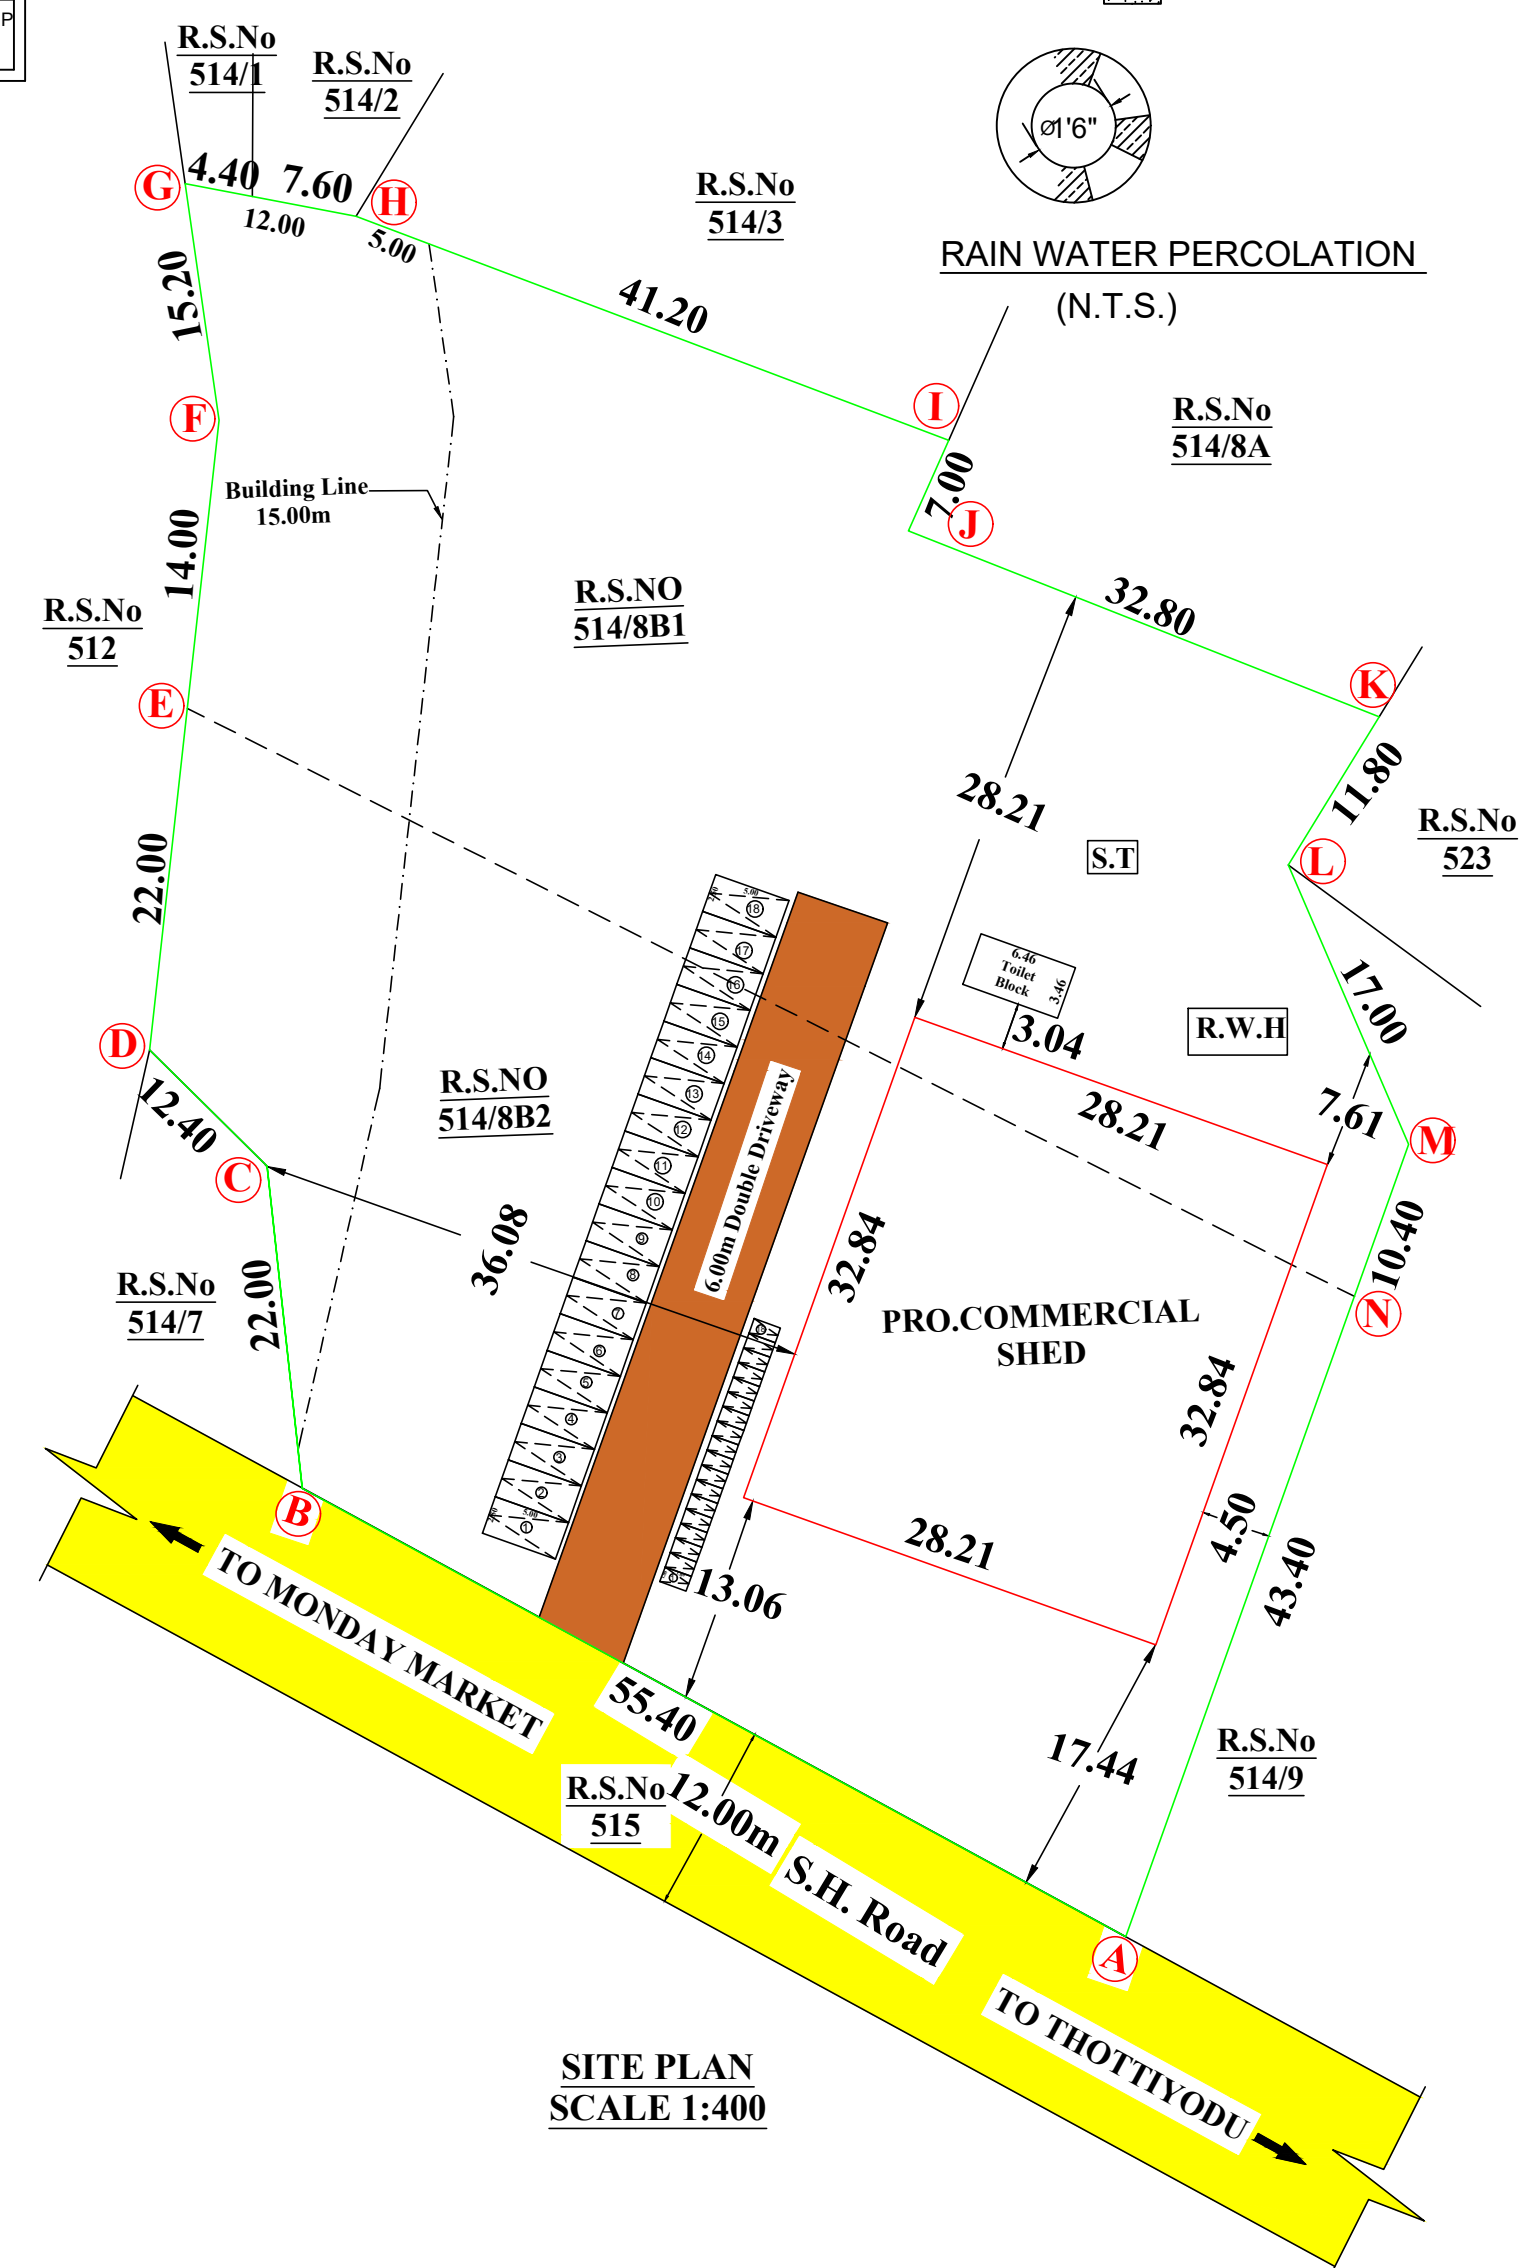

SITE PLAN SCALE 1:400

PLAN SHOWING THE PROPOSED CONSTRUCTION OF COMMERCIAL BUILDING (RETAIL SHOP) , IN Re.Sy.No: 514/8B1,514/8B2, OF ERANIAL VILLAGE, AT ERANIAL, ERANIAL TOWN PANCHAYAT, KALKUKAM TALUK , KANYAKUMARI DISTRICT.

Name of the Owners : 1. S.MOHAMED FAYAZ ,2. S.MOHAMMED FAROOQ .

AREA DETIALS

SITE AREA : 5467 Sq.m (58847 Sq.ft)

	FSI AREA in Sq.m	NON FSI AREA in Sq.m	TOTAL AREA in Sq.m
GROUND FLOOR AREA (SHOP)	926.41	-	926.41
GROUND FLOOR AREA (TOILET)	22.35	-	22.35
TOTAL FLOOR AREA	948.76	-	948.76

FLOOR AREA RATIO: 948.76 / 5467 = 0.17 < 2.00	PLOT COVERAGE RATIO PC - 948.76/100 = 17.35% 5467	PARKING CALCULATION: TOTAL FSI AREA (PARKING AREA) = 948.76 SQ.M REQUIRED PARKING : 1 Car Space and 1 Two Wheeler Space For Every 50.00 Sq.m CAR SPACE 1ST 50 SQ.M NIL REQUIRED PARKING = 898.76 / 50 = 17.97 SAY 18 NOS REQUIRED TWO WHEELER PARKING=898.76/50 = 17.97 = 18 NOS PROVIDED CAR PARKING = 18 NOS PROVIDED TWO WHEELER PARKING = 18 NOS.
AL L DIMENSION ARE IN METERS	SCALE 1 : 100 SITE PLAN = 1:400	
SCHEDULE OF JOINERIES :		

D	GL-DOOR	3.05 X 3.05
D1	GLASS DOOR	0.90X 3.05
D2	TOILET DOOR	0.75 X 2.50
V	VENTILATOR	1.80 X 2.50

COLOUR INDEX

SITE BOUNDARY	—
ROAD / STREET	—
PROPOSED BUILDING	—
DRIVEWAY	—

NOTES:

1. RAIN WATER HARVESTING RECYCLING IS TO BE PROVIDED.
 2. BATH ROOM AND WASHBASIN RECYCLING WATER SYSTEM IS TO BE PROVIDED.
 3. FIRE EXTINGUISHER IS TO BE PROVIDED.
 4. EMERGENCY ALARM IS TO BE PROVIDED.
 5. SOLAR ASSITED WATER HEATING SYSTEM IS TO BE PROVIDED.
 6. WASTE WATER COLLECTED TO SUMP AND DISPOSED BY PRIVATE SEWAGE TRUCKS.
 7. SOLID WASTE DISPOSED BY MUNICIPAL TRUCKS.
 8. RAIN WATER PERCOLATION PIT IS TO BE PROVIDED.
 9. DRINKING WATER PROVIDED AS PER MUNICIPAL NORMS.
 10. 'U' TRAP PROVIDED & OR SEPTIC TANK AND WATER TANK.
 11. SEWAGE TREATMENT PLANT TO BE PROVIDED.
- F.E - FIRE EXTINGUISHING SYSTEM.
E.A - EMERGENCY ALARAM.
P.P - PERCOLATION PIT.

CERTIFICATE
Certified that provision shall be made to providerain water harvesting arrangements system in the proposed construction.

ONLINE APPLICATION :SWP/BPA/011834/2023

SWP/B.P/ADKKD.NO: 60 /2023

1. Mr.S.MOHAMED FAYAZ
 2. Mr.S.MOHAMMED FAROOQ
- S/o.Mr.SAFI MOHAMED.
2/60A, Mela Thathiyatrakulam
Nagercoil-629001

APPLICANT

OFFICE USE ONLY:

U. Sunil Prem
Registered Construction Engineer
Reg. No: RCE/NLPA/2020/011

CONSTRUCTION ENGINEER

R. VENKADESH, B.E.,
Registered Engineer Gr.III
RE-III/KKDTCP/001/2022
S.E. CONSTRUCTION
M.M. Plaza, Beach Road Jn., Ngl-2
Cell : 9444535448

REGISTERED ENGINEER