
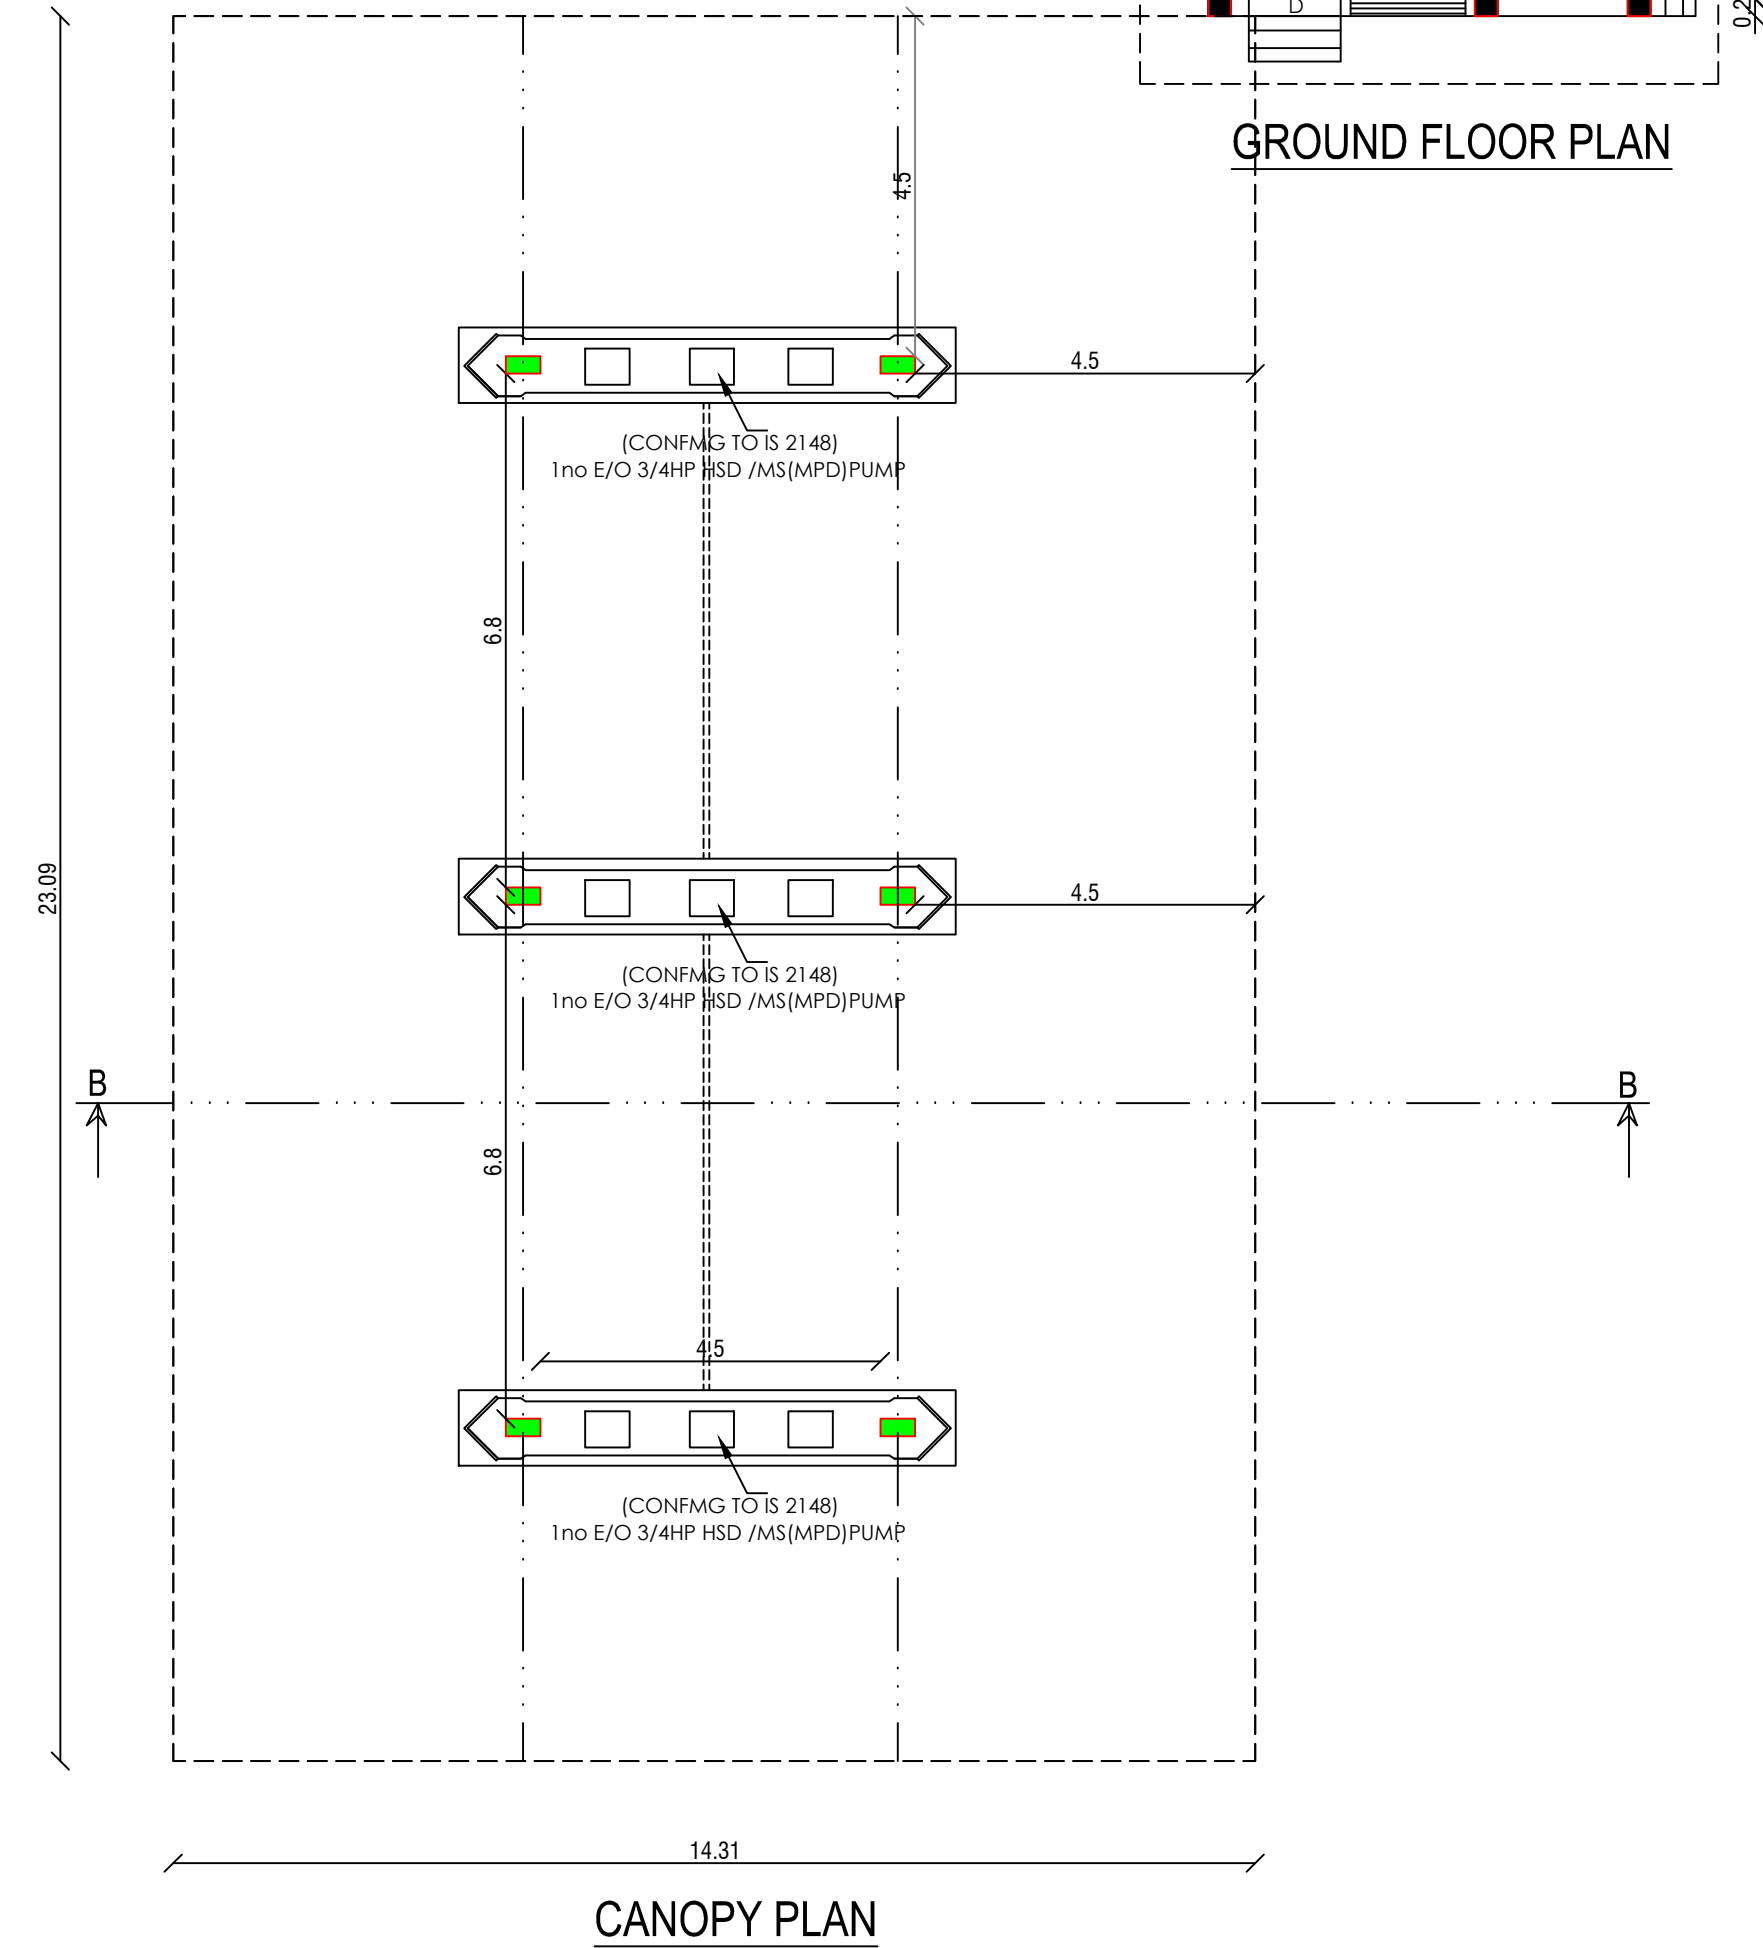
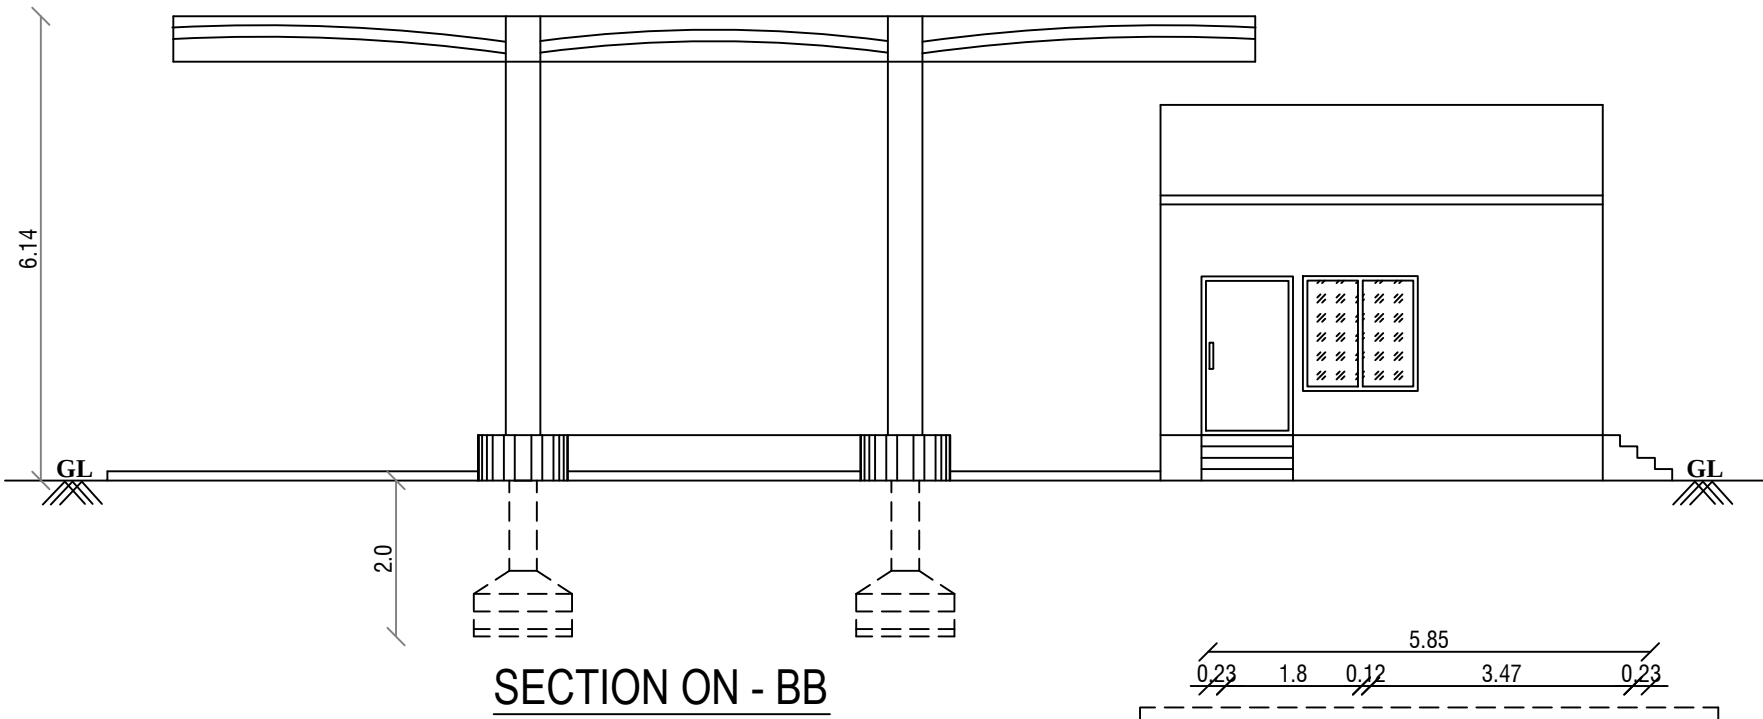


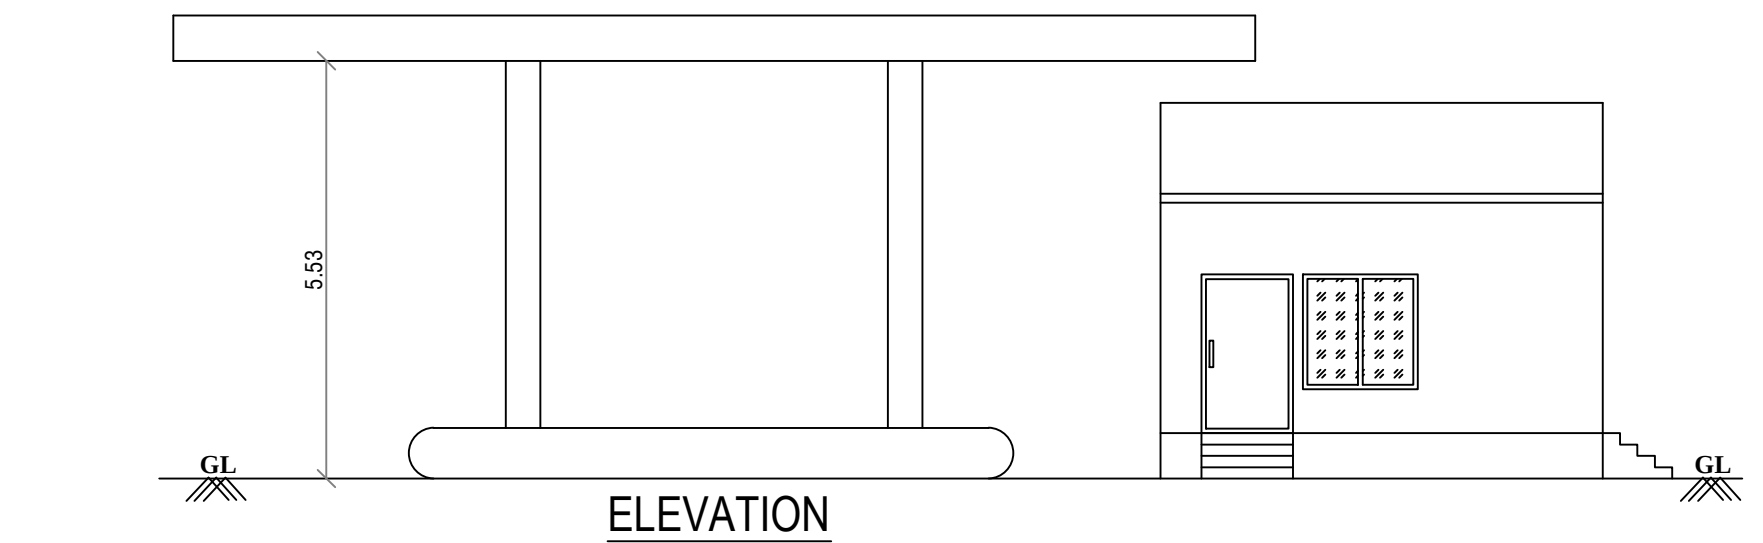

MEACHINER & HP DETAILS			
SL.NO	MEACHINER & HP (EACH)	NOS	HP
1	H.S.D.OUTLET / 1.50HP /20K.L	2	3.00
2	M.S.OUTLET / 1.50HP /10K.L	1	1.50
3	H.S.D.OUTLET / 1.50HP /45K.L	1	1.50
TOTAL HP		4	6.00

JOINERY DETAILS:			
D	- DOOR	1.22 x 2.10	
D1	- DOOR	0.91 x 2.10	
D2	- DOOR	0.76 x 2.10	
W	- WINDOW	0.91 x 1.22	
V1	- VENTILATOR	0.91 x 0.61	
V2	- VENTILATOR	0.56 x 0.61	

NOTE :-

- ALL DIMENSIONS ARE IN "METRE", SCALE 1:100
- WASTE WATER USED FOR GARDEN
- FIRE EXTINGUISHER TO BE PROVIDED
- EMERGENCY ALARM TO BE PROVIDED
- DRINKING WATER TO BE PROVIDED

1. 2nos OF FIRE EXTINGUISHERS AT EACH PUMP ISLAND AND 12nos SAND BUCKETS PAROVEDE AT SITE

2. 'NO SMOKING' BOARD DISPLAYED AT SITE

3. EXTRACT OF PETROLEUM RULES EXHIBITED AT SITE



4. EXPLOSIVE DEPT. LICENCE NO.DISPLAYED AT SITE

ALL PUMP ARE ELECTRICALLY OPERATED CONFIRMS TO IS2418







ALL PUMP 4.0m HIGH ABOVE GROUND LEVEL AND FREE ENDS COVERED WITH 2LAYERS OF NON CORRSIVE WIRE GUAGE

11MESH/LCM

SOLAR SYSTEM WATER TANK TO BE PROVIDE

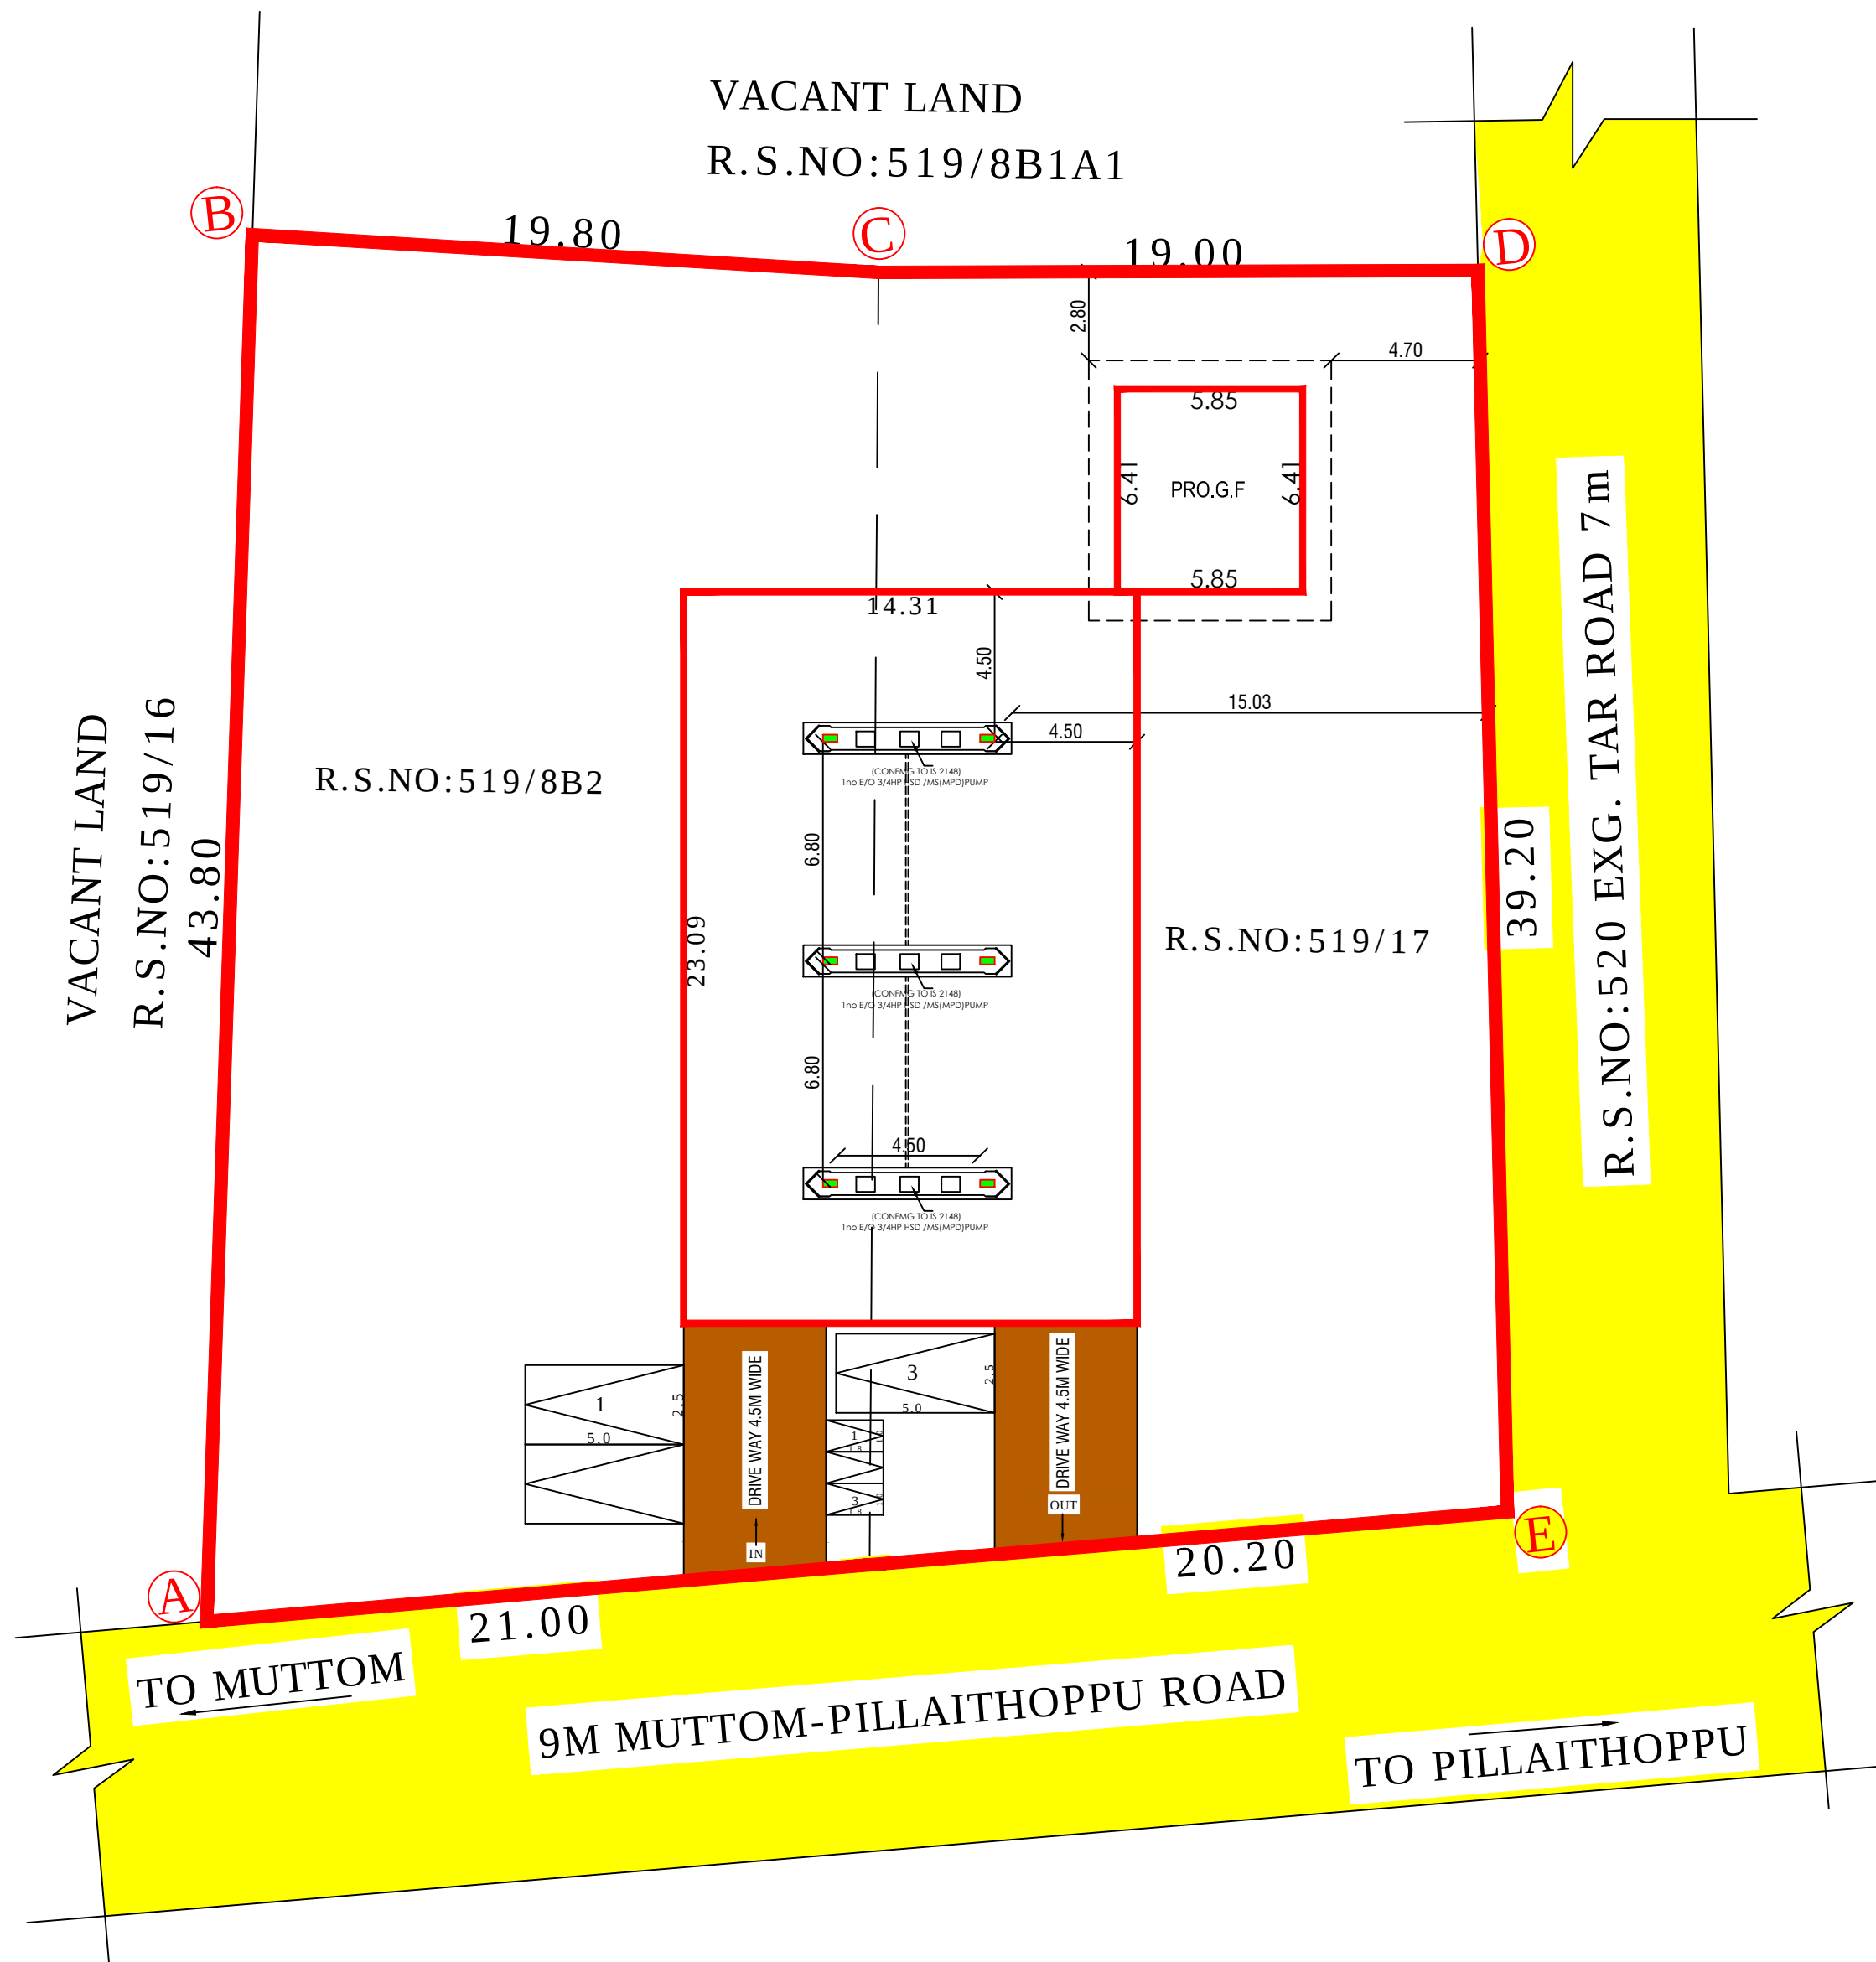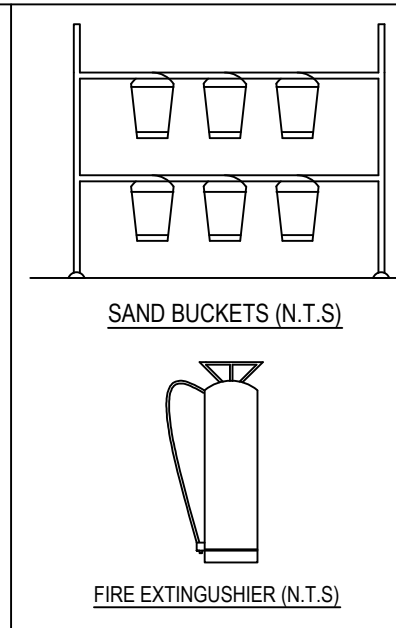

SITE PLAN
SCALE 1:200

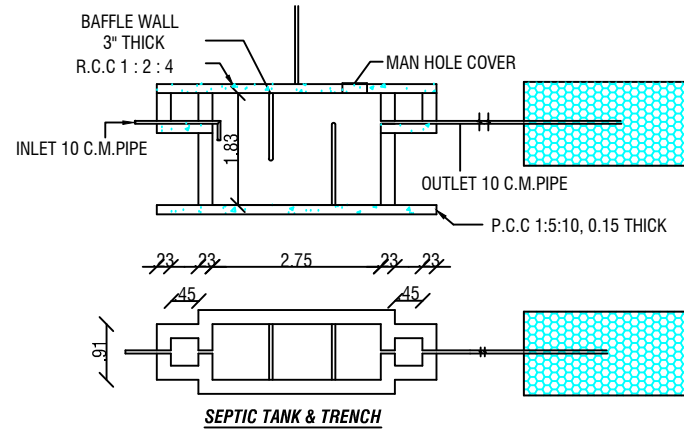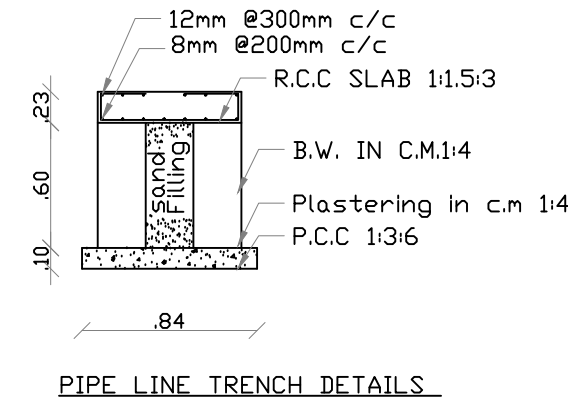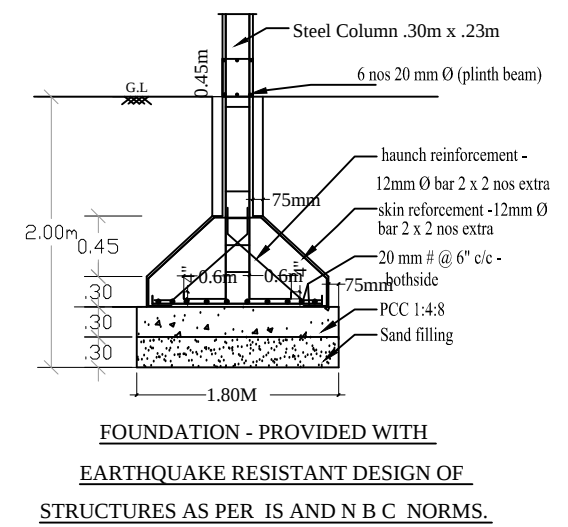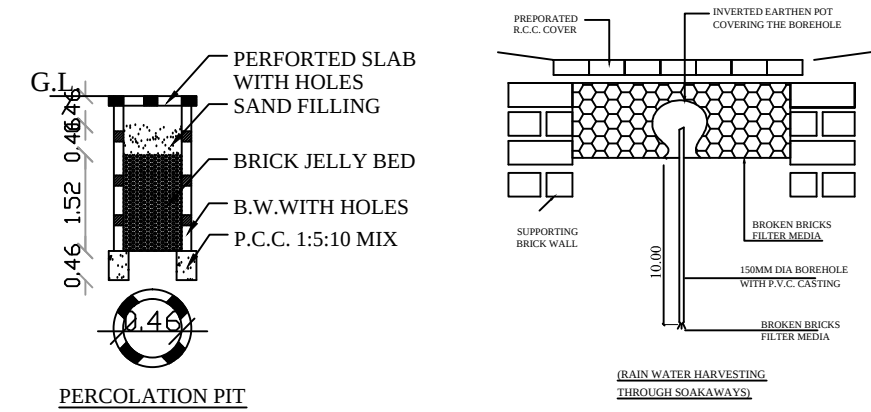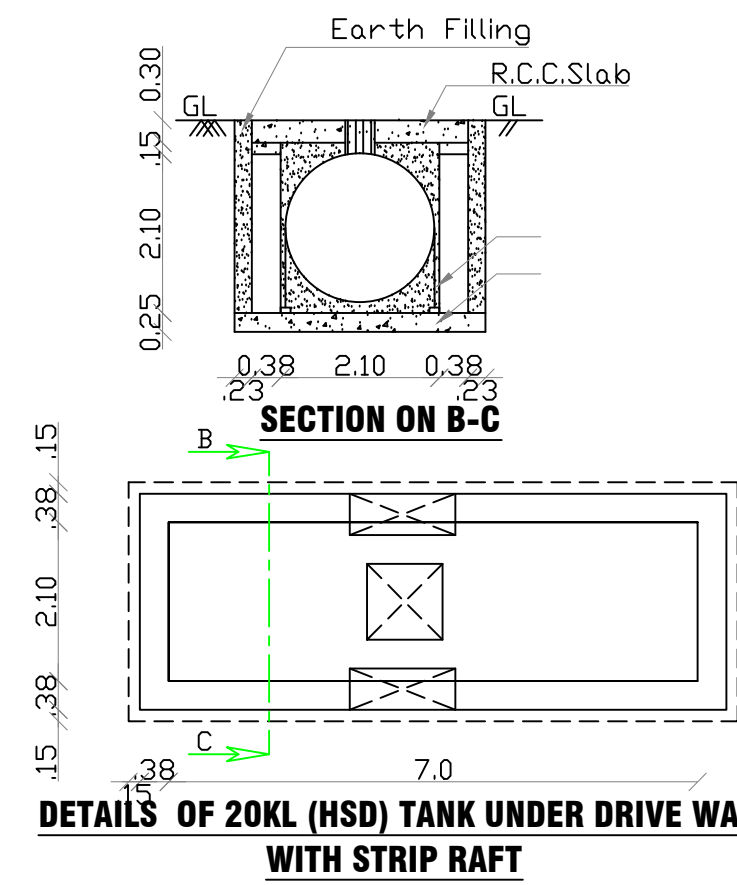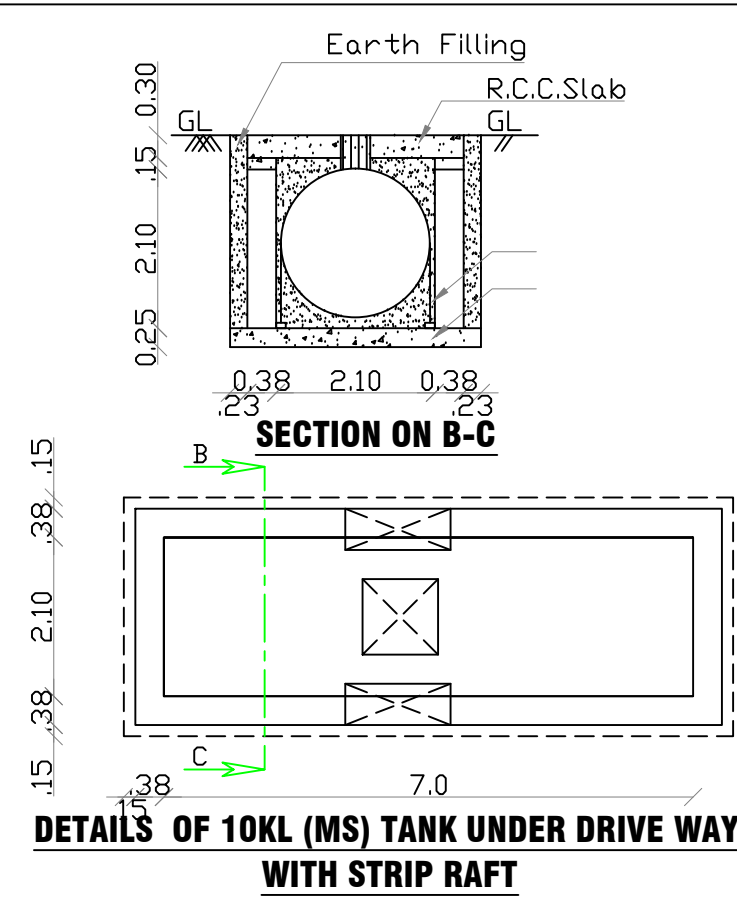

PLAN SHOWING THE PROPOSED CONSTRUCTION OF PETROL RETAIL SHOP IN R.S.NO:519/8B2, 519/17 OF KADIYAPATINAM VILLAGE AND MUTTOM PANCHAYAT, KALKULAM TALUK, KANYAKUMARI DISTRICT.			
ALL DIMENSIONS ARE IN METER, SCALE 1:100, 1:200			
COLOR CODE	AREA DETAILS	SQ.M	SQ.FT
	SITE AREA	1618.00	17416.15
PRO.BUILDING AREA DETAILS			
	CANOPY AREA	330.42	3556.64
	OFFICE BUILDING AREA	37.50	403.65
	TOTAL BUILDING AREA	367.92	3960.29
	OPEN SPACE AREA	1250.08	13455.86
	DRIVE WAY		
	EXISTING ROAD		
FLOOR AREA RATIO		PARKING AREA CALCULATION	
= TOTAL FLOOR AREA / SITE AREA		TOTAL PLINTH AREA 367.94 SQ.M (367.92 x 0.75) / 100 = 2.75 = SAY 3	
= 367.92 / 1618.00 = 0.227 < 2.0		REQUIRED PARKING = 3 CAR & TWO WHEELER PROVIDED PARKING = 3 CAR & TWO WHEELER	

ONLINE APPLICATION NO. SWP/BPA/022678/2023
SWP/BP/ADKKD NO. 73/2023

OFFICE USE (ONLY)

APPLICANT

P. K. Thameemul Ansari, B.E., M.E.
Reg.No: RE-1/KKDOTCP/013/2022
729, Jubilee Complex, M.S. Road
Vadasery, Nagercoil, Kanniyakumari

REG.ENGINEER