

SITE PLAN SHOWING THE PROPOSED CONSTRUCTION OF SENTHIL PUBLIC SCHOOL (CBSE) IN S.F NO:210/1A2,215/1B, 216/2D2,216/2E2, AT KATTINAYNAPALLI VILLAGE & PANCHAYAT, KRISHNAGIRI PANCHAYAT UNION & TALUK,KRISHNAGIRI DISTRICT

SCALE:1:400 ALL DIMENSIONS ARE IN METRE

SITE AREA DETAILS:	S.F. NO	HECTARE
	210/1A2	0.01.50
	215/1B	0.02.93
	216/2D2	0.02.63
	216/2E2	0.74.08
	TOTAL	0.81.14

TOTAL AREA	0.81.14 Hectare
FMB AREA	0.81.14 Hectare
DOCUMENT AREA	0.81.14 Hectare.

PROPOSED BUILDING AREA	FSI SQ.MT	NON FSI SQ.MT	TOTAL SQ.MT
GROUND FLOOR	2366.96		2366.96
FIRST FLOOR	2201.21		2201.21
SECOND FLOOR	2192.47		2192.47
THIRD FLOOR	2192.47		2192.47
FOURTH FLOOR	2192.47		2192.47
TERRACE FLOOR		122.27	122.27
TOTAL	11145.58	122.27	11267.85

Notes:-

All Dimension are in meter

OPEN SPACE RESERVATION 10%(PARK)-812.56(10.01%)


FE - FIRE EQUIPMENT
FA - FIRE ALARM
SB - SAND BUCKET
ALROUND FIRE FIGHTING PIPE LINE
FIRE FIGHTING SUMP & WATER TANK PROVIDED

PARKING DETAILS	AREA	CAR		TWO WHEELER		CYCLE	
		REQUIRED	PROVIDED	REQUIRED	PROVIDED	REQUIRED	PROVIDED
CLASS ROOM AREA	3256.55	11	11	66	66	652	690
ADMINISTRATION AREA	285	3	3	6	6	57	63
TOTAL AREA	4132	REGULAR +DA	12+2=14	72	72	709	753



REFERENCE:
CAR PARKING - 12
DA PARKING - 2
TWO WHEELER PARKING - 72
CYCLE PARKING - 753




For SENTHIL EDUCATIONAL TRUST

PRESIDENT APPLICANT

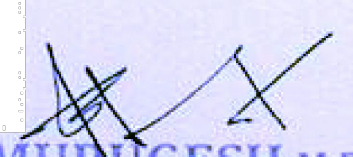
S. MURUGESH,M.E.,FIE.,
Chartered Engineer F-1279323
Structural Engineer Grade-I
(Coimbatore LPA/SE/Gr-I/19-04-19)
STRUCTURAL ENGINEER

   
S. MURUGESH,M.E.,FIE.,
Chartered Engineer F-1279323
Structural Engineer Grade-I
(Coimbatore LPA/SE/Gr-I/19-04-19)
REGISTER ENGINEER

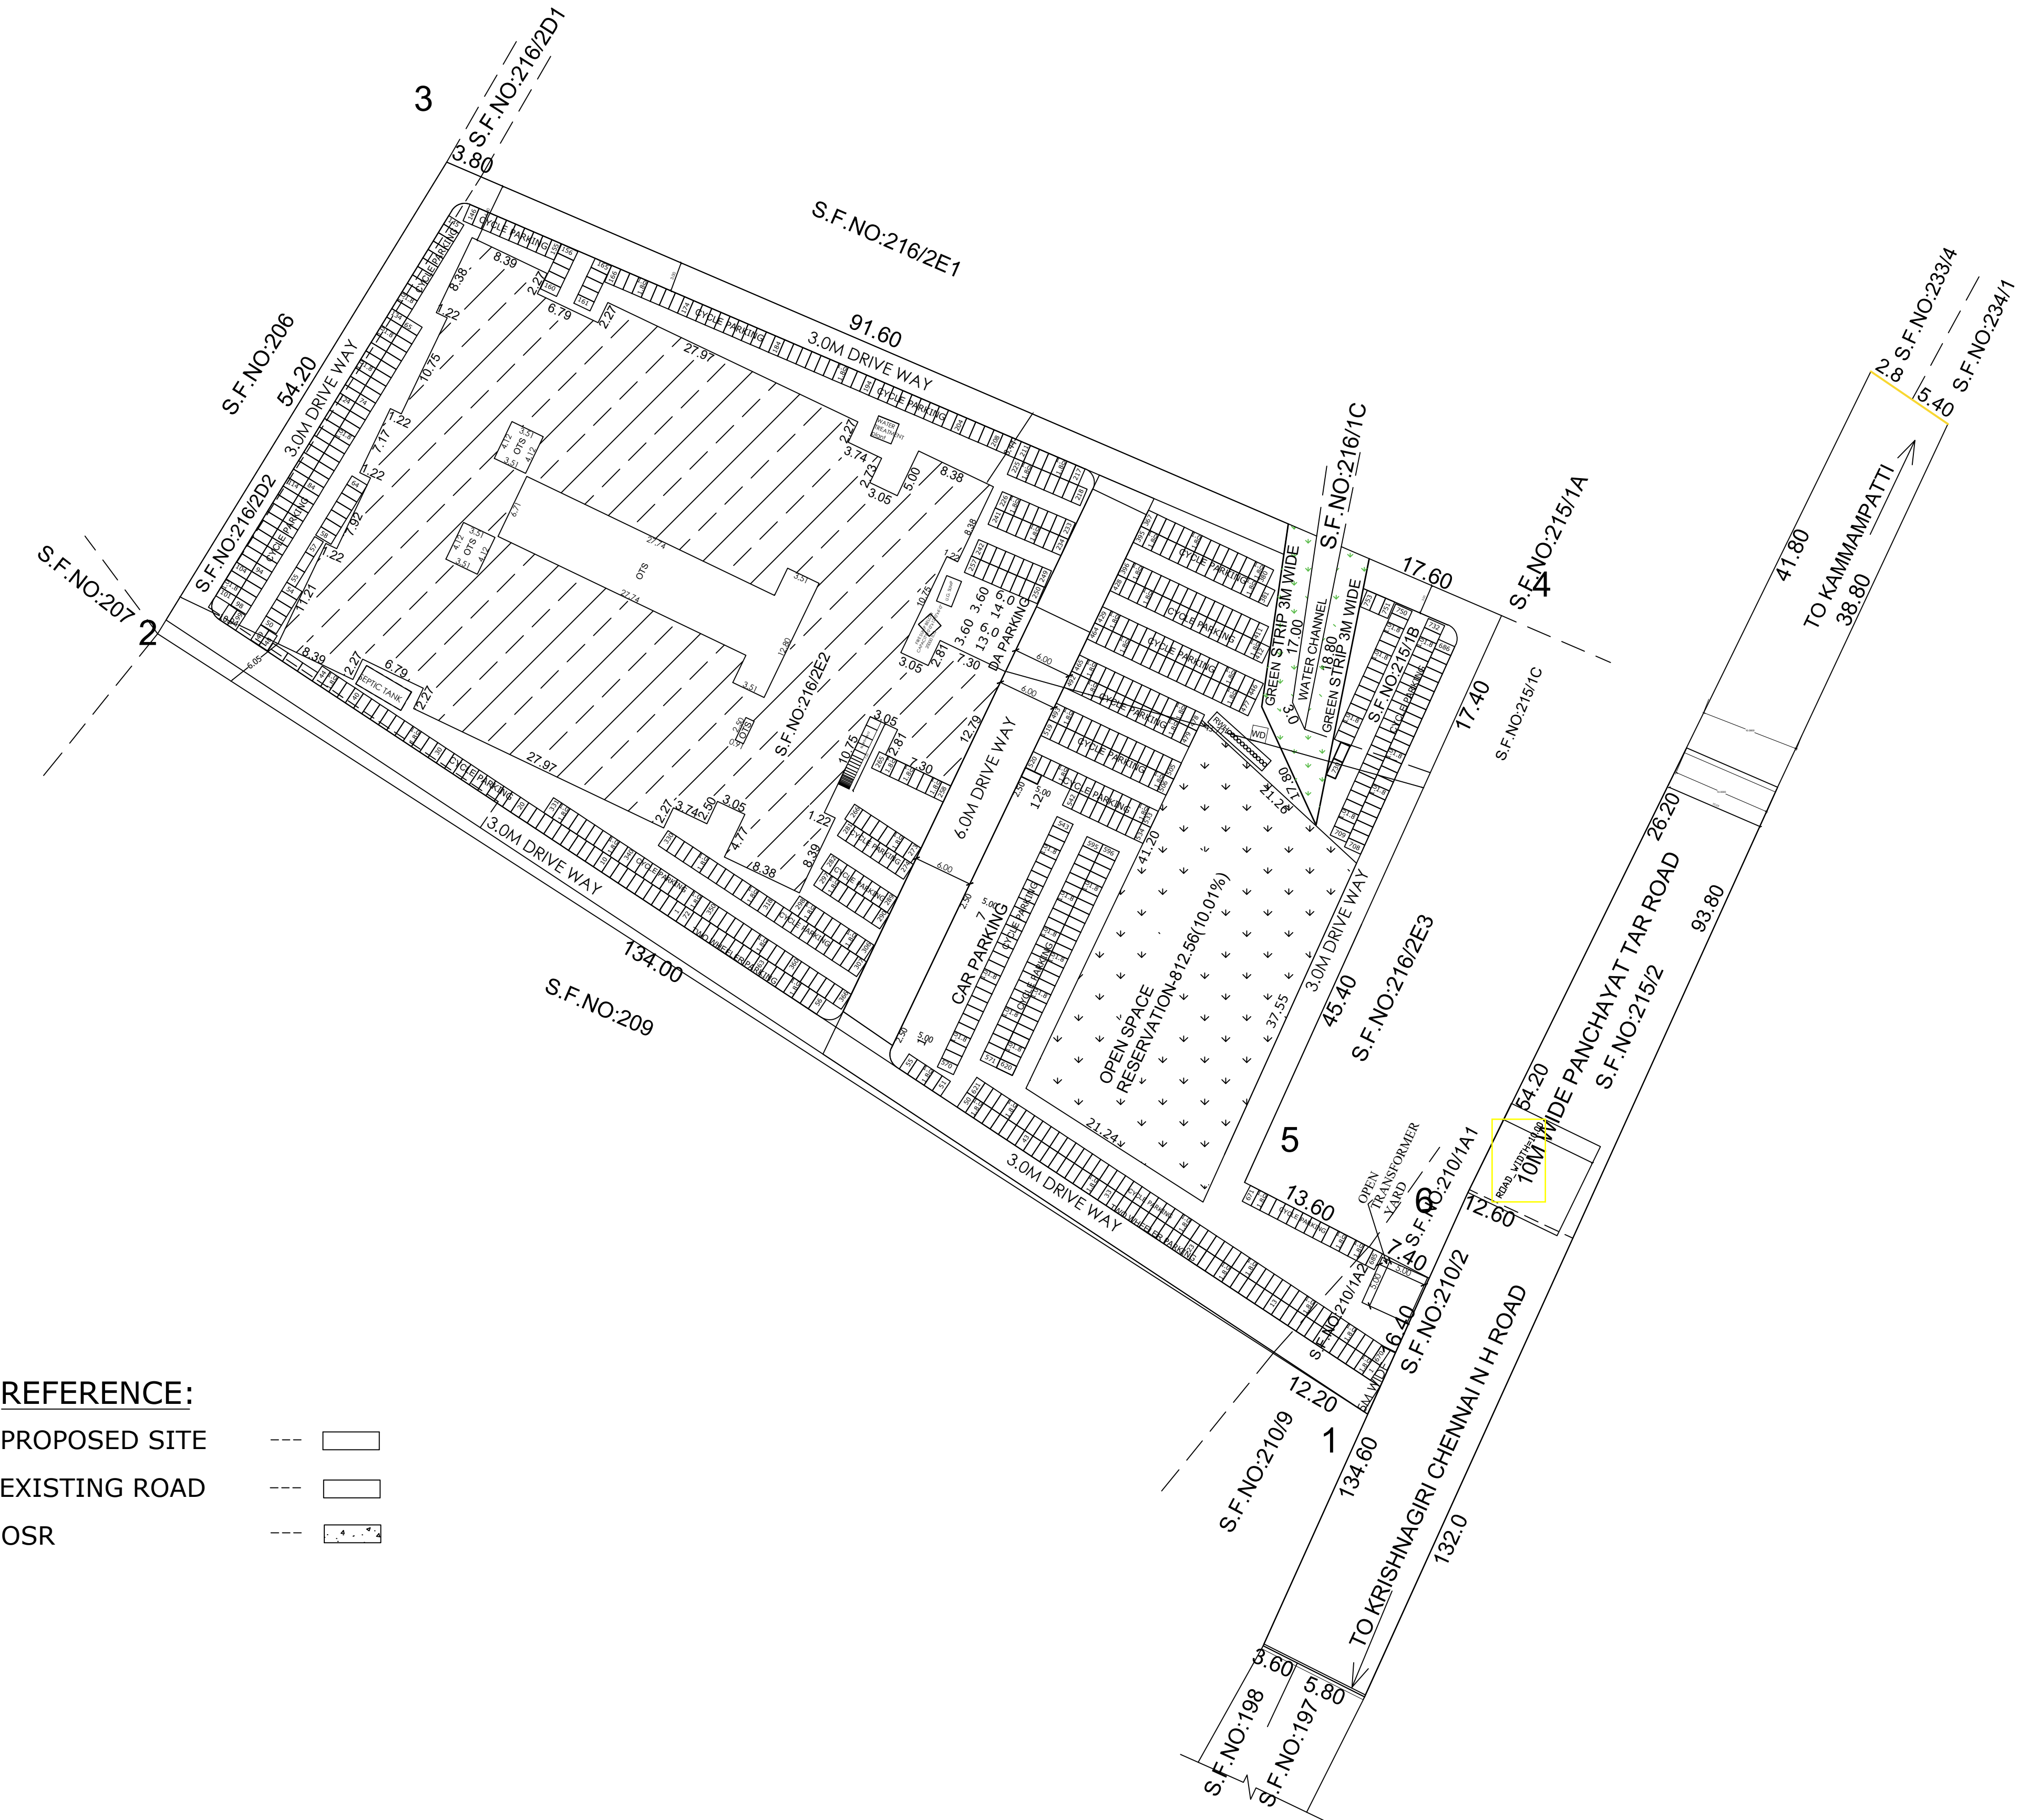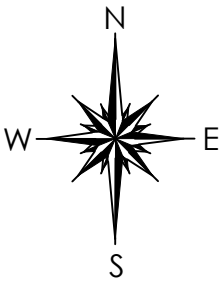


REFERENCE:
PROPOSED SITE --- 
EXISTING ROAD --- 
OSR --- 

PLAN SHOWING THE PROPOSED
CONSTRUCTION OF SENTHIL PUBLIC
SCHOOL (CBSE) IN S.F
NO:210/1A2,215/1B, 216/2D2,216/2E2,
AT KATTINAYNAPALLI VILLAGE &
PANCHAYAT, KRISHNAGIRI
PANCHAYAT UNION &
TALUK,KRISHNAGIRI DISTRICT

ALL DIMENSIONS ARE IN METRE

SCALE: 1:100

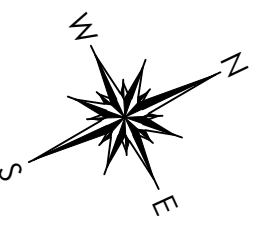

JOINERY DETAILS	METER		
RS - ROLLING SHUTTER	4.00 X 2.13		
D - DOOR	1.60 X 2.13		
D1 - DOOR	1.00 X 2.13		
D2 - DOOR	0.76 X 2.13		
SD - SLIDING DOOR	1.22 X 2.13		
LD - LIFT DOOR	1.22 X 2.13		
W - WINDOW	1.83 X 1.53		
W1- WINDOW	1.00 X 1.53		
V1 - VENTILATOR	3.05 X 0.91		
V2 - VENTILATOR	0.91X 0.91		
PROPOSED BUILDING AREA	FSI SQ.MT	NON FSI SQ.MT	TOTAL SQ.MT
GROUND FLOOR	2366.96		2366.96

NOTE:
FE FIRE EXTINGUISHER
SAND BUCKET
MECHANICAL VENTILATION ARE PROVIDED

For SENTHIL EDUCATIONAL TRUST

PRESIDENT


APPLICANT


S. MURUGESH, M.E., F.I.E.,
Chartered Engineer F-1279323
Structural Engineer Grade-I
(Coimbatore LPA/SE/Gr-I/19-04-19)

STRUCTURAL ENGINEER

S. MURUGESH, M.E., F.I.E.,
Chartered Engineer F-1279323
Structural Engineer Grade-I
(Coimbatore LPA/SE/Gr-I/19-04-19)

REGISTER ENGINEER

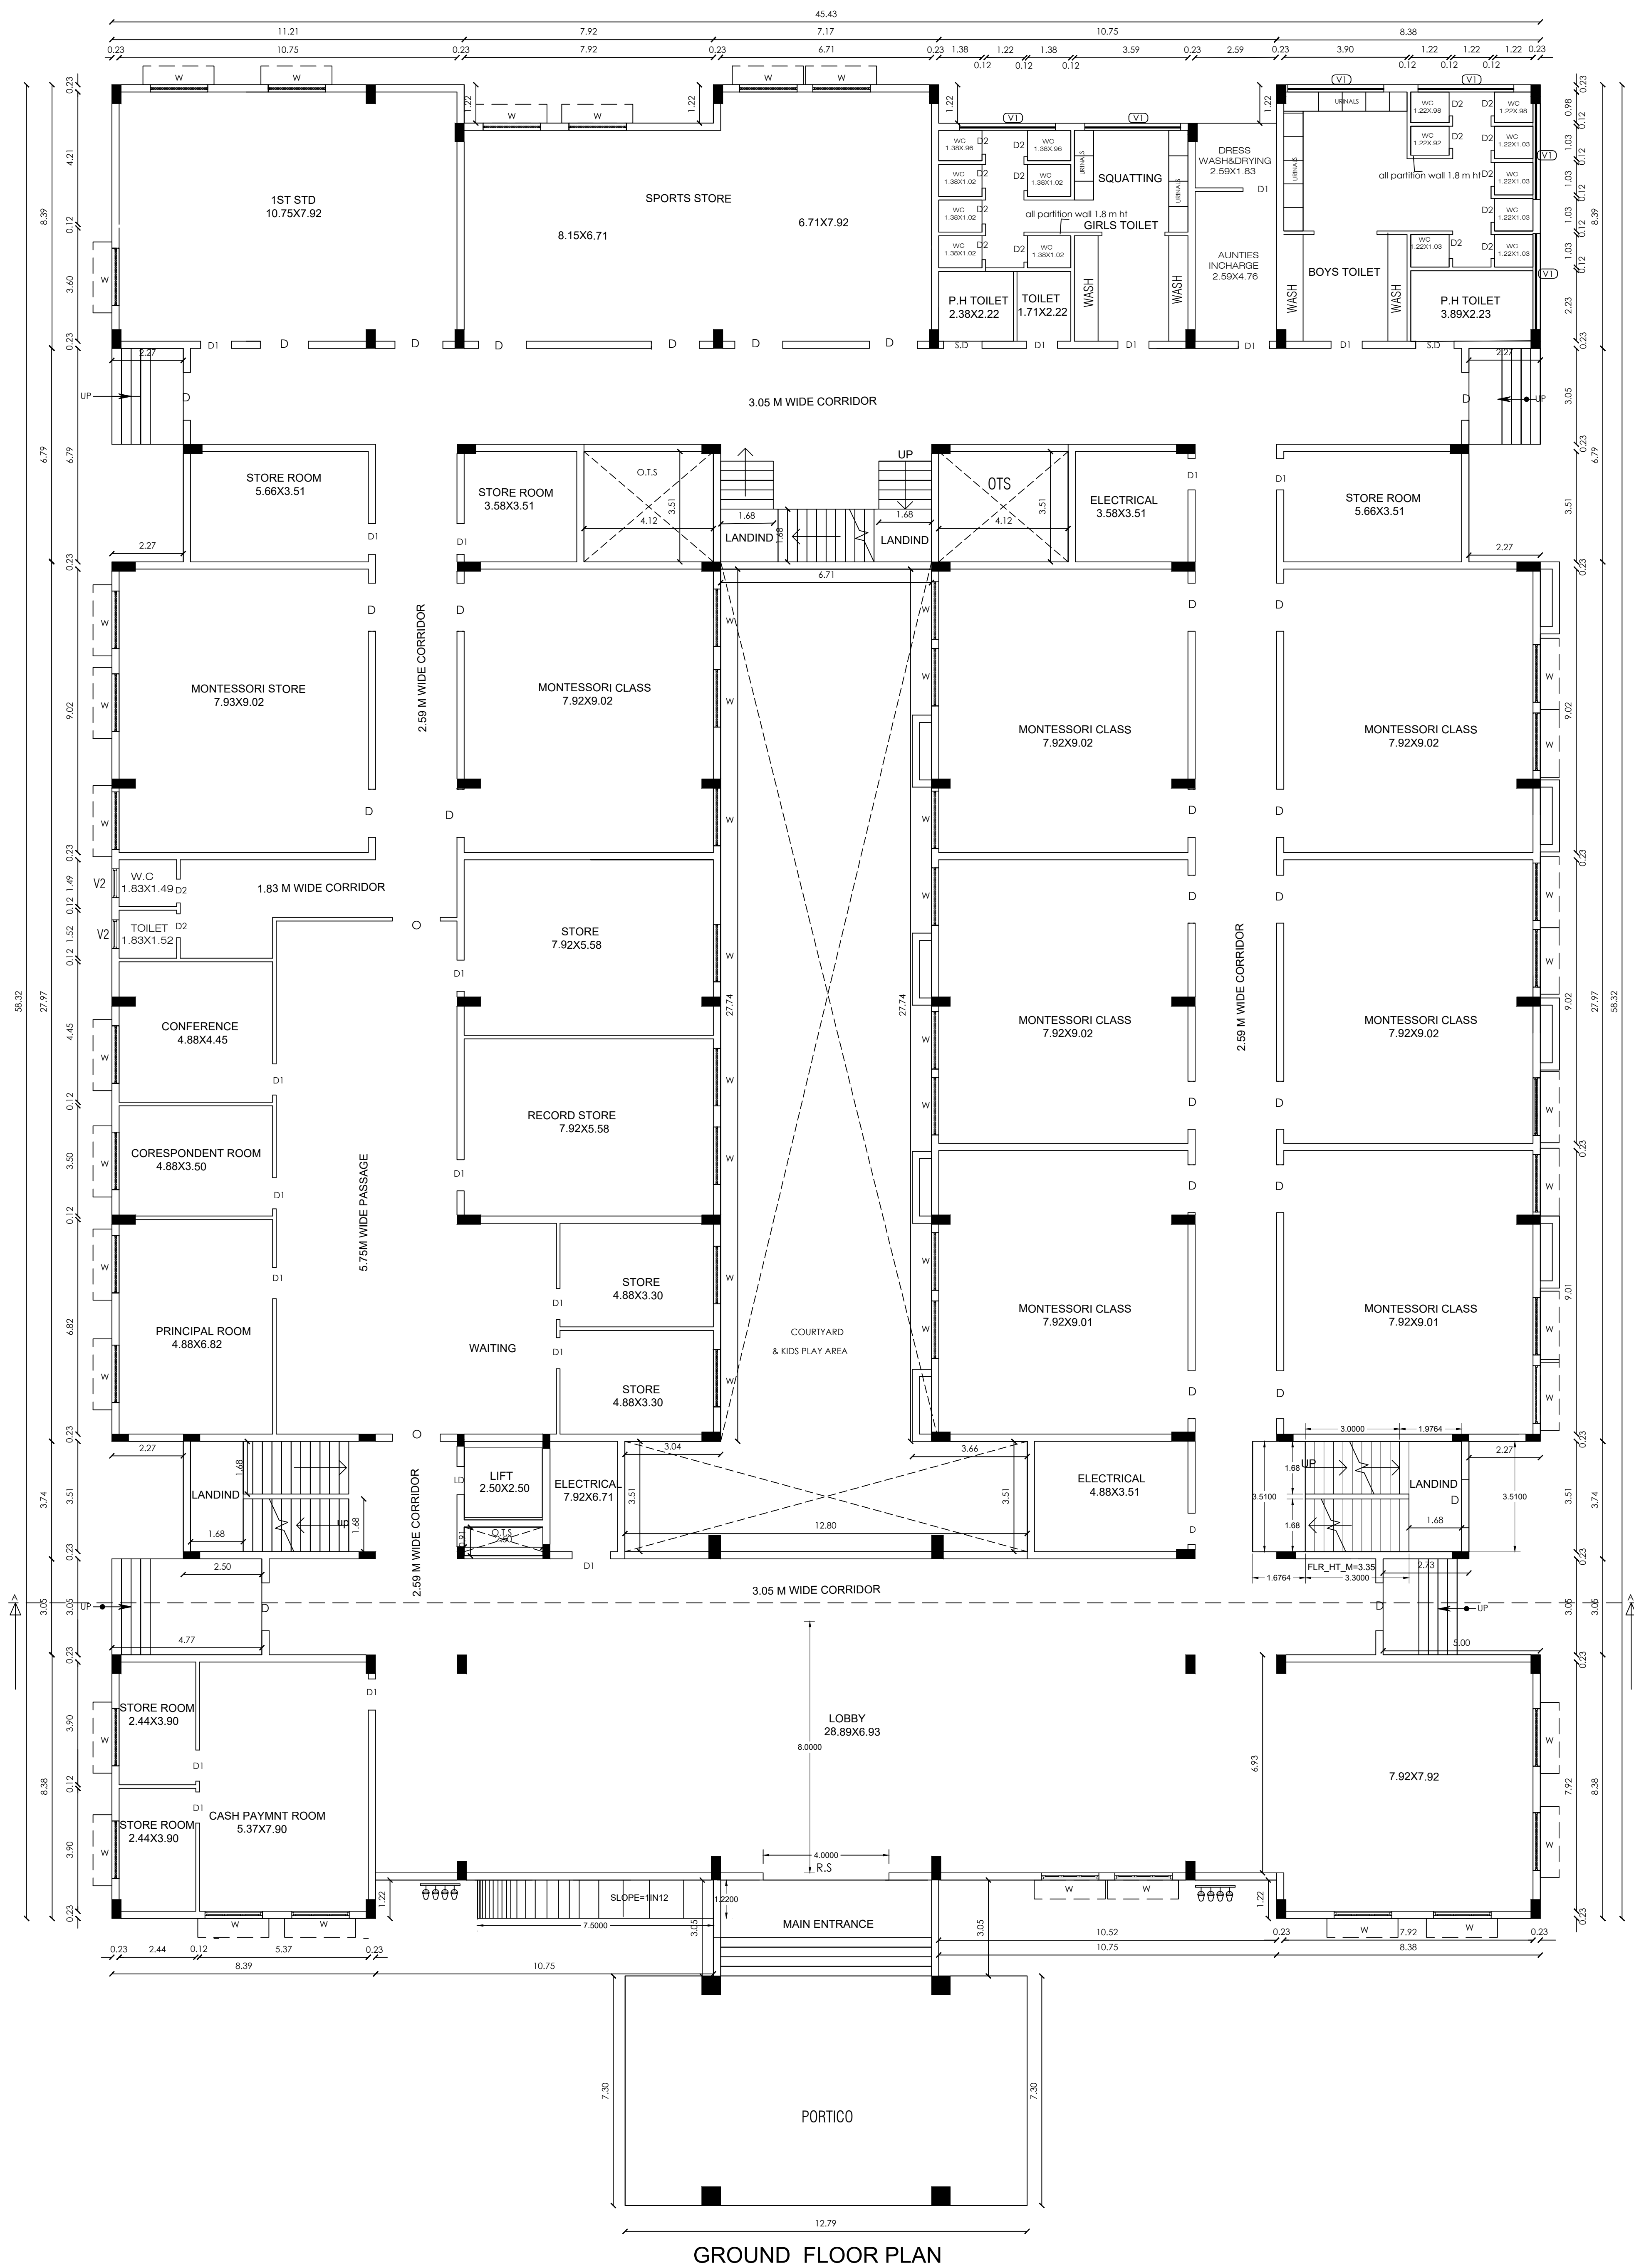

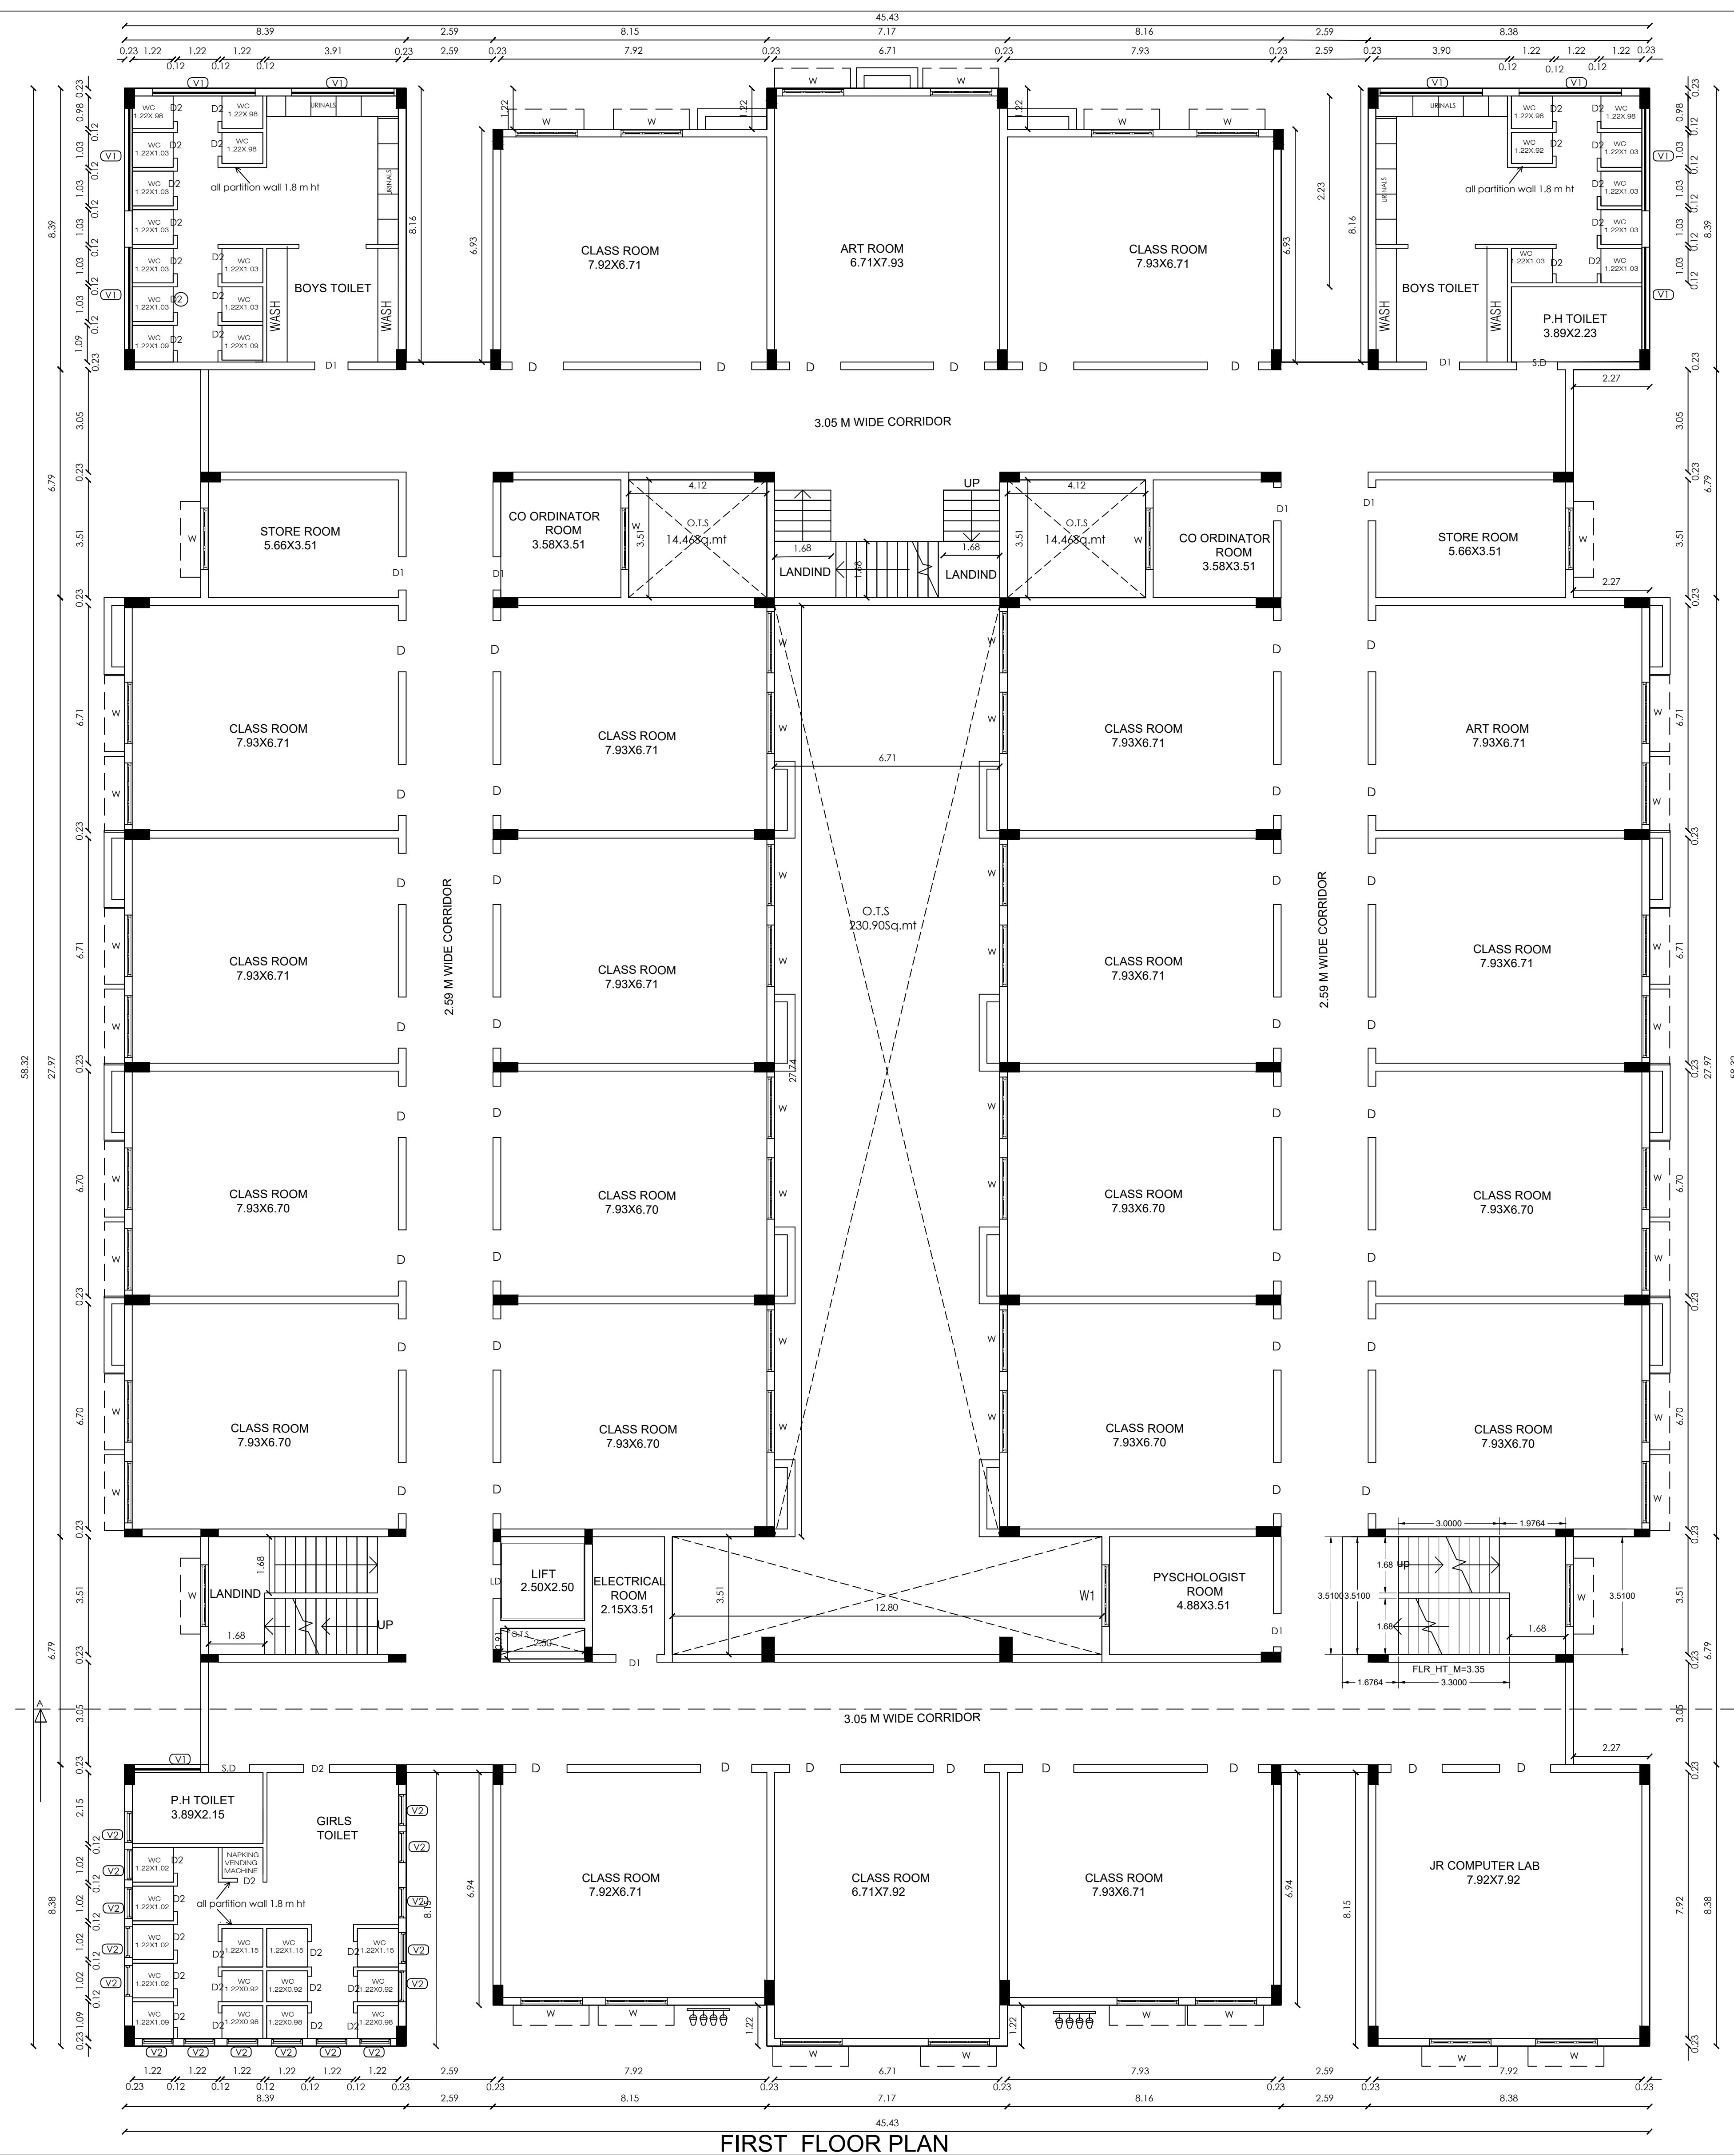


SHEET NO:4

PLAN SHOWING THE PROPOSED
CONSTRUCTION OF SENTHIL PUBLIC
SCHOOL (CBSE) IN S.F
NO:210/1A2,215/1B, 216/2D2,216/2E2,
AT KATTINAYNAPALLI VILLAGE &
PANCHAYAT, KRISHNAGIRI
PANCHAYAT UNION &
TALUK,KRISHNAGIRI DISTRICT

ALL DIMENSIONS ARE IN METRE

SCALE: 1:100

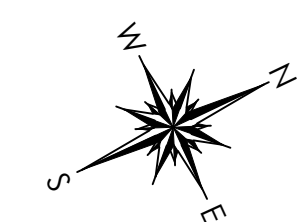

JOINERY DETAILS	METER		
D - DOOR	1.60 X 2.13		
D1 - DOOR	1.00 X 2.13		
D2 - DOOR	0.76 X 2.13		
SD - SLIDING DOOR	1.22 X 2.13		
LD - LIFT DOOR	1.22 X 2.13		
W - WINDOW	1.83 X 1.53		
W1- WINDOW	1.00 X 1.53		
V1 - VENTILATOR	3.05 X 0.91		
V2 - VENTILATOR	0.91X 0.91		
PROPOSED BUILDING AREA	FSI SQ.MT	NON FSI SQ.MT	TOTAL SQ.MT
FIRST FLOOR	2201.21		2201.93

NOTE:	
FE	FIRE EXTINGUISHER
	SAND BUCKET
	MECHANICAL VENTILATION ARE PROVIDED

For SENTHIL EDUCATIONAL TRUST
PRESIDENT

APPLICANT


S. MURUGESH, M.E., F.I.E.,
Chartered Engineer F-1279323
Structural Engineer Grade-I
(Coimbatore LPA/SE/Gr-I/19-04-19)

STRUCTURAL ENGINEER

S. MURUGESH, M.E., F.I.E.,
Chartered Engineer F-1279323
Structural Engineer Grade-I
(Coimbatore LPA/SE/Gr-I/19-04-19)

REGISTER ENGINEER

SCALE: 1:100

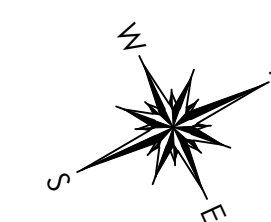

JOINERY DETAILS	METER		
D - DOOR	1.60 X 2.13		
D1 - DOOR	1.00 X 2.13		
D2 - DOOR	0.76 X 2.13		
SD - SLIDING DOOR	1.22 X 2.13		
LD - LIFT DOOR	1.22 X 2.13		
W - WINDOW	1.83 X 1.53		
W1- WINDOW	1.00 X 1.53		
V1 - VENTILATOR	3.05 X 0.91		
V2 - VENTILATOR	0.91X 0.91		
PROPOSED BUILDING AREA	FSI SQ.MT	NON FSI SQ.MT	TOTAL SQ.MT
SECOND FLOOR	2192.47		2192.47

NOTE:
FE FIRE EXTINGUISHER
 SAND BUCKET
MECHANICAL VENTILATION ARE PROVIDED

For SENTHIL EDUCATIONAL TRUST



PRESIDENT


APPLICANT

S. MURUGESH, M.E., F.I.E.,
Chartered Engineer F-1279323
Structural Engineer Grade-I
(Coimbatore LPA/SE/Gr-I/19-04-19)


STRUCTURAL ENGINEER

S. MURUGESH, M.E., F.I.E.,
Chartered Engineer F-1279323
Structural Engineer Grade-I
(Coimbatore LPA/SE/Gr-I/19-04-19)

REGISTER ENGINEER

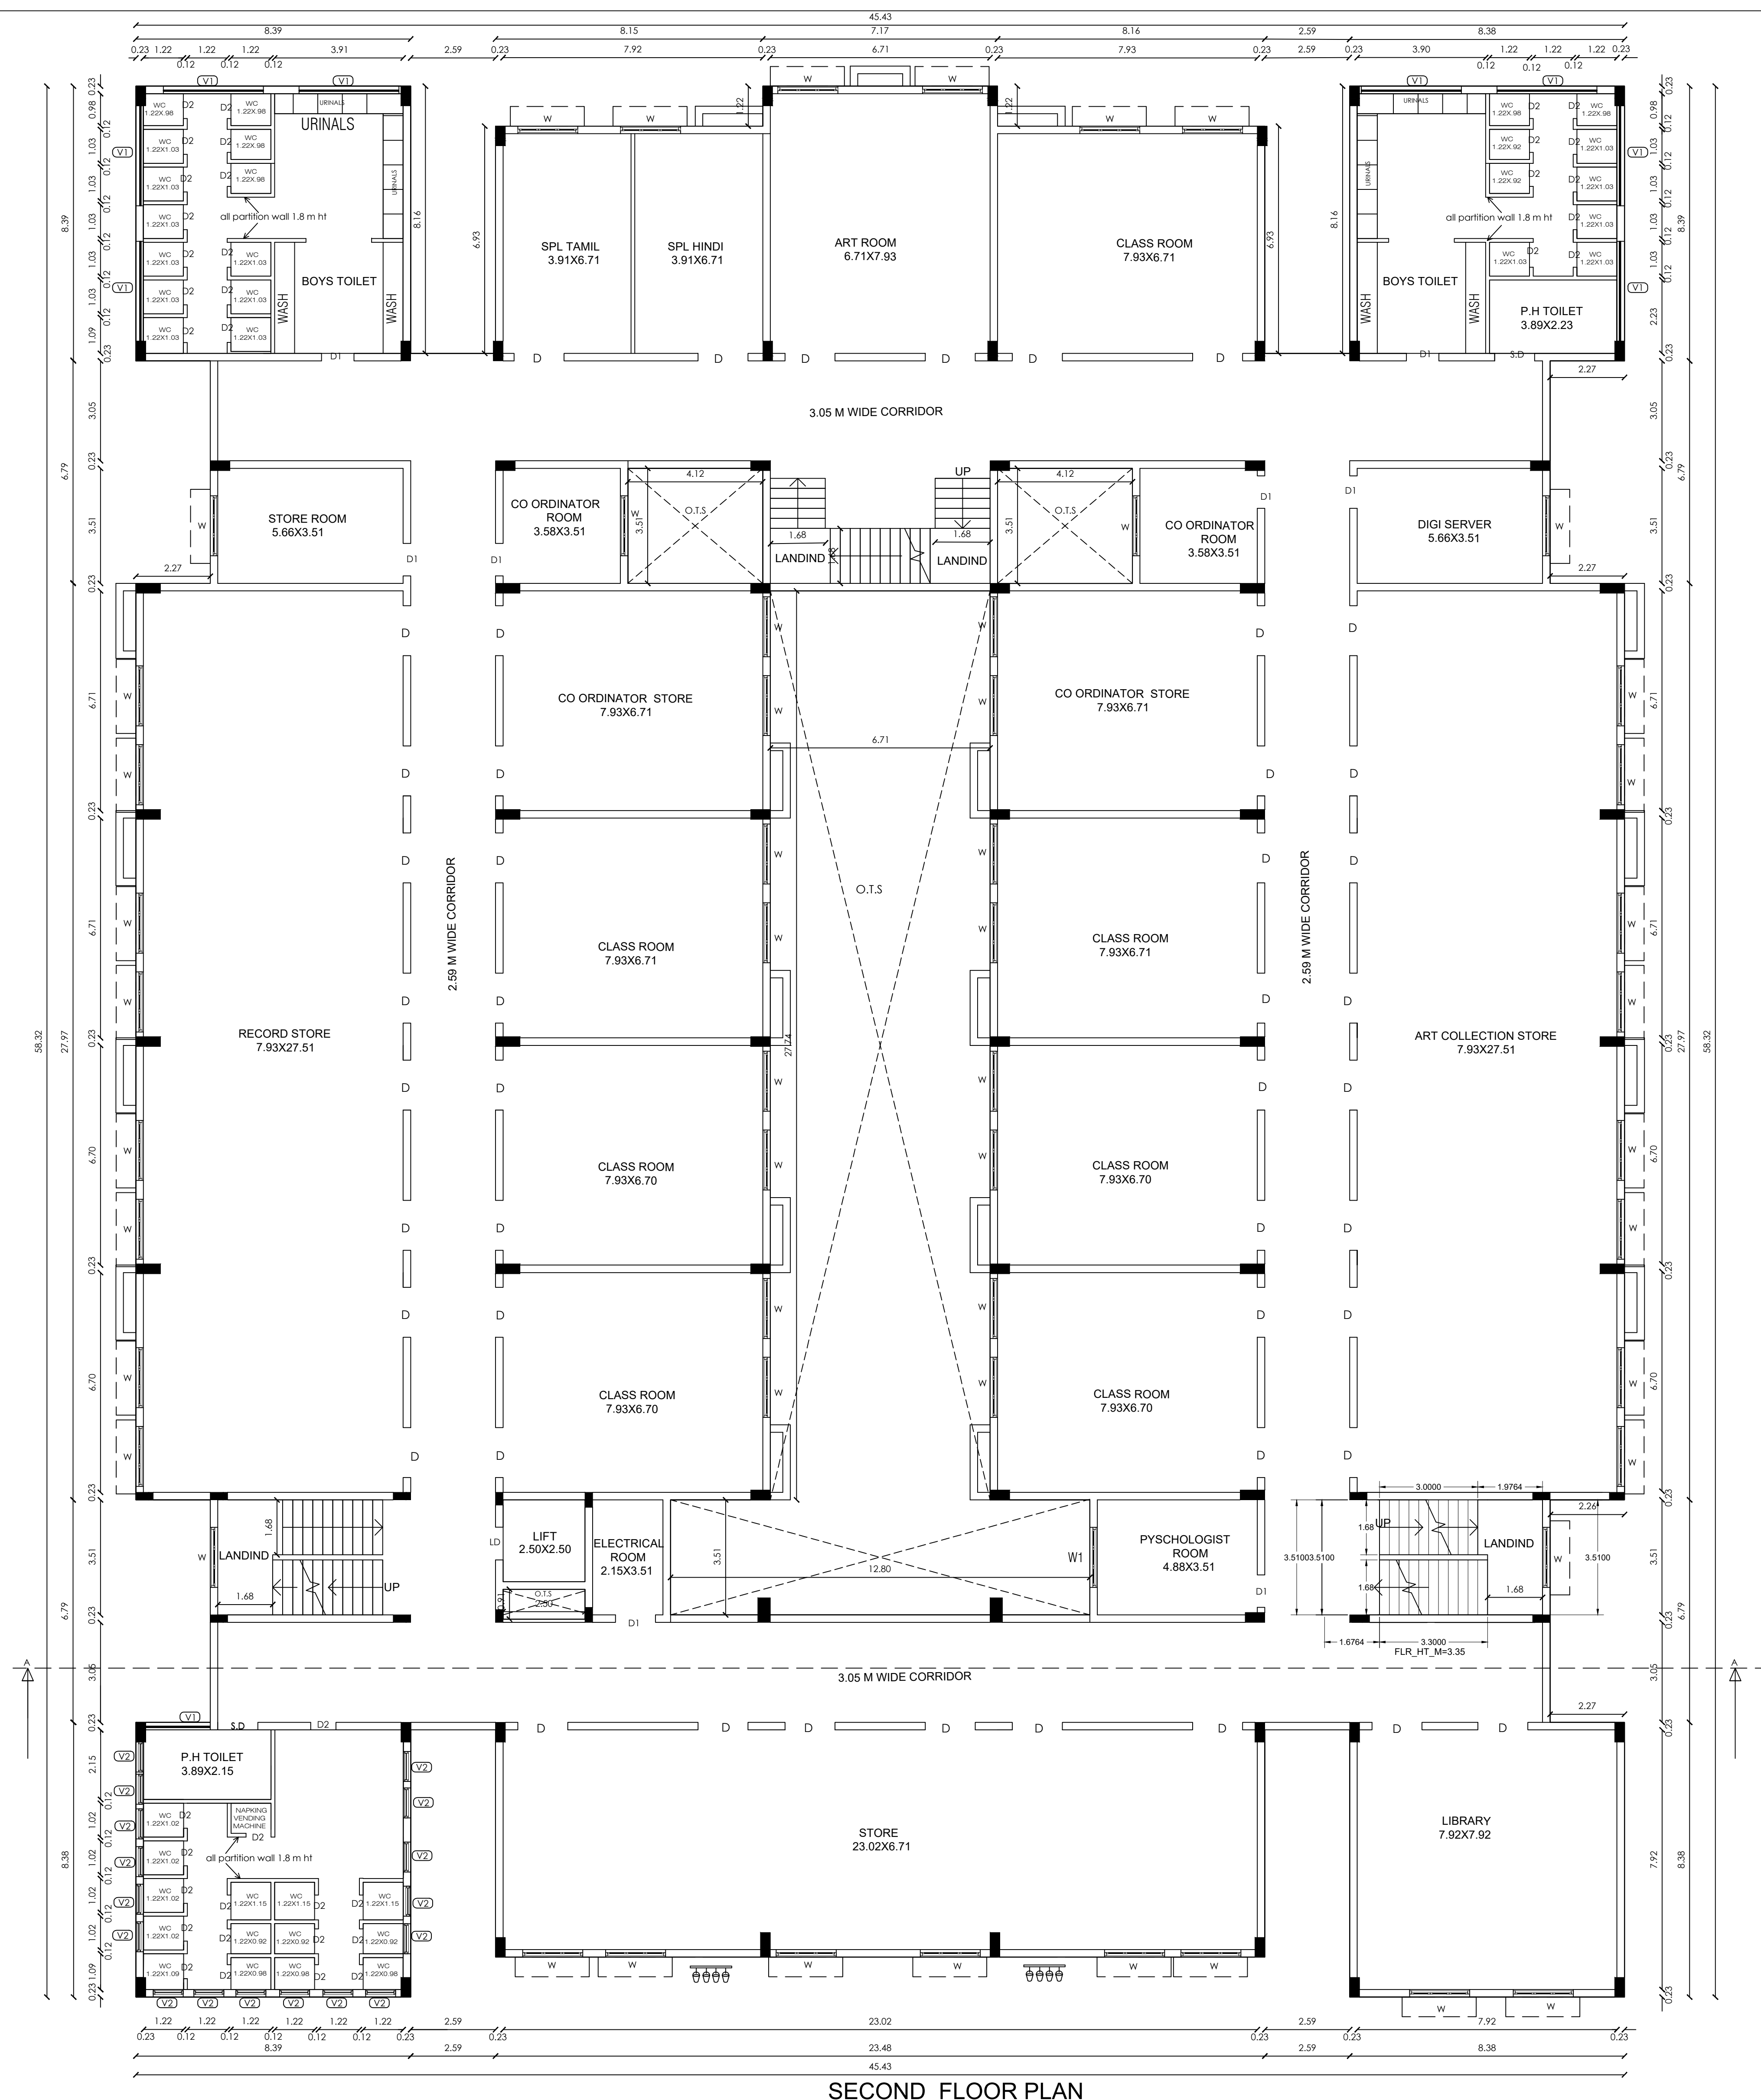

SCALE: 1:100

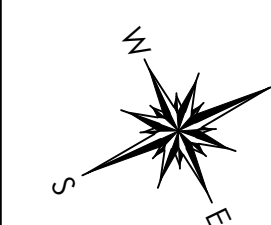

JOINERY DETAILS	METER		
D - DOOR	1.60 X 2.13		
D1- DOOR	1.00 X 2.13		
D2- DOOR	0.76 X 2.13		
SD - SLIDING DOOR	1.22 X 2.13		
LD - LIFT DOOR	1.22 X 2.13		
W - WINDOW	1.83 X 1.53		
W1- WINDOW	1.00 X 1.53		
V1 - VENTILATOR	3.05 X 0.91		
V2 - VENTILATOR	0.91X 0.91		
PROPOSED BUILDING AREA	FSI SQ.MT	NON FSI SQ.MT	TOTAL SQ.MT
THIRD FLOOR	2192.47		2192.47

NOTE:
FE FIRE EXTINGUISHER
 SAND BUCKET
MECHANICAL VENTILATION ARE PROVIDED

For SENTHIL EDUCATIONAL TRUST
PRESIDENT


APPLICANT


S. MURUGESH, M.E., F.I.E.,
Chartered Engineer F-1279323
Structural Engineer Grade-I
(Coimbatore LPA/SE/Gr-I/19-04-19)

STRUCTURAL ENGINEER

S. MURUGESH, M.E., F.I.E.,
Chartered Engineer F-1279323
Structural Engineer Grade-I
(Coimbatore LPA/SE/Gr-I/19-04-19)

REGISTER ENGINEER

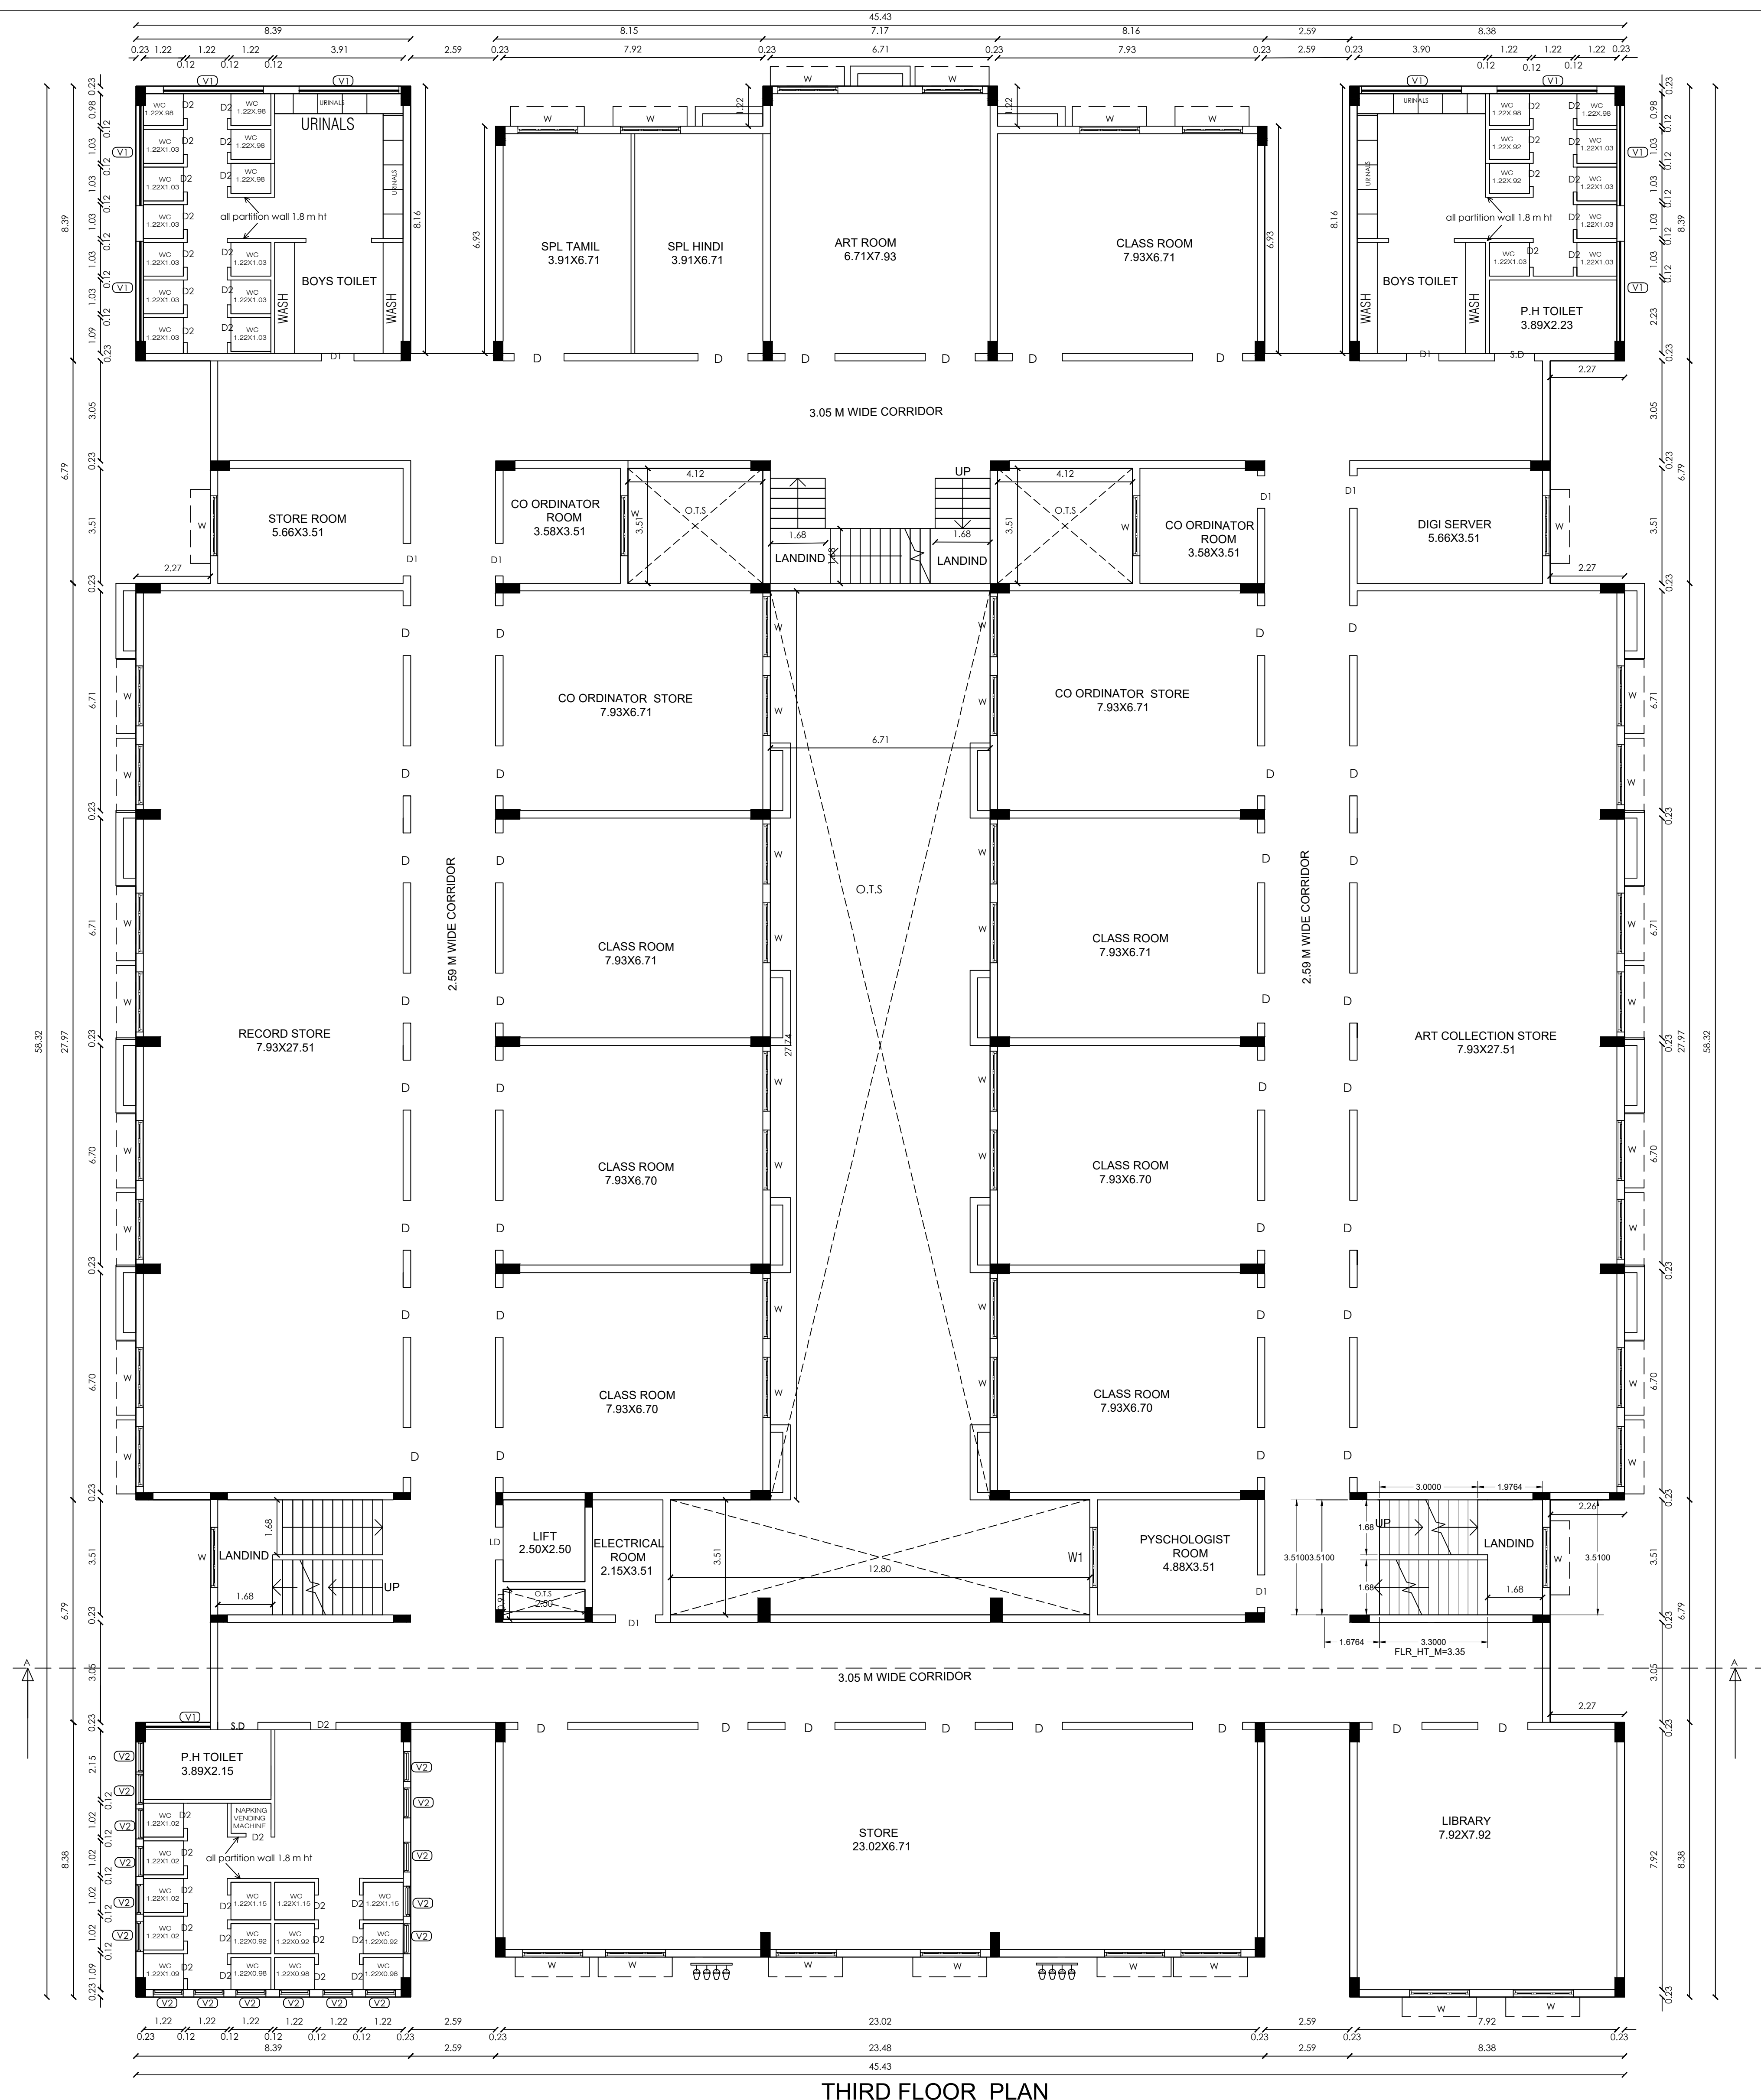

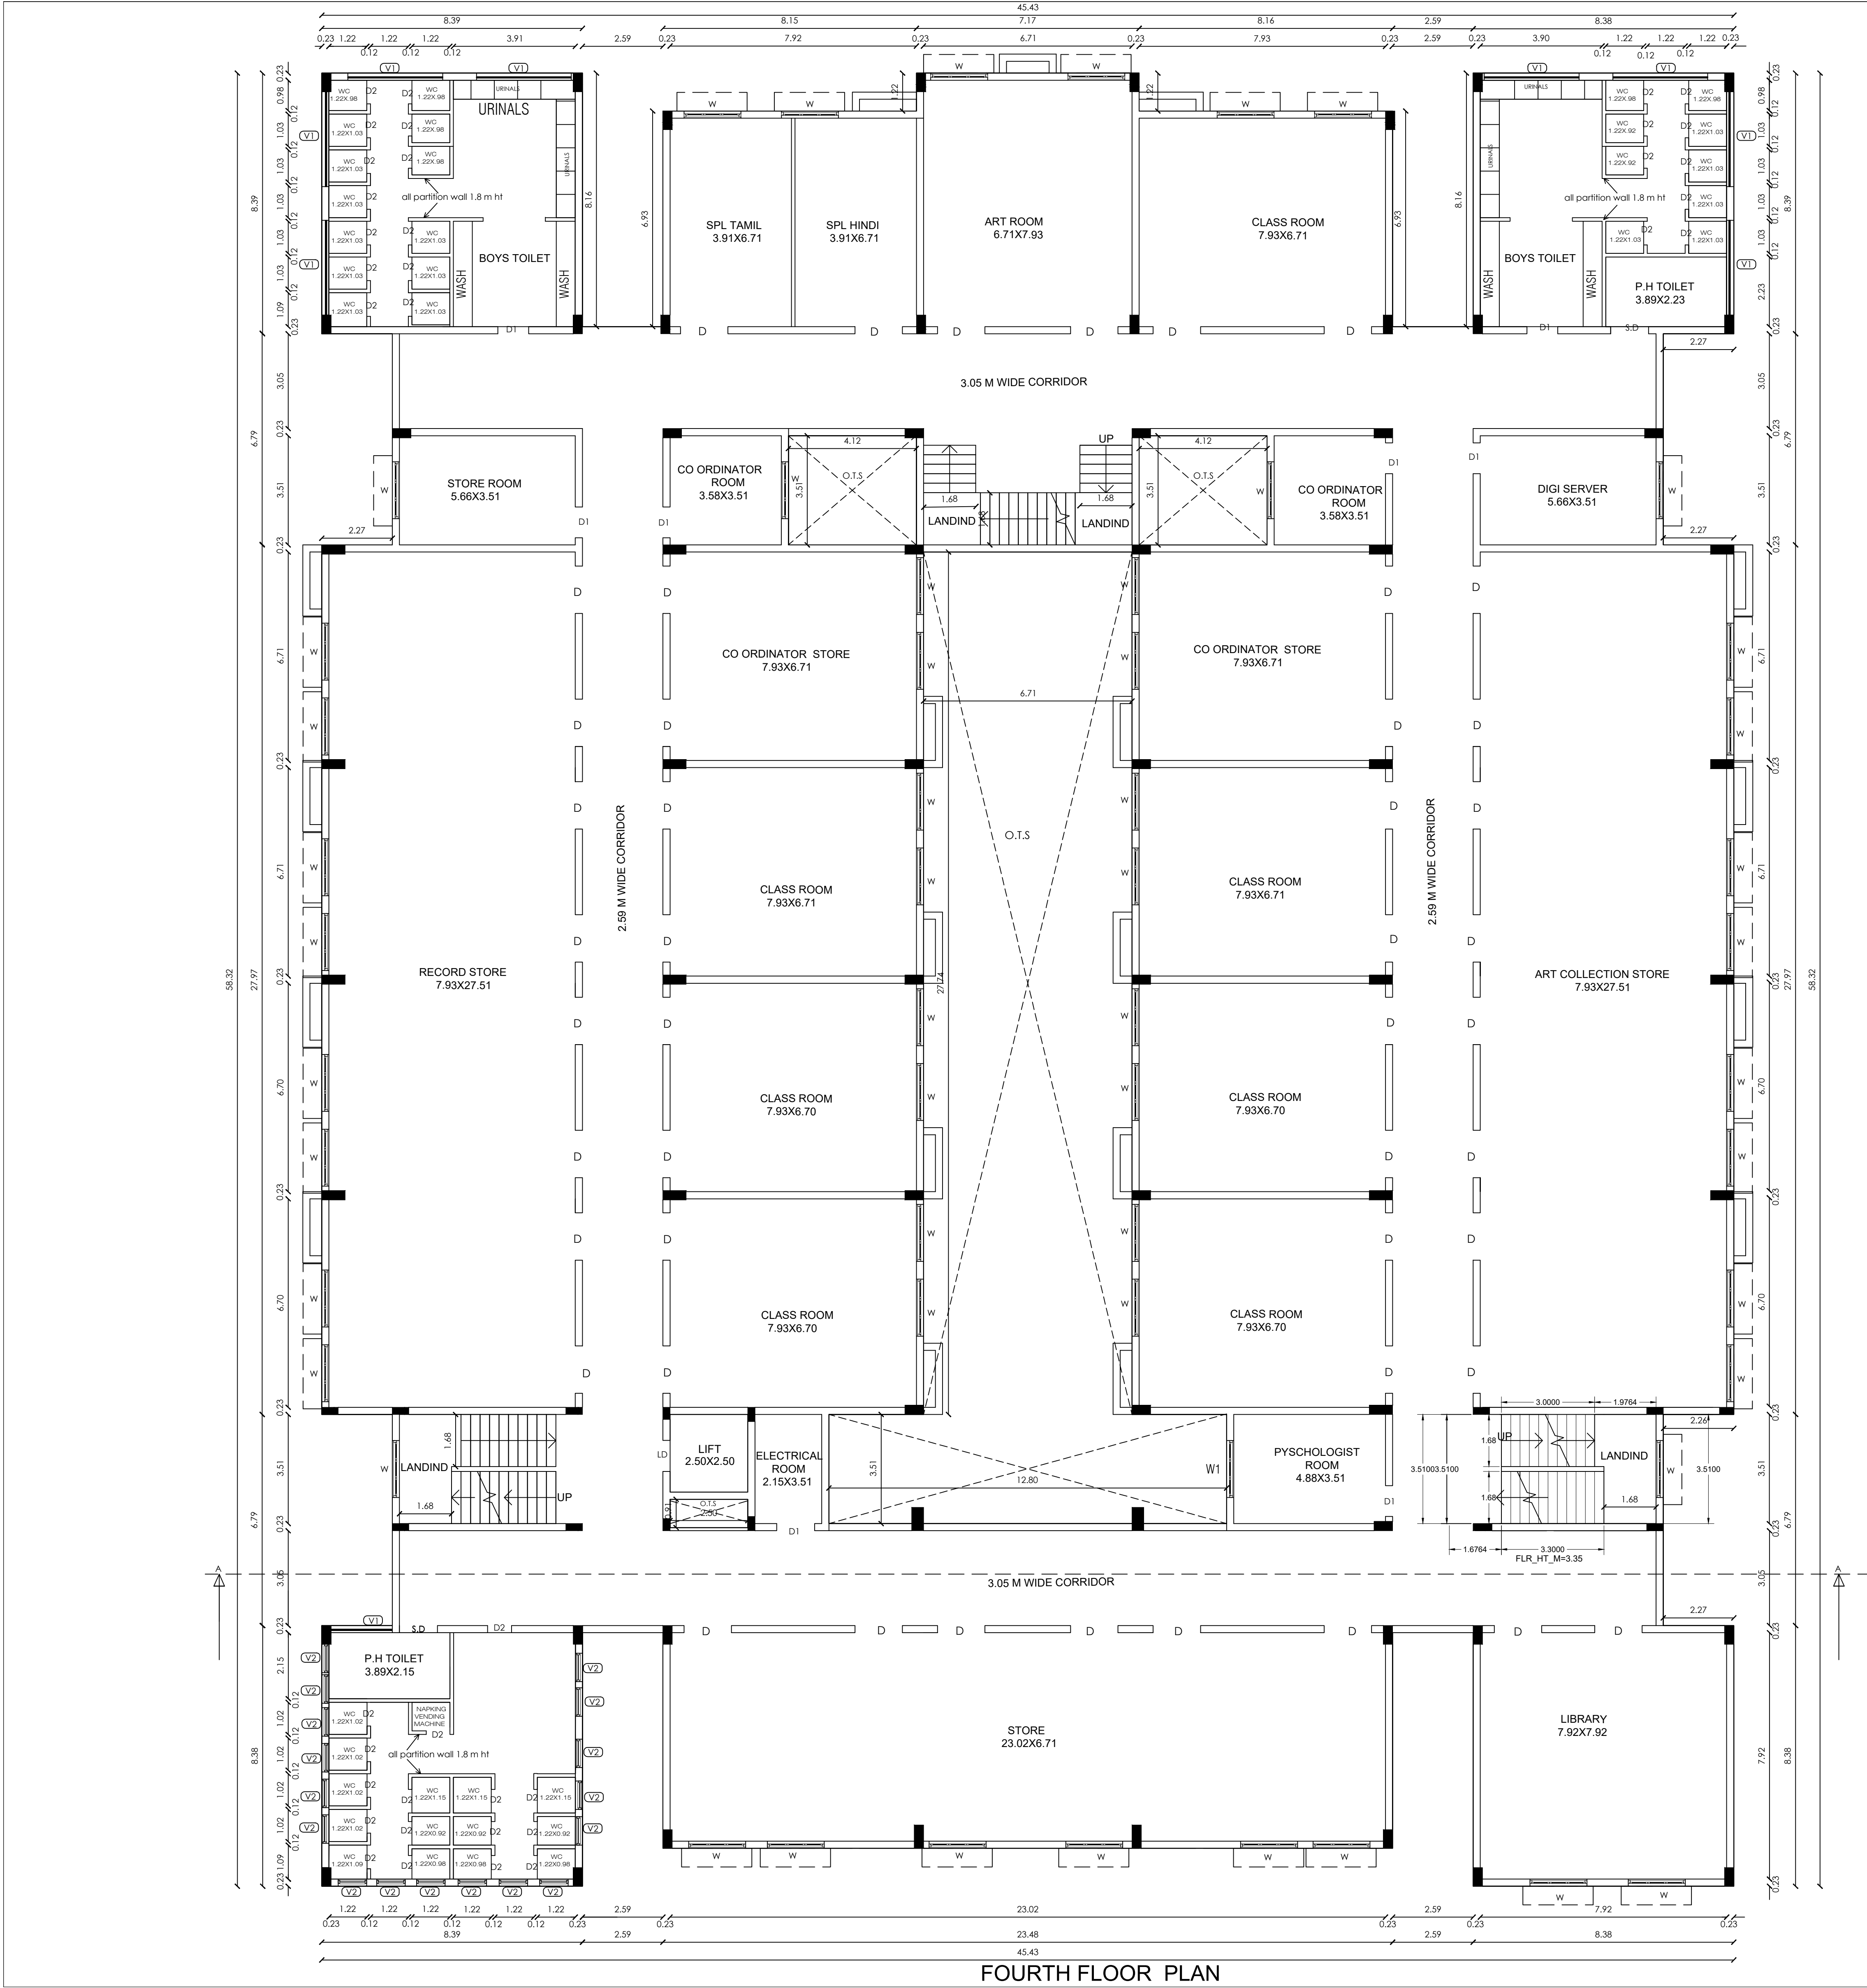


FOURTH FLOOR PLAN

SHEET NO.5

PLAN SHOWING THE PROPOSED CONSTRUCTION OF SENTHIL PUBLIC SCHOOL (CBSE) IN S.F NO:210/1A2,215/1B, 216/2D2,216/2E2, AT KATTINAYNAPALLI VILLAGE & PANCHAYAT, KRISHNAGIRI PANCHAYAT UNION & TALUK,KRISHNAGIRI DISTRICT

ALL DIMENSIONS ARE IN METRE
SCALE: 1:100

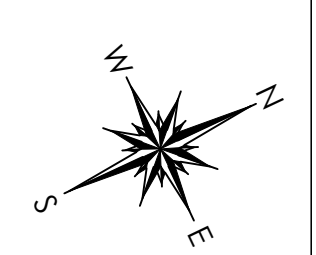

JOINERY DETAILS		METER		
D - DOOR		1.60 X 2.13		
D1 - DOOR		1.00 X 2.13		
D2 - DOOR		0.76 X 2.13		
SD - SLIDING DOOR		1.22 X 2.13		
LD - LIFT DOOR		1.22 X 2.13		
W - WINDOW		1.83 X 1.53		
W1- WINDOW		1.00 X 1.53		
V1 - VENTILATOR		3.05 X 0.91		
V2 - VENTILATOR		0.91X 0.91		
PROPOSED BUILDING AREA	FSI SQ.MT	NON FSI SQ.MT	TOTAL SQ.MT	
FOURTH FLOOR	2192.47		2192.47	


NOTE:
FE FIRE EXTINGUISHER
SAND BUCKET
MECHANICAL VENTILATION ARE PROVIDED

For SENTHIL EDUCATIONAL TRUST


PRESIDENT
APPLICANT

S. MURUGESH,M.E.,FIE.,
Chartered Engineer F-1279323
Structural Engineer Grade-I
(Coimbatore LPA/SE/Gr-I/19-04-19)
STRUCTURAL ENGINEER


S. MURUGESH,M.E.,FIE.,
Chartered Engineer F-1279323
Structural Engineer Grade-I
(Coimbatore LPA/SE/Gr-I/19-04-19)
REGISTER ENGINEER

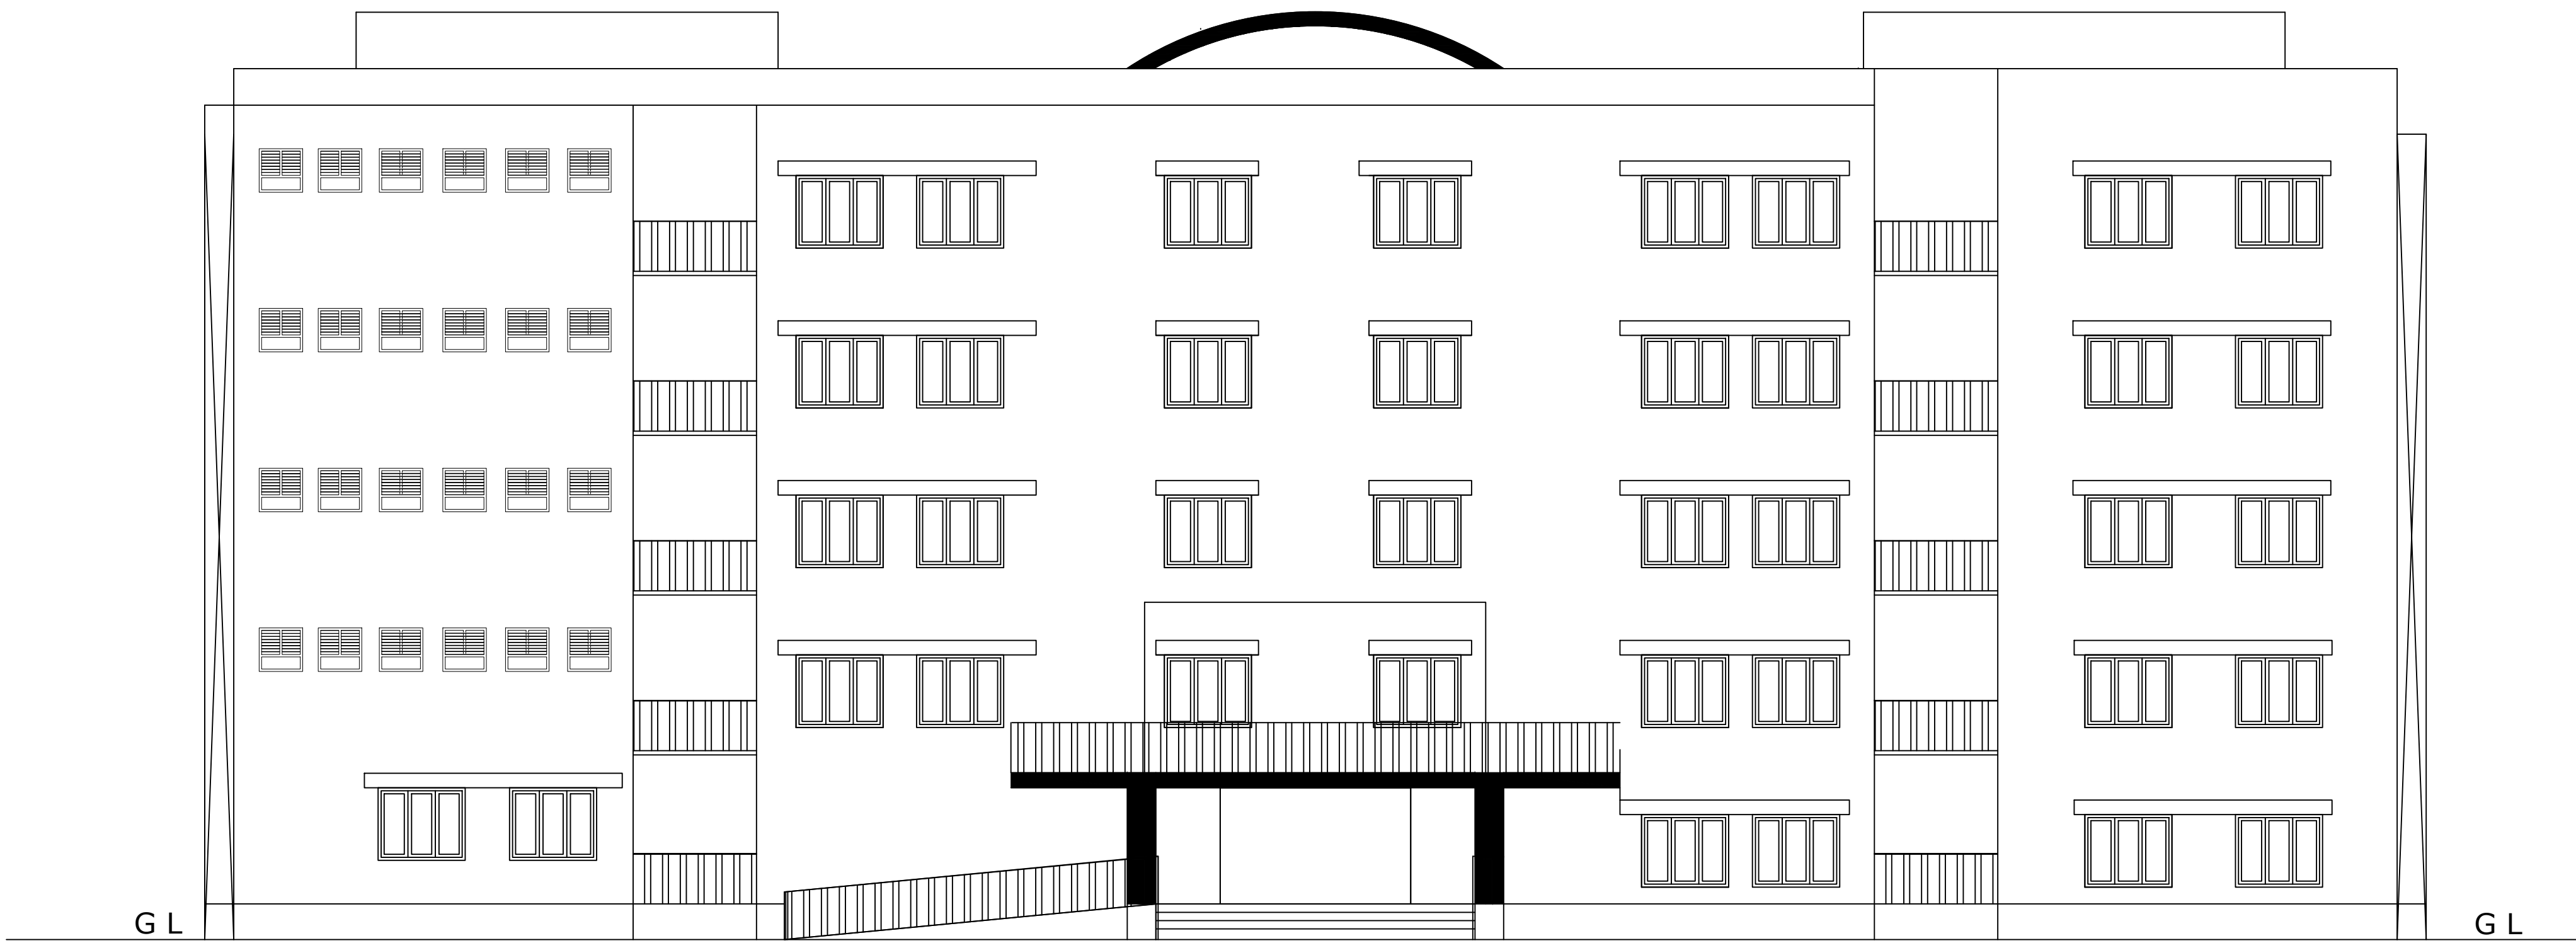

FRONT ELEVATION

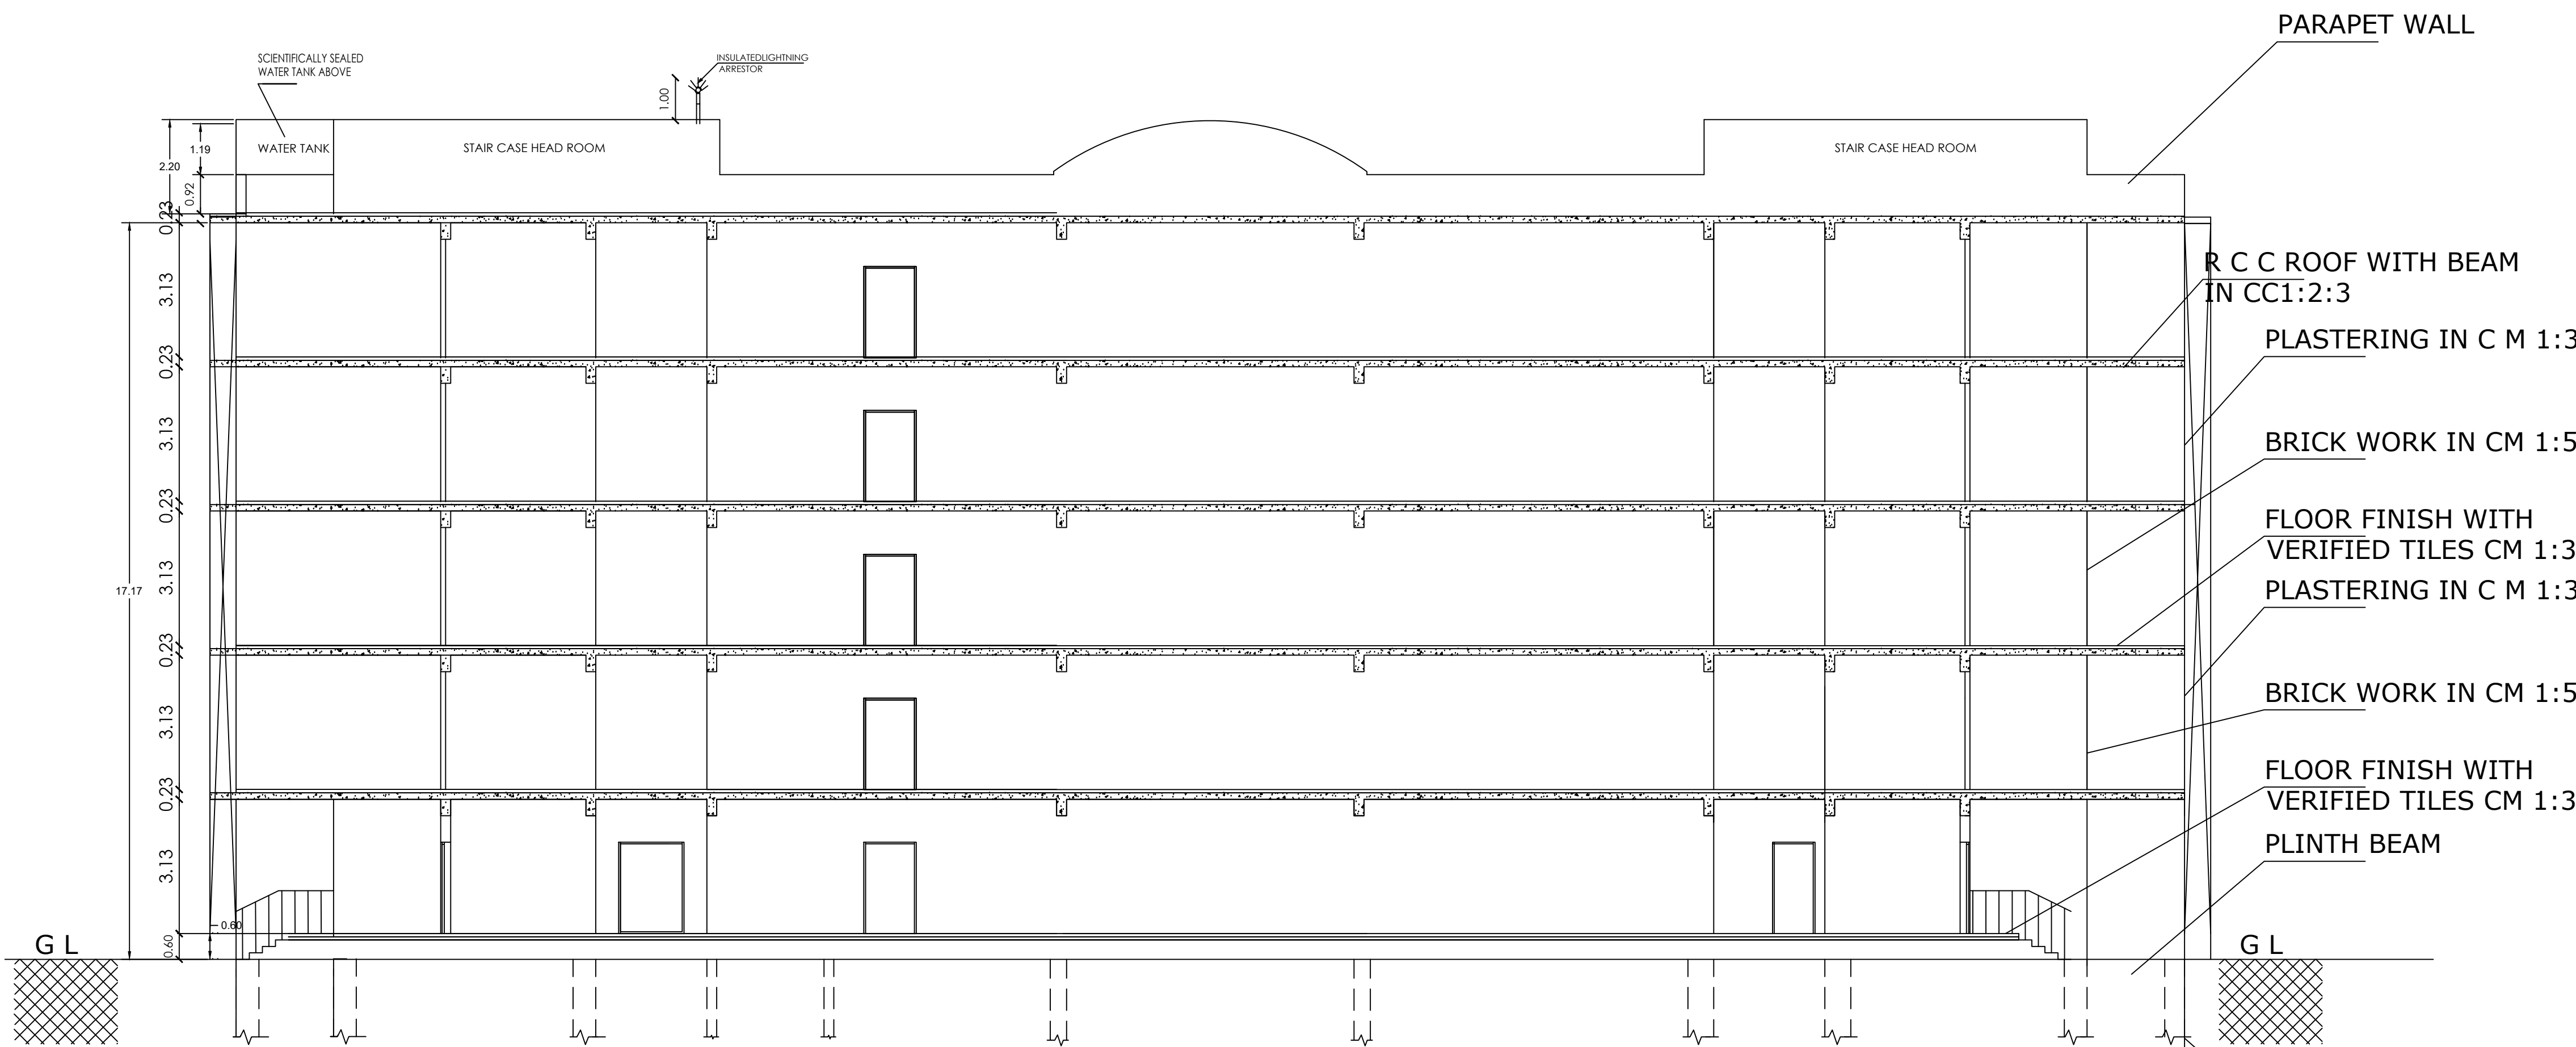


SECTION ON AA

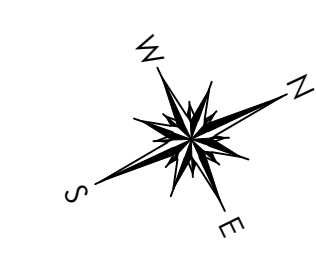

PLAN SHOWING THE PROPOSED
CONSTRUCTION OF SENTHIL PUBLIC
SCHOOL (CBSE) IN S.F
NO:210/1A2,215/1B, 216/2D2,216/2E2,
AT KATTINAYNAPALLI VILLAGE &
PANCHAYAT, KRISHNAGIRI
PANCHAYAT UNION &
TALUK,KRISHNAGIRI DISTRICT

SCALE:1:400 ALL DIMENSIONS ARE IN METRE

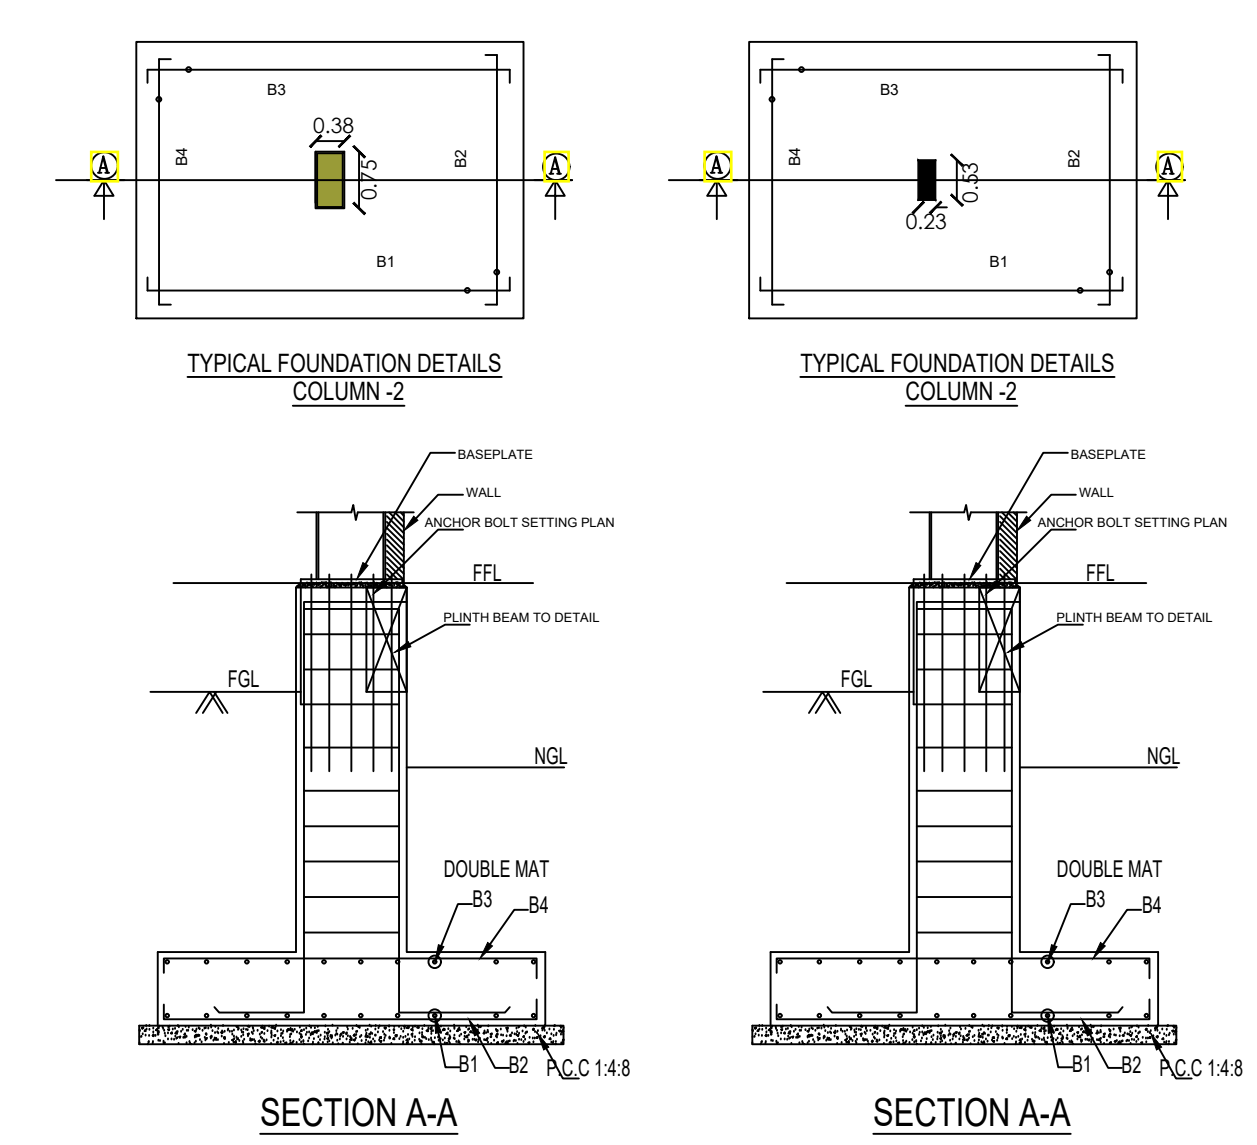

For SENTHIL EDUCATIONAL TRUST
PRESIDENT


APPLICANT

S. MURUGESH, M.E., F.I.E.,
Chartered Engineer F-1279323
Structural Engineer Grade-I
(Coimbatore LPA/SE/Gr-I/19-04-19)






STRUCTURAL ENGINEER

S. MURUGESH, M.E., F.I.E.,
Chartered Engineer F-1279323
Structural Engineer Grade-I
(Coimbatore LPA/SE/Gr-I/19-04-19)

REGISTER ENGINEER

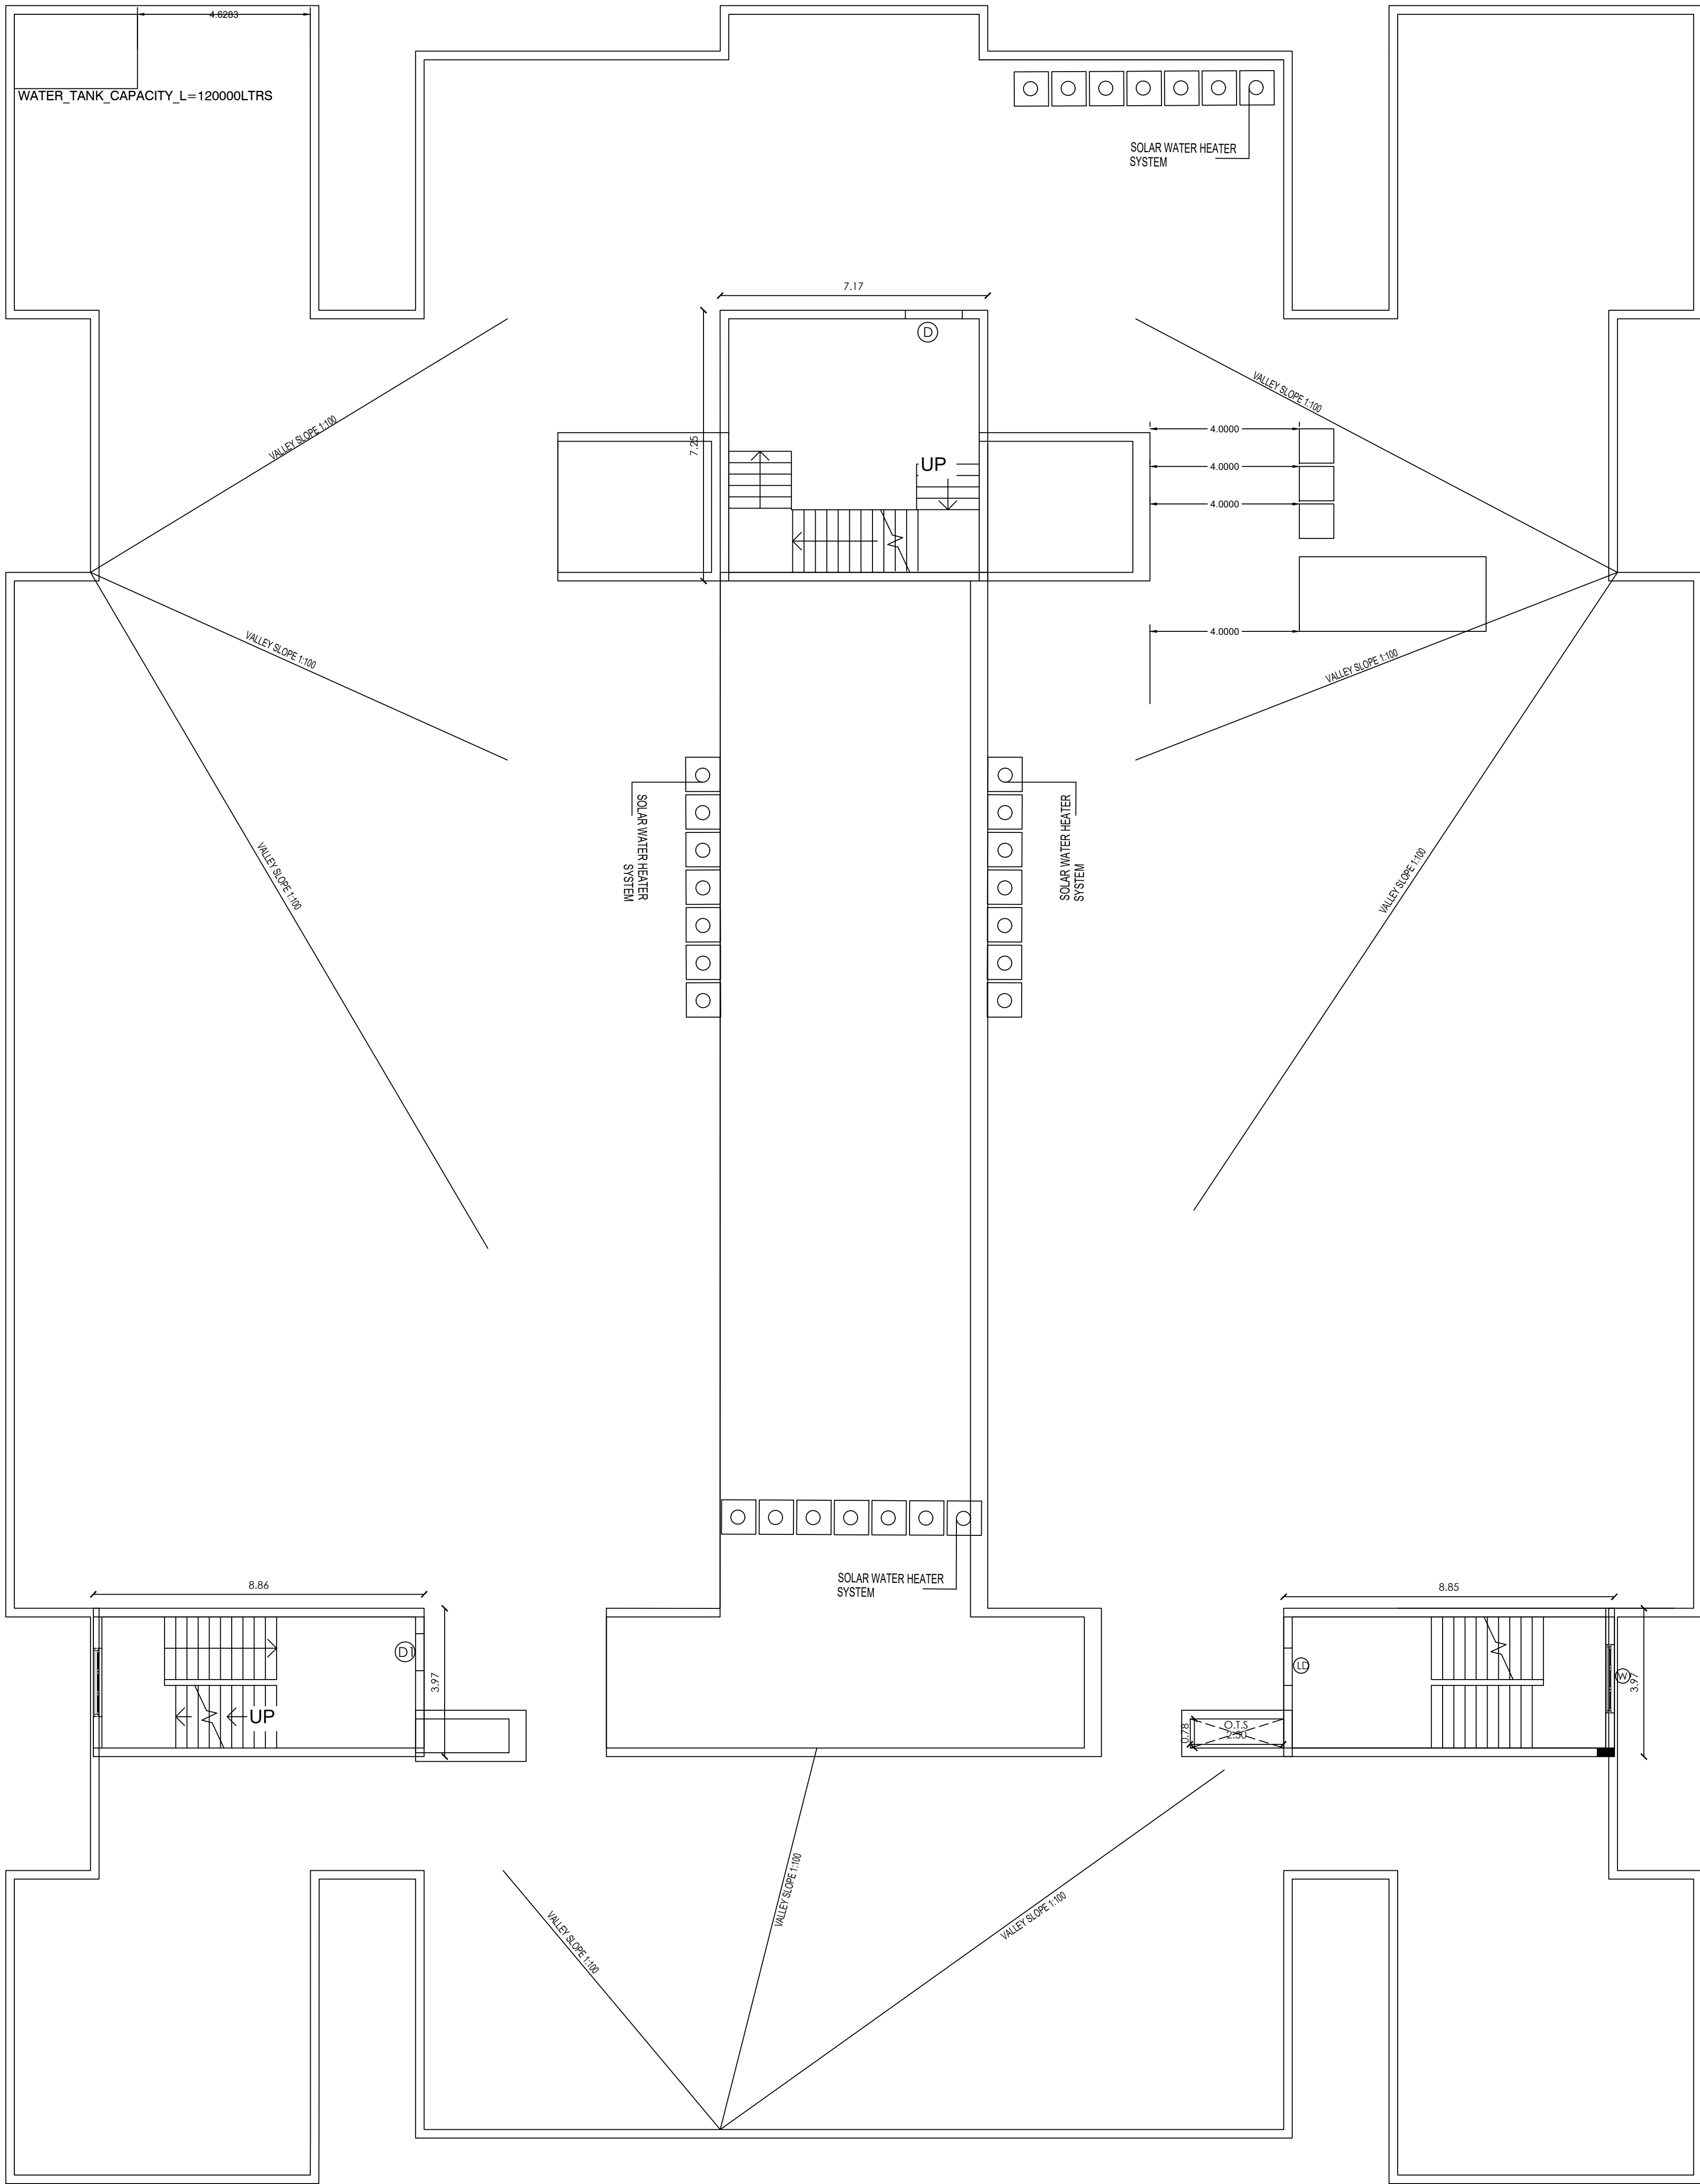

TERRACE FLOOR PLAN

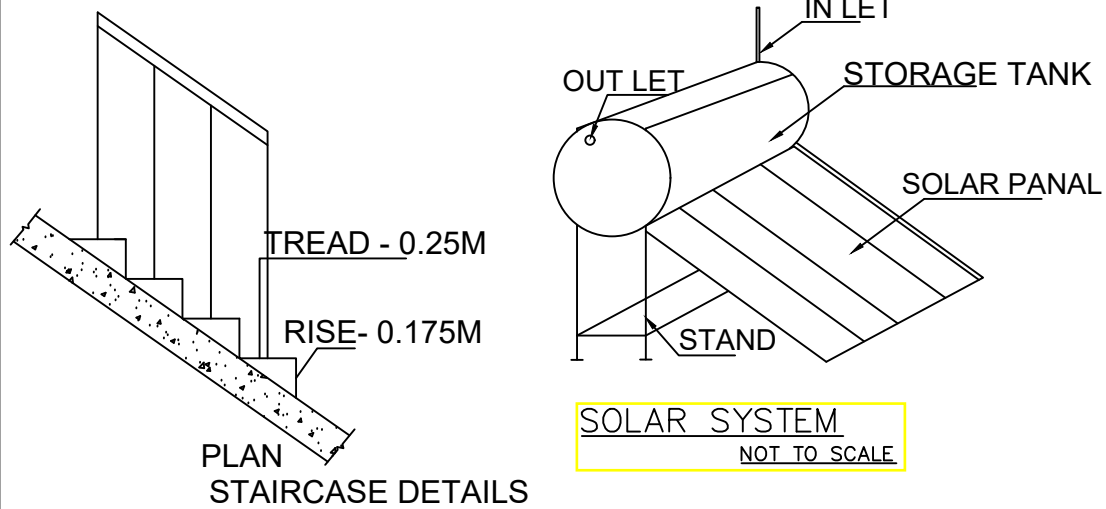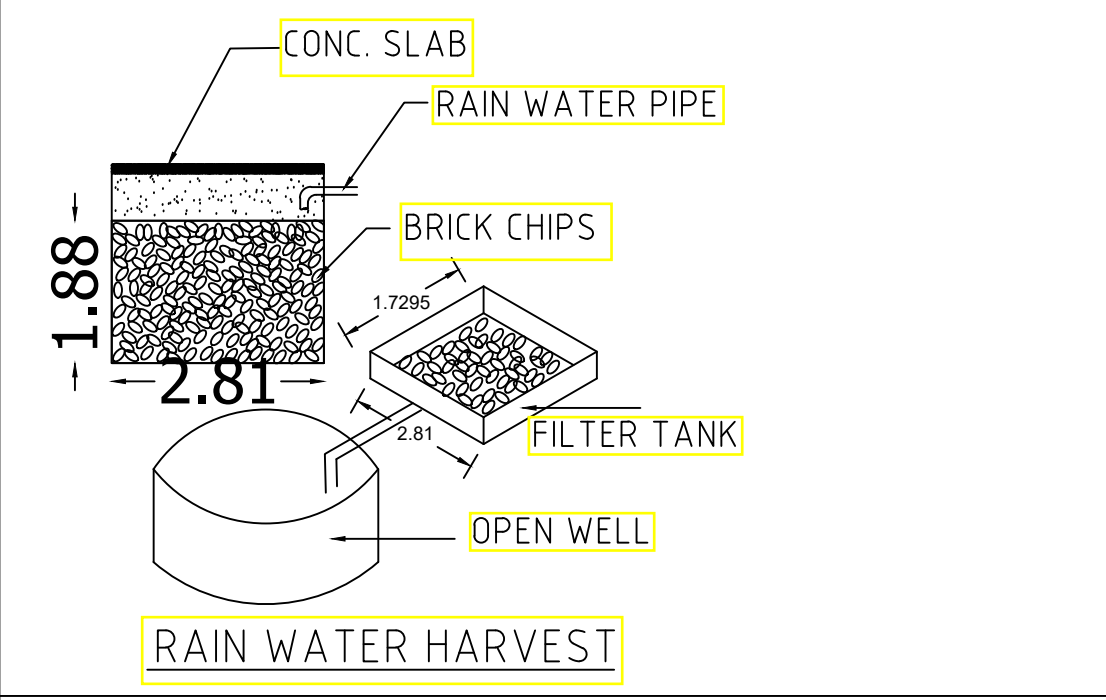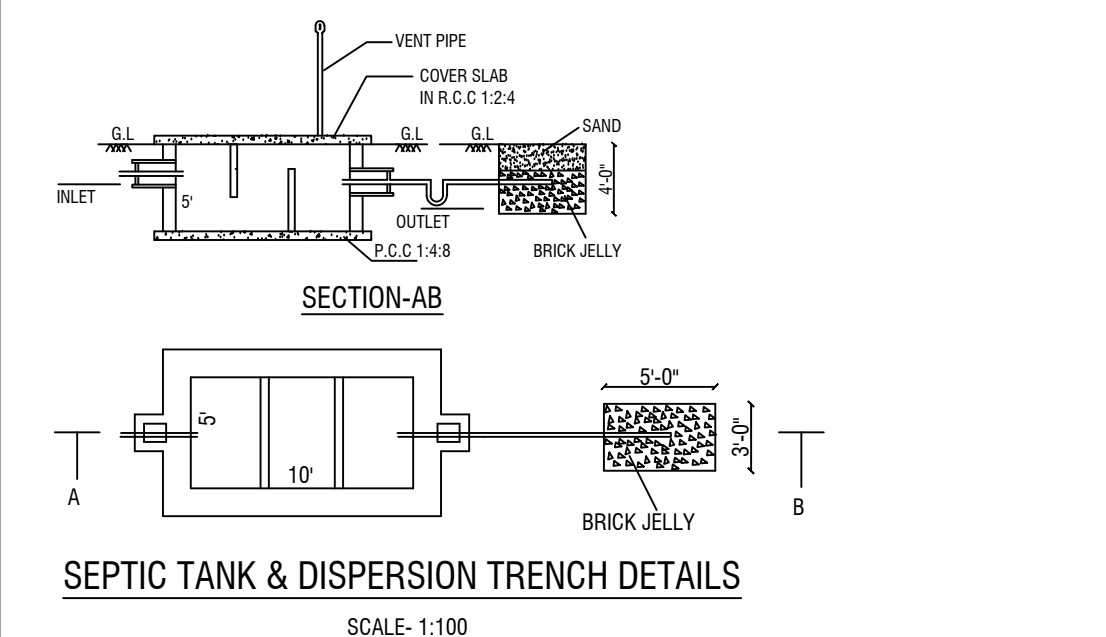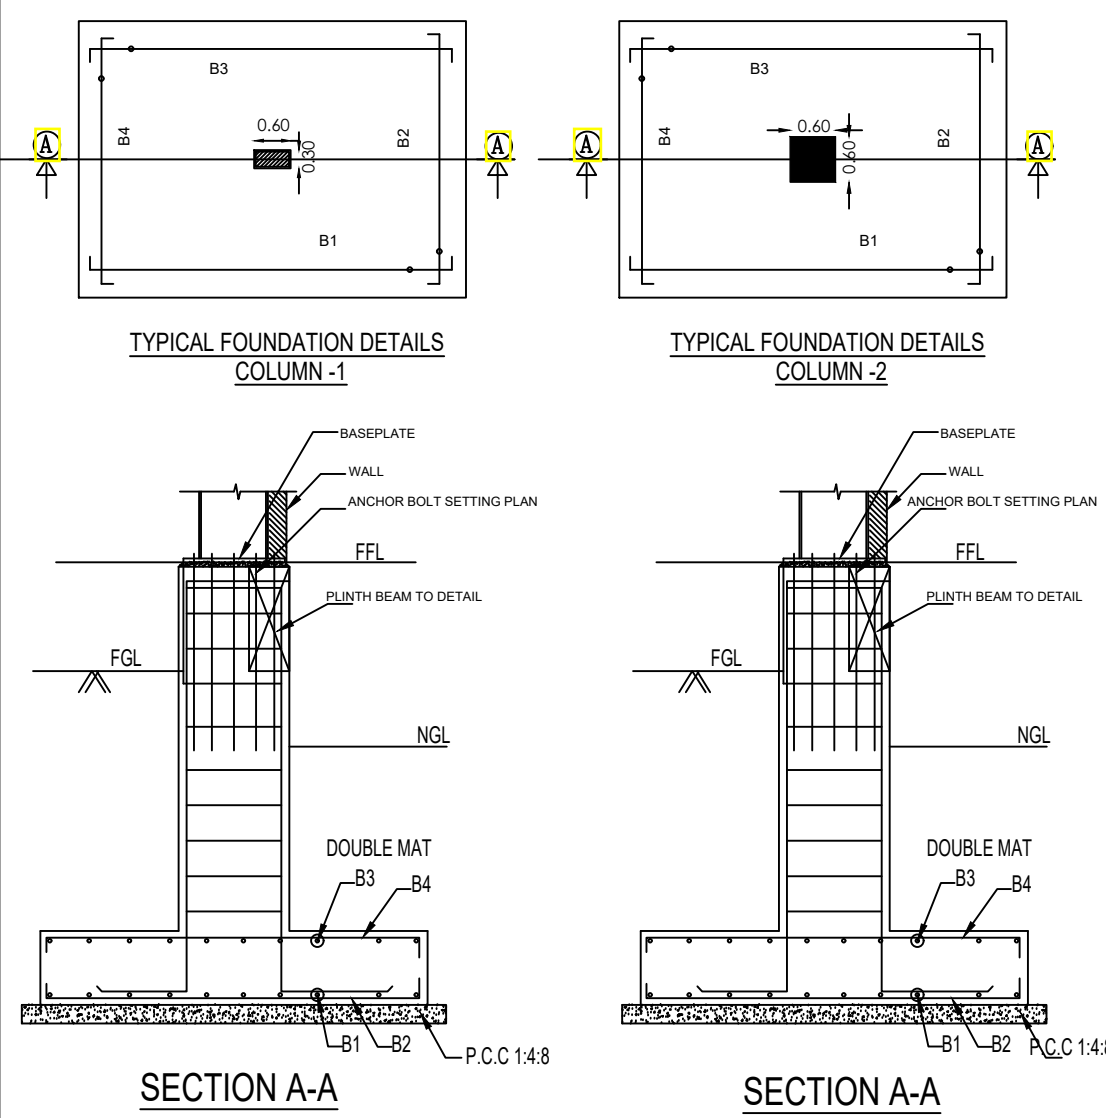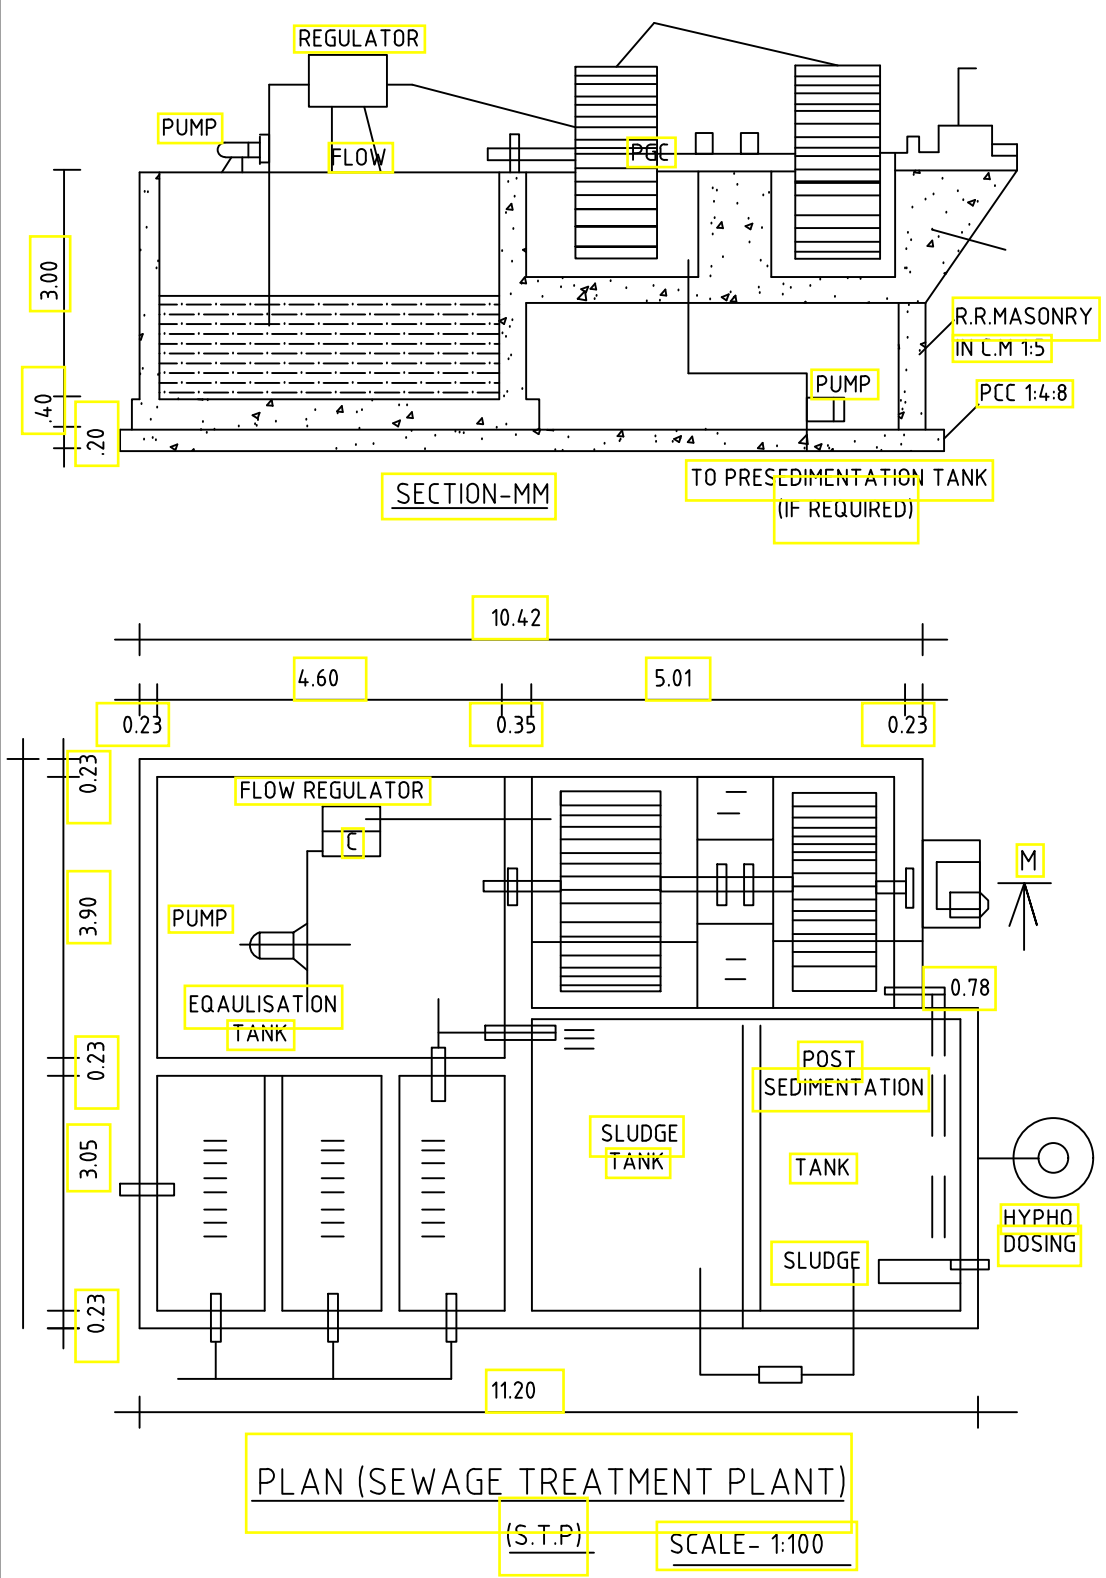

PLAN SHOWING THE PROPOSED CONSTRUCTION OF SENTHIL PUBLIC SCHOOL (CBSE) IN S.F NO:210/1A2,215/1B, 216/2D2,216/2E2, AT KATTINAYNAPALLI VILLAGE & PANCHAYAT, KRISHNAGIRI PANCHAYAT UNION & TALUK,KRISHNAGIRI DISTRICT

ALL DIMENSIONS ARE IN METRE SCALE: 1:100

PROPOSED BUILDING AREA	FSI SQ.MT	NON FSI SQ.MT	TOTAL SQ.MT
BLOCK-I			
OPEN TERRACE FLOOR		122.27	122.27

NOTE: FIRE EXTINGUISHER SAND BUCKET MECHANICAL VENTILATION ARE PROVIDED

For SENTHIL EDUCATIONAL TRUST
PRESIDENT

APPLICANT

S. MURUGESH, M.E., F.I.E.,
Chartered Engineer F-1279323
Structural Engineer Grade-I
(Coimbatore LPA/SE/Gr-I/19-04-19)

STRUCTURAL ENGINEER

S. MURUGESH, M.E., F.I.E.,
Chartered Engineer F-1279323
Structural Engineer Grade-I
(Coimbatore LPA/SE/Gr-I/19-04-19)

REGISTER ENGINEER