


PLAN SHOWING THE PROPOSED CONSTRUCTION OF A.C.SHEET ROOF COMMERCIAL BUILDING IN S.F.NO: 162/4B, NEW NO: 162/4B1, PATTA NO: 5861, WARD : 13, AT KUKKALPATTY KATTUVALAVU, MALLIKUNDHAM MAIN ROAD, MECHERI PO, MECHERI SPECIAL GRADE TOWN PANCHAYAT, METTUR -TALUK, SALEM DIST.

SCALE 1:100

APPLICANTS : 1. Mr. R. HARIHARAN, S/O. RAJENDRAN,
2. Mr. R. RAMKUMAR, S/O. RAJENDRAN,

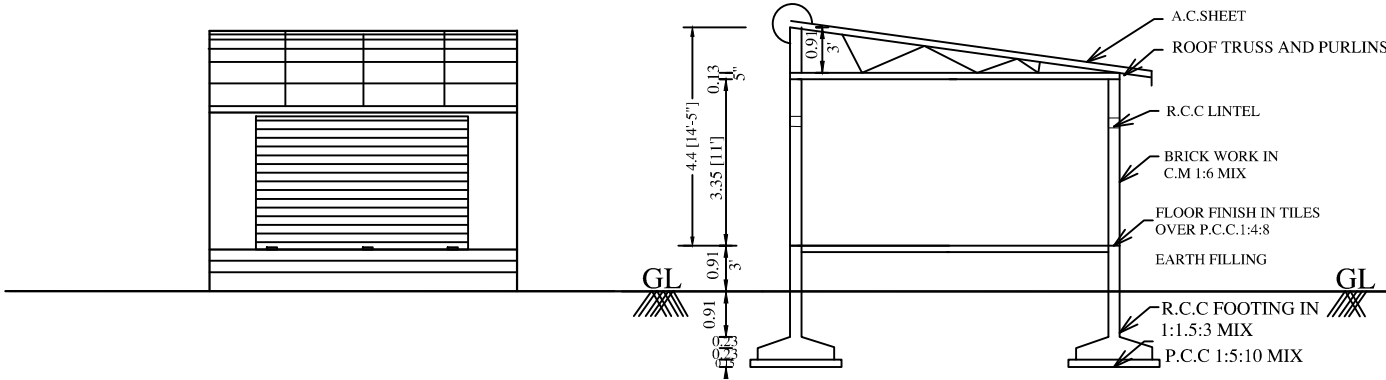

ELEVATION

SECTION ON AA

DETAILS OF JOINERIES

RS- ROLLING SHUTTER 4.51 X 2.13
D1- DOOR 0.76 X 2.13
V - VENTILATOR 0.91 X 0.76
W- WINDOW 1.22 X 1.22

AREA DETAILS:-

	Sq.ft.	Sq.mt.
TOTAL LAND AREA (AS PER DOC)	5893.75	547.75
PROPOSED BUILDING AREA -	600.00	55.76
CARPET AREA	527.25	49.00
OPEN SPACE AREA	5293.75	491.99

ENGINEER


C. Balh.
Er.T.BALAMURUGAN,
REGISTERED ENGINEER (gr:1)
Salem main road, MECHERI,
Mettur Tk, Salem 636453,
Cell: 98947 53044

OFFICE USE ONLY :-

LEGEND:-



BOUNDARY SHOWN IN --- ---
PROPOSED BUILDING SHOWN IN
EXISTING ROAD SHOWN IN---

FOUNDATION
DETAIL - A

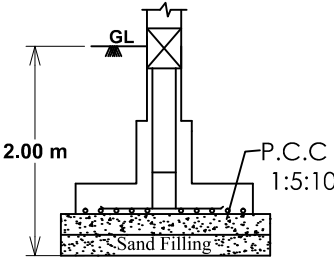


Isolated Footing -A (1.50X1.50)
(Not to Scale)

 Septic Tank With U Trap
Not To Scale

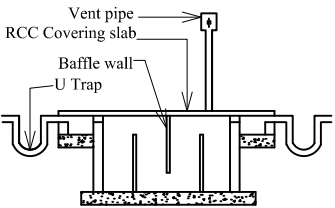


Using 'U' type trap 2 Nos in inlet, outlet & Ventpipe
will be covered with mosquito proof covering net in
inner side of vent pipe and top of vent pipe

Solar Energy
Not To Scale

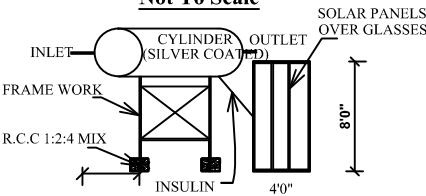

Waste Water (RAIN WATER)
Recycle Unit Not To Scale

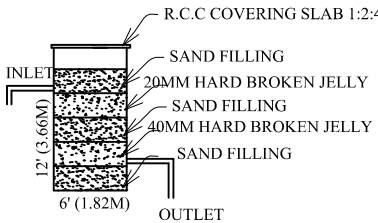



Bath & wash basin pipe line connection is
directly connected to the rectangle pit for
recycling the waste water.

APPLICANT

-
-

SITE PLAN

SCALE 1:100

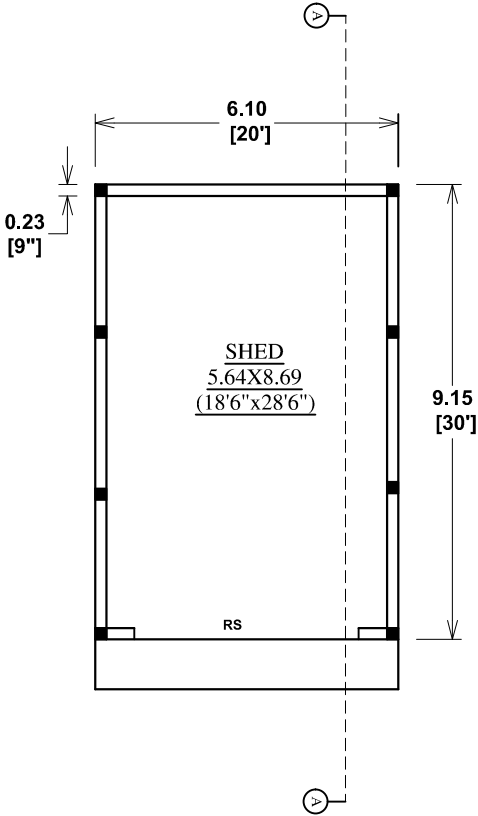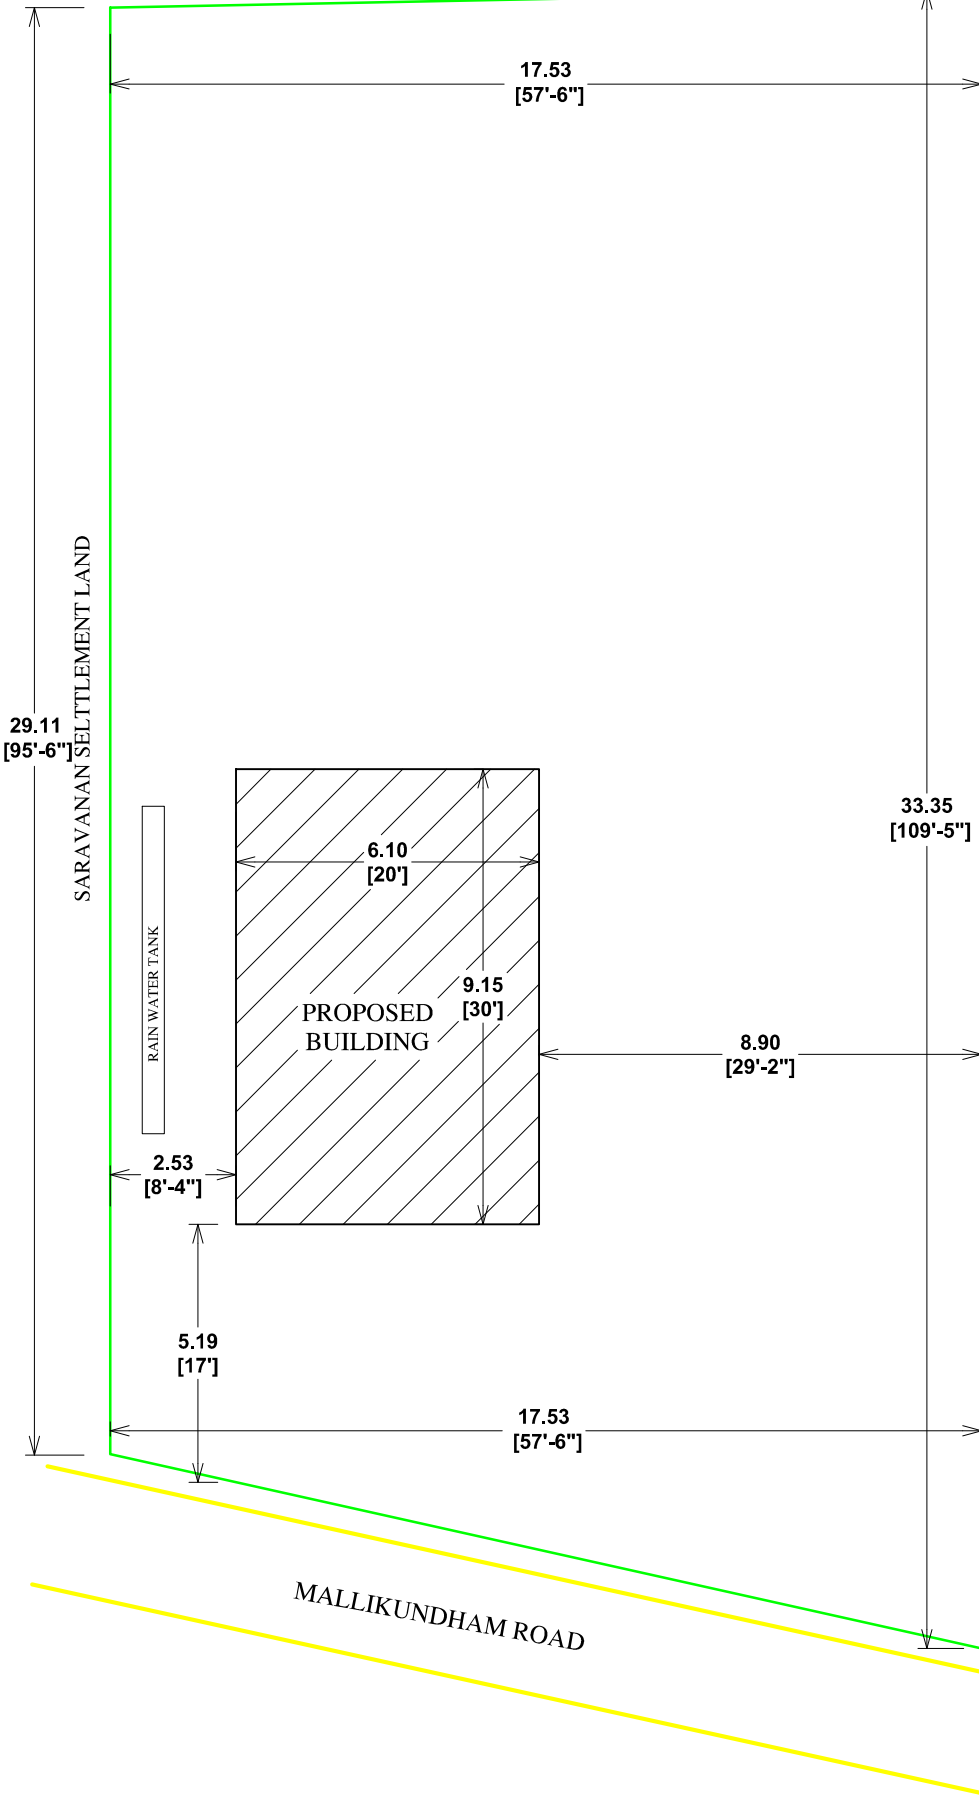

FLOOR PLAN
FACED TO NORTH