
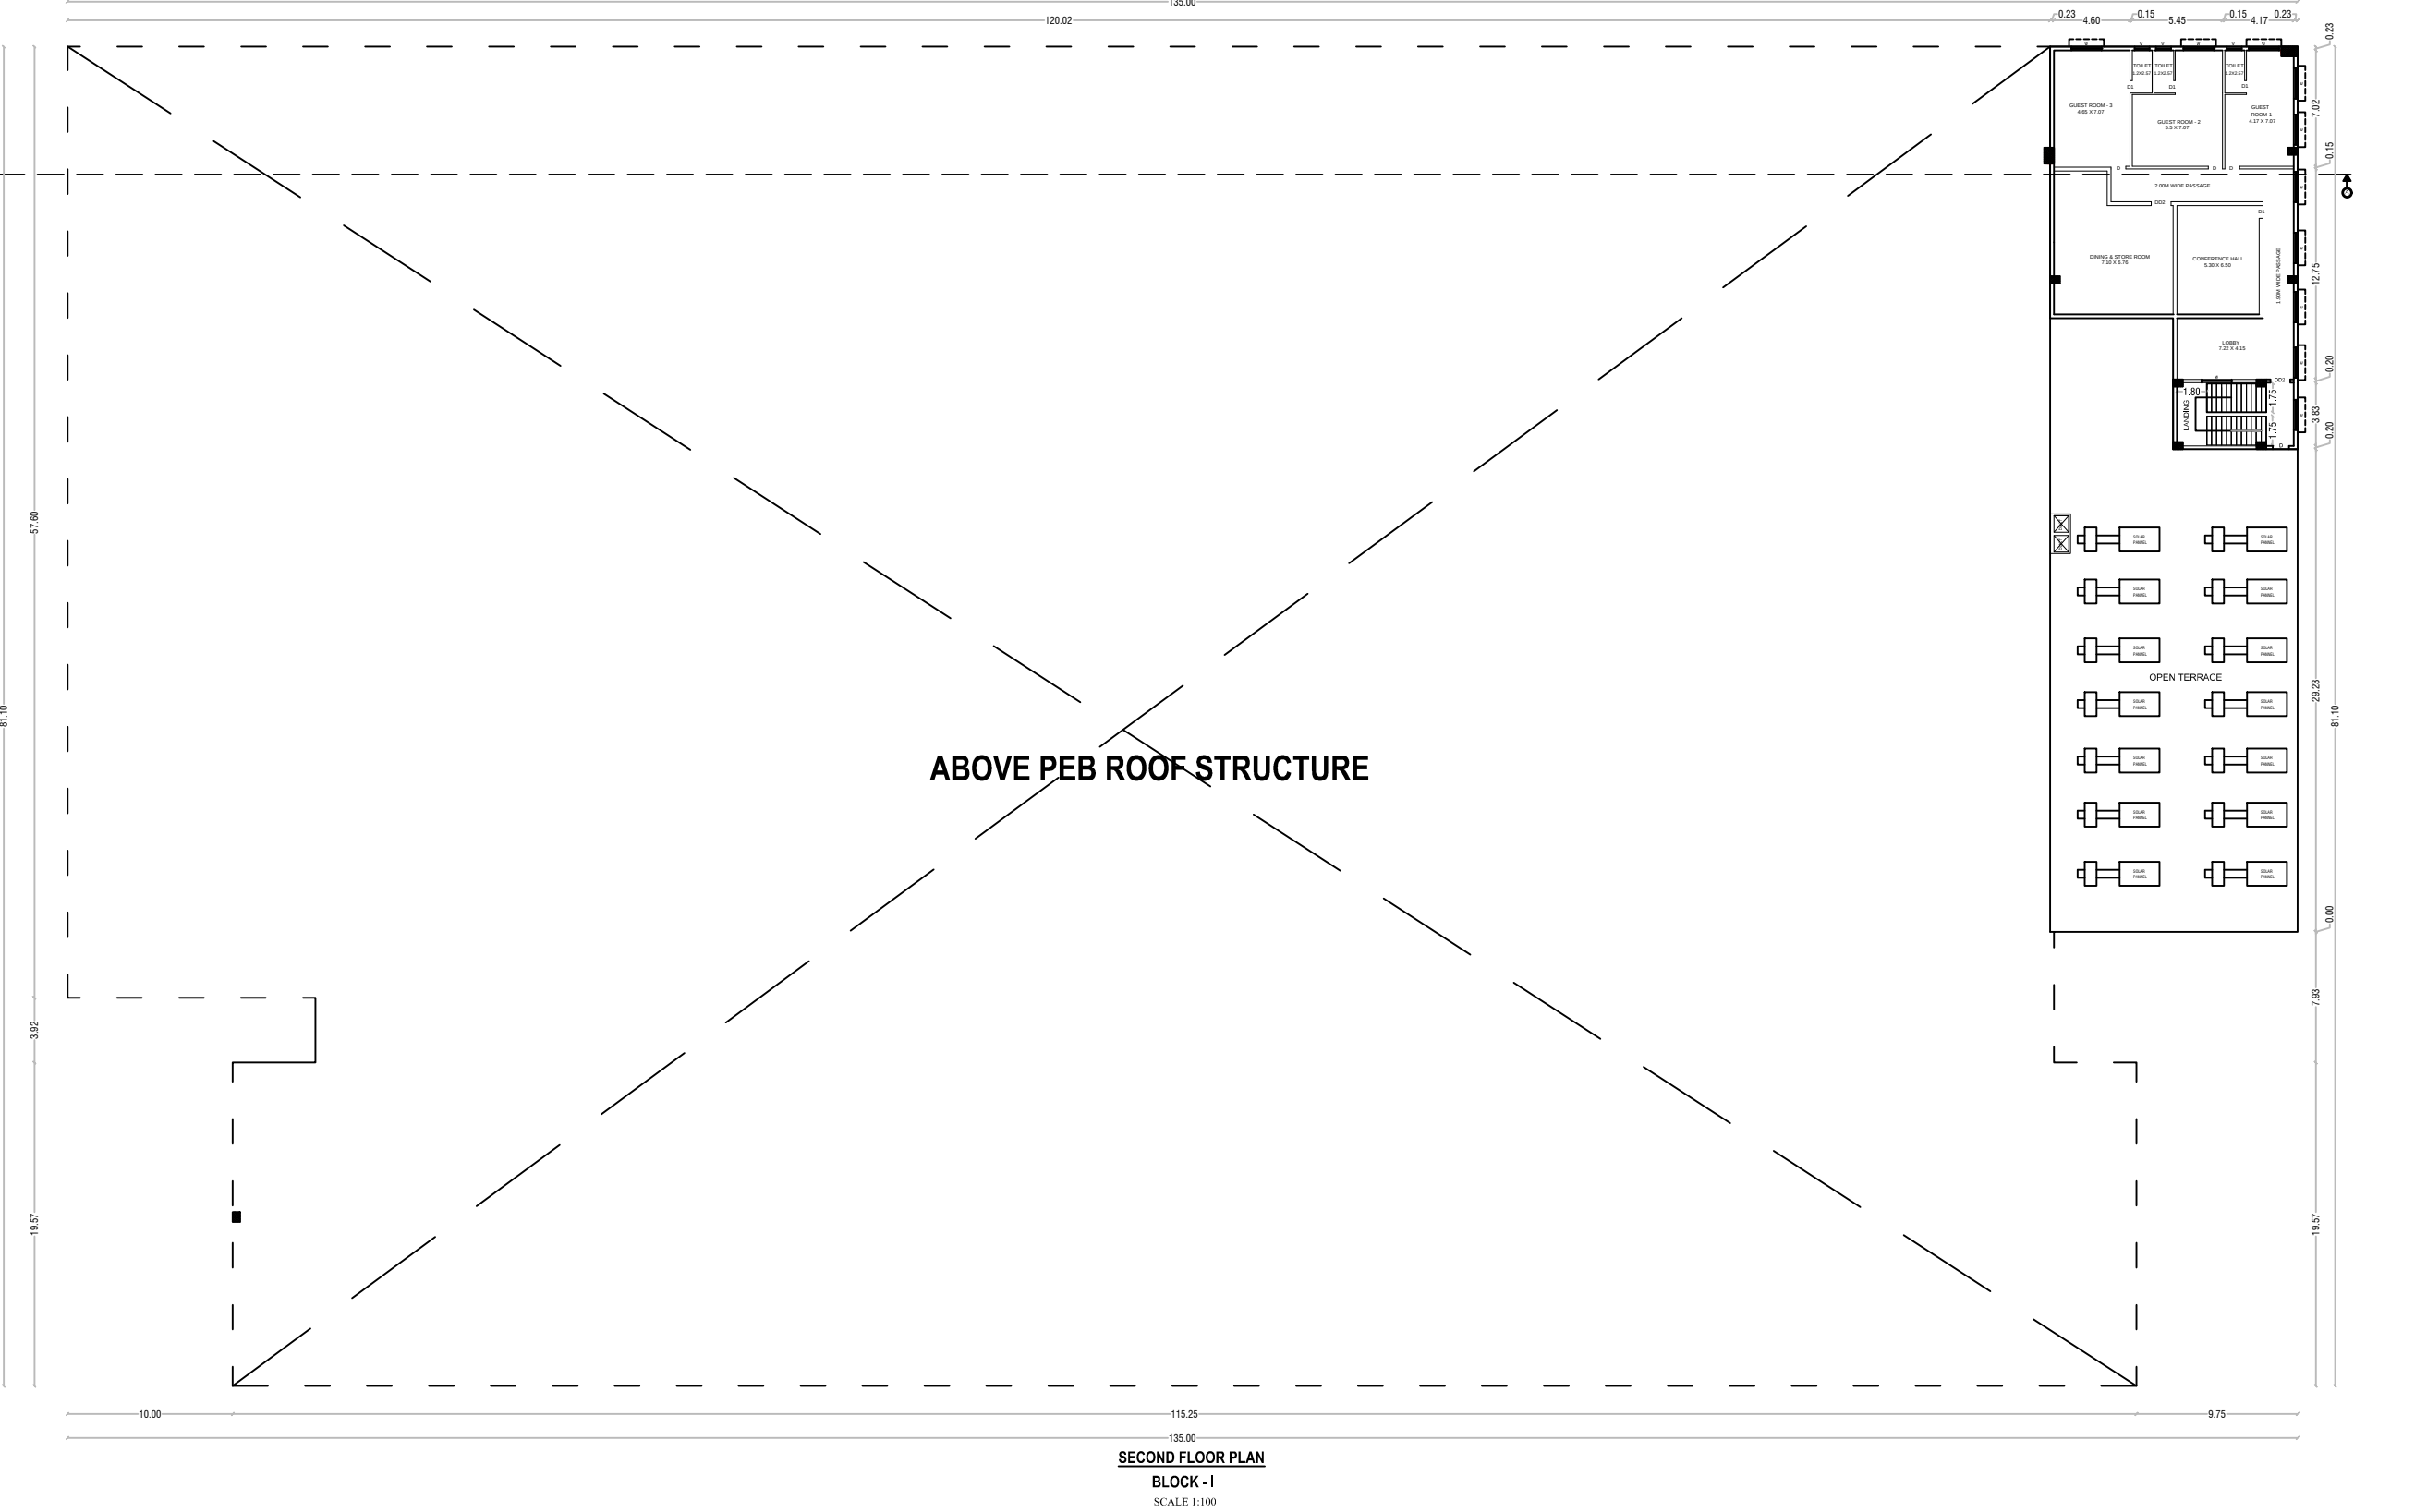
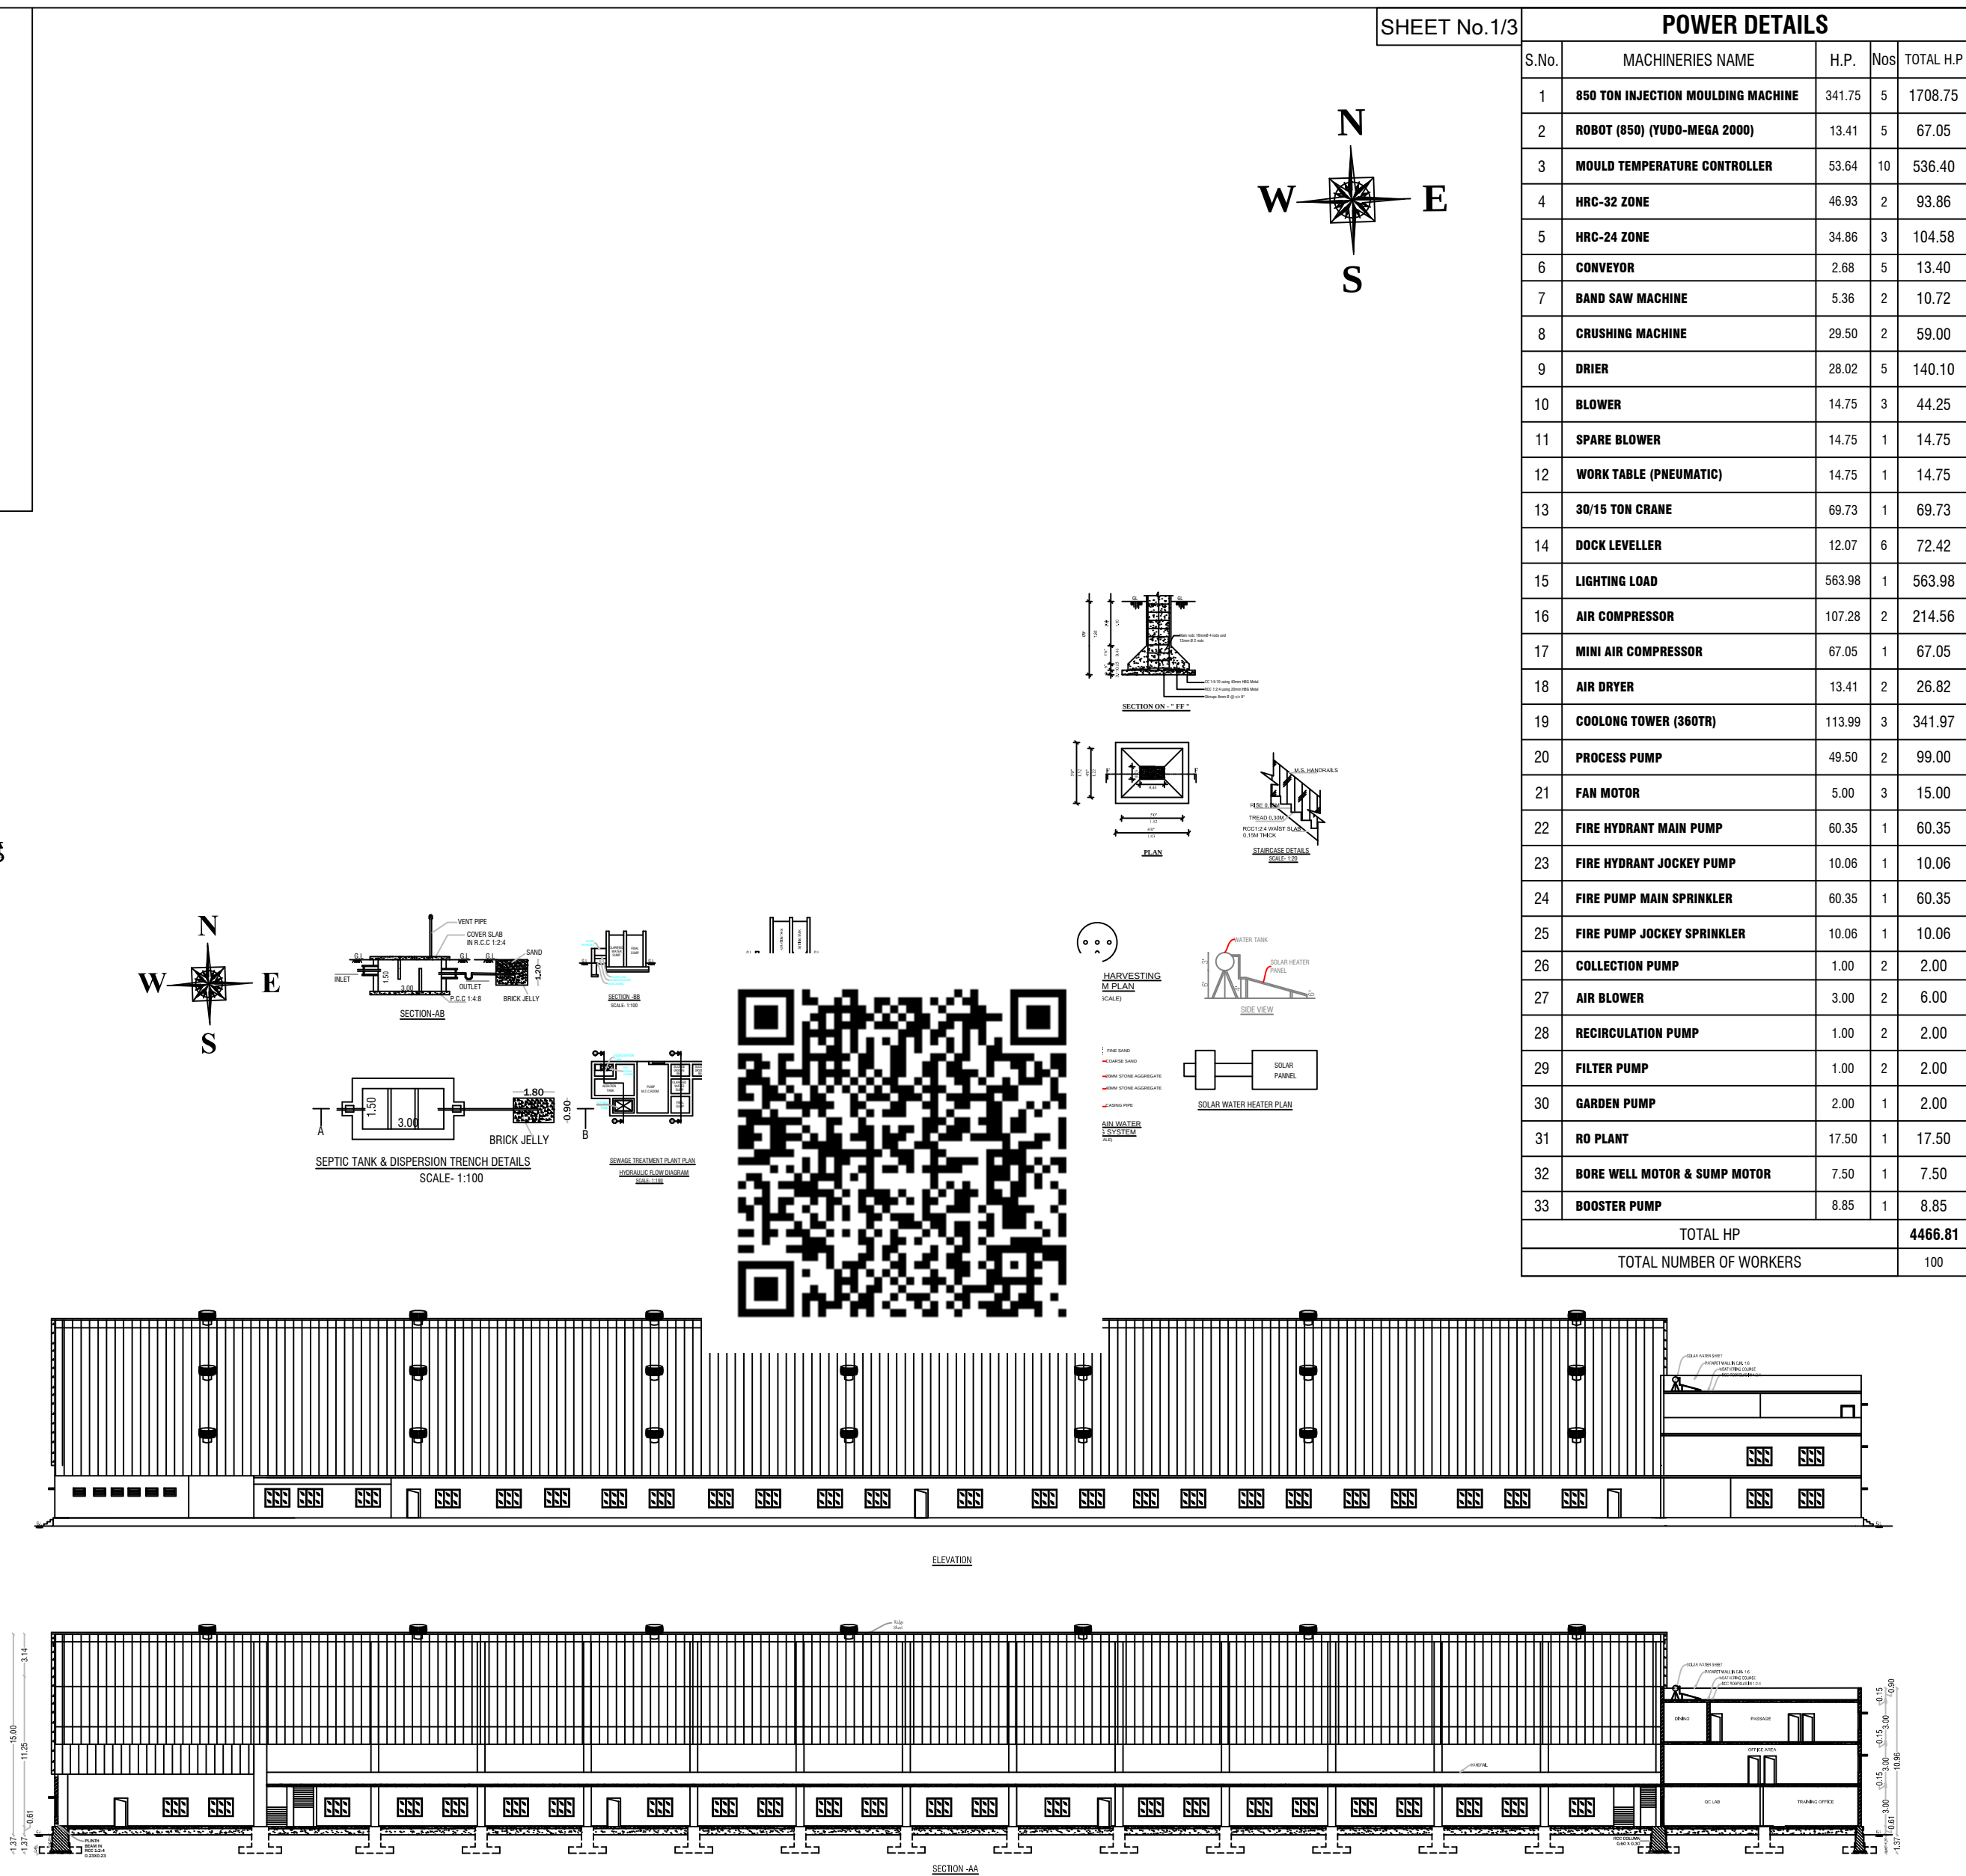


PLAN SHOWING THE PROPOSED CONSTRUCTION OF GROUND FLOOR, FIRST FLOOR & SECOND FLOOR INDUSTRIAL BUILDING FOR "M/S SEYON E-HWA SUMMMIT MOBILITY KRISHNAGIRI PVT LTD"- ORANGE INDUSTRIES-(PLASTIC INDUSTRIES LIKE INJECTION MOLDING) IN PLOT NO:B2B6/D, SF.No: 86/3 PART, 86/4 PART, 91/3 PART, 92/1 PART, 92/3 PART, 92/4 PART & 93 PART AT SIPCOT INDUSTRIAL PARK, OLAIPATTI VILLAGE, SALAMARATUPATTI PANCHAYAT, MATHUR PANCHAYAT UNION, UTHANGARAI TALUK, KRISHNAGIRI DISTRICT.

DTCP REVISED LAYOUT APPROVAL No.175/2023

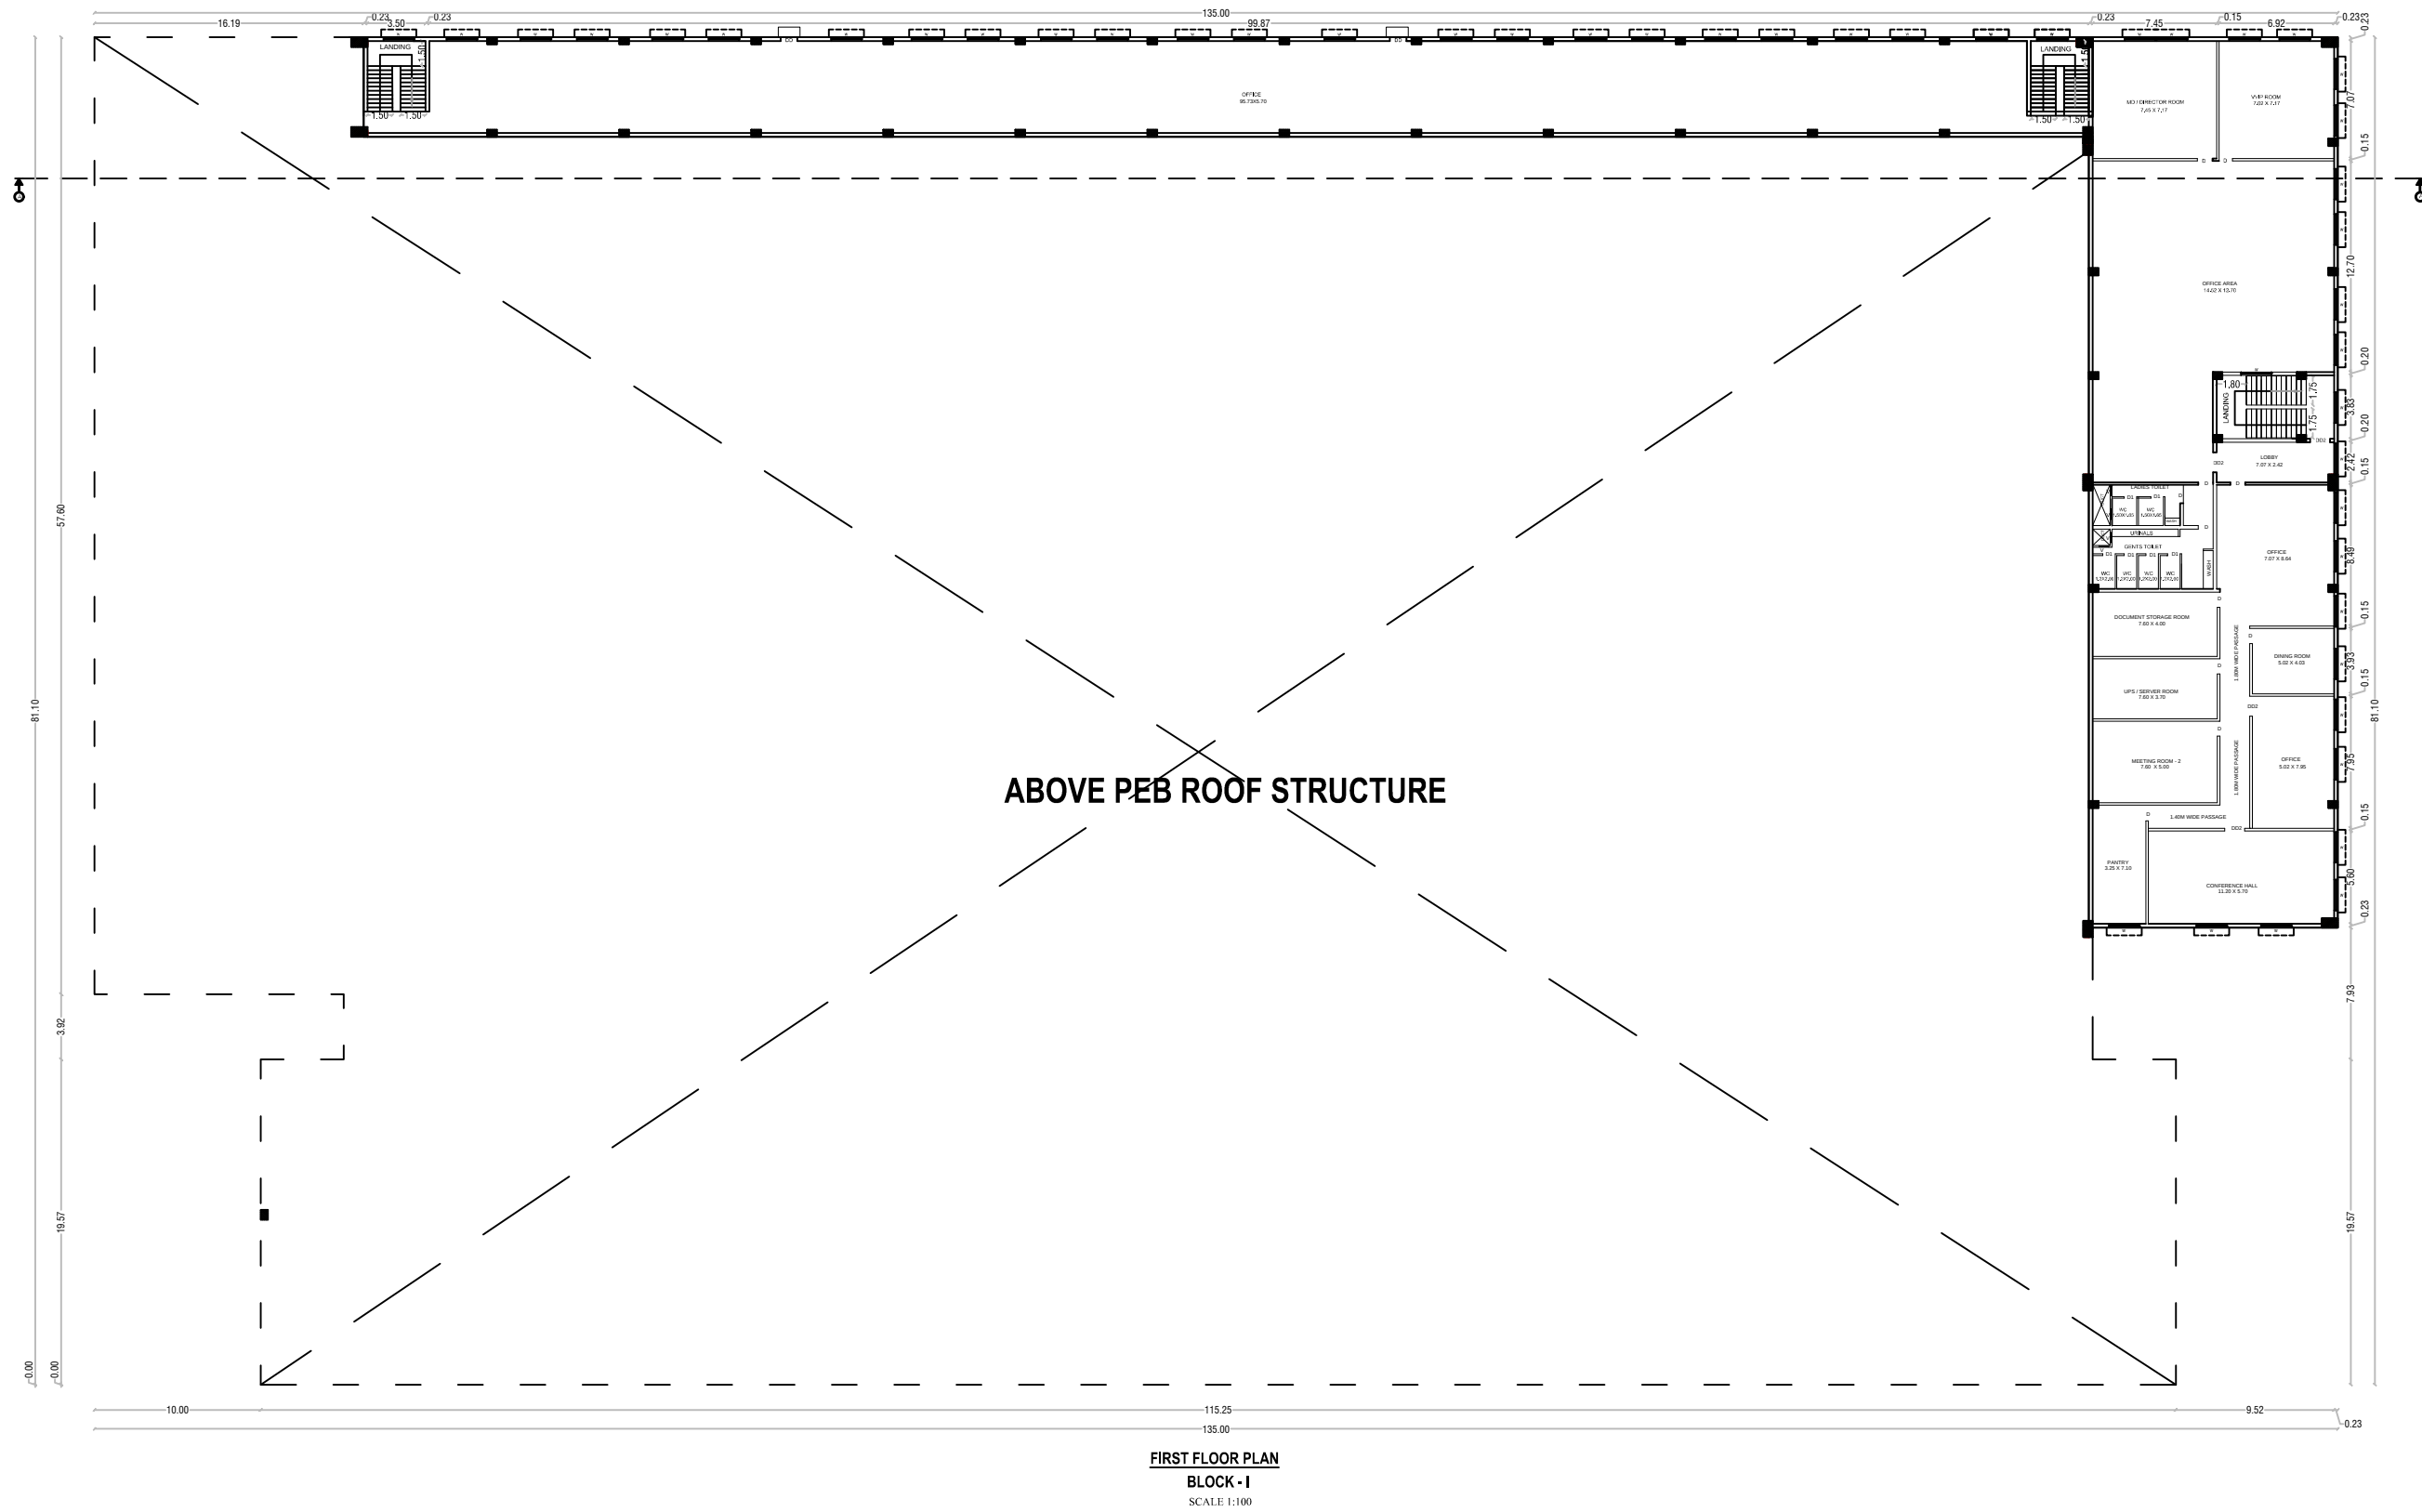

POWER DETAILS			
S.No.	MACHINERIES NAME	H.P.	Nos
1	850 TON INJECTION Moulding MACHINE	341.75	5
2	ROBOT (RSO) (YUDO-MEGA 2000)	13.41	5
3	MOULD TEMPERATURE CONTROLLER	53.64	10
4	HRC-32 ZONE	46.93	2
5	HRC-24 ZONE	34.86	3
6	CONVEYOR	2.68	5
7	BAND SAW MACHINE	5.36	2
8	CRUSHING MACHINE	29.50	2
9	DRIER	28.02	5
10	BLOWER	14.75	3
11	SPARE BLOWER	14.75	1
12	WORK TABLE (PNEUMATIC)	14.75	1
13	30/15 TON CRANE	69.73	1
14	DOCK LEVELLER	12.07	8
15	LIGHTING LOAD	563.98	1
16	AIR COMPRESSOR	107.28	2
17	MINI AIR COMPRESSOR	67.05	1
18	AIR DRYER	13.41	2
19	COOLING TOWER (360TR)	113.99	3
20	PROCESS PUMP	49.50	2
21	FAN MOTOR	5.00	3
22	FIRE HYDRANT MAIN PUMP	60.35	1
23	FIRE HYDRANT JOCKEY PUMP	10.06	1
24	FIRE PUMP MAIN SPRINKLER	60.35	1
25	FIRE PUMP JOCKEY SPRINKLER	10.06	1
26	COLLECTION PUMP	1.00	2
27	AIR BLOWER	3.00	2
28	RECIRCULATION PUMP	1.00	2
29	FILTER PUMP	1.00	2
30	GARDEN PUMP	2.00	1
31	RO PLANT	17.50	1
32	BORE WELL MOTOR & SUMP MOTOR	7.50	1
33	BOOSTER PUMP	8.85	1
TOTAL HP		4466.81	
TOTAL NUMBER OF WORKERS		100	

OFFICE USE			

PLAN SHOWING THE PROPOSED CONSTRUCTION OF GROUND FLOOR, FIRST FLOOR & SECOND FLOOR INDUSTRIAL BUILDING FOR "M/S SEYON E-HWA SUMMMIT MOBILITY KRISHNAGIRI PVT LTD"-


ORANGE INDUSTRIES-(PLASTIC INDUSTRIES LIKE INJECTION MOLDING) IN PLOT NO:B2B6/D, SF.No: 86/3 PART, 86/4 PART, 91/3 PART, 92/1 PART, 92/3 PART, 92/4 PART & 93 PART AT SIPCOT INDUSTRIAL PARK,

OLAIPATTI VILLAGE, SALAMARATUPATTI PANCHAYAT, MATHUR PANCHAYAT UNION, UTHANGARAI TALUK, KRISHNAGIRI DISTRICT.





DTCP REVISED LAYOUT APPROVAL No.175/2023

SHEET No.2/3

OFFICE USE

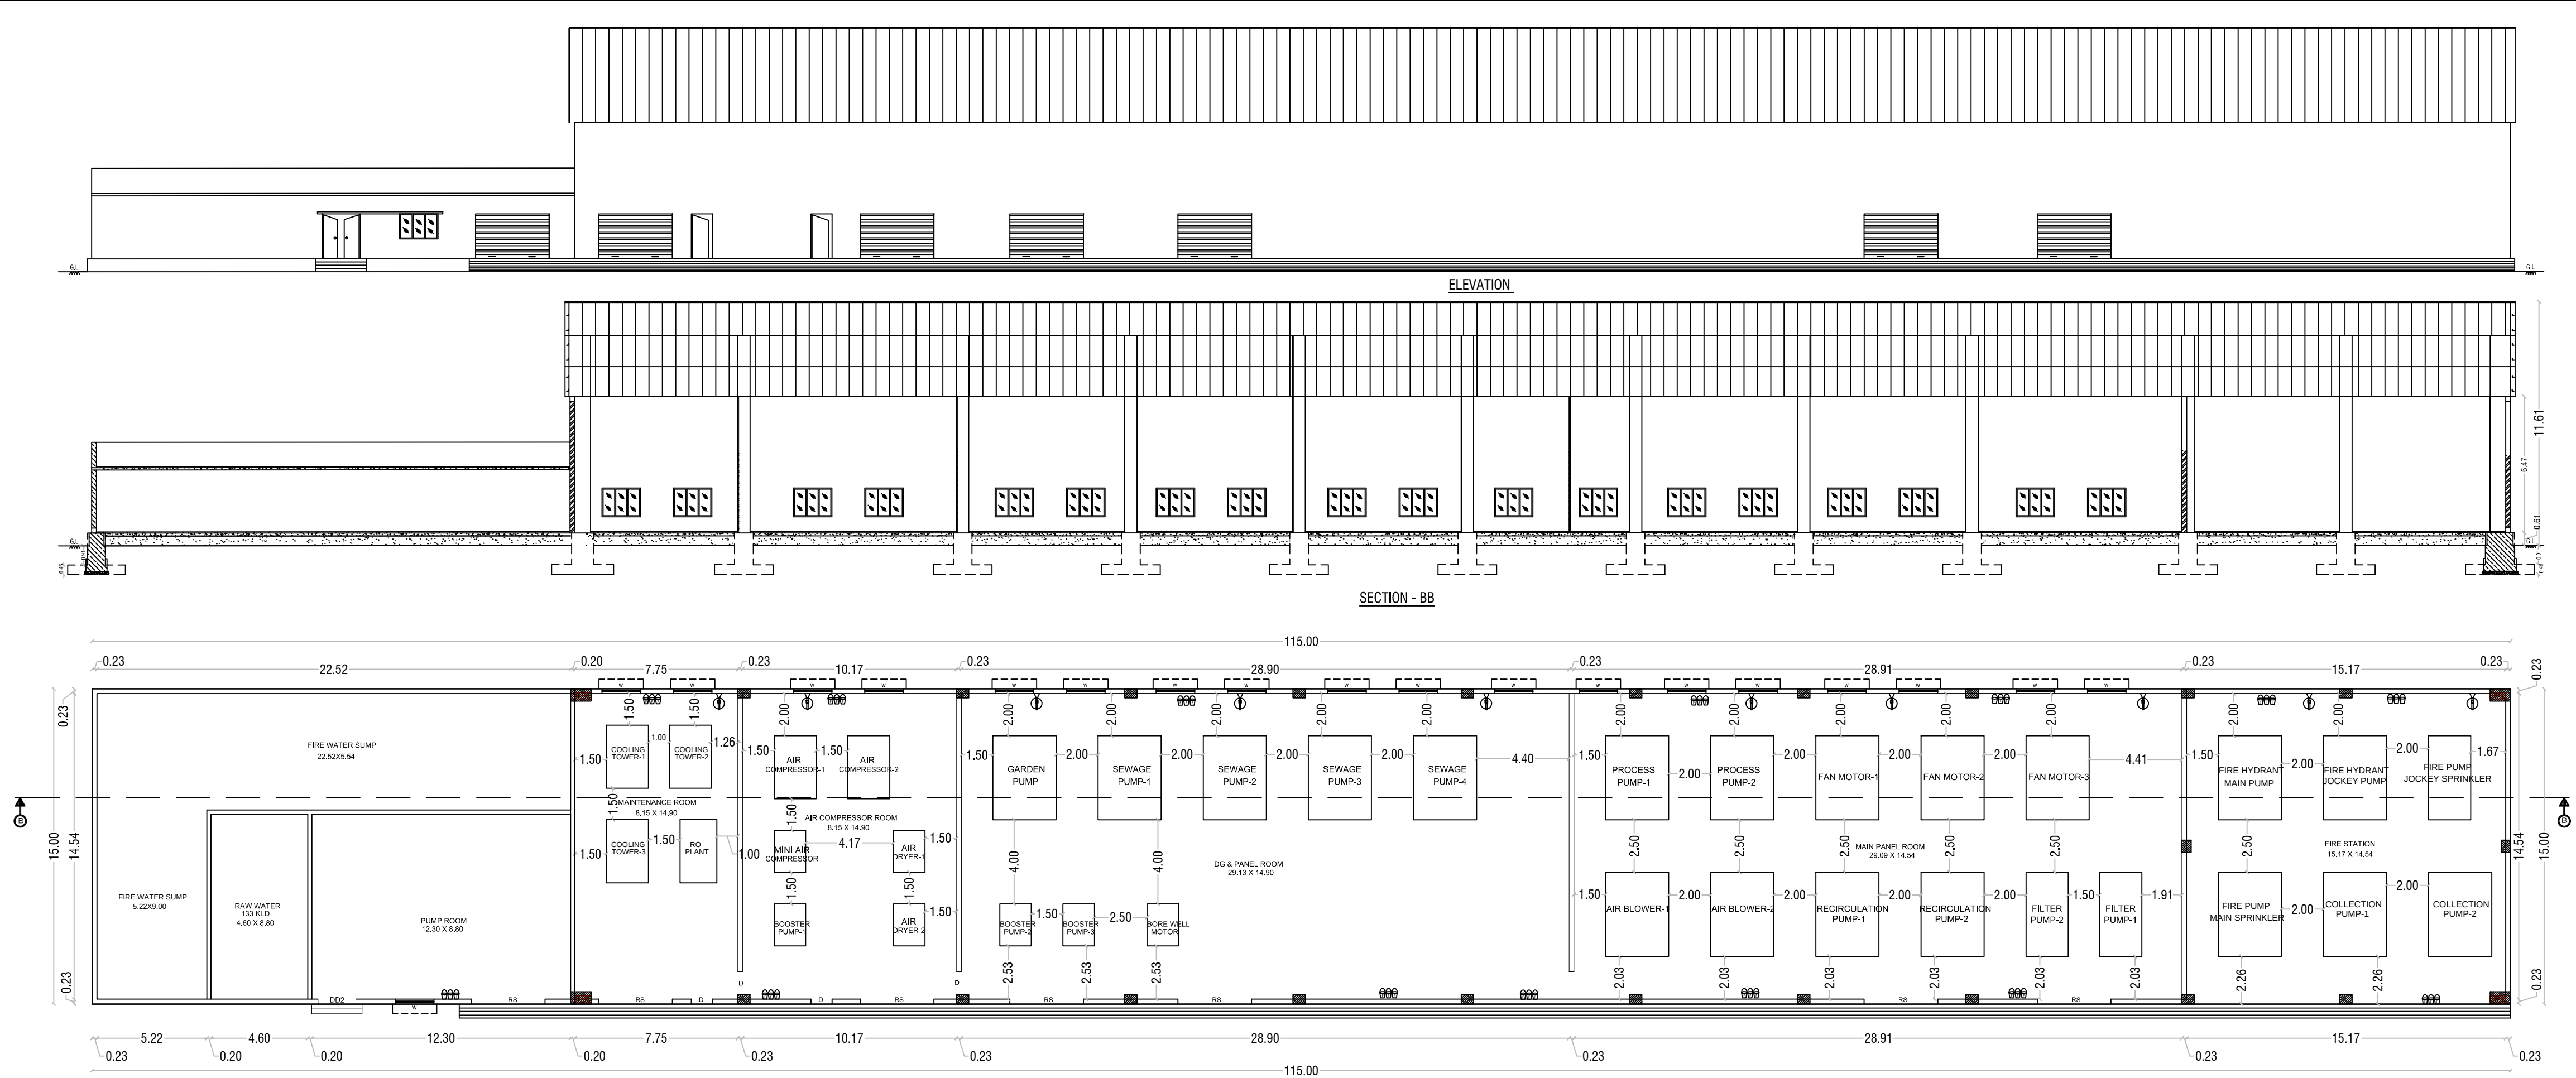

GROUND FLOOR PLAN
BLOCK - II
SCALE 1:100

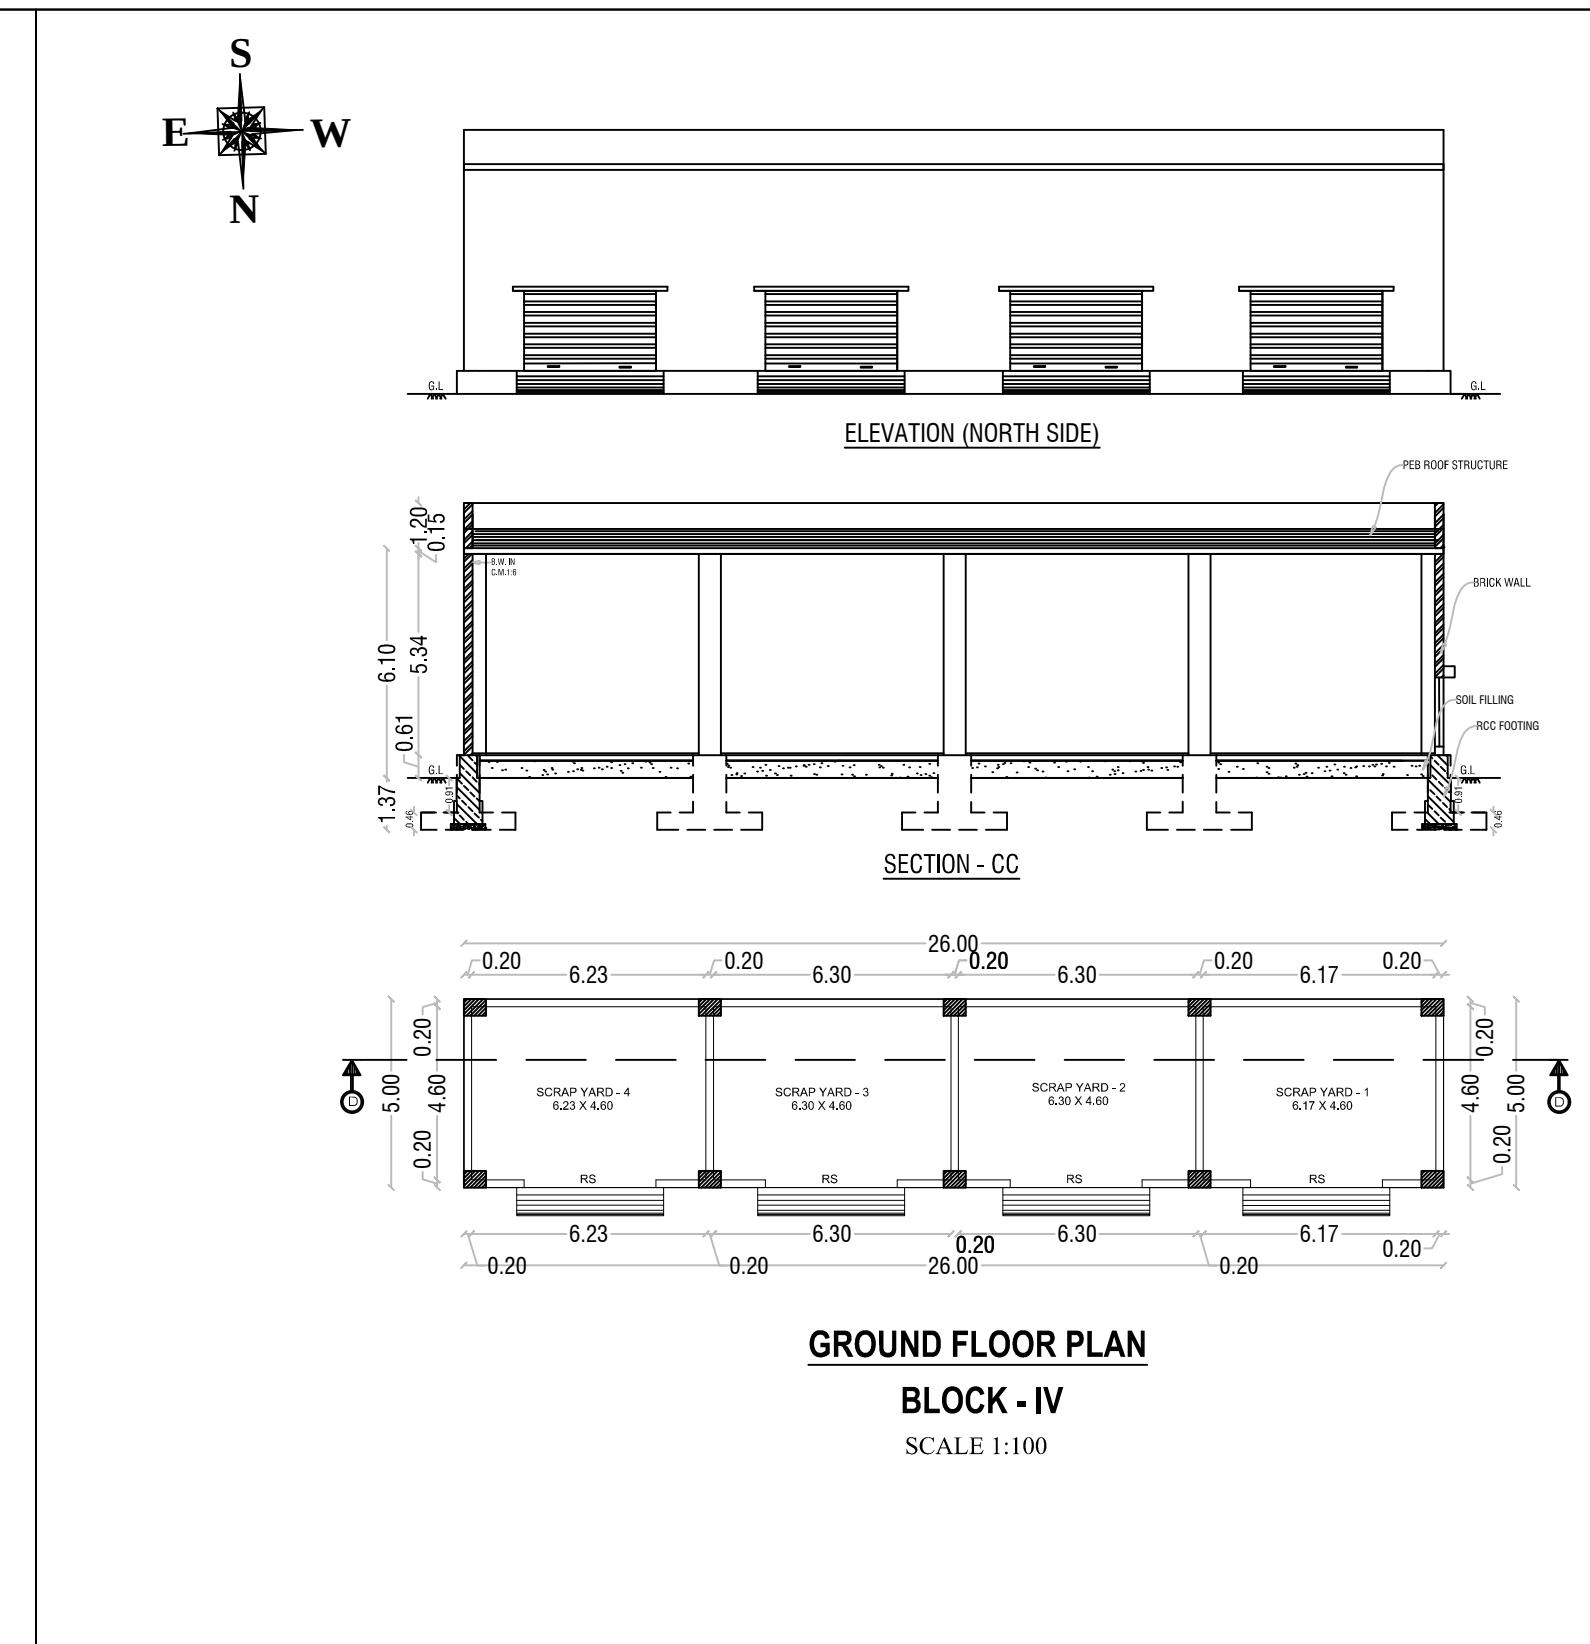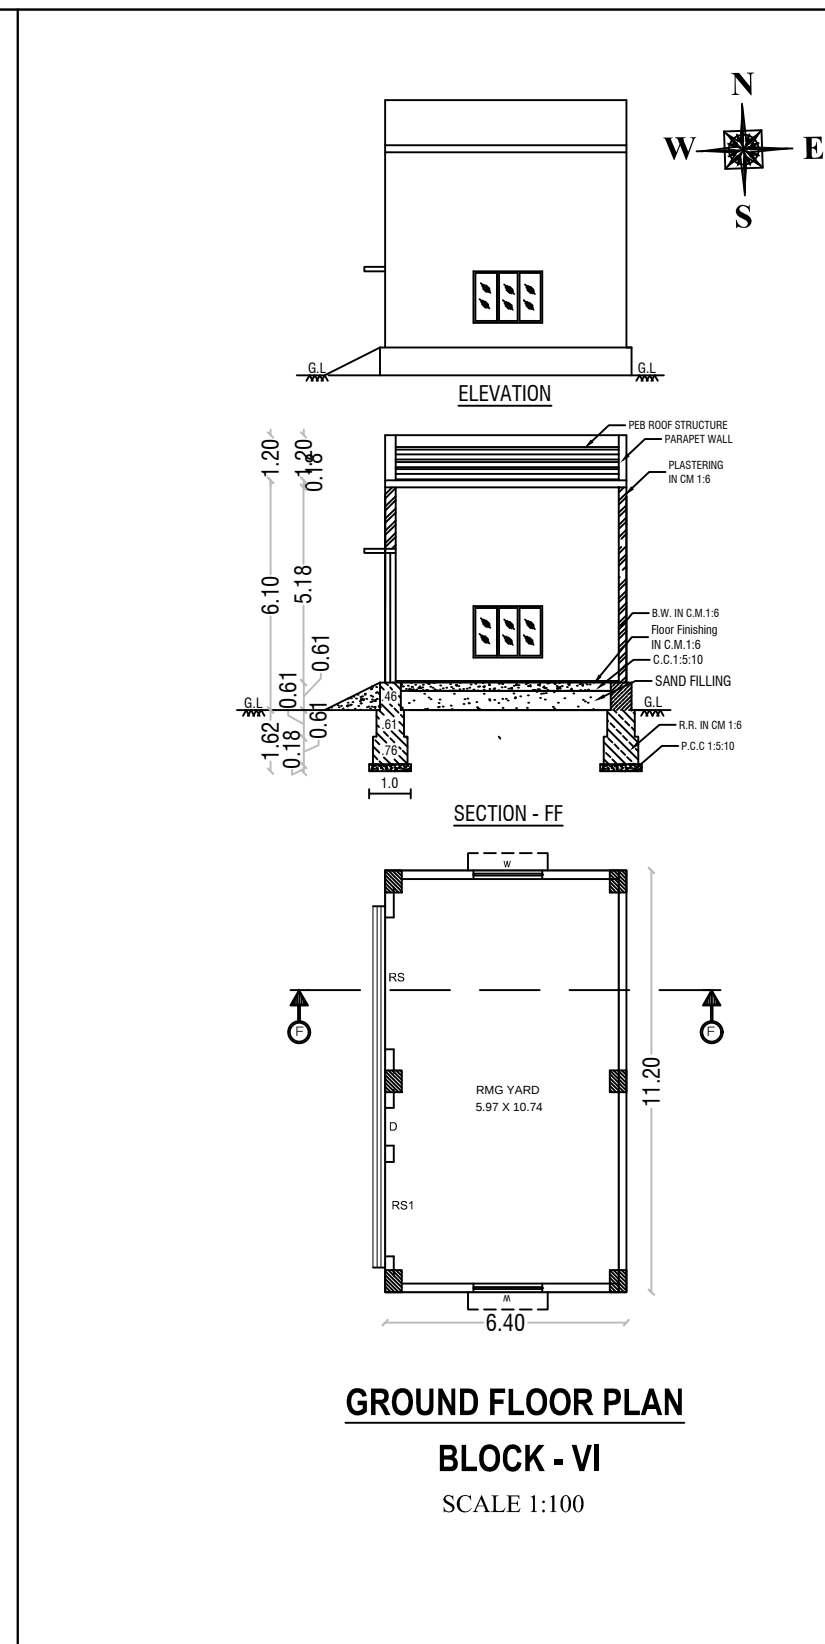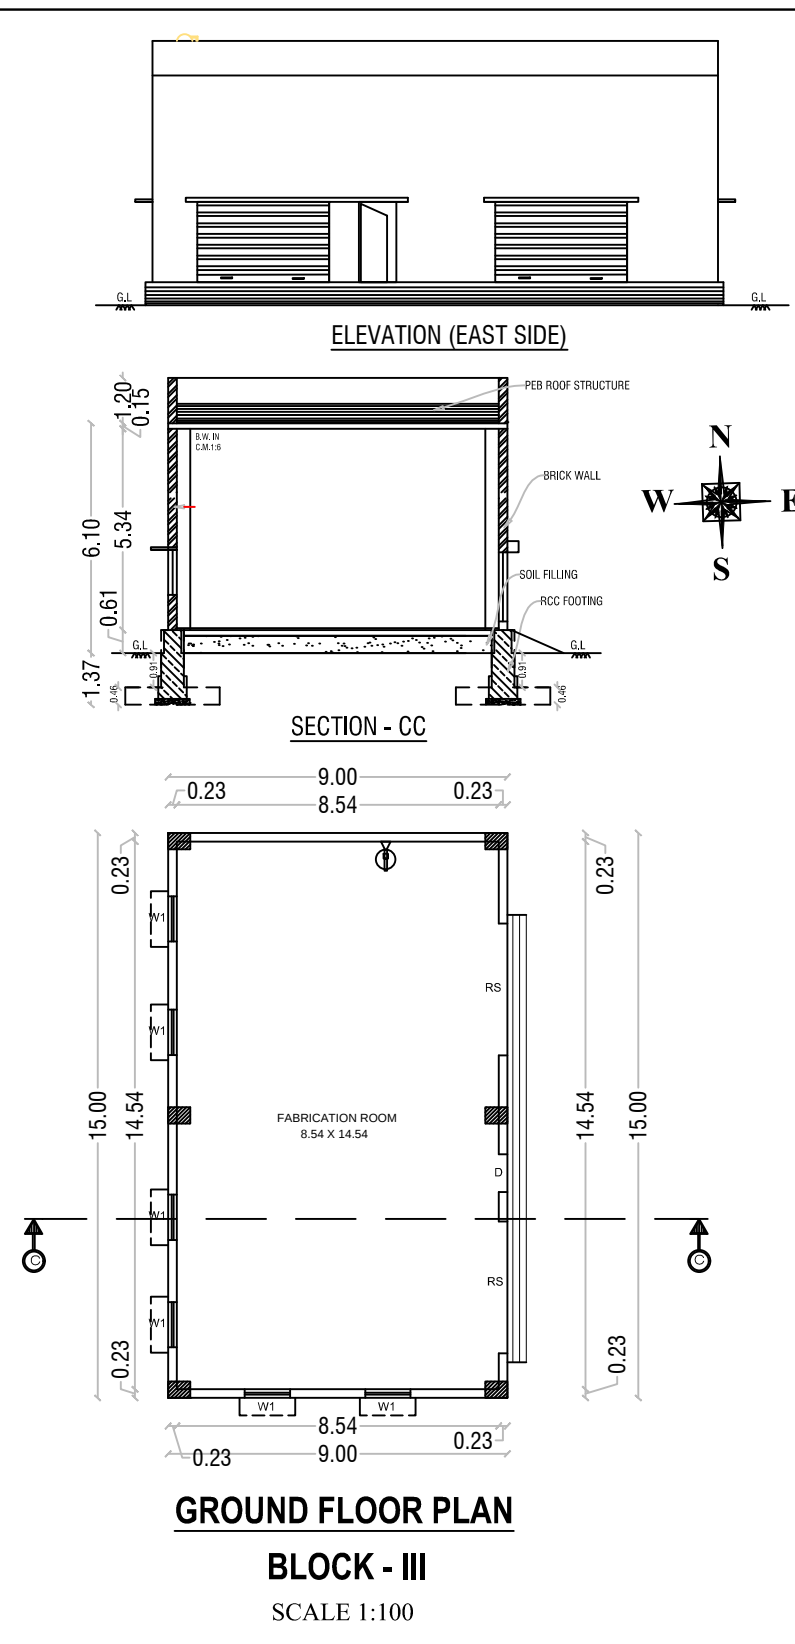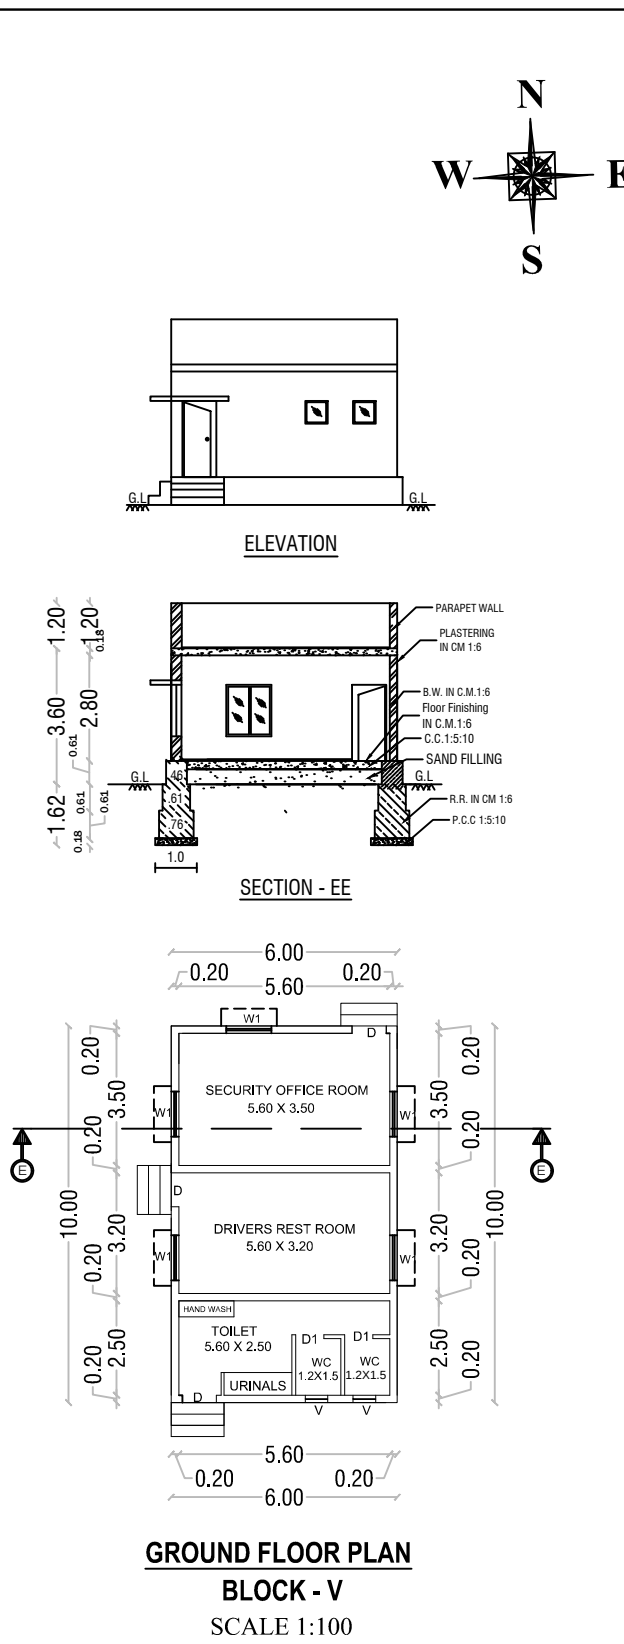

POWER DETAILS				
S.No.	MACHINERIES NAME	H.P.	Nos	TOTAL H.P
1	550 TON INJECTION Moulding MACHINE	341.75	5	1708.75
2	ROBOT (800) (YUDO-MEGA 2000)	13.41	5	67.05
3	MOULD TEMPERATURE CONTROLLER	53.64	10	536.40
4	HRC-32 ZONE	46.93	2	93.86
5	HRC-24 ZONE	34.86	3	104.58
6	CONVEYOR	2.68	5	13.40
7	BAND SAW MACHINE	5.36	2	10.72
8	CRUSHING MACHINE	29.50	2	59.00
9	DRIER	28.02	5	140.10
10	BLOWER	14.75	3	44.25
11	SPARE BLOWER	14.75	1	14.75
12	WORK TABLE (PNEUMATIC)	14.75	1	14.75
13	30/15 TON CRANE	69.73	1	69.73
14	DOCK LEVELLER	12.07	6	72.42
15	LIGHTING LOAD	563.98	1	563.98
16	AIR COMPRESSOR	107.28	2	214.56
17	MINI AIR COMPRESSOR	67.05	1	67.05
18	AIR DRYER	13.41	2	26.82
19	COOLING TOWER (300TR)	113.99	3	341.97
20	PROCESS PUMP	49.50	2	99.00
21	FAN MOTOR	5.00	3	15.00
22	FIRE HYDRANT MAIN PUMP	60.35	1	60.35
23	FIRE HYDRANT JOCKEY PUMP	10.06	1	10.06
24	FIRE PUMP MAIN SPRINKLER	60.35	1	60.35
25	FIRE PUMP JOCKEY SPRINKLER	10.06	1	10.06
26	COLLECTION PUMP	1.00	2	2.00
27	AIR BLOWER	3.00	2	6.00
28	RECIRCULATION PUMP	1.00	2	2.00
29	FILTER PUMP	1.00	2	2.00
30	GARDEN PUMP	2.00	1	2.00
31	RO PLANT	17.50	1	17.50
32	BORE WELL MOTOR & SUMP MOTOR	7.50	1	7.50
33	BOOSTER PUMP	8.85	1	8.85
TOTAL HP		4466.81		
TOTAL NUMBER OF WORKERS		100		

DESCRIPTIONS					
(FE) Fire Extinguisher	-				
(FA) Fire Alarm	-				
Ponds	-				
Rain Water Perculation	-				
SAND BUCKETS	-				
MECHANICAL VENTILATION	-				
JOINERY DETAILS					
D	DOOR	0.91 X 2.10	DD	DOOR	1.00 X 2.10
D1	DOOR	0.76 X 2.10	DD1	DOOR	1.10 X 2.10
RS	ROLLING SHUTTER	3.50 X 3.50	DD2	DOOR	1.20 X 2.10
RS1	ROLLING SHUTTER	2.50 X 2.10	DD3	DOOR	1.80 X 2.10
O	OPEN	1.20 X 2.10	W	WINDOW	1.83 X 1.37
V	VENTILATOR	0.91 X 0.61	W1	WINDOW	1.22 X 1.23

AREA DETAILS	
TOTAL AREA OF THE SITE	IN SQMT
PLR/FMB AREA	30230.00
DOCUMENT AREA	30230.00
SUPER IMPOSED PLOT AREA	30227.45

INDUSTRIAL BULDING			
PARTICULARS	FSI (sqmt)	NON FSI(sqmt)	TOTAL (sqmt)
AREA OF THE PRO. BLDG - GF (GI-SHEET ROOF BLOCK - II)	1380.75	-	1380.75
AREA OF THE PRO. BLDG - GF (RCC ROOF BLOCK - II)	344.25	-	344.25
AREA OF THE PRO. BLDG -GF (GI-SHEET ROOF BLOCK - III)	135.00	-	135.00
AREA OF THE PRO. BLDG -GF (GI-SHEET ROOF BLOCK - IV)	130.00	-	130.00
AREA OF THE PRO. BLDG -GF (RCC-ROOF BLOCK - V)	60.00	-	60.00
AREA OF THE PRO. BLDG -GF (GI-SHEET ROOF BLOCK - VI)	71.68	-	71.68
TOTAL AREA	2121.68	-	2121.68

PLOT COVERAGE - (P.C.) %	7.00
FLOOR SPACE INDEX - (FSI)	0.070

APPLICANT	
M/s SEYON E-HWA SUMMIT MOBILITY KRISHNAGIRI PVT.LTD	
Mr.KIM SUNGJU S/o Mr.KIM YUNHWAN	
REG.STRUCTURAL ENGINEER	REGISTER ENGINEER
Er N. PRAVEEN KUMAR, ME., CREATIVE CONSTRUCTION Structural Engineer / Chartered Engineer Govt.HNTDA Reg.Structural Engineer-II(14/2020) MOBILE:7502330468, 6380345365 MAIL:creativeconstructionhosur@gmail.com	Er N. PRAVEEN KUMAR, ME., CREATIVE CONSTRUCTION Structural Engineer / Chartered Engineer Govt.HNTDA Reg.Construction Engineer -(25/2020) MOBILE:7502330468, 6380345365 MAIL:creativeconstructionhosur@gmail.com

SHEET No.3/3



REG.STRUCTURAL ENGINEER <i>m. Praveen Kumar</i> Er. N. PRAVEEN KUMAR, ME., CREATIVE CONSTRUCTION Structural Engineer / Chartered Engineer Govt.HNTDA Reg.Structural Engineer (14/4/2023) MOBILE:7502330468, 6380345365 MAIL:creativeconstructionhsur@gmail.com	REGISTER ENGINEER <i>m. Praveen Kumar</i> Er. N. PRAVEEN KUMAR, ME., CREATIVE CONSTRUCTION Structural Engineer / Chartered Engineer Govt.HNTDA Reg.Engineer-III(11/2020) Govt.HNTDA Reg.Construction Engineer-(25/2020) MOBILE:7502330468, 6380345365 MAIL:creativeconstructionhsur@gmail.com
---	--