
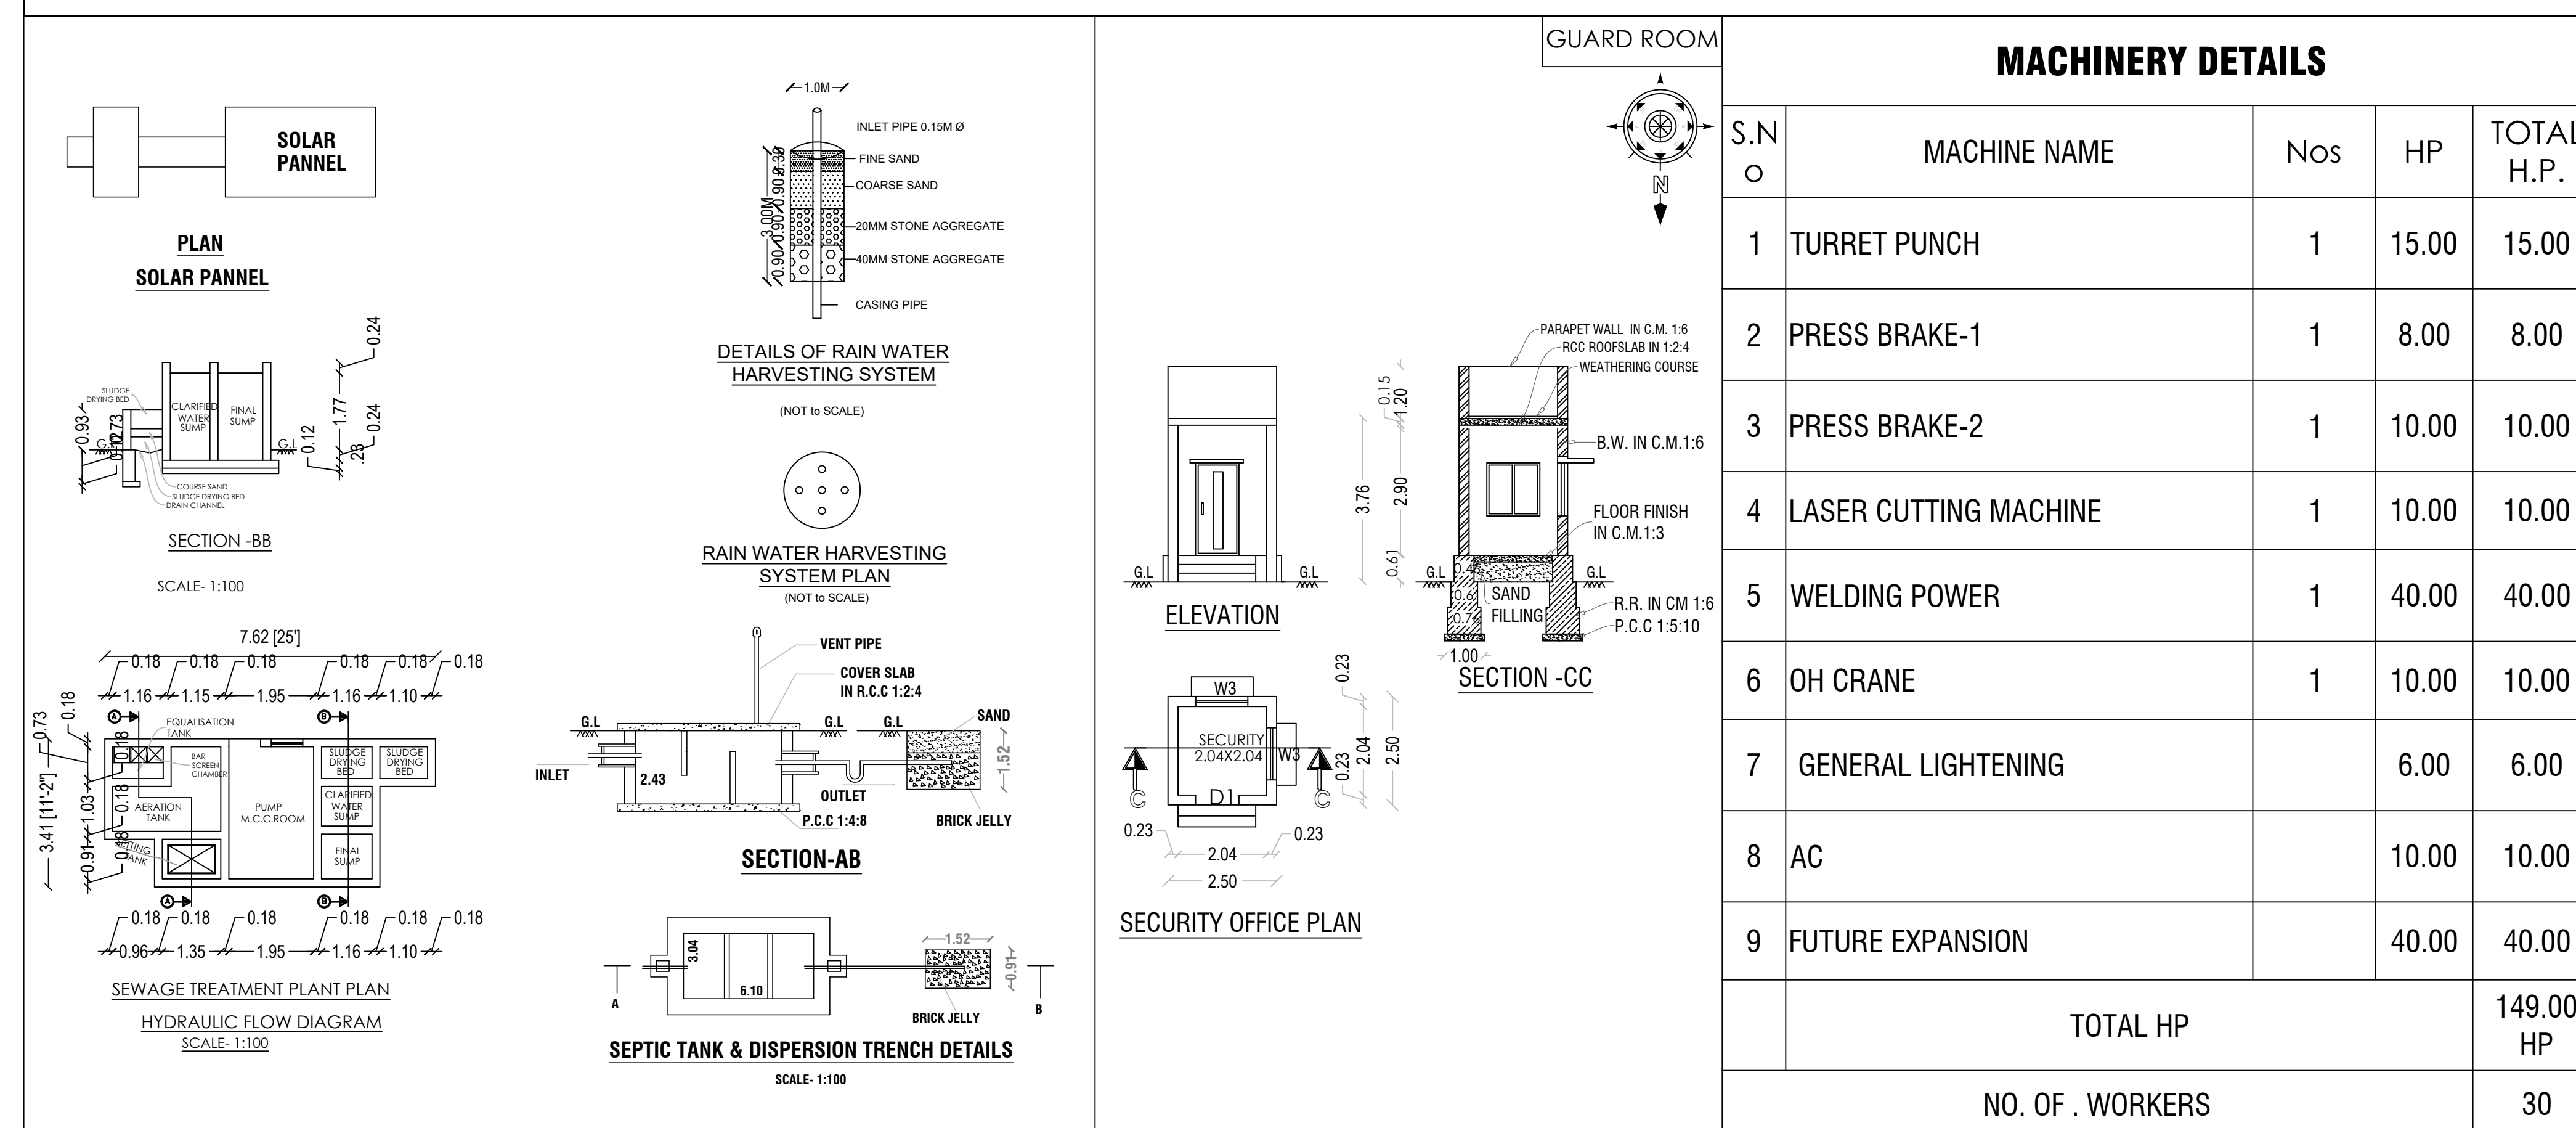
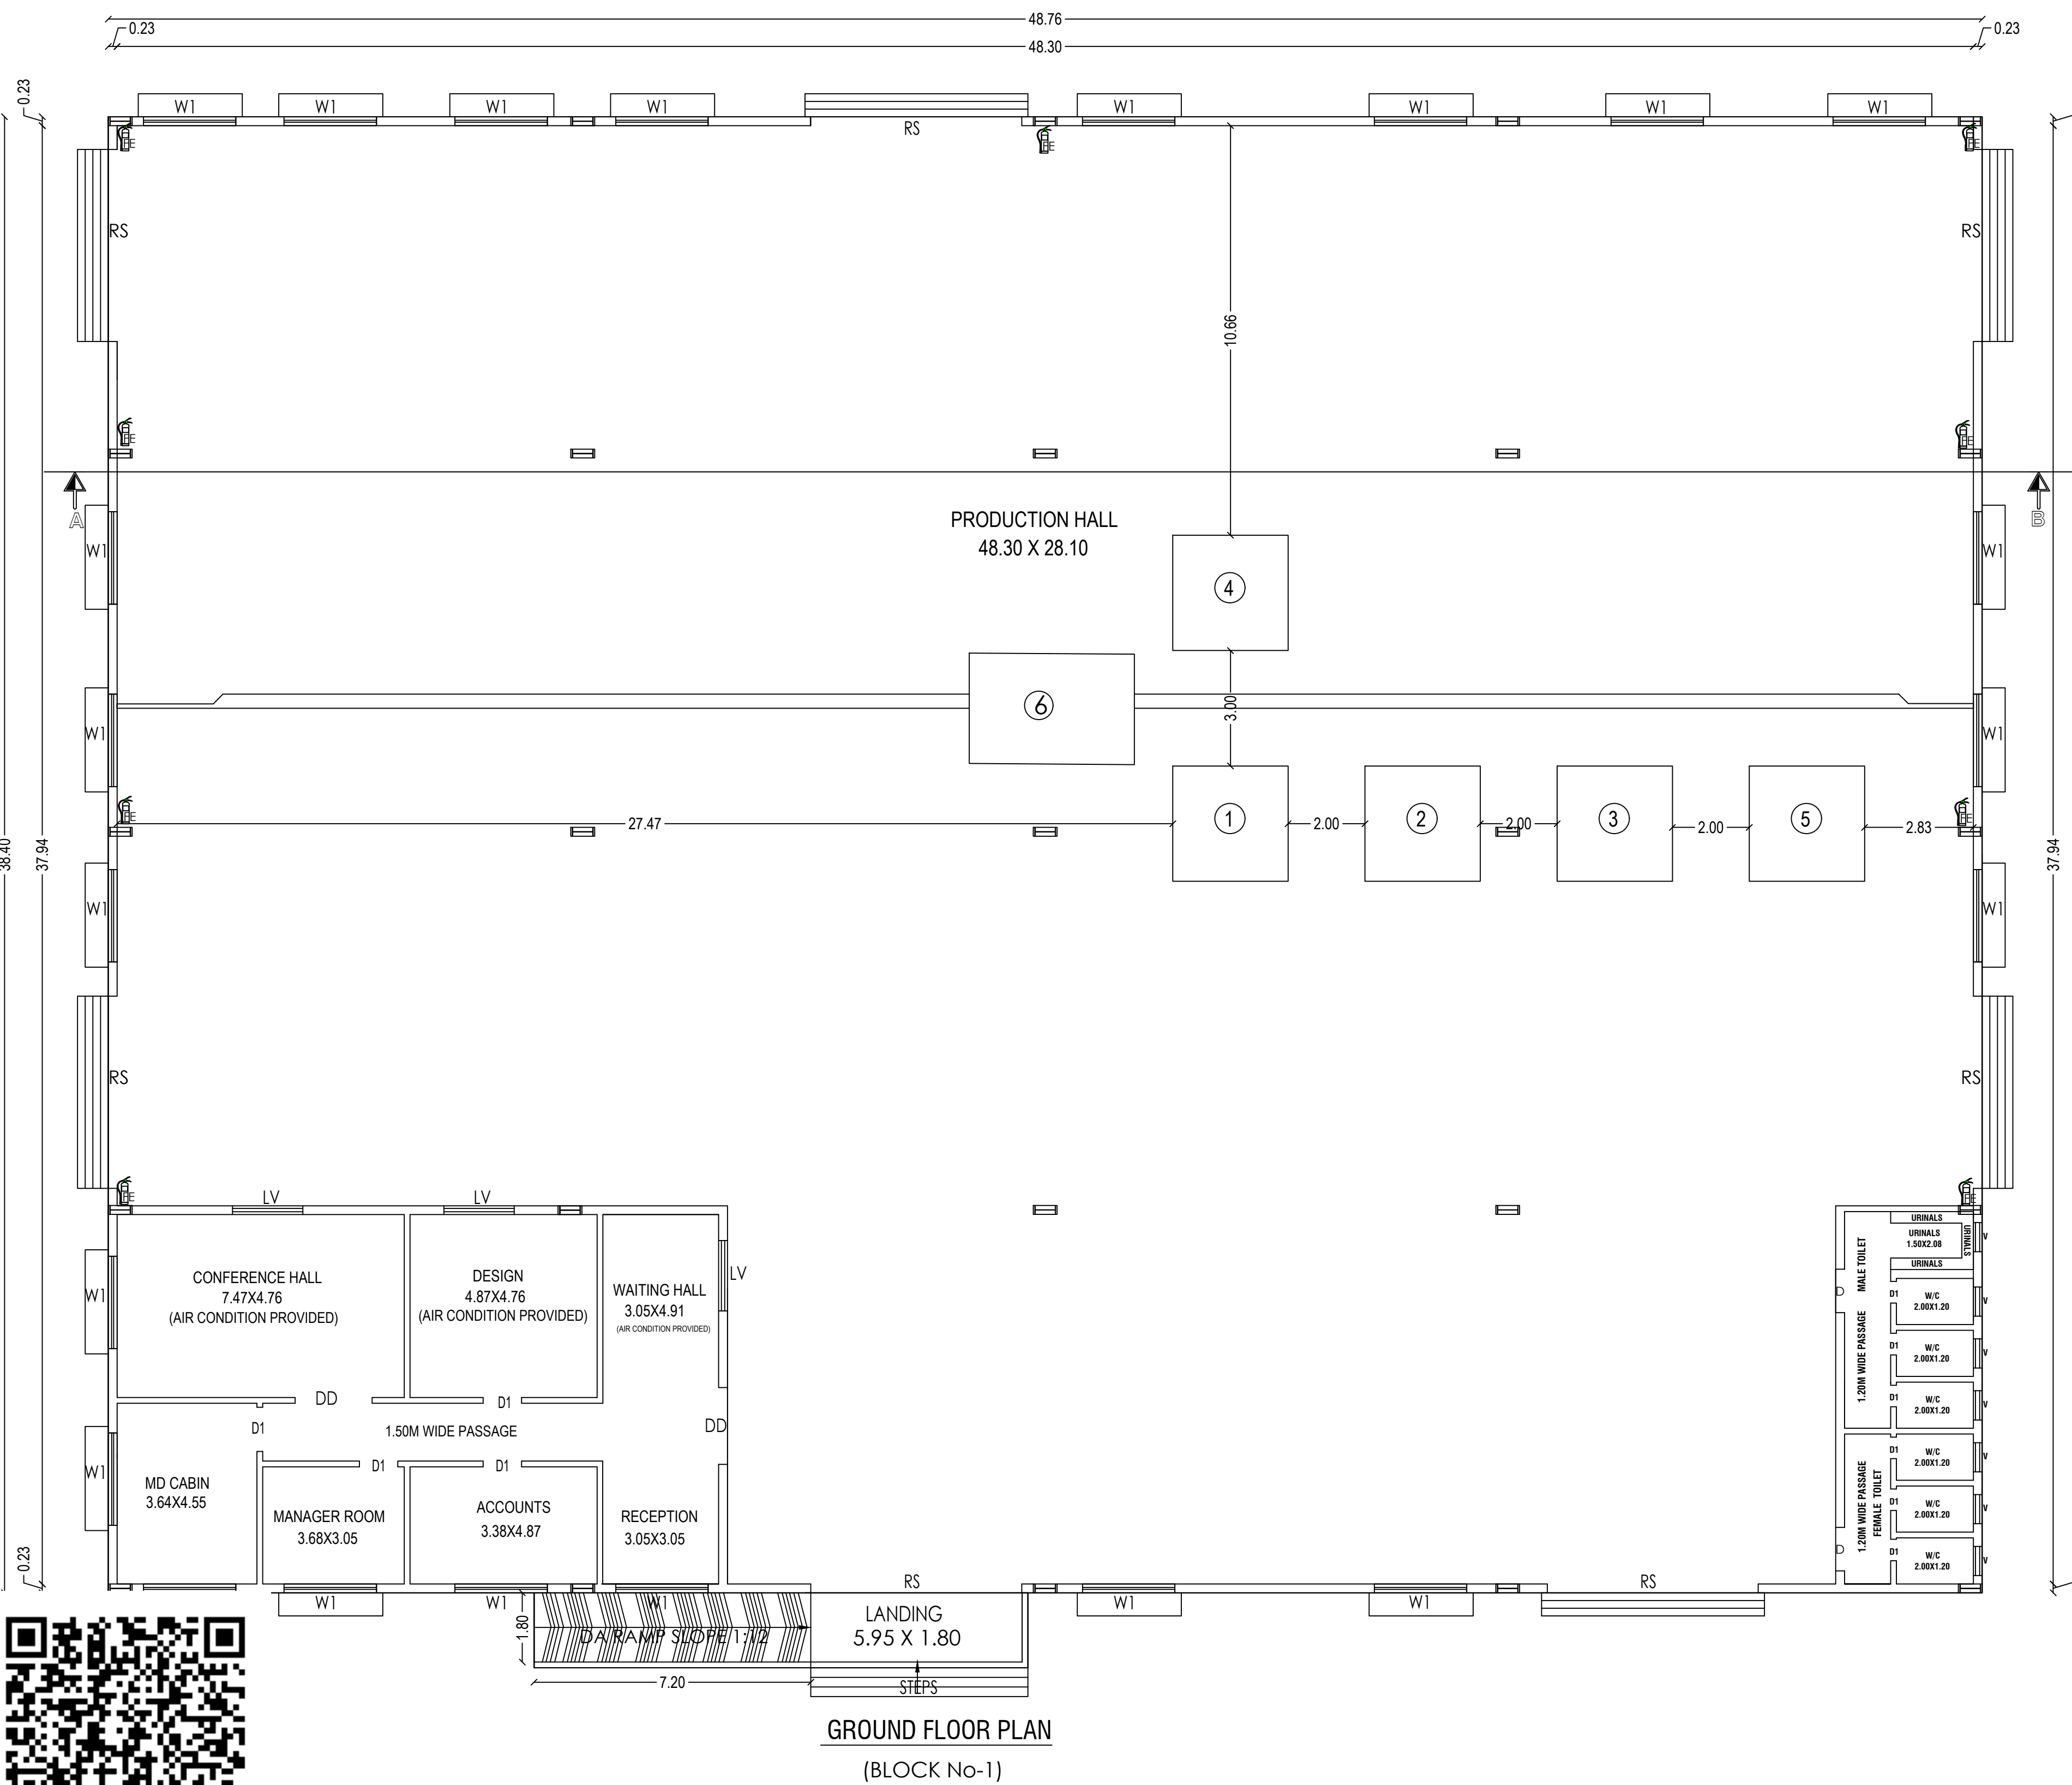


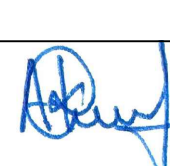

	DRAWING TITLE	ALL DIMENSIONS ARE IN METER		
	MANUFACTURING SHED BUILDING, SECURITY OFFICE, STP SITE PLAN	SCALE- 1:100		
PLAN SHOWING THE PROPOSED CONSTRUCTION OF INDUSTRIAL BUILDING FOR M/s."POWER DRIVE METALS AND CONTROL SYSTEMS" (GREEN CATORGORY-ELECTRONIC AND ELECTRICAL GOODS) IN PLOT NO - 18 , S.F.No: 50/1A(Pt), 50/2(Pt), 50/3(Pt), 50/4A(Pt), 50/4B(Pt), 50/6A(Pt), 50/6C, 50/7A(Pt), 50/8B(Pt), 52/1B(Pt), 52/6(Pt) AT SIPCOT INDUSTRIAL PARK - BARGUR(SEZ) , OLAI PATTI VILLAGE AND SALAMARATHUPATTI PANCHAYAT, MATHUR PANCHAYAT UNION, UTHANGARAI TALUK, KRISHNAGIRI DISTRICT.				
TOTAL AREA OF SITE - 3.62 (ACRES)				
BUILDING AREA DETAILS				
BLOCK No.	PARTICULARS	FSI (SQ.M.)	NON-FSI (SQ.M.)	TOTAL BUILT-UP AREA(SQ.M.)
1	MANUFACTURING SHED	1897.44	-	1897.44
	GUARD ROOM	-	6.25	6.25
	TOTAL BUILTUP AREA	1897.44	6.25	1903.69
PLOT COVERAGE (PC) = (1903.69/14655.87) X100 = 12.99 %				
FLOOR SPACE INDEX (FSI) = (1897.44 /14655.87) = 0.13 < 1.50				
REFERENCE				
REF. ID	DESCRIPTIONS	SIZES		
RS	ROLLING SHUTTER	5.00X 3.05		
DD	DOUBLE DOOR	1.52X 2.10		
D	DOOR	1.22 X 2.10		
D1	DOOR	1.07 X 2.10		
D2	DOOR	0.76 X 2.10		
W1	WINDOW	2.40 X 1.20		
V	VENTILATOR	0.90 X 0.60		
LV	LOUVERS VENT	1.83 X 0.60		
COLOR INDEX				
SITE BOUNDARY				
DRIVEWAY				
EXISTING ROAD				
PROPOSED BUILDING				
PARKING DETAILS				
S.No	PARTICULARS	REQUIRED IN NOS.	PROVIDED IN NOS.	
1	TWO WHEELER PARKING	28	40	
2	CYCLE PARKING	28	40	
3	LORRY PARKING	03	04	
4	CAR PARKING	00	03	
APPLICANT				
 M/s."POWER DRIVE METAL AND CONTROL SYSTEMS"				
REGISTERED ENGINEER				
 Er. S.SAKTHIVEL, B.E., TN.Govt. Registered Professional of DTCP, Registered Engineer Grade-II-01/2024, Registered Construction Engineer-01/2024, Registered Structural Engineer Grade-II-02/2022, R.E.(G-3) DMC. No-037/LS/2022/00006, CIVIL INFO No-24/3, Second Floor, Opp:Nagaraj Hospital, Chathiram Street, Dharmapuri-636 701, Cell: 7550315100, 8098094769, Email:civilinfo.dpi@gmail.com.				
REGISTERED STRUCTURAL ENGINEER				
 Er. A.K. MANMATHAN, M.E., AMIE, C.Eng(I), Chartered Engineer (India) Regd. Engineer (RE), Regd. Structural Engineer (RSE) AKM INFRASTRUCTURE & DESIGN SOLUTIONS 59144-C, Chakkiyampatti, Dharmapuri-636 705 Email:info.akminfra@gmail.com Ph: 94342-292663, Mobile: +91 96587 30832				