


SITE PLAN SHOWING THE PROPOSED NURSING COLLEGE AT SURVEY No : 255 / 2, 3A, 4 MANJAPETTAI VILLAGE & PANCHAYATH , GANDARVAKOTTAI TALUK, PUDUKKOTTAI DISTRICT.

NAME OF THE OWNER : Mr. K. MARUTHUPANDIAN (MANAGING TRUSTEE), ATHIVETTI KARUMUTHUVALLI EDUCATIONAL AND CHARITABLE TRUST

SHEET NO : 1 / 3

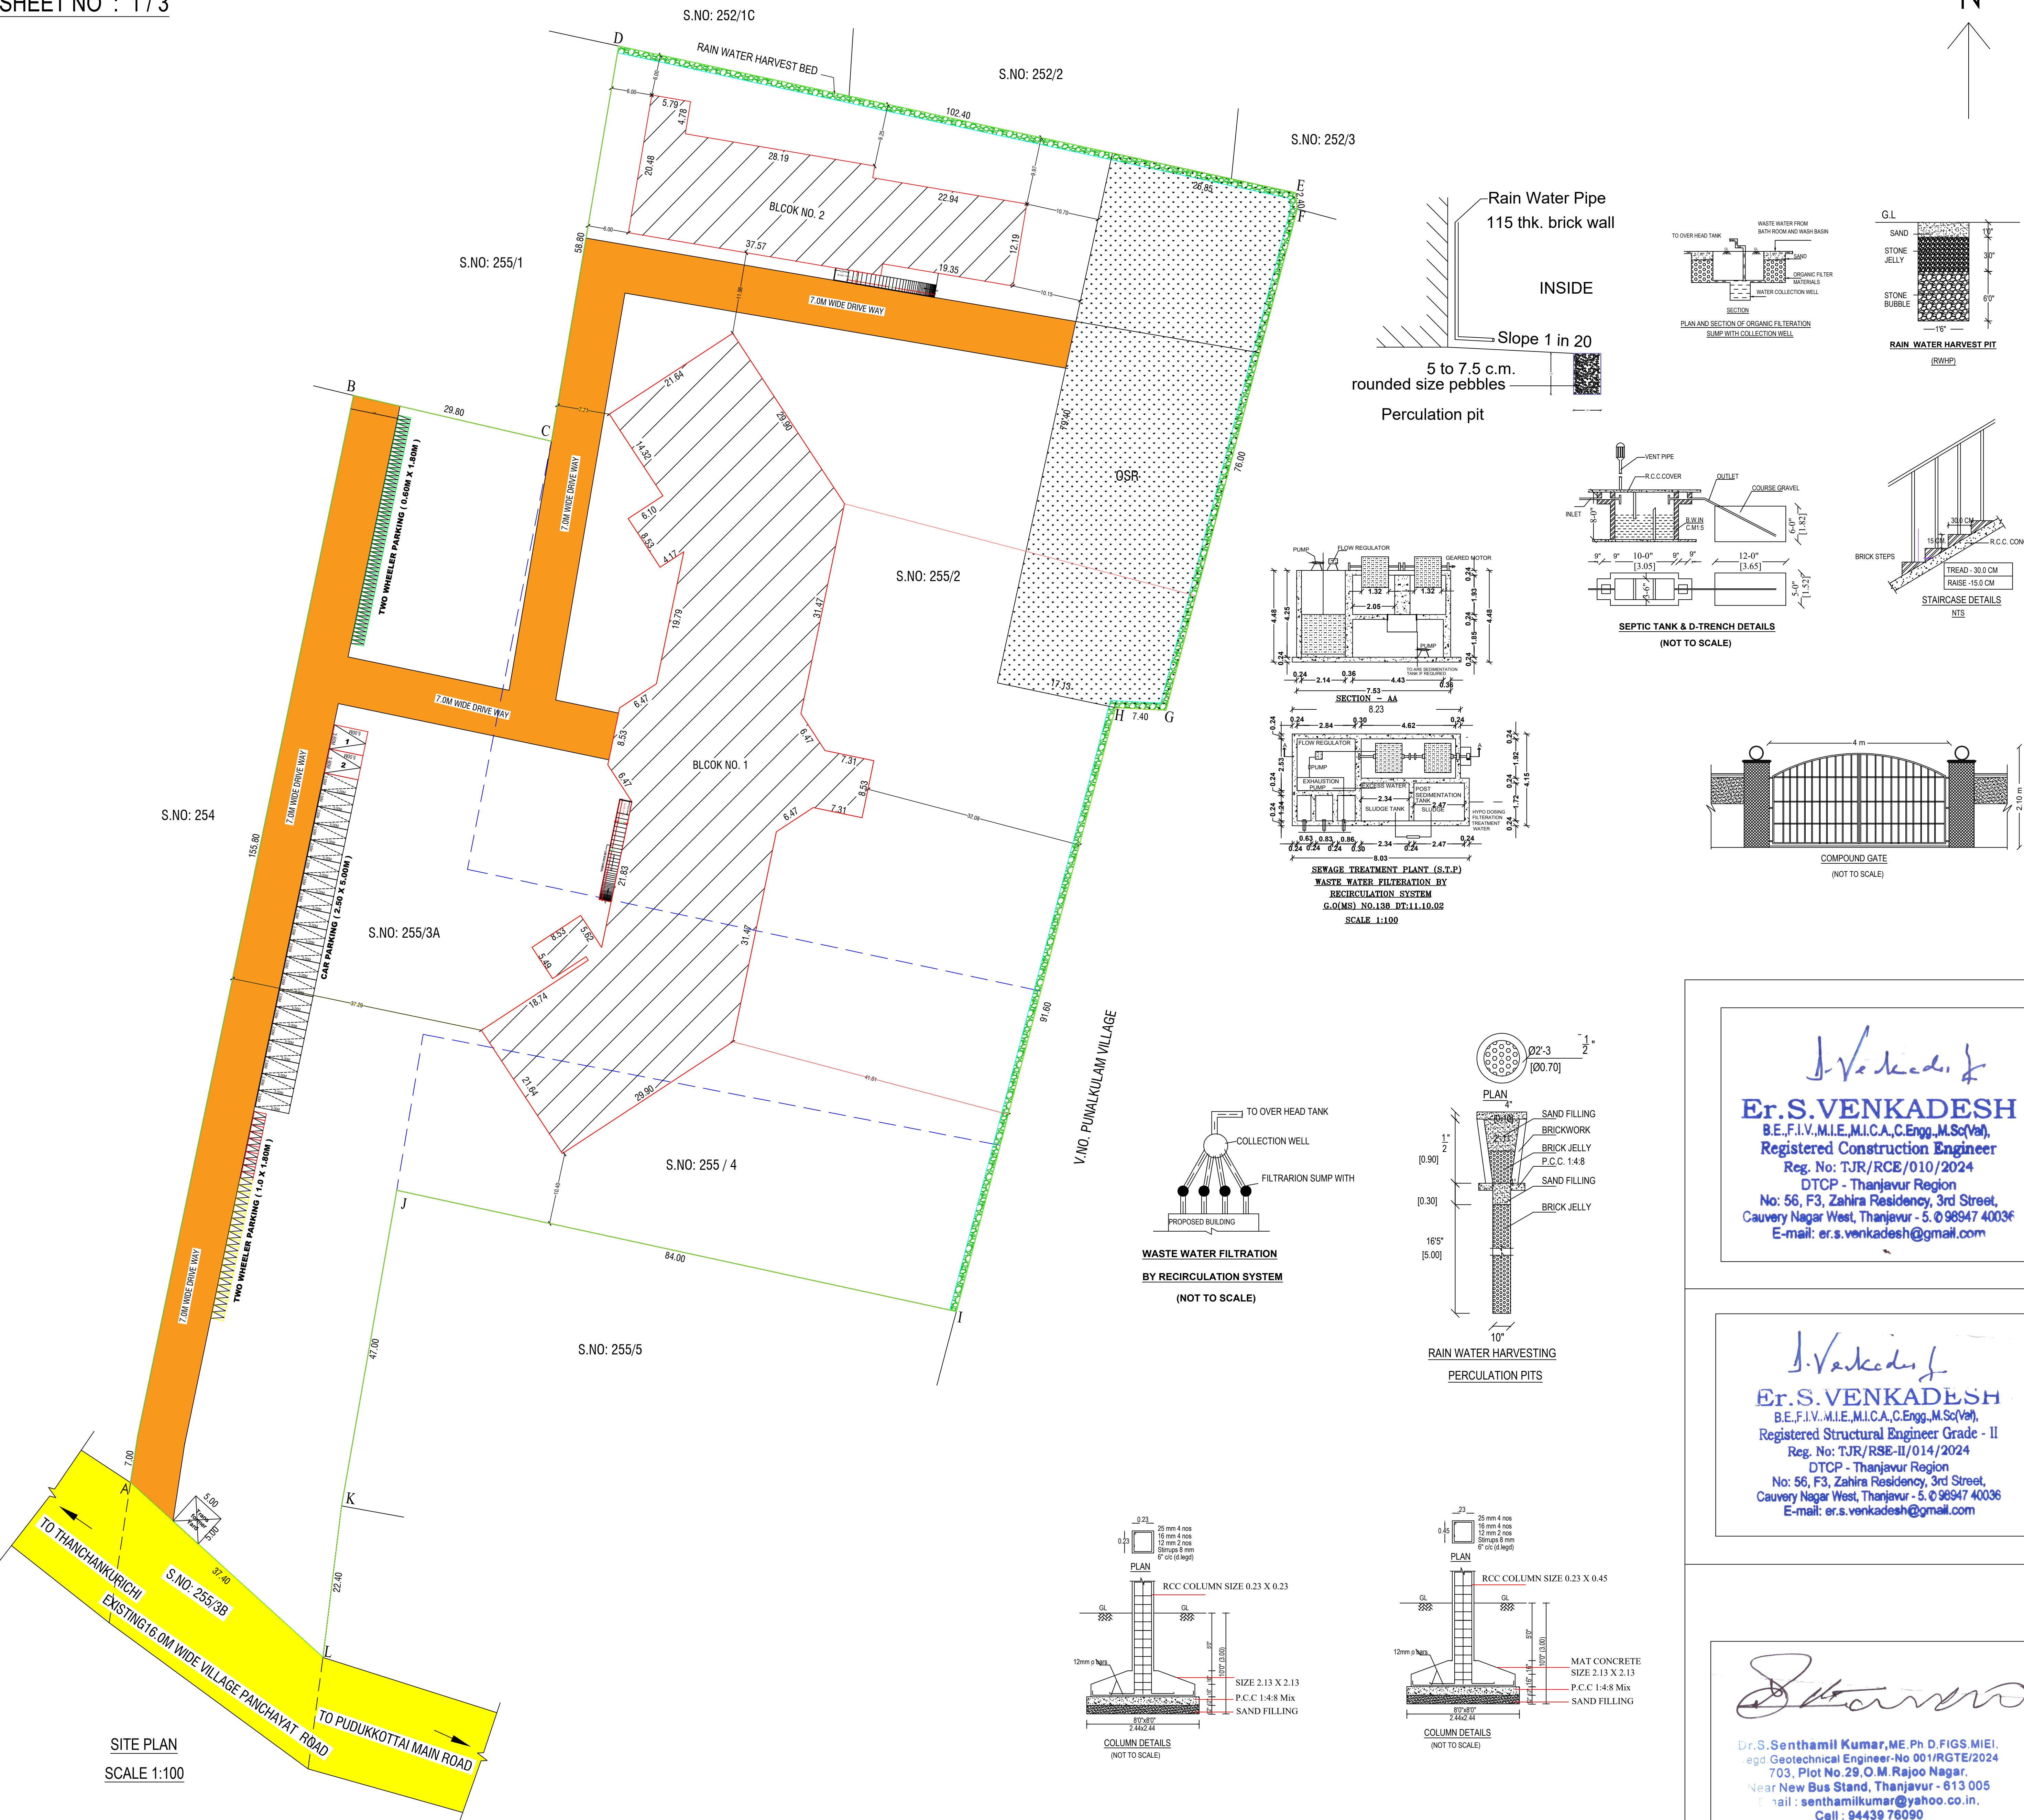

DISTRICT TOWN AND COUNTRY PLANNING OFFICE
PUDUKKOTTAI DISTRICT

ONLINE APPLICATION NO : SWP / BPA / 372899 / 2024

AREA DETAILS	SQ.MT.		
AREA OF SITE	20450.00		
	FSI	NON - FSI	TOTAL AREA
BLOCK - 1			
AREA OF GROUND FLOOR	2888.22		2888.22
AREA OF HEAD ROOM		288.43	288.43
AREA OF RAMP		27.45	27.45
BLOCK - 2			
AREA OF GROUND FLOOR	841.20		841.20
AREA OF HEAD ROOM		77.12	77.12
AREA OF RAMP		27.45	27.45
TOTAL AREA	3729.42	420.45	4149.87

FLOOR SPACE INDEX (FSI) = $\frac{3729.42}{20450.00} = 0.18$

PARKING

NUMBER OF CAR PARKING (2.50 X 5.00) = 20 NOS.

PHYSICALLY HANDICAPED PARKING (3.60 X 5.00) = 2 NOS.

NUMBER OF TWO WHEELER PARKING (1.00 X 1.80) = 21 NOS.

NUMBER OF CYCLE PARKING (0.60 X 1.80) = 57 NOS.

OPEN SPACE RESERVATION (OSR) = 2111.79 SQ.M

COLOUR INDEX

PROPOSED SITE	
PROPOSED BUILDING	
PROPOSED DRIVE WAY	
EXISTING ROAD	
RAIN WATER HARVEST BED	
OSR	

APPLICANT


Mr. K. Maruthupandian
MANAGING TRUSTEE,
ATHIVETTI KARUMUTHUVALLI
EDUCATIONAL AND CHARITABLE TRUST
THANJAVUR.

ENGINEER


Er. S. VENKADESH
B.E., F.I.V., M.I.E., M.I.C.A., C.Engg., M.Sc(Va),
Registered Engineer Grade - I
Reg. No: T.JR/RSE-1/032/2024
DTCP - Thanjavur Region
No: 56, F3, Zahira Residency, 3rd Street,
Cauvery Nagar West, Thanjavur - 5. 098947 40036
E-mail: er.s.venkadesh@gmail.com

SWP / DTCP / PD / BPA No - 44 / 2024


JOINT DIRECTOR / DEPUTY DIRECTOR (i/c)
DISTRICT TOWN AND COUNTRY PLANNING OFFICE
PUDUKKOTTAI DISTRICT

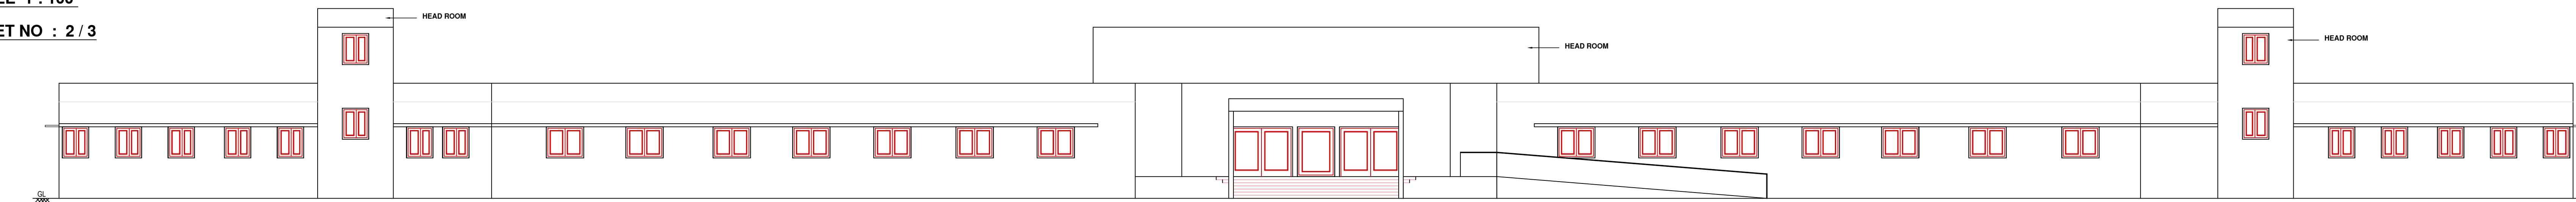


ELEVATION

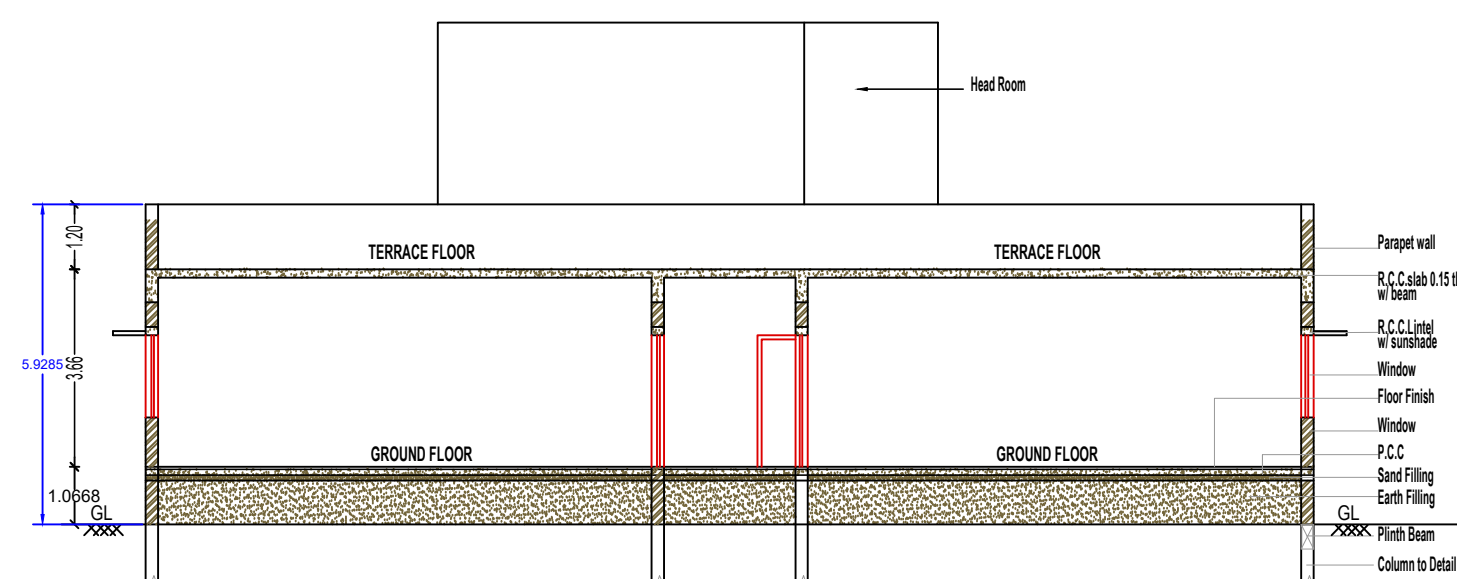

SECTION ON XX

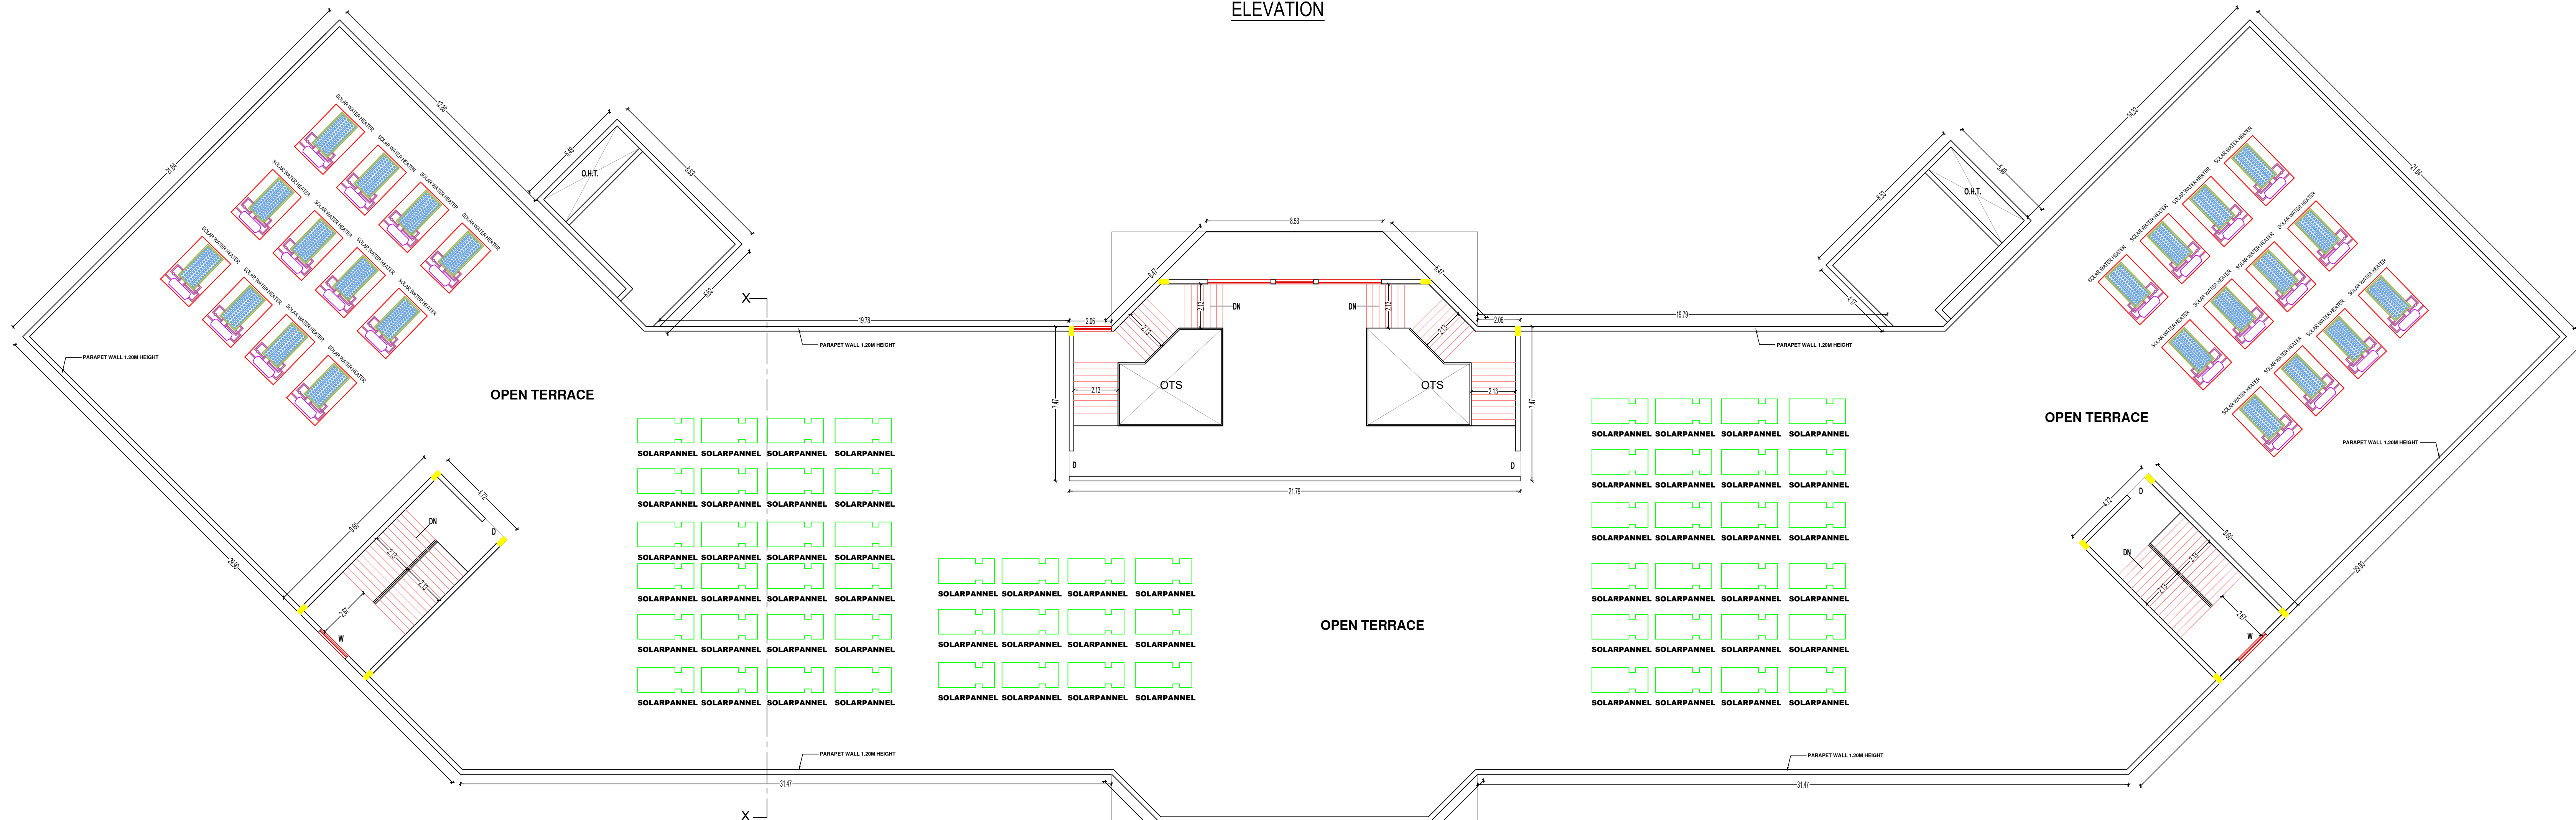

TERRACE FLOOR PLAN

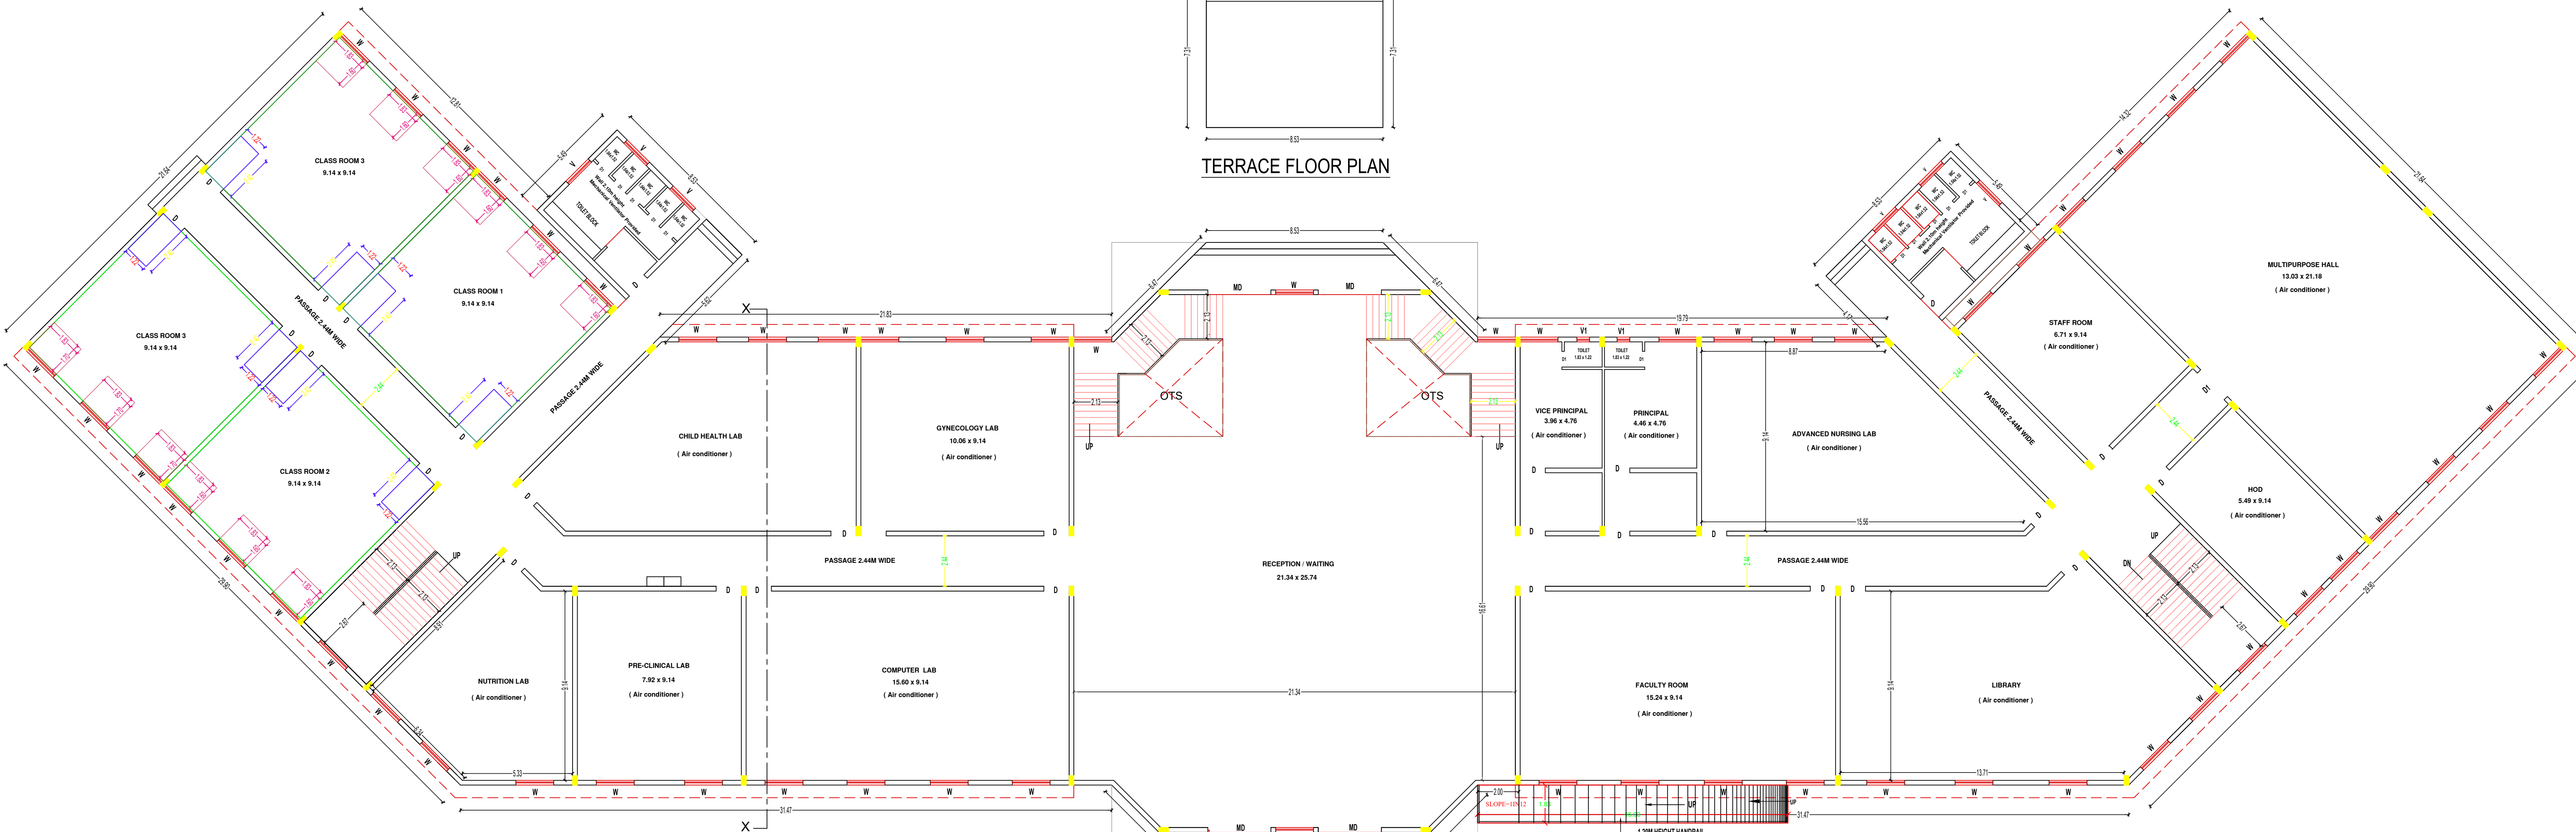

GROUND FLOOR PLAN

SCHEDULE OF JOINERIES

MD	- MAIN DOOR	- 3.05 X 2.40M
D	- DOOR	- 1.20 X 2.40M
D1	- DOOR	- 0.76 X 2.10M
W	- WINDOW	- 2.44 X 1.37M
W1	- WINDOW	- 1.83 X 1.60M
V	- VENTILATOR	- 1.52 X 0.61M

AREA DETAILS

SQ.MT.

BLOCK - 1

AREA OF GROUND FLOOR

FSI

NON FSI

2888.22

AREA OF HEAD ROOM

288.43

AREA OF RAMP

27.45

TOTAL AREA

2888.22

315.88

NOTES:-

1. ALL DIMENSIONS ARE IN METRE
2. RAINWATER COLLECTION WELLS WILL BE PROVIDED
3. FIRE FIGHTING ARRANGEMENTS WILL BE PROVIDED
4. EMERGENCY ALARMS WILL BE PROVIDED
5. DRINKING WATER WILL BE PROVIDED
6. GROUND WATER SUMPS WILL BE PROVIDED
7. FILTERED RAIN WATER SUMPS WILL BE PROVIDED
8. EXHAUST FAN PROVISION IS MADE AT TOILET & WASH
9. SOLAR WATER HEATING SYSTEM PROVIDED.
10. RAINWATER HARVESTING FACILITIES PROVIDED.
11. WASTE WATER RECYCLING TRENCH AND TANK PROVIDED.
12. SEWAGE TREATMENT PLANT PROVIDED.
13. SEPTIC TANK PROVIDED.
14. WATER FACILITIES PROVIDED.
15. TRANSFORMER YARD PROVIDED.
16. FA - FIRE ALARM PROVIDED
17. F E - FIRE SAFETY MEASURES PROVIDED.
18. SB - SAND BUCKET PROVIDED
19. FE - FIRE EXTINGUISHER PROVIDED



Er. S. VENKADESH
B.E./F.V./M.E./M.C.A./C.Eng./M.Sc/M.M.
Registered Construction Engineer
Reg. No: T.J.R/RCE/010/2024
DTCP - Thanjavur Region
No. 56, F3, Zahira Residency, 3rd Street,
Cauvery Nagar West, Thanjavur - 5.0 95947 40036
E-mail: sr.s.venkadesh@gmail.com

APPLICANT

MANJAPETTAI
MANAGING TRUSTEE,
ATHIVETTI KARUMUTHUVALI
EDUCATIONAL AND CHARITABLE TRUS
THANJAVUR

ENGINEER

Er. S. VENKADESH
B.E./F.V./M.E./M.C.A./C.Eng./M.Sc/M.M.
Registered Engineer Grade - II
Reg. No: T.J.R/RSE-II/014/2024
DTCP - Thanjavur Region
No. 56, F3, Zahira Residency, 3rd Street,
Cauvery Nagar West, Thanjavur - 5.0 95947 40036
E-mail: sr.s.venkadesh@gmail.com

Er. S. VENKADESH
B.E./F.V./M.E./M.C.A./C.Eng./M.Sc/M.M.
Registered Engineer Grade - I
Reg. No: T.J.R/RSE-I/032/2024
DTCP - Thanjavur Region
No. 56, F3, Zahira Residency, 3rd Street,
Cauvery Nagar West, Thanjavur - 5.0 95947 40036
E-mail: sr.s.venkadesh@gmail.com

S. Senthil Kumar
S. Senthil Kumar ME Ph.D P.05 MIE
Civil Construction Engineer No. 20 0401652024
733, Plot No. 29 D M Rajoo Nagar
New Bus Stand, Thanjavur - 613 005
senthilkumar@yahoo.co.in
Call: 94436 70700



SWP / DTCP / PD / BPA No - 44 / 2024

JOINT DIRECTOR / DEPUTY DIRECTOR (i/c)
DISTRICT TOWN AND COUNTRY PLANNING OFFICE
PUDUKKOTTAI DISTRICT


PLAN SHOWING THE PROPOSED NURSING COLLEGE AT SURVEY No : 255 / 2, 3A, 4 MANJAPETTAI VILLAGE & PANCHAYAT, GANDHARVAKOTTAI TALUK, PUDUKKOTTAI DISTRICT

SCALE 1 : 100

SHEET NO : 3 / 3

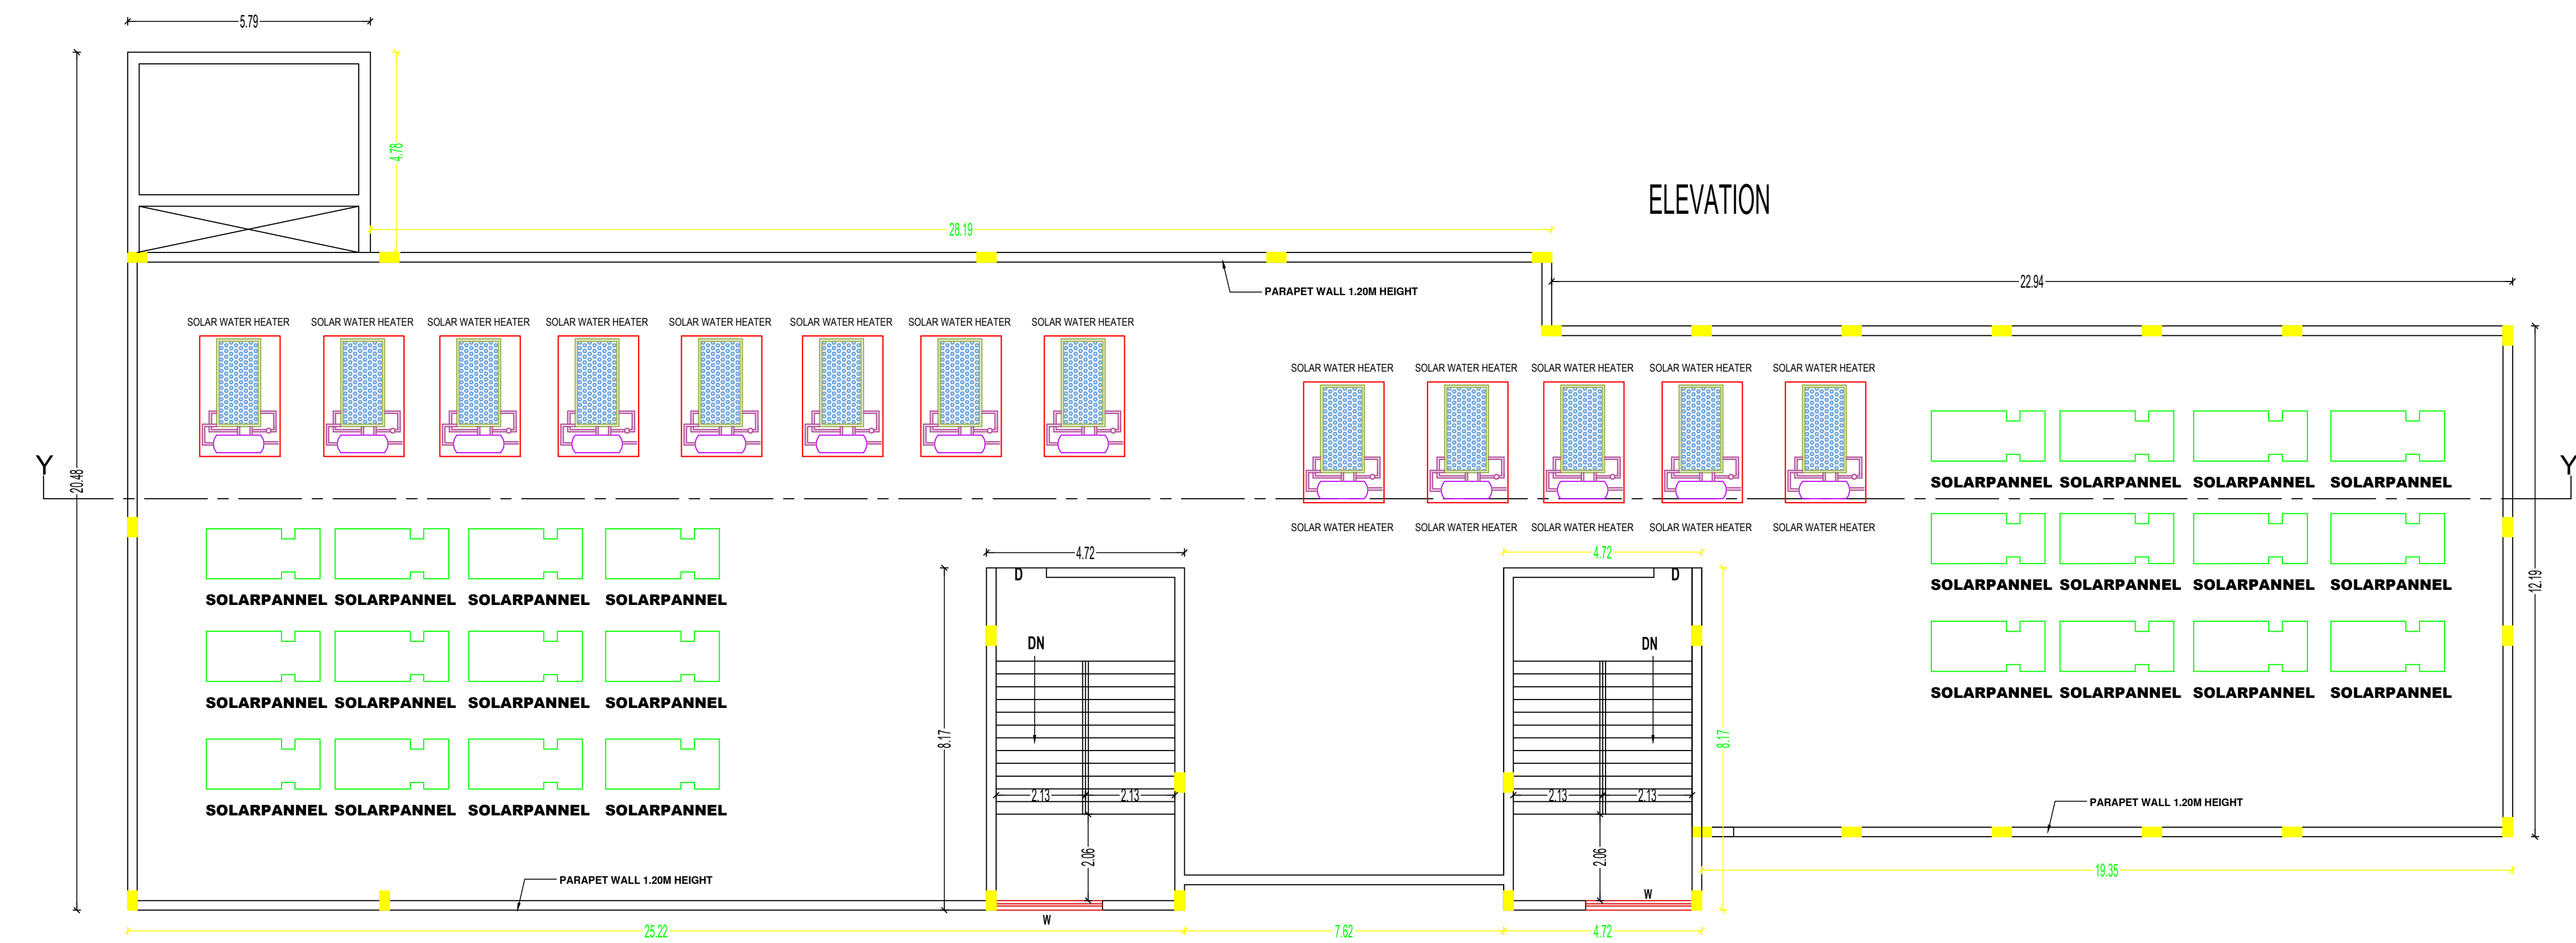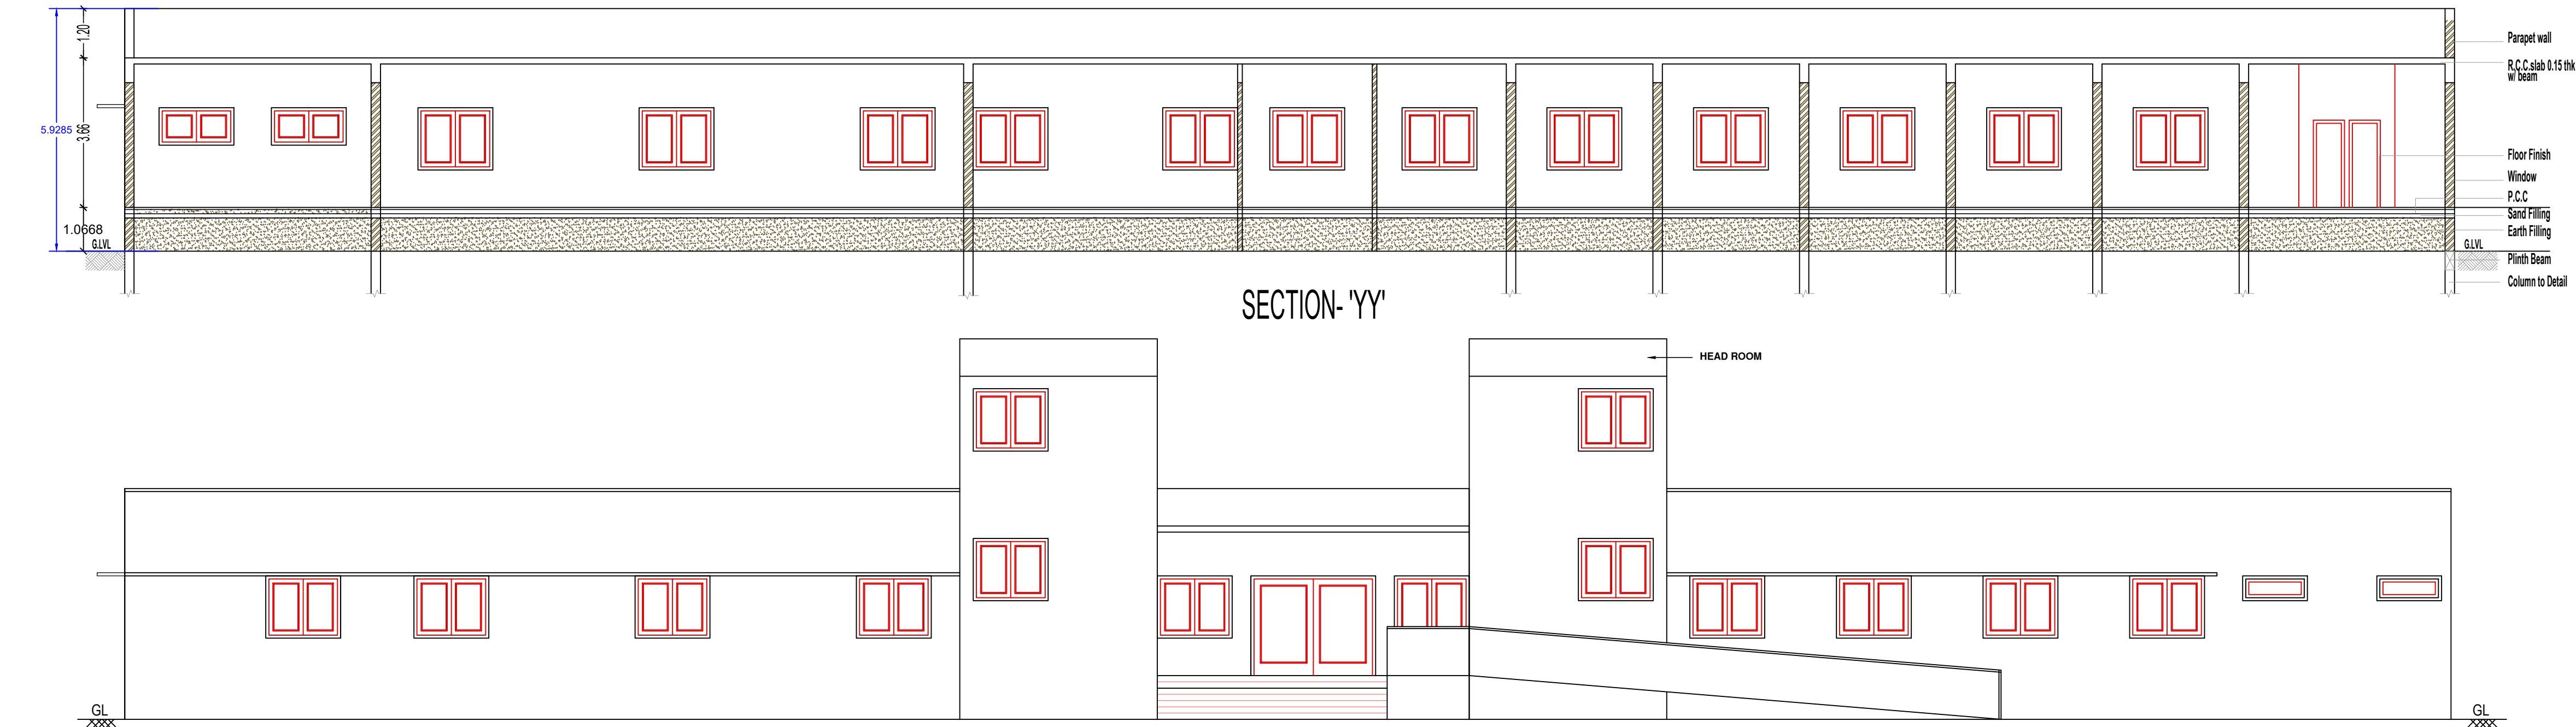

TERRACE FLOOR PLAN

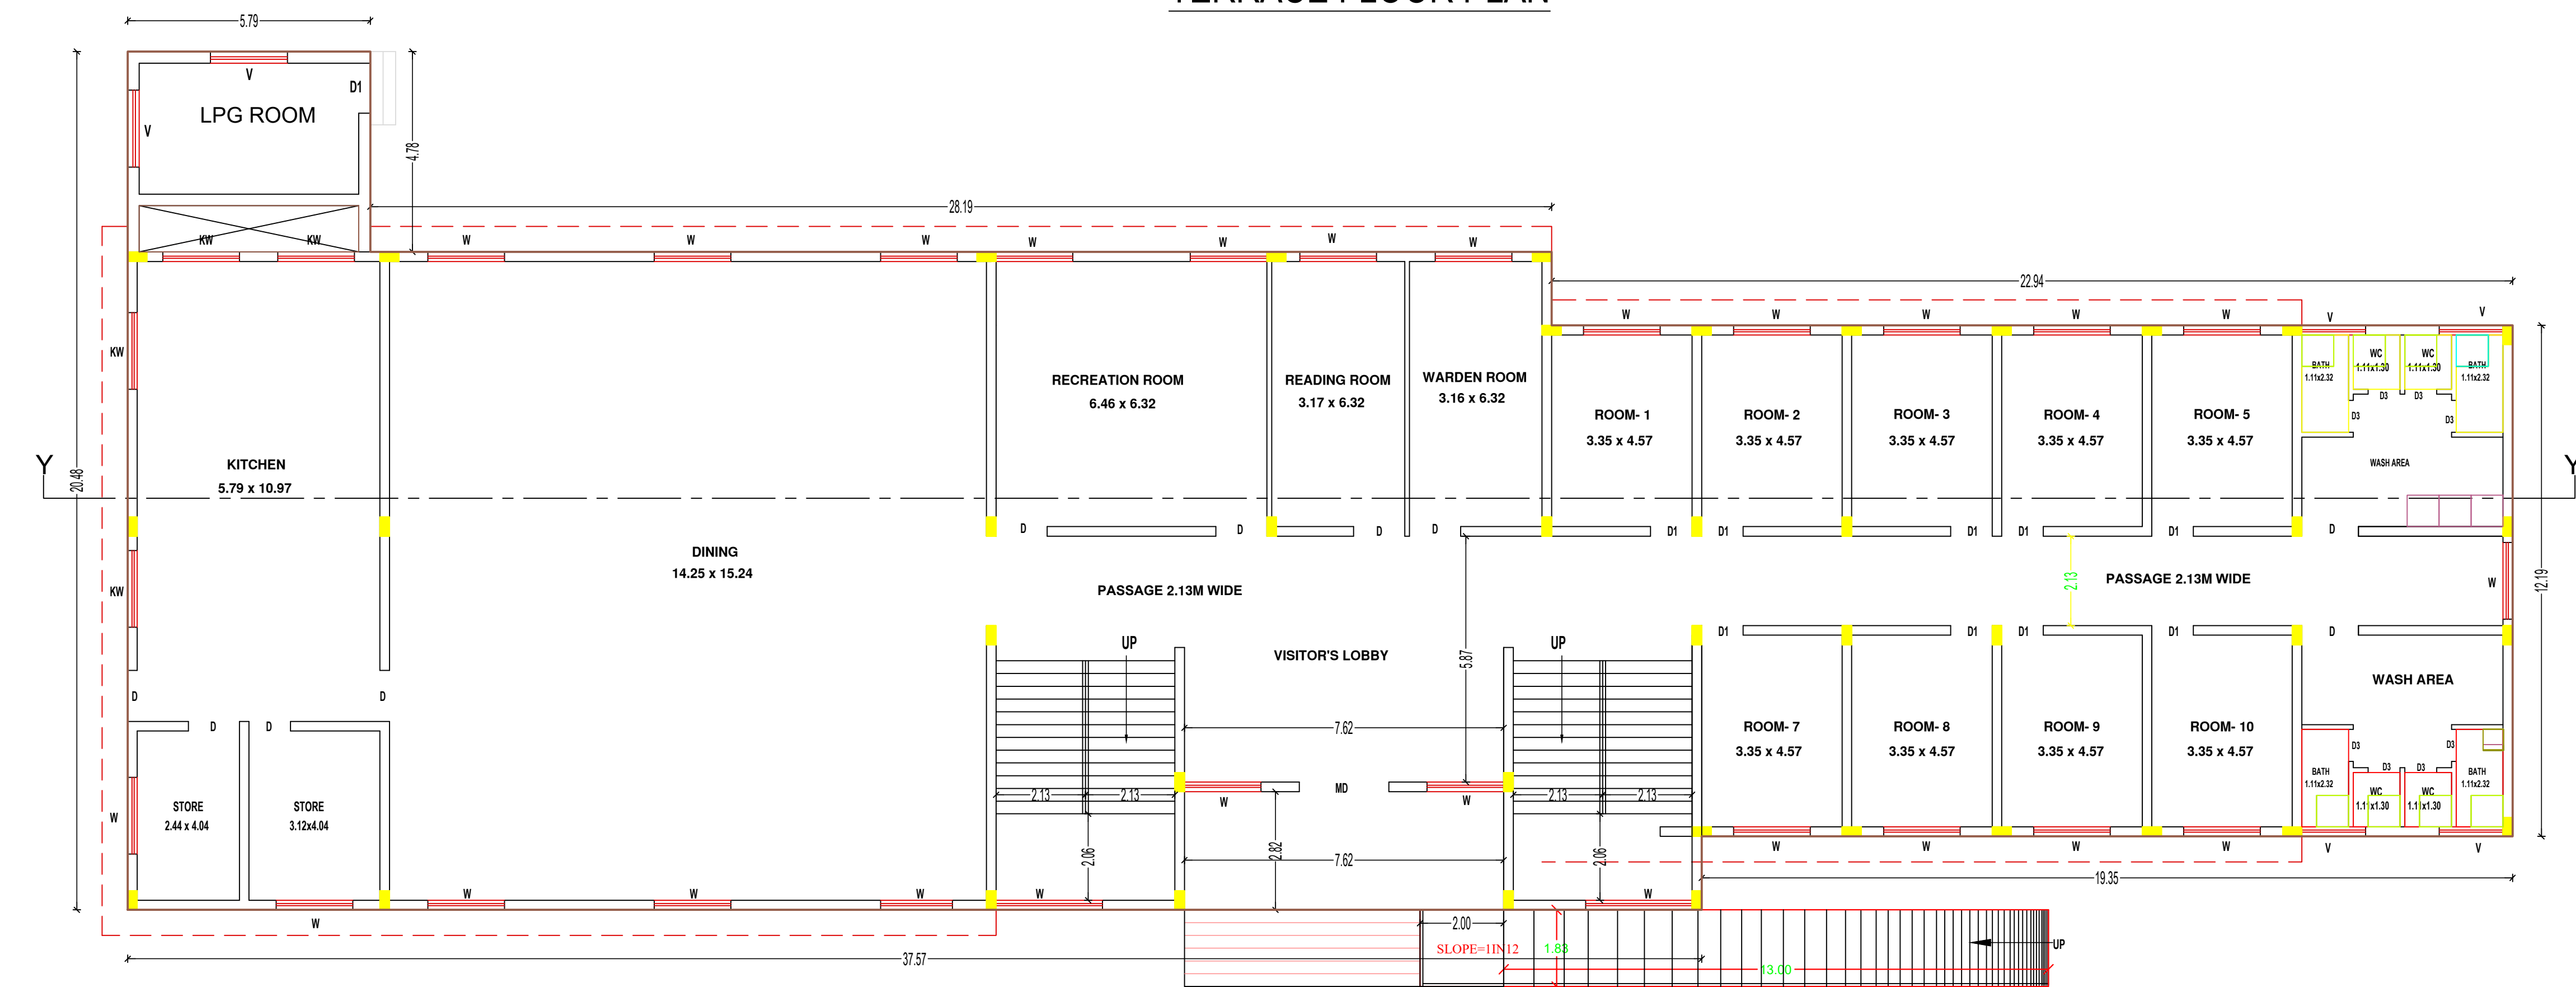

GROUND FLOOR PLAN

SCHEDULE OF JOINERIES

MD	-	MAIN DOOR	-	3.05 X 2.40M
D	-	DOOR	-	1.20 X 2.40M
D1	-	DOOR	-	0.76 X 2.10M
W	-	WINDOW	-	2.44 X 1.37M
W1	-	WINDOW	-	1.83 X 1.60M
V	-	VENTILATOR	-	1.52 X 0.61M

AREA DETAILS

BLOCK - 2	SQ.MT.	
	FSI	NON FSI
AREA OF GROUND FLOOR	841.20	
AREA OF HEAD ROOM		77.12
AREA OF RAMP		27.45
TOTAL AREA	841.20	104.57

NOTES:-

1. ALL DIMENSIONS ARE IN METRE
2. RAINWATER COLLECTION WELLS WILL BE PROVIDED
3. FIRE FIGHTING ARRANGEMENTS WILL BE PROVIDED
4. EMERGENCY ALARMS WILL BE PROVIDED
5. DRINKING WATER WILL BE PROVIDED
6. GROUND WATER SUMPS WILL BE PROVIDED
7. FILTERED RAIN WATER SUMPS WILL BE PROVIDED
8. EXHAUST FAN PROVISION IS MADE AT TOILET & WASH
9. SOLAR WATER HEATING SYSTEM PROVIDED.
10. RAINWATER HARVESTING FACILITIES PROVIDED.
11. WASTE WATER RECYCLING TRENCH AND TANK PROVIDED.
12. SEWAGE TREATMENT PLANT PROVIDED.
13. SEPTIC TANK PROVIDED.
14. WATER FACILITIES PROVIDED.
15. TRANSFORMER YARD PROVIDED.
16. FA - FIRE ALARAM PROVIDED
17. F E - FIRE SAFETY MEASURES PROVIDED.
18. SB - SAND BUCKET PROVIDED
19. FE - FIRE EXTINGUISHER PROVIDED



Er.S.VENKADESH
B.E.,F.I.V.,M.I.E.,M.I.C.A.,C.Engg.,M.Sc(Vel),
Registered Construction Engineer
Reg. No: TJR/RCE/010/2024
DTCP - Thanjavur Region
No: 56, F3, Zahira Residency, 3rd Street,
Cauvery Nagar West, Thanjavur - 5. 098947 40036
E-mail: er.s.venkadesh@gmail.com

ENGINEER

Er.S.VENKADESH
B.E.,F.I.V.,M.I.E.,M.I.C.A.,C.Engg.,M.Sc(Vel),
Registered Structural Engineer Grade - II
Reg. No: TJR/RSE-II/014/2024
DTCP - Thanjavur Region
No: 56, F3, Zahira Residency, 3rd Street,
Cauvery Nagar West, Thanjavur - 5. 098947 40036
E-mail: er.s.venkadesh@gmail.com

Er.S.VENKADESH
B.E.,F.I.V.,M.I.E.,M.I.C.A.,C.Engg.,M.Sc(Vel),
Registered Engineer Grade - I
Reg. No: TJR/RE-I/032/2024
DTCP - Thanjavur Region
No: 56, F3, Zahira Residency, 3rd Street,
Cauvery Nagar West, Thanjavur - 5. 098947 40036
E-mail: er.s.venkadesh@gmail.com

SWP / DTCP / PD / BPA No - 44 / 2024

Dr.S.Senthamil Kumar,ME,Ph.D,FIGS,MIEI,
egd,Geotechnical Engineer-No 001/RGTE/2024
703, Plot No.29,O.M.Rajoo Nagar,
Near New Bus Stand, Thanjavur - 613 005
Mail : senthamilkumar@yahoo.co.in,
Cell : 94439 76090

JOINT DIRECTOR / DEPUTY DIRECTOR (i/c)
DISTRICT TOWN AND COUNTRY PLANNING OFFICE
PUDUKKOTTAI DISTRICT