
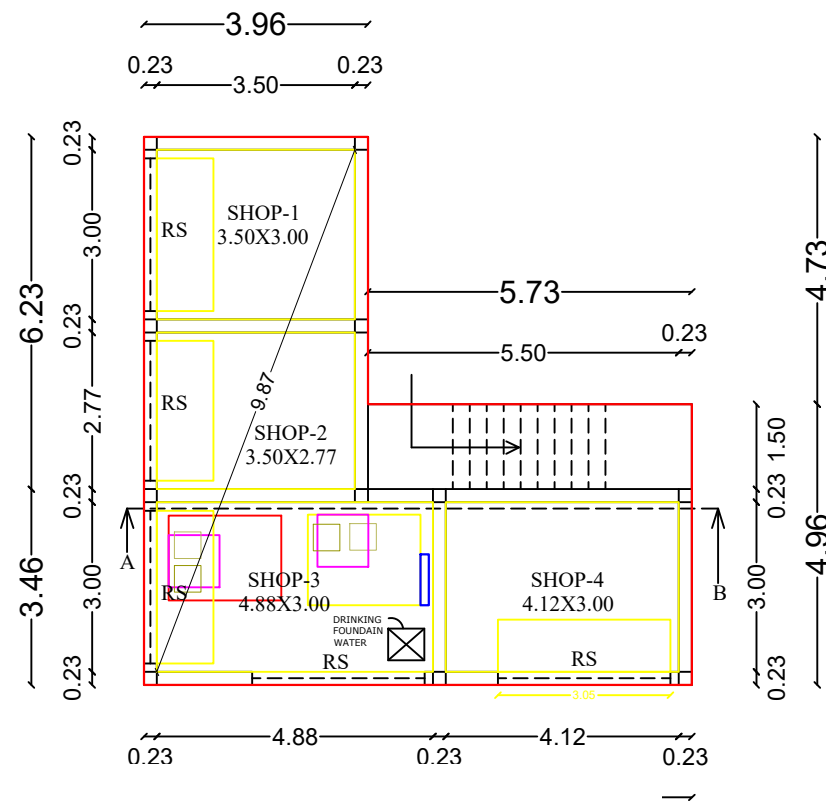
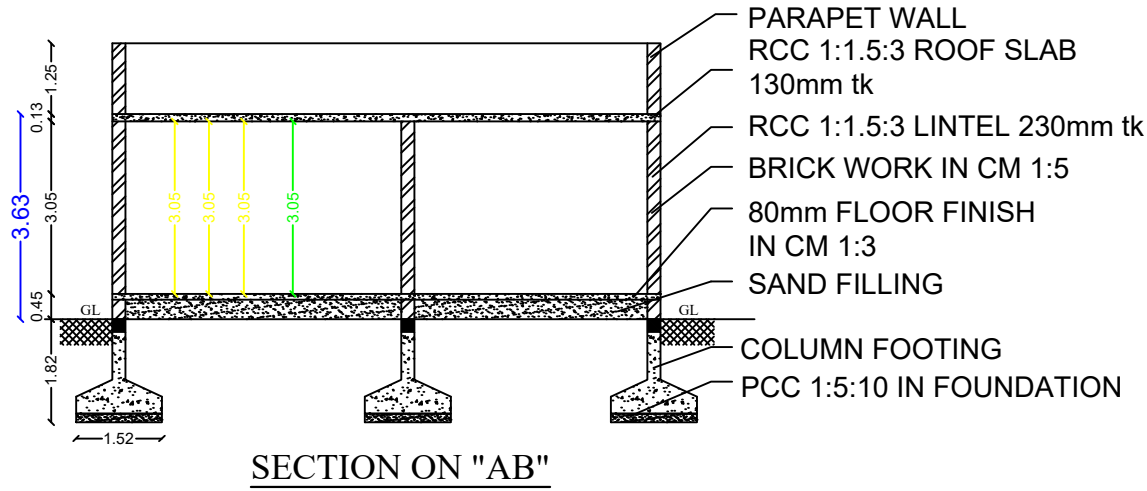





PLAN SHOWING THE PROPOSED CONSTRUCTION OF RCC ROOF COMMERCIAL BUILDING IN GROUND FLOOR AT S.F.NO:361/5A1A1, SUB DIVISION S.F.NO:361/5A1A1A3, PATTA NO:4097, PLOT NO:387, MUTHU NAGAR-B.BLOCK, WARD NO:15, YETHAPUR TOWN PANCHAYAT, PETHANAICKENPALAYAM TALUK, SALEM DISTRICT.

(SCALE- 1:100)



NAME OF APPLICANT : Mr.S.NATARAJAN, S/O SUBRAMANI.

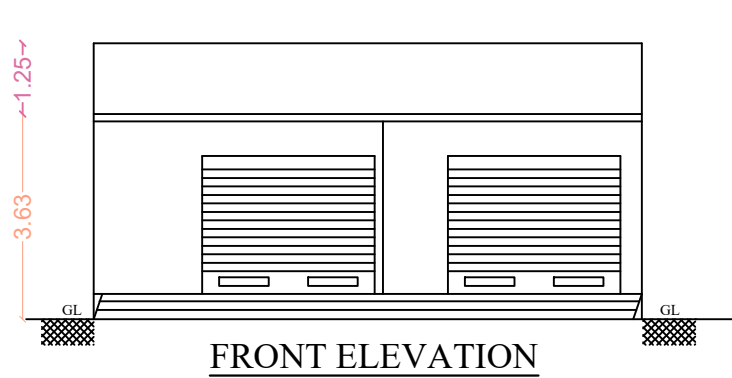

RAIN WATER (SOAK WELL)

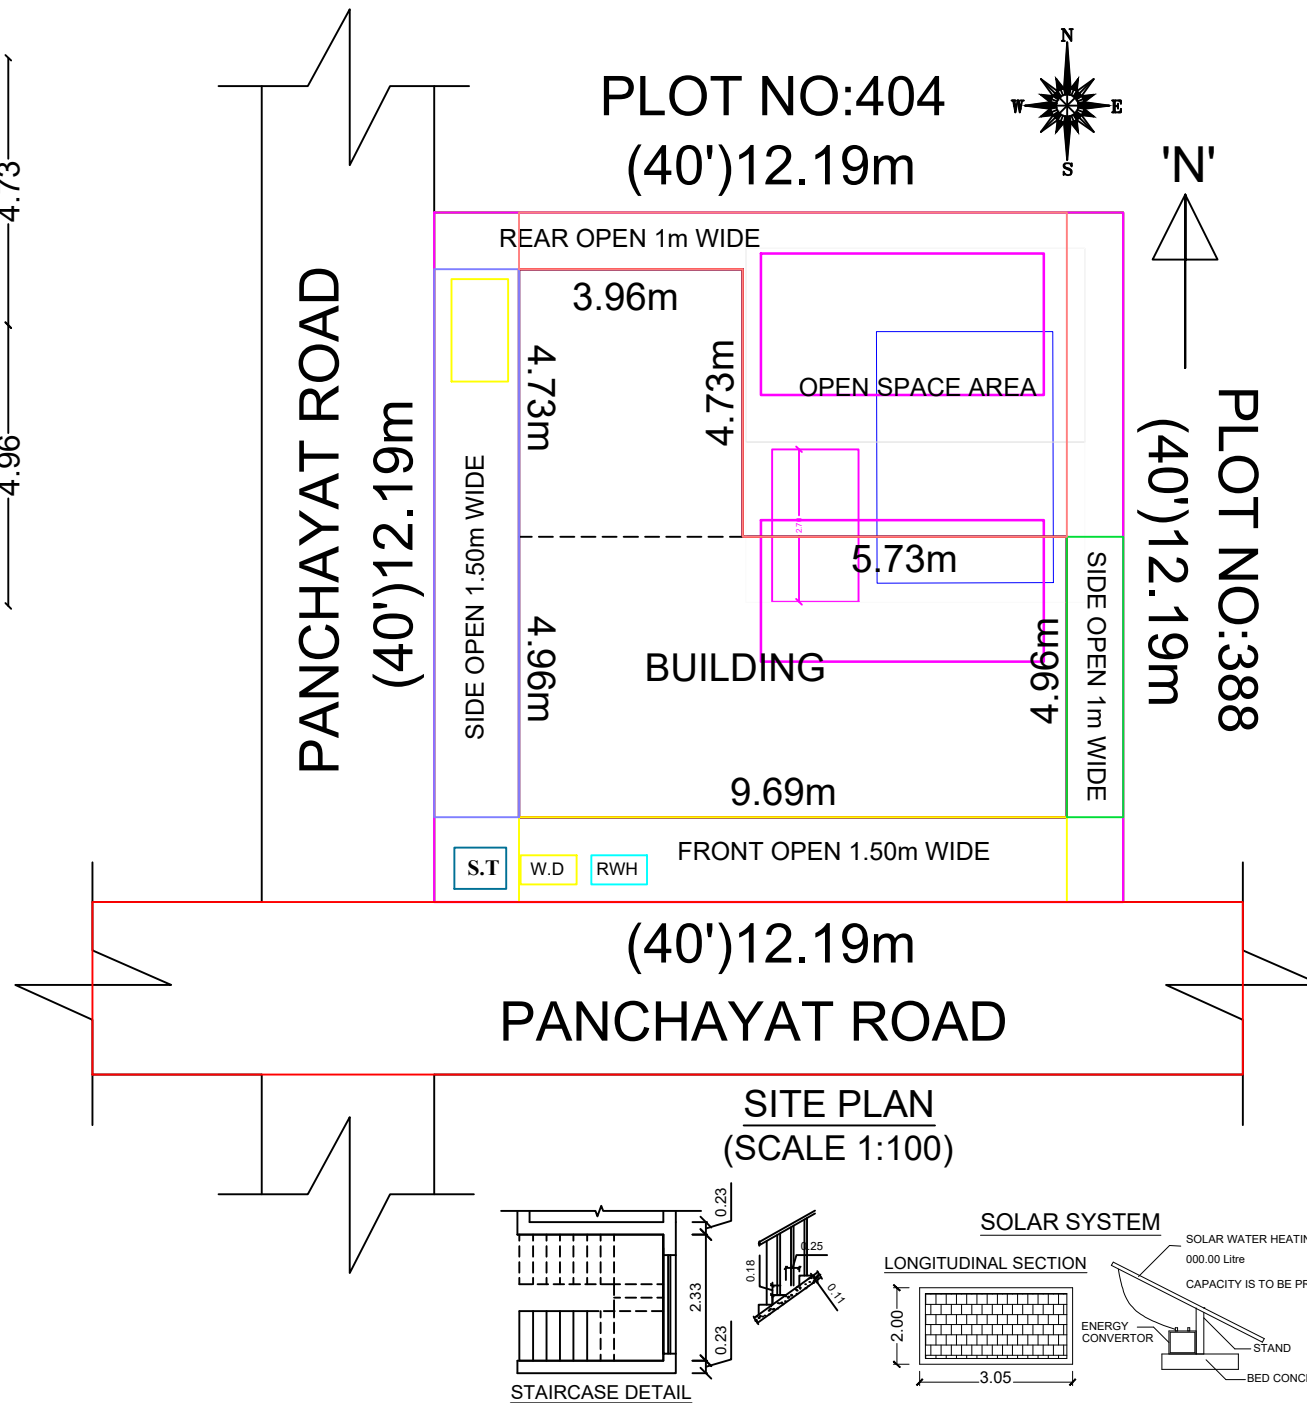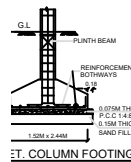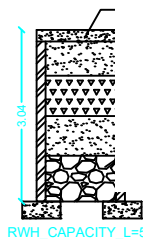

SITE PLAN (SCALE 1:100)

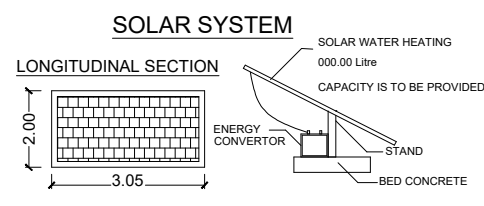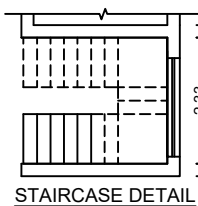

PLAN ELEVATION AND SECTION	SCALE 1:100	ALL DIMENSIONS ARE IN "METRE"
SCHEDULE OF JOINERIES :-		
JOINERYS	Ft	M
D-DOOR	3'6" X 7'0"	1.06 X 2.13
D1 - DOOR	3'0" X 7'0"	0.91 X 2.13
W - WINDOW	3'6" X 4'0"	1.06 X 1.22
W1 - WINDOW	5'0" X 6'0"	1.52 X 1.83
W2 - WINDOW	6'0" X 6'0"	1.83 X 1.83
V - VENTILATOR	3'0" X 2'0"	0.91 X 0.61

AREA PARTICULARS	IN SQM	IN SFT
TOTAL AREA	148.64m²	1600.00sft
PROPOSED BUILDING		
GROUND FLOOR	66.79m ²	718.92sft
CARPET AREA (GF)	47.20m ²	508.06sft
AREA OF OPEN SPACE (GF)	81.85m ²	881.07sft

REGISTERED ENGINEER:-


[Signature]

Er.M.VIJAYA BARATHI, D.C.E.,L.I.V.,M.I.S.T.E.,
V.J.BUILDERS & CONSTRUCTIONS,
884D,LPNV Complex inside,
LIC OFFICE OPPOSITE, ATTUR TALUK,
SALEM DISTRICT.9944478899


APPLICANT:-

[Signature]


Mr.S.NATARAJAN.

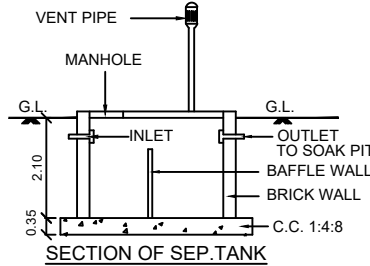


SECTION OF SEP.TANK

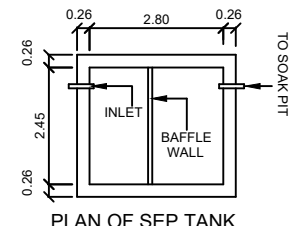

PLAN OF SEP.TANK

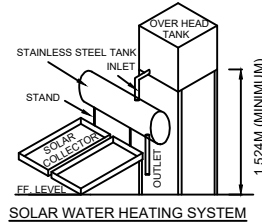

SOLAR WATER HEATING SYSTEM

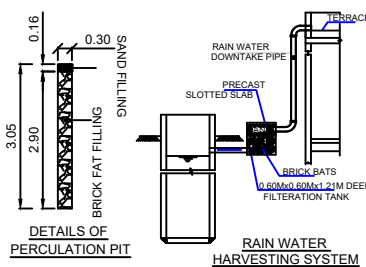

DETAILS OF PERCOLATION PIT

RAIN WATER HARVESTING SYSTEM