



PLAN SHOWING THE PROPOSED CONSTRUCTION OF SHEET ROOF & RCC TERRACED ROOF M/S RELECTRON INDIA PRIVATE LIMITED BUILDING (BLOCK-I & II)
IN GROUND FLOOR & FIRST FLOOR AT S.F.NO: 59(p),P.NO S-1 SIPCOT PHASE-III, MUGUNDARAYAPURAM, WALAJAH TALUK, RANIPET DISTRICT.
ALL DIMENSIONS ARE IN METRE. APPROVED SIPCOT LAYOUT NO-L/DDTCP(VELLORE REGION)-NO-43/2020

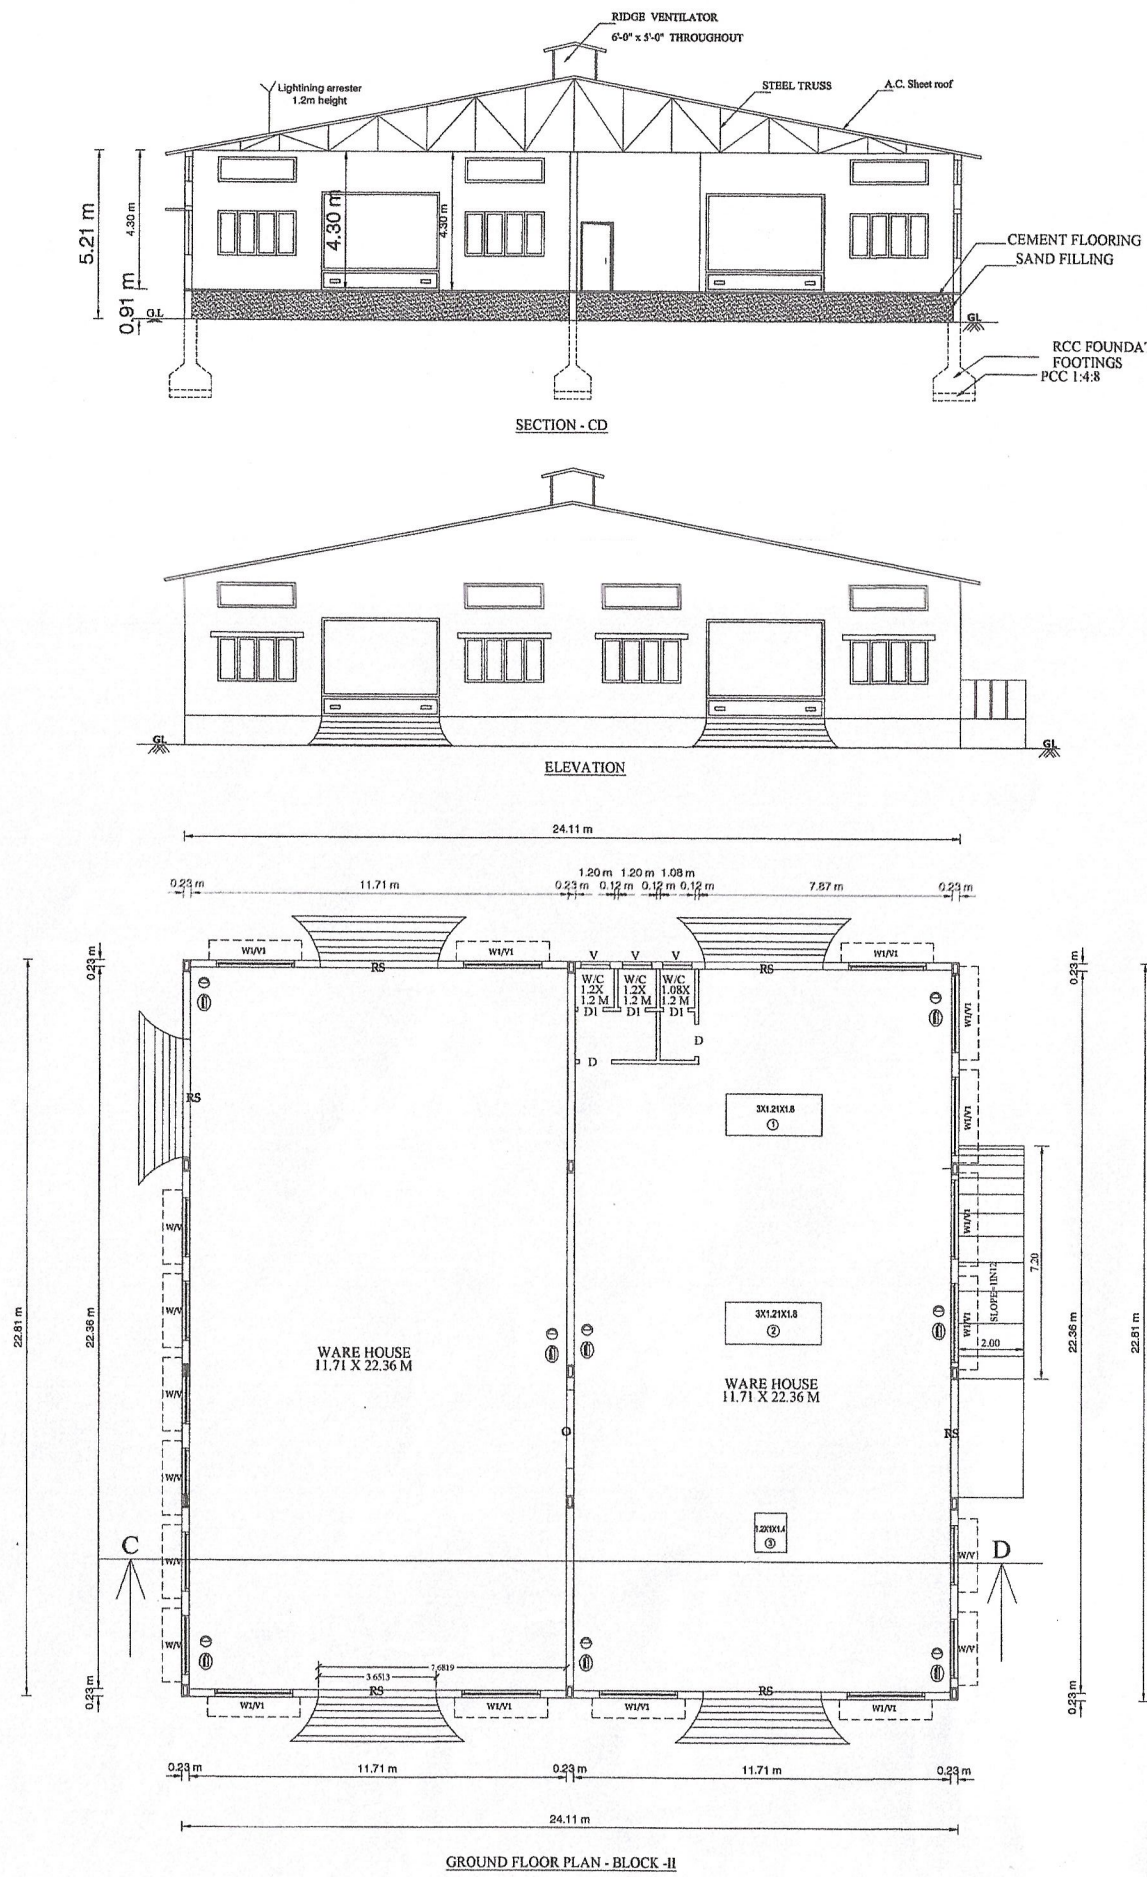

SITE PLAN
SCALE 1:200

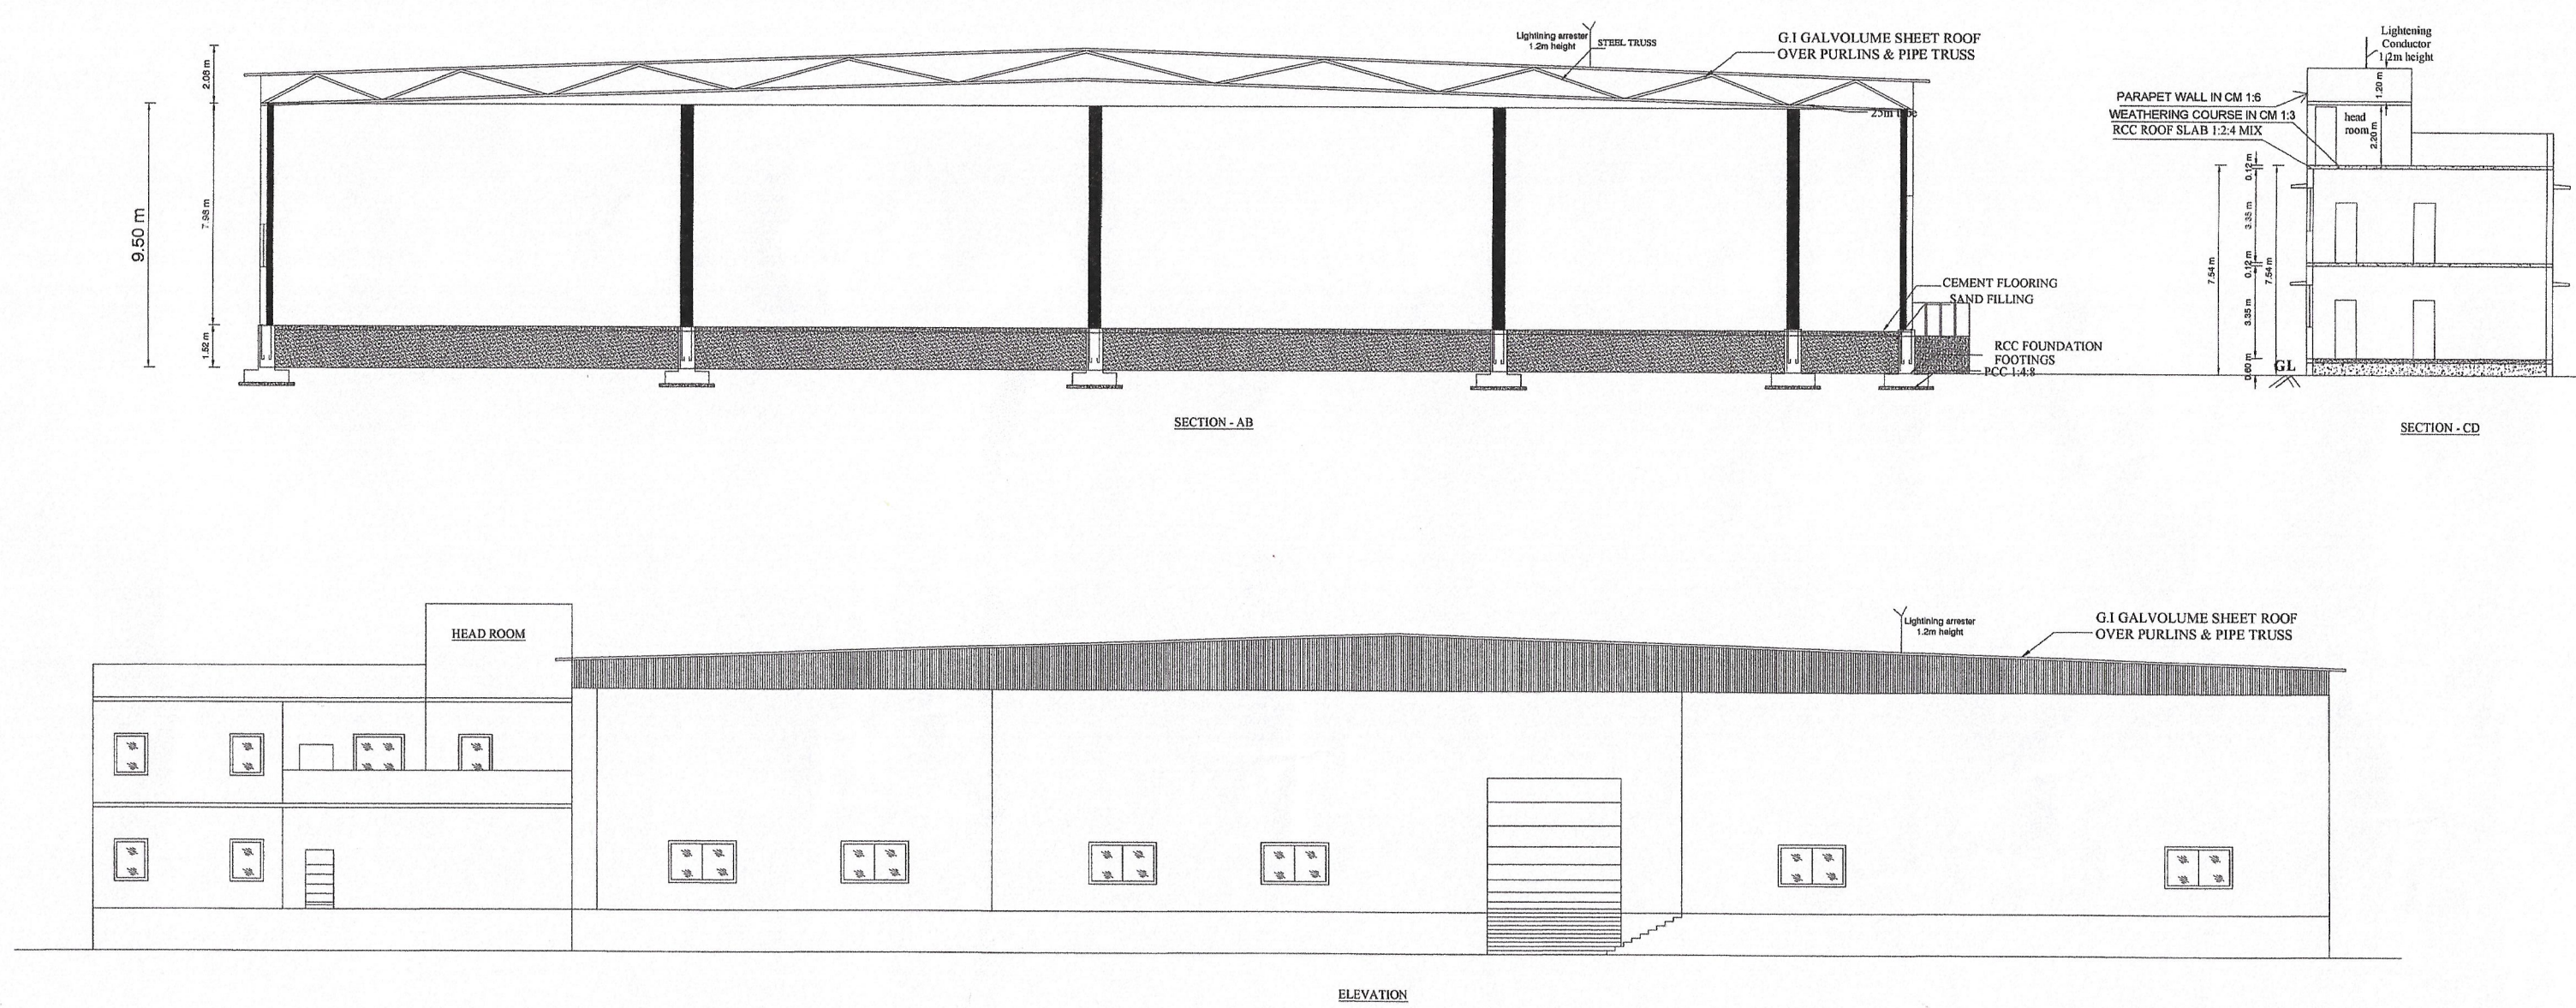

GRINDING MACHINE - 1 100HP
GRINDING MACHINE 2 - 100HP
TOTAL HP - 200HP

Note:
FIRE EXTINGUISHER

TOTAL NO. OF WORKERS - 20 MEMBERS

Note:
Owner's Boundary shown
Proposed Construction area shown
Existing road shown

TOTAL AREA OF THE SITE				9765.20 Sq.m
SL. NO.	DESCRIPTION	FSI (SQ.M.)	(NON FSI) (SQ.M.)	TOTAL AREA
01	GROUND FLOOR(B-I)	2958.40	-	2958.40
02	FIRST FLOOR(B-I)	141.77	-	141.77
03	GROUND FLOOR(B-II)	549.88	-	549.88
TOTAL		3650.05	-	3650.05

Floor Space Index:
Floor space index: $3650.05/9765.20 = 0.37 < 1.50$


Parking area:
Parking Area As Per Report - 3650.05 Sq.m
1 Lorry For Every 500 Sq.m
1 Car for every 100 sq.m
1 Two wheeler and cycle for every 50sq.m
Required Lorry Parking - 08 Nos
Provided Lorry Parking - 08 Nos
Provided Car Parking - 39 Nos
Provided Two Wheeler - 78 Nos
Provided Cycle - 78 Nos

Fire Certificate:
Necessary Fire Extinguishers will be provided with the permission from the fire Service

Reference:
For Bath and wash separate pipeline is to be provided and directly connected to the Recharge pit for recycling purpose.

JOINERY DETAILS	
RS	ROLLING SHUTTER --- 3.66 X 3.00 M
RS	ROLLING SHUTTER --- 1.00 X 2.13 M
MD	MAIN DOOR --- 1.22 X 2.13 M
D	DOOR --- 1.22 X 2.13 M
D1	DOOR --- 0.76 X 2.13 M
W	WINDOW --- 1.83 X 1.52 M
W1	WINDOW --- 2.44 X 1.52 M
V	VENTILATOR --- 0.91 X 0.91 M
V1	VENTILATOR --- 2.44 X 0.61 M

For RELECTRON INDIA PVT.LTD.
APPLICANT SIGNATURE

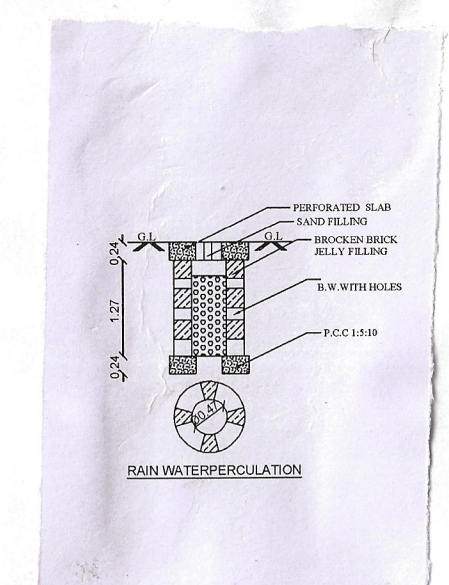

Er. V. M. ARCHANA, M.E.,
Licensed Structural Engineer,
Regd. No: SE-GR-HOCT 2020/00
No. 40, Opposite to NSD Motors,
Gandhi Nagar, Ammor Road,
Vellore - 512 513,
C. No: 76449 28097 / 63938 75044

STRUCTURAL ENGINEER

Er. K. K. ARJUNAN, DCF
Regd. No: SE-GR-HOCT 2020/00
No. 40, Opposite to NSD Motors,
Gandhi Nagar, Ammor Road,
Vellore - 512 513,
C. No: 76449 28097 / 63938 75044

REGISTERED ENGINEER

