


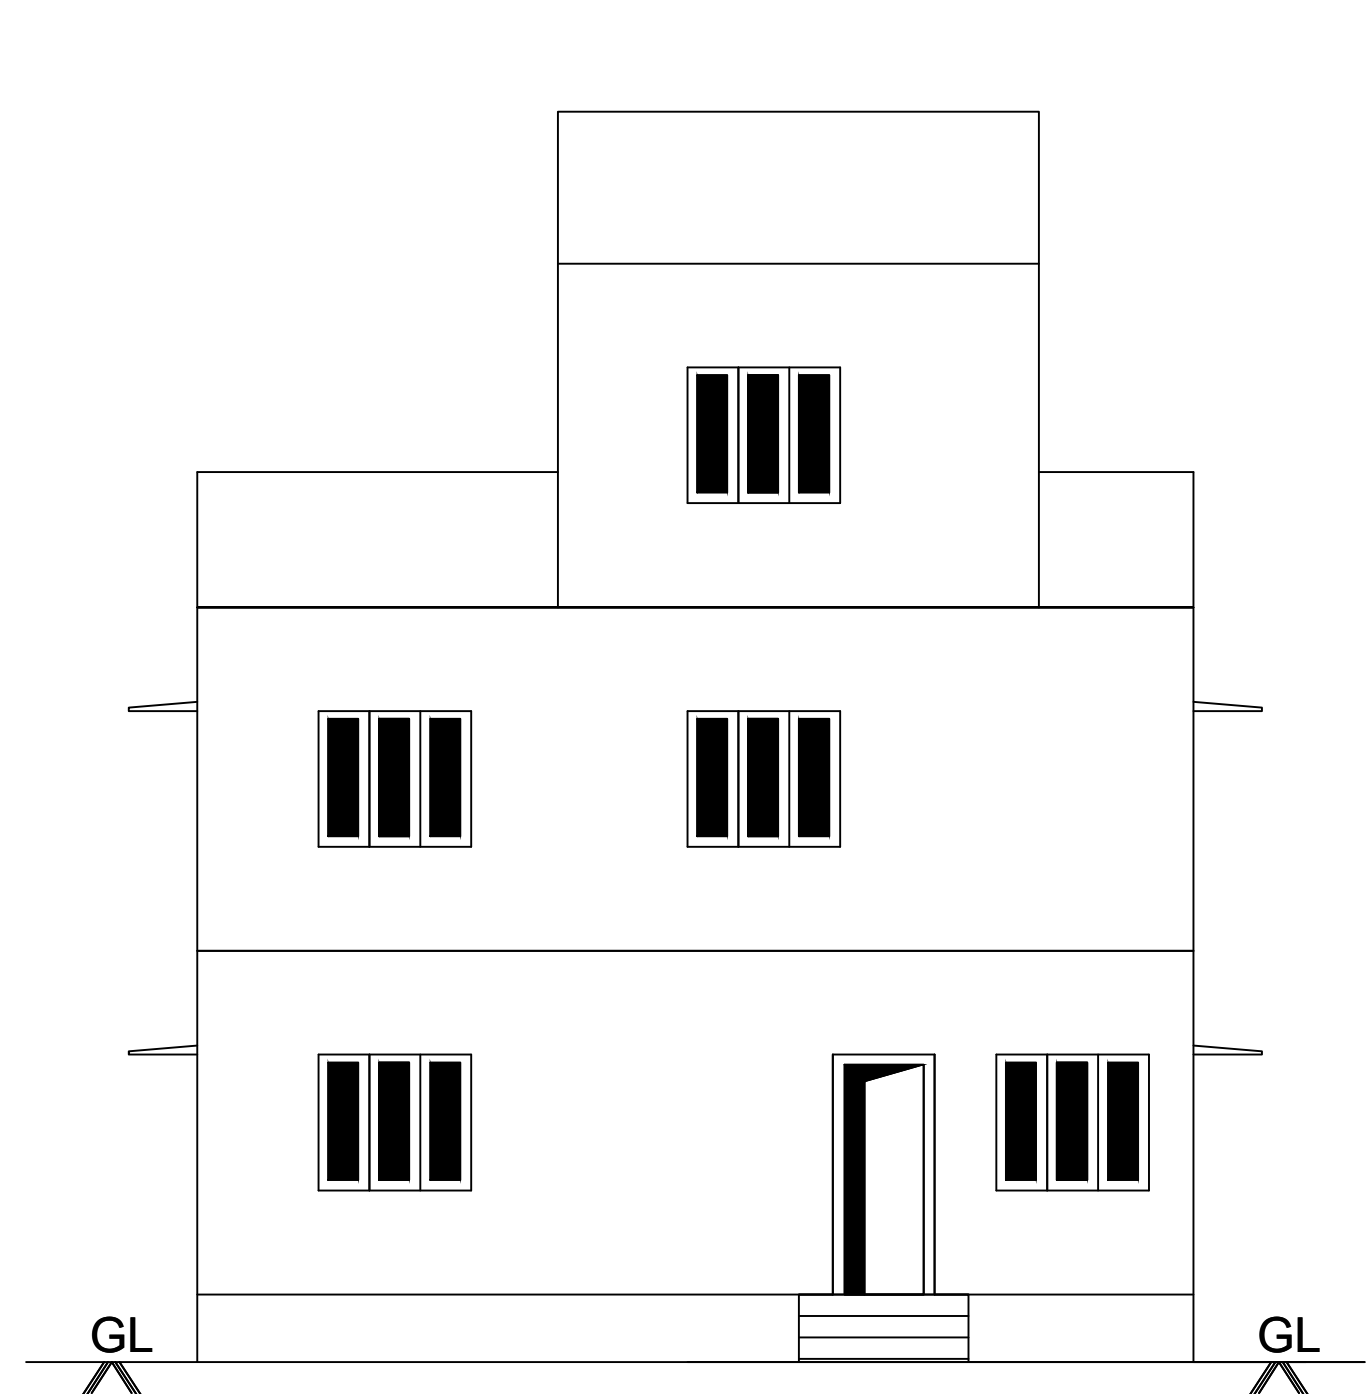


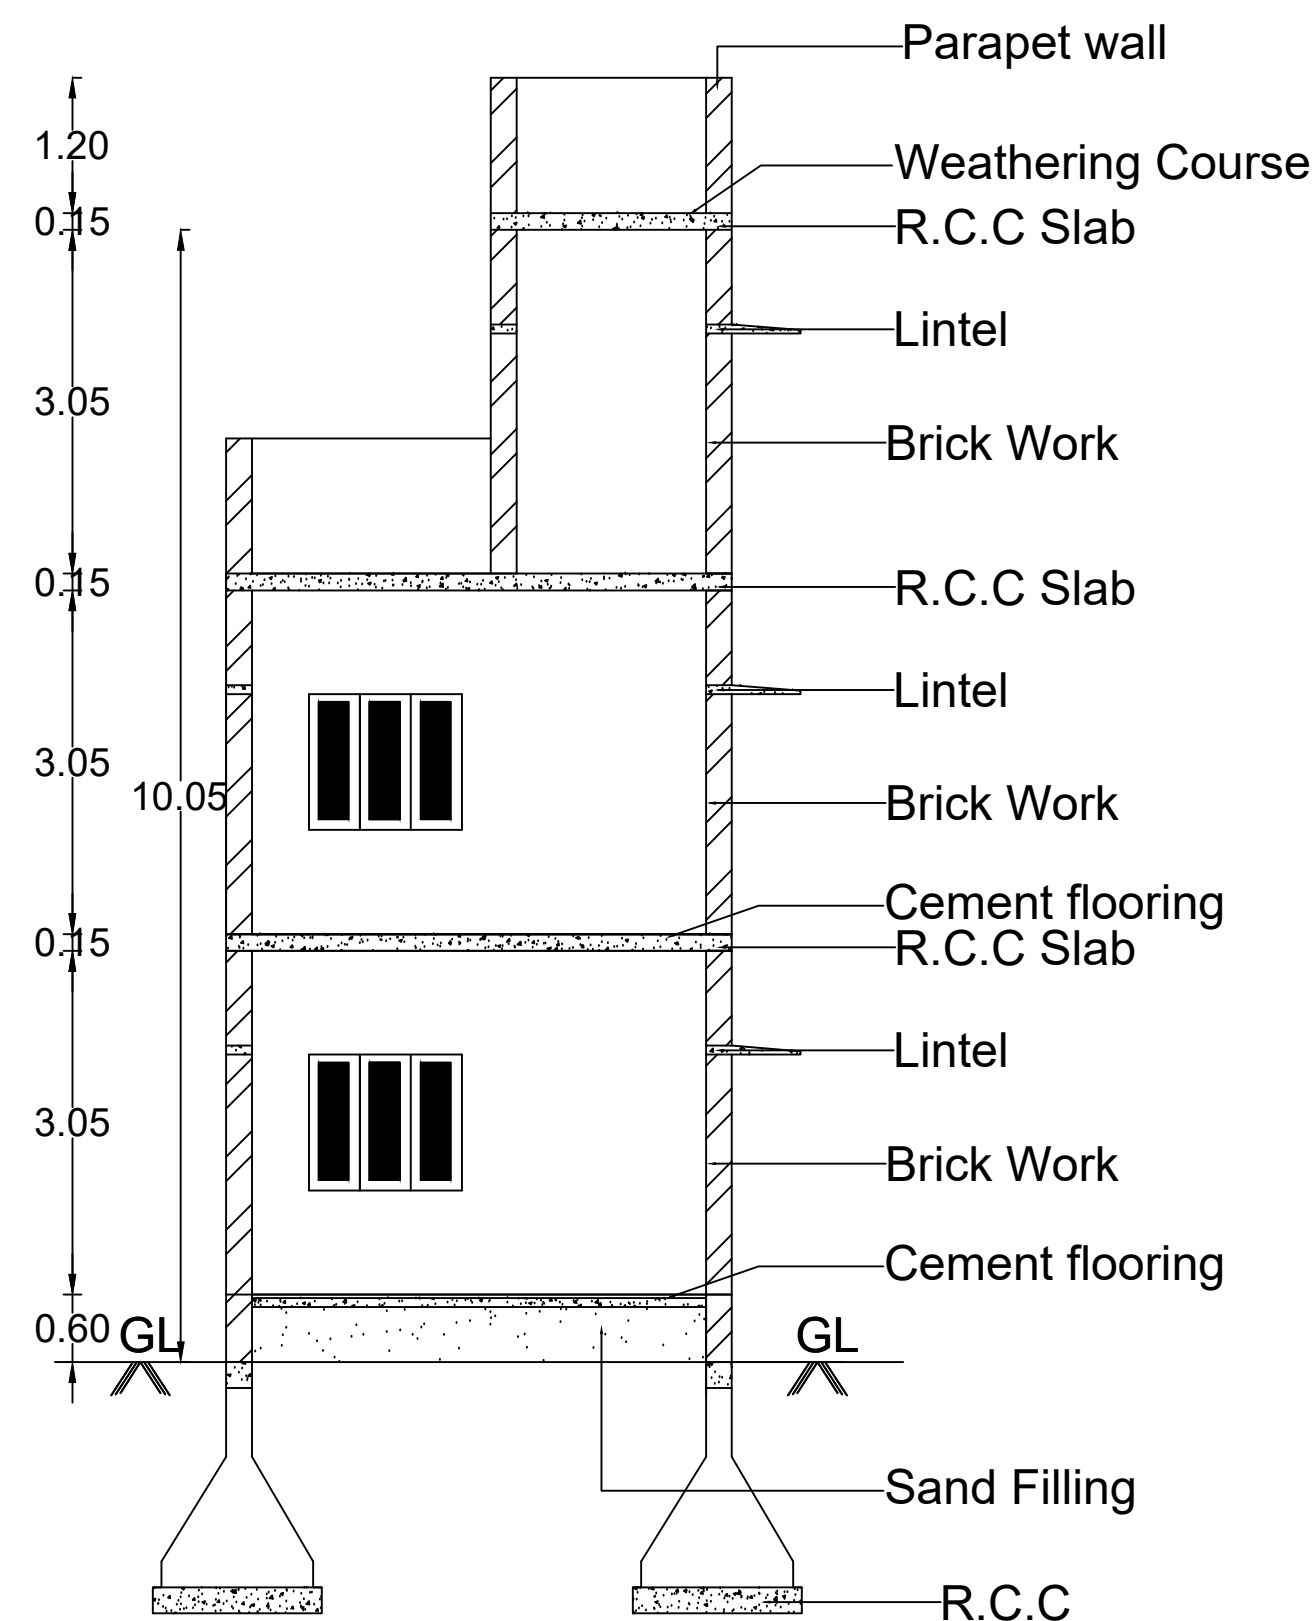



ELEVATION

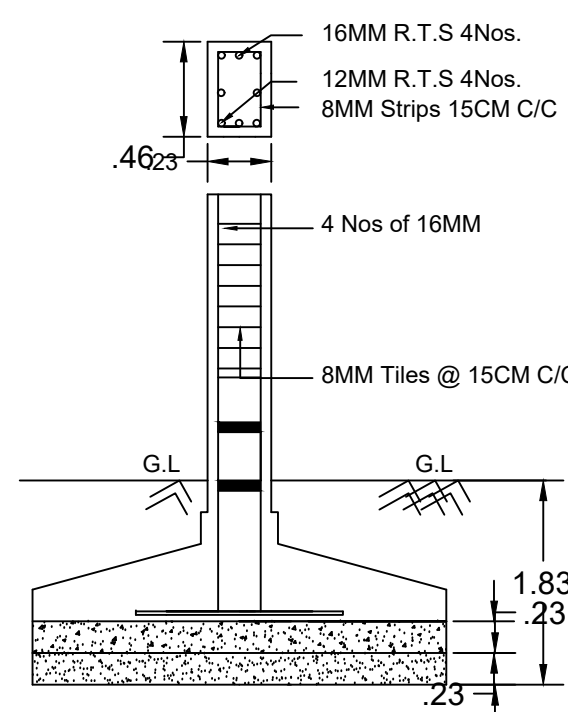

SECTION ON'AB'

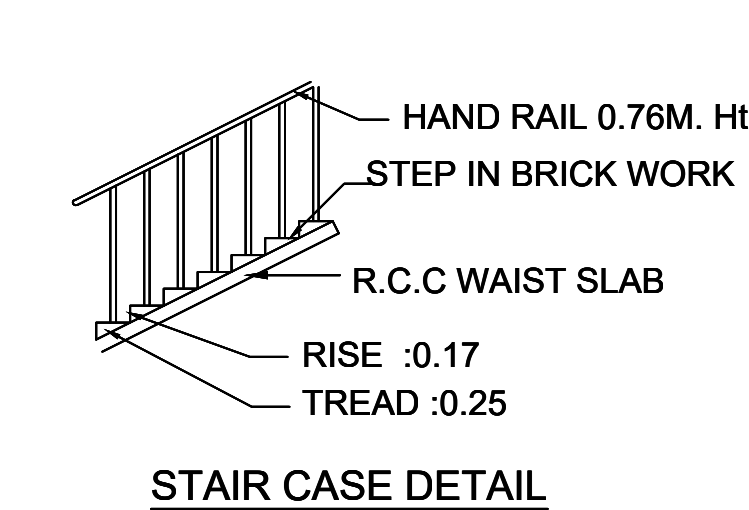



RCC COLUMN DETAILS

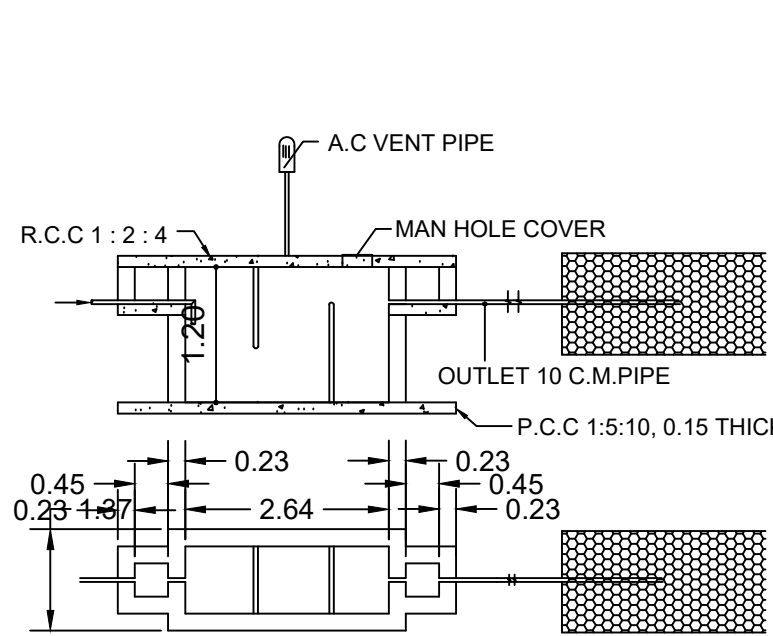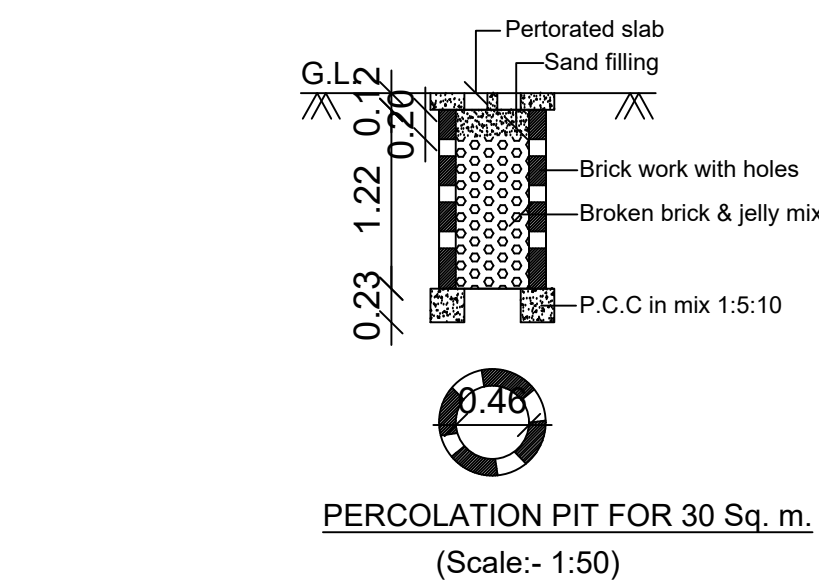


SEPTIC TANK DETAILS

PLAN SHOWING THE PROPOSED CONSTRUCTION OF R.C.C ROOF HOUSE AFTER DEMOLISHING THE EXISTING HOUSE BEARING DOOR.NO:68, IN SY.NO:12/934,WARD.NO:18,AT ILAYANKUDI VILLAGE,ILAYANKUDI TOWN PANCHAYAT,SIVAGANGAI DISTRICT.


NAME OF THE APPLICANT : Mr.SHAIK DEEVAN S/O.Mr.MOHAMMED JAFARRULAKHAN.

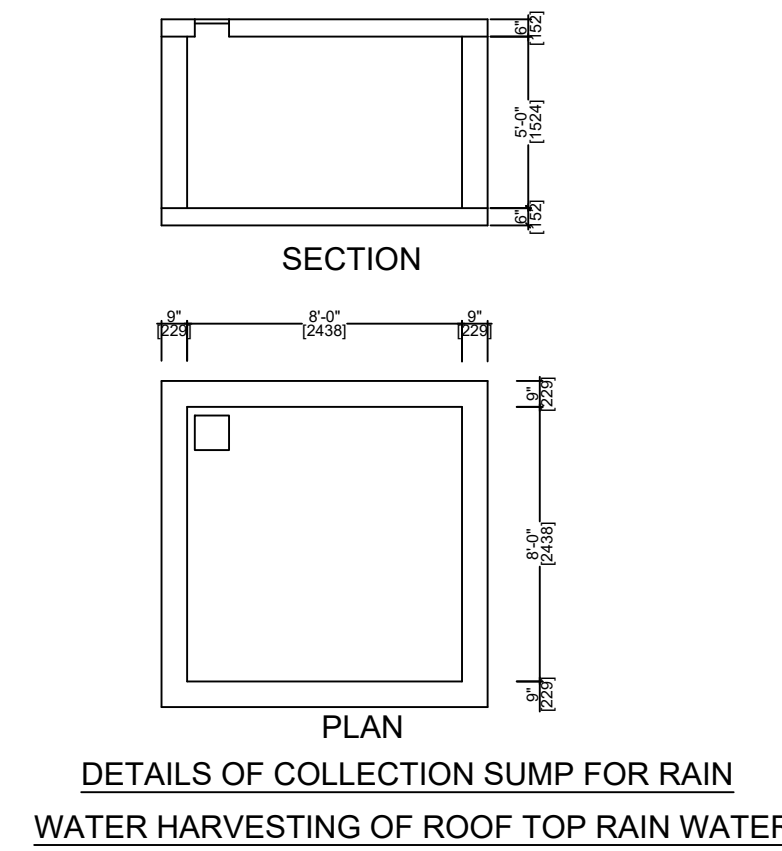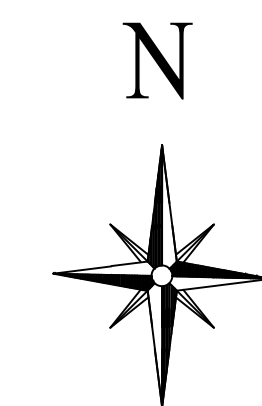


DETAILS OF COLLECTION SUMP FOR RAIN WATER HARVESTING OF ROOF TOP RAIN WATER

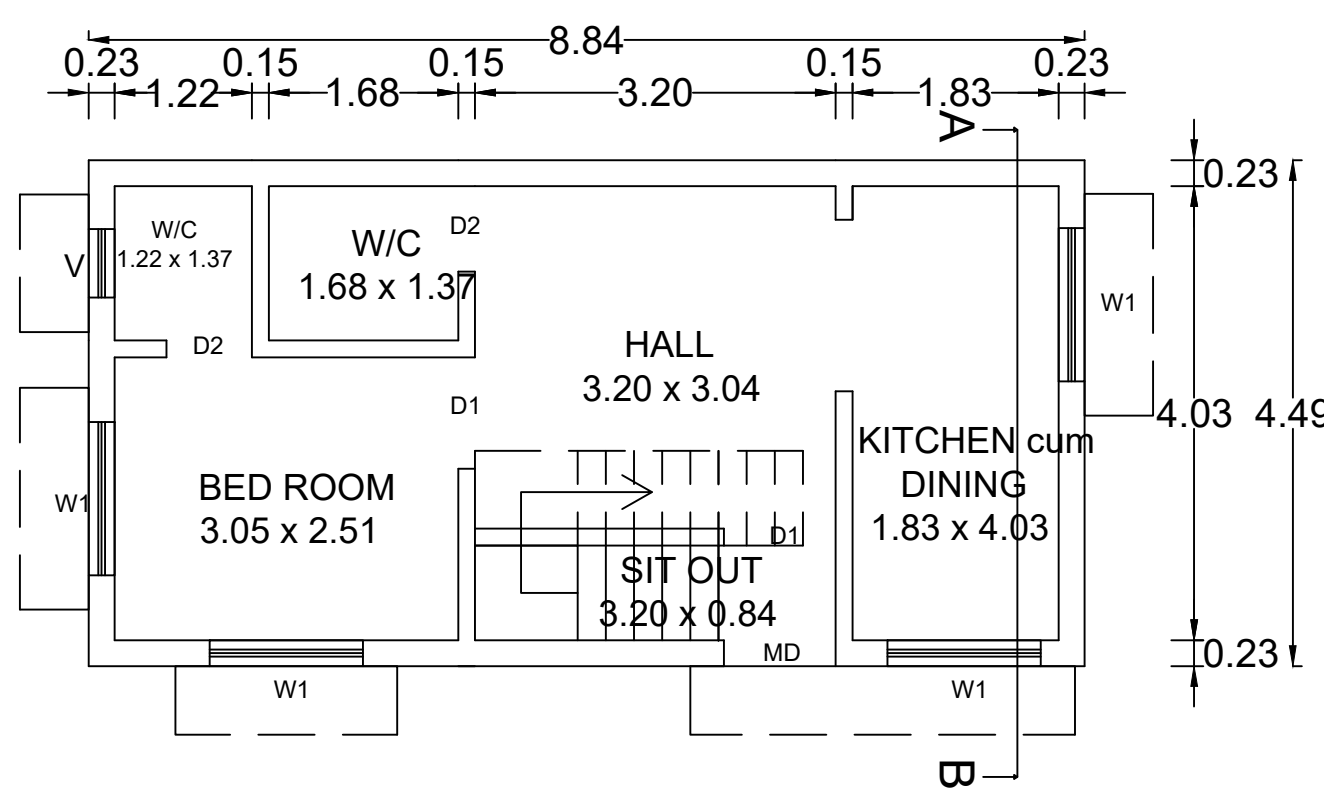


GROUND FLOOR PLAN

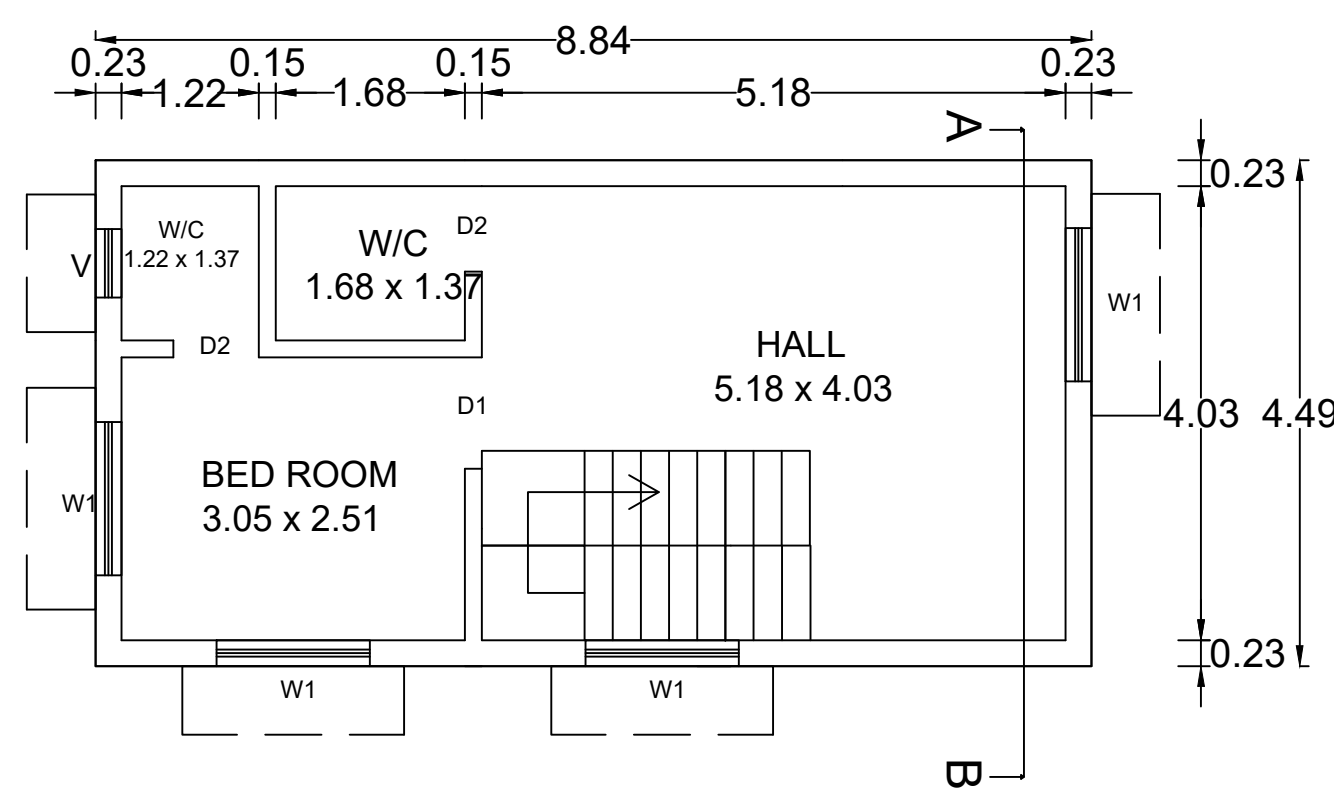

FIRST FLOOR PLAN

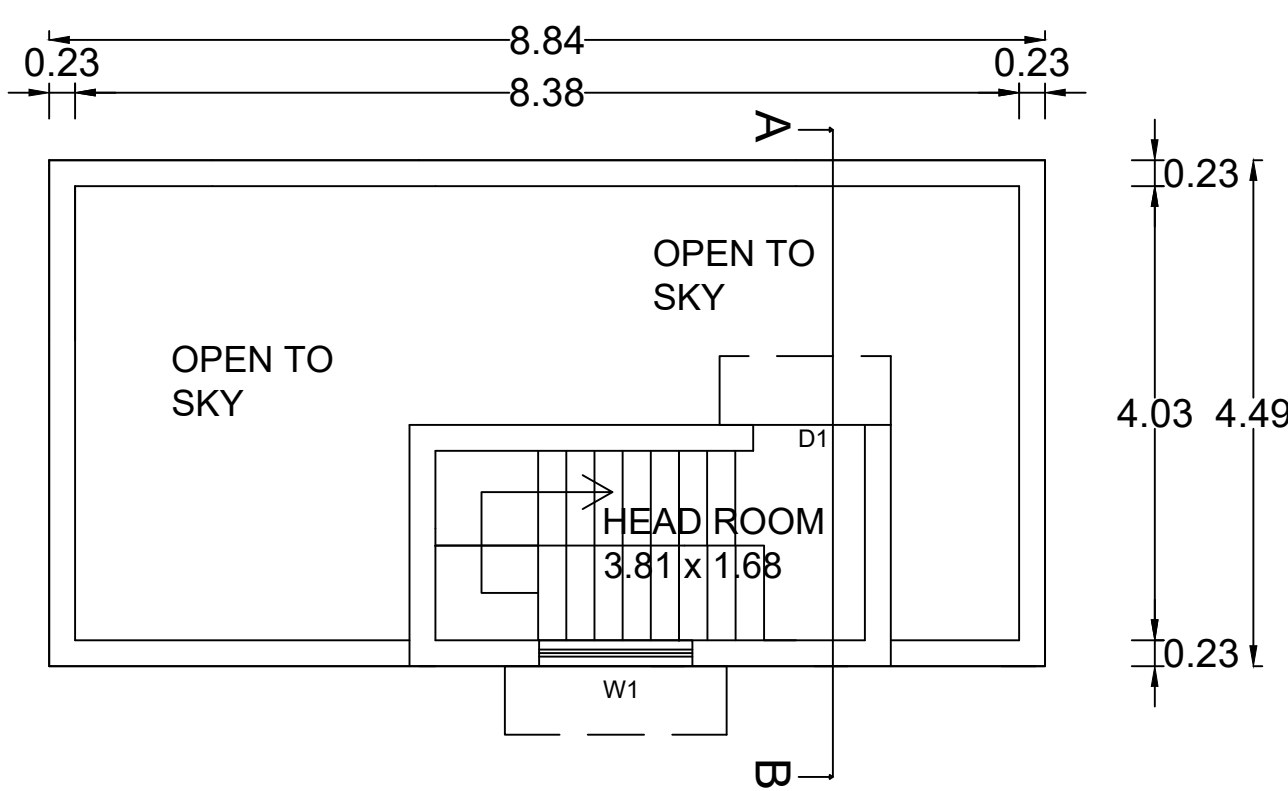

SECOND FLOOR PLAN

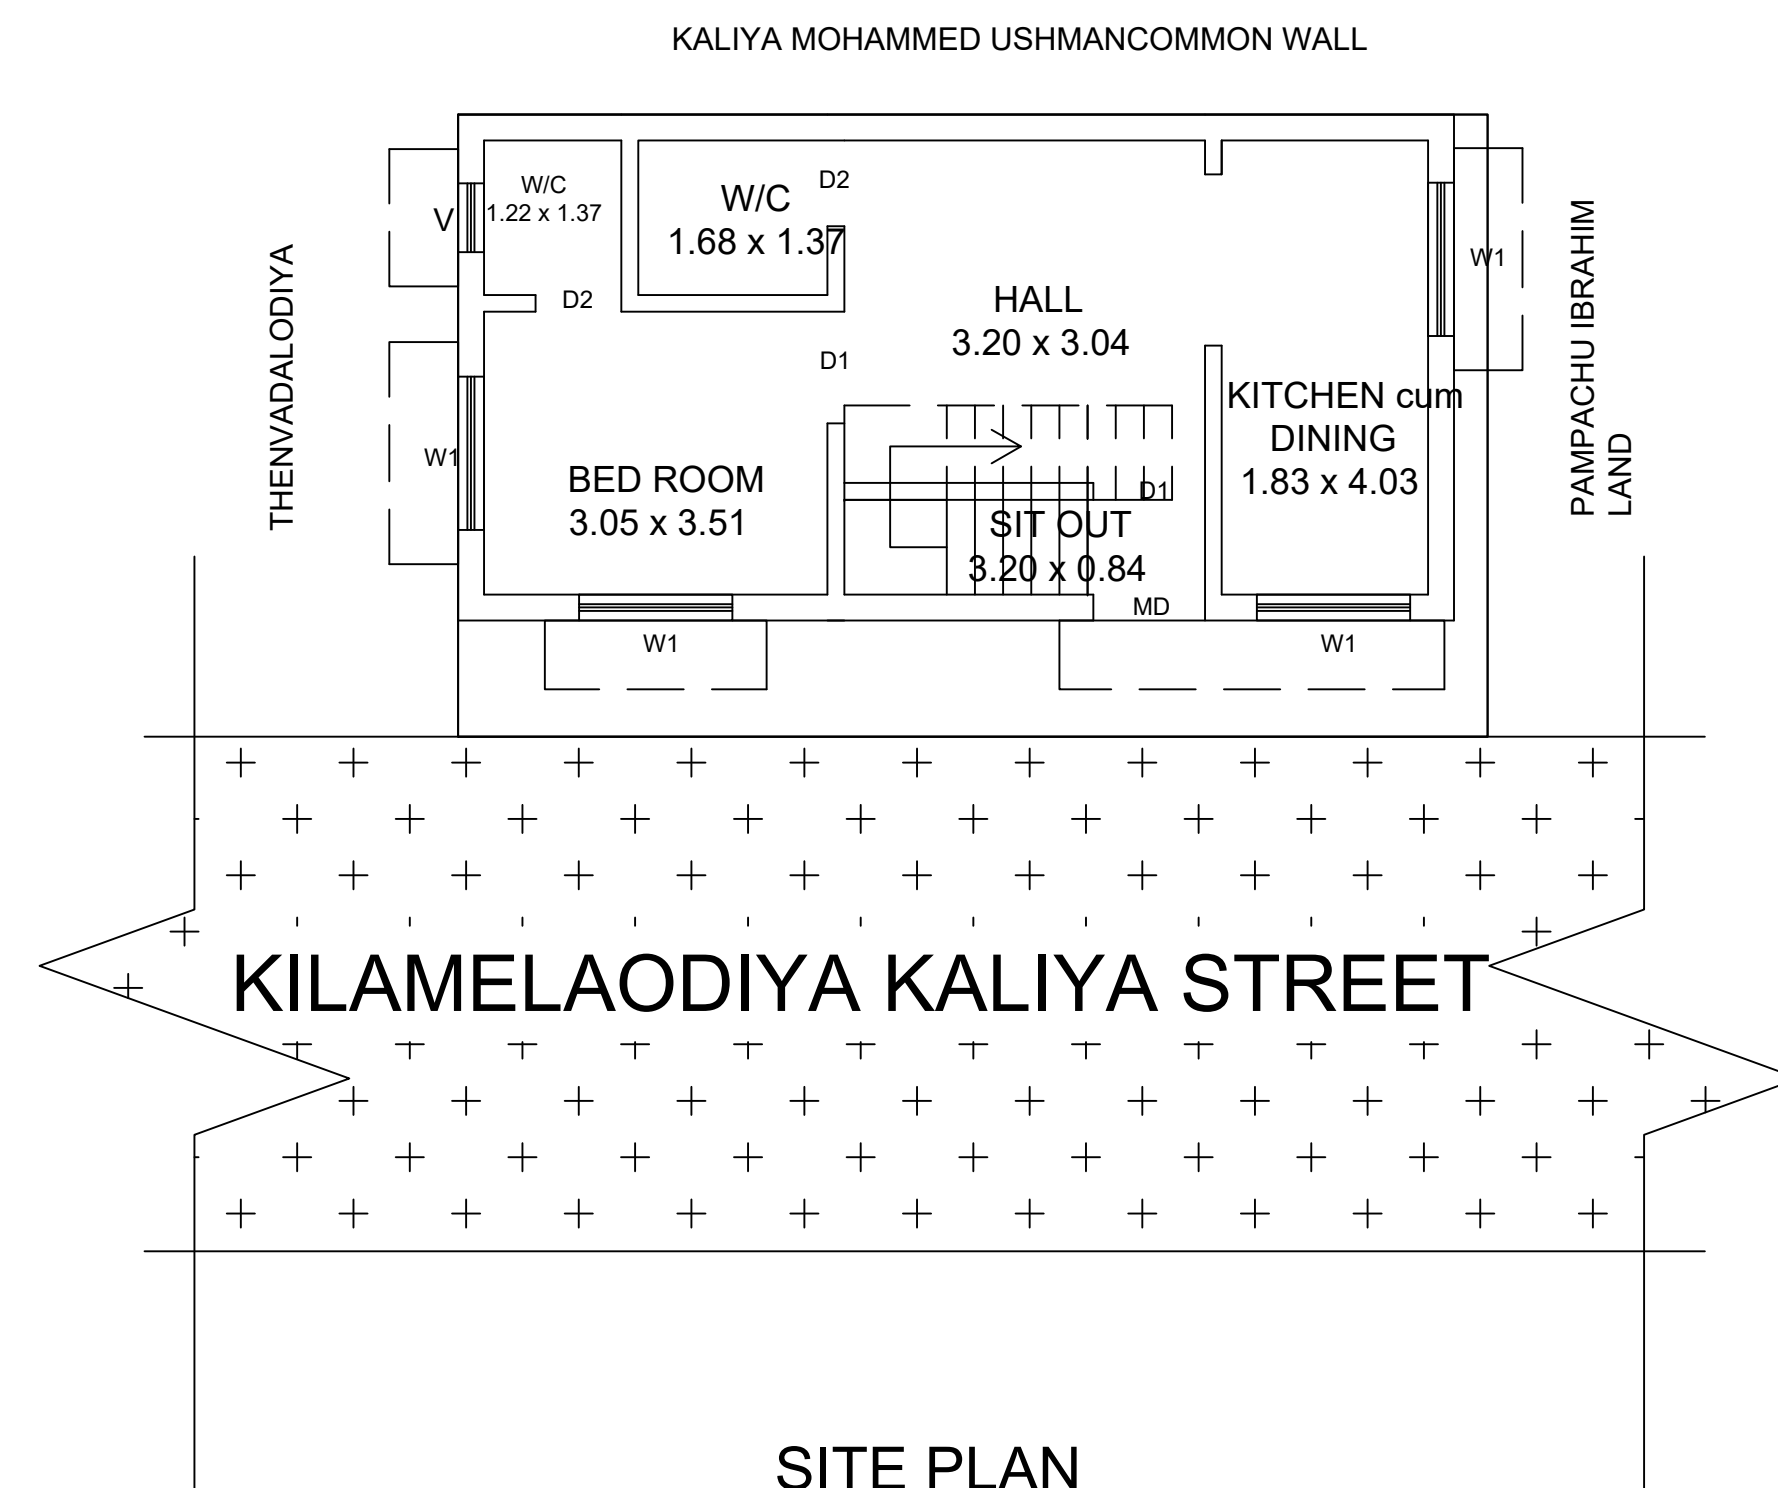

SITE PLAN

SCALE - 1:100

JOINERY				
W3	Window 4.49 X 1.22	W2	Window 2.98 X 1.22	
D	DOOR 1.22 X 2.10	V1	Ventilator 2.33 X 0.61	
D2	DOOR 0.76 X 2.10	V	Ventilator 0.91 X 0.61	
AREA DETAILS			SQ.M	SQ.FT
	SITE AREA		50.45	542.84
	PROPOSED AREA		88.52	952.47
	PRO. GROUND FLOOR		39.69	427.06
	PRO. FIRST FLOOR		39.69	427.06
	PRO. SECOND FLOOR		9.14	98.35
	OPEN SPACE		10.76	115.78
	ROAD			

☐ RAIN WATER COLLECTING TANK IS TO BE PROVIDED waste water to be garden
ALL DIMENSION ARE IN METRE
SCALE 1:100

OFFICE USE

APPLICANT

ENGINEER

