




PLAN SHOWING THE PROPOSED ADDITIONAL FIRST FLOOR CONSTRUCTION OF THE R.C.C ROOF COMMERCIAL BUILDING OF BEARING OF OLD S.NO:3/23,NEW S.NO:3/202A1B, PLOT.NO:77,BHAGYA NAGAR,THIRUPPUVANAM NELMUDIKARAI VILLAGE,THIRUPPUVANAM TOWN PANCHAYAT,THIRUPPUVANAM TALUK & SIVAGANGAI DISTRICT.

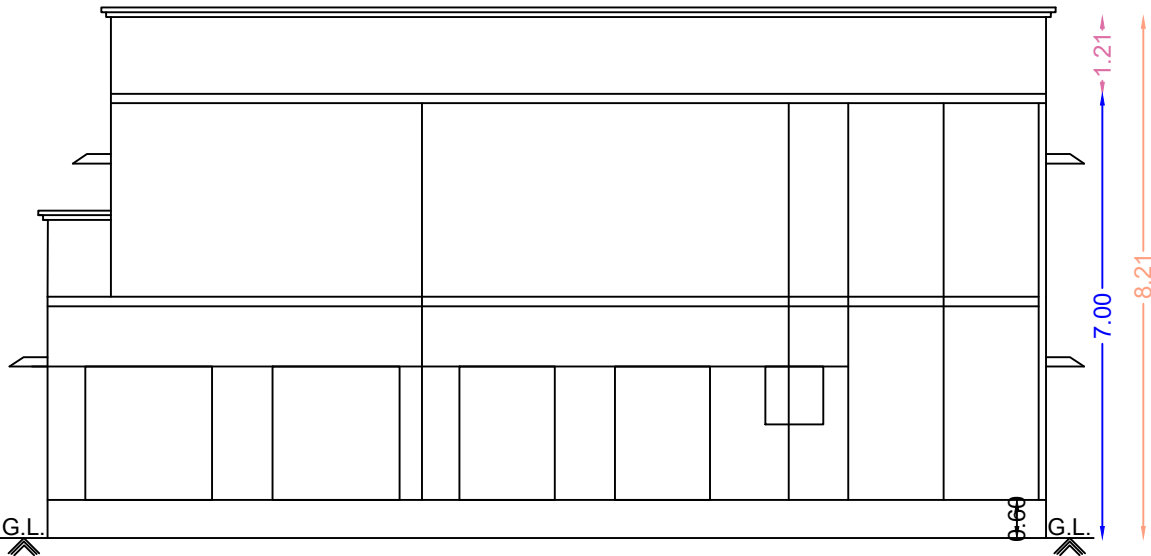



Front Elevation

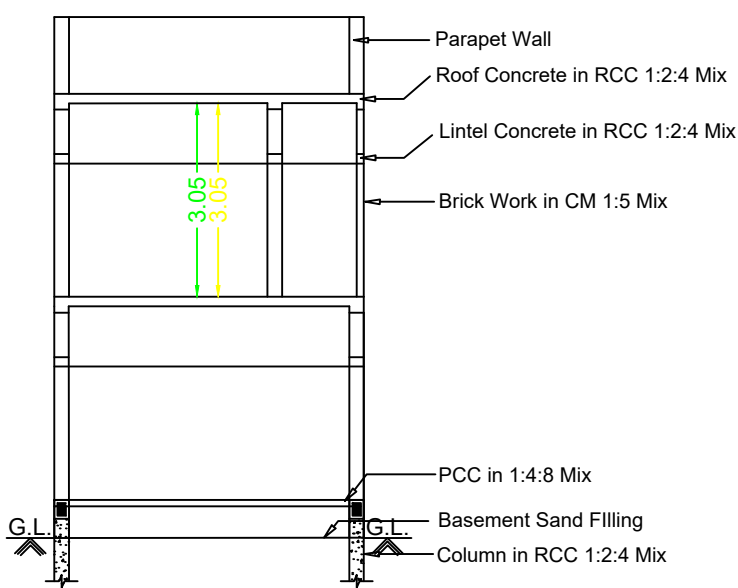

Section RR

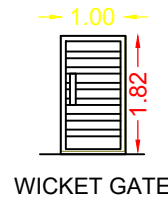

WICKET GATE

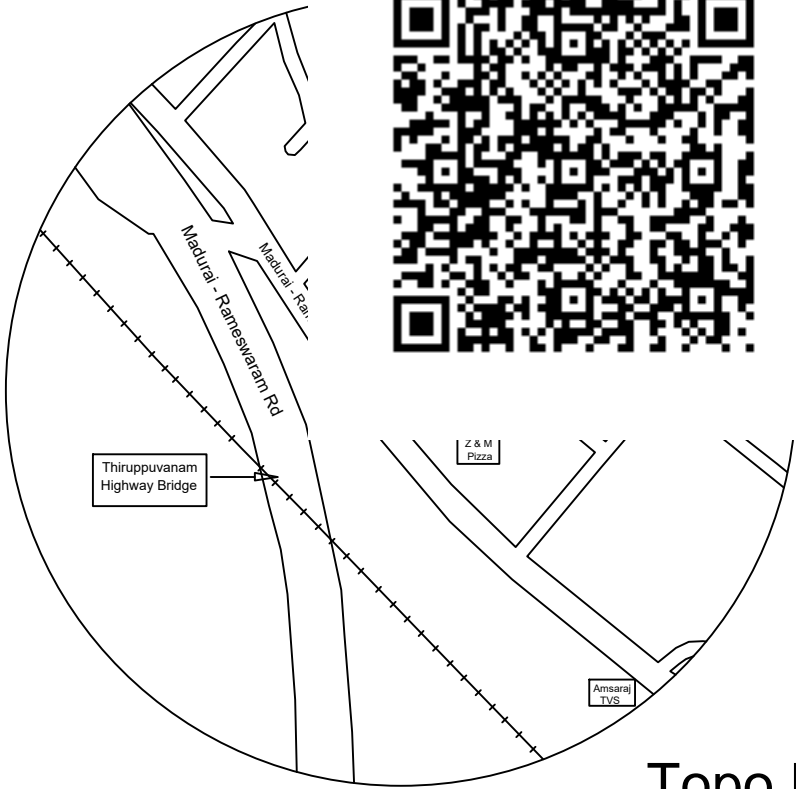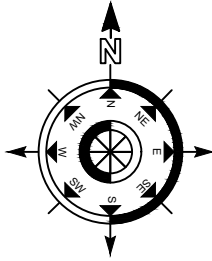

Topo Plan

CASE TYPE	New Proposal
PLOT USE	COMMERCIAL
PLOT SUB USE	COMMERCIAL Dwelling Units
AREA OF THE PLOT	2417.00 Sq Ft
SCHEME / AREA	
LAYOUT APPROVAL NUMBER	4/2017-2018

LEGEND	FEET	METRE
MD/DD DOOR	3'3"X7'0"	1.02X2.13
D DOOR	3'0"X7'0"	0.91X2.13
D1 DOOR	2'6"X7'0"	0.76X2.13
W WINDOW	4'0"X4'6"	1.22X1.37
V VENTILATOR	3'0"X2'6"	0.91X0.76

(Scale 1:100)	AREA DETAILS	
	In Sq.Ft	In Sq.Mt
Total Area (As Per Document)	2417.00	224.54

Ex.Building Approval No:114/2022-2023		
Ex.Ground Floor	810.96	75.34
Pro.First Floor	772.32	71.75
Open Space	1606.04	149.20

APPLICANT


M.S.

Mr.M.SARAVANAVEL.


REGISTERED ENGINEER

S. Senthil


Er.S.SIVAKUMAR.B.E.,
LICENSED CIVIL ENGINEER & BUILDER
Licensed.No:13/2020
ALAMARAM BUS STOP,
MUTHOOT FINANCE SECOND FLOOR,
THIRUPPUVANAM,SIVAGANGAI-630611.
Ph:+91 7904956057.

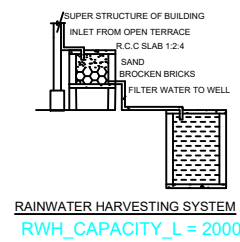


RAINWATER HARVESTING SYSTEM
RWH_CAPACITY_L = 2000

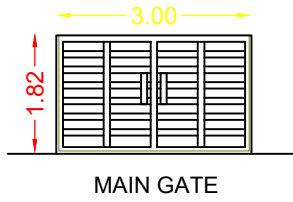


MAIN GATE

 


SECTION OF BORE WELL

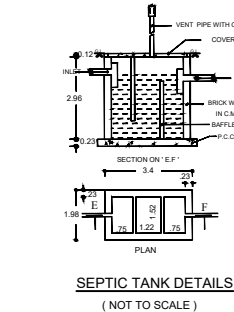


SEPTIC TANK DETAILS
(NOT TO SCALE)

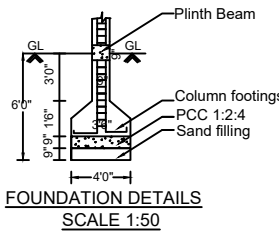


FOUNDATION DETAILS
SCALE 1:50

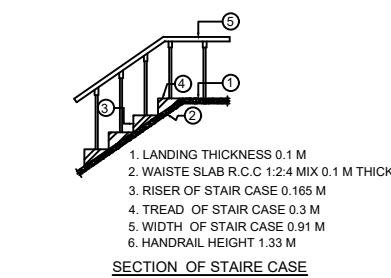


SECTION OF STAIR CASE

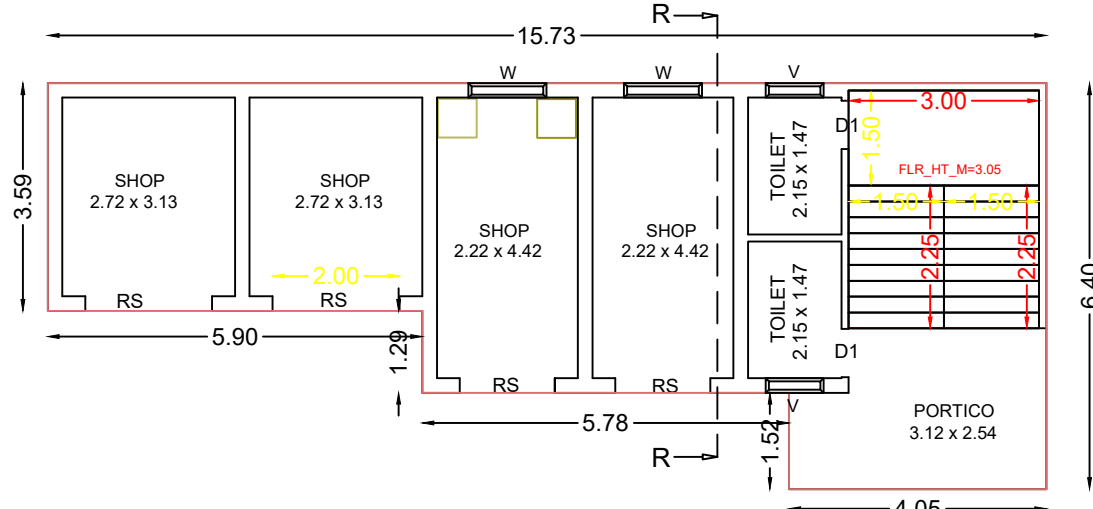

EX.Ground Floor Plan

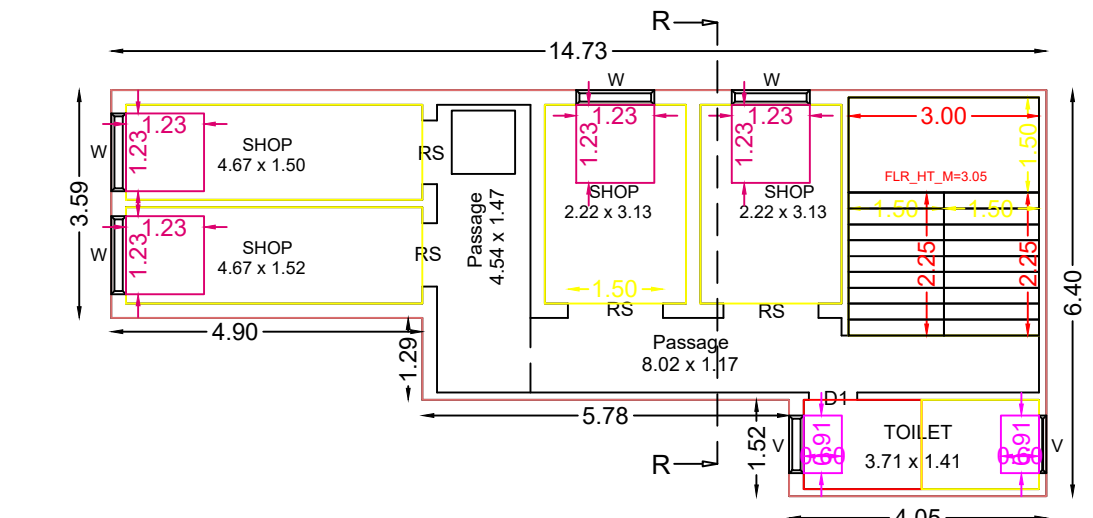

Pro.First Floor Plan

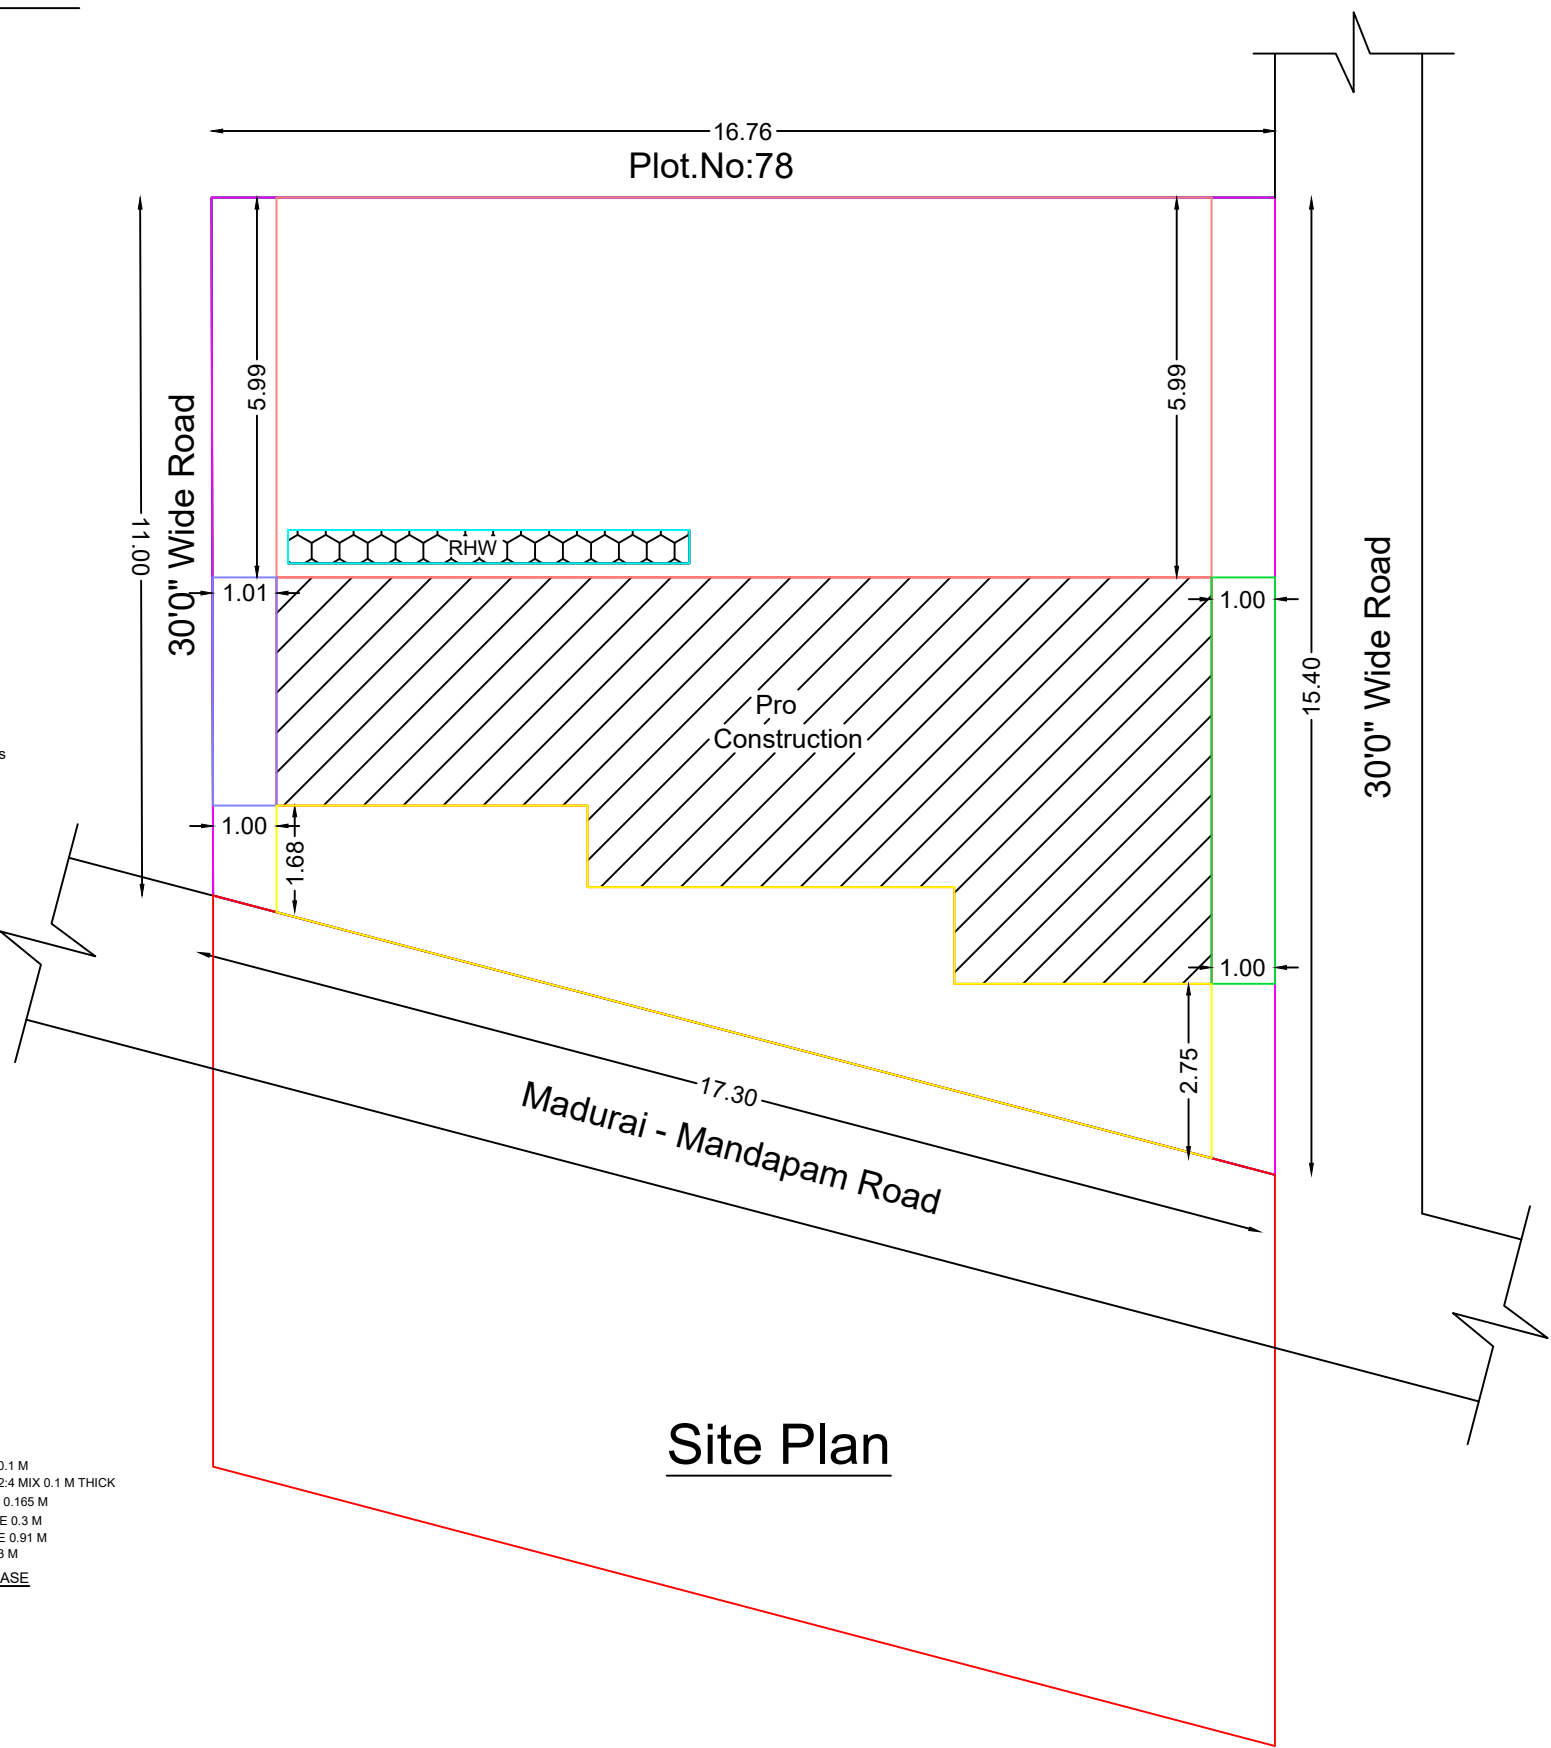

Site Plan