

PLAN SHOWING THE PROPOSED ADDITIONAL CONSTRUCTION OF

HOSTEL BLOCK FOR "ANNASAMY RAJAMMAL COLLEGE OF NURSING" BUILDING

IN DOOR NO :6/373,TAMILUR,S.NO : 369/ 3,4,5,7,8, 9, 370/ 2,3,4A,5A1 & 5A2,

POOLANKULAM VILLAGE & PANCHAYAT , ALANGULAM TALUK ,TENKASI DISTRICT.

Scale 1:100 All Dimensions are in Metre

AREA DETAILS :-	Sq.Mt	Sq.Ft	JOINERY DETAILS
GROUND FLOOR AREA:			MD Main Door 4.21 x 2.10
Building Area In G.F	915.50	9854.00	D Door 1.50 x 2.10
Portico Area In G.F	22.80	246.00	D1 Door 0.91 x 2.10
	938.30	10100.00	D2 Door 0.76 x 2.10
			D3 Door 0.60 x 2.10
FIRST FLOOR AREA:			W4 Window 1.20 x 1.50
Building Area In F.F	915.50	9854.00	V3 Ventilator 0.90 x 0.60
SECOND FLOOR AREA:			V2 Ventilator 0.60 x 0.60
Head Room Area In S.F	58.47	630.00	
Total Building Area In G.F, F.F & H.R	1912.27	20584.00	

Note:

Waste Water Used for Garden
 Rain Water harvesting Details Provided
 Solar System Water tank provided
 Fire Resistance to be provided
 Emergency alarm to be provided
 Drinking water to be provided Panchayat
 Rain water harvesting tank to be provided
 Waste water from recycled water tank & Trench connected to sullage disposal tank
 Solid waste sub to be provided
 1" traps provided in septic tank to prevent curb breeding of mosquitoes (As per G.O (M.S) No : 341 - dated 03.11.2004)
 Head Room - 2.10 m
 Septic Tank and Dispersion Trench
 Entrance Gate 5.0m
 Lightning Arrestor Provided
 Earthquake Resistance Provided
 Exhaust Fan Provided For Lab
 Emergency Stair Provided

M. N. Balakrishnan
 Managing Trustee
 St. Mary's Educational Trust
 Annasamy Rajammal College of Nursing
 Tamilur, Athiyoothu, Andipatti Road
 Alangulam (Tk.), Tirunelveli (Dist).

APPLICANT

N. Balakrishnan
 Er. N. BALAKRISHNAN, OCE, B.E.,
 Registered Construction Engineer
 Reg. No. RCE / TVLR / 11 / 2019
 7714, Shanmughi Nagar,
 Gopasamuthiram Road, TVL - 627 604.
 Cell No: 91221 55332
 Email ID: balakrishnan@gmail.com

CONSTRUCTION ENGINEER


OFFICE USE

K. P. Mahalakshmi
 Er. K. P. MAHALAKSHMI, B.E.,
 REGISTERED ENGINEER GRADE-I
 REG NO: RE/GR-I/TVLMARCH/2019/001
 0722, VETHAKOVIL STREET, THENKALAM
 TRINELVELI - 627 357.


STRUCTURAL ENGINEER

REGISTERED ENGINEER


(Almighty Planners & Consultants)

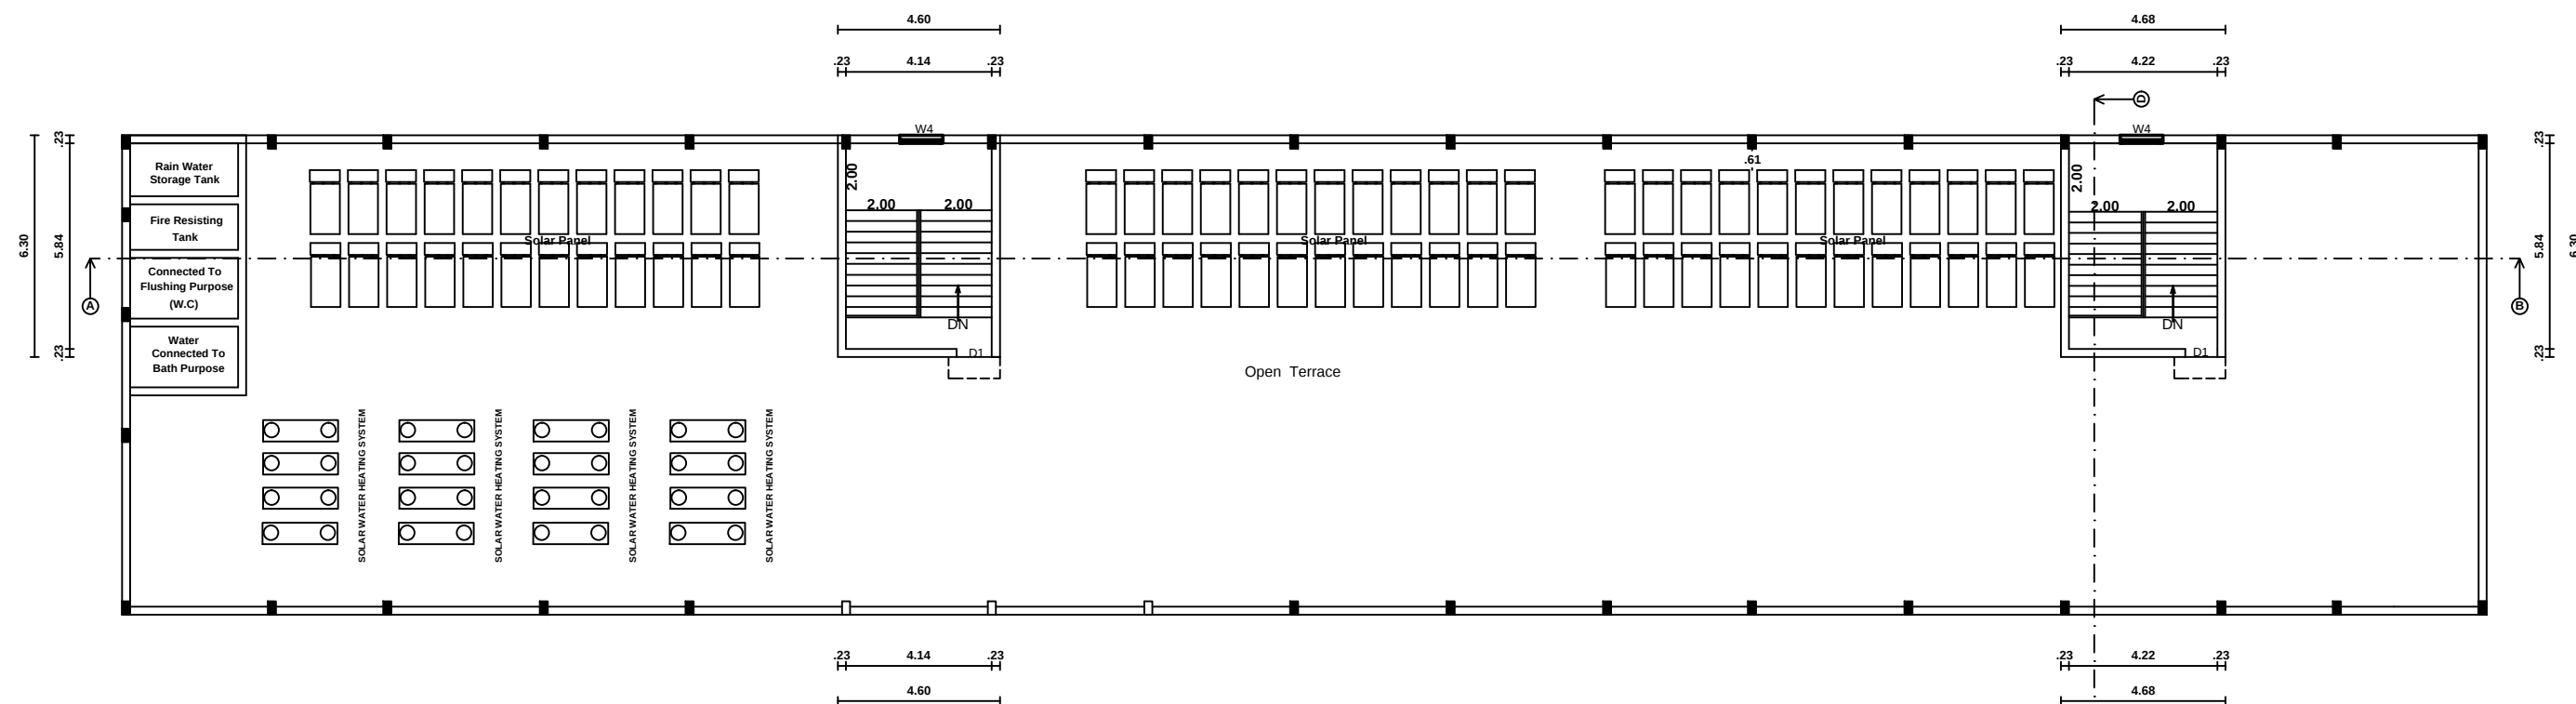

Terrace Floor Plan

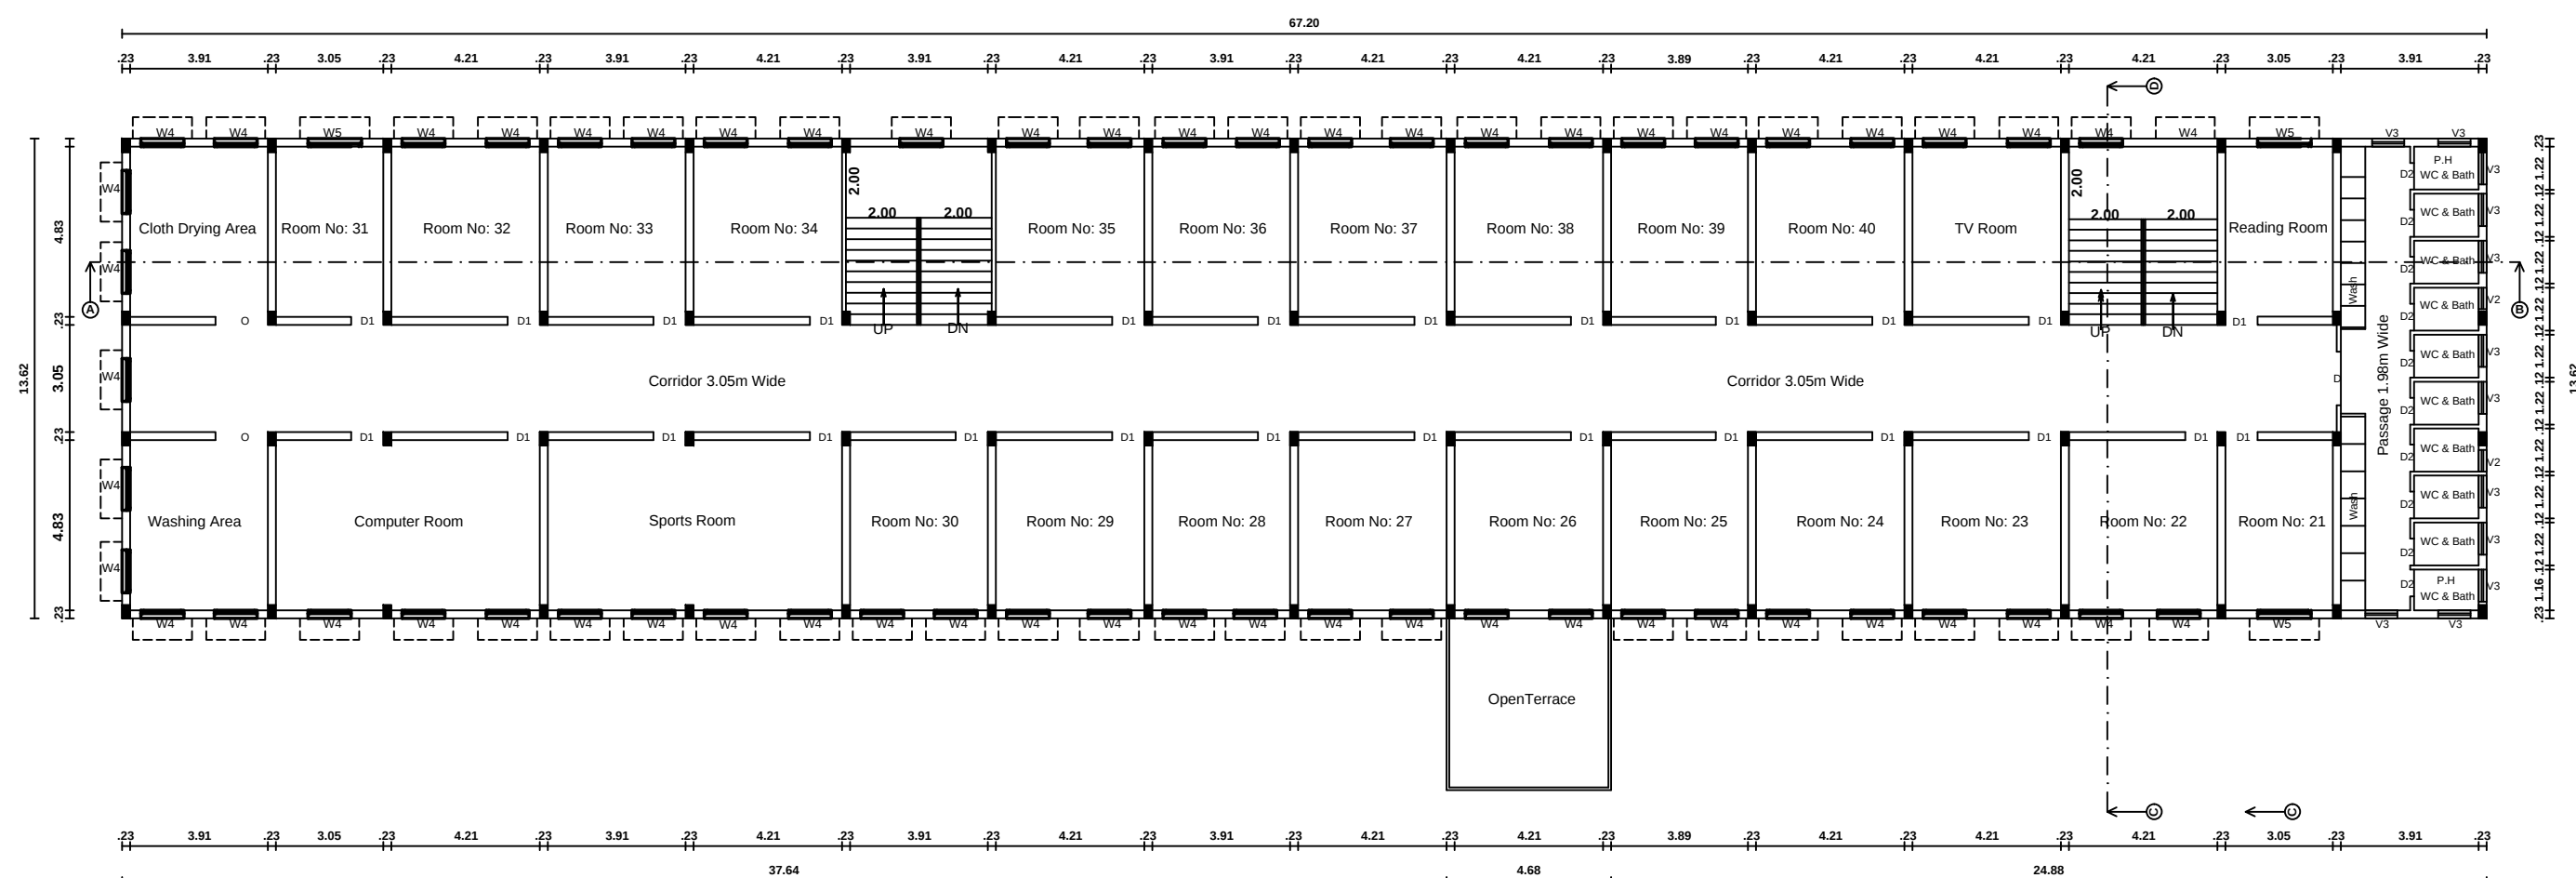


First Floor Plan

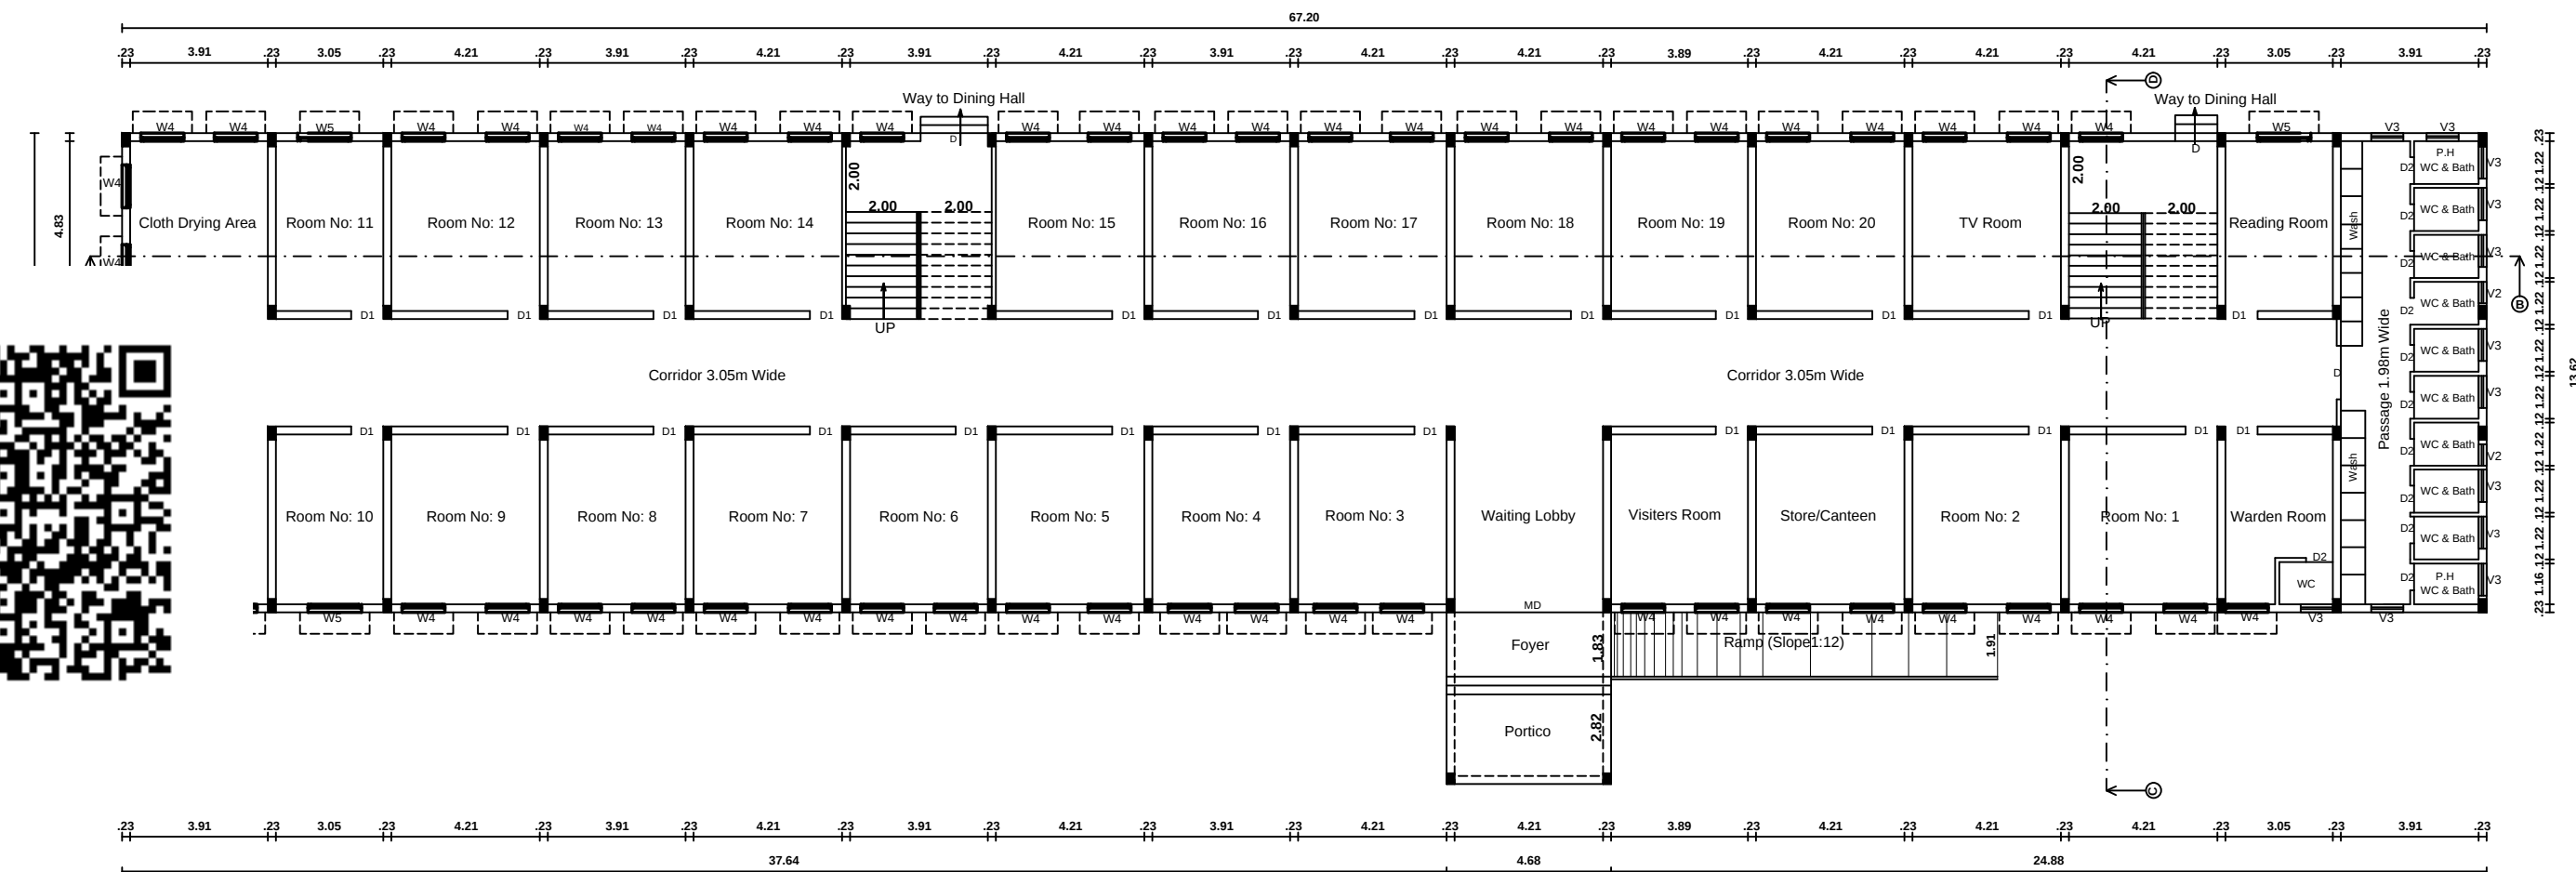



Ground Floor Plan



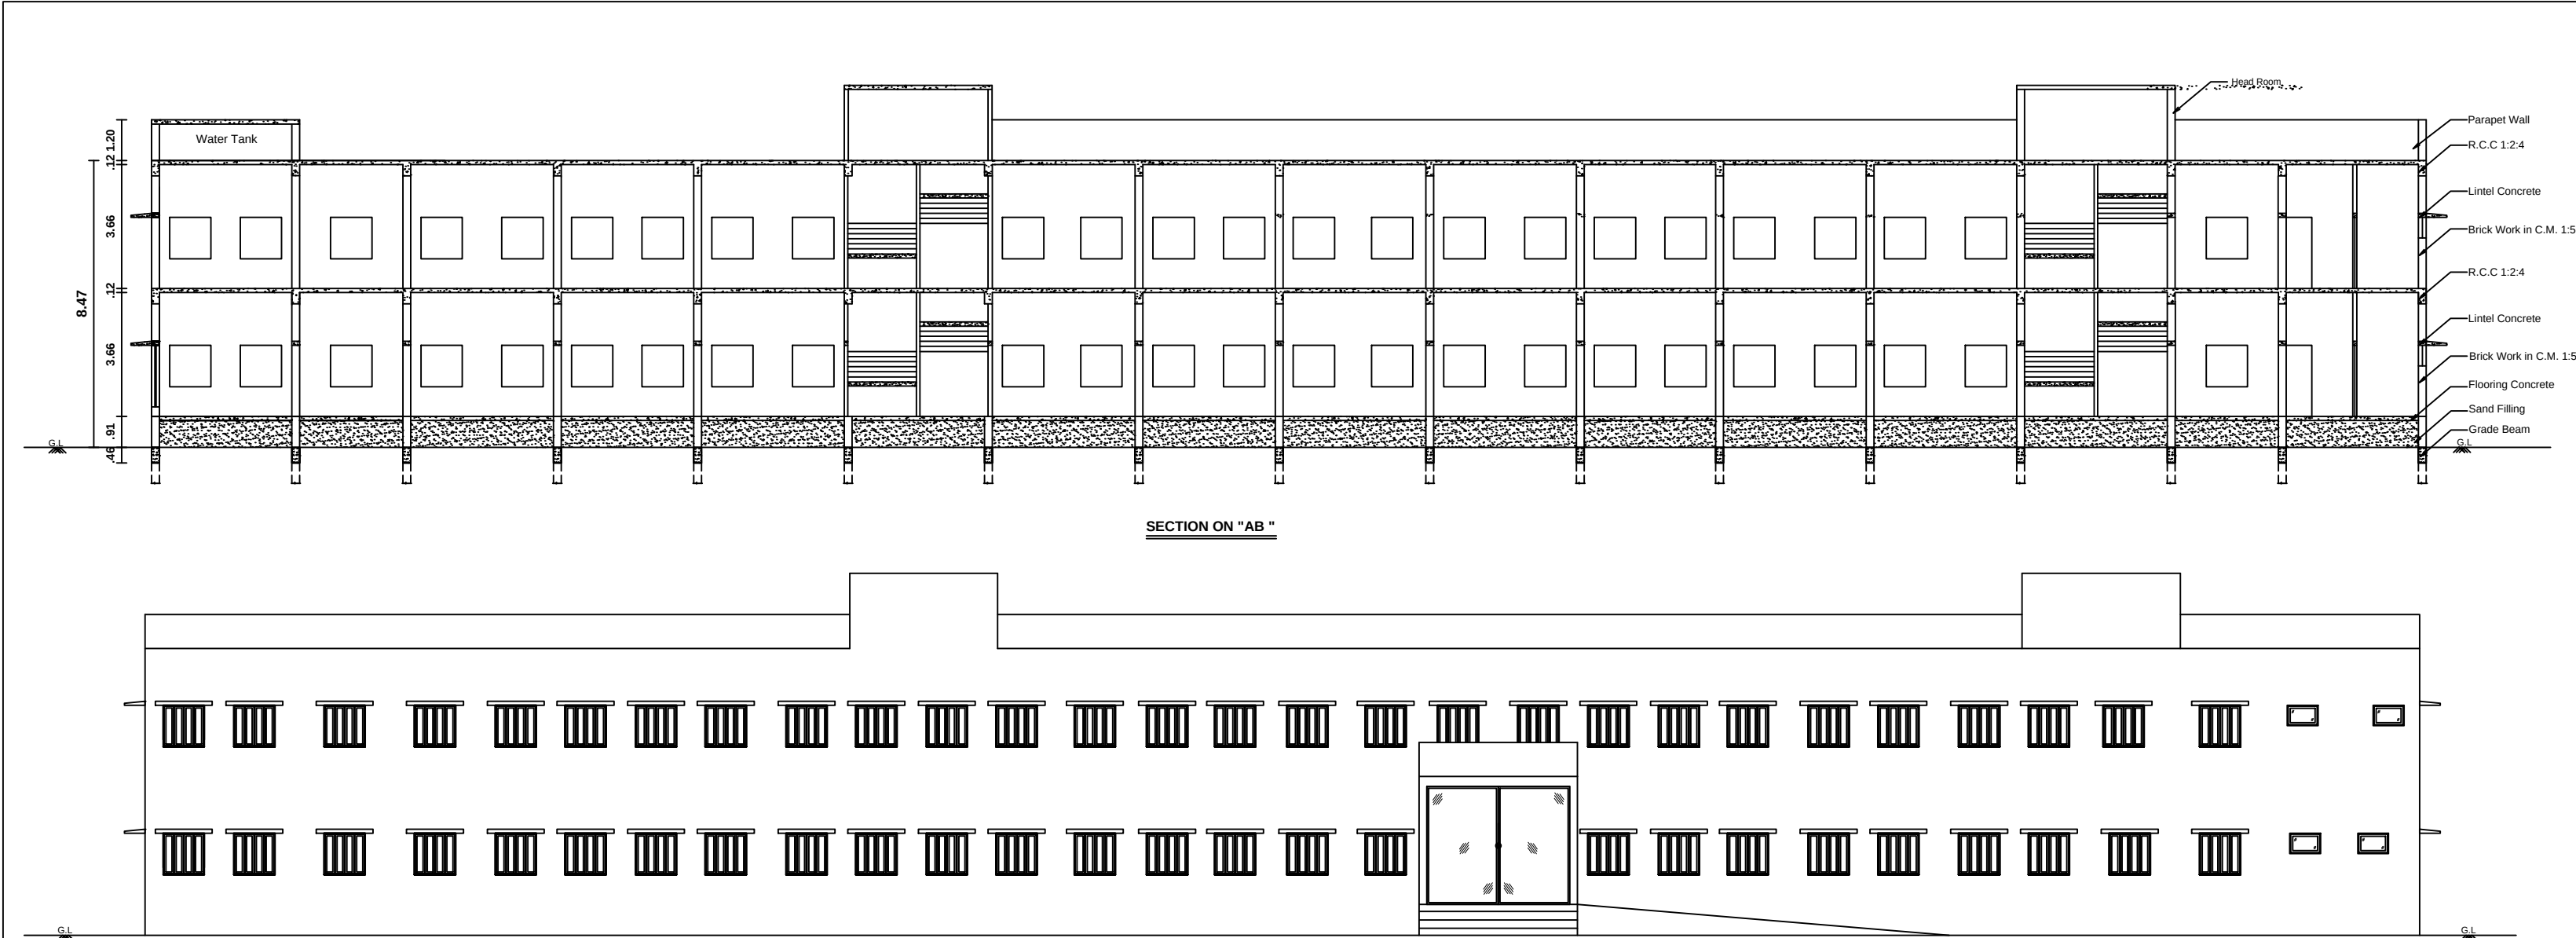


SECTION ON "AB "

ELEVATION

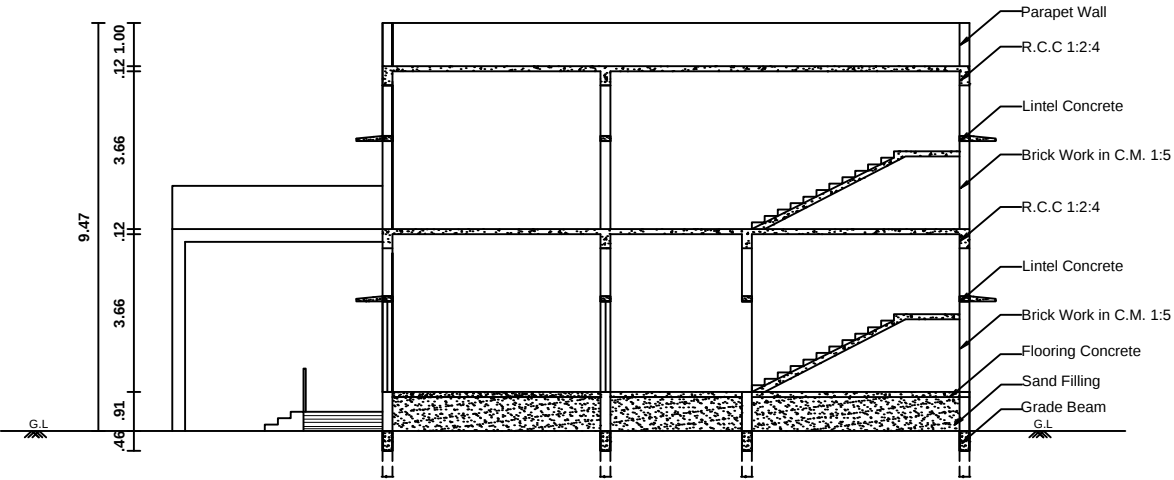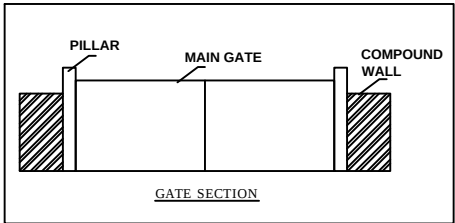

SECTION ON "CD "

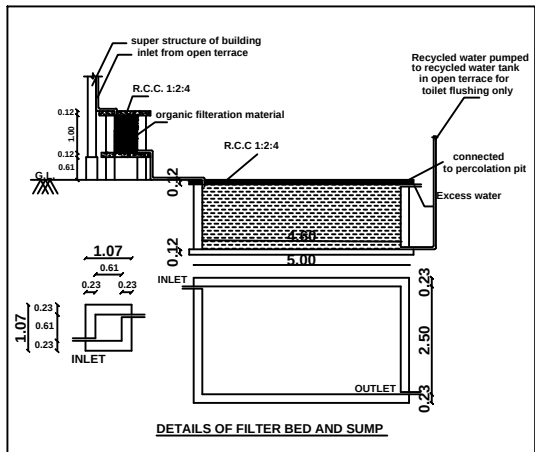

SHEET NO: 3																									
PLAN SHOWING THE PROPOSED ADDITIONAL CONSTRUCTION OF																									
HOSTEL BLOCK FOR " ANNASAMY RAJAMMAL COLLEGE OF NURSING"BUILDING																									
IN DOOR NO: 6/373, TAMILUR, S.NO : 369/ 3,4,5,7,8, 9, 370/ 2, 3, 4A, 5A1 & 5A2,																									
POOLANKULAM VILLAGE & PANCHAYAT , ALANGULAM TALUK ,TENKASI DISTRICT.																									
Scale 1:100 All Dimensions are in Metre																									
Note: Waste Water Used for Garden Rain Water harvesting Details Provided Solar System Water tank provided Fire Resistance to be provided Emergency alarm to be provided Drinking water to be provided Panchayat Rain water harvesting tank to be provided Waste water from recycled water tank & Trench connected to sullage disposal tank Solid waste tub to be Provided 'U' traps provided in septic tank to prevent curb breeding of mosquitoes (As per G.O (M.S) No : 341 - dated 03.11.2004) Head Room - 2.10 m Septic Tank and Dispersion Trench Entrance Gate 5.0m Lightning Arrestor Provided Earthquake Resistance Provided Exhaust Fan Provided For Lab Emergency Stair Provided	JOINERY DETAILS																								
	<table><tr><td>MD</td><td>Main Door</td><td>4.21 x 2.10</td></tr><tr><td>D</td><td>Door</td><td>2.00 x 2.10</td></tr><tr><td>D1</td><td>Door</td><td>0.91 x 2.10</td></tr><tr><td>D2</td><td>Door</td><td>0.76 x 2.10</td></tr><tr><td>D3</td><td>Door</td><td>0.60 x 2.10</td></tr><tr><td>W4</td><td>Window</td><td>1.20 x 1.50</td></tr><tr><td>V3</td><td>Ventilator</td><td>0.90 x 0.60</td></tr><tr><td>V2</td><td>Ventilator</td><td>0.60 x 0.60</td></tr></table>	MD	Main Door	4.21 x 2.10	D	Door	2.00 x 2.10	D1	Door	0.91 x 2.10	D2	Door	0.76 x 2.10	D3	Door	0.60 x 2.10	W4	Window	1.20 x 1.50	V3	Ventilator	0.90 x 0.60	V2	Ventilator	0.60 x 0.60
MD	Main Door	4.21 x 2.10																							
D	Door	2.00 x 2.10																							
D1	Door	0.91 x 2.10																							
D2	Door	0.76 x 2.10																							
D3	Door	0.60 x 2.10																							
W4	Window	1.20 x 1.50																							
V3	Ventilator	0.90 x 0.60																							
V2	Ventilator	0.60 x 0.60																							
APPLICANT <i>[Signature]</i> Managing Trustee St. Mary Angel Educational Trust Annasamy Rajammal College of Nursing Tamilur, Althuvoothu, Andipatti Road Alangulam (Tk.), Tirunelveli (Dist).																									
CONSTRUCTION ENGINEER <i>[Signature]</i> Er. N. BALAMURUGAN, B.E., Registered Construction Engineer Reg. No. RCE/TVLR/11/2019 7/14, Shanmathi Nagar, Gopalamubram Road, U.L. 627 604. Cell No. 97721 25512 Email ID: balamurugan@gmail.com		OFFICE USE																							
STRUCTURAL ENGINEER <i>[Signature]</i> BK DESIGN PVT LTD. Er. C. BALAKRISHNAN MEGESTRUC Registered Structural Engineer Reg. No. RSE/GR/UT/1/14March/2019/003 Chartered Structural Engineer Reg. No. CE/SE/141 District Panel Engineer, Coimbatore-1A R.C.C. No. 11710222 No. 6, USA Complex, Opp. Mohanram Temple, South Base, Palayamkottai. Mob. 9787006776		REGISTERED ENGINEER (Almighty Planners & Consultants) <i>[Signature]</i> Er. K.P. MAHALAKSHMI, B.E., REGISTERED ENGINEER GRADE-I REG NO: RE/GR-1/TVLMARCH/2019/001 10/22 VETHAKOVL STREET, THENKALAM TIRUNELVELI - 627 357.																							

PLAN SHOWING THE PROPOSED ADDITIONAL CONSTRUCTION OF

STAFF ROOM FOR " ANNASAMY RAJAMMAL COLLEGE OF NURSING" BUILDING

IN DOOR NO : 6/373, TAMILUR, S.NO : 369/ 3,4,5,7,8, 9, 370/ 2,3,4A,5A1 & 5A2,

POOLANKULAM VILLAGE&PANCHAYAT,ALANGULAM TALUK,TENKASI DISTRICT.

Scale 1:100 All Dimensions are in Metre

Note:-

- Waste Water Used for Garden
- Rain Water harvesting Details Provided
- Solar System Water tank provided
- Fire Resistance to be provided
- Emergency alarm to be provided
- Drinking water to be provided Panchayat
- Rain water harvesting tank to be provided
- Waste water from recycled water tank & Trench connected to sullage disposal tank
- Solid waste tub to be Provided
- 'U' traps provided in septic tank to prevent curb breeding of mosquitoes (As per G.O (M.S) No : 341 - dated 03.11.2004)
- Head Room - 2.10 m
- Septic Tank and Dispersion Trench
- Entrance Gate 5.0m
- Lightning Arrestor Provided
- Earthquake Resistance Provided
- Exhaust Fan Provided For Lab
- Emergency Stair Provided

AREA DETAILS:-

		Sq.Mt	Sq.Ft
☐	Building Area In G.F	187.78	2021.00
☐	Building Area In F.F	187.78	2021.00
☐	Total Building Area In G.F ,& F.F	375.56	4042.00

JOINERY DETAILS

D	Door	1.20 x 2.10
D2	Door	0.76 x 2.10
W4	Window	1.22 x 1.22
V3	Ventilator	0.61 x 0.91

Mansingh Trustee
St. Mary's Educational Trust
Annasamy Rajammal College of Nursing
Tamilur, Athiyoothu, Andipatti Road
Alangulam (Tk.), Tirunelveli (Dist).

APPLICANT

Er. N. BALAMURUGAN, OCE, B.E.,
Registered Construction Engineer
Reg. No. RCE/TN/11/2019
7/14, Shanmathi Nagar,
Gopalanmuthur Road, TVL-627 694.
Cell No. 81221 65332
Email ID: balamurugan@gmail.com

CONSTRUCTION ENGINEER


OFFICE USE

BK DESIGN PVT. LTD.
REGISTERED STRUCTURAL FIRM
ER. C. BALAKRISHNAN, M.E.(Struc)
Registered Structural Engineer
Reg. No. RSE/STRUCT/11/March/2019/0003
Chartered Structural Engineer
Reg. No. CE/ISE/M261
District Panel Engineer, Class-1A
R.O.C. No. 1/1/1/2022
No. 8, USA Complex, Opp. Murugan Temple,
South Bazar, Palayamkottai. Mob. 9787008789


STRUCTURAL ENGINEER

Er. K.P. MAHALAKSHMI, B.E.,
REGISTERED ENGINEER GRADE-I
REG.NO: RE/GR-I/TVL/MARCH/2019/001
10/22, VETHAKOVEL STREET, THENKALAM
TIRUNELVELI - 627 357.


REGISTERED ENGINEER
(Almighty Planners & Consultants)

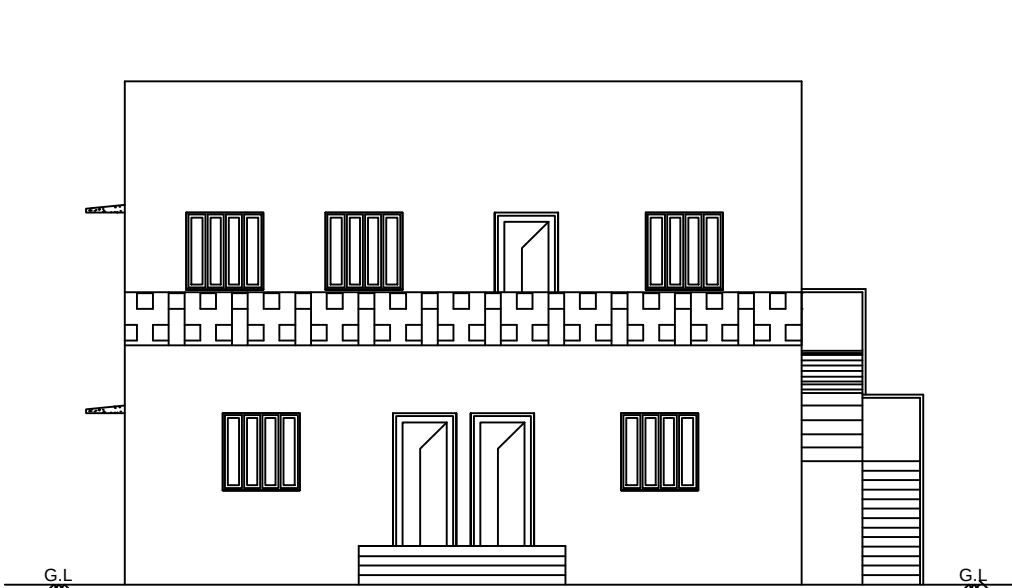


ELEVATION

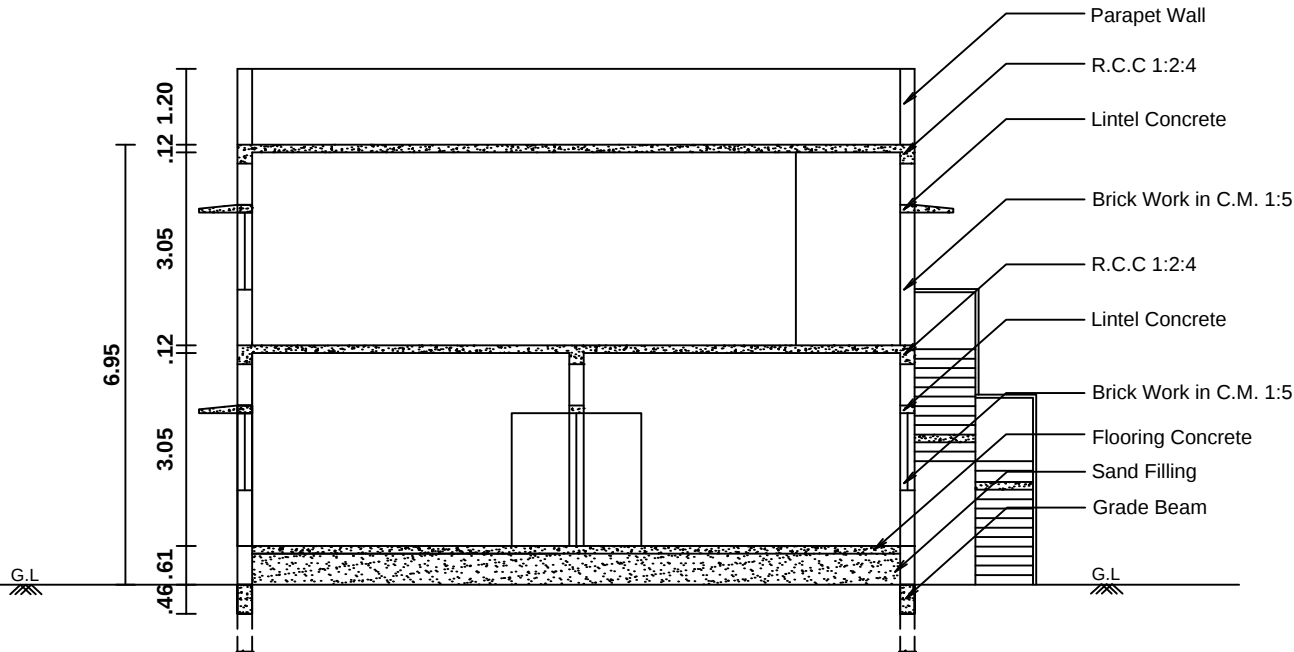

SECTION "AB"

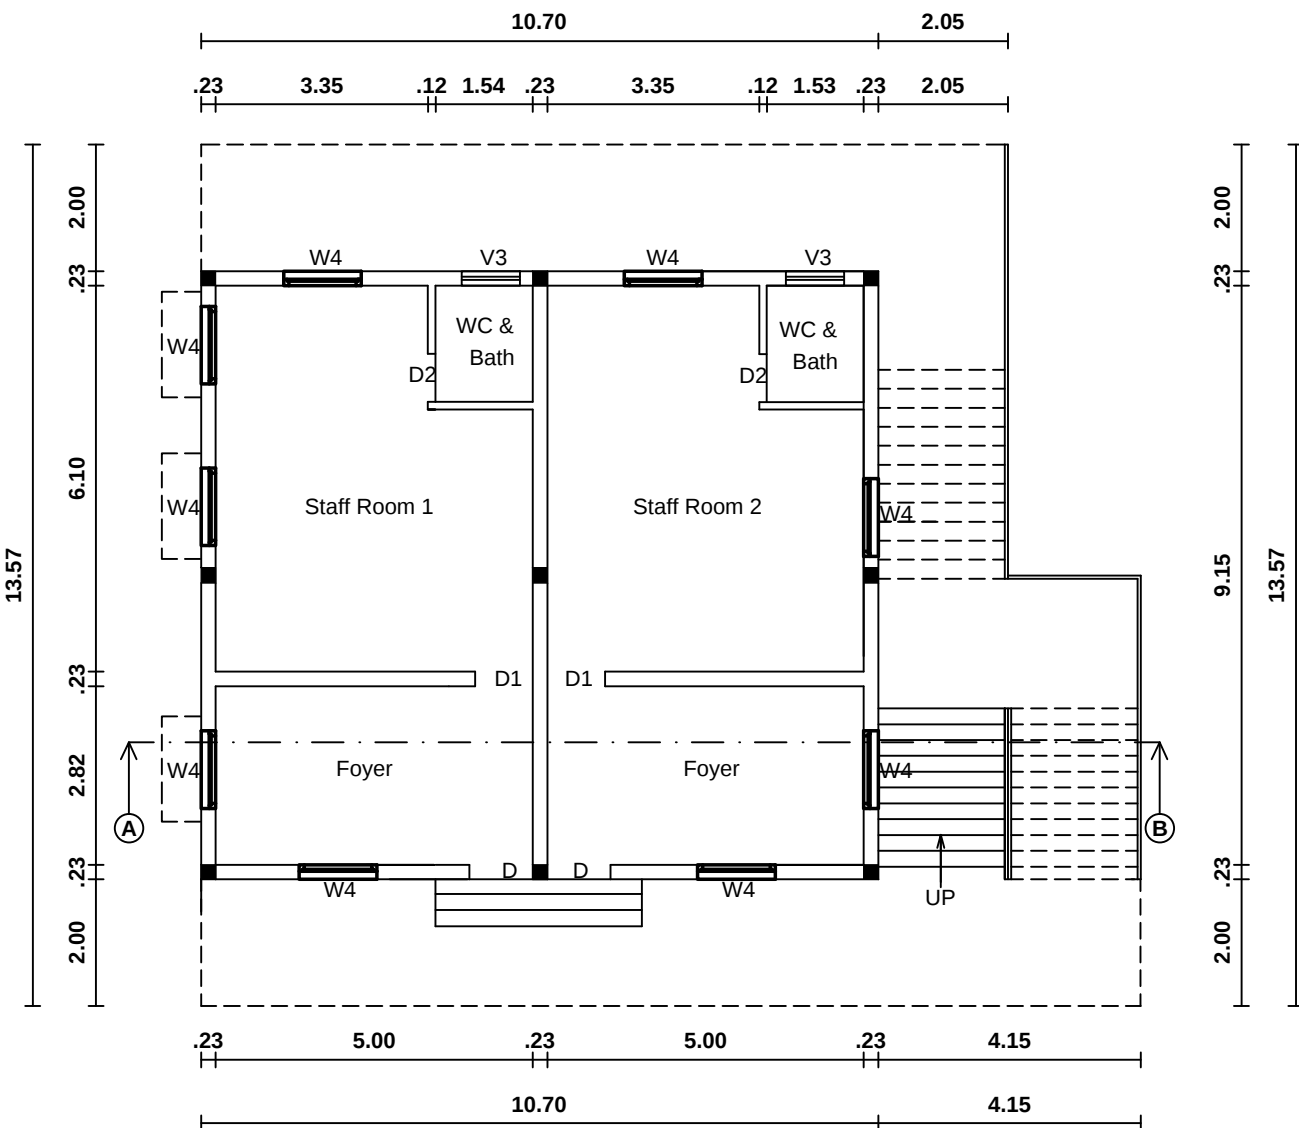

Ground Floor Plan

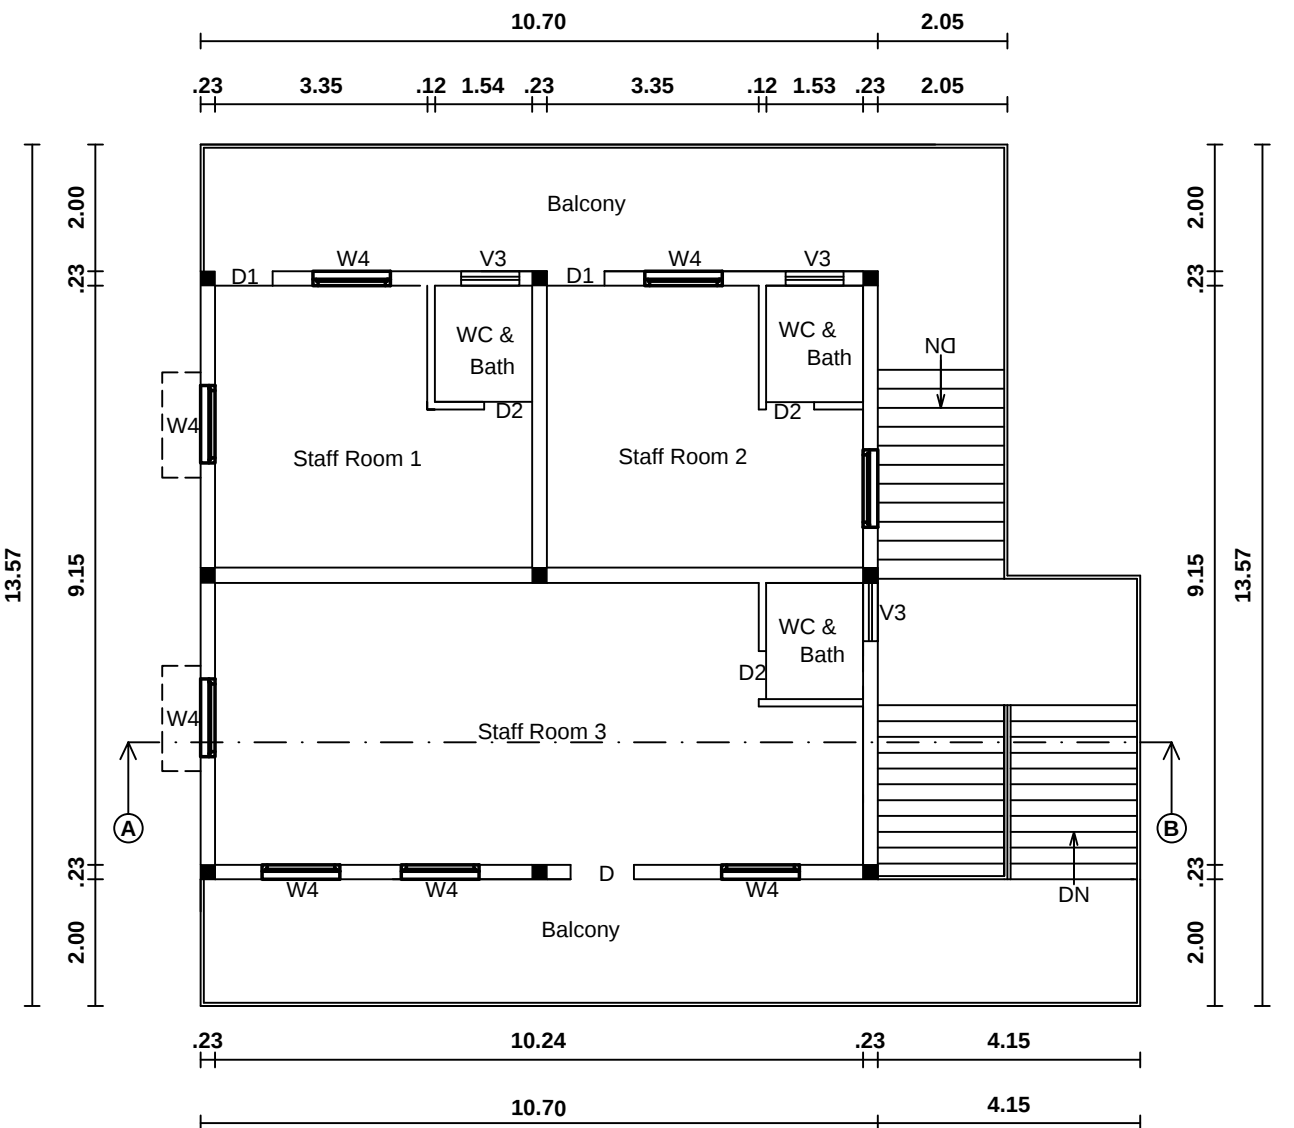

First Floor Plan


PLAN SHOWING THE PROPOSED ADDITIONAL CONSTRUCTION OF

KITCHEN BLOCK FOR " ANNASAMY RAJAMMAL COLLEGE OF NURSING" BUILDING


IN DOOR NO:6/373,TAMILUR, S.NO : 369/ 3, 4, 5, 7, 8, 9, 370/ 2, 3, 4A, 5A1 & 5A2,

POOLANKULAM VILLAGE & PANCHAYAT , ALANGULAM TALUK ,TENKASI DISTRICT.


Scale 1:100 All Dimensions are in Metre

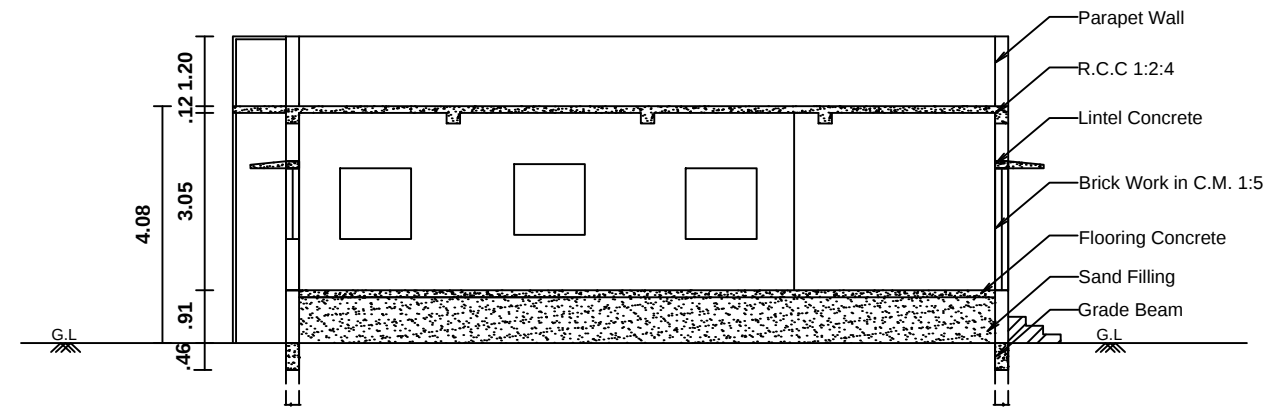

SECTION "AB"

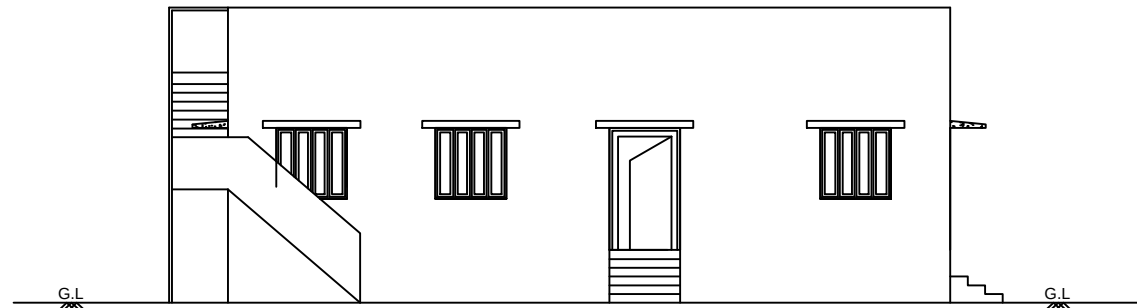

ELEVATION

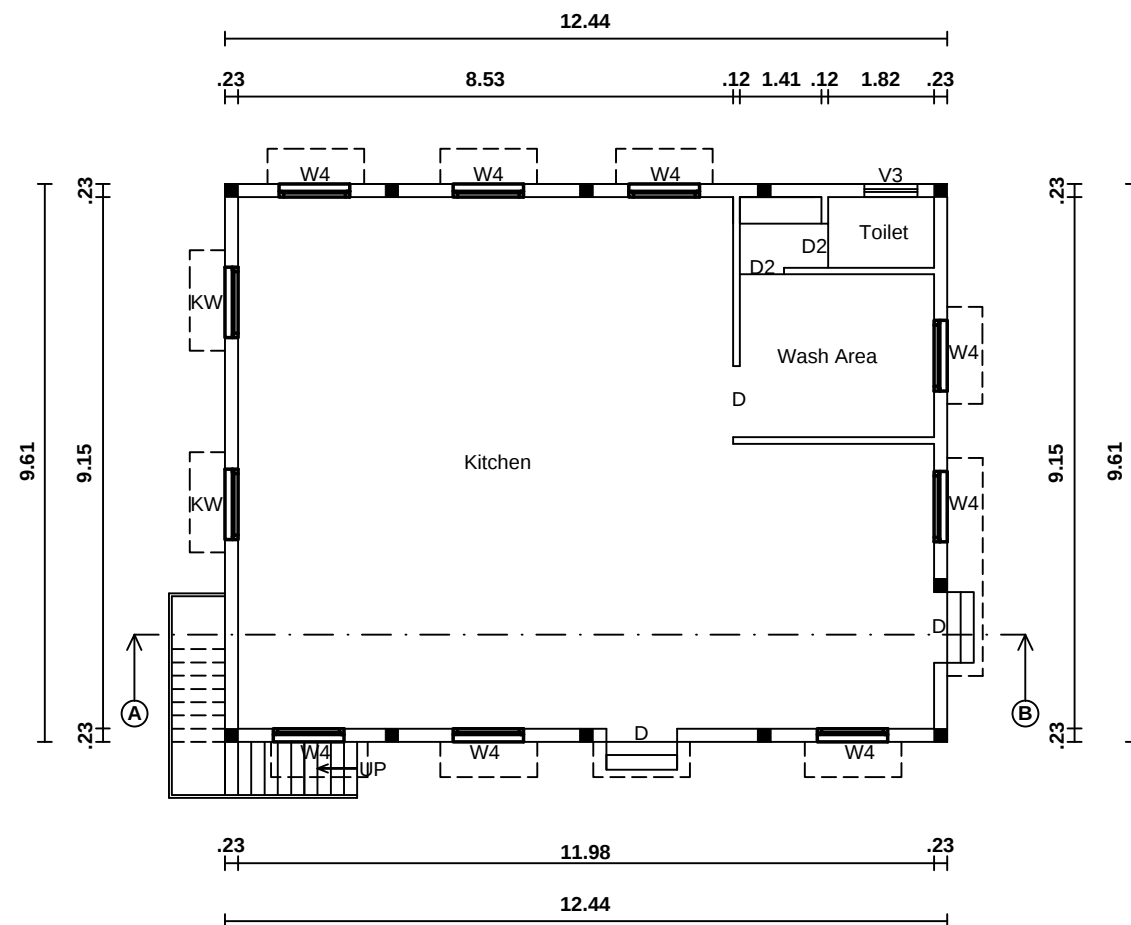

Ground Floor Plan

AREA DETAILS:-

	Sq.Mt	Sq.Ft
Building Area In G.F	125.10	1347.00

JOINERY DETAILS

D	Door	1.20 x 2.10
D2	Door	0.76 x 2.10
W4	Window	1.22 x 1.22
V3	Ventilator	0.61 x 0.91

Note:

Waste Water Used for Garden
 Rain Water harvesting Details Provided
 Solar System Water tank provided
 Fire Resistance to be provided
 Emergency alarm to be provided
 Drinking water to be provided Panchayat
 Rain water harvesting tank to be provided
 Waste water from recycled water tank & Trench connected to
 sullage disposal tank
 Solid waste tub to be Provided
 'U' traps provided in septic tank to prevent curb breeding of
 mosquitoes (As per G.O (M.S) No : 341 - dated 03.11.2004)
 Head Room - 2.10 m
 Septic Tank and Dispersion Trench
 Entrance Gate 5.0m
 Lightning Arrestor Provided
 Earthquake Resistance Provided
 Exhaust Fan Provided For Lab
 Emergency Stair Provided

Managing Trustee
 St. Mary Ange/Educational Trust
 Annasamy Rajammal College of Nursing
 Tamilur, Athiyoothu, Andipatti Road
 Alangulam (Tk.), Tirunelveli (Dist).

APPLICANT

Er. N. BALAMURUGAN, DCE., B.E.,
 Registered Construction Engineer
 Reg. No. RCE / TVLR / 11 / 2019
 7/14, Shanmathi Nagar,
 Gopalasamuthiram Road, TVL - 627 604.
 Cell No: 81221 55332
 Email ID: balamuruga@gmail.com

CONSTRUCTION ENGINEER

OFFICE USE

BK DESIGN PVT LTD.
 STRUCTURAL FIRM
 Er. C. BALAKRISHNAN ME(Struct)
 Registered Structural Engineer
 Reg. No. RSE/GR-ITV/UMarch/2019/003
 Chartered Structural Engineer
 Reg. No. CE/ISE/IM/261
 District Panel Engineer, Class-1A
 R.O.C. No. 1/171/2022
 No. 5, USA Complex, Opp. Mutharamman Temple,
 South Bazar, Palayamkottai. Mob. 9787008789

STRUCTURAL ENGINEER

Er. K.P. MAHALAKSHMI, B.E.,
 REGISTERED ENGINEER GRADE-I
 REG.NO: RE/GR-I/TVL/MARCH/2019/001
 0/22, VETHAKOVI STREET, THENKALAM
 TIRUNELVELI - 627 357.

REGISTERED ENGINEER
(Almighty Planners & Consultants)

REGISTERED ENGINEER
(Almighty Planners & Consultants)