



PLAN SHOWING THE PROPOSED CONSTRUCTION OF G I SHEET ROOF GROUND & MEZZANINE FLOOR INDUSTRIAL BUILDING AND PARTLY RCC ROOF BUILDING IN R.S.NO:79/2 (PART), PLOT NO: DP-85, WITH INSTALLATION - 313 H.P. AT (SIDCO INDUSRIAL ESTATE, APPROVED IN DTCP. NO: 24/2018) THIRUBUVANAM VILLAGE, THIRUBUVANAM TOWN PANCHAYAT, THIRUVIDAIMARUTHUR TALUK AND THANJAVUR DISTRICT.

OWNER : ELANCHAZIYAN S/O SWAMINATHAN SCALE 1CM = 1M.

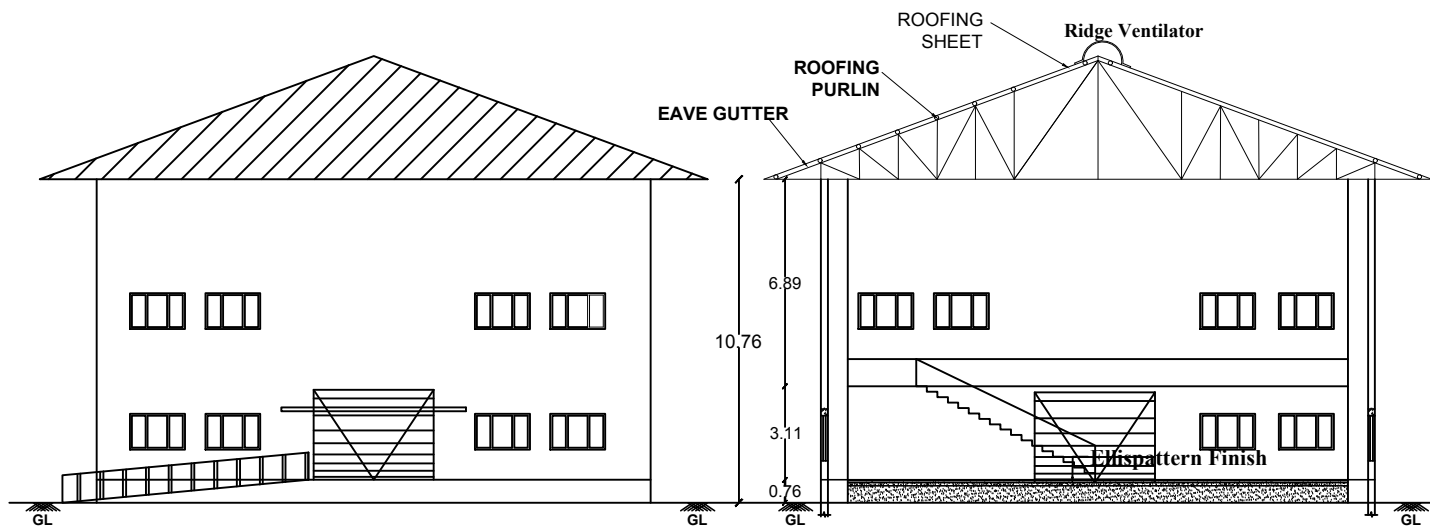


FRONT ELEVATION

SECTION ON 'AB'

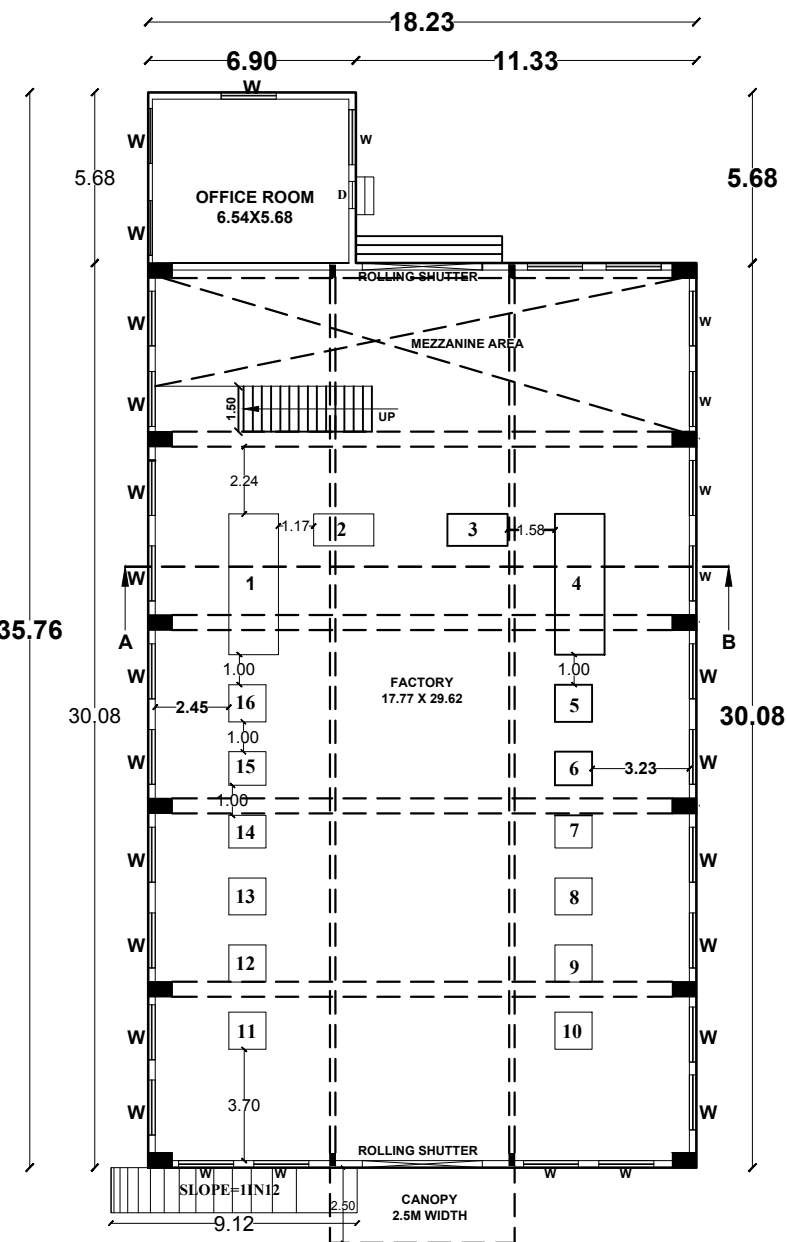

GROUND FLOOR PLAN

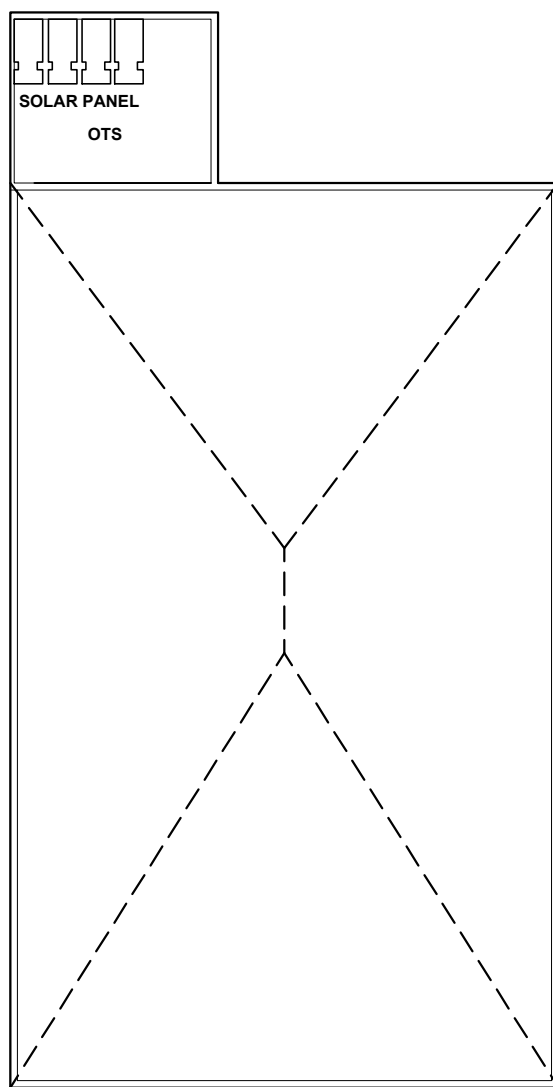

TERRACE FLOOR PLAN


COLOUR INDEX		SCHEDULE OF JOINERIES	
SITE BOUNDARY	—	RS ROLLING SHUTTER	2.44 X 2.13
EXG. ROAD	—	D DOOR	0.91 X 2.13
PRO. BUILDING	—	D1 DOOR	0.76 X 2.13
RAIN WATER HARVESTING	—	W WINDOW	1.50 X 1.37
DRIVE WAY	—	V VENTILATOR	0.61 X 0.91

AREA CHART
Area of the plot — 1144.83 Sq.m (12322.91Sq.ft)

FLOORWISE BREAKUP

Floor Name	Total Builtup Area	Non FSI Area		Commercial / Public
		Covered Parking	Deduction	
Floor-Ground RCC Roof	39.22	—	—	39.22
Floor-Ground Factory GI sheet	548.31	—	—	548.31
Mezzanine Floor	87.91	—	—	87.91
Toilet Block	12.15	—	—	12.15
Total	687.59	—	—	687.59

Vacant Area — 545.15 Sq.m (5865.81 Sq.ft)

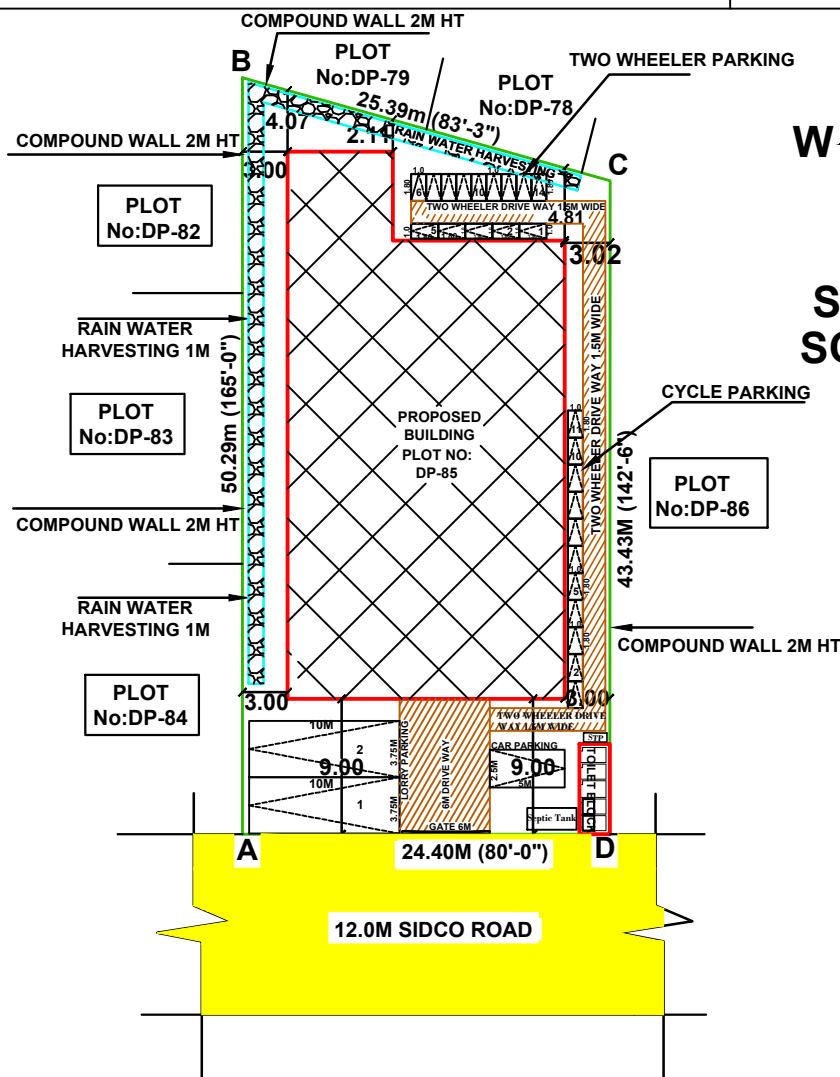


N
W
S
E
SITE PLAN
SCALE 1:200

MACHINERIES DETAILS

S. NO	DESCRIPTIONS	NOS	H.P	H.P
1	Laser cutting Machine	1	67.00	67.00
2	Folding Machine	1	18.50	18.50
3	Folding Machine	1	13.50	13.50
4	Laser Cutting Machine	1	82.00	82.00
5-16	Mig Welding Machine	12	11.00	132.00
TOTAL H.P.S				313.00


NO of Labours = 5 persons

SCALE 1:100

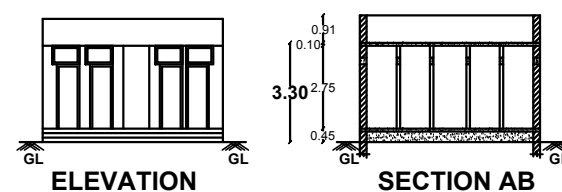


ELEVATION

SECTION AB

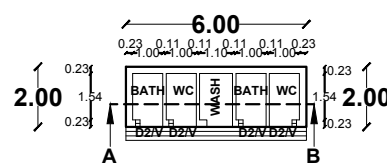

GROUND FLOOR PLAN

TOILET BLOCK

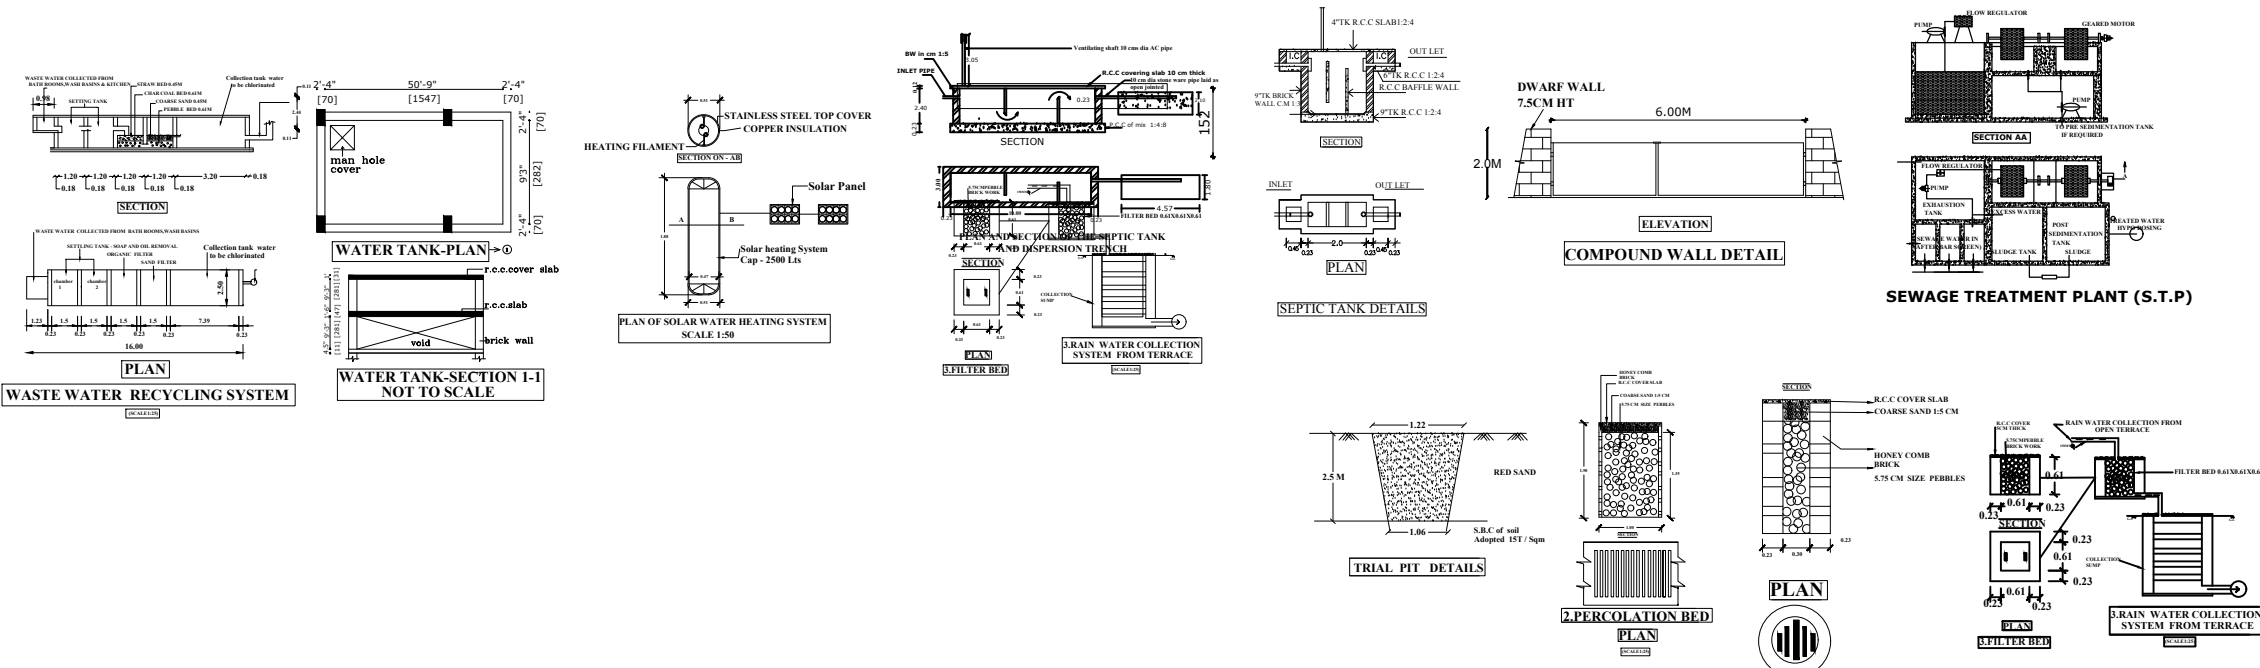

BUILDING APPROVAL NO : SWP / DTCP / TNJ / R / BP NO : 19 / 2024

ASSISTANT DIRECTOR / DEPUTY DIRECTOR

THANJAVUR DISTRICT TOWN AND COUNTRY PLANNING

APPROVAL AUTHORITY



SHEET - 1 / 1

Note :-

Plan, Section, Elevation - Scale - 1:100

All measurements are in Metres

Certified that the Rain Water Harvesting System shall be Provided as per the norms and condition laid down in

The G.O. No:18 Municipal Administration and Water Supply Department dated 04/02/2019.

Solar water heater system will be provided Rain Water is connected to rain water pit

All sewage line to be connected to ugss 'U' Trap will be provided in all the outlets

FIRE EXTINGUISHER —

FIRE ALARMS ARE TO BE PROVIDED —

FIRE SPRINKLER SYSTEM TO BE PROVIDED —

LIGHTNING CONDUCTORS ARE TO BE PROVIDED —

REVERSE OSMOSIS WATER POINT —

FLOOR SPACE INDEX (F.S.I) = 0.60

PLOT COVERAGE (PC) = 52.38 %

PARKING DETAILS

Number of Car Parking (Required) = 0 Nos

Number of Car Parking (Provided) = 1 No

Number of Two Wheeler Parking (Required) = 11 Nos


Number of Two Wheeler Parking (Provided) = 14 Nos


Number of Cycle Parking (Required) = 11 Nos


Number of Cycle Parking (Provided) = 11 Nos


Number of Lorry Parking (Required) = 2 Nos

Number of Lorry Parking (Provided) = 2 Nos

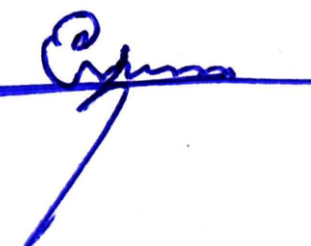
S. ELANCHAZIYAN
APPLICANT

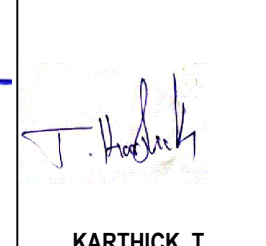
KARTHICK. T
REG.No: CA/2017/88512
ARCHITECT

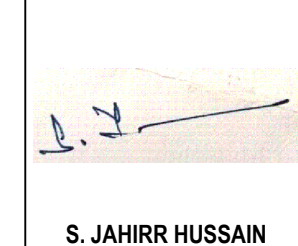
S. JAHIRR HUSSAIN
REG.NO: TJR/RCE/2020/002
CONSTRUCTION ENGINEER

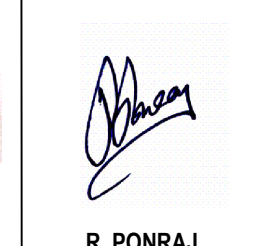
R. PONRAJ
REG. NO: 001-RSE-GR II
STRUCTURAL ENGINEER

APPROVAL AUTHORITY LOCAL BODY
THIRUBUVANAM TOWN PANCHAYAT OFFICE