


PLAN SHOWING THE PROPOSED ADDITIONAL CONSTRUCTION IN THE EXISTING DECORTICATING DRY DHALL INDUSTRIAL (GREEN CATEGORY) BUILDING USING 20.00 HP ELECTRICAL POWER IN DOOR NO. 4/54, SURVEY NO. 293/1 & 294/1A, PUTHIYAMPUTHUR ROAD (MELATTHERU), SILLANATTHAM VILLAGE, OTTAPIDARAM TALUK, THOOTHUKUDI DISTRICT.

APPLICANT NAME: M/s. SIGARAM COLD STORAGE LLP

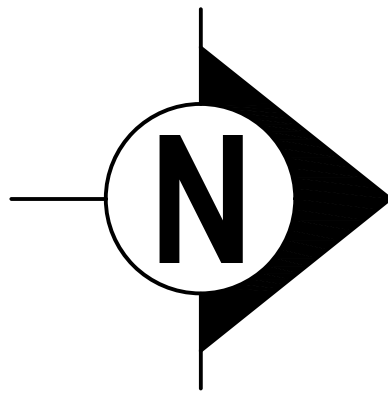


SHEET NO.

1/8

SCALE: 1:100

OFFICE USE:

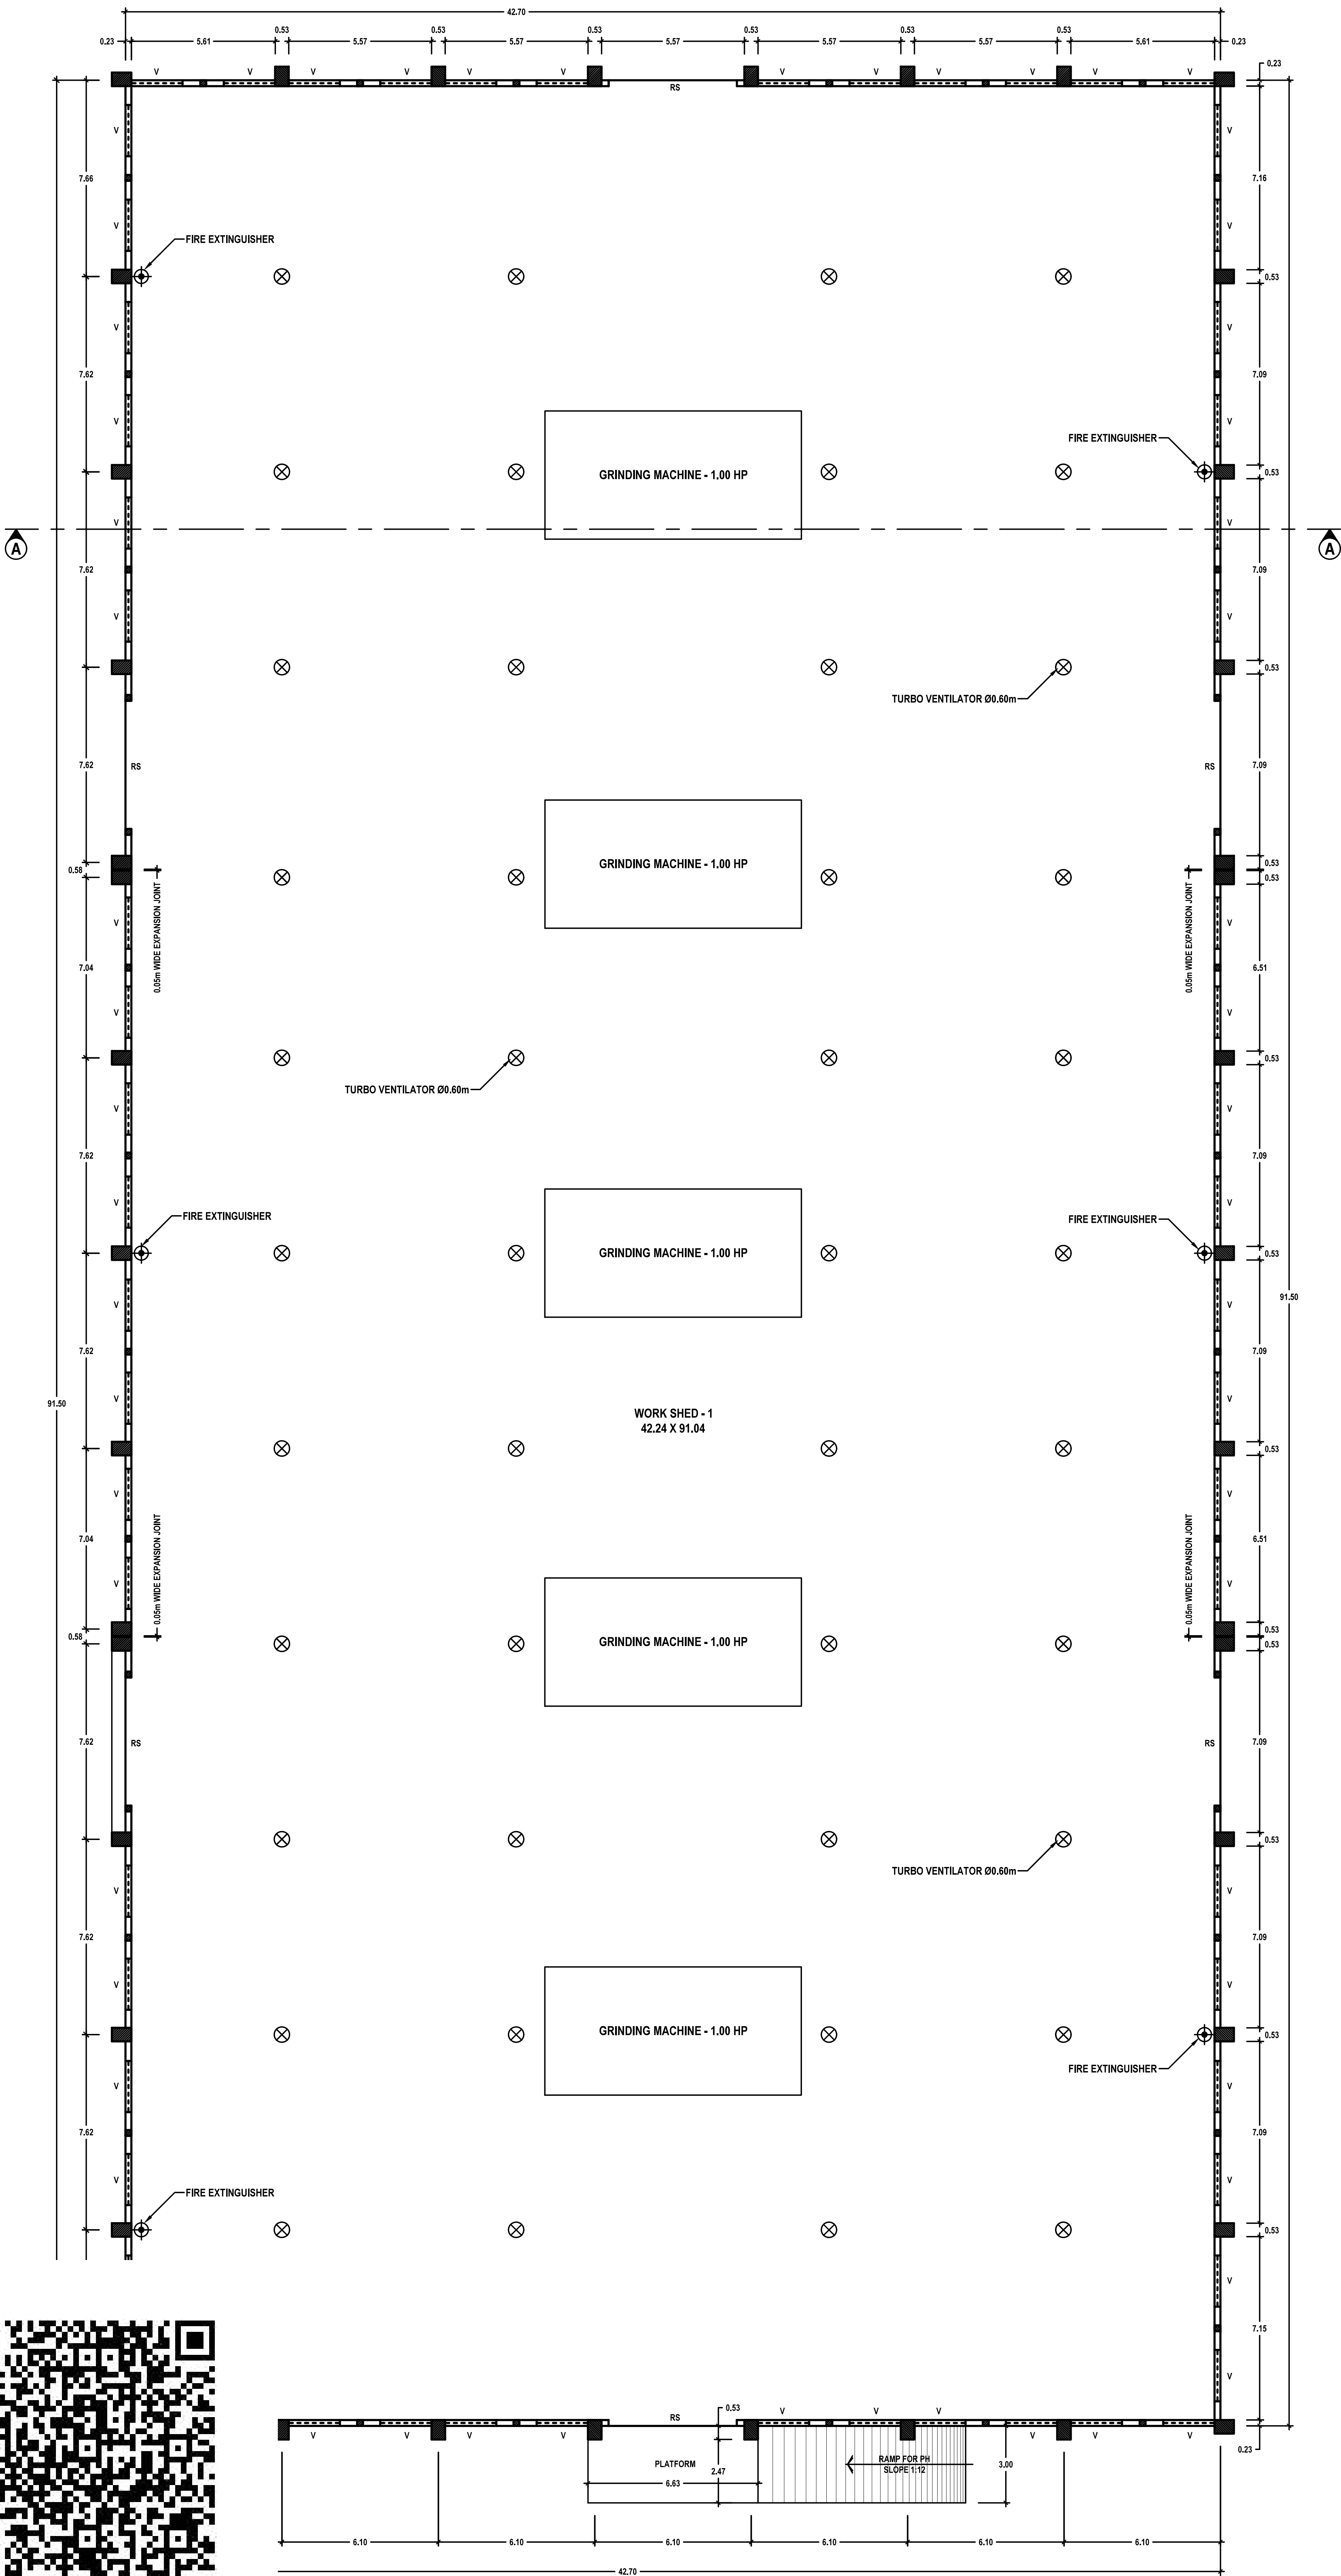

PLAN
PROPOSED WORK SHED - 1

PLANNING PERMISSION
ROC. NO. SWP/BPA/397807/2024
SITE BOUNDARY SHOWN AS "A TO F"
PLANNING PERMISSION NO. 06/2025 (SWP/TUTY)

SWP/BPA/397807/2024
B.P / DTCP No: 34 / 2025

For SIGARAM COLD STORAGE LLP



Partner

APPLICANT

K. Shankar Narayanan
Er. K. SHANKAR NARAYANAN, B.E., M.Tech.,
Registered Geotech Engineer
RGTE 001 / 2022
VARAHA GEOTECHNICAL WORKS
RAJAPALAYAM - 626 117.

REGISTERED GEO-TECH ENGINEER

S.K. Arun Kamaraj
Er.S.K.Arun Kamaraj M.E.(Struct.), M.B.A., M.I.E.,
Chartered Structural Engineer,
Reg: CBELPA-LPA/SE/GR-4/19/05/051
KAARVENS Structural Consultancy,
41, BR Nagar, 3rd Street, Kothari layout,
Ramanathapuram, Coimbatore - 641005.
E: skarun@kaarvens.com W: www.karvens.com
M: +91-9894215019, O: +91-8270005019

REGISTERED STRUCTURAL ENGINEER

S. Suresh Kumar
S. SURESH KUMAR, B.E., M.I.E., F.I.V.,
Chartered Engineer, Approved Valuer,
Consulting Engineer, Registered Engineer Gr. I,
RE / Gr. I / TUT / May 2019 / 001,
District Panel Engineer Class 1A,
Licensed Builder and Surveyor,
28, 1st Floor, Tooveypuram 5th Street,
Thoothukudi - 628 003.

REGISTERED ENGINEER

PLAN SHOWING THE PROPOSED ADDITIONAL CONSTRUCTION IN THE EXISTING DECORTICATING DRY DHALL INDUSTRIAL (GREEN CATEGORY) BUILDING USING 20.00 HP ELECTRICAL POWER IN DOOR NO. 4/54, SURVEY NO. 293/1 & 294/1A, PUTHIYAMPUTHUR ROAD (MELATATHERU), SILLANATTHAM VILLAGE, OTTAPIDARAM TALUK, THOOTHUKUDI DISTRICT.



SHEET NO.

2/8

OFFICE USE:

APPLICANT NAME: M/s. SIGARAM COLD STORAGE LLP

SCALE: 1:100

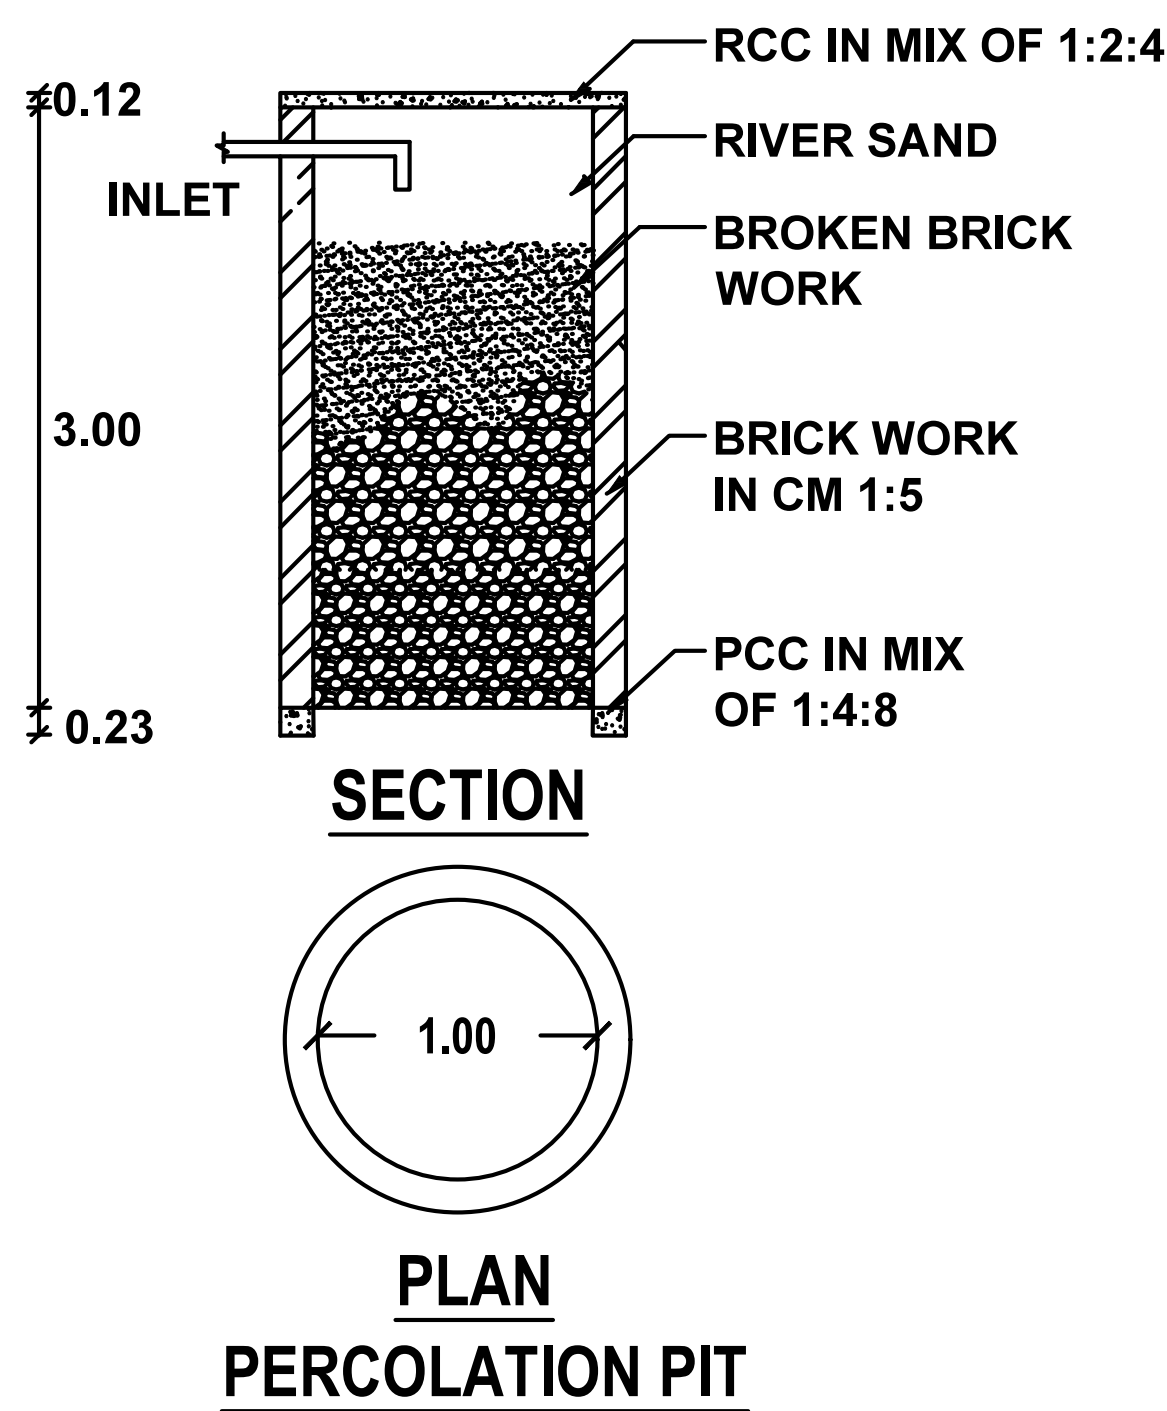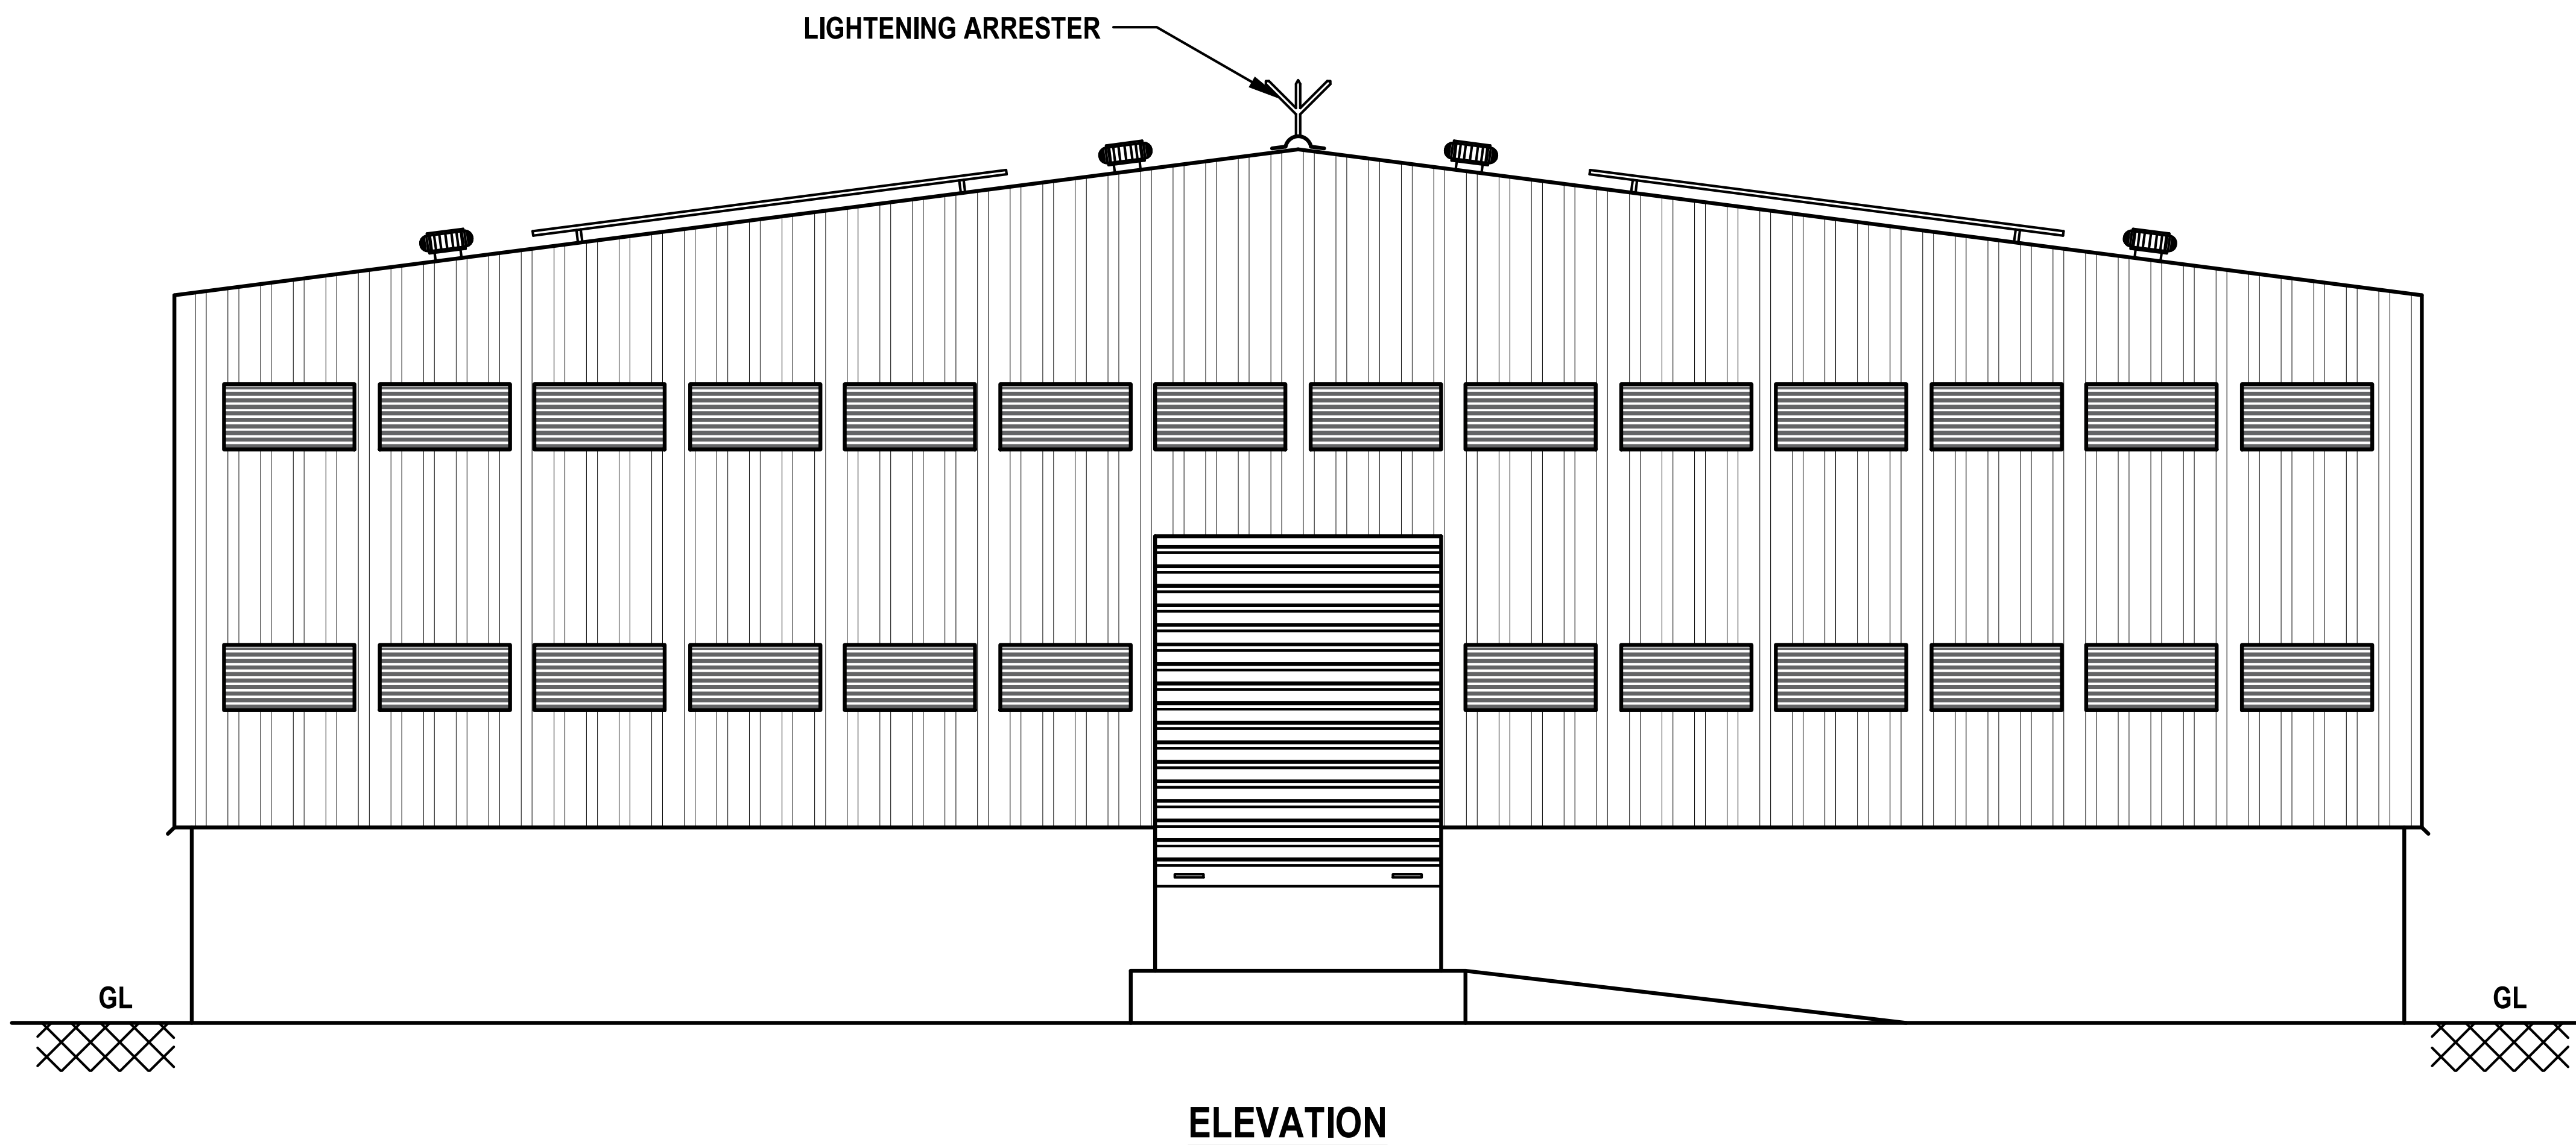

PLANNING PERMISSION


ROC. NO. SWP/BPA/397807/2024

SITE BOUNDARY SHOWN AS "A TO F"

PLANNING PERMISSION NO. 06/2025 (SWP/TUTY)

SWP/BPA/397807/2024

B.P / DTCP No: 34 / 2025

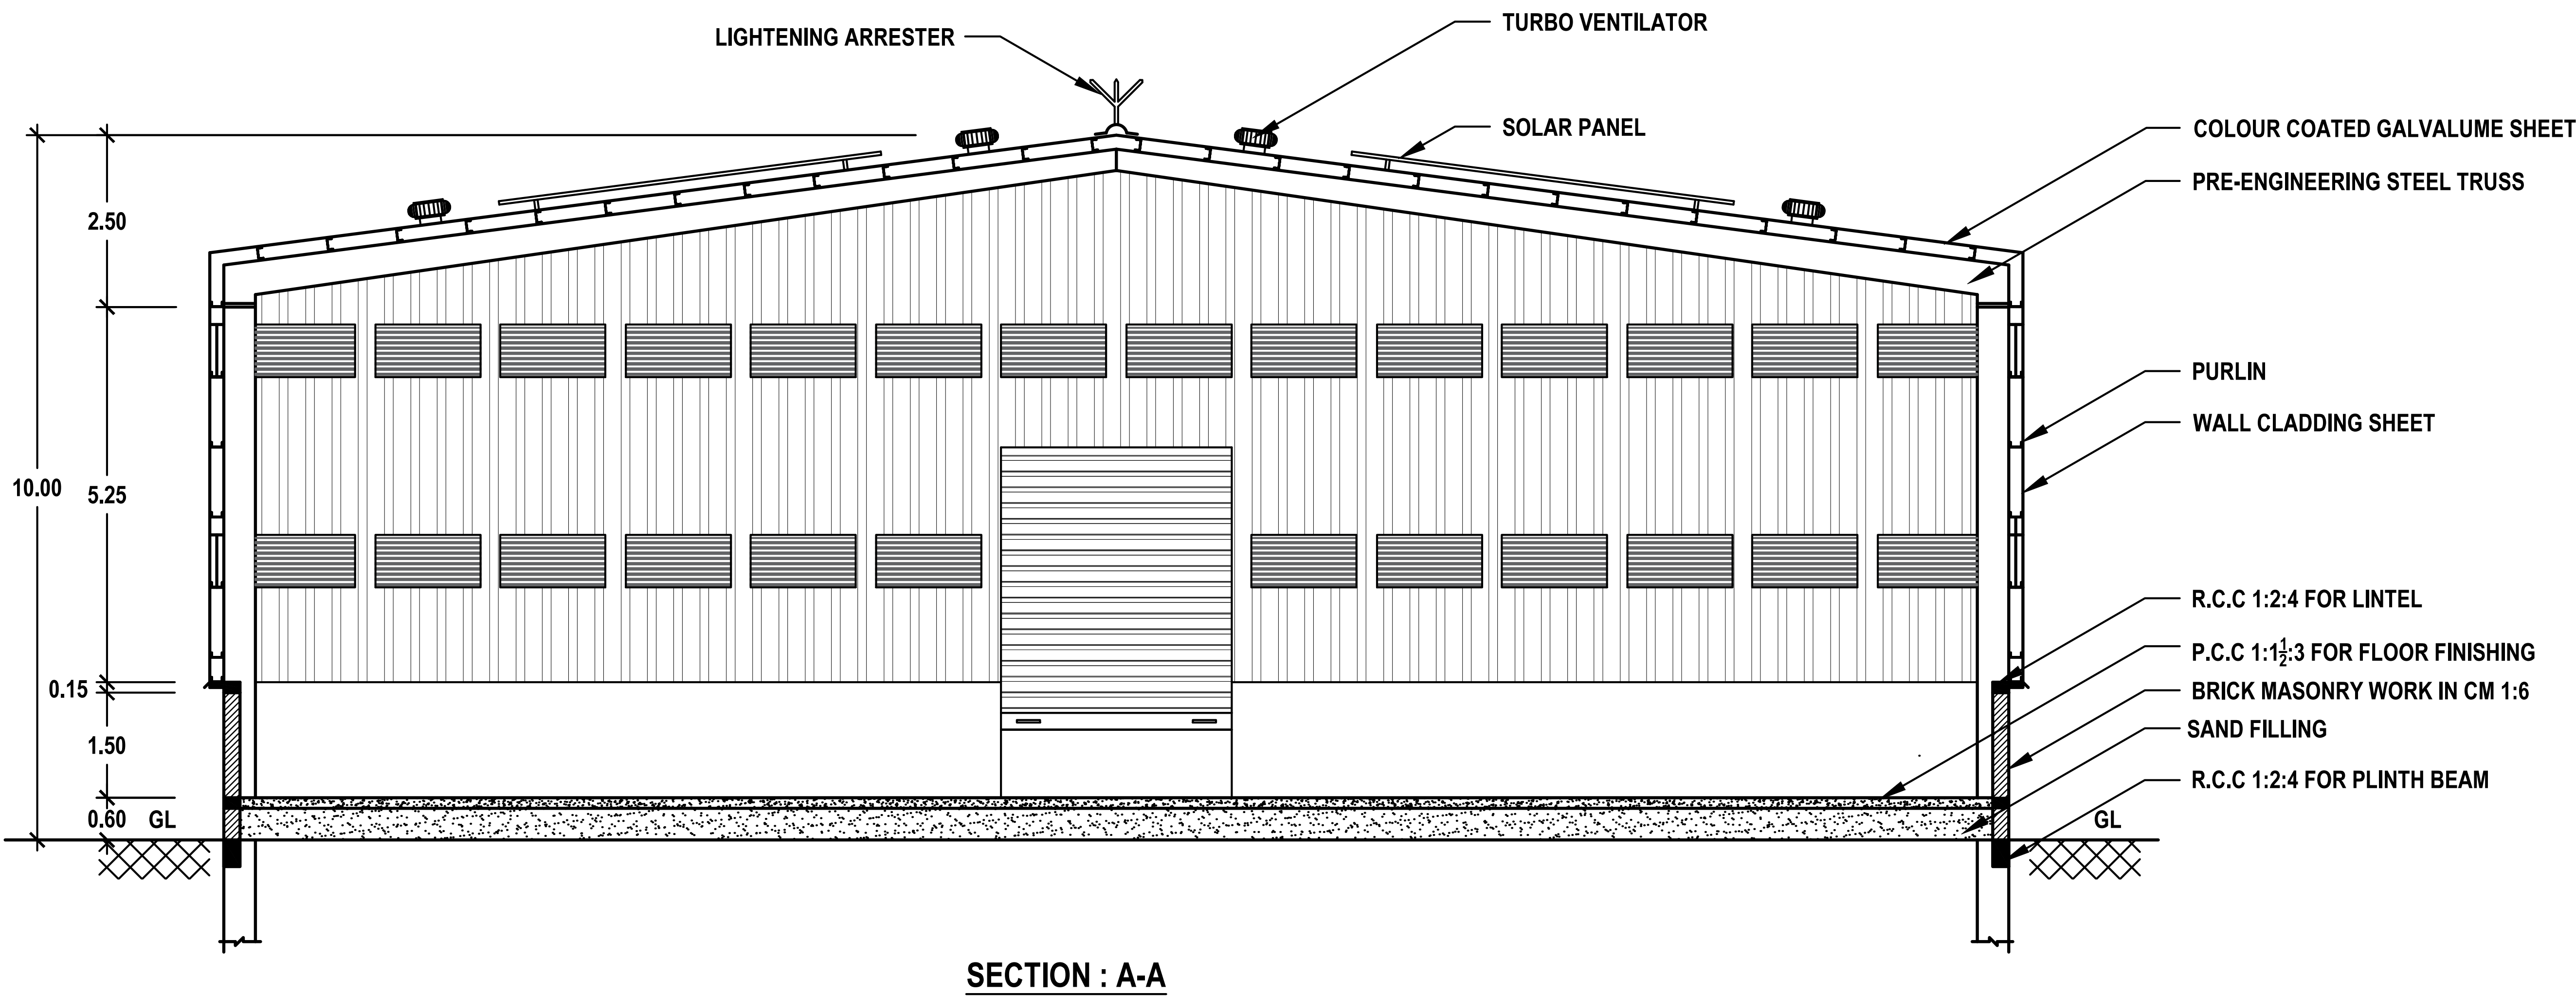

K. Shankar Narayanan
Er. K. SHANKAR NARAYANAN, B.E., M.Tech.,
Registered Geotech Engineer
RGTE 001 / 2022
VARAHA GEOTECHNICAL WORKS
RAJAPALAYAM - 626 117.

For SIGARAM COLD STORAGE LLP
[Signature]
Partner

REGISTERED GEO-TECH ENGINEER

APPLICANT

S.K. Arun Kamaraj
Er.S.K.Arun Kamaraj M.E.(Struct.), MBA, MIE.,
Chartered Structural Engineer,
Reg: CBELPA-LPA/SE/GR-I/19/05/051
KAARVENS Structural Consultancy,
41, BR Nagar, 3rd Street, Kothari layout,
Ramanathapuram, Coimbatore - 641005.
E: skarun@kaarvens.com W: www.karvens.com
M: +91-9894215019, O: +91-8270005019


S. Suresh Kumar
S. SURESH KUMAR, B.E., M.I.E., F.I.V.,
Chartered Engineer, Approved Valuer,
Consulting Engineer, Registered Engineer Gr. I,
RE / Gr. I / TUT / May 2019 / 001,
District Panel Engineer Class IA,
Licensed Builder and Surveyor,
28, 1st Floor, Tooveypuram 5th Street,
Thoothukudi - 628 003.

REGISTERED STRUCTURAL ENGINEER

REGISTERED ENGINEER

PLAN SHOWING THE PROPOSED ADDITIONAL CONSTRUCTION IN THE EXISTING DECORTICATING DRY DHALL INDUSTRIAL (GREEN CATEGORY) BUILDING USING 20.00 HP ELECTRICAL POWER IN DOOR NO. 4/54, SURVEY NO. 293/1 & 294/1A, PUTHIYAMPUTHUR ROAD (MELATTHERU), SILLANATTHAM VILLAGE, OTTAPIDARAM TALUK, THOOTHUKUDI DISTRICT.

APPLICANT NAME: M/s. SIGARAM COLD STORAGE LLP

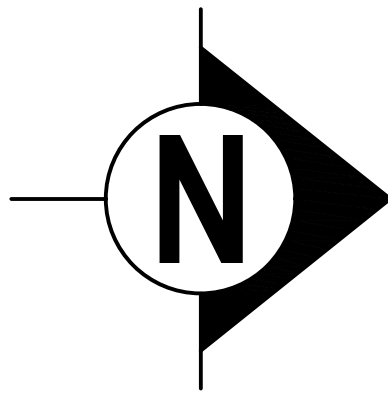


SHEET NO.

3/8

SCALE: 1:100

OFFICE USE:

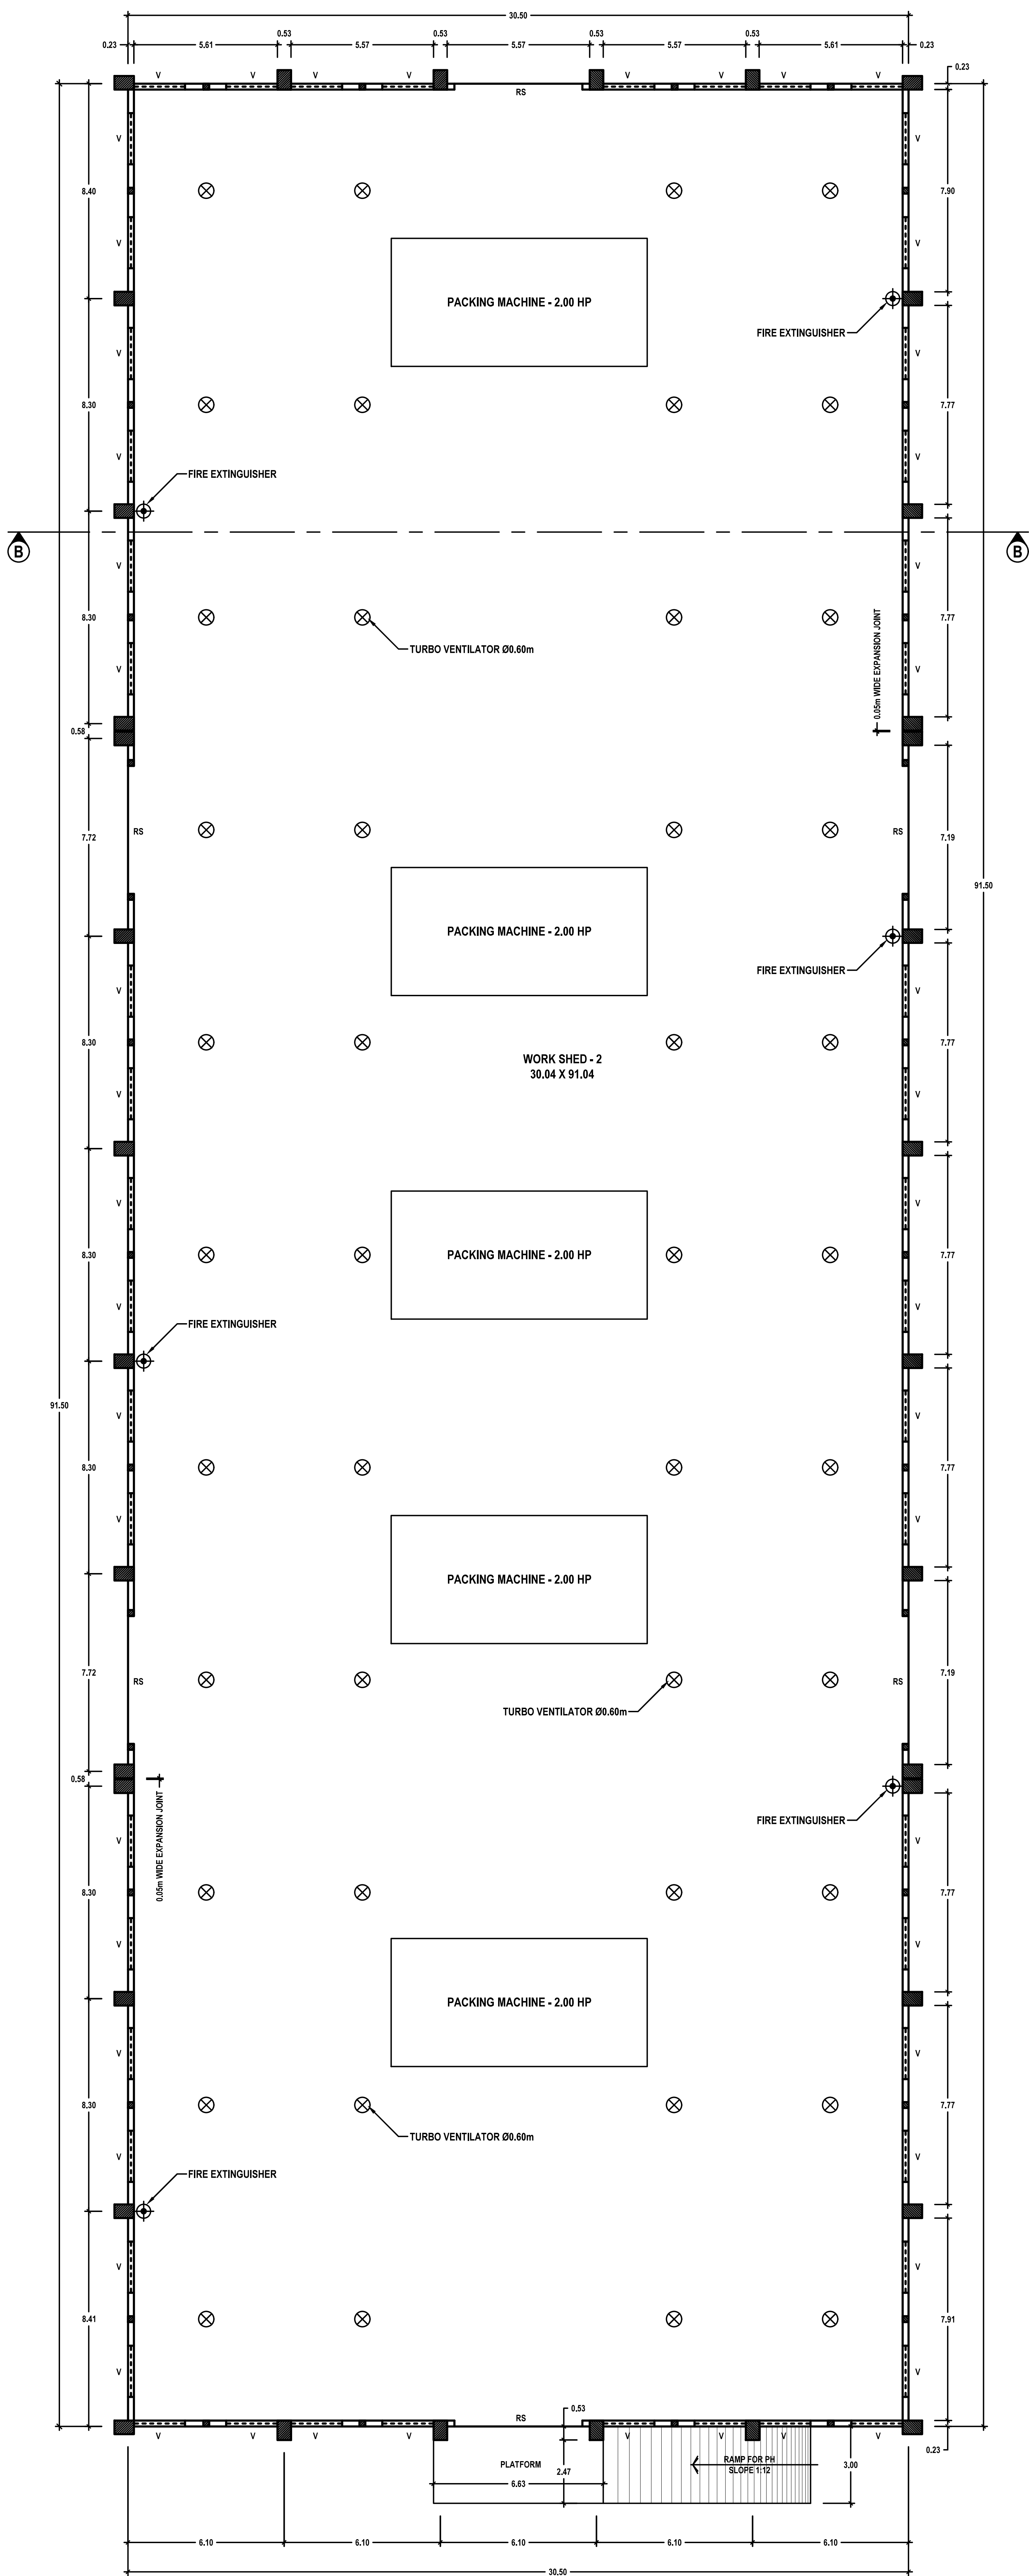

PROPOSED WORK SHED - 2

PLANNING PERMISSION
ROC. NO. SWP/BPA/397807/2024
SITE BOUNDARY SHOWN AS "A TO F"
PLANNING PERMISSION NO. 06/2025 (SWP/TUTY)

SWP/BPA/397807/2024
B.P / DTCP No: 34 / 2025

For SIGARAM COLD STORAGE LLP

Partner

APPLICANT

Er. K. SHANKAR NARAYANAN, B.E., M.Tech.,
Registered Geotech Engineer
RGTE 001 / 2022
VARAHA GEOTECHNICAL WORKS
RAJAPALAYAM - 626 117.

REGISTERED GEO-TECH ENGINEER

Er. S.K. Arun Kamaraj M.E.(Struct.), M.B.A., M.I.E.,
Chartered Structural Engineer,
Reg: CBELPA-LPA/SE/GR-I/19/05/051
KAARVENS Structural Consultancy,
41, BR Nagar, 3rd Street, Kothari layout,
Ramanathapuram, Coimbatore - 641005.
E: skarun@kaarvens.com W: www.karvens.com
M: +91-9894215019, O: +91-8270005019


REGISTERED STRUCTURAL ENGINEER

S. SURESH KUMAR, B.E., M.I.E., F.I.V.,
Chartered Engineer, Approved Valuer,
Consulting Engineer, Registered Engineer Gr. I,
RE / Gr. I / TUT / May 2019 / 001,
District Panel Engineer Class IA,
Licensed Builder and Surveyor,
28, 1st Floor, Tooveypuram 5th Street,
Thoothukudi - 628 003.

REGISTERED ENGINEER

PLAN SHOWING THE PROPOSED ADDITIONAL CONSTRUCTION IN THE EXISTING DECORTICATING DRY DHALL INDUSTRIAL (GREEN CATEGORY) BUILDING USING 20.00 HP ELECTRICAL POWER IN DOOR NO. 4/54, SURVEY NO. 293/1 & 294/1A, PUTHIYAMPUTHUR ROAD (MELATTHERU), SILLANATTHAM VILLAGE, OTTAPIDARAM TALUK, THOOTHUKUDI DISTRICT.


APPLICANT NAME: M/s. SIGARAM COLD STORAGE LLP

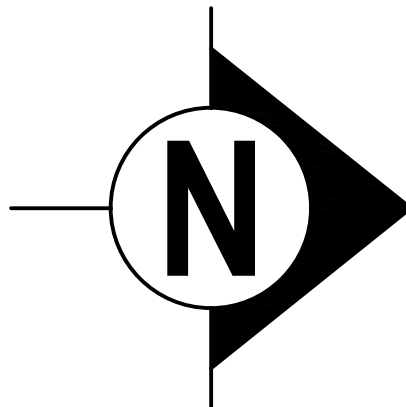

4/8

SCALE: 1:100

OFFICE USE:

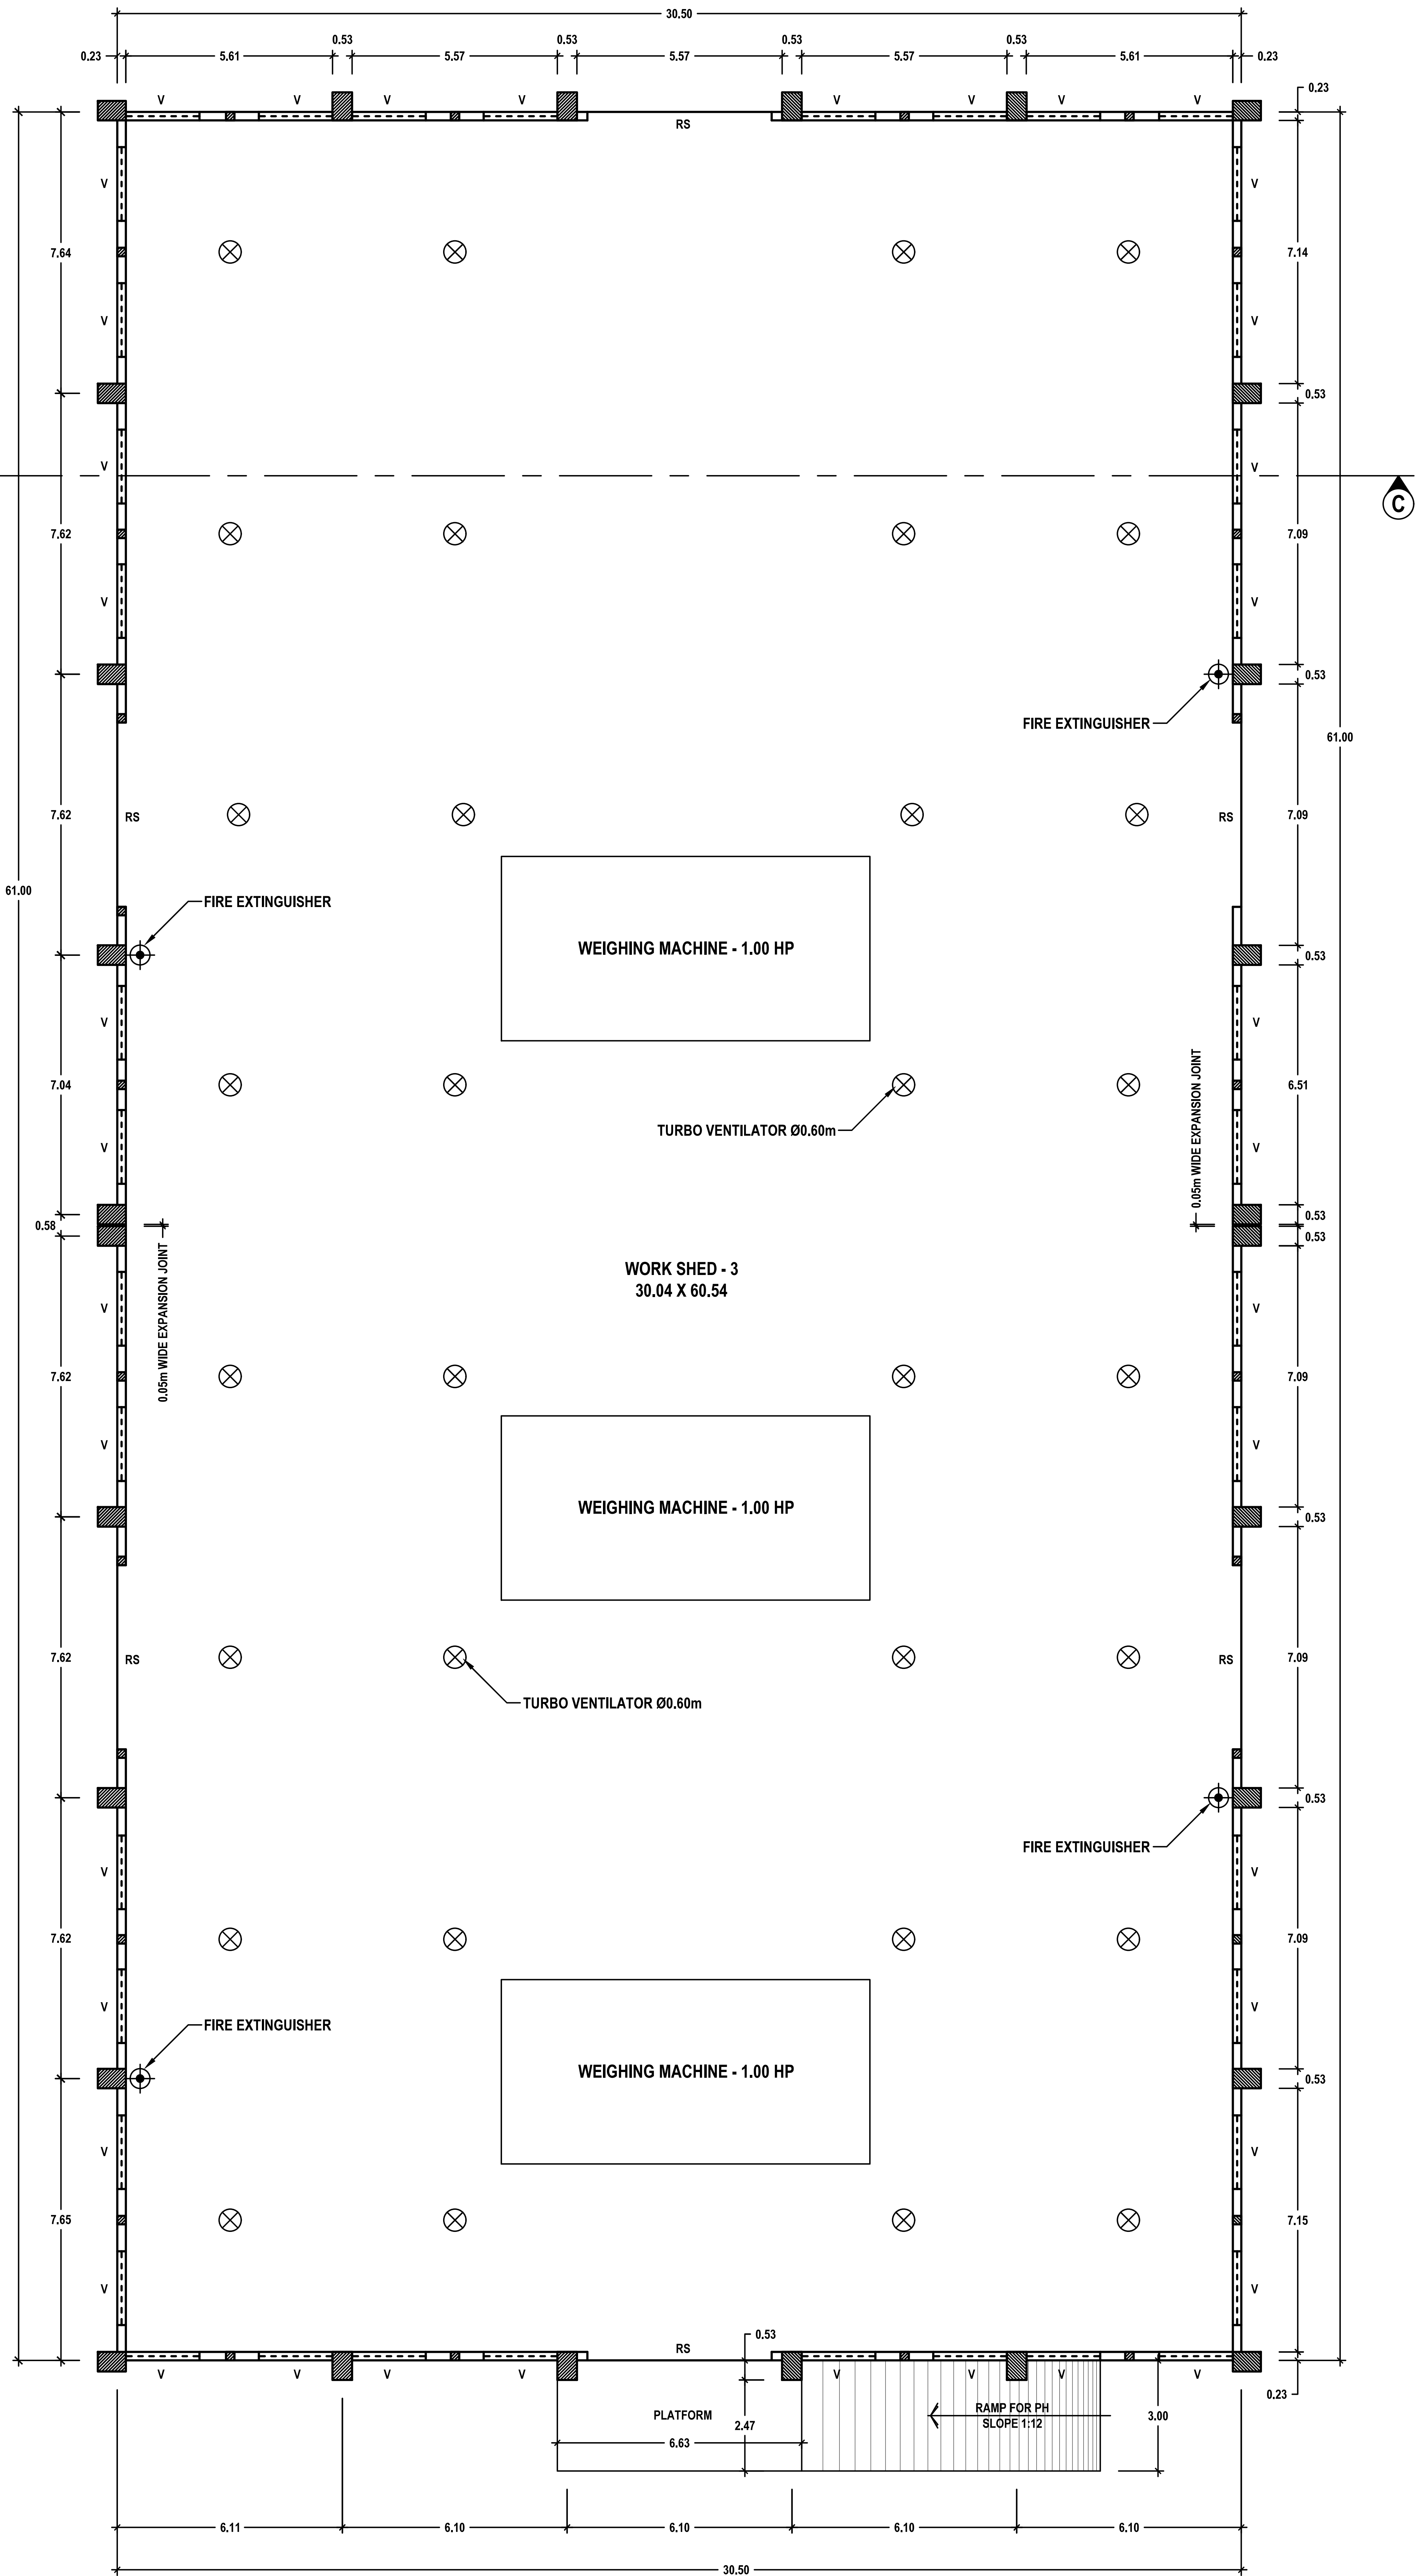

PLAN

PROPOSED WORK SHED - 3

PLANNING PERMISSION
ROC. NO. SWP/BPA/397807/2024
SITE BOUNDARY SHOWN AS "A TO F"
PLANNING PERMISSION NO. 06/2025 (SWP/TUTY)

SWP/BPA/397807/2024
B.P / DTCP No: 34 / 2025

For SIGARAM COLD STORAGE LLP




Partner

APPLICANT


Er. K. SHANKAR NARAYANAN, B.E., M.Tech.,
Registered Geotech Engineer
RGTE 001 / 2022
VARAHA GEOTECHNICAL WORKS
RAJAPALAYAM - 626 117.

REGISTERED GEO-TECH ENGINEER

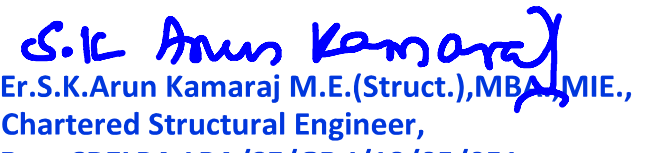
Er. S.K. Arun Kamaraj M.E.(Struct.), M.B.A., MIE.,
Chartered Structural Engineer,
Reg: CBELPA-LPA/SE/GR-1/19/05/051
KAARVENS Structural Consultancy,
43, SR Nagar, 3rd Street, Kothari layout,
Ramanathapuram, Coimbatore - 641005.
E: skarun@kaarvens.com W: www.karvens.com
M: +91-9894215019, O: +91-8270005019

REGISTERED STRUCTURAL ENGINEER


S. SURESH KUMAR, B.E., M.I.E., F.I.V.,
Chartered Engineer, Approved Valuer,
Consulting Engineer, Registered Engineer Gr. I,
RE / Gr. I / TUT / May 2019 / 001,
District Panel Engineer Class IA,
Licensed Builder and Surveyor,
28, 1st Floor, Tooveypuram 5th Street,
Thoothukudi - 628 003.

REGISTERED ENGINEER



PLAN SHOWING THE PROPOSED ADDITIONAL CONSTRUCTION IN THE EXISTING DECORTICATING DRY DHALL INDUSTRIAL (GREEN CATEGORY) BUILDING USING 20.00 HP ELECTRICAL POWER IN DOOR NO. 4/54, SURVEY NO. 293/1 & 294/1A, PUTHIYAMPUTHUR ROAD (MELATATHERU), SILLANATTHAM VILLAGE, OTTAPIDARAM TALUK, THOOTHUKUDI DISTRICT.

SHEET NO.
5/8



OFFICE USE:

APPLICANT NAME: M/s. SIGARAM COLD STORAGE LLP

SCALE: 1:100

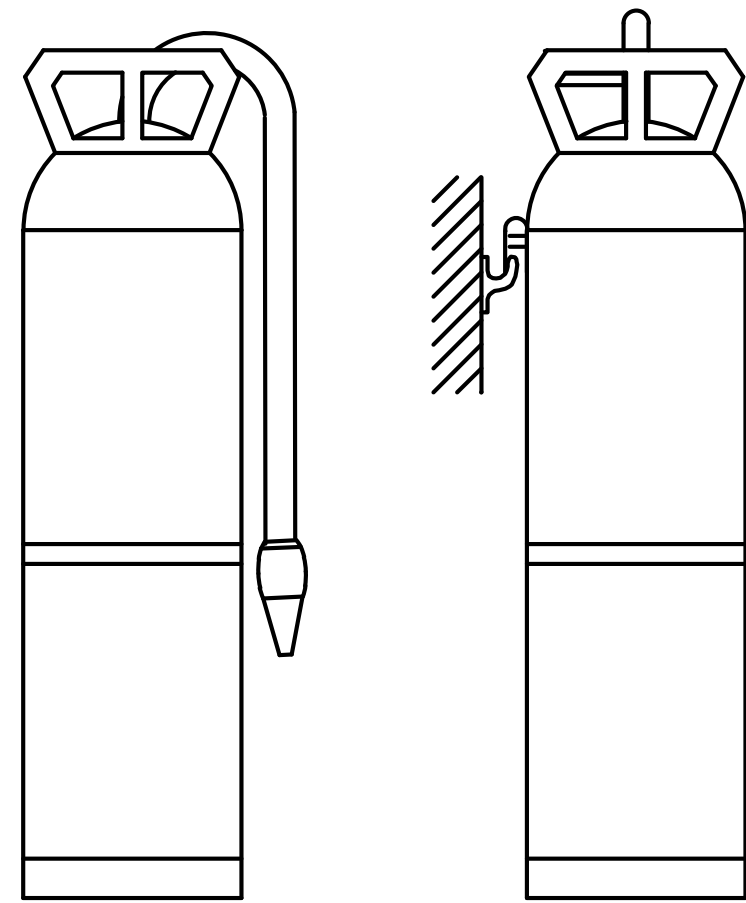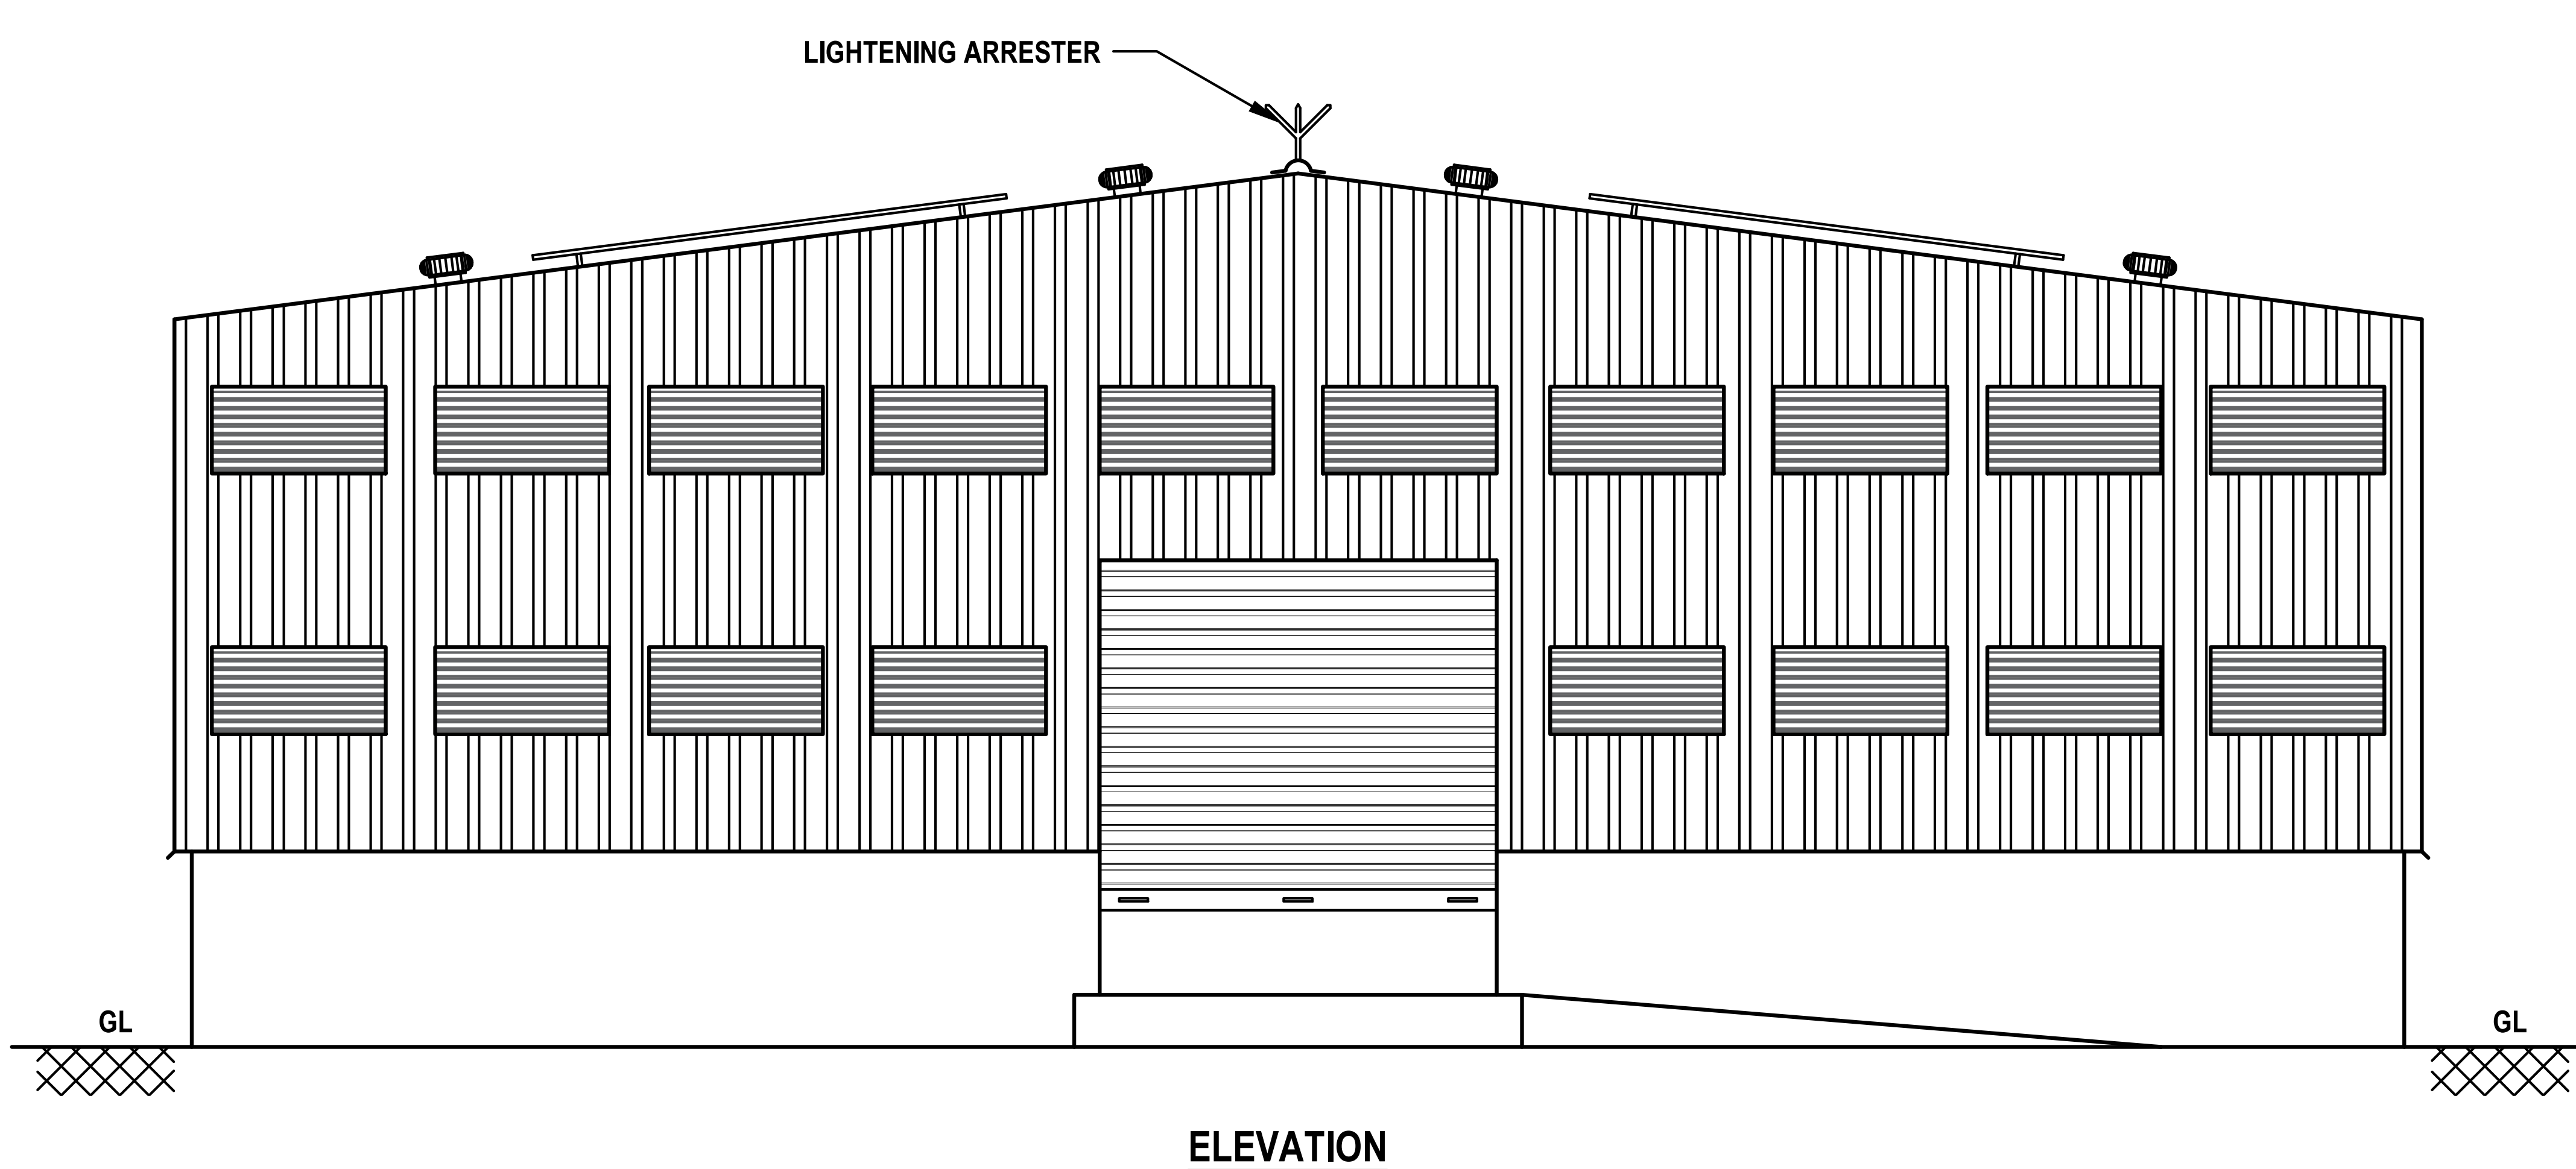

FIRE EXTINGUISHER

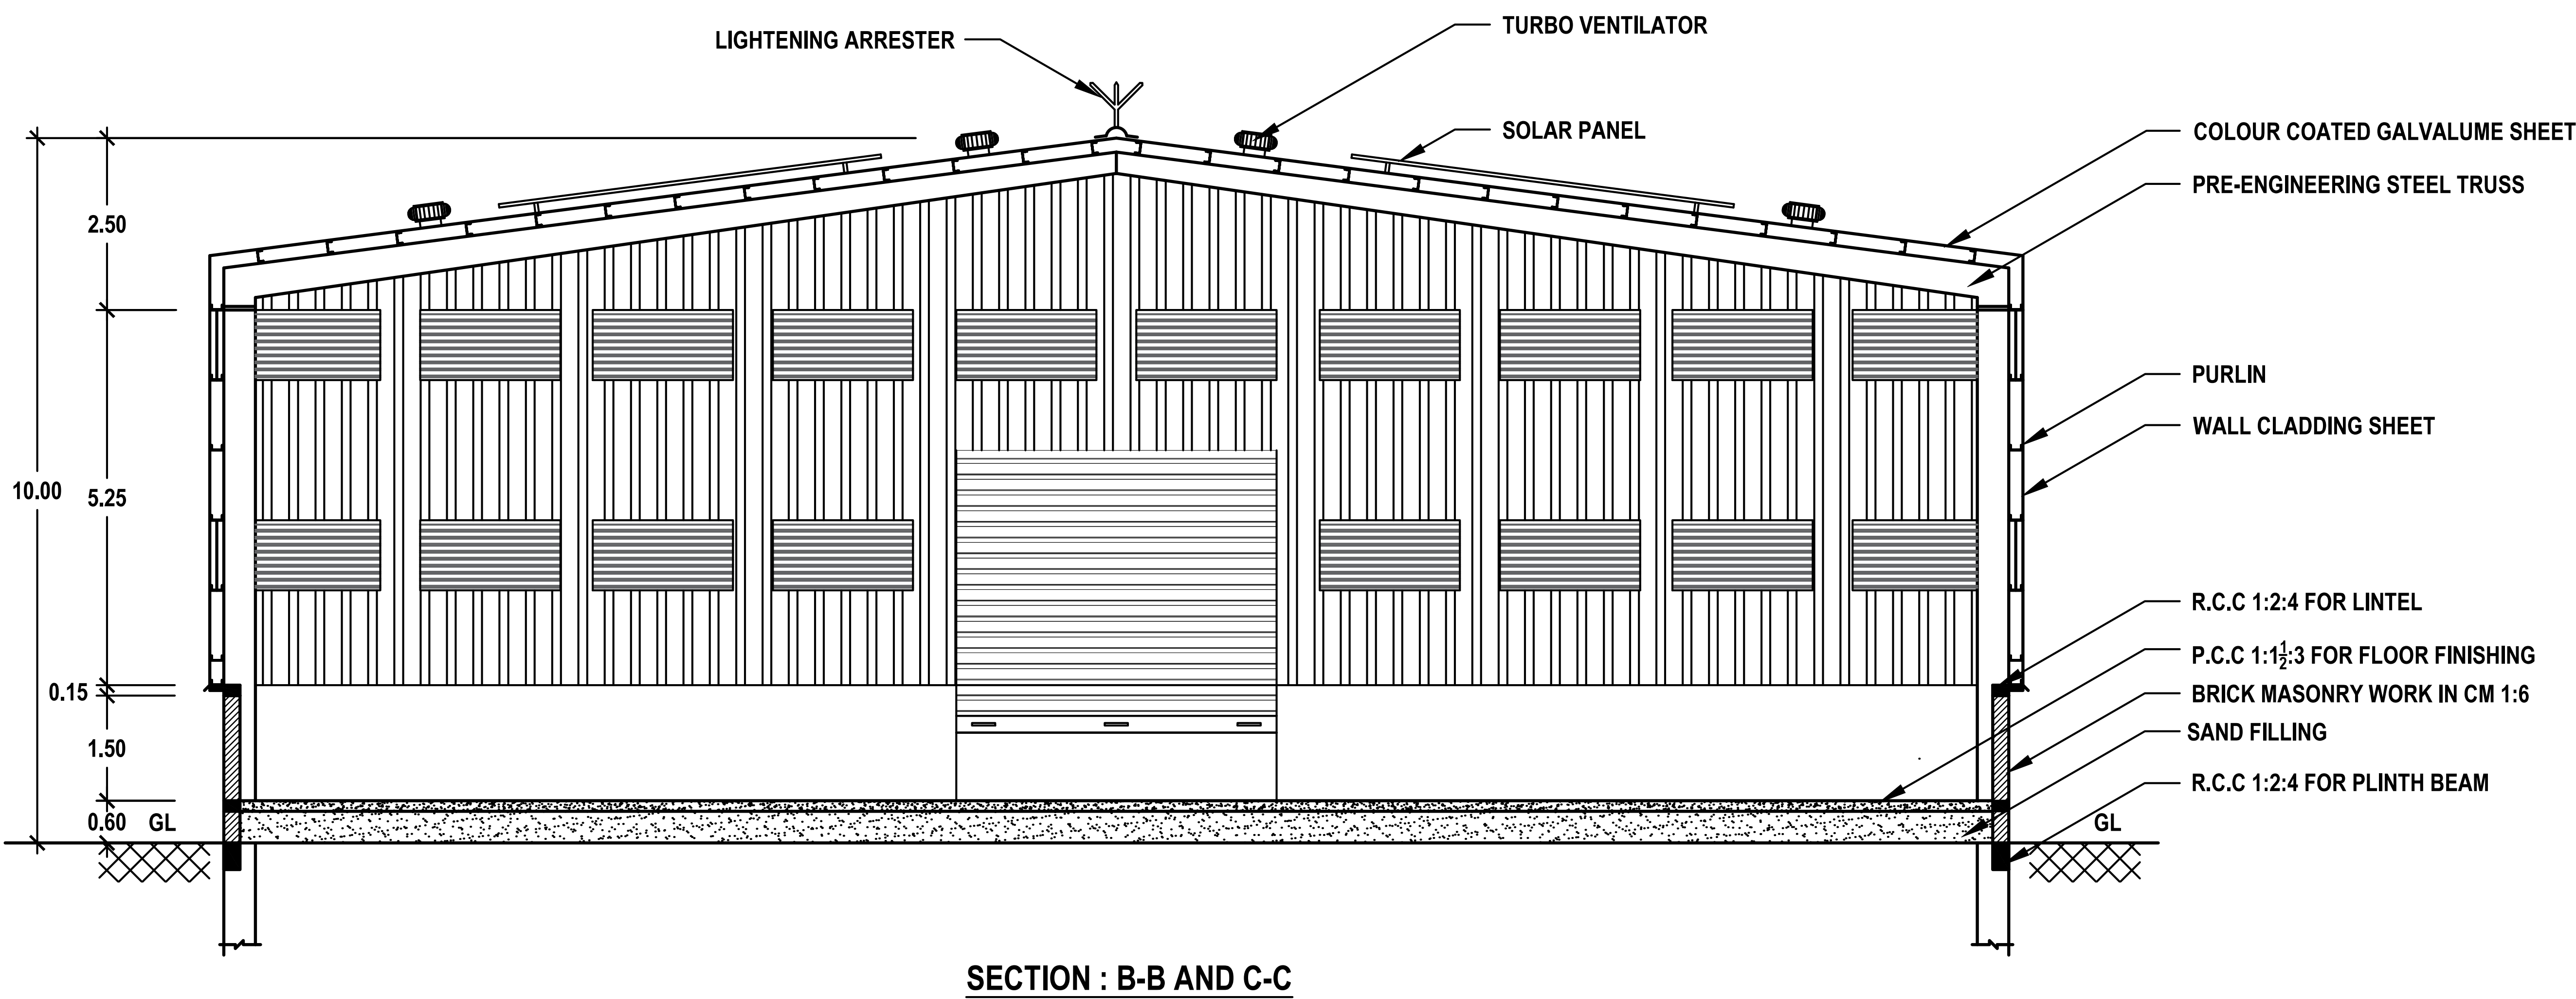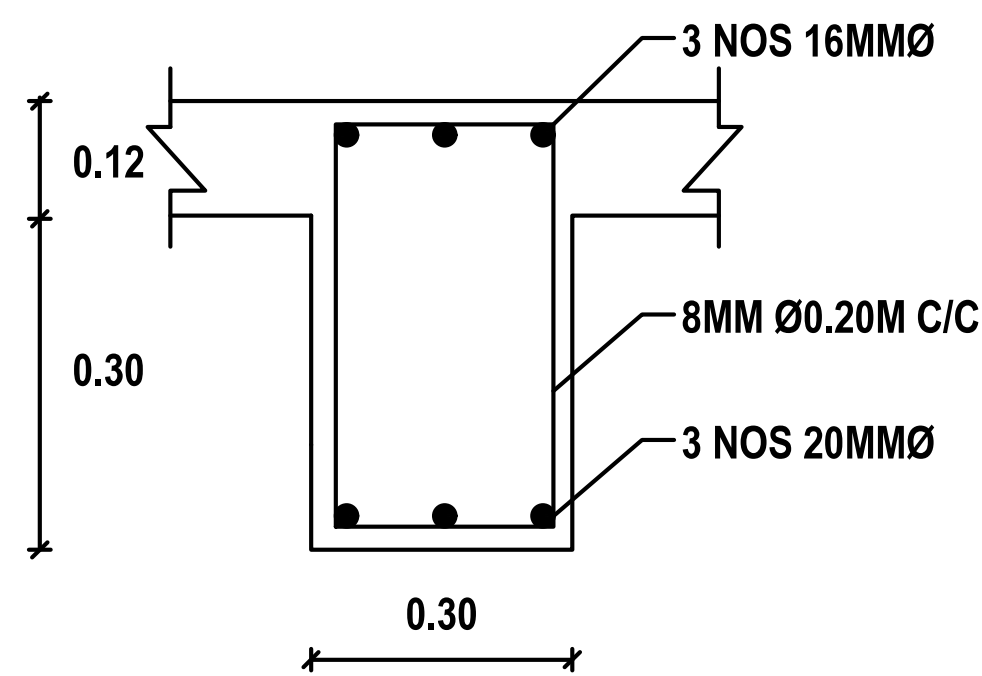

ELEVATION AND SECTION OF PROPOSED WORK SHED 2 AND WORK SHED 3 - TYPICAL

PLANNING PERMISSION
ROC. NO. SWP/BPA/397807/2024
SITE BOUNDARY SHOWN AS "A TO F"
PLANNING PERMISSION NO. 06/2025 (SWP/TUTY)

SWP/BPA/397807/2024
B.P / DTCP No: 34 / 2025

K. Shankar Narayanan
Er. K. SHANKAR NARAYANAN, B.E., M.Tech.,
Registered Geotech Engineer
RGTE 001 / 2022
VARAHA GEOTECHNICAL WORKS
RAJAPALAYAM - 626 117.

For SIGARAM COLD STORAGE LLP
[Signature]
Partner

REGISTERED GEO-TECH ENGINEER

APPLICANT

S.K. Arun Kamaraj
Er.S.K.Arun Kamaraj M.E.(Struct.), M.B.A., M.I.E.,
Chartered Structural Engineer,
Reg: CBELPA-LPA/SE/GR-I/19/05/051
KAARVENS Structural Consultancy,
41, BR Nagar, 3rd Street, Kothari layout,
Ramanathapuram, Coimbatore - 641005.
E: skarun@kaarvens.com W: www.karvens.com
M: +91-9894215019, O: +91-8270005019

S. Suresh Kumar
S. SURESH KUMAR, B.E., M.I.E., F.I.V.,
Chartered Engineer, Approved Valuer,
Consulting Engineer, Registered Engineer Gr. I,
RE / Gr. I / TUT / May 2019 / 001,
District Panel Engineer Class IA,
Licensed Builder and Surveyor,
28, 1st Floor, Tooveyapuram 5th Street,
Thoothukudi - 628 003.

REGISTERED STRUCTURAL ENGINEER

REGISTERED ENGINEER

PLAN SHOWING THE PROPOSED ADDITIONAL CONSTRUCTION IN THE EXISTING DECORTICATING DRY DHALL INDUSTRIAL (GREEN CATEGORY) BUILDING USING 20.00 HP ELECTRICAL POWER IN DOOR NO. 4/54, SURVEY NO. 293/1 & 294/1A, PUTHIYAMPUTHUR ROAD (MELATTHEERU), SILLANATTHAM VILLAGE, OTTAPIDARAM TALUK, THOOTHUKUDI DISTRICT.


SHEET NO.

6/8


OFFICE USE:

APPLICANT NAME: M/s. SIGARAM COLD STORAGE LLP


SCALE: 1:100

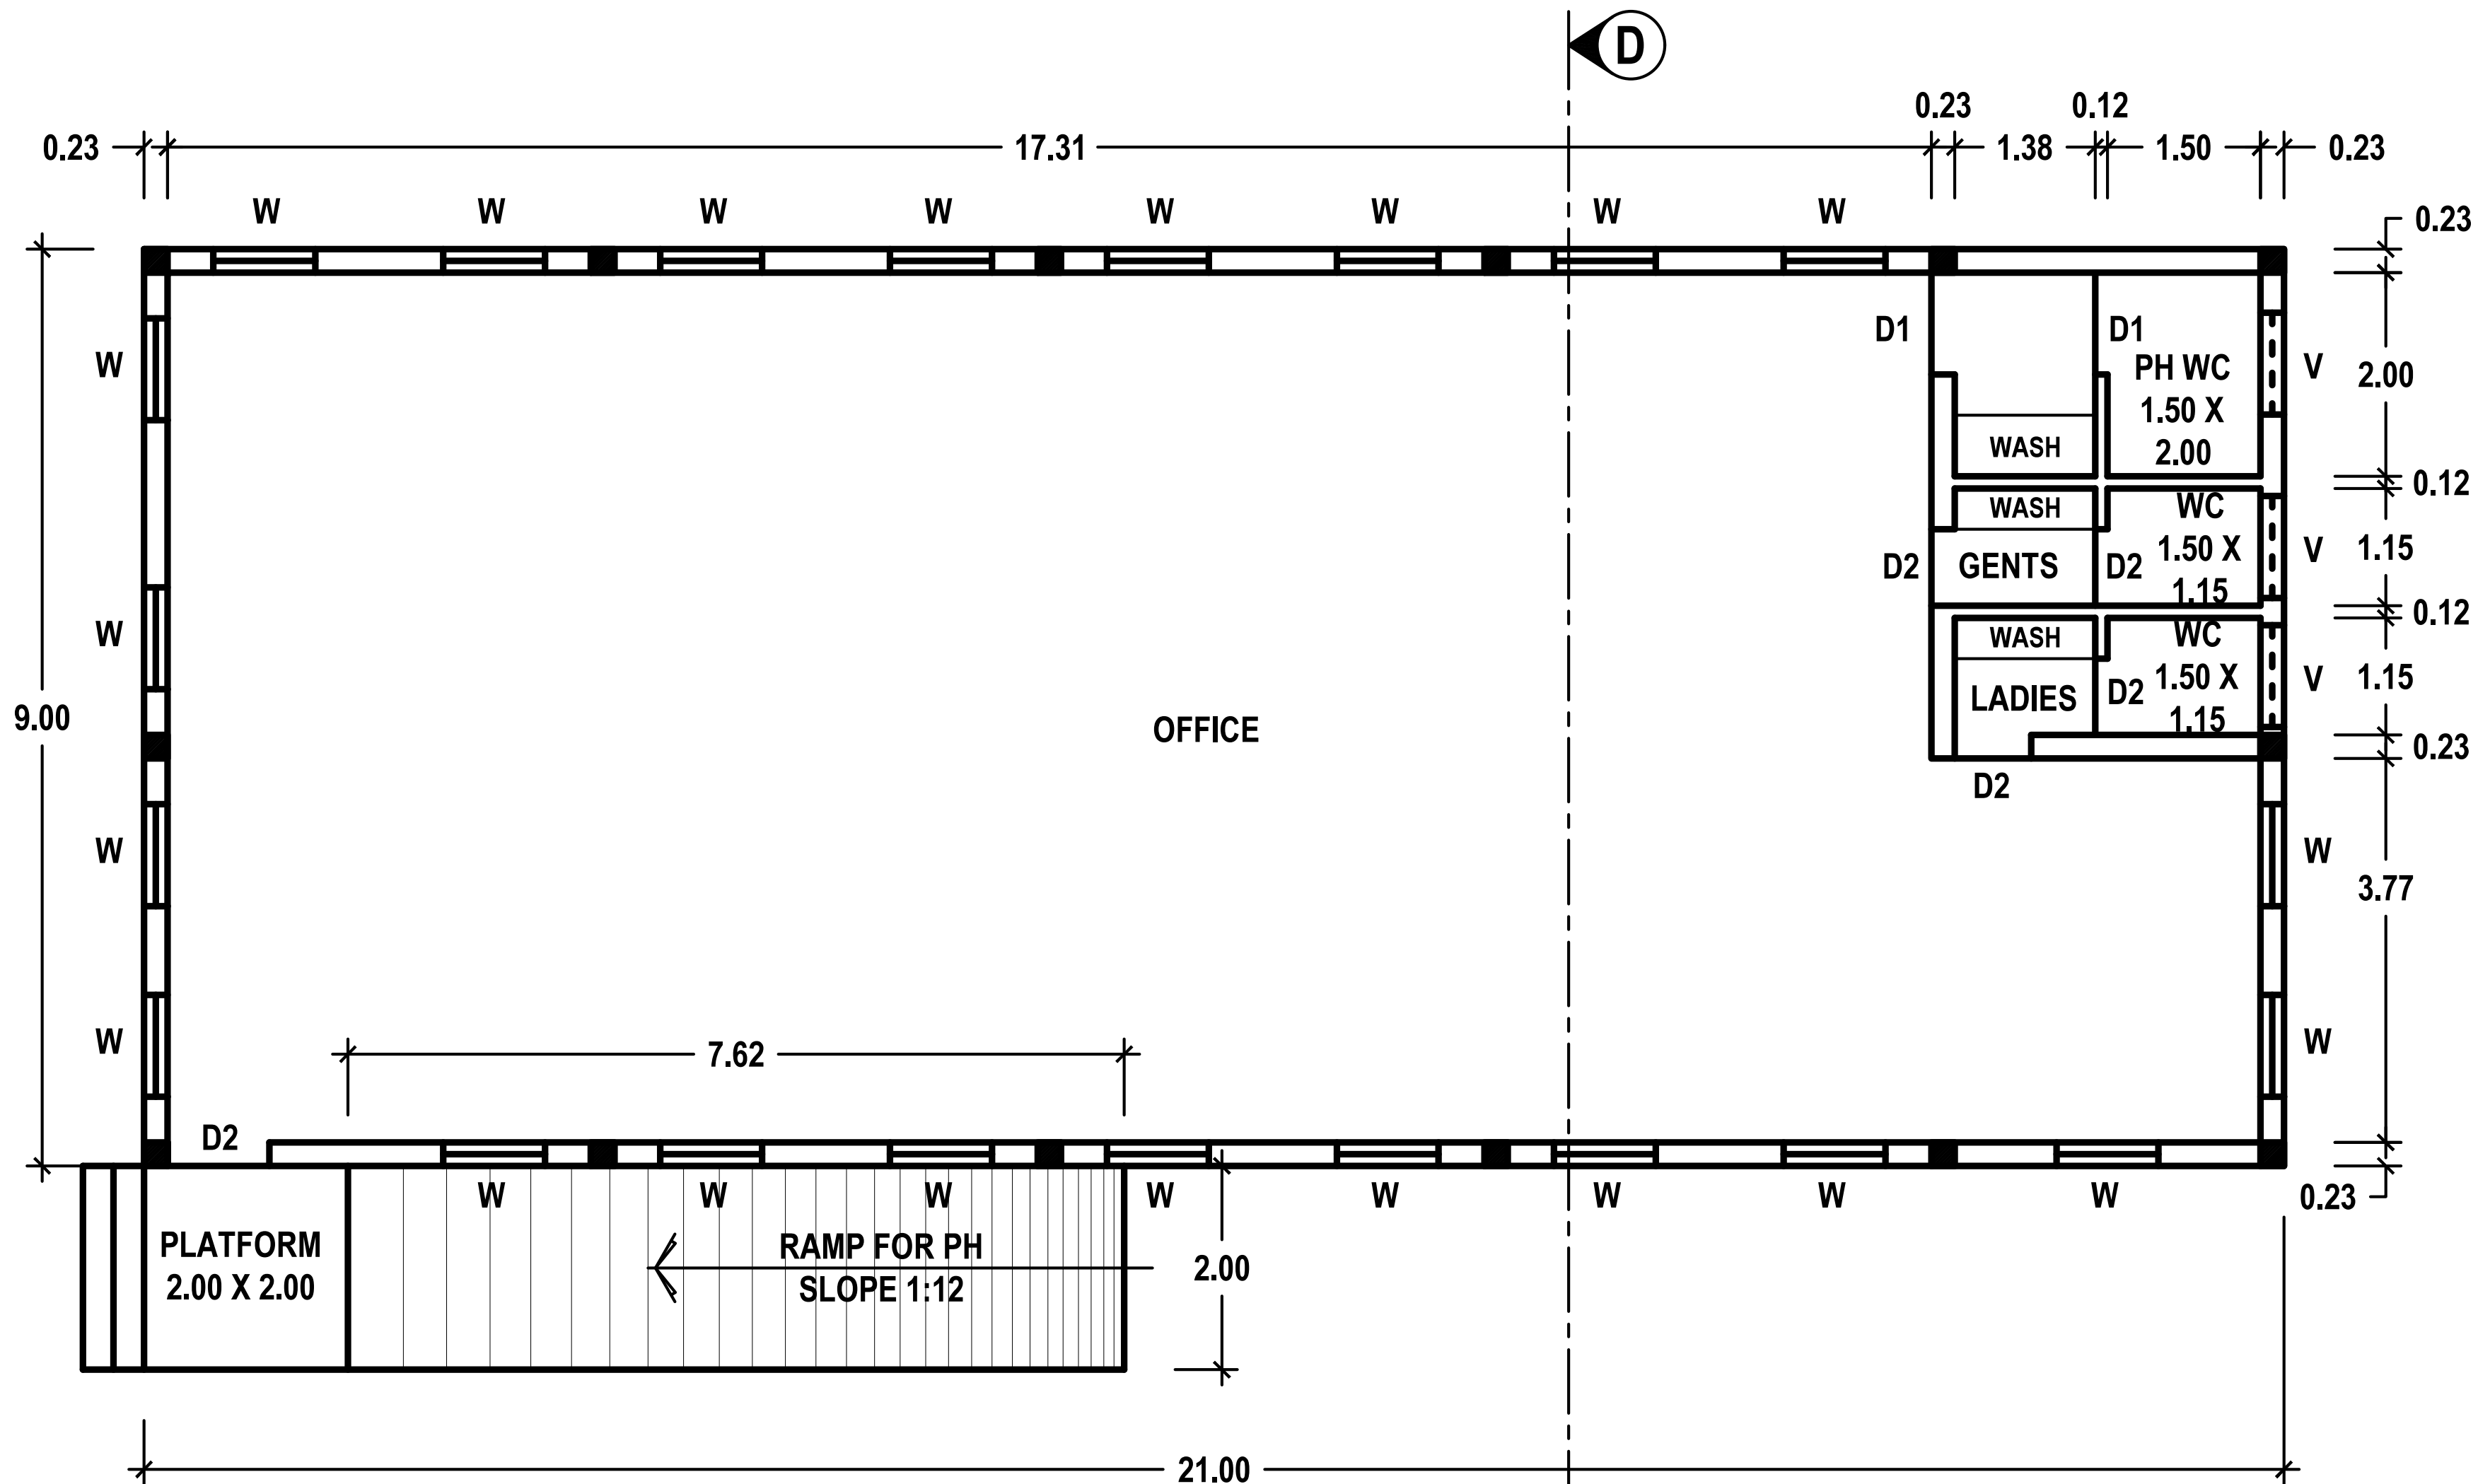


PLAN

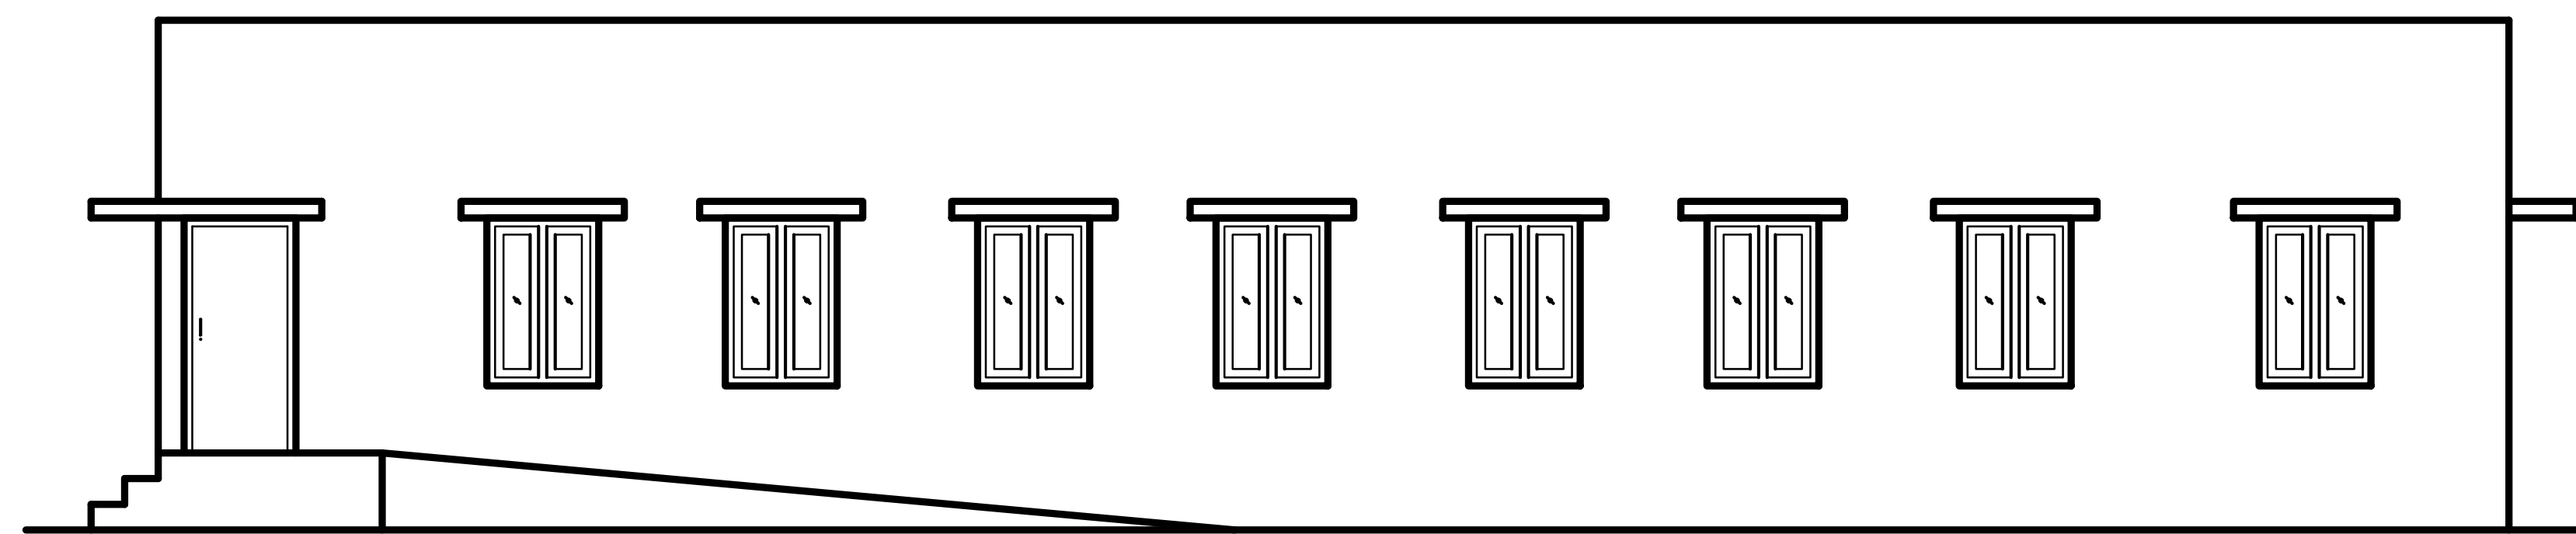


ELEVATION

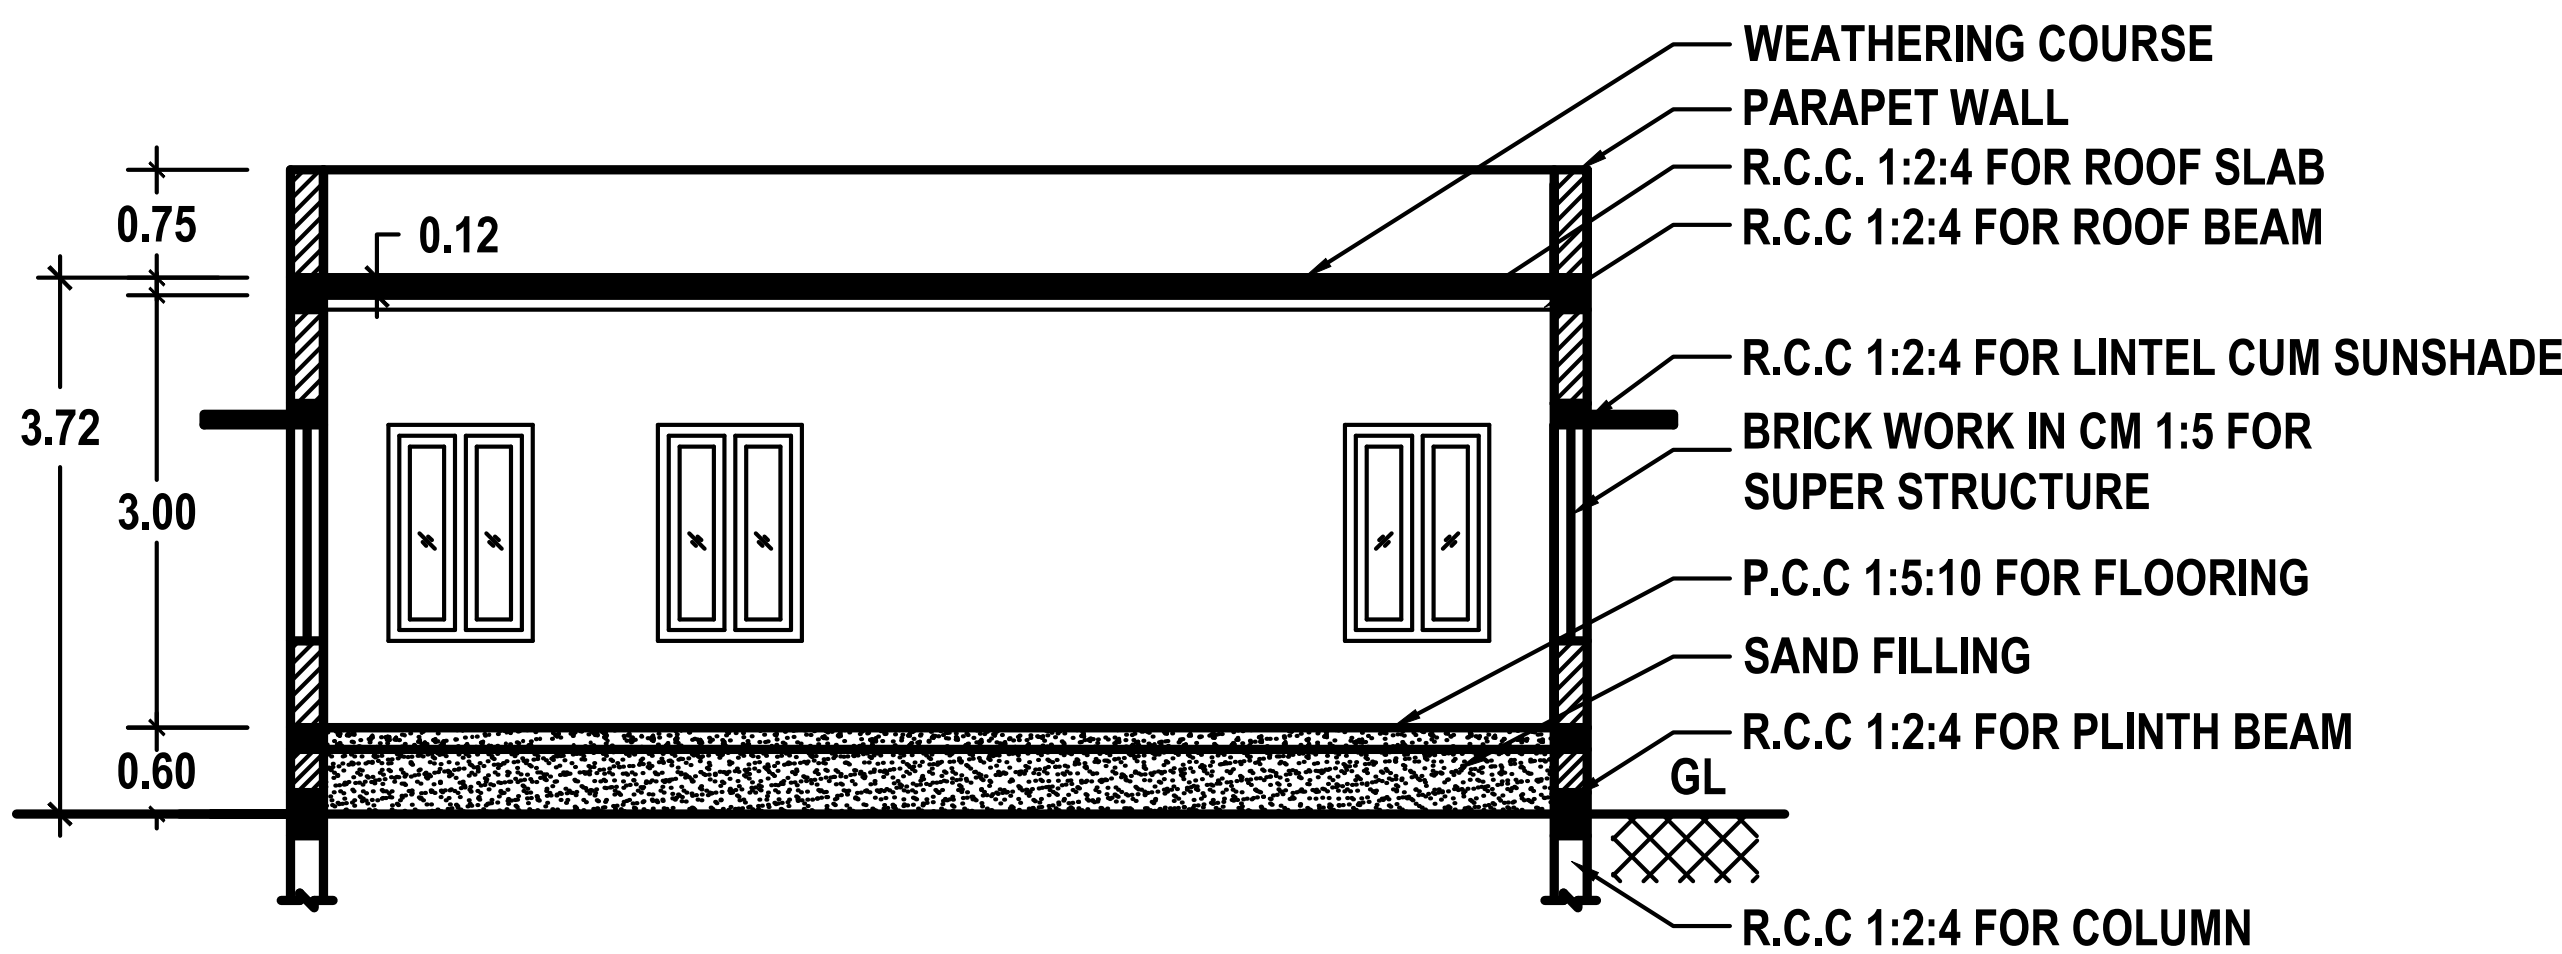


SECTION: D - D

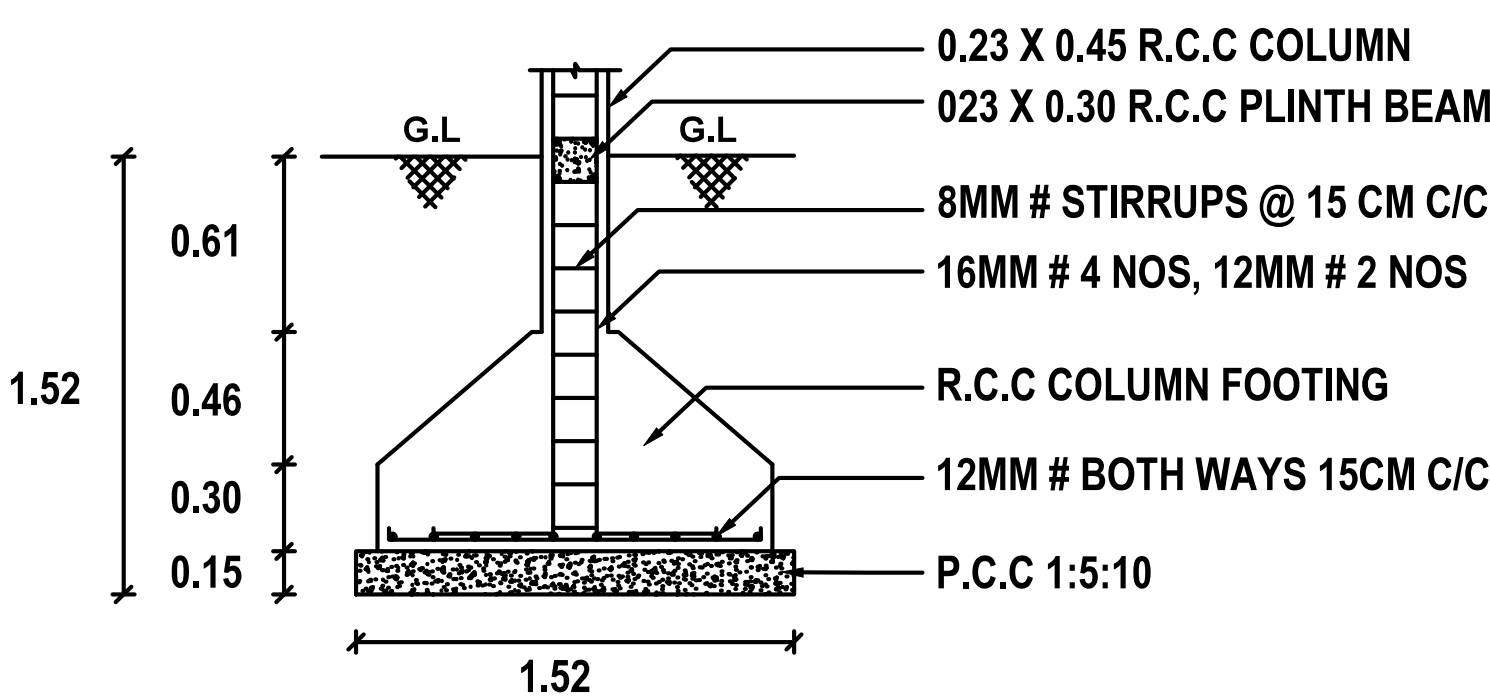


COLUMN FOOTING DETAILS

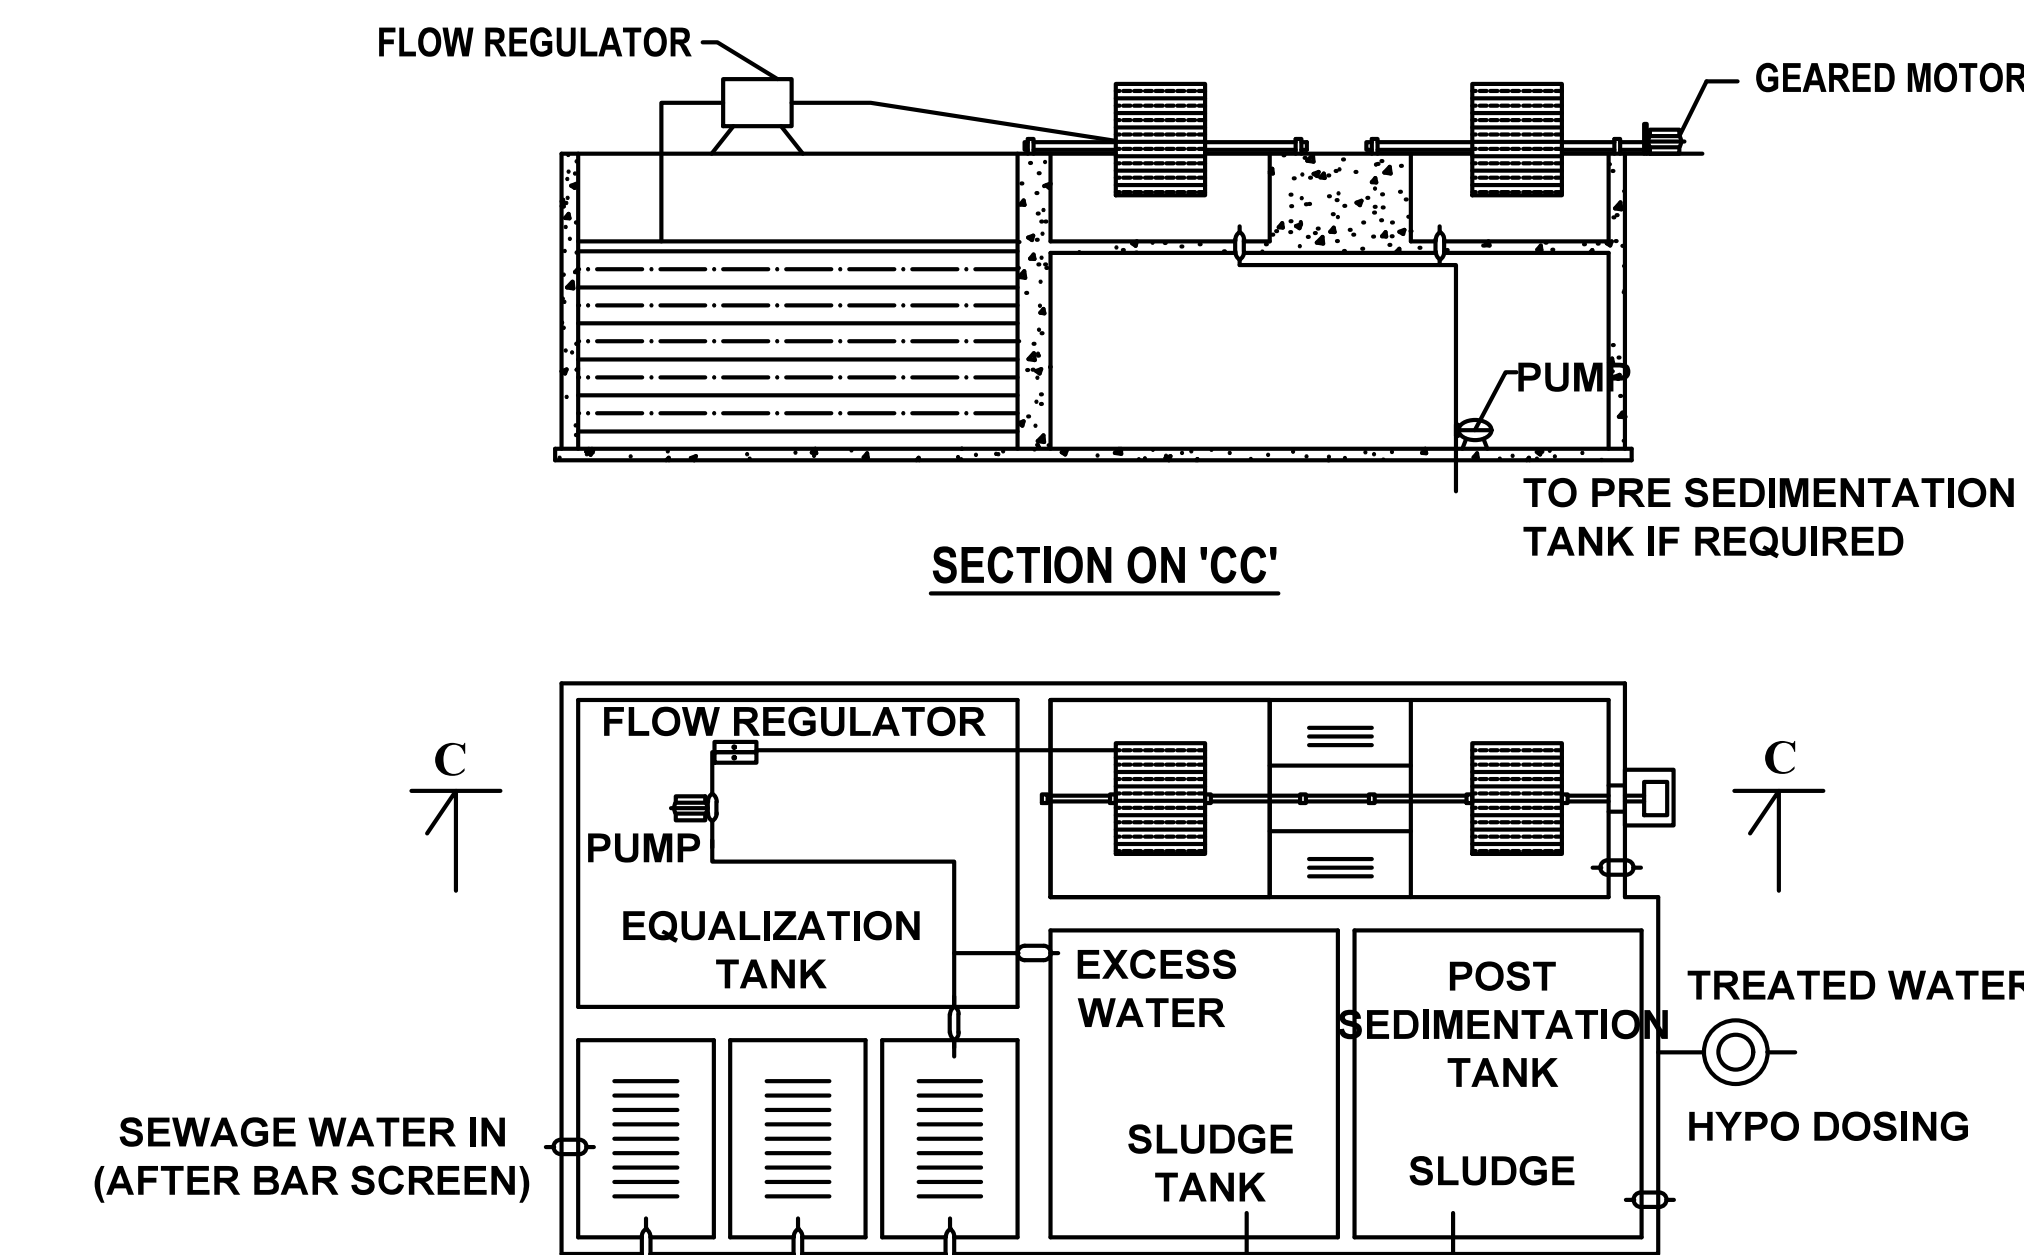

DETAILS OF SEWAGE TREATMENT PLANT

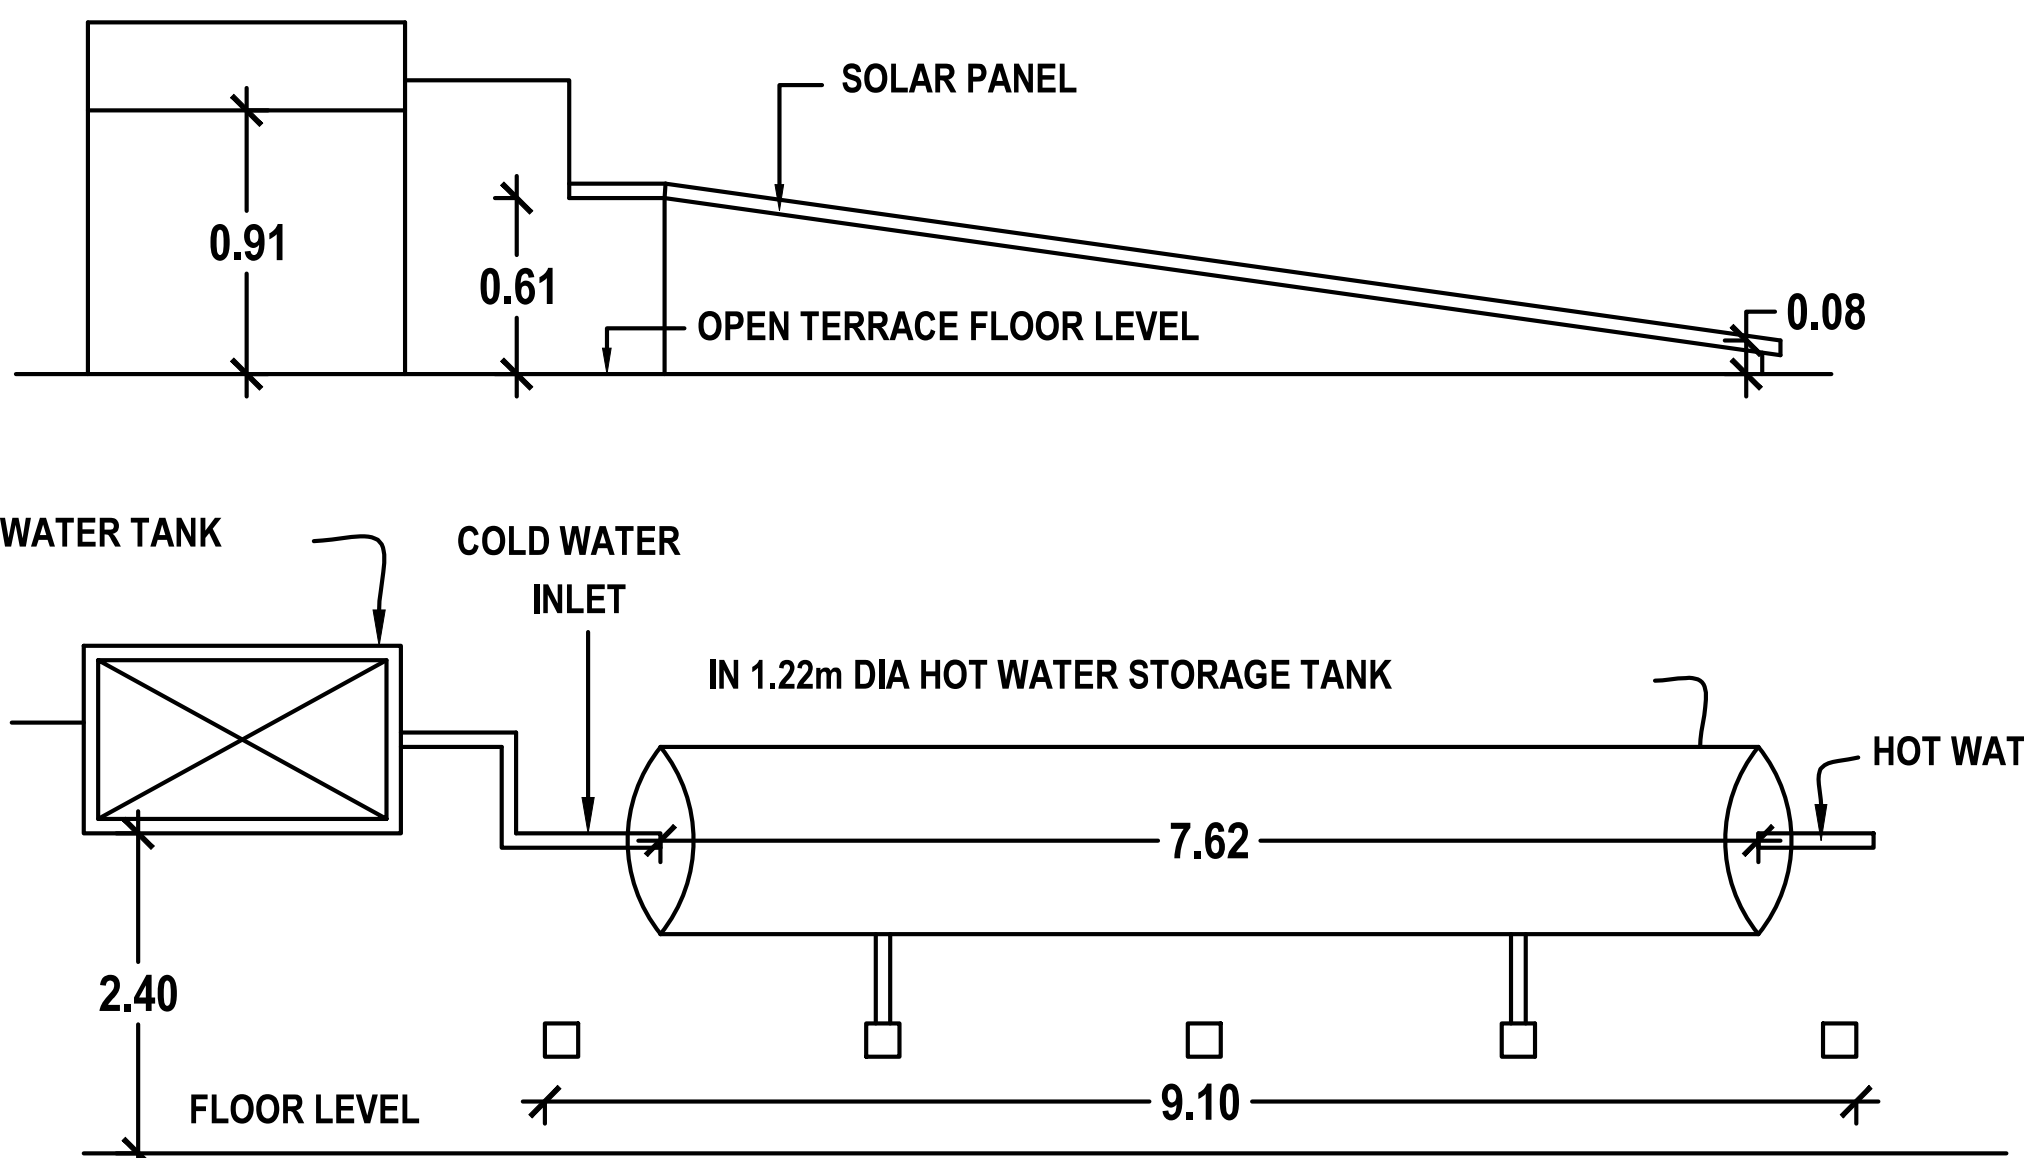

DETAILS OF SOLAR WATER HEATING SYSTEM

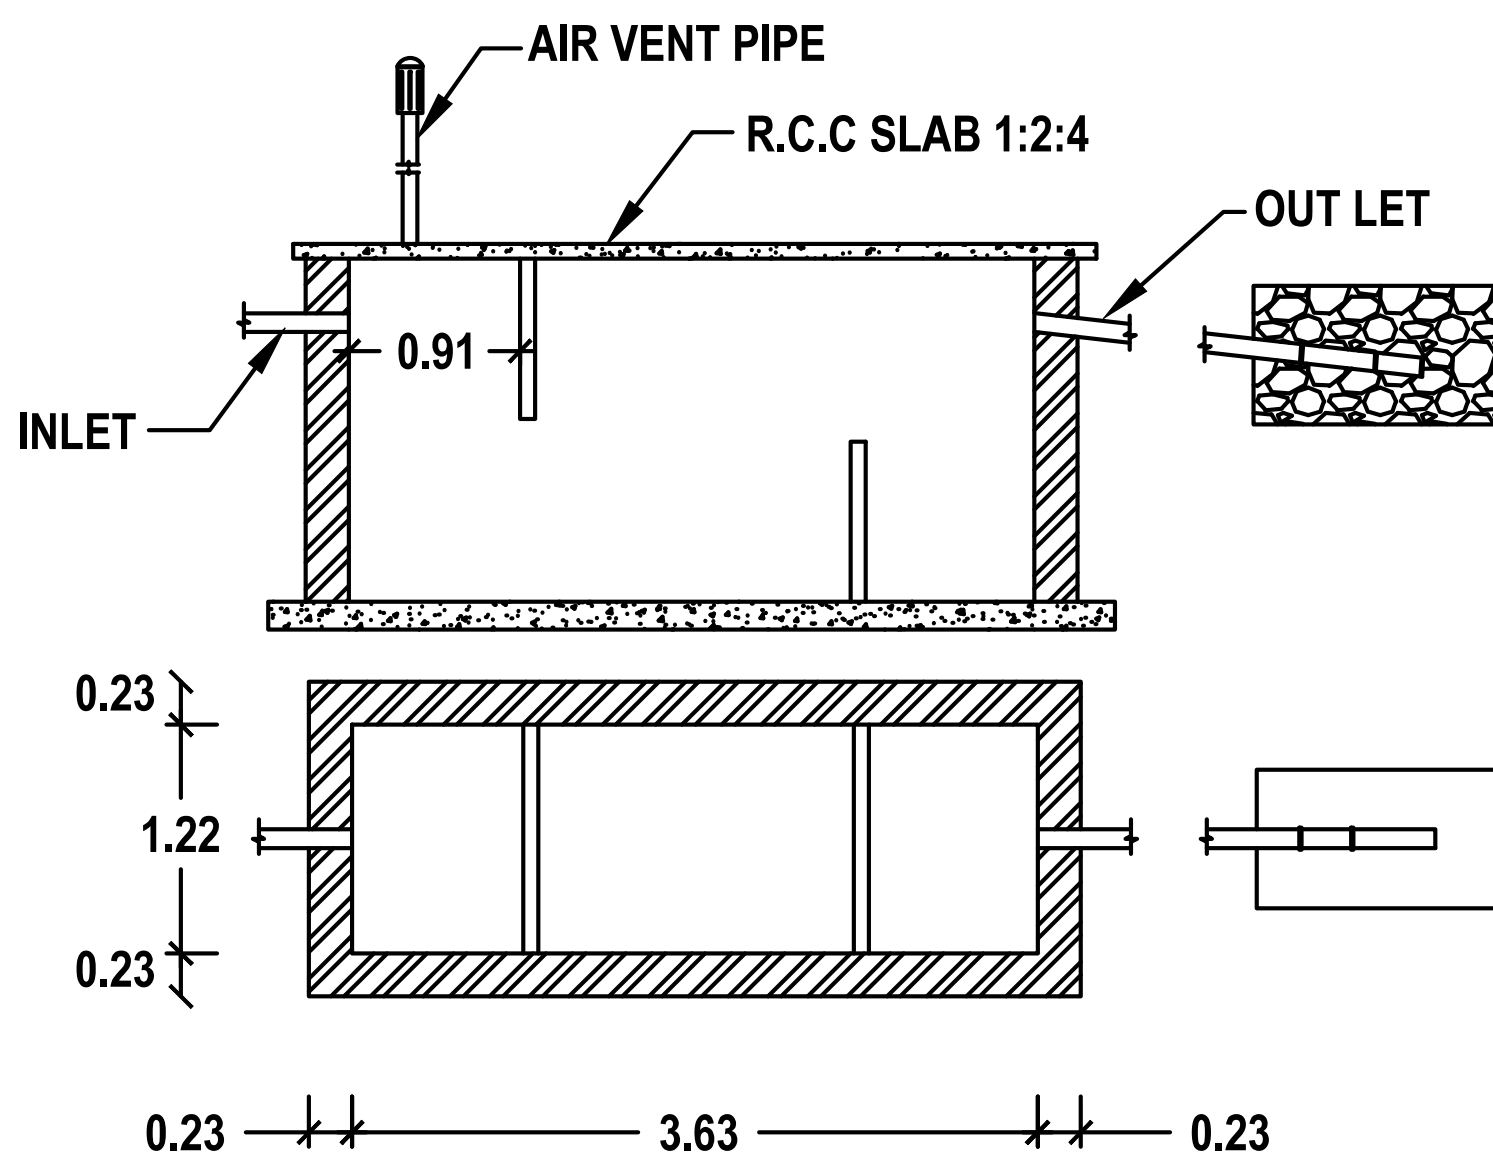

SEPTIC TANK & TRENCH

PLANNING PERMISSION
ROC. NO. SWP/BPA/397807/2024
SITE BOUNDARY SHOWN AS "A TO F"
PLANNING PERMISSION NO. 06/2025 (SWP/TUTY)

SWP/BPA/397807/2024
B.P / DTCP No: 34 / 2025

K. Shankar Narayanan
Er. K. SHANKAR NARAYANAN, B.E., M.Tech.,
Registered Geotech Engineer
RGTE 001 / 2022
VARAHA GEOTECHNICAL WORKS
RAJAPALAYAM - 626 117.

For SIGARAM COLD STORAGE LLP
S. Suresh Kumar
Partner

REGISTERED GEO-TECH ENGINEER

APPLICANT

S.K. Arun Kamaraj
Er.S.K.Arun Kamaraj M.E.(Struct.), M.B.A., M.I.E.,
Chartered Structural Engineer,
Reg: CBELPA-LPA/SE/GR-I/19/05/051
KAARVENS Structural Consultancy,
41, BR Nagar, 3rd Street, Kothari layout,
Ramanathapuram, Coimbatore - 641005.
E: skarun@kaarvens.com W: www.karvens.com
M: +91-9894215019, O: +91-8270005019

S. Suresh Kumar
S. SURESH KUMAR, B.E., M.I.E., F.I.V.,
Chartered Engineer, Approved Valuer,
Consulting Engineer, Registered Engineer Gr. I,
RE / Gr. I / TUT / May 2019 / 001,
District Panel Engineer Class IA,
Licensed Builder and Surveyor,
28, 1st Floor, Tooveyapuram 5th Street,
Thoothukudi - 628 003.

REGISTERED STRUCTURAL ENGINEER

REGISTERED ENGINEER

PLAN SHOWING THE PROPOSED ADDITIONAL CONSTRUCTION IN THE EXISTING DECORTICATING DRY DHALL INDUSTRIAL (GREEN CATEGORY) BUILDING USING 20.00 HP ELECTRICAL POWER IN DOOR NO. 4/54, SURVEY NO. 293/1 & 294/1A, PUTHIYAMPUTHUR ROAD (MELATTHERU), SILLANATTHAM VILLAGE, OTTAPIDARAM TALUK, THOOTHUKUDI DISTRICT.


SHEET NO.

7/8


OFFICE USE:

APPLICANT NAME: M/s. SIGARAM COLD STORAGE LLP


SCALE: 1:100

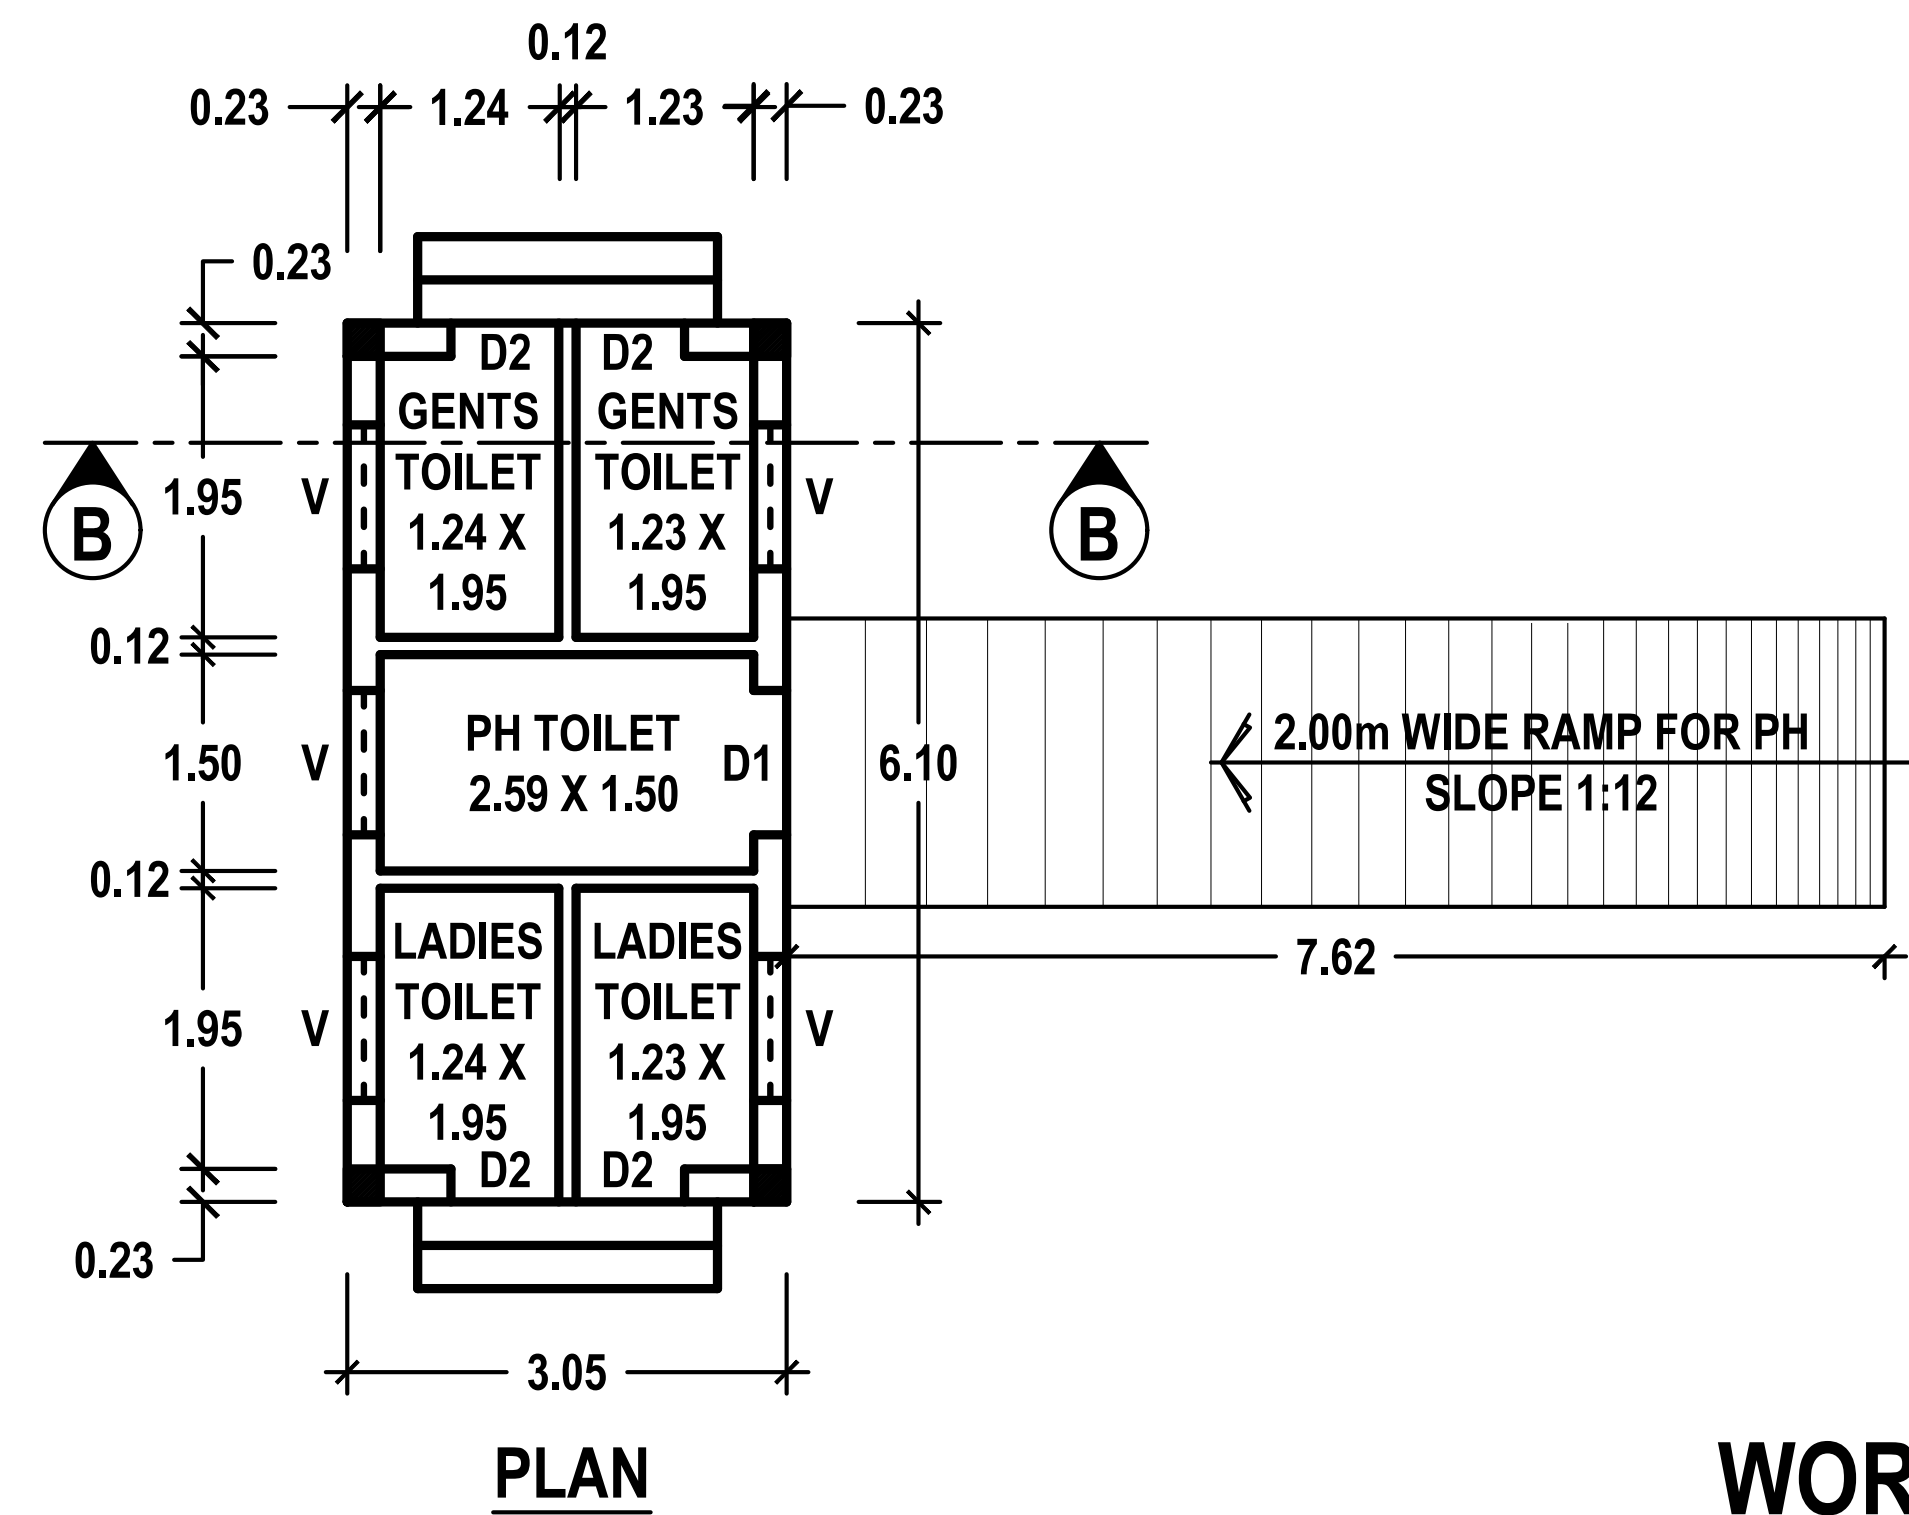


WORKER'S TOILET

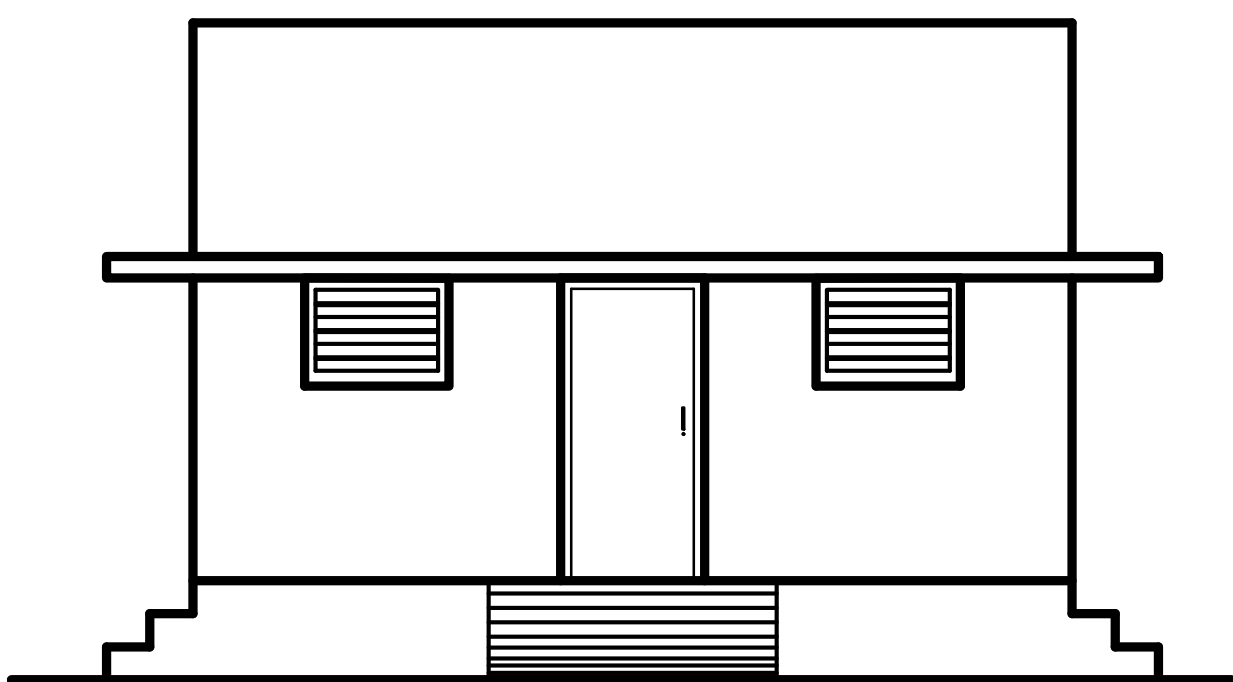


WEST SIDE ELEVATION

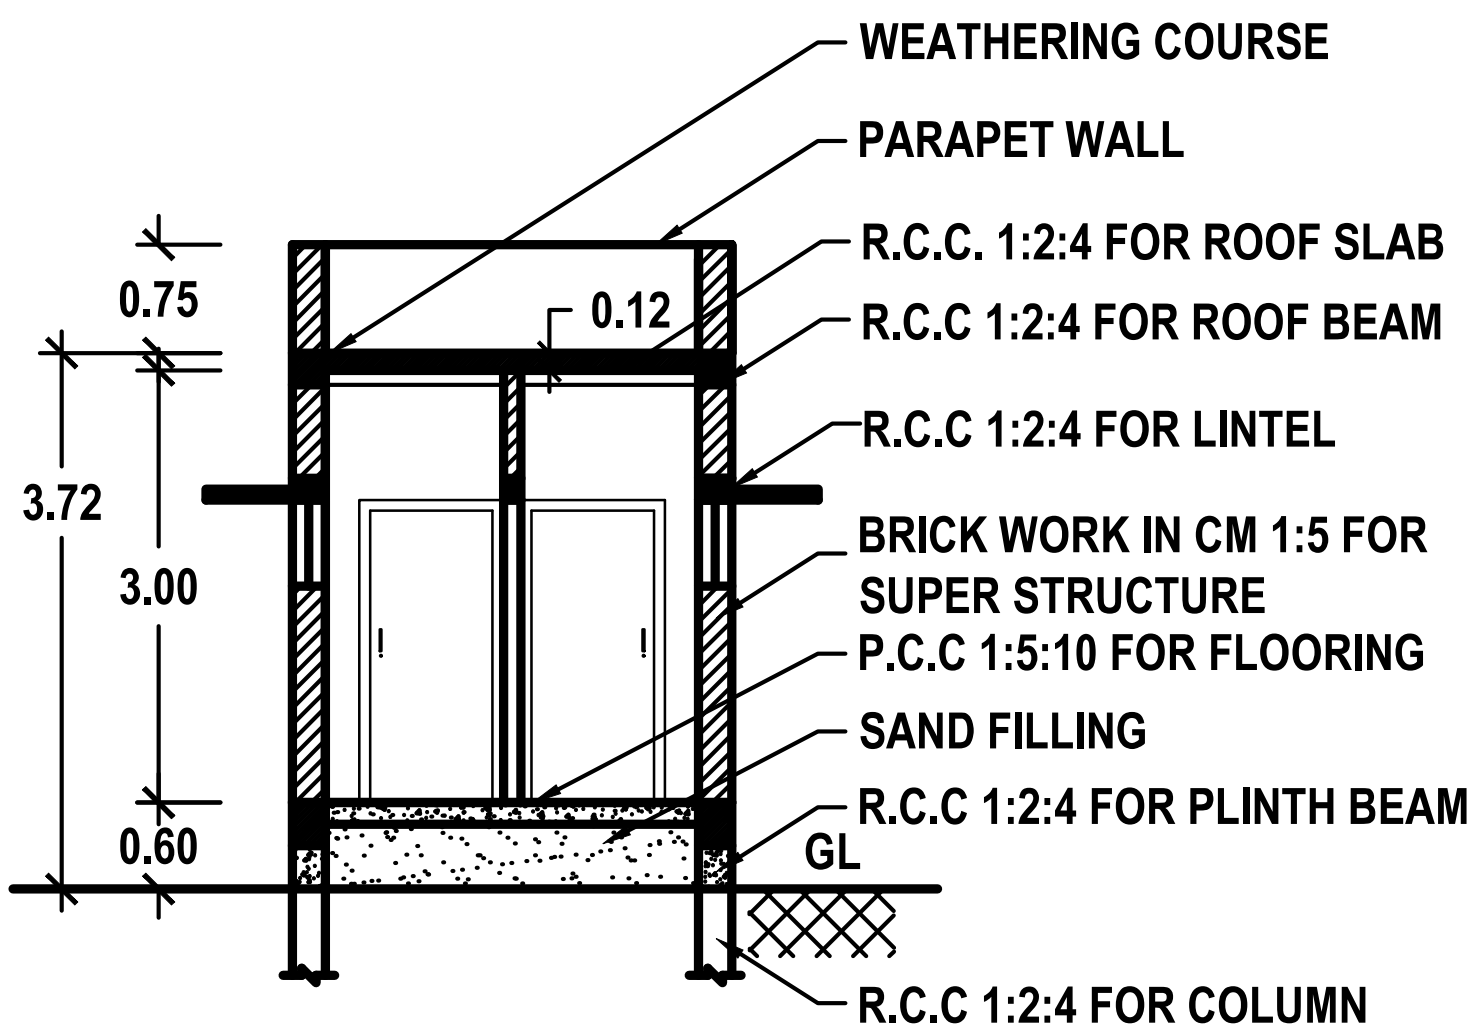


SECTION: E-E

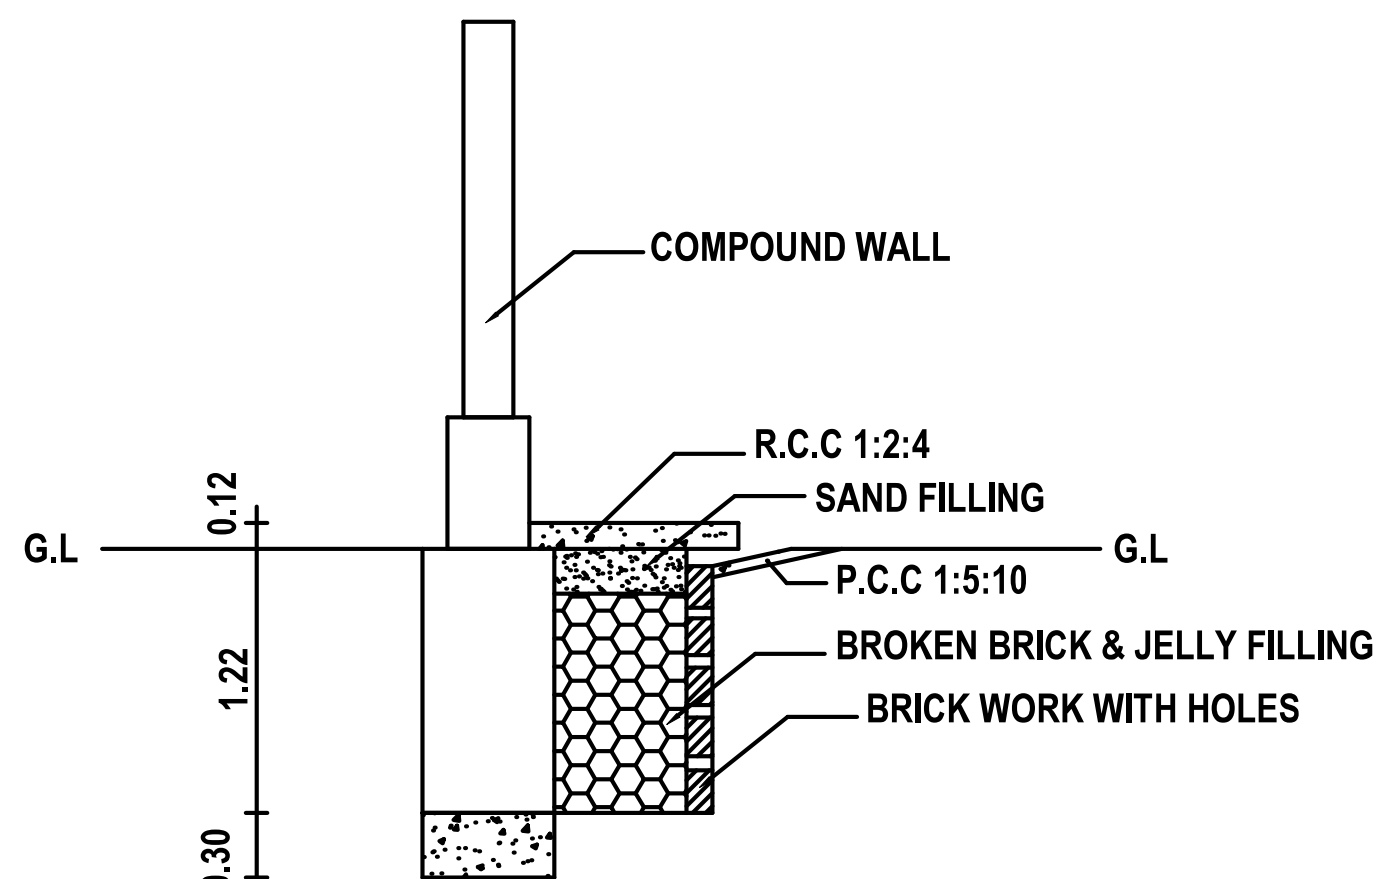

PLINTH BOUNDARY PERCOLATION PIT

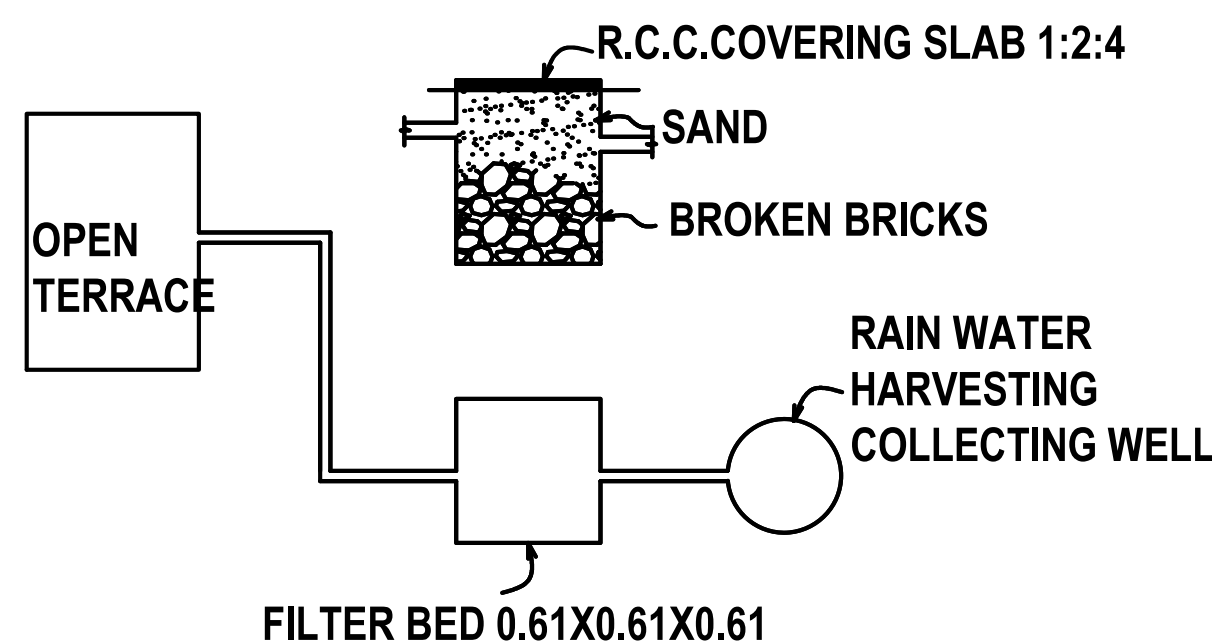


DETAILS OF RAIN WATER HARVESTING SYSTEM

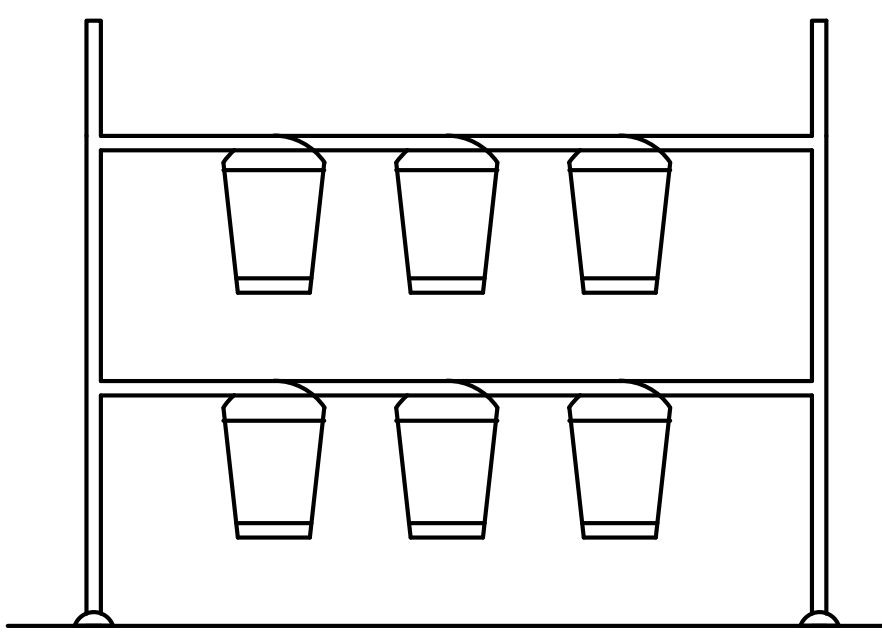


SAND BUCKETS

PLANNING PERMISSION
ROC. NO. SWP/BPA/397807/2024
SITE BOUNDARY SHOWN AS "A TO F"
PLANNING PERMISSION NO. 06/2025 (SWP/TUTY)


SWP/BPA/397807/2024
B.P / DTCP No: 34 / 2025

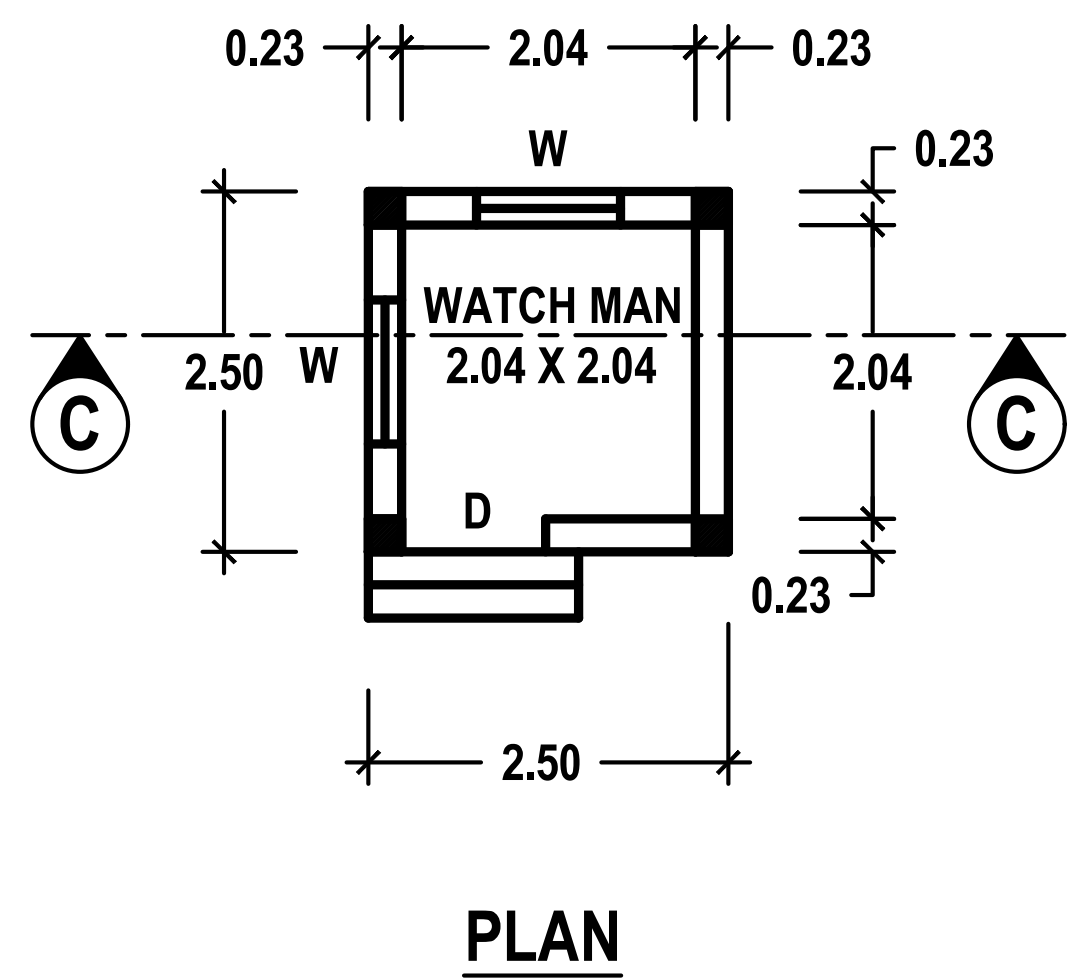


WATCH MAN BOOTH

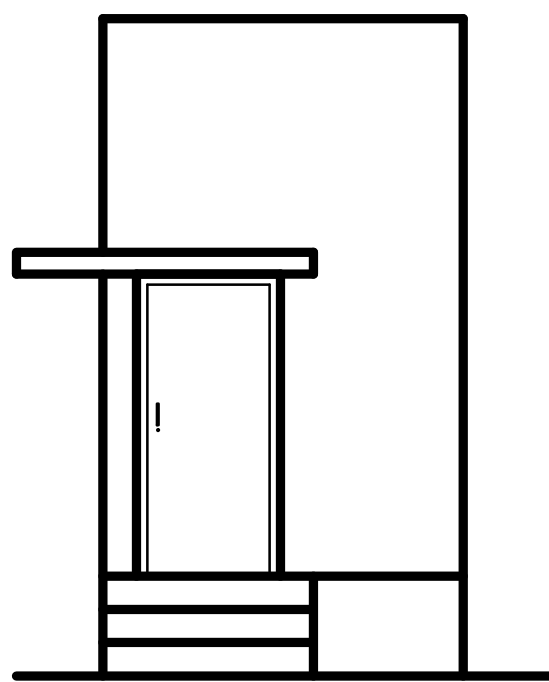


ELEVATION

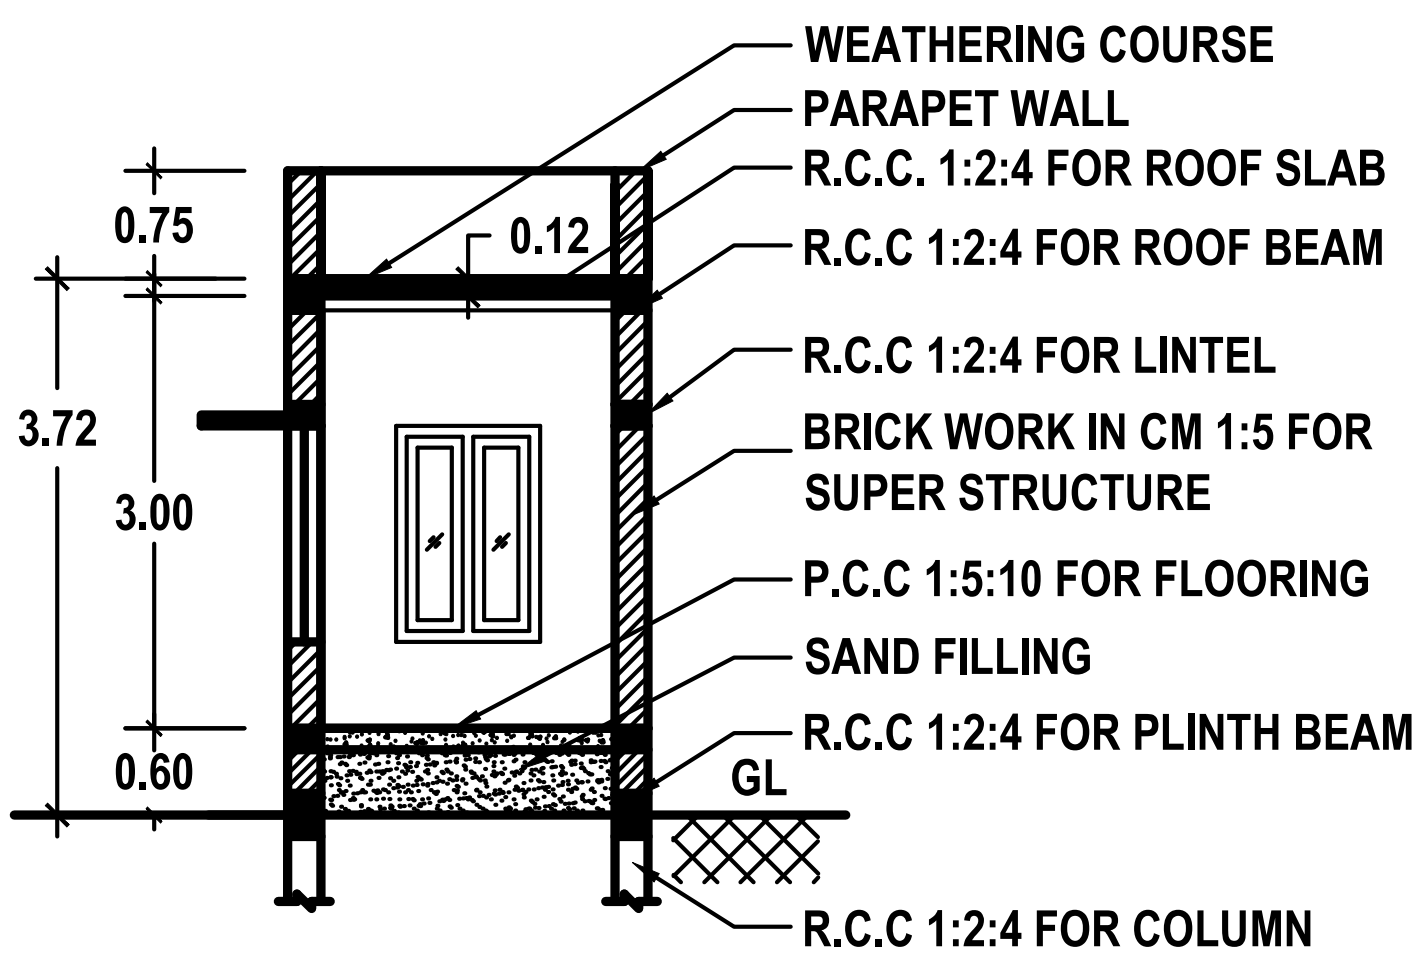


SECTION: F-F

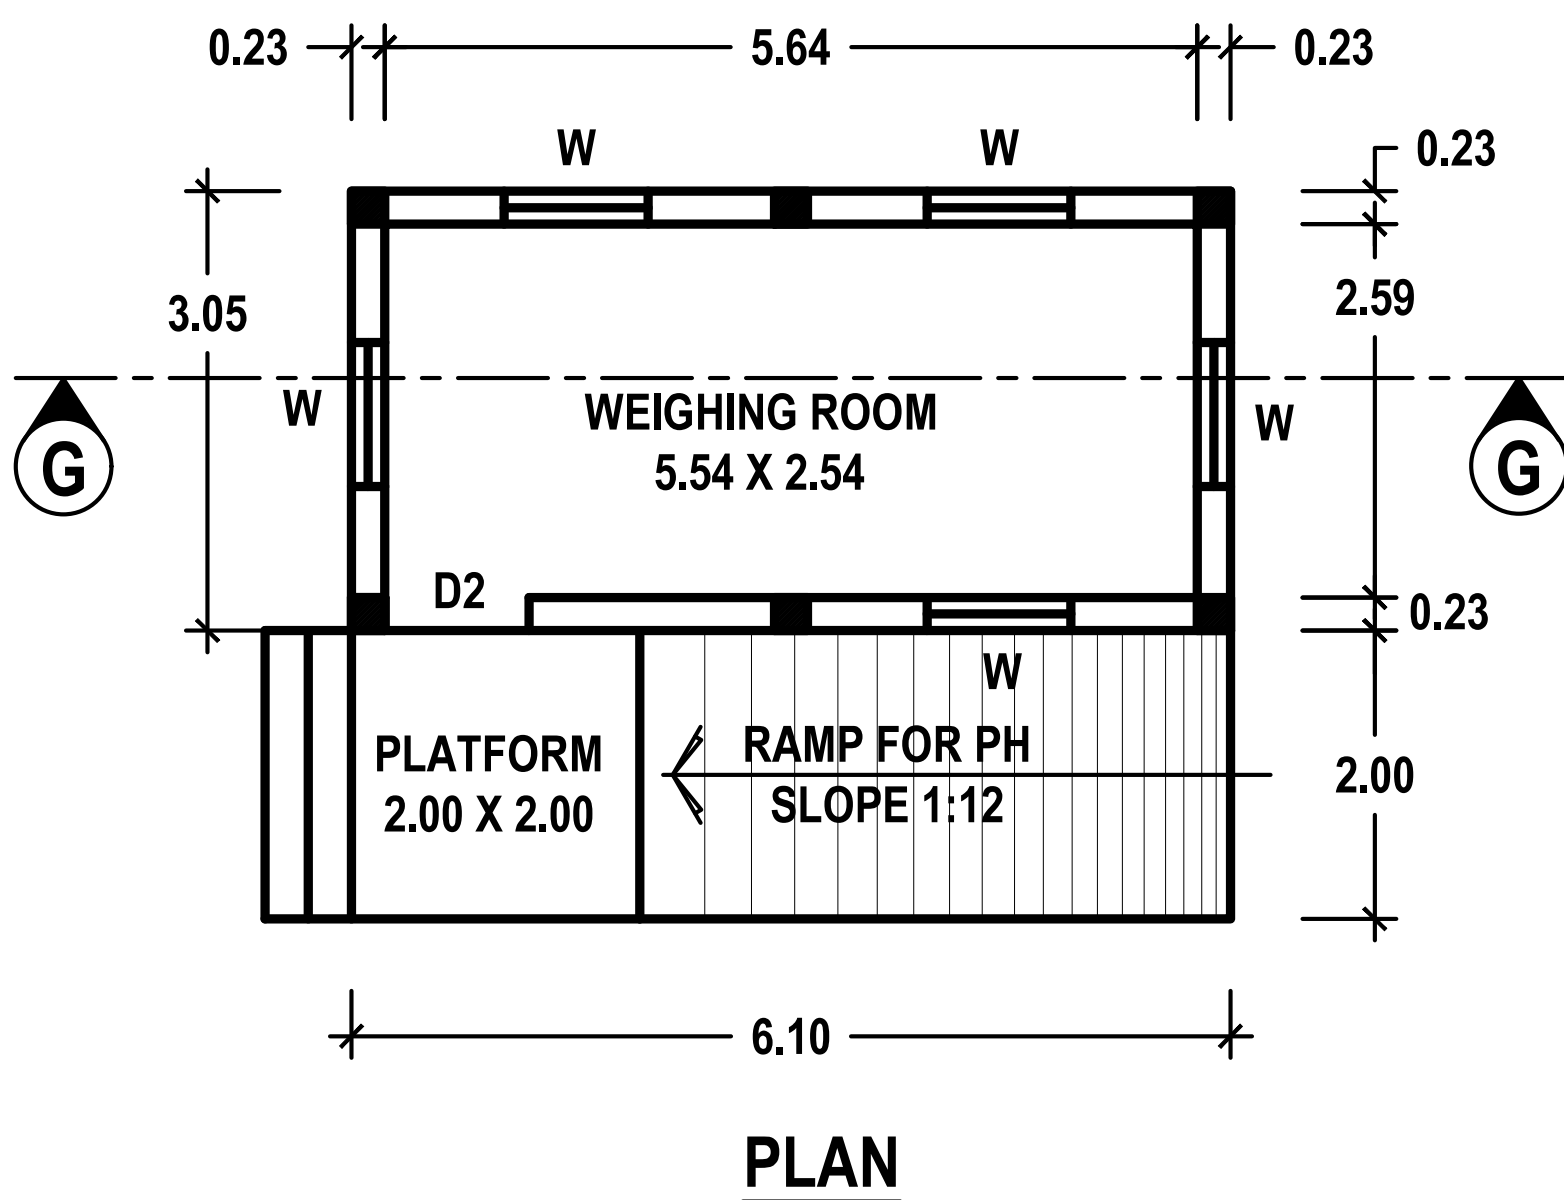

WEIGHING ROOM

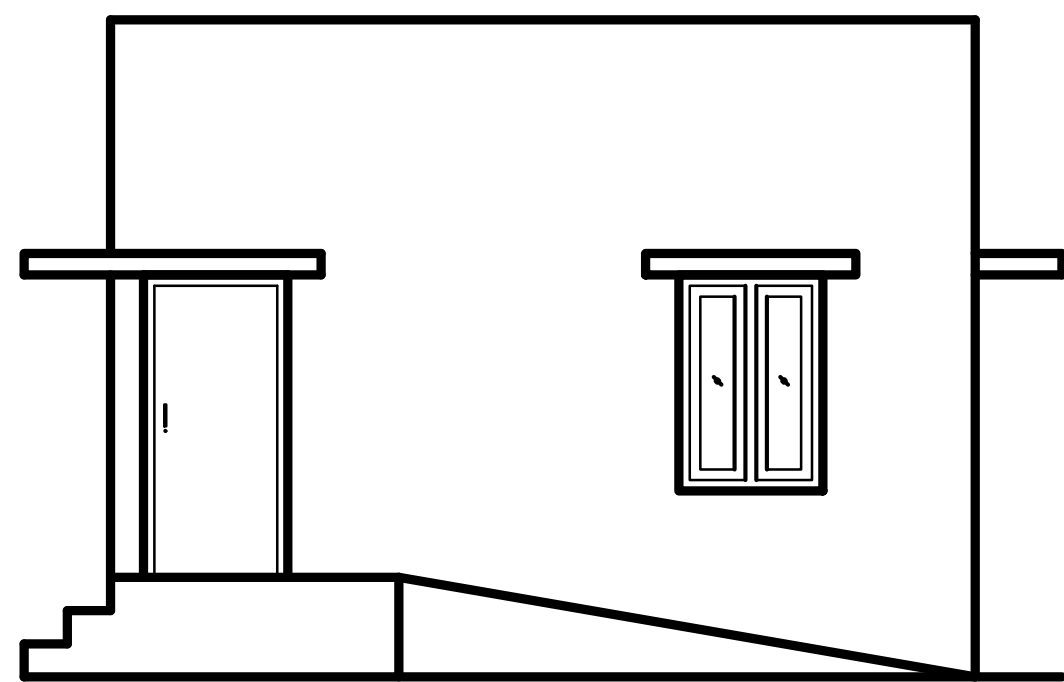

ELEVATION

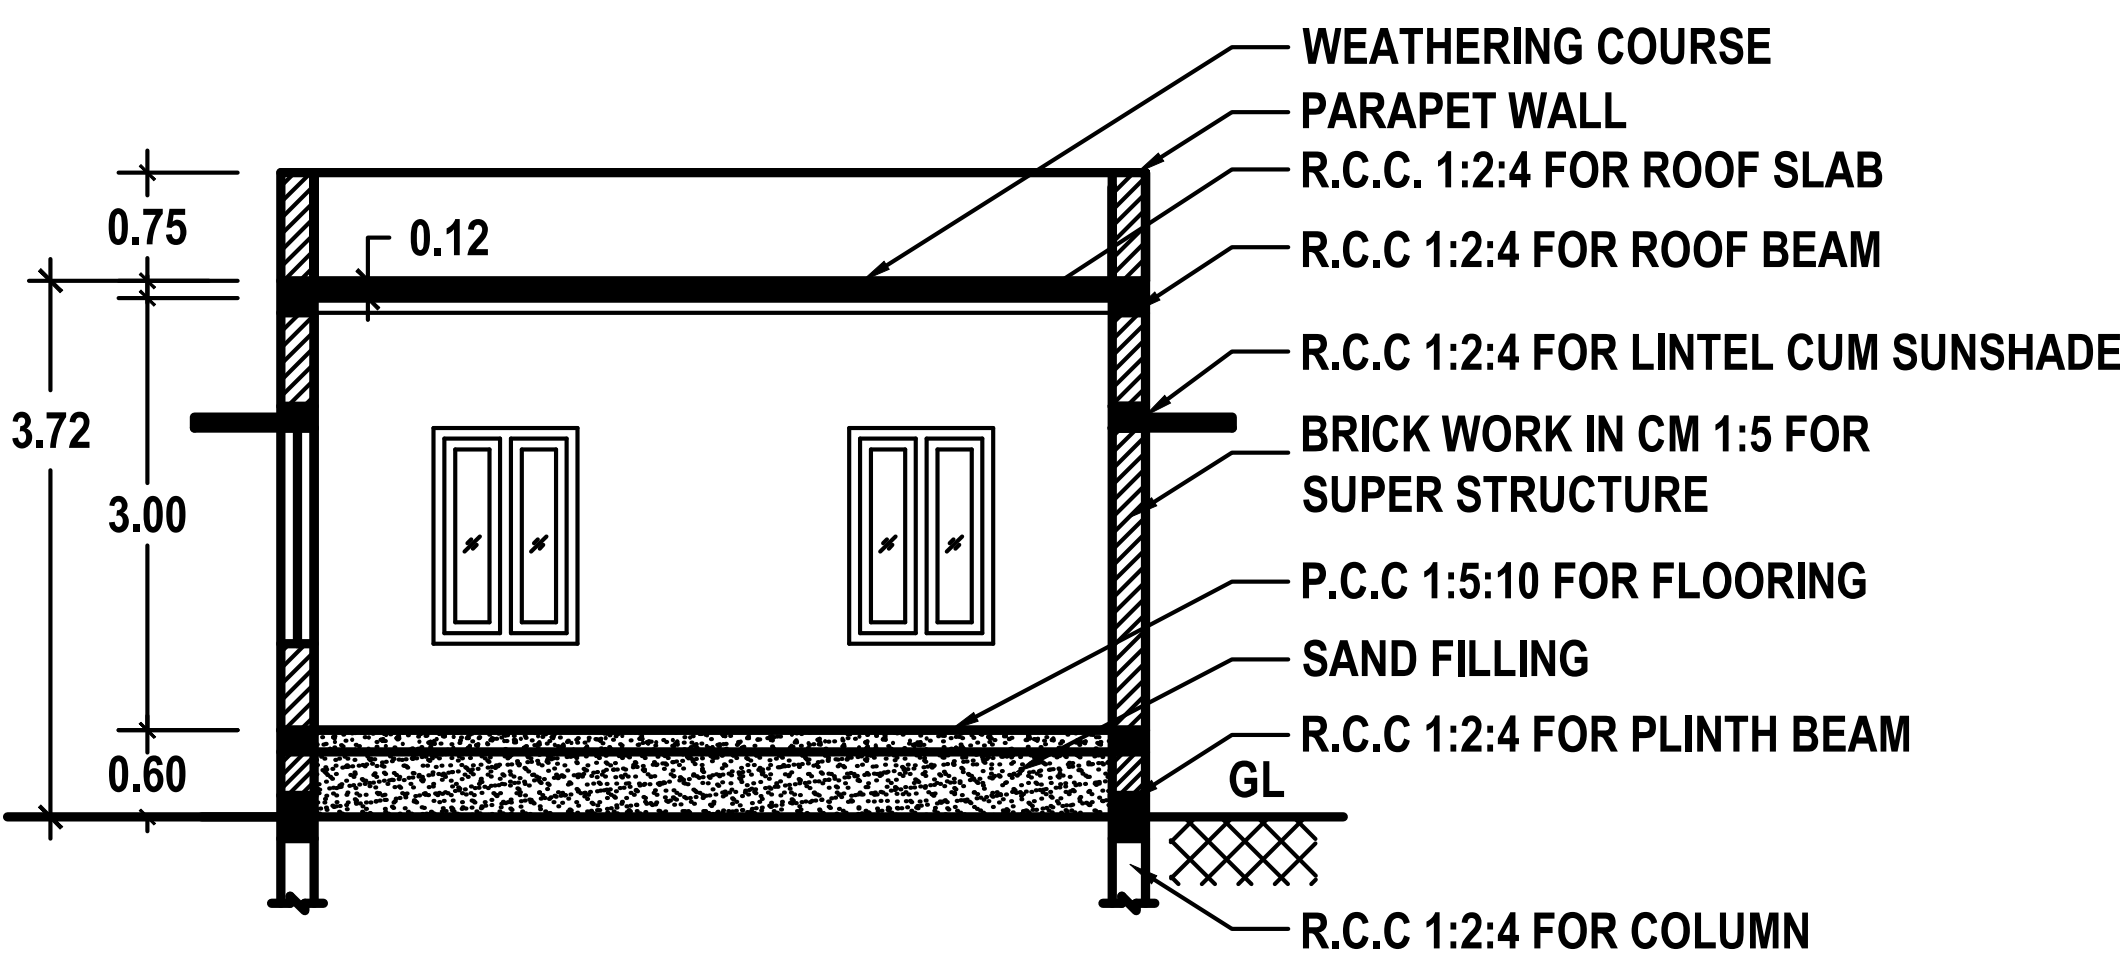

SECTION: G - G

K. Shankar Narayanan
Er. K. SHANKAR NARAYANAN, B.E., M.Tech.,
Registered Geotech Engineer
RGTE 001 / 2022
VARAHA GEOTECHNICAL WORKS
RAJAPALAYAM - 626 117.

For SIGARAM COLD STORAGE LLP

S. Suresh Kumar
Partner

REGISTERED GEO-TECH ENGINEER

APPLICANT

S.K. Arun Kamaraj
Er. S.K. Arun Kamaraj M.E. (Struct.), MBA, MIE.,
Chartered Structural Engineer,
Reg: CBELPA-LPA/SE/GR-I/19/05/051
KAARVENS Structural Consultancy,
41, BR Nagar, 3rd Street, Kothari layout,
Ramanathapuram, Coimbatore - 641005.
E: skarun@kaarvens.com W: www.karvens.com
M: +91-9894215019, O: +91-8270005019


S. Suresh Kumar
S. SURESH KUMAR, B.E., M.I.E., F.I.V.,
Chartered Engineer, Approved Valuer,
Consulting Engineer, Registered Engineer Gr. I,
RE / Gr. I / TUT / May 2019 / 001,
District Panel Engineer Class IA,
Licensed Builder and Surveyor,
28, 1st Floor, Tooveyapuram 5th Street,
Thoothukudi - 628 003.

REGISTERED STRUCTURAL ENGINEER

REGISTERED ENGINEER

SITE PLAN SHOWING THE PROPOSED ADDITIONAL CONSTRUCTION IN THE EXISTING DECORTICATING DRY DHALL INDUSTRIAL (GREEN CATEGORY) BUILDING USING 20.00 HP ELECTRICAL POWER IN DOOR NO. 4/54, SURVEY NO. 293/1 & 294/1A, PUTHIYAMPUTHUR ROAD (MELATTHERU), SILLANATTHAM VILLAGE, OTTAPIDARAM TALUK, THOOTHUKUDI DISTRICT.

APPLICANT NAME: M/s. SIGARAM COLD STORAGE LLP

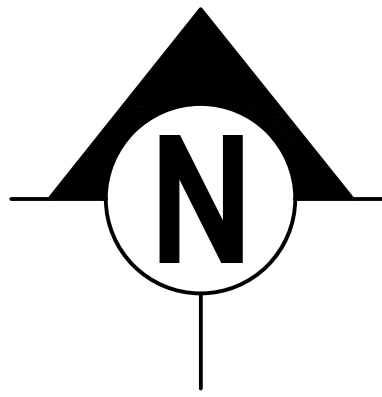

SHEET NO.

8/8

SCALE: 1:500

OFFICE USE:

PLANNING PERMISSION
ROC. NO. SWP/BPA/397807/2024
SITE BOUNDARY SHOWN AS "A TO F"
PLANNING PERMISSION NO. 06/2025 (SWP/TUTY)

SITE AREA DETAILS AS PER SALE DEED

S. NO.	DOCUMENT NUMBER & YEAR	SURVEY NUMBER	AREA in	
			Sqm	Acre
1.	2605/2024	294/1A PART	2187.00	0.540
2.	2606/2024	294/1A PART	8016.00	1.980
3.	2607/2024	293/1 PART	7571.00	1.870
4.	2608/2024	293/1 PART & 294/1A PART	5588.00	1.380
5.	2609/2024	293/1 PART & 294/1A PART	5588.00	1.380
TOTAL			28950.00	7.150

SITE AREA DETAILS AS PER PATTI

S. NO.	PATTI NUMBER	SURVEY NUMBER	AREA in	
			Sqm	Acre
1.	1437	293/1	14900.00	3.680
2.	1436	294/1A	14050.00	3.470
TOTAL			28950.00	7.150

BUILD UP AREA DETAILS

BLOCK NO.	DESCRIPTION	FSI AREA	NON FSI AREA	AREA in Sqm	AREA in Sq. Ft
AREA OF THE SITE		----	----	28950.00	311617.80

EXISTING APPROVED BUILDING

1	WORK SHED	1883.42	----	1883.42	20273.13
TOTAL		1883.42	----	1883.42	20273.13

PROPOSED BUILDING

2	WORK SHED - 1	3907.05	----	3907.05	42055.49
3	WORK SHED - 2	2790.75	----	2790.75	30039.63
4	WORK SHED - 3	1860.50	----	1860.50	20026.42
5	OFFICE	189.00	----	189.00	2034.40
6	WEIGHING ROOM	18.61	----	18.61	200.32
7	WORKER'S TOILET	----	18.61	18.61	200.32
8	WATCH MAN BOOTH	----	6.25	6.25	67.28
TOTAL		8765.91	24.86	8790.77	94623.86
GRAND TOTAL		10649.33	24.86	10674.19	114896.99

TOTAL AREA OF ALL FLOORS = 10649.33
FSI = $\frac{10649.33}{28950.00} = 0.368 < 2.00$

PARKING DETAILS FOR MANUFACTURING INDUSTRIES

1 CAR SPACE FOR EVERY 100 Sqm OF OFFICE FLOOR AREA

1 TWO WHEELER SPACE AND 1 CYCLE SPACE FOR

EVERY 50 Sqm OF WORKSHOP FLOOR AREA

1 LORRY SPACE FOR EVERY 500 Sqm OF WORKSHOP FLOOR AREA

STALL SIZE FOR PARKING		SET BACK DETAILS		
DESCRIPTION	REQUIRED	REQUIRED	PROVIDED	
1 CYCLE SPACE	- 0.58m X 1.80m	FRONT	6.00	24.20
1 TWO WHEELER SPACE	- 1.00m X 1.80m	SIDE - 1	3.00	6.00
1 CAR SPACE	- 2.50m X 5.00m	SIDE - 2	3.00	23.15
1 CAR SPACE FOR PH	- 3.60m X 5.00m	REAR	2.00	6.00
1 LORRY SPACE	- 3.50m X 10.00m			

PARKING DETAILS FOR FSI

DESCRIPTION	AREA	REQUIRED	PROVIDED
EXISTING AND PROPOSED BUILDING	10460.33	210 LORRIES 210 TWO WHEELERS 210 CYCLES	25 LORRIES 5 CARS 220 TWO WHEELERS 220 CYCLES
OFFICE	189.00	2 CAR	


For SIGARAM COLD STORAGE LLP


Partner

APPLICANT


Er. K. SHANKAR NARAYANAN, B.E., M.Tech.,
Registered Geotech Engineer
RGTE 001 / 2022
VARAHA GEOTECHNICAL WORKS
RAJAPALAYAM - 626 117.


REGISTERED GEO-TECH ENGINEER

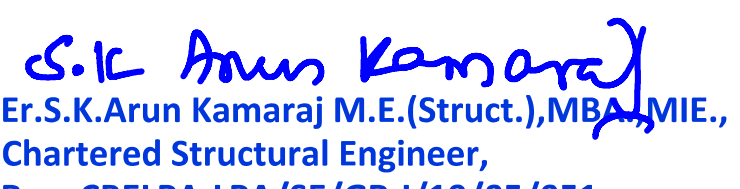
Er. S.K. Arun Kumaraj M.E. (Struct.), M.B.A., MIE.,
Chartered Structural Engineer,
Reg: CBELPA-LPA/SE/GR-I/19/05/051
KAARVENS Structural Consultancy,
41, BR Nagar, 3rd Street, Kothari layout,
Ramanathapuram, Coimbatore - 641005.
E: skarun@kaarvens.com W: www.kaarvens.com
M: +91-9894215019, O: +91-8270005019

REGISTERED STRUCTURAL ENGINEER





S. SURESH KUMAR, B.E., M.E., F.I.V.,
Chartered Engineer, Approved Valuer,
Consulting Engineer, Registered Engineer Gr. I,
RE / Gr. I / TUT / May 2019 / 001,
District Panel Engineer Class IA,
Licensed Builder and Surveyor,
28, 1st Floor, Tooveypram 5th Street,
Thoothukudi - 628 003.

REGISTERED ENGINEER

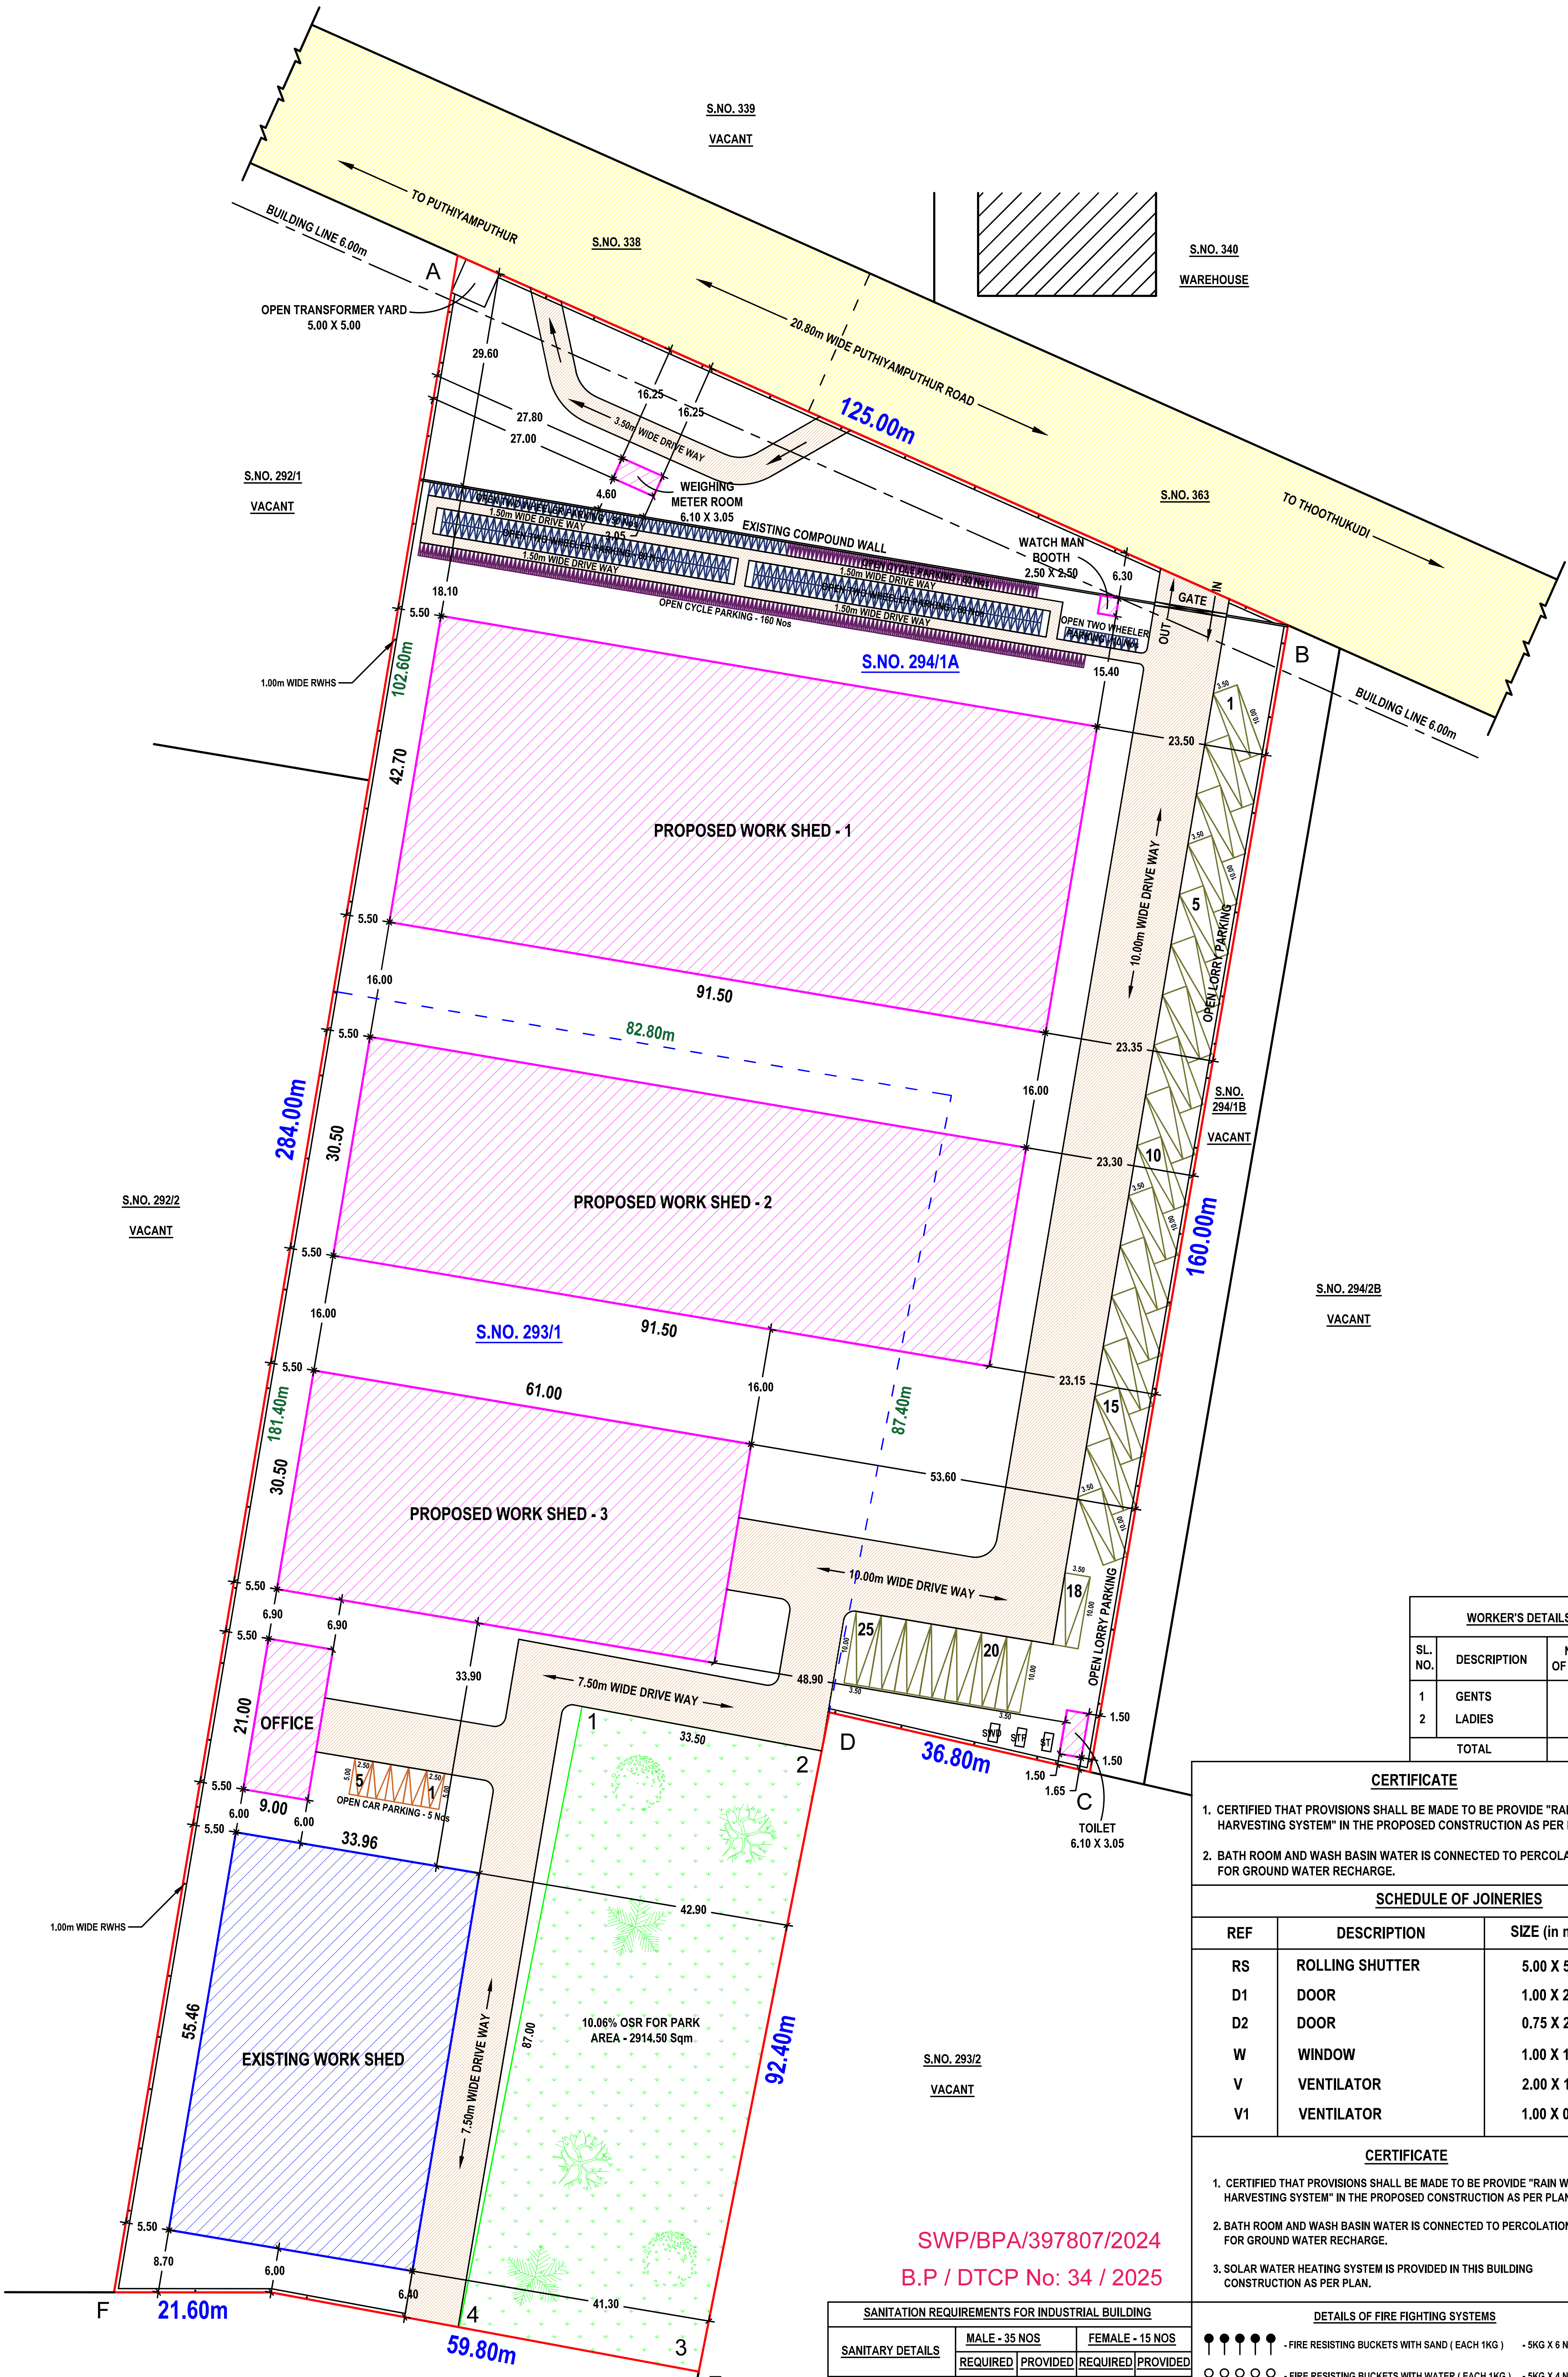

SWP/BPA/397807/2024
B.P / DTCP No: 34 / 2025

SANITATION REQUIREMENTS FOR INDUSTRIAL BUILDING					
SANITARY DETAILS		MALE - 35 NOS		FEMALE - 15 NOS	
		REQUIRED	PROVIDED	REQUIRED	PROVIDED
WATER CLOSET		2	3	2	2
ABLUTION TAP		2	3	2	2
URINAL		2	3	-	-
WASHING TAP		2	3	1	2
DRINKING WATER		1	2	1	1
BATH		-	-	-	-
EMERGENCY SHOWER		1	2	1	1

   DETAILS OF FIRE FIGHTING SYSTEMS		
	- FIRE RESISTING BUCKETS WITH SAND (EACH 1KG)	- 5KG X 6 NOS = 30 KG
	- FIRE RESISTING BUCKETS WITH WATER (EACH 1KG)	- 5KG X 4 NOS = 20 KG
	- CO - CARBON DIOXIDE TYPE FIRE EXTINGUISHER	- 2KG X 10 NOS = 20 KG
	- DCP DRY CHEMICAL TYPE FIRE EXTINGUISHER	- 5KG X 6 NOS = 30 KG
	- FA - FIRE ALARM	= 4 NOS
	- SPRINKLER SYSTEM TO BE PROVIDED	
	- FIRE HYDRANT SYSTEM TO BE PROVIDED	
	- HOSE REEL SYSTEM TO BE PROVIDED	

- NOTE:
- EXISTING APPROVED BUILDING
 - PLANNING PERMISSION NO. 04/2015, DATED. 20-03-2015
 - BUILDING PERMISSION NO. 01/2015-2016, DATED. 09-04-2015
 - ALL DIMENSIONS ARE IN METER.
 - CENTRALIZED AIR-CONDITION SYSTEM TO BE PROVIDED.
 - OPEN TRANSFORMER YARD - 5.00M X 5.00M
 - NUMBER OF WORKERS INVOLVED - 50 PERSONS.

ELECTRICAL POWER DETAILS			REFERENCE	
SL. NO.	DESCRIPTION	POWER (in HP)	DESCRIPTION	COLOUR
1	WEIGHING MACHINE (1.00 HP) - 3 Nos	3	APPLICANT SITE	
2	GRINDING MACHINE (1.00 HP) - 5 Nos	5	EXISTING APPROVED BUILDING	
	CRACKING MACHINE (2.00 HP) - 5 Nos	10	PROPOSED BUILDING	
	PRINTING MACHINE (2.00 HP) - 1 No	2	OSR FOR PARK (10.06%) - 2914.50 Sqm	
TOTAL		20	DRIVE WAY	
			EXISTING BUILDING	
			EXISTING ROAD	

Signed by: Director
Location: null
Date: 2025-04-22 10:57:36

Signature valid