

SHEET NO.1



B.P/DTCP No: 206/2024

Block01

REFERENCES:	METRES
RS -ROLLING SHUTTER	3.50 X 3.65
GW - GRILL WINDOW	6.00 X 2.00
GW1 -GRILL WINDOW	4.00 X 2.00
GW2 -GRILL WINDOW	1.22 X 2.00
GW3 -GRILL WINDOW	6.00 X 1.37
GW4 -GRILL WINDOW	4.00 X 1.37
V1 - VENTILATOR	0.91 X 0.61
J -JALLY	2.93 X 1.50
D - DOOR	1.52 X 2.10
D1 -DOOR	0.90 X 2.10
D2 - DOOR	0.76 X 2.10
GD - GRILL DOOR	1.06 X 1.98

GROUND FLOOR AREA - 787.37M²
FIRST FLOOR AREA - 787.37 M²
HEAD ROOM AREA - 24.86 M²

Δ_{FE}	FIRE EXTINGUISHER	SCALE 1:100
---------------	-------------------	-------------

APPLICANT

For **SHIVA AUTOMOBILES (P) LTD.**

S.V. [Signature]
Director

GEO-TECH ENGINEER

D.S. Senthil Kumar, P.E., M.E., Ph.D., FGS, MIE,
Registered Geotechnical Engineer,
(TJR/RGE/2019/096), Chartered Engineer,
703, Plot No.29, O.M. Rajoo Nagar,
Near New Bus Stand, THANJAVUR-613 005.

CONSTRUCTION ENGINEER


SR. MARINER/STRUCTURAL ENGINEER
CONSULTING STRUCTURAL ENGINEER
Corporation BLS No: 086/LS/2021/00012
Registered Engineer
Reg. No: RE/Gr./TLPA/Apr2019/016 on 24.04.2019
Registered Structural Engineer
Reg.No. SE/Gr./I/TLPA/June2019/120
BASUVARAJ BUILDING, THILLAINGAR,
THIRUCHI - 670 018. Cell: 9443059910



ARCHITECT:

DR. K. MARUTHI NATH, Structural Engineer
CONSULTING STRUCTURAL ENGINEER
Corporation BLS No: 086/JS/2011/00012
Registered Engineer
Reg. No: RE/Gr./TLPA/Apr2019/016 on 24.04.2019
Registered Structural Engineer
Reg.No. SE/Gr./H./TLPA/June2019/120
BASUVARAJ BUILDING, THILLAIANGAR,
TRICHY - 670 018. Cell: 94430 59910

**STRUCTURAL ENGINEER/
REGISTER ENGINEER :**

Basuvaraj Building, Thillainagar, Trichy
CONSULTING STRUCTURAL ENGINEER
Corporation BIS No: 086/LS/2021/00012
Registered Engineer
Reg No: RE/Gt.II/TI/PA/Apr2019/016 on 24.04.2019
Registered Structural Engineer
Regn.No:SE/Gt.II/TI/PA/June2019/120
**BASUVARAJ BUILDING, THILLAINAGAR,
TRICHY - 620 018. Cell: 94430 59910**

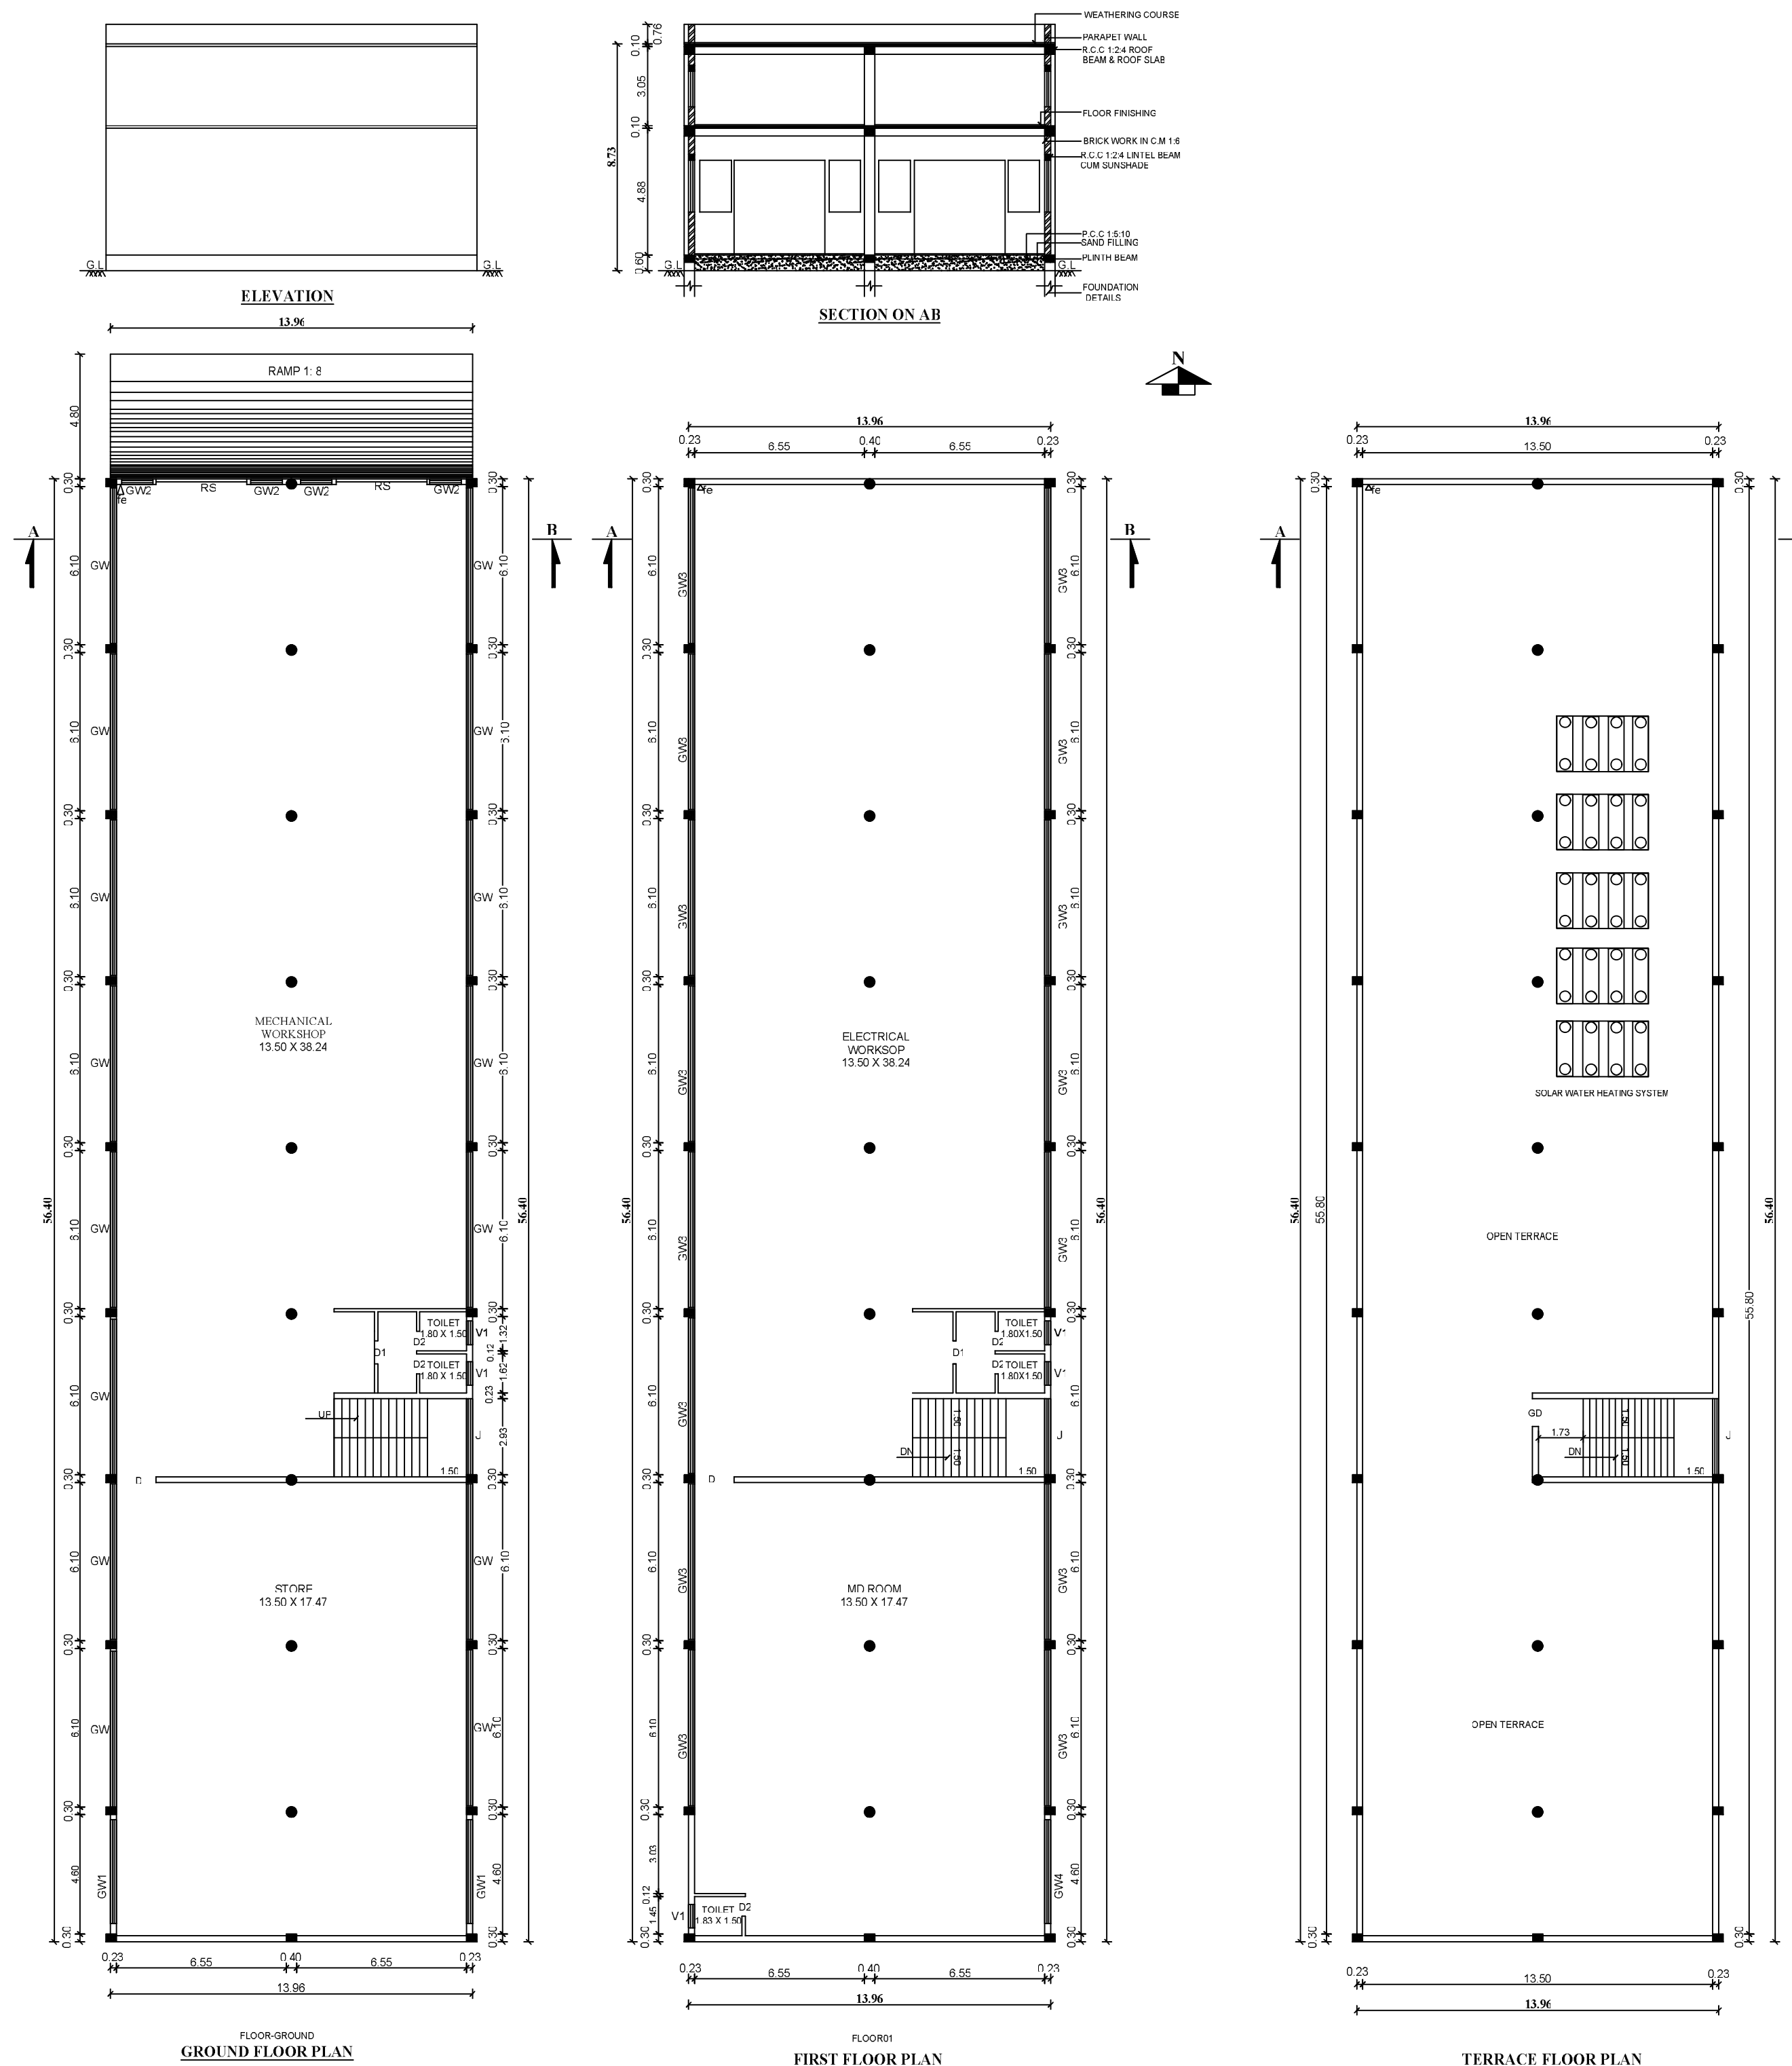

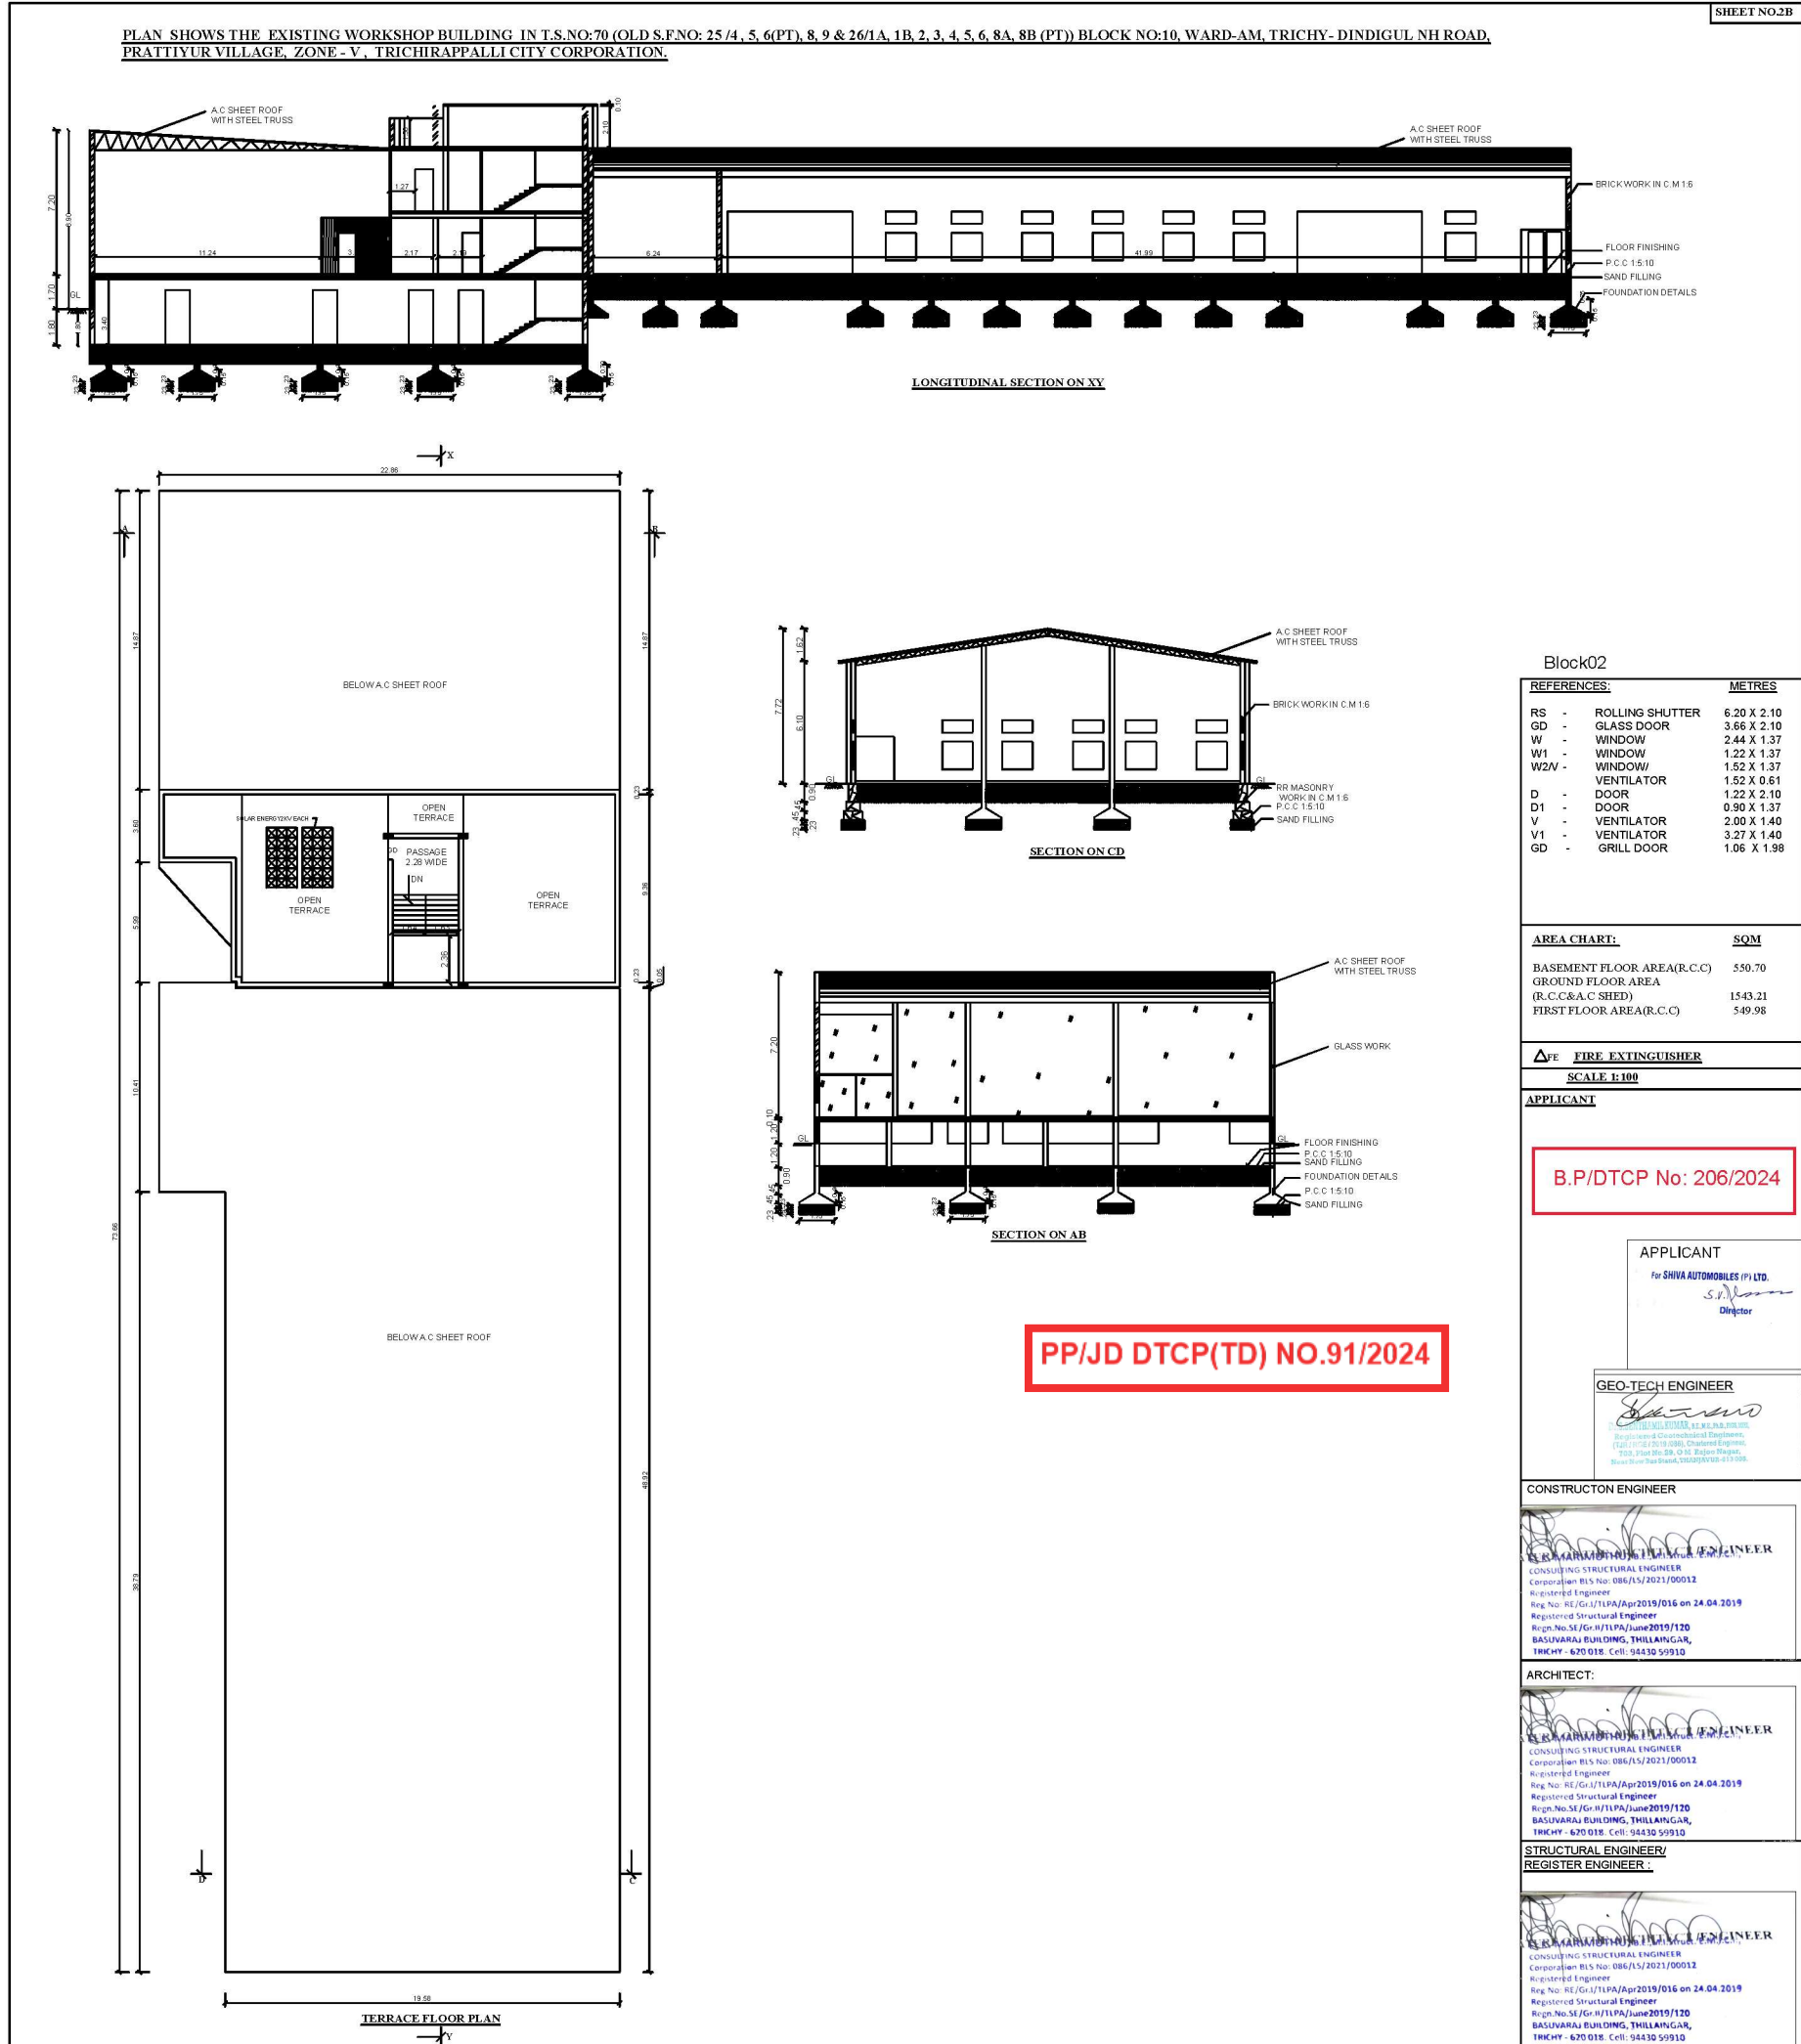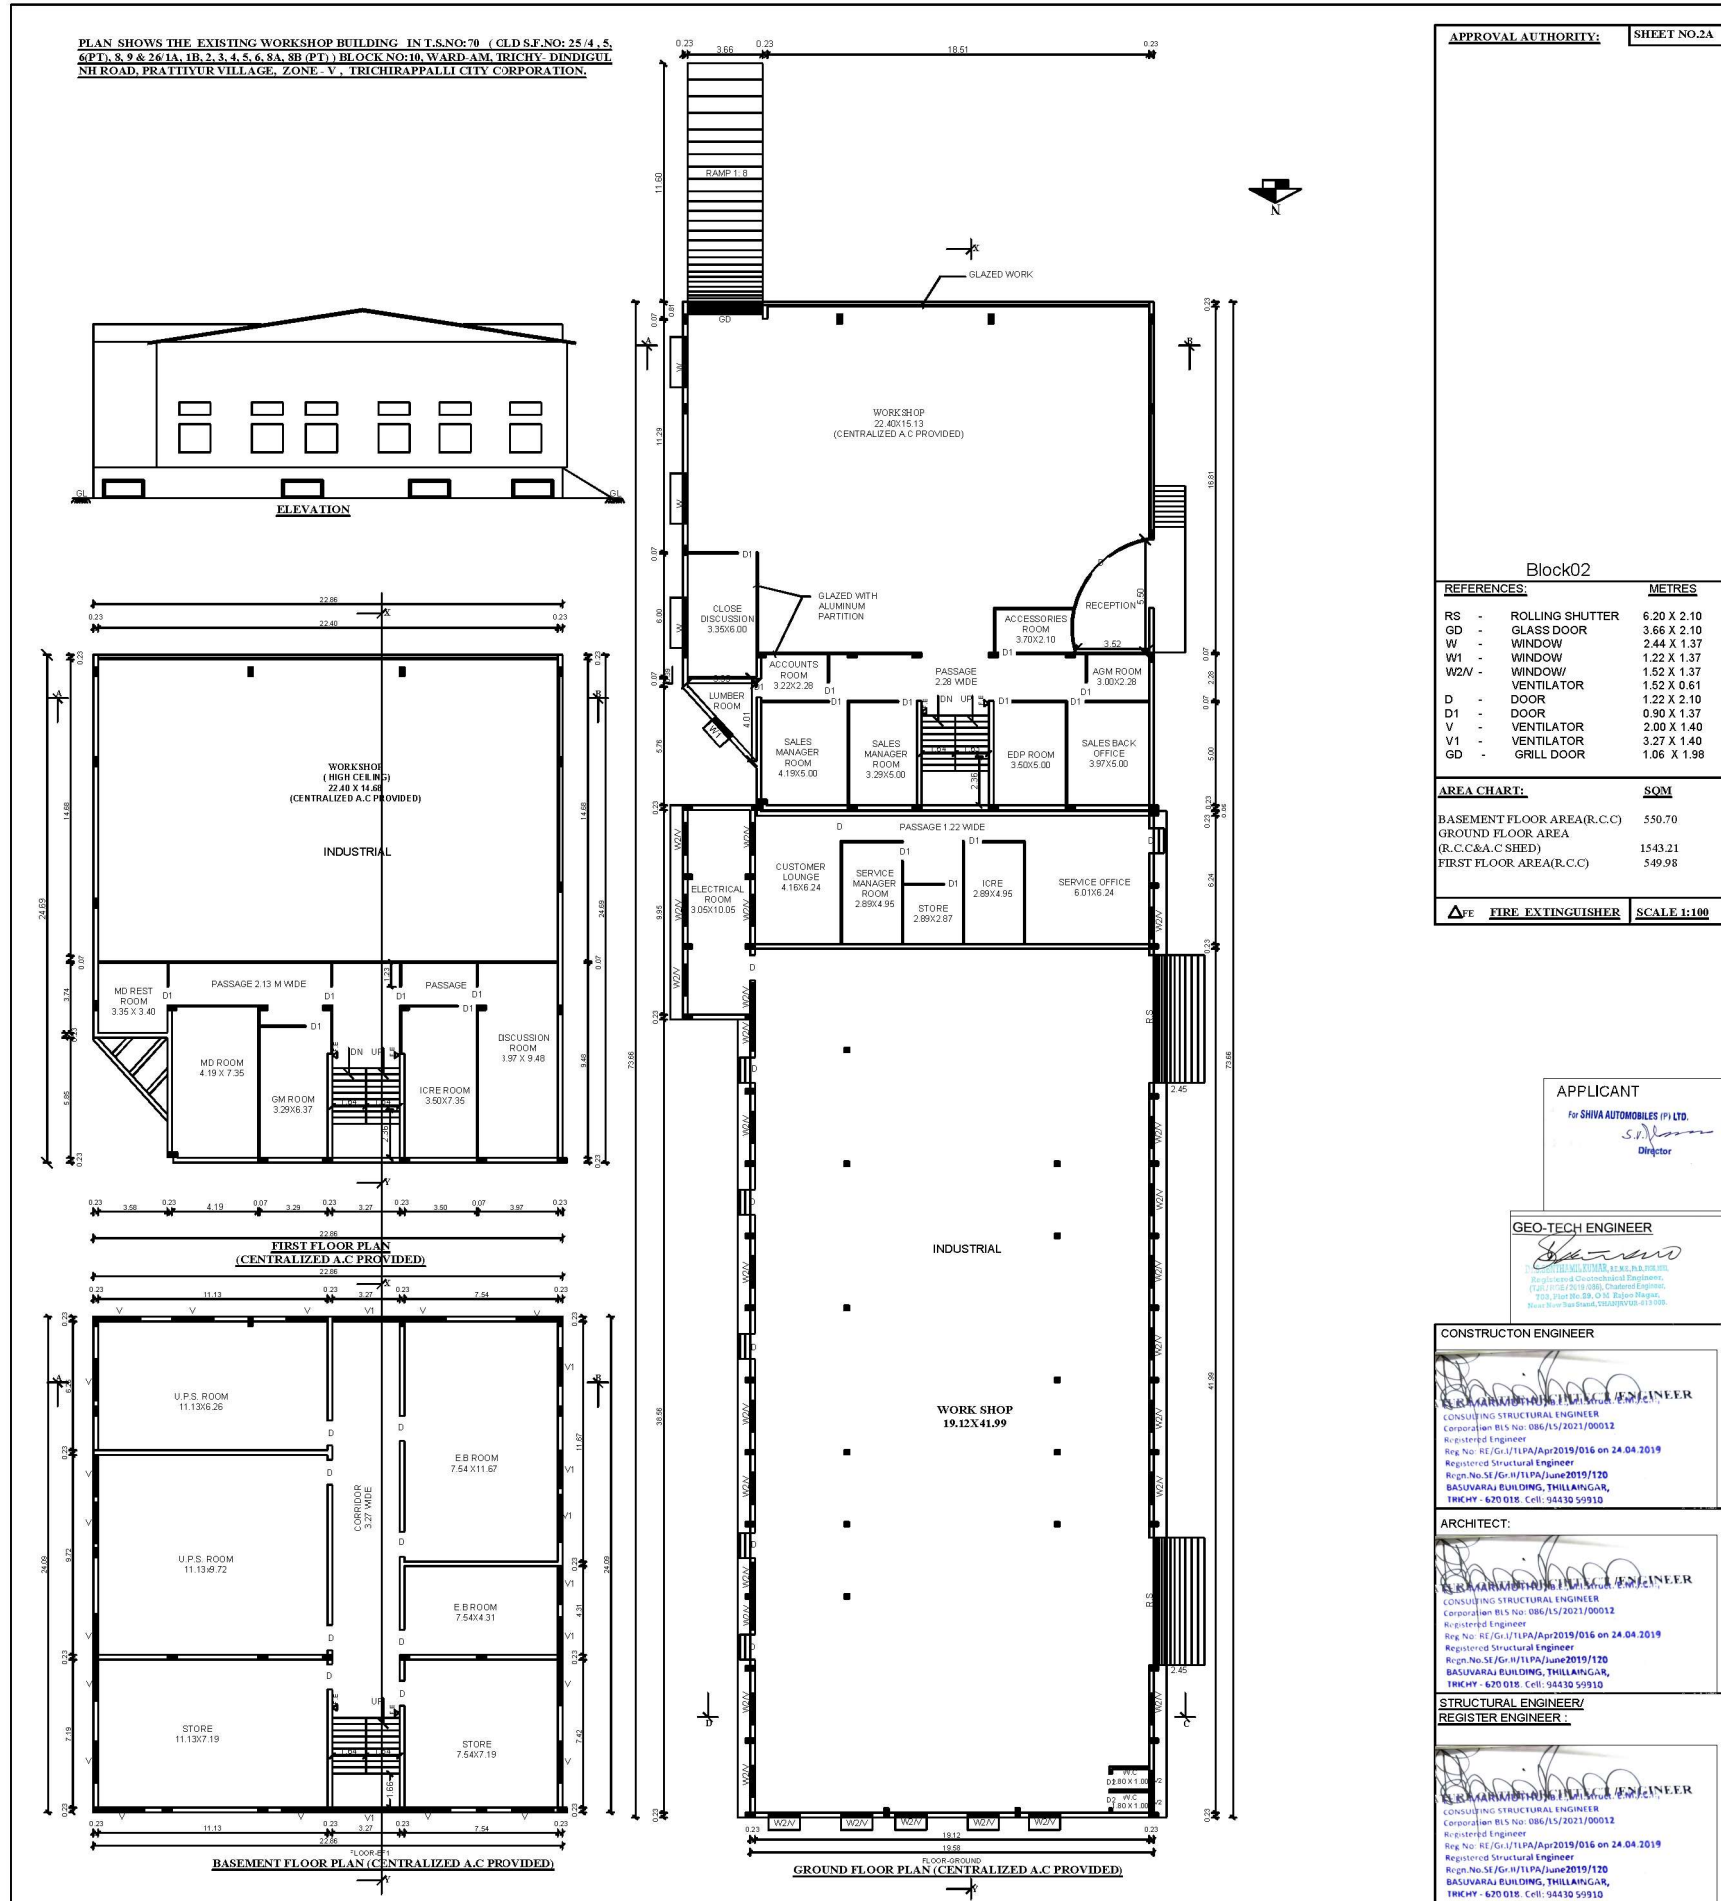


PLAN SHOWS THE SECURITY ROOM IN T.S.NO:70 (OLD S.F.NO: 25 /4 , 5, 6(PT), 8, 9 & 26/1A, 1B, 2, 3, 4, 5, 6, 8A, 8B (PT)) BLOCK NO:10, WARD-AM AT TRICHY- DINDIGUL NH ROAD, PRATTIYUR WEST VILLAGE, ZONE - V, TRICHIRAPPALLI CITY CORPORATION



SHEET NO.3


PP/JD DTCP(TD) NO.91/2024

B.P/DTCP No: 206/2024


Block03

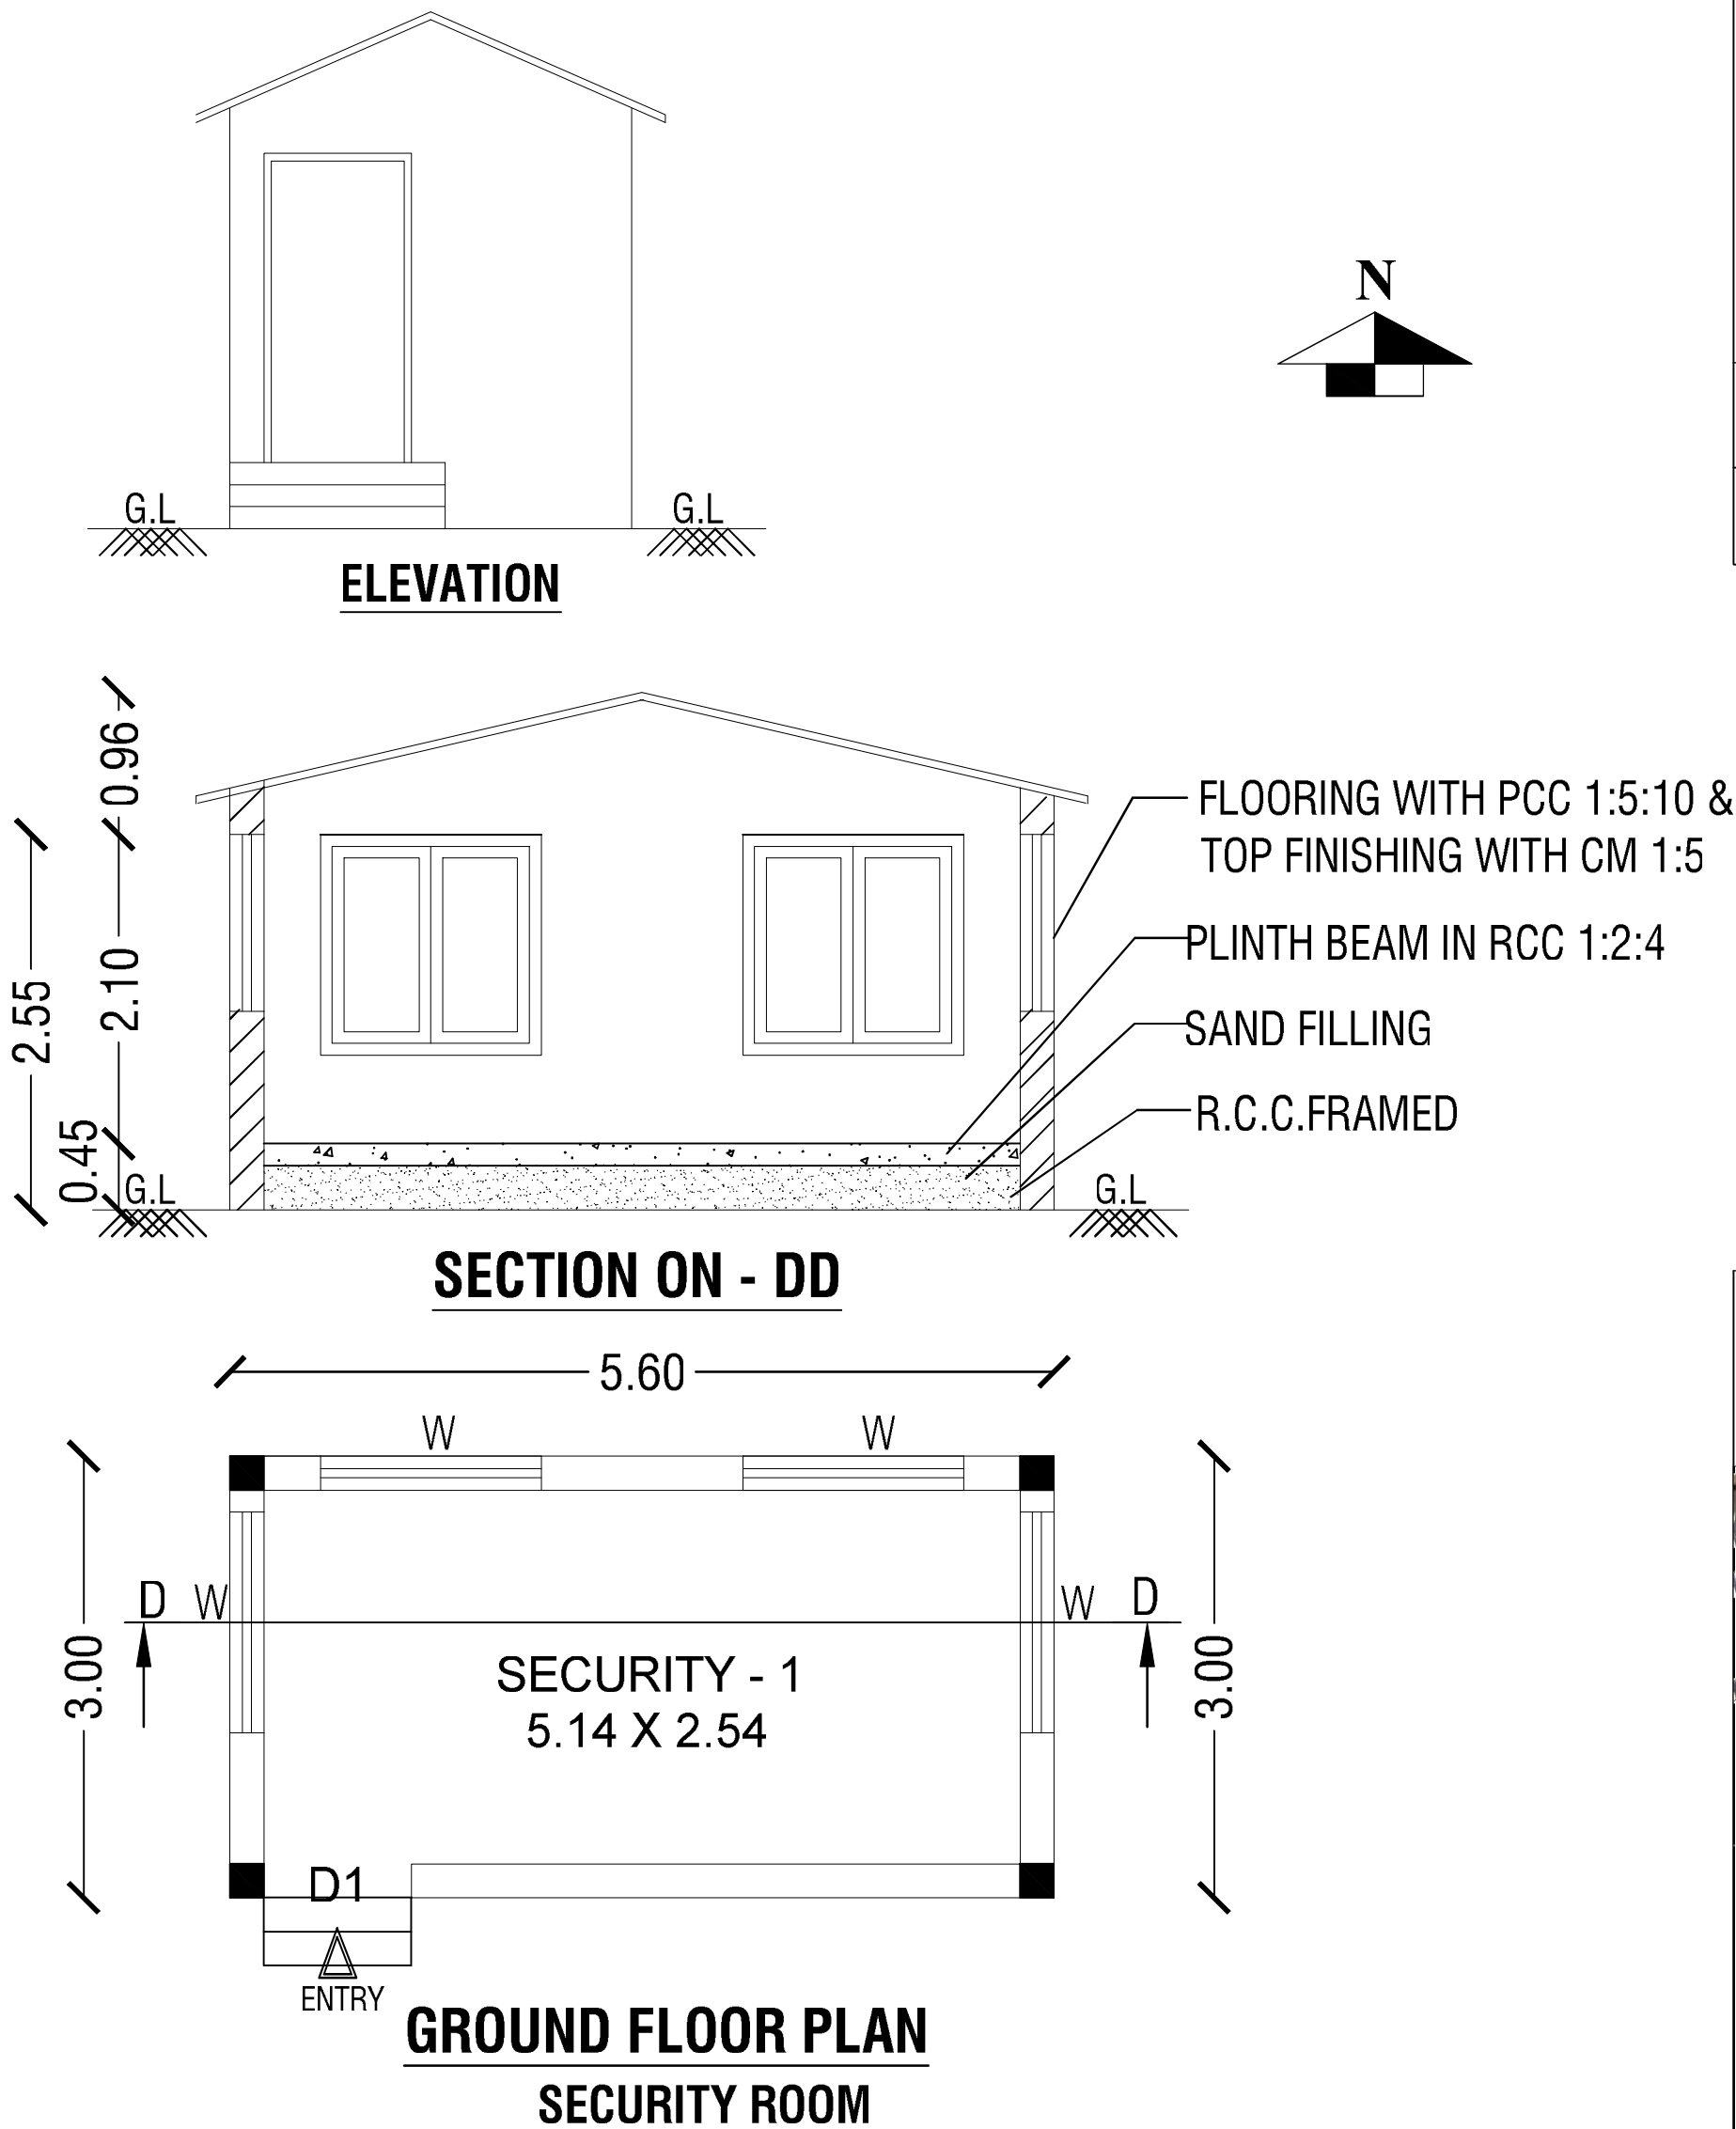

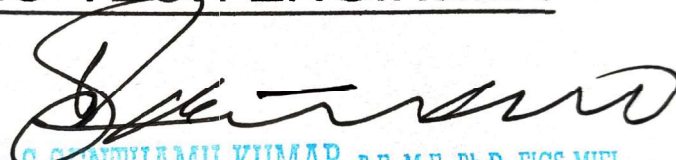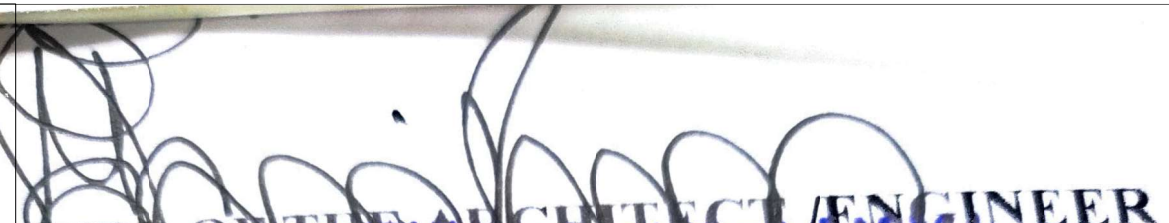REFERENCES:METRES W - WINDOW1.50 X 1.50 D1 - DOOR0.90 X 2.10 SCALE 1:100△ FE FIRE EXTINGUISHER GROUND FLOOR AREA -16.8M²		GEO-TECH ENGINEER  DR. S SENTHIL KUMAR, B.E., M.E., Ph.D., FGS, MIEI, Registered Geotechnical Engineer, (TJR / RGE / 2019 / 086), Chartered Engineer, 703, Plot No.29, O M Rajoo Nagar, Near New Bus Stand, THANJAVUR-613 005.
APPLICANT For SHIVA AUTOMOBILES (P) LTD.  Director		CONSTRUCTON ENGINEER  K.R. MARIMUTHU, B.E., M.I. Struct. E.M./C.E., CONSULTING STRUCTURAL ENGINEER Corporation BLS No: 086/LS/2021/00012 Registered Engineer Reg No: RE/Gr.I/TLPA/Apr2019/016 on 24.04.2019 Registered Structural Engineer Regn.No.SE/Gr.II/TLPA/June2019/120 BASUVARAJ BUILDING, THILLAINGAR, TRICHY - 620 018. Cell: 94430 59910
ARCHITECT:  K.R. MARIMUTHU, B.E., M.I. Struct. E.M./C.E., CONSULTING STRUCTURAL ENGINEER Corporation BLS No: 086/LS/2021/00012 Registered Engineer Reg No: RE/Gr.I/TLPA/Apr2019/016 on 24.04.2019 Registered Structural Engineer Regn.No.SE/Gr.II/TLPA/June2019/120 BASUVARAJ BUILDING, THILLAINGAR, TRICHY - 620 018. Cell: 94430 59910		STRUCTURAL ENGINEER/ REGISTER ENGINEER :  K.R. MARIMUTHU, B.E., M.I. Struct. E.M./C.E., CONSULTING STRUCTURAL ENGINEER Corporation BLS No: 086/LS/2021/00012 Registered Engineer Reg No: RE/Gr.I/TLPA/Apr2019/016 on 24.04.2019 Registered Structural Engineer Regn.No.SE/Gr.II/TLPA/June2019/120 BASUVARAJ BUILDING, THILLAINGAR, TRICHY - 620 018. Cell: 94430 59910

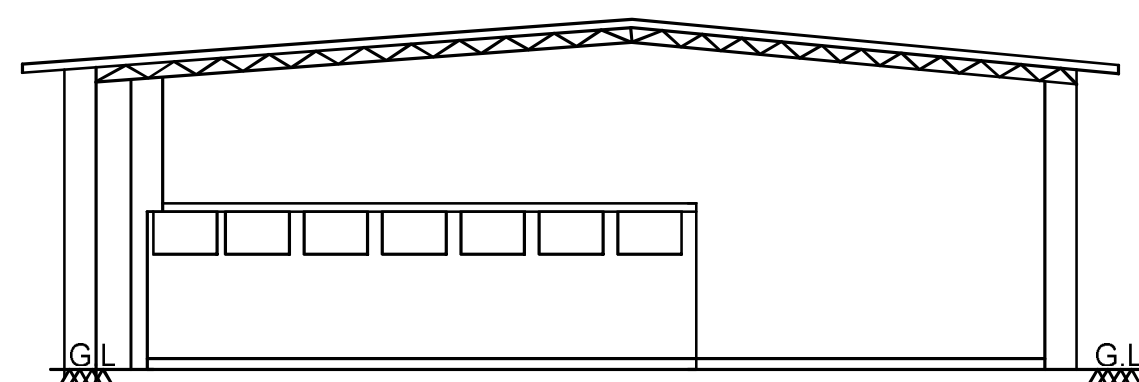

ELEVATION

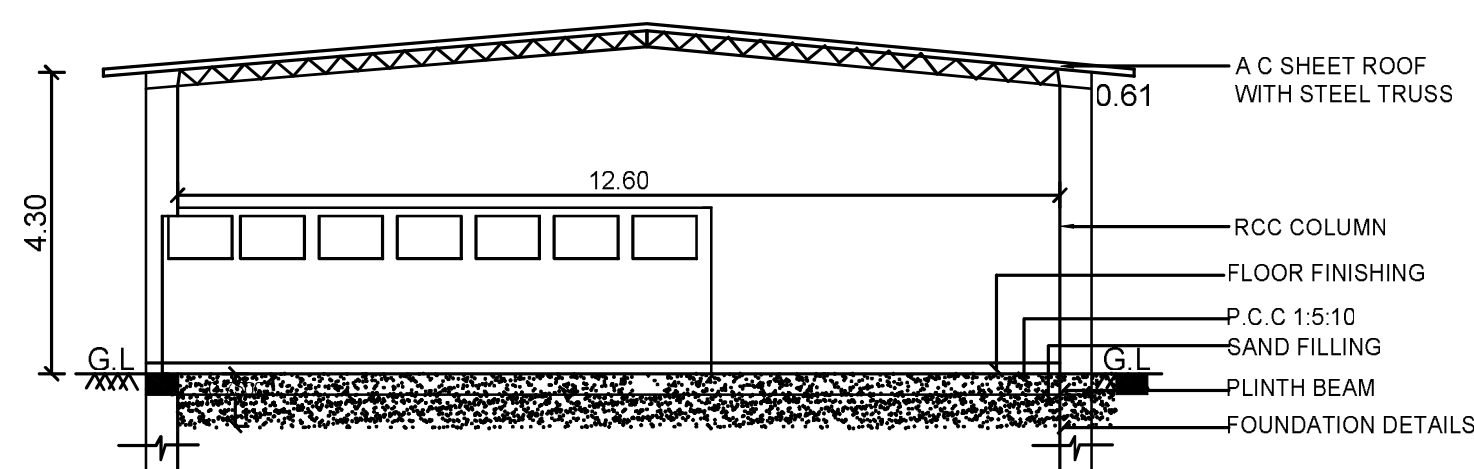

SECTION ON AB

VEHICLE PARKING-1
14 30 X 45 35

PP/JD DTCP(TD) NO.91/2024

B.P/DTCP No: 206/2024

Block04

<u>REFERENCES:</u>	<u>METRES</u>
V1 - VENTILATOR	0.91 X 0.61
D2 - DOOR	0.76 X 2.10

VEHICLE PARKING-1
GROUND FLOOR AREA - 670.79M²

△_{FE} FIRE EXTINGUISHER **SCALE 1:100**

CONSTRUCTION ENGINEER

PERMARATHU B.E., M. Struct. E.M., Cn.,
CONSULTING STRUCTURAL ENGINEER
Corporation BLS No: 086/15/2021/00012
Registered Engineer
Reg No: RE/Gr.I/TLPA/Apr2019/016 on **24.04.2019**
Registered Structural Engineer
Regn.No.SE/Gr.II/TLPA/June2019/120
BASUVARAJ BUILDING, THILLAINGAR,
TRICHY - 620 018. Cell: 94430 59910

STRUCTURAL ENGINEER/
REGISTER ENGINEER :

GEO-TECH ENGINEER


DR. S. SETHAMAIL KUMAR, B.E., M.E., Ph.D., FGS, MIE,
Registered Geotechnical Engineer,
(TJR/RGE/2019/086), Chartered Engineer,
703, Plot No.29, O M Rajoo Nagar,
Near New Bus Stand, THANJAVUR-613 005.

ARCHITECT:


MR. MARTIN MUTHU, B.E., M.STRUCT. E.M., C.E.,
CONSULTING STRUCTURAL ENGINEER
Corporation BLS No: 086/LS/2021/00012
Registered Engineer
Reg. No: RE/I/TLPA/Apr2019/016 on **24.04.2019**
Registered Structural Engineer
Regn.No.SE/Gr.II/TLPA/June2019/120
BASUVARAJ BUILDING, THILLAIANGAR,
TRICHY - 620 018. Cell: 94430 59910

MR. MARUTHU B. E., M. Struct. E. M. C. E.,
CONSULTING STRUCTURAL ENGINEER
Corporation BLS No: 086/LS/2021/00012
Registered Engineer
Reg No: RE/Gr.I/TLPA/Apr2019/016 on **24.04.2019**
Registered Structural Engineer
Regn.No. SE/Gr.II/TLPA/June2019/120
BASUVARAJ BUILDING, THILLAINGAR,
TRICHY - 620 018. Cell: 94430 59910


PLAN SHOWS THE EXISTING SPARE PARTS ROOM IN
T.S.NO:70 (OLD S.F.NO: 25 /4 , 5, 6(PT), 8, 9 & 26/1A, 1B, 2, 3, 4, 5, 6, 8A, 8B (PT))
BLOCK NO:10, WARD-AM AT TRICHY- DINDIGUL NH ROAD, PRATTIYUR
WEST VILLAGE, ZONE - V, TRICHIRAPPALLI CITY CORPORATION.

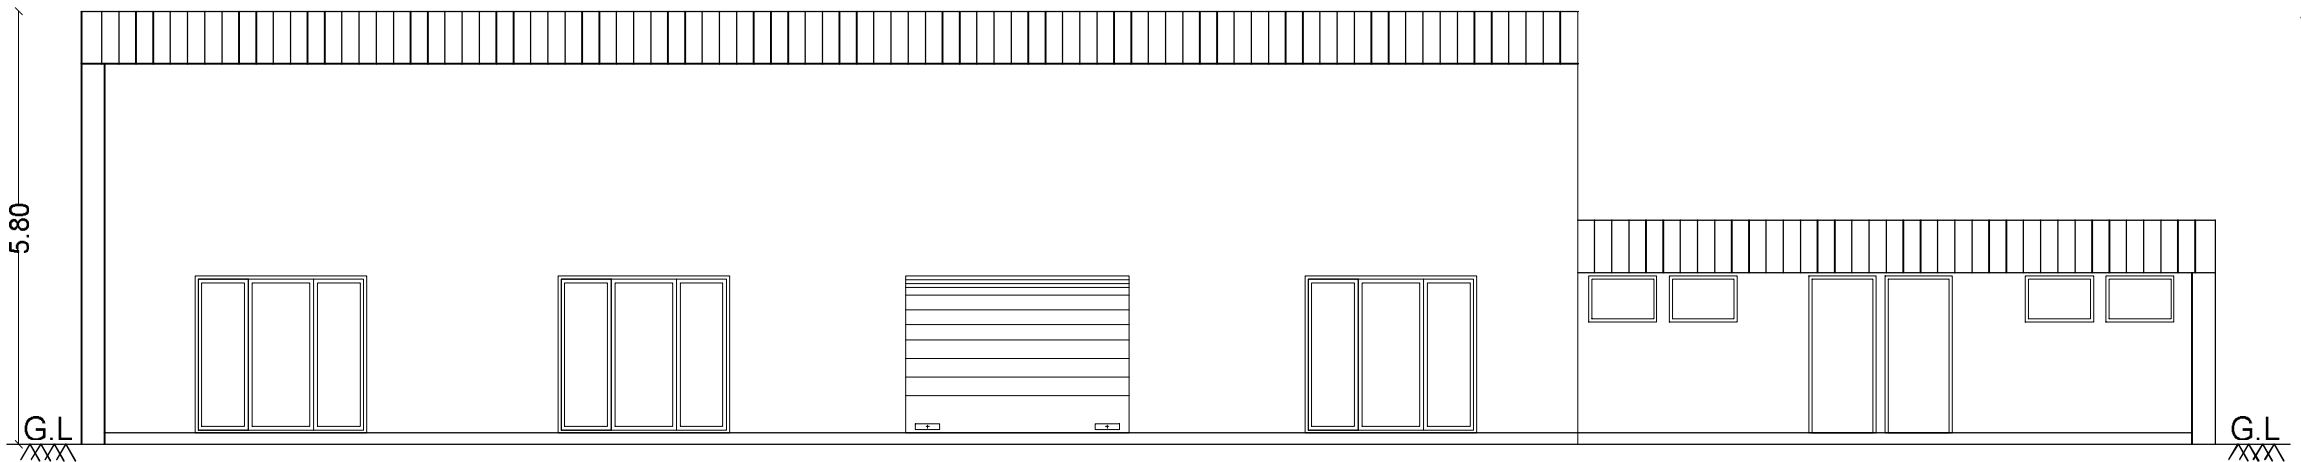

ELEVATION

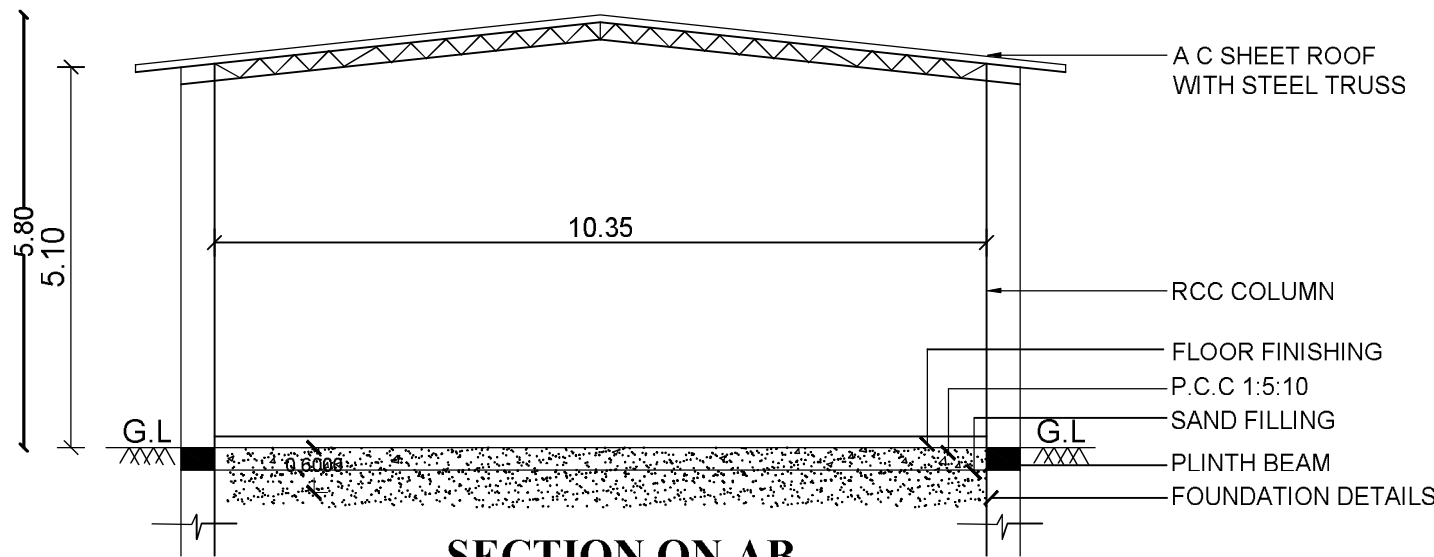

SECTION ON AB

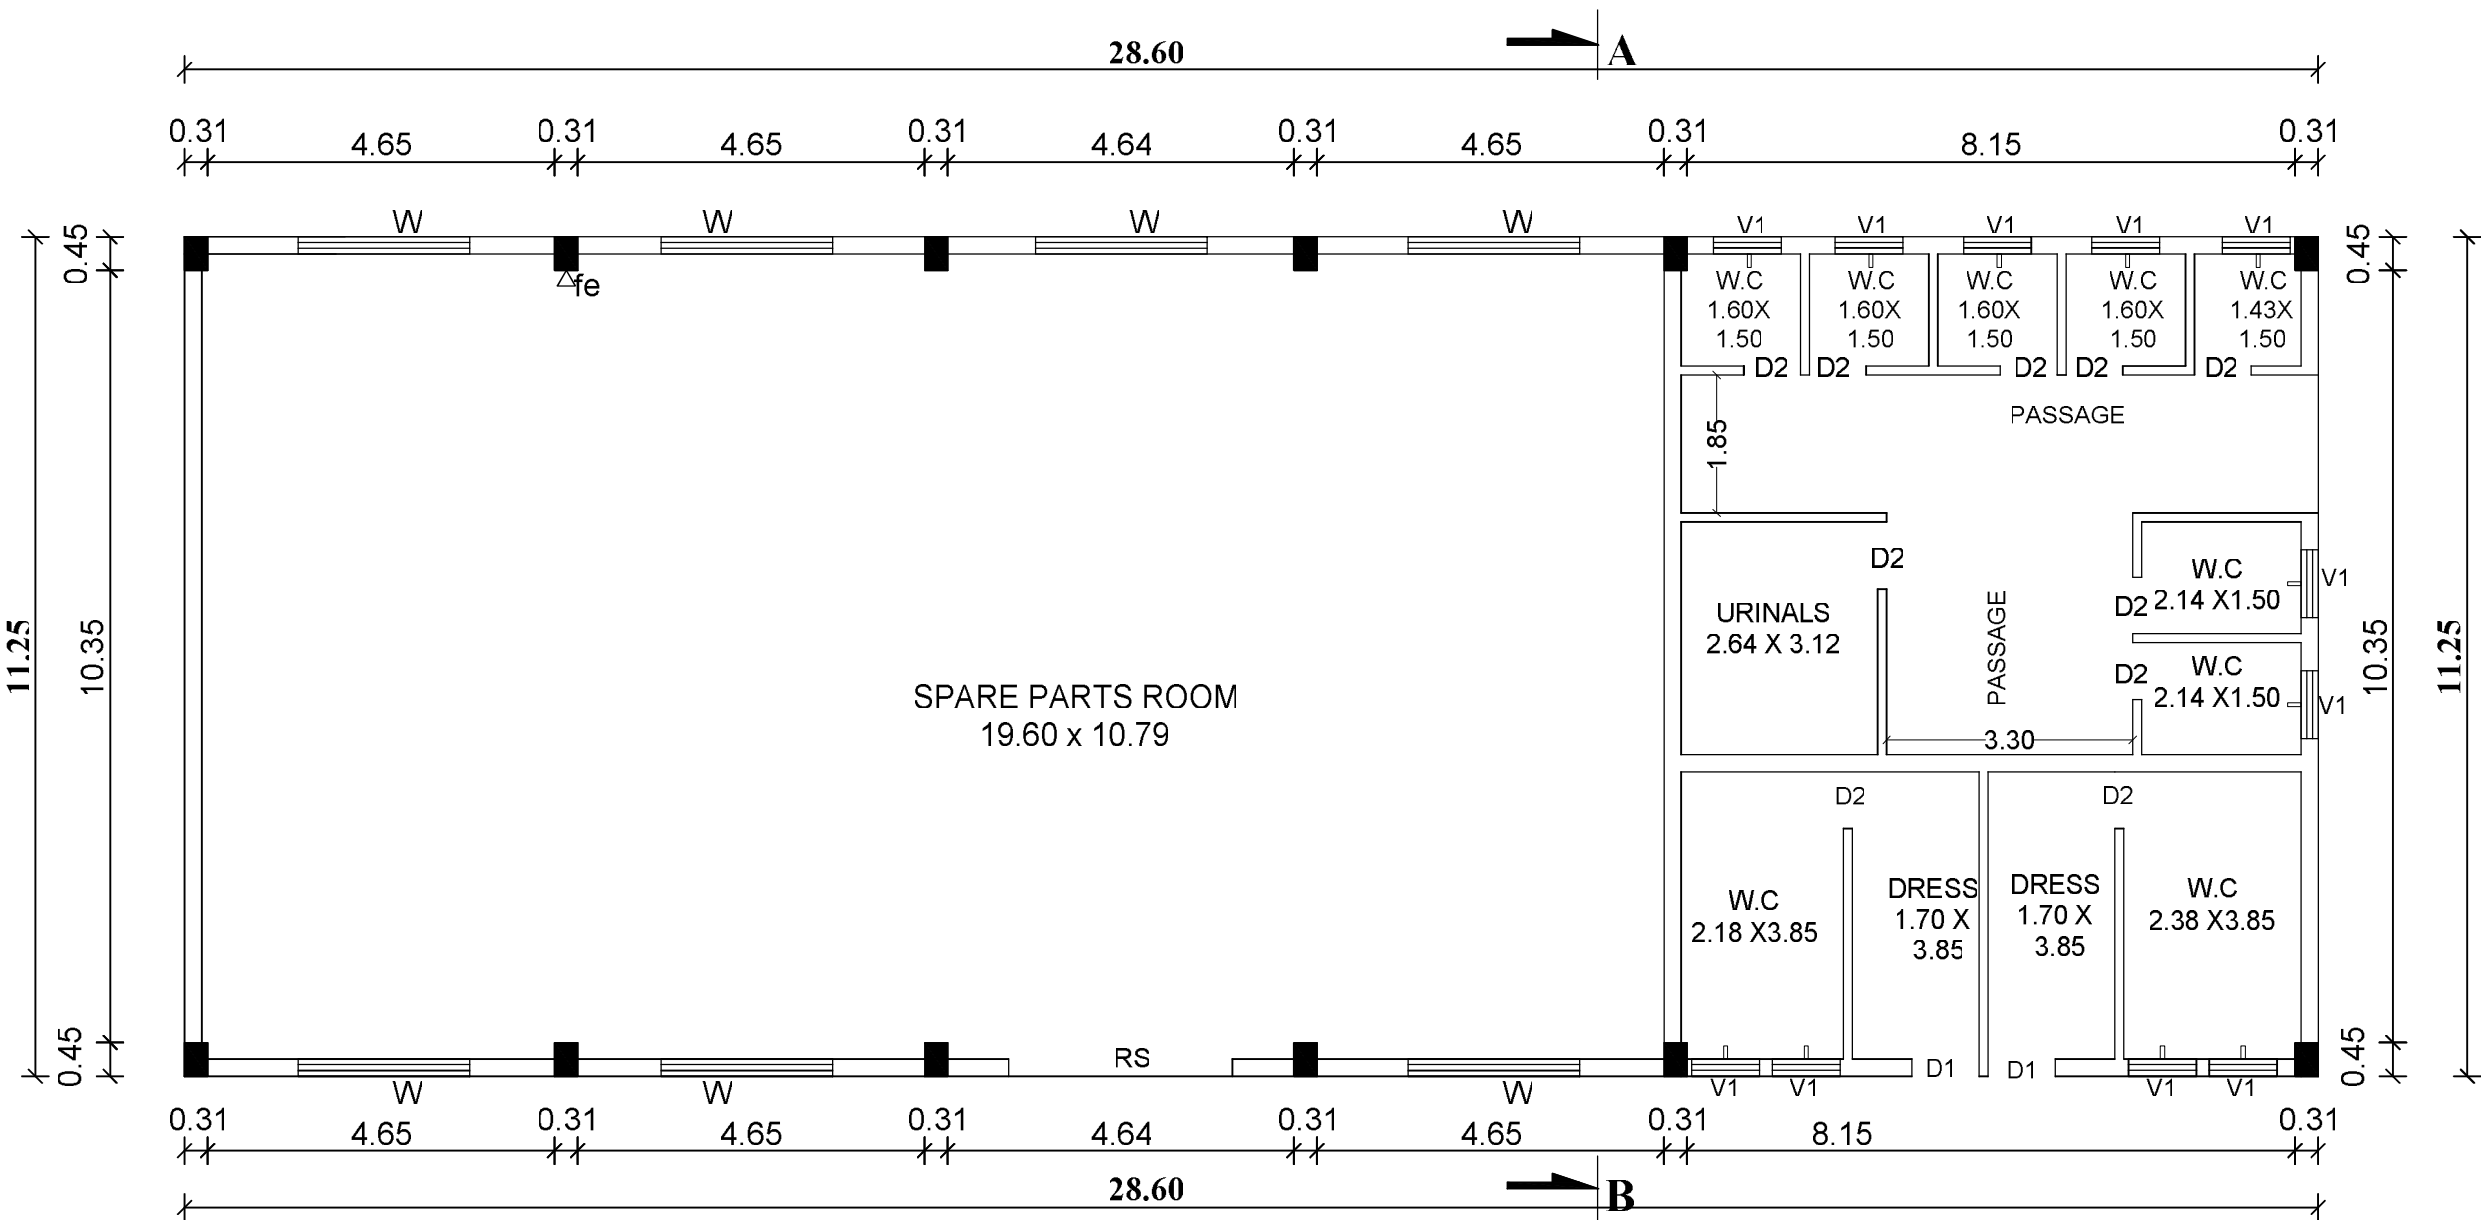

GROUND FLOOR PLAN

SCALE 1:100

GROUND FLOOR AREA - 321.75M²

FE FIRE EXTINGUISHER

GEO-TECH ENGINEER

[Signature]
D. S. SETHAMIL KUMAR, B.E., M.E., Ph.D., FGS, MIE,
Registered Geotechnical Engineer,
(TJR / RGE / 2019 / 086), Chartered Engineer,
703, Plot No. 29, O M Rajoo Nagar,
Near New Bus Stand, THANJAVUR-613 005.

REFERENCES:

METRES

RS	- ROLLING SHUTTER	3.00 X 2.10
W	- WINDOW	2.30 X 1.80
V1	- VENTILATOR	0.91 X 0.61
D1	- DOOR	0.90 X 2.10
D2	- DOOR	0.76 X 2.10

B.P/DTCP No: 206/2024

PP/JD DTCP NO.91/2024

APPLICANT

For SHIVA AUTOMOBILES (P) LTD.

[Signature]
S.V. Director

CONSTRUCTON ENGINEER

[Signature]
K. R. MARUDHUGI, B.E., M.Sc., E.M.C.,
CONSULTING STRUCTURAL ENGINEER
Corporation BLS No: 086/LS/2021/00012
Registered Engineer
Reg. No: RE/Gr.II/TLPA/Apr2019/016 on 24.04.2019
Registered Structural Engineer
Rogn.No.SE/Gr.II/TLPA/June2019/120
BASUVARAJ BUILDING, THILLAINGAR,
TRICHY - 620 018. Cell: 94430 59910


ARCHITECT:

[Signature]
K. R. MARUDHUGI, B.E., M.Sc., E.M.C.,
CONSULTING STRUCTURAL ENGINEER
Corporation BLS No: 086/LS/2021/00012
Registered Engineer
Reg. No: RE/Gr.II/TLPA/Apr2019/016 on 24.04.2019
Registered Structural Engineer
Rogn.No.SE/Gr.II/TLPA/June2019/120
BASUVARAJ BUILDING, THILLAINGAR,
TRICHY - 620 018. Cell: 94430 59910


STRUCTURAL ENGINEER/
REGISTER ENGINEER :

[Signature]
K. R. MARUDHUGI, B.E., M.Sc., E.M.C.,
CONSULTING STRUCTURAL ENGINEER
Corporation BLS No: 086/LS/2021/00012
Registered Engineer
Reg. No: RE/Gr.II/TLPA/Apr2019/016 on 24.04.2019
Registered Structural Engineer
Rogn.No.SE/Gr.II/TLPA/June2019/120
BASUVARAJ BUILDING, THILLAINGAR,
TRICHY - 620 018. Cell: 94430 59910

PLAN SHOWS THE EXISTING WASTE STORAGE, SOLID BLOCK AND WATER WASHING IN T.S.NO:70 (OLD S.F.NO: 25 /4 , 5, 6(PT), 8, 9 & 26/1A, 1B, 2, 3, 4, 5, 6, 8A, 8B (PT))
BLOCK NO:10, WARD-AM AT TRICHY- DINDIGUL NH ROAD, PRATTIYUR WEST VILLAGE, ZONE - V, TRICHIRAPPALLI CITY CORPORATION.

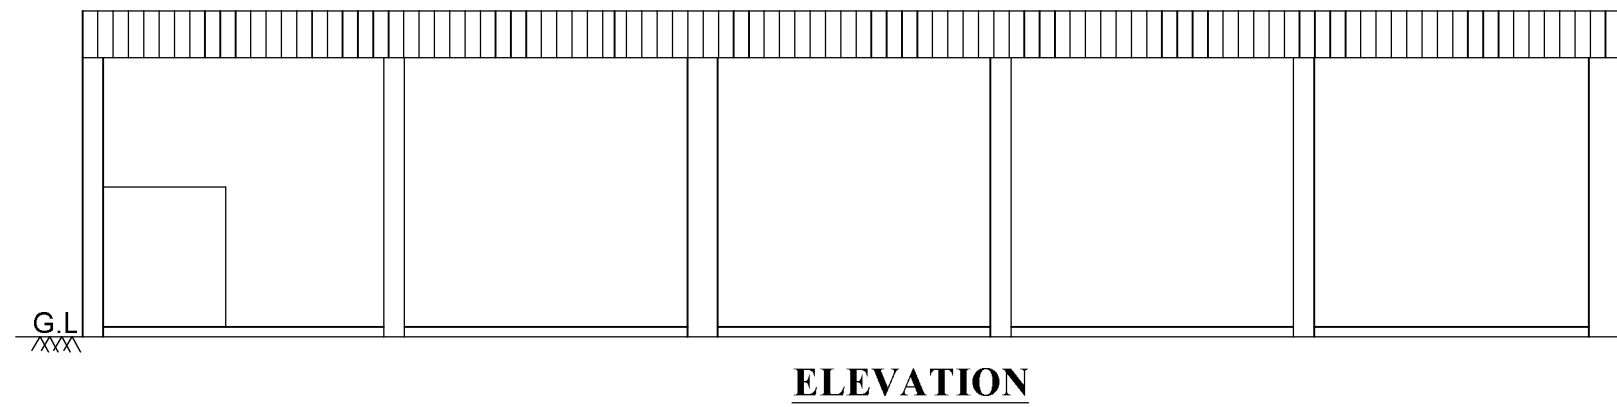

ELEVATION

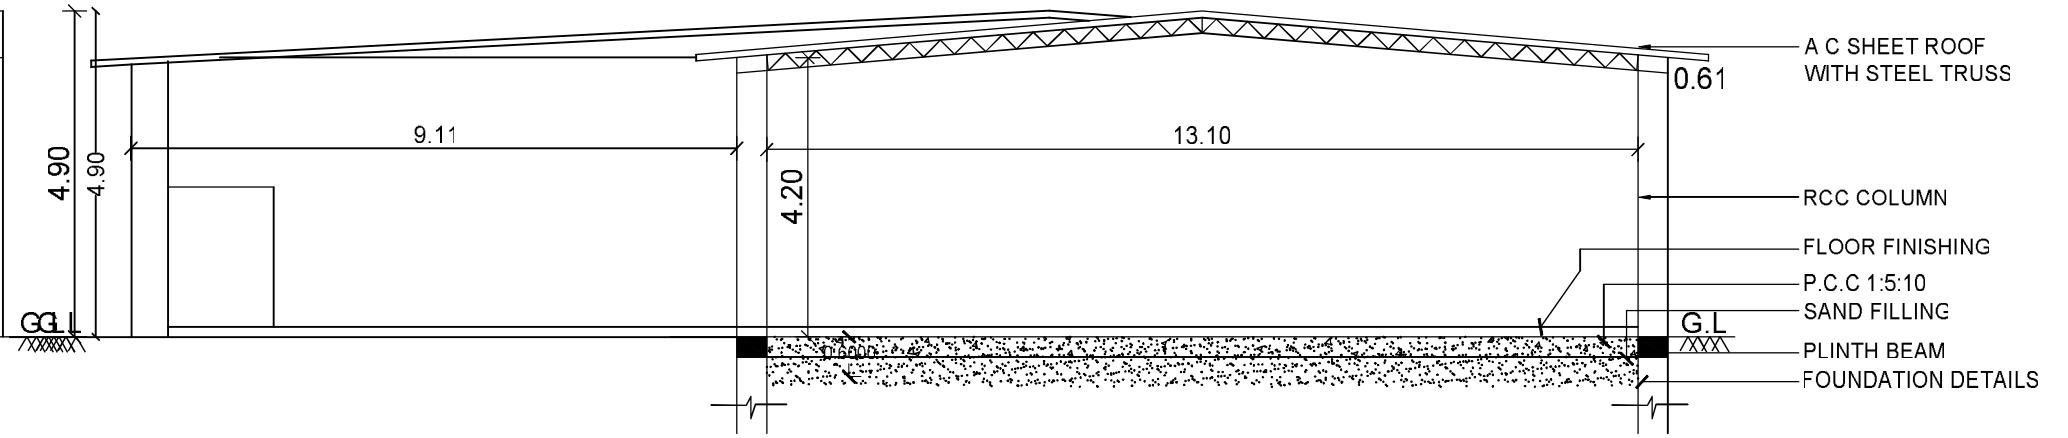

SECTION ON AB

Block06

TOTAL GROUND FLOOR AREA -425.04M²

REFERENCES:	METRES
V1 - VENTILATOR	0.91 X 0.61
D2 - DOOR	0.76 X 2.10
SCALE 1:100	△ _{FE} FIRE EXTINGUISHER


B.P/DTCP No: 206/2024

PP/JD DTCP NO.91/2024

APPLICANT

For SHIVA AUTOMOBILES (P) LTD.

S.V. [Signature]
Director

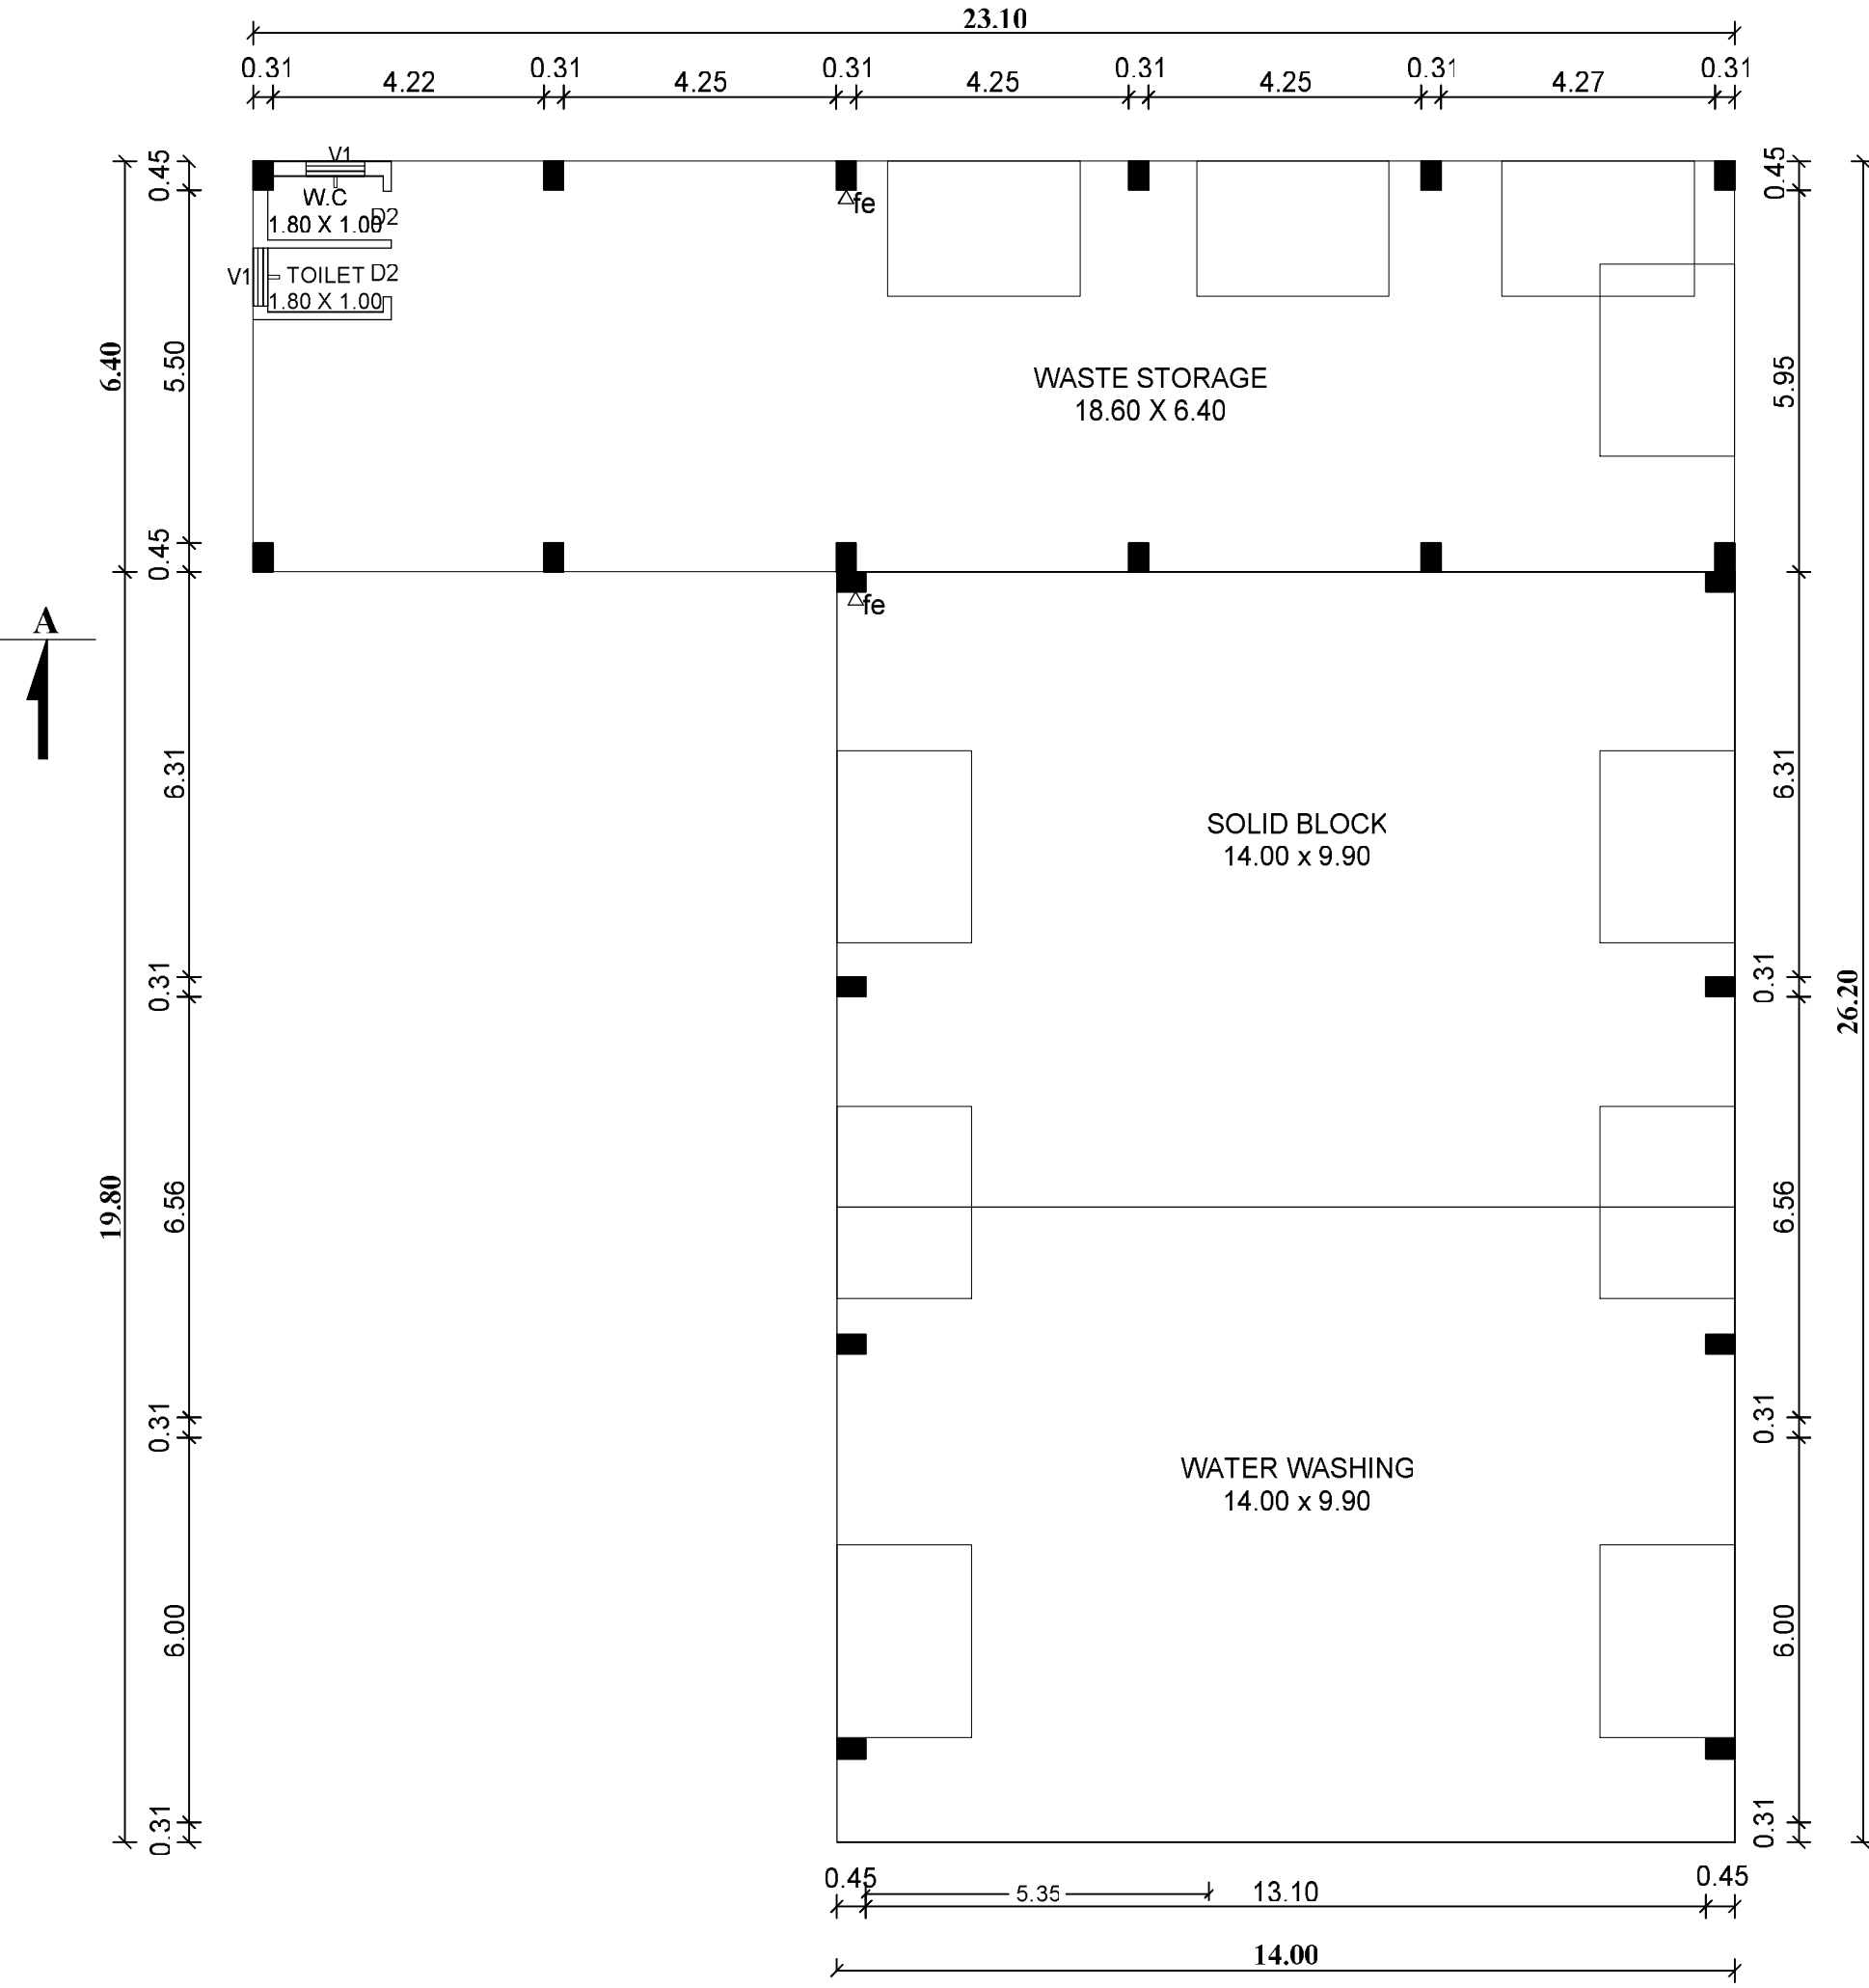

GROUND FLOOR PLAN

CONSTRUCTON ENGINEER

[Signature]
R.K. MARIMUTHU, B.E., M. Struct. E.M./C.E.,
CONSULTING STRUCTURAL ENGINEER
Corporation BLS No: 086/LS/2021/00012
Registered Engineer
Reg No: RE/Gr.I/TLPA/Apr2019/016 on 24.04.2019
Registered Structural Engineer
Regn.No.SE/Gr.II/TLPA/June2019/120
BASUVARAJ BUILDING, THILLAINGAR,
TRICHY - 620 018. Cell: 94430 59910

ARCHITECT:

[Signature]
R.K. MARIMUTHU, B.E., M. Struct. E.M./C.E.,
CONSULTING STRUCTURAL ENGINEER
Corporation BLS No: 086/LS/2021/00012
Registered Engineer
Reg No: RE/Gr.I/TLPA/Apr2019/016 on 24.04.2019
Registered Structural Engineer
Regn.No.SE/Gr.II/TLPA/June2019/120
BASUVARAJ BUILDING, THILLAINGAR,
TRICHY - 620 018. Cell: 94430 59910

GEO-TECH ENGINEER

[Signature]
D. SUBENTHAMILKUMAR, B.E., M.E., Ph.D., FOS, MIEE,
Registered Geotechnical Engineer,
(TJR/RGE/2019/086), Chartered Engineer,
703, Plot No.29, O M Rajoo Nagar,
Near New Bus Stand, THANJAVUR-613 005.

STRUCTURAL ENGINEER/
REGISTER ENGINEER :

[Signature]
R.K. MARIMUTHU, B.E., M. Struct. E.M./C.E.,
CONSULTING STRUCTURAL ENGINEER
Corporation BLS No: 086/LS/2021/00012
Registered Engineer
Reg No: RE/Gr.I/TLPA/Apr2019/016 on 24.04.2019
Registered Structural Engineer
Regn.No.SE/Gr.II/TLPA/June2019/120
BASUVARAJ BUILDING, THILLAINGAR,
TRICHY - 620 018. Cell: 94430 59910

PLAN SHOWS THE EXISTING CONSTRUCTION OF VEHICLE PARKING-2 IN T.S.NO:70 (OLD S.F.NO: 25 /4 , 5, 6(PT), 8, 9 & 26/1A, 1B, 2, 3, 4, 5, 6, 8A, 8B (PT)), BLOCK NO:10, WARD-AM AT TRICHY- DINDIGUL NH ROAD, PRATTIYUR WEST VILLAGE, ZONE - V, TRICHIRAPPALLI CITY CORPORATION.


SHEET NO.8

Block09




PP/JD DTCP NO.91/2024



B.P/DTCP No: 206/2024

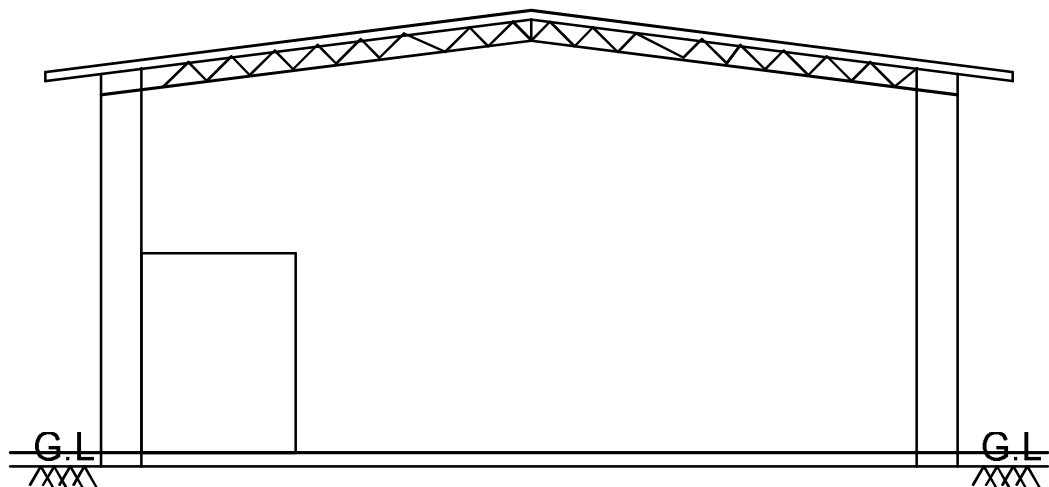

ELEVATION

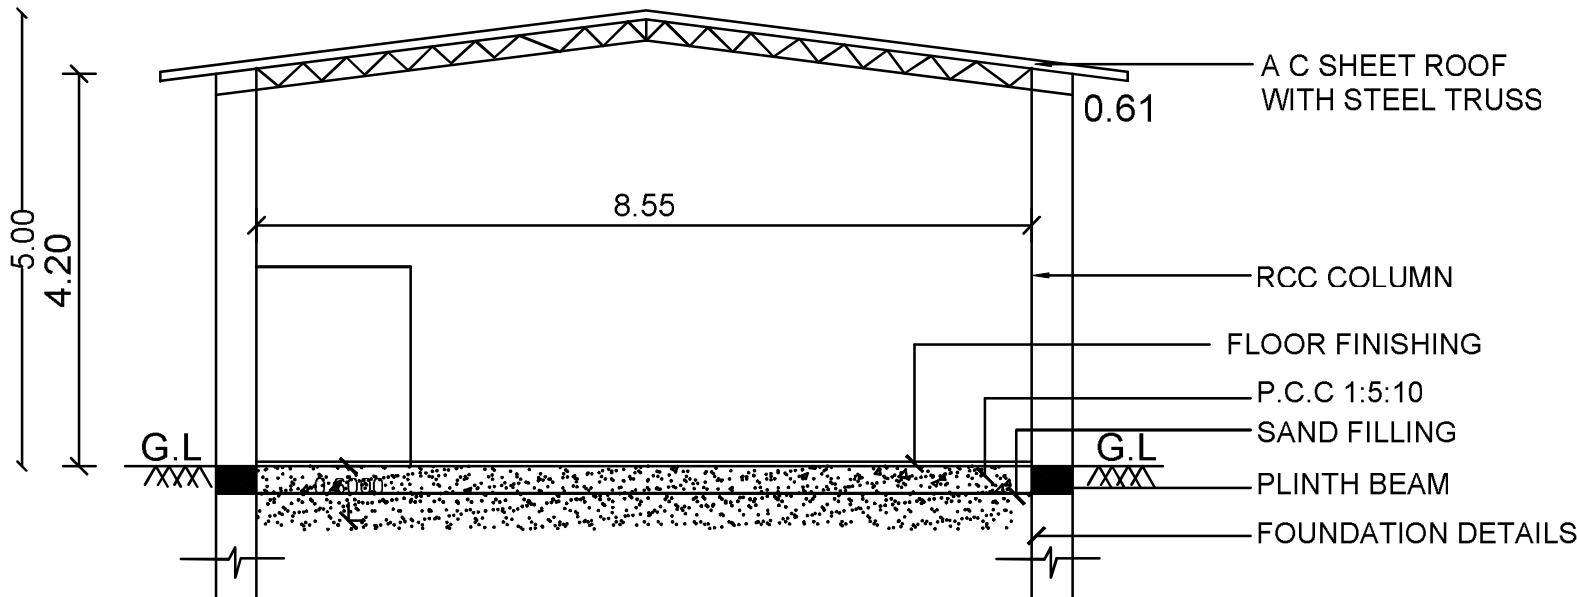

SECTION ON AB

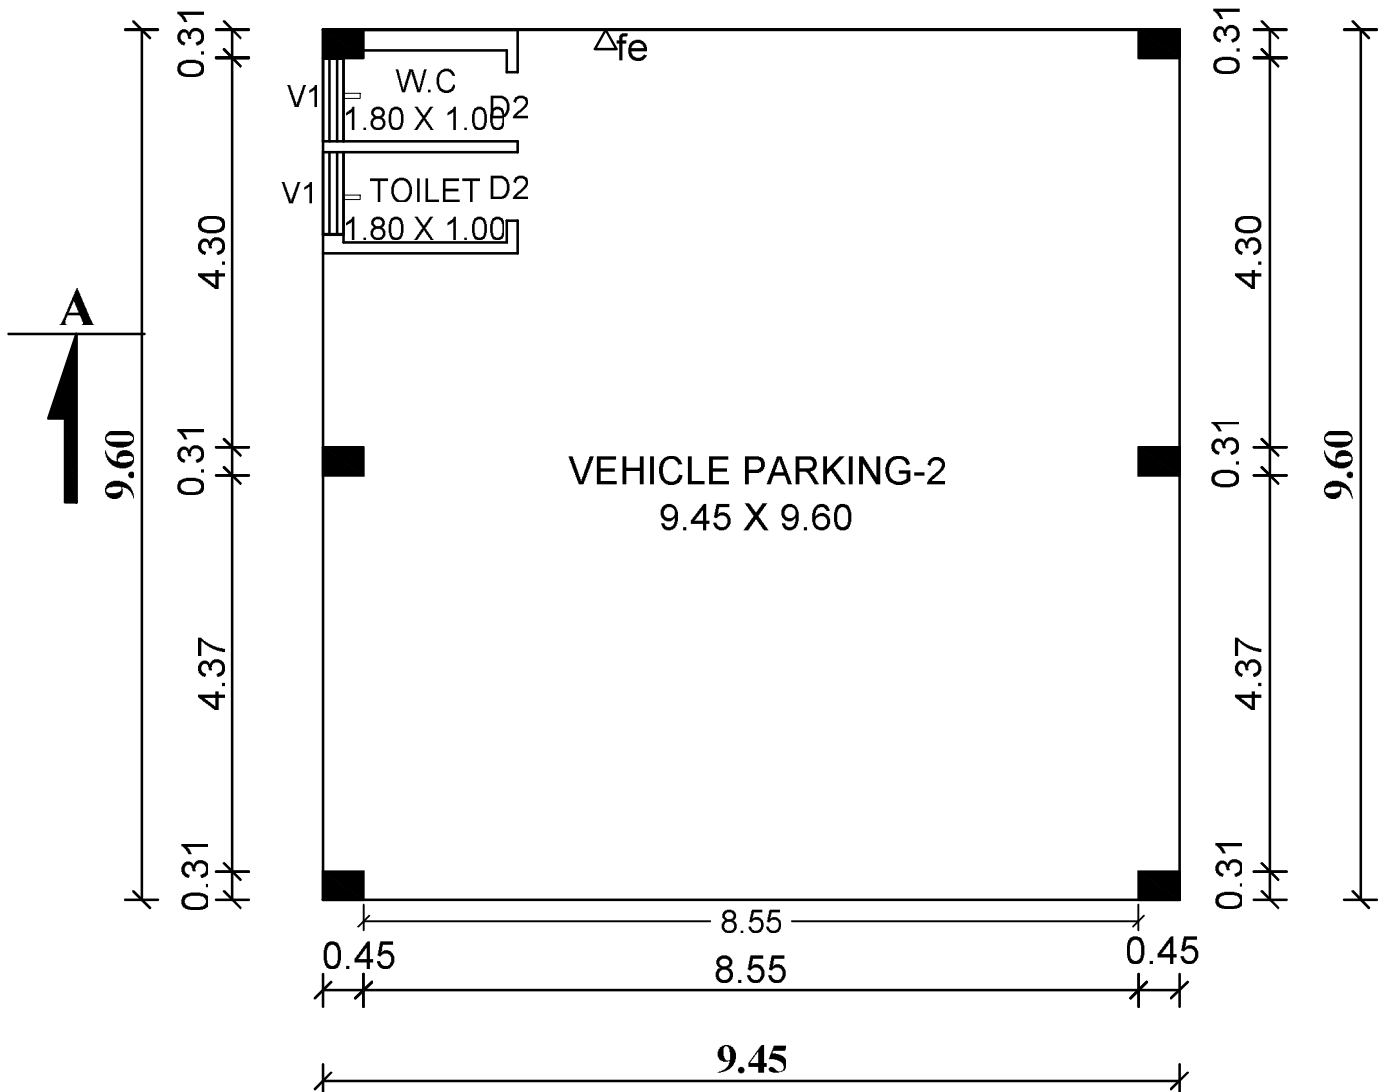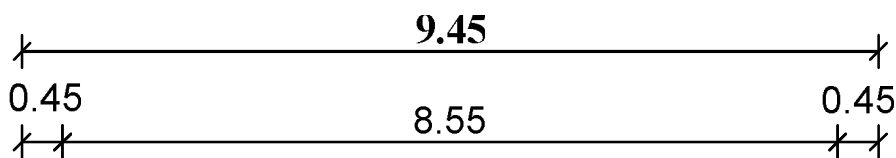

FLOOR-GROUND
GROUND FLOOR PLAN

REFERENCES:

METRES

V1	- VENTILATOR	0.91 X 0.61
D2	- DOOR	0.76 X 2.10

VEHICLE PARKING-2
AREA - 90.72 M²

SCALE 1:100

△FE FIRE EXTINGUISHER

APPLICANT

For SHIVA AUTOMOBILES (P) LTD.

S.V. [Signature]
Director

GEO-TECH ENGINEER

[Signature]
DR.S.SENTHAMIL KUMAR, B.E., M.E., Ph.D., FICS, MIEE,
Registered Geotechnical Engineer,
(TJR/RGE/2019/086), Chartered Engineer,
703, Plot No.29, O M Rajoo Nagar,
Near New Bus Stand, THANJAVUR-613 005.

CONSTRUCTON ENGINEER

[Signature]
S.R.MARIMUTHU, B.E., M.I.Struct. E.M./C.E.,
CONSULTING STRUCTURAL ENGINEER
Corporation BLS No: 086/LS/2021/00012
Registered Engineer
Reg No: RE/Gr.I/TLPA/Apr2019/016 on 24.04.2019
Registered Structural Engineer
Regn.No.SE/Gr.II/TLPA/June2019/120
BASUVARAJ BUILDING, THILLAINGAR,
TRICHY - 620 018. Cell: 94430 59910

ARCHITECT:


[Signature]
S.R.MARIMUTHU, B.E., M.I.Struct. E.M./C.E.,
CONSULTING STRUCTURAL ENGINEER
Corporation BLS No: 086/LS/2021/00012
Registered Engineer
Reg No: RE/Gr.I/TLPA/Apr2019/016 on 24.04.2019
Registered Structural Engineer
Regn.No.SE/Gr.II/TLPA/June2019/120
BASUVARAJ BUILDING, THILLAINGAR,
TRICHY - 620 018. Cell: 94430 59910

STRUCTURAL ENGINEER/
REGISTER ENGINEER :


[Signature]
S.R.MARIMUTHU, B.E., M.I.Struct. E.M./C.E.,
CONSULTING STRUCTURAL ENGINEER
Corporation BLS No: 086/LS/2021/00012
Registered Engineer
Reg No: RE/Gr.I/TLPA/Apr2019/016 on 24.04.2019
Registered Structural Engineer
Regn.No.SE/Gr.II/TLPA/June2019/120
BASUVARAJ BUILDING, THILLAINGAR,
TRICHY - 620 018. Cell: 94430 59910

PLAN SHOWS THE EXISTING VEHICLE PARKING-3 IN T.S.NO:70 (OLD S.F.NO: 25 /4 , 5, 6(PT), 8, 9 & 26/1A, 1B, 2, 3, 4, 5, 6, 8A, 8B (PT)), BLOCK NO:10, WARD-AM AT TRICHY- DINDIGUL NH ROAD, PRATTIYUR WEST VILLAGE, ZONE - V, TRICHIRAPPALLI CITY CORPORATION.

SHEET NO.9

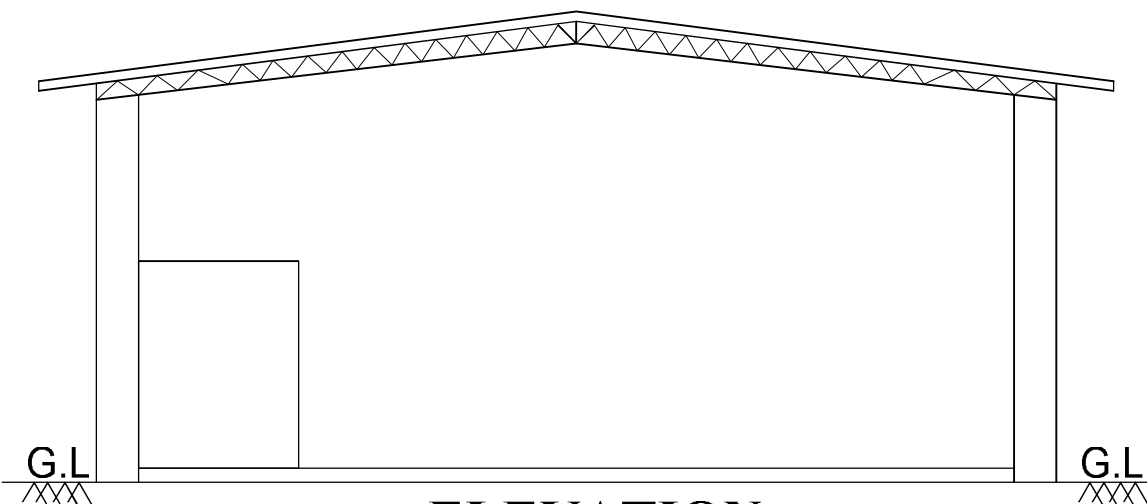

ELEVATION

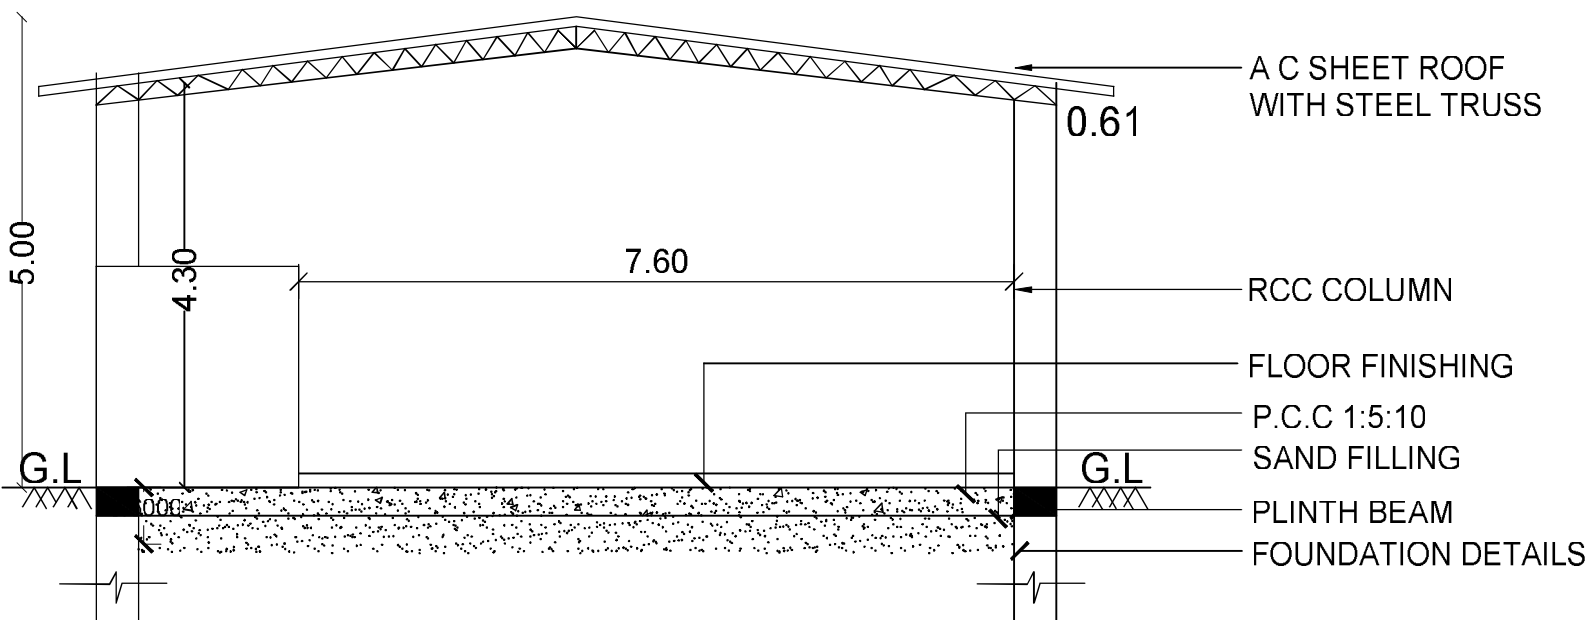

SECTION ON AB

B.P/DTCP No: 206/2024



Block010

PP/JD DTCP NO.91/2024

VEHICLE PARKING-3
GROUND FLOOR AREA - 81.60M²

REFERENCES:	METRES
V1 - VENTILATOR	0.91 X 0.61
D2 - DOOR	0.76 X 2.10

△FE FIRE EXTINGUISHER


SCALE 1:100

APPLICANT

For SHIVA AUTOMOBILES (P) LTD.

S.V. Director

GEO-TECH ENGINEER

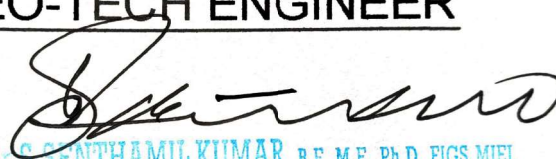
DR. SENTHAMIL KUMAR, B.E., M.E., Ph.D., FGS, MIEI,
Registered Geotechnical Engineer,
(TJR/RGE/2019/086), Chartered Engineer,
703, Plot No.29, O.M. Rajoo Nagar,
Near New Bus Stand, THANJAVUR-613 005.

CONSTRUCTON ENGINEER


K.R. MARIMUTHU, B.E., M.E., Ph.D., FGS, MIEI,
CONSULTING STRUCTURAL ENGINEER
Corporation BLS No: 086/LS/2021/00012
Registered Engineer
Reg No: RE/Gr.I/TLPA/Apr2019/016 on 24.04.2019
Registered Structural Engineer
Regn.No.SE/Gr.II/TLPA/June2019/120
BASUVARAJ BUILDING, THILLAINGAR,
TRICHY - 620 018. Cell: 94430 59910


ARCHITECT:


K.R. MARIMUTHU, B.E., M.E., Ph.D., FGS, MIEI,
CONSULTING STRUCTURAL ENGINEER
Corporation BLS No: 086/LS/2021/00012
Registered Engineer
Reg No: RE/Gr.I/TLPA/Apr2019/016 on 24.04.2019
Registered Structural Engineer
Regn.No.SE/Gr.II/TLPA/June2019/120
BASUVARAJ BUILDING, THILLAINGAR,
TRICHY - 620 018. Cell: 94430 59910


STRUCTURAL ENGINEER/
REGISTER ENGINEER :


K.R. MARIMUTHU, B.E., M.E., Ph.D., FGS, MIEI,
CONSULTING STRUCTURAL ENGINEER
Corporation BLS No: 086/LS/2021/00012
Registered Engineer
Reg No: RE/Gr.I/TLPA/Apr2019/016 on 24.04.2019
Registered Structural Engineer
Regn.No.SE/Gr.II/TLPA/June2019/120
BASUVARAJ BUILDING, THILLAINGAR,
TRICHY - 620 018. Cell: 94430 59910


FLOOR-GROUND
GROUND FLOOR PLAN

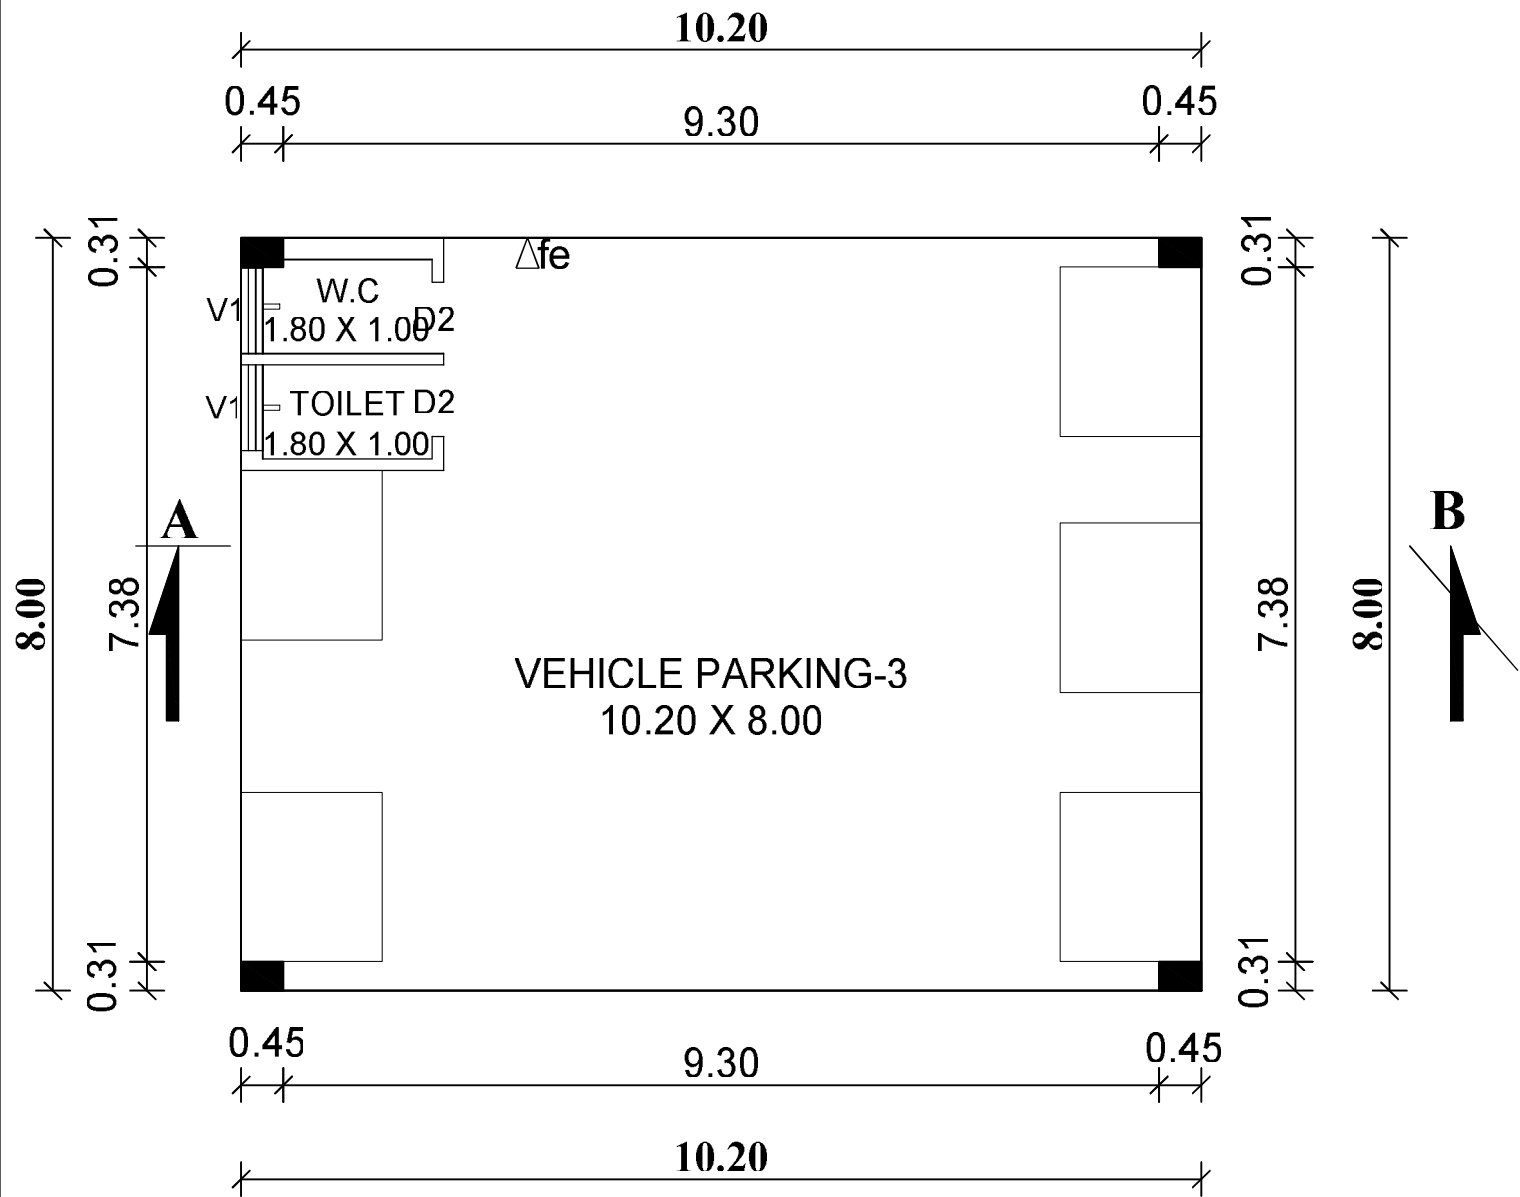



PLAN SHOWS THE EXISTING PAINTING BOOTH IN T.S.NO:70 (OLD S.F.NO: 25 /4 , 5, 6(PT), 8, 9 & 26/1A, 1B, 2, 3, 4, 5, 6, 8A, 8B (PT)) BLOCK NO:10, WARD-AM AT TRICHY- DINDIGUL NH ROAD, PRATTIYUR WEST VILLAGE, ZONE - V, TRICHIRAPPALLI CITY CORPORATION

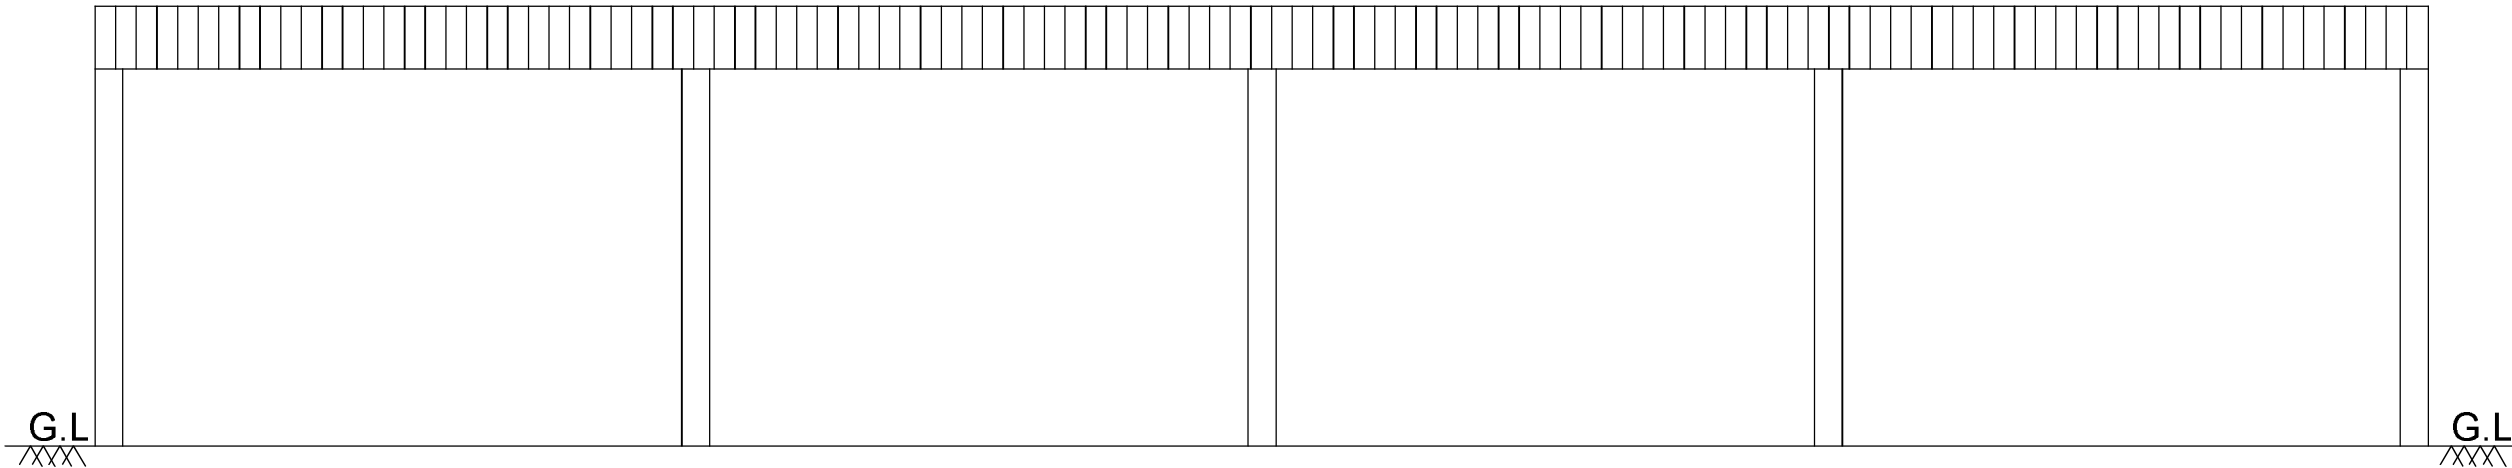

ELEVATION

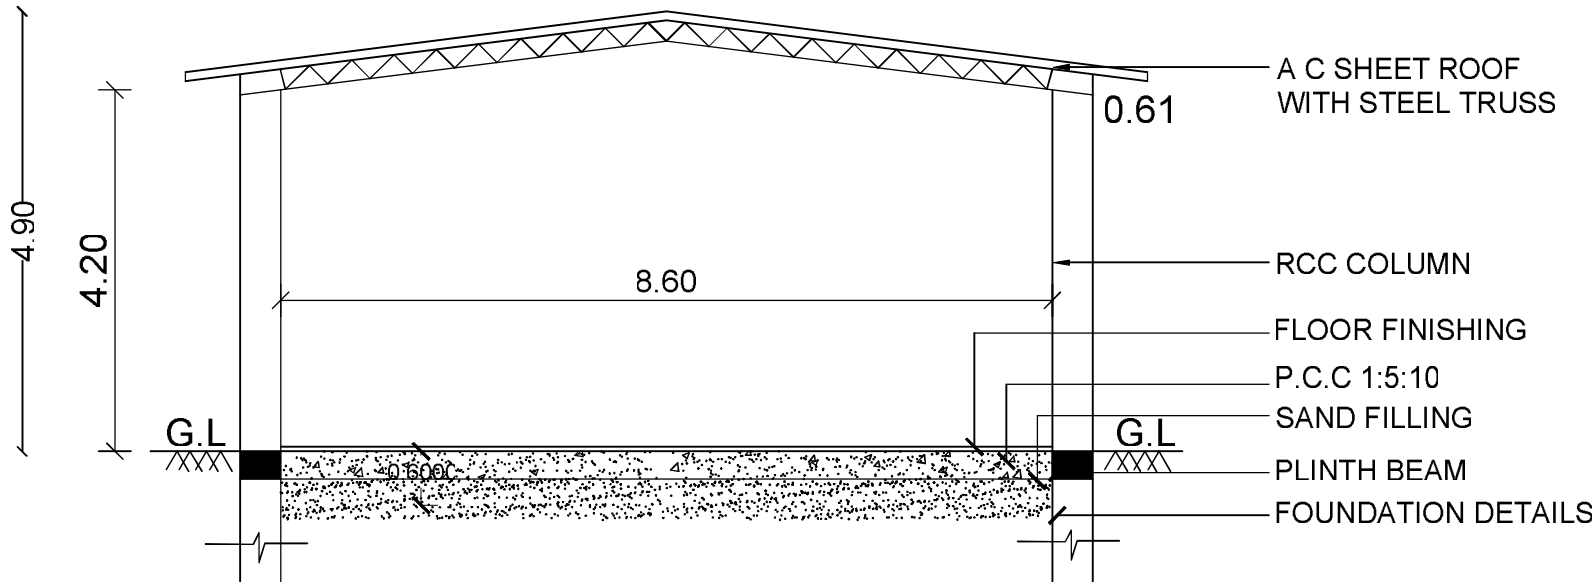

SECTION ON AB

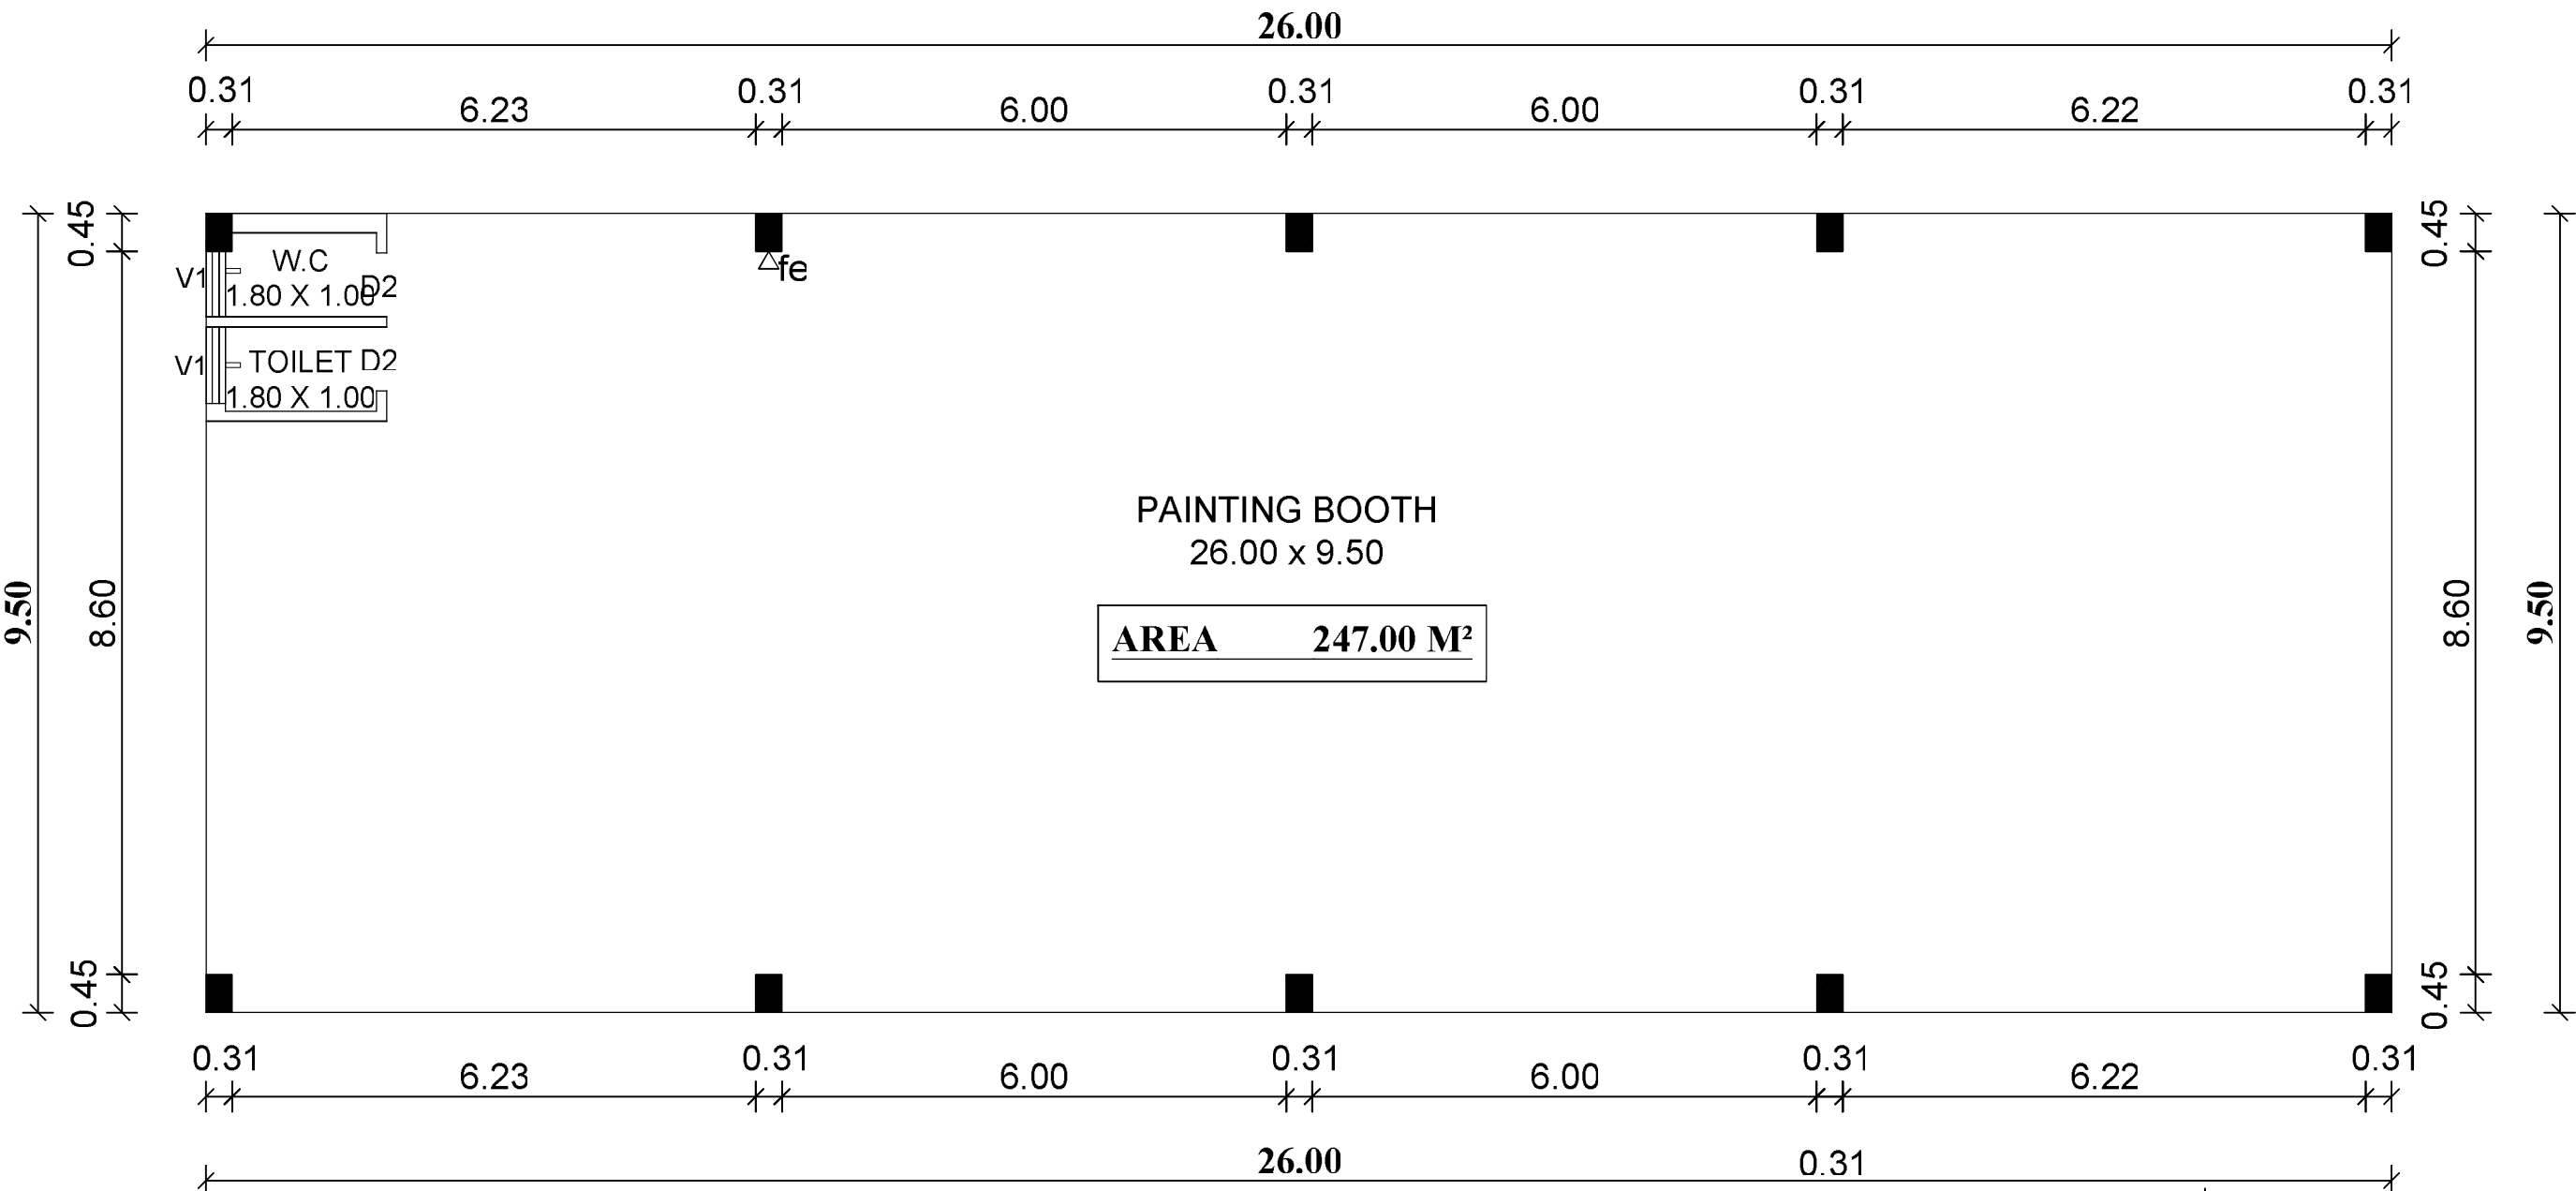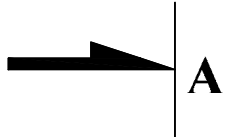

GROUND FLOOR PLAN

PPI/ JD DTCP NO.91/2024

B.P/DTCP No: 206/2024

REFERENCES:	METRES
V1 - VENTILATOR	0.91 X 0.61
D2 - DOOR	0.76 X 2.10

PAINTING BOOTH
GROUND FLOOR AREA - 247.00M²

△FE FIRE EXTINGUISHER SCALE 1:100

GEO-TECH ENGINEER

[Signature]
D. S. SETHAMIL KUMAR, B.E., M.E., Ph.D., FGS, MIEI,
Registered Geotechnical Engineer,
(TJR / RGE / 2019 / 086), Chartered Engineer,
703, Plot No.29, O M Rajoo Nagar,
Near New Bus Stand, THANJAVUR-613 005.

APPLICANT

For SHIVA AUTOMOBILES (P) LTD.

[Signature]
Director

CONSTRUCTON ENGINEER

[Signature]
K. MARUTHAN, B.E., M.I. Struct. E.M.I.C.E.,
CONSULTING STRUCTURAL ENGINEER
Corporation BLS No: 086/LS/2021/00012
Registered Engineer
Reg No: RE/Gr.I/TLPA/Apr2019/016 on 24.04.2019
Registered Structural Engineer
Regn.No.SE/Gr.II/TLPA/June2019/120
BASUVARAJ BUILDING, THILLAINGAR,
TRICHY - 620 018. Cell: 94430 59910

ARCHITECT:

[Signature]
K. MARUTHAN, B.E., M.I. Struct. E.M.I.C.E.,
CONSULTING STRUCTURAL ENGINEER
Corporation BLS No: 086/LS/2021/00012
Registered Engineer
Reg No: RE/Gr.I/TLPA/Apr2019/016 on 24.04.2019
Registered Structural Engineer
Regn.No.SE/Gr.II/TLPA/June2019/120
BASUVARAJ BUILDING, THILLAINGAR,
TRICHY - 620 018. Cell: 94430 59910

STRUCTURAL ENGINEER/
REGISTER ENGINEER :

[Signature]
K. MARUTHAN, B.E., M.I. Struct. E.M.I.C.E.,
CONSULTING STRUCTURAL ENGINEER
Corporation BLS No: 086/LS/2021/00012
Registered Engineer
Reg No: RE/Gr.I/TLPA/Apr2019/016 on 24.04.2019
Registered Structural Engineer
Regn.No.SE/Gr.II/TLPA/June2019/120
BASUVARAJ BUILDING, THILLAINGAR,
TRICHY - 620 018. Cell: 94430 59910

△_{FE} FIRE EXTINGUISHER

SCALE 1:100

B.P/DTCP No: 206/2024

For SHIVA AUTOMOBILES (P) LTD.
S.V. [Signature]
Director


D. S SENTHAMIL KUMAR, B.E., M.E., Ph.D., FGS, MIEI,
Registered Geotechnical Engineer,
(TJR/RGE/2019/036), Chartered Engineer,
703, Plot No.29, O.M Rajoo Nagar,
Near New Bus Stand, THANJAVUR-613 005.

DR. M. MATHIYANDAN, Ph.D., M.Sc., E.M.B., C.E.
CONSULTING STRUCTURAL ENGINEER
Corporation BLS No: 086/15/2021/00012
Registered Engineer
Reg. No: RE/Gr./I/TPA/Apr2019/016 on 24.04.2019
Registered Structural Engineer
Reg. No. SE/Gr./I/TPA/June2019/120
BASUVARAJ BUILDING, THILLAINAGAR,
TRICHY - 670 018. Cell: 94430 59910

BASUVARAJ BUILDING ENGINEER

CONSULTING STRUCTURAL ENGINEER
Corporation BIS No: 086/S/2011/00012
Registered Engineer
Reg. No: RE/Grl/TILPA/Apr2019/016 on 24.04.2019
Registered Structural Engineer
Regn.No.SE/Grl.V/TILPA/June2019/120
BASUVARAJ BUILDING, THILLAINGAR,
TRICHY - 620 018. Cell: 94430 59910

DR. M. MATHUR, Ph.D., M.Sc., E.M.C.,
CONSULTING STRUCTURAL ENGINEER
Corporation BLS No: 086/LS/2021/00012
Registered Engineer
Reg. No: RE/Gr./I/TPA/Apr2019/016 on 24.04.2019
Registered Structural Engineer
Reg.No:SE/Gr./I/TPA/June2019/120
BASUVARAJ BUILDING, THILLAINGAR,
TRICHY - 620 018. Cell: 94430 59910

GROUND FLOOR PLAN

