



PLAN SHOWING THE PROPOSED CONSTRUCTION OF R.C.C ROOF RESIDENTIAL BUILDING IN GROUND FLOOR , IN OLD S.F.NO:99/3,99/3A ,NEW S.F.NO:99/3A2A ,
PATTA NO :7012,TIRUVENGADAM TOWN PANCHAYAT AND TALUK, TENKASI DISTRICT.


NAME OF APPLICANT :- Mrs.K.SULOCHANA W/O KARTHIKEYAN.

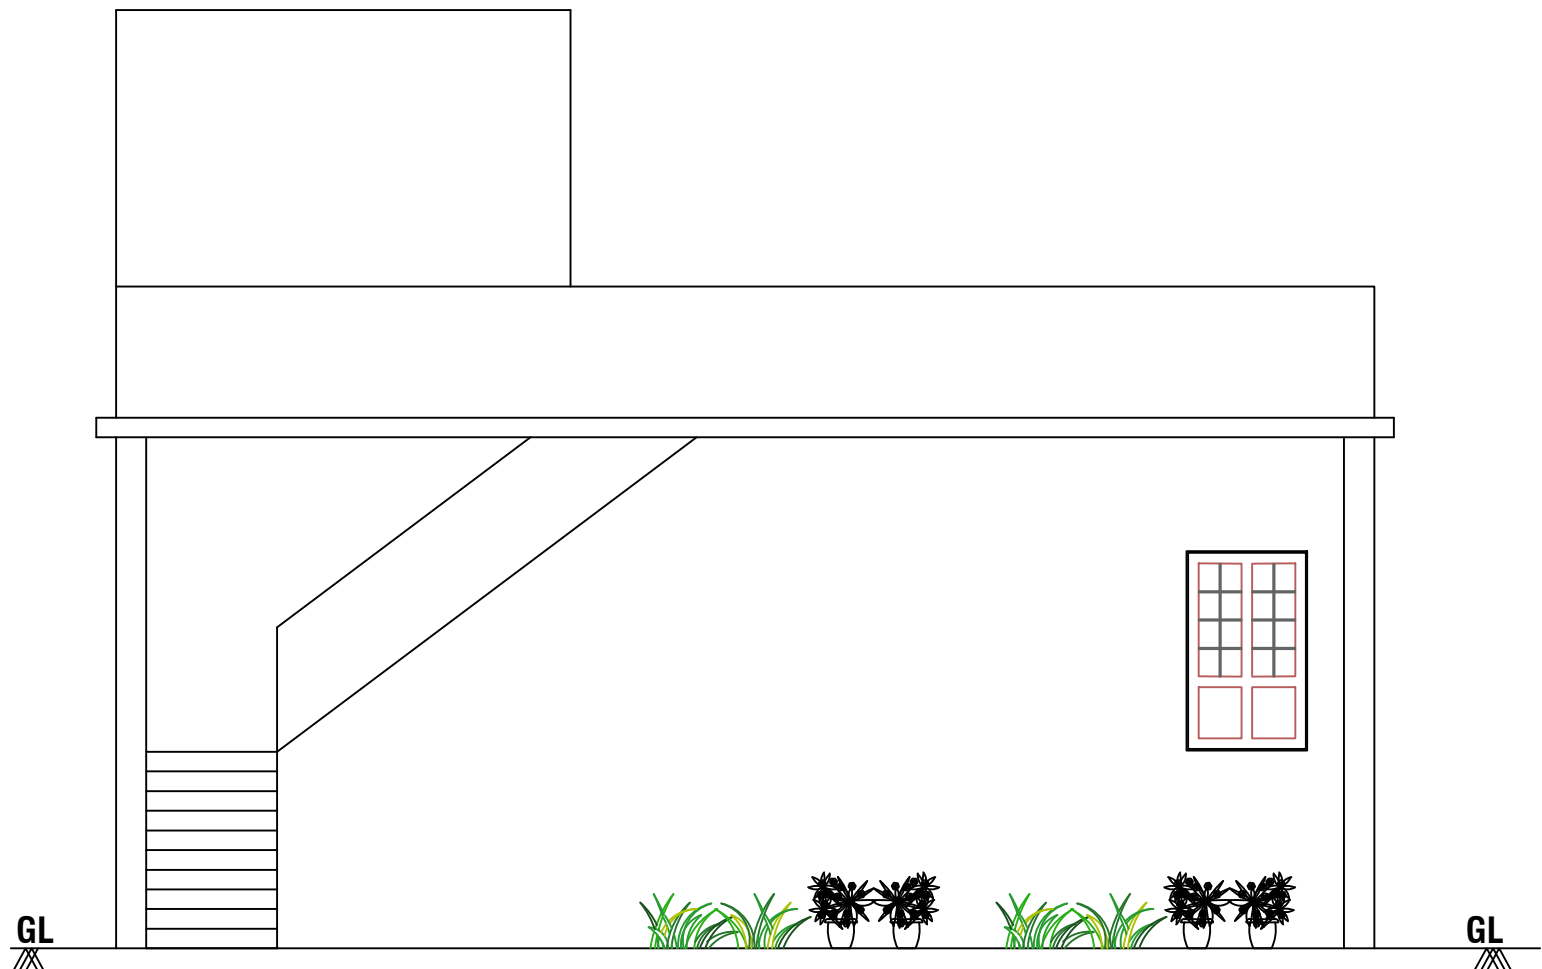


ELEVATION

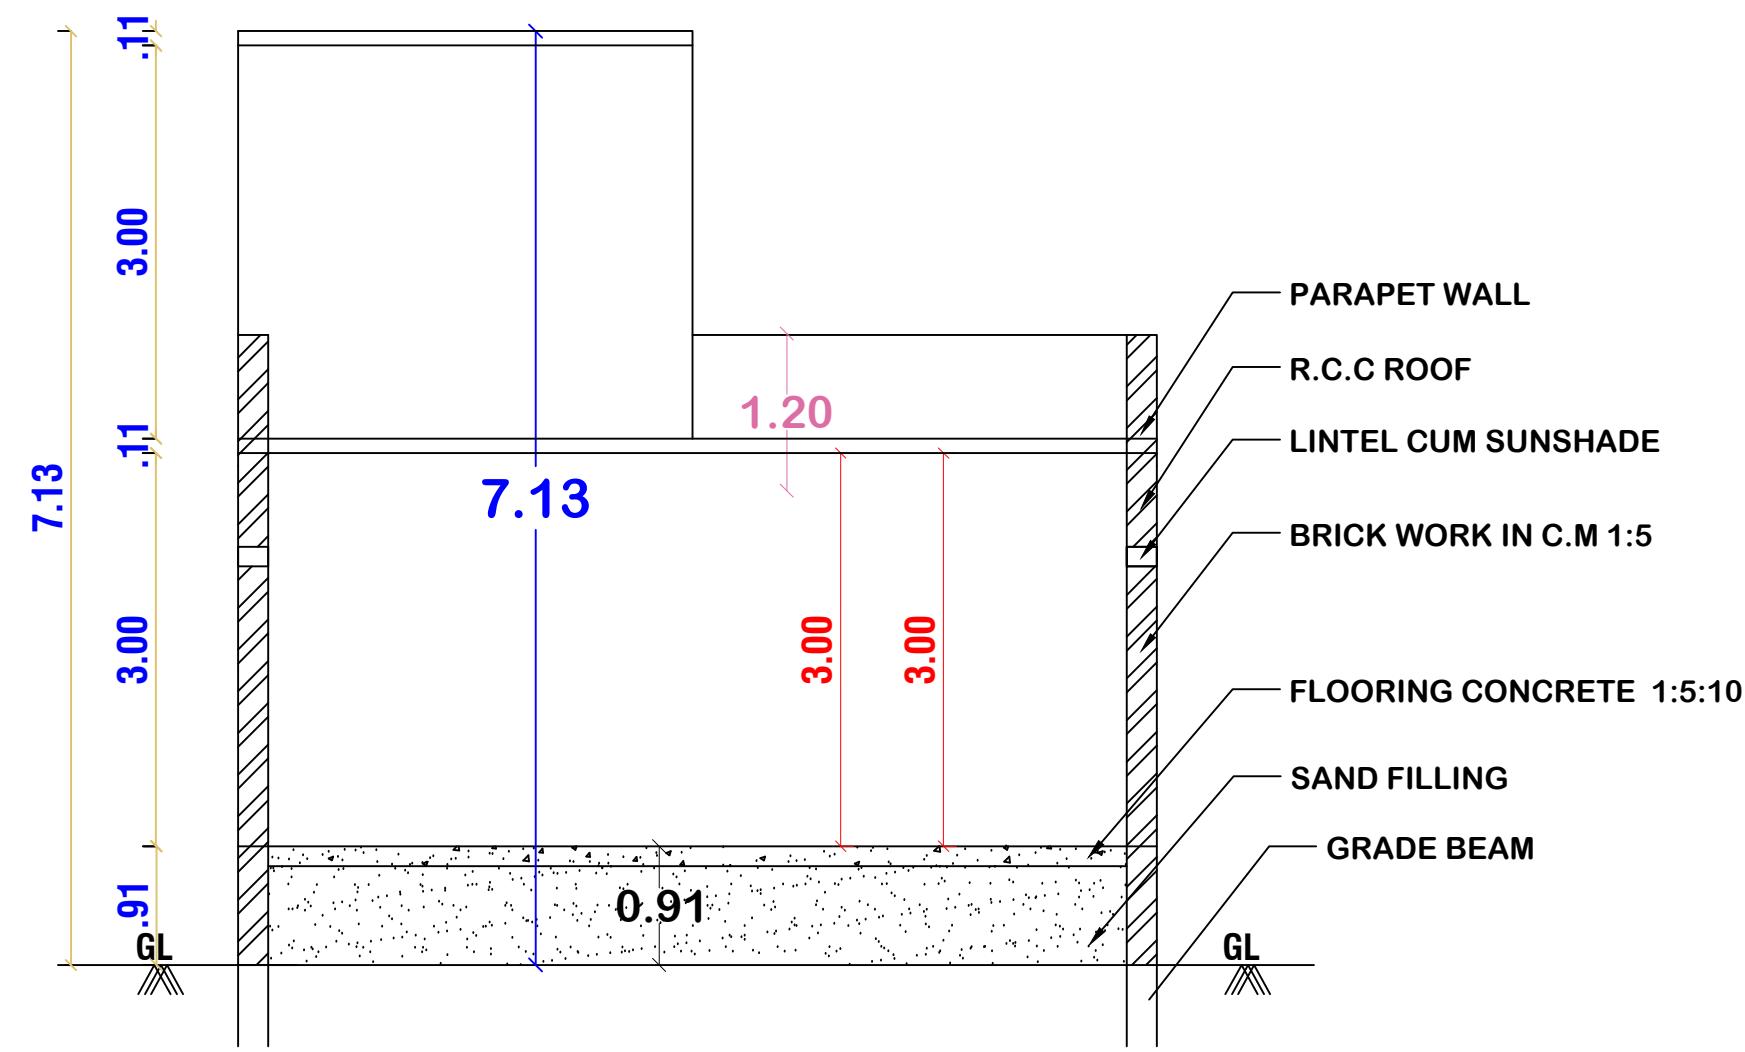


SECTION-"AA"

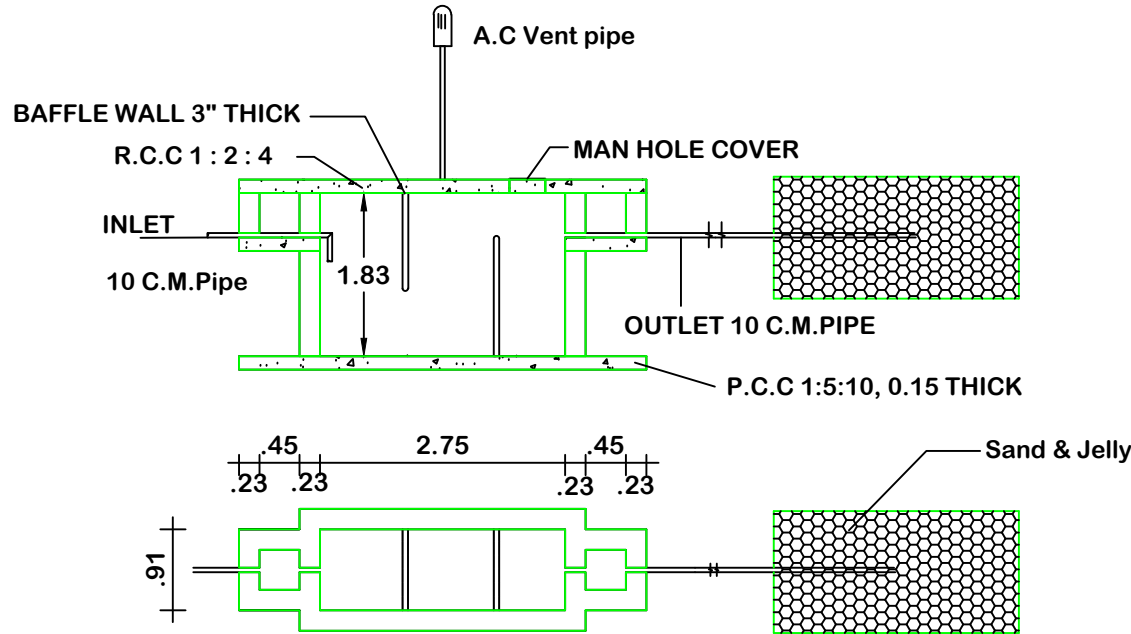


SEPTIC TANK AND TRENCH

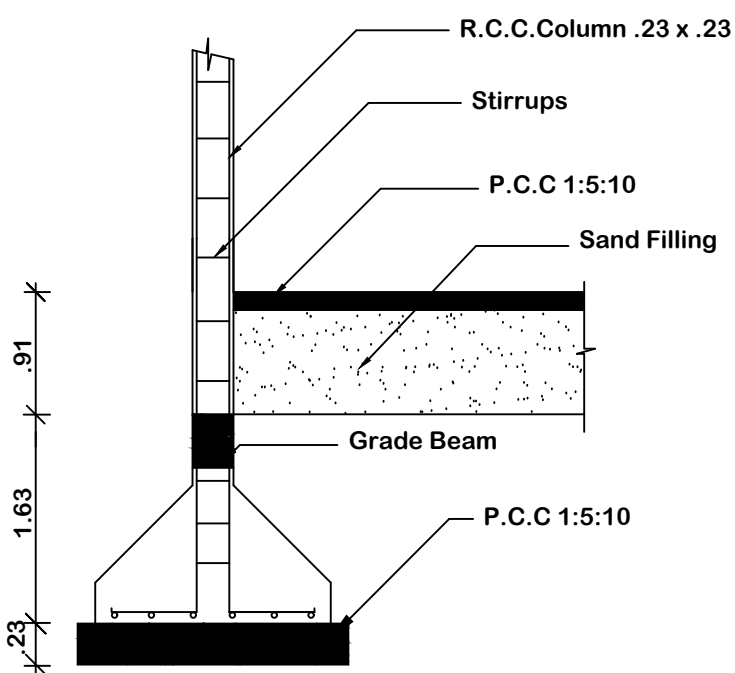


COLUMN DETAIL

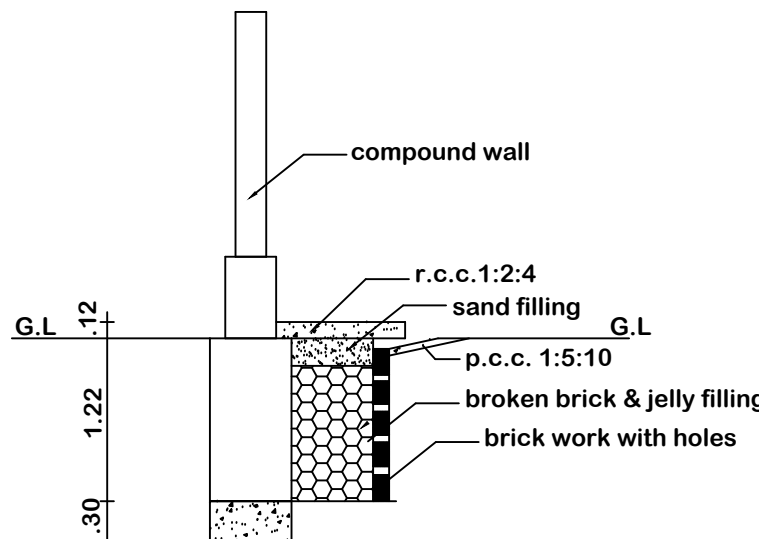

PLINTH BOUNDARY PERCOLATION PIT

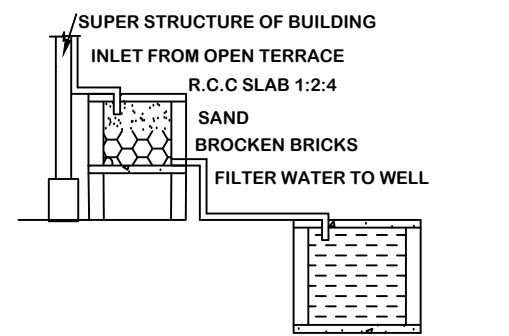


RAINWATER HARVESTING

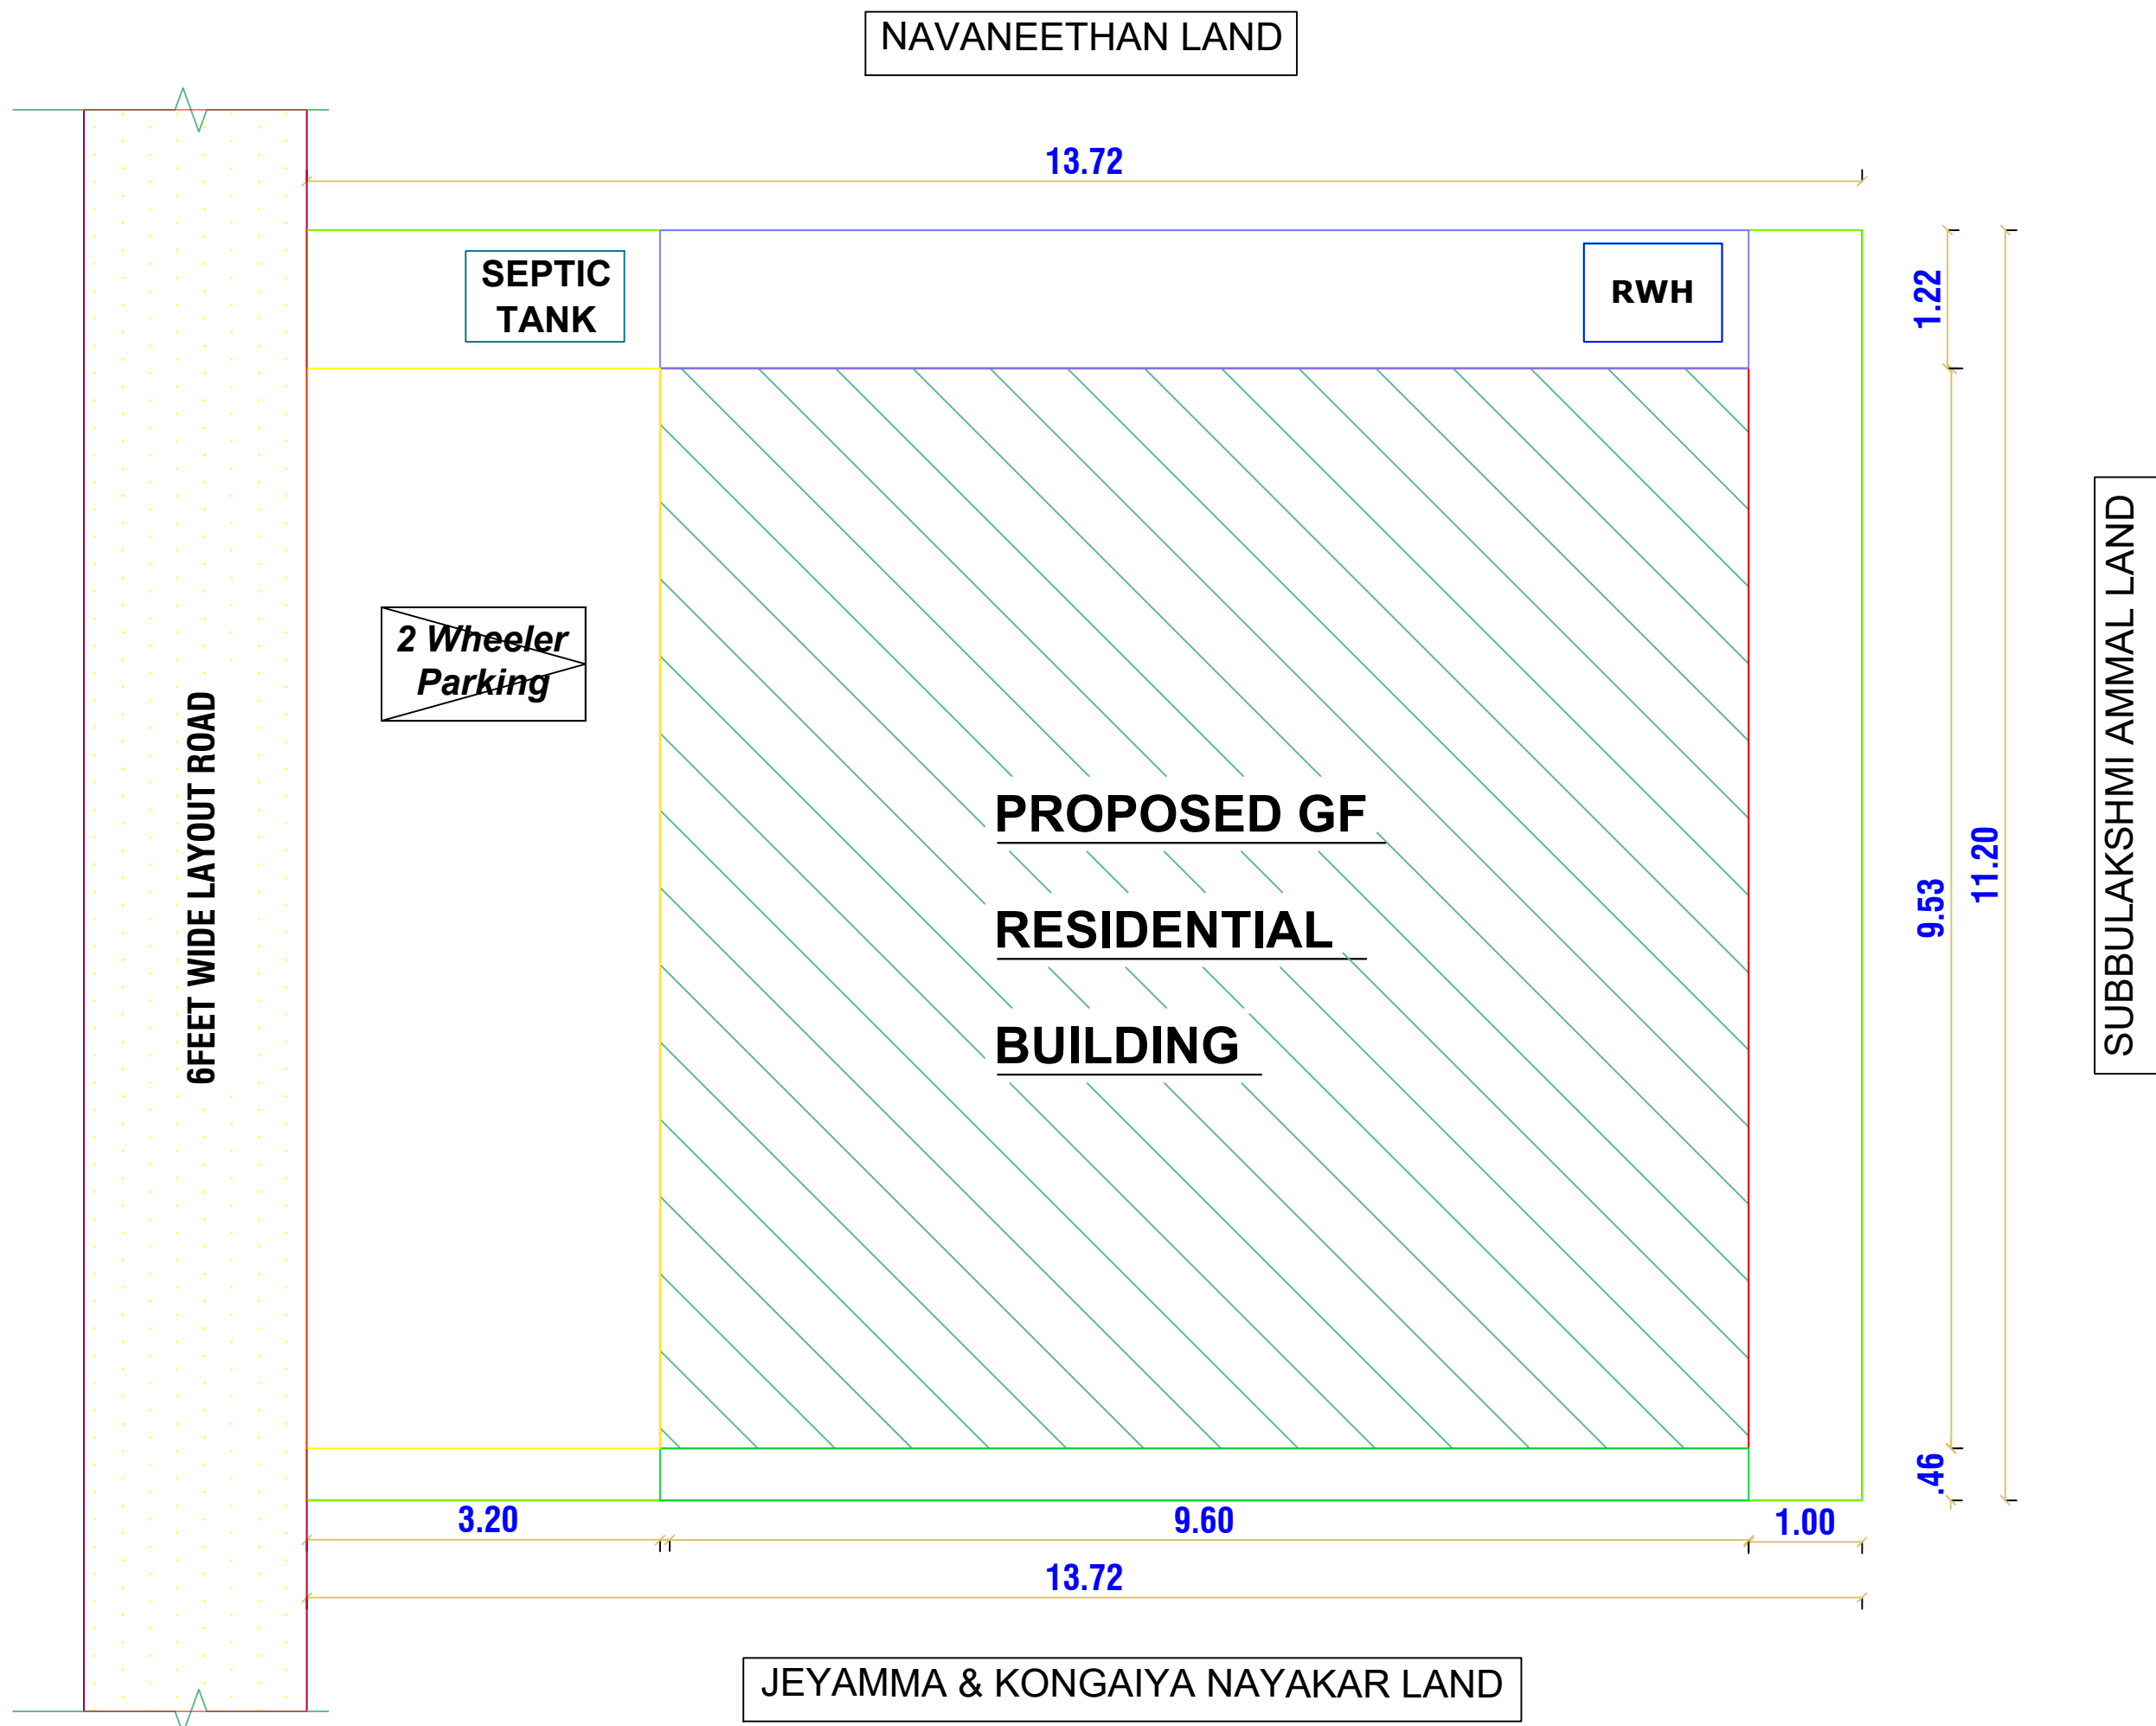


KEY PLAN (N.T.S)


N

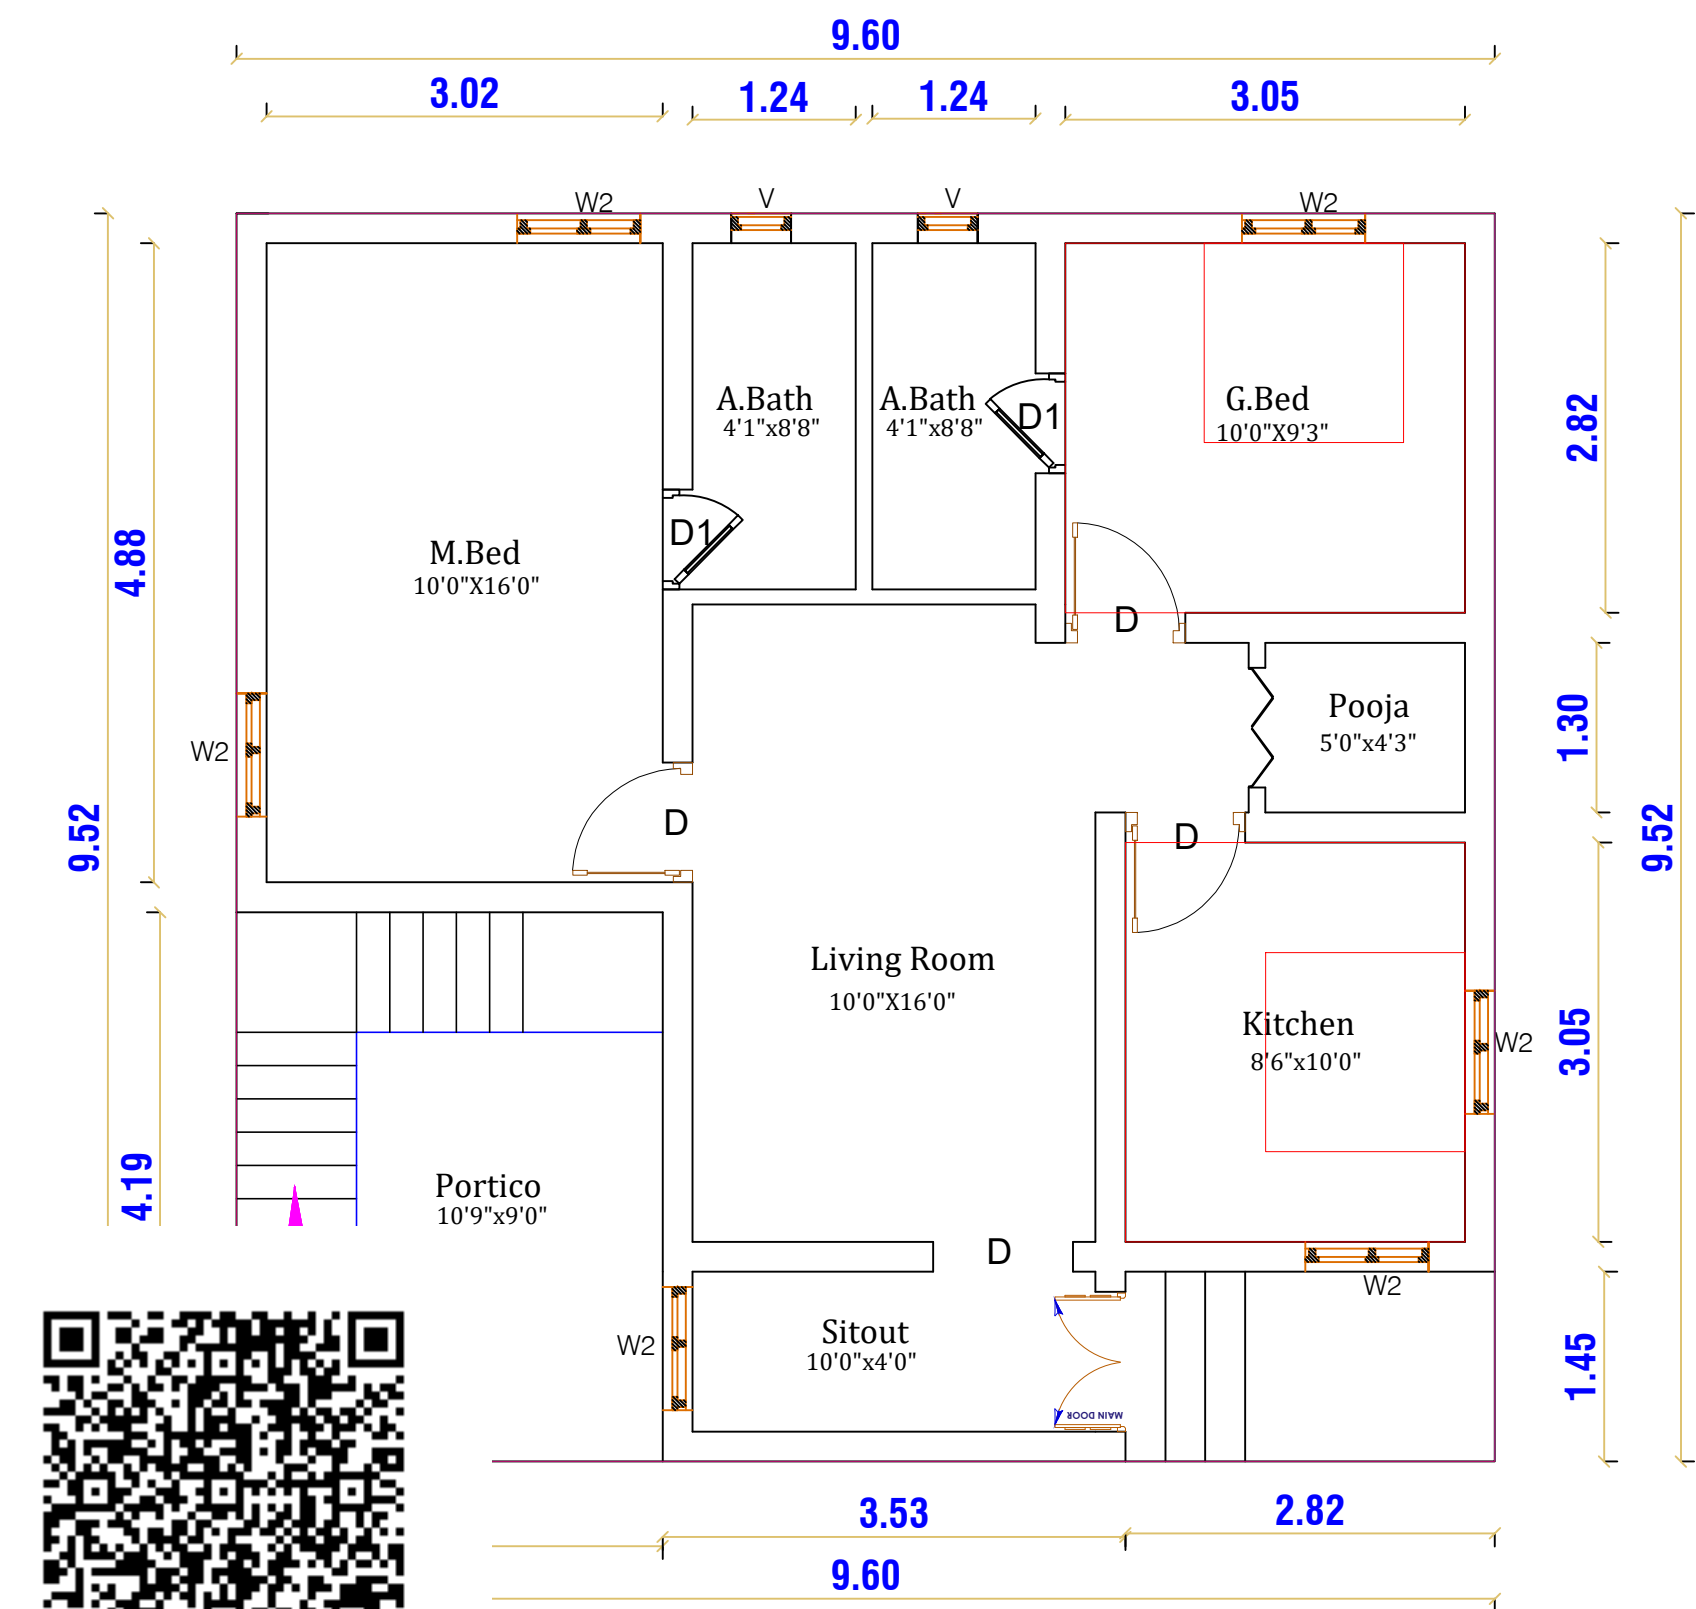



GROUND FLOOR PLAN

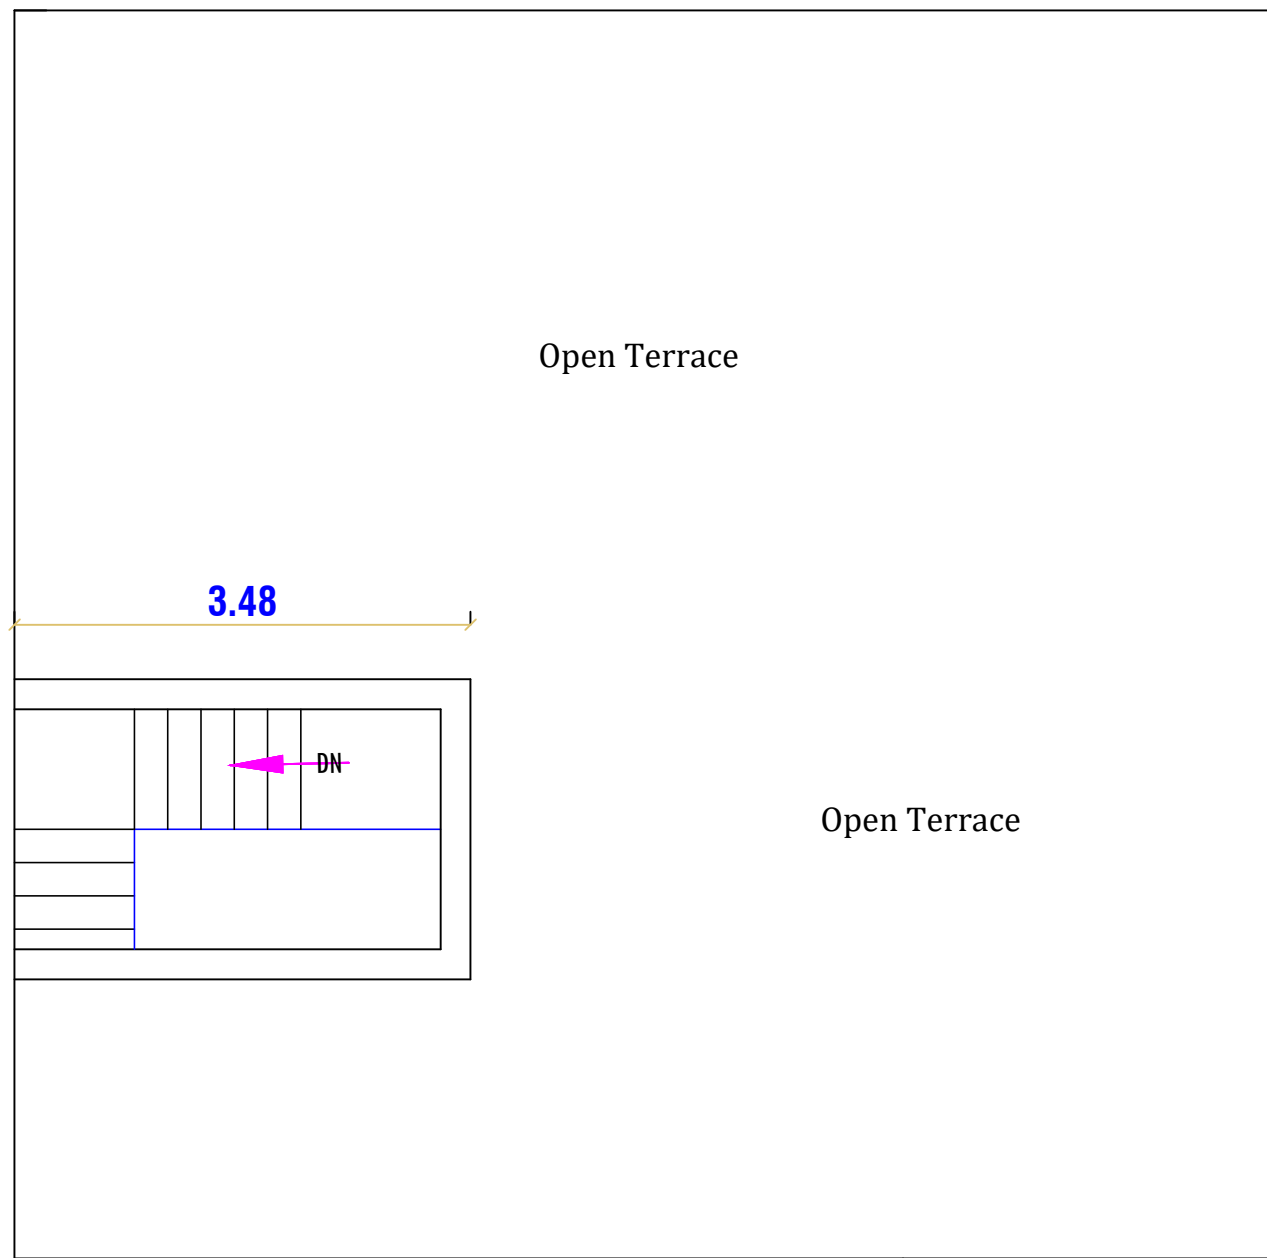


TERRACE FLOOR PLAN

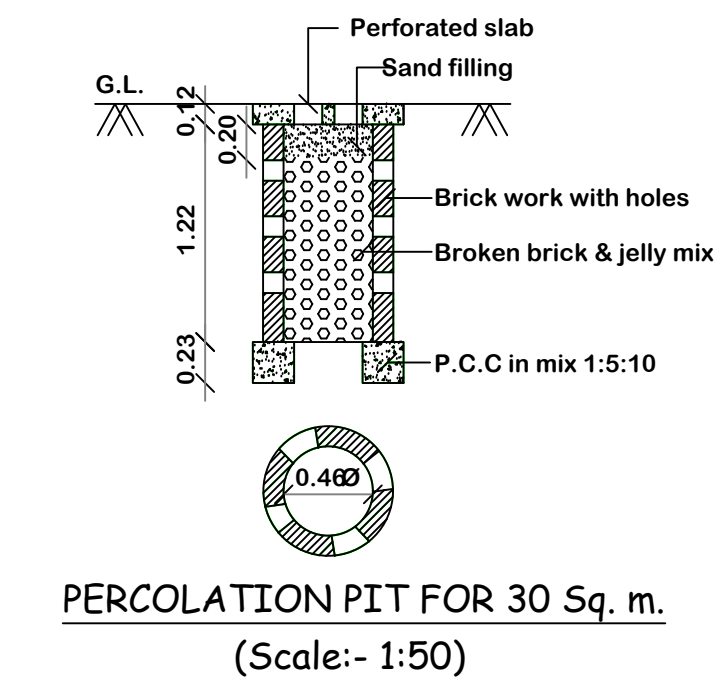


SOLAR SYSTEM FLOW DIAGRAM

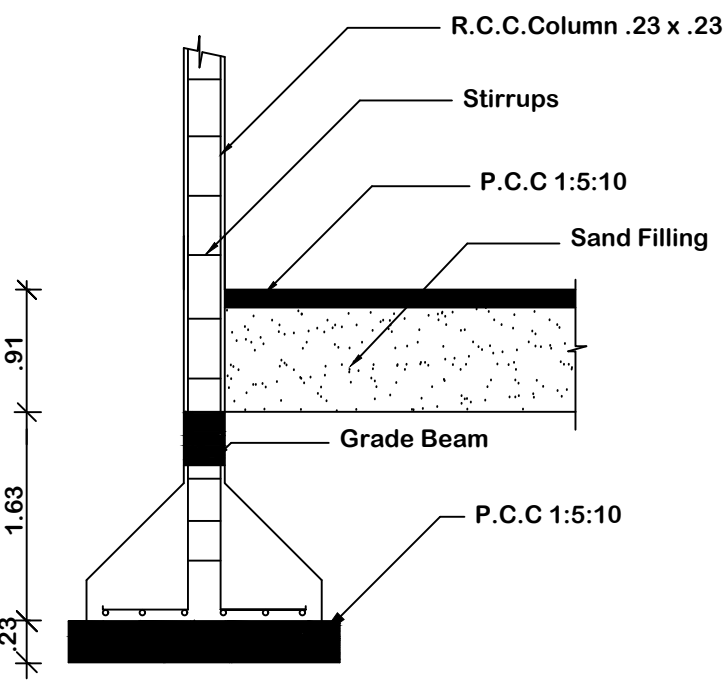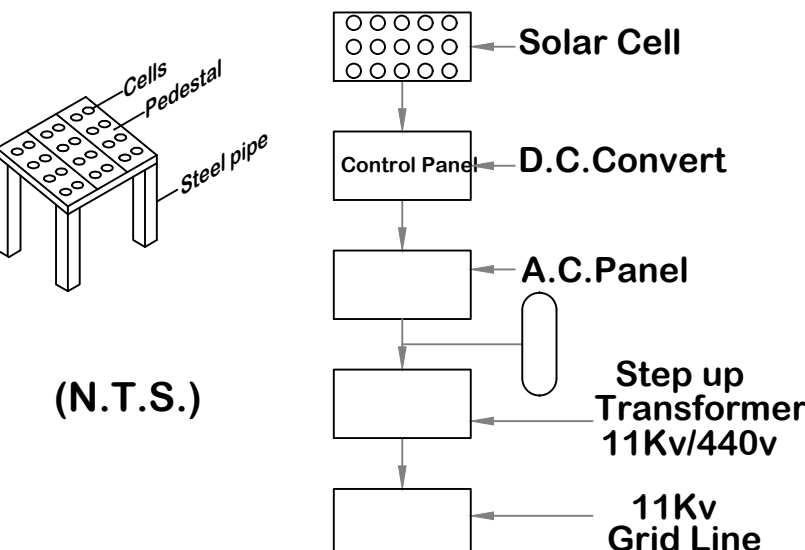

COLUMN DETAIL

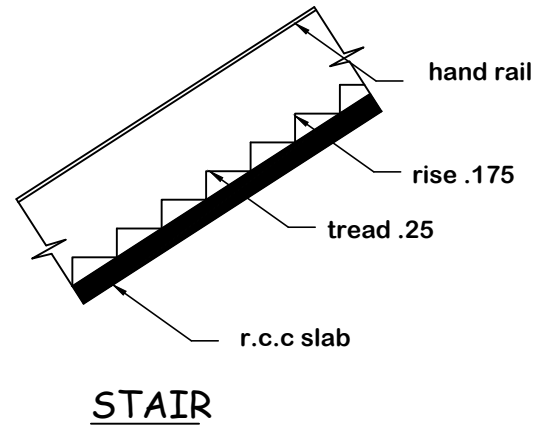

STAIR

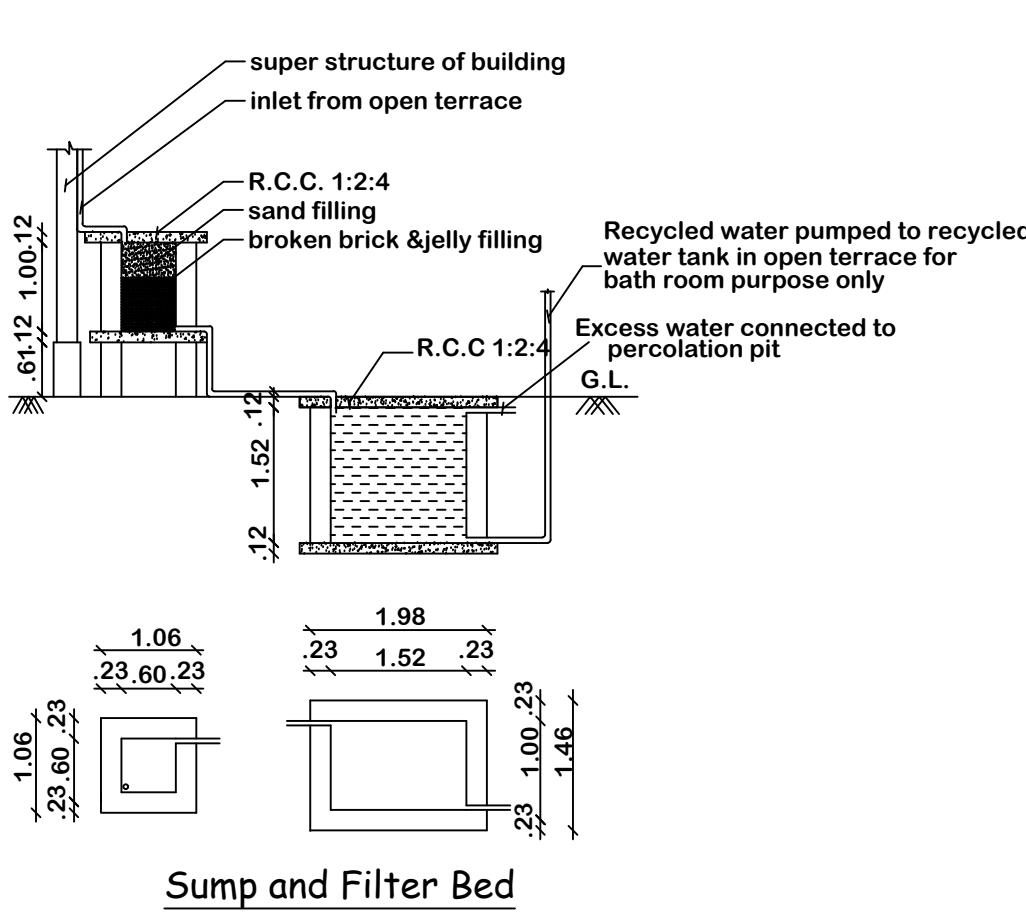

Sump and Filter Bed

OFFICE USE			
AREA DETAILS			
REF.	DESCRIPTION	SQ.M	SQ.FT
☐	SITE AREA	153.64	1653.75
☐	PRO. PLINTH AREA IN G.F	91.43	984.14
☐	OPEN AREA	62.20	669.61
☐	F.S.I	0.59	
JOINERY DETAILS			
MD	Door	1.00 x 2.10	
D1	Door	0.91 x 2.10	
D2	Door	0.75 x 2.10	
W	Window	1.50 x 1.50	
W1	Window	1.20 x 1.50	
V	Ventilator	0.90 x 0.60	
ALL DIMENSIONS ARE IN METRE, SCALE 1:100			
Note:			
Waste Water Used for Garden			
Rain Water harvesting Details Provided			
Rain water harvesting tank to be provided			

Sulochana.k

APPLICANT

S.Selvaramachandran

E.R.S.SELVARAMACHANDRAN, DCE., B.E.,
CONSULTING ENGINEER & LICENSED SURVEYOR
REGISTRATION NO: 129/LS/2022/00016
K. V CONSTRUCTION
101, VIJAYAM MESS 1st FLOOR,
SIVAKASI MAIN ROAD,
THIRUTHANGAL 626 130.
MOBILE NO: 8124694663.

ENGINEER