

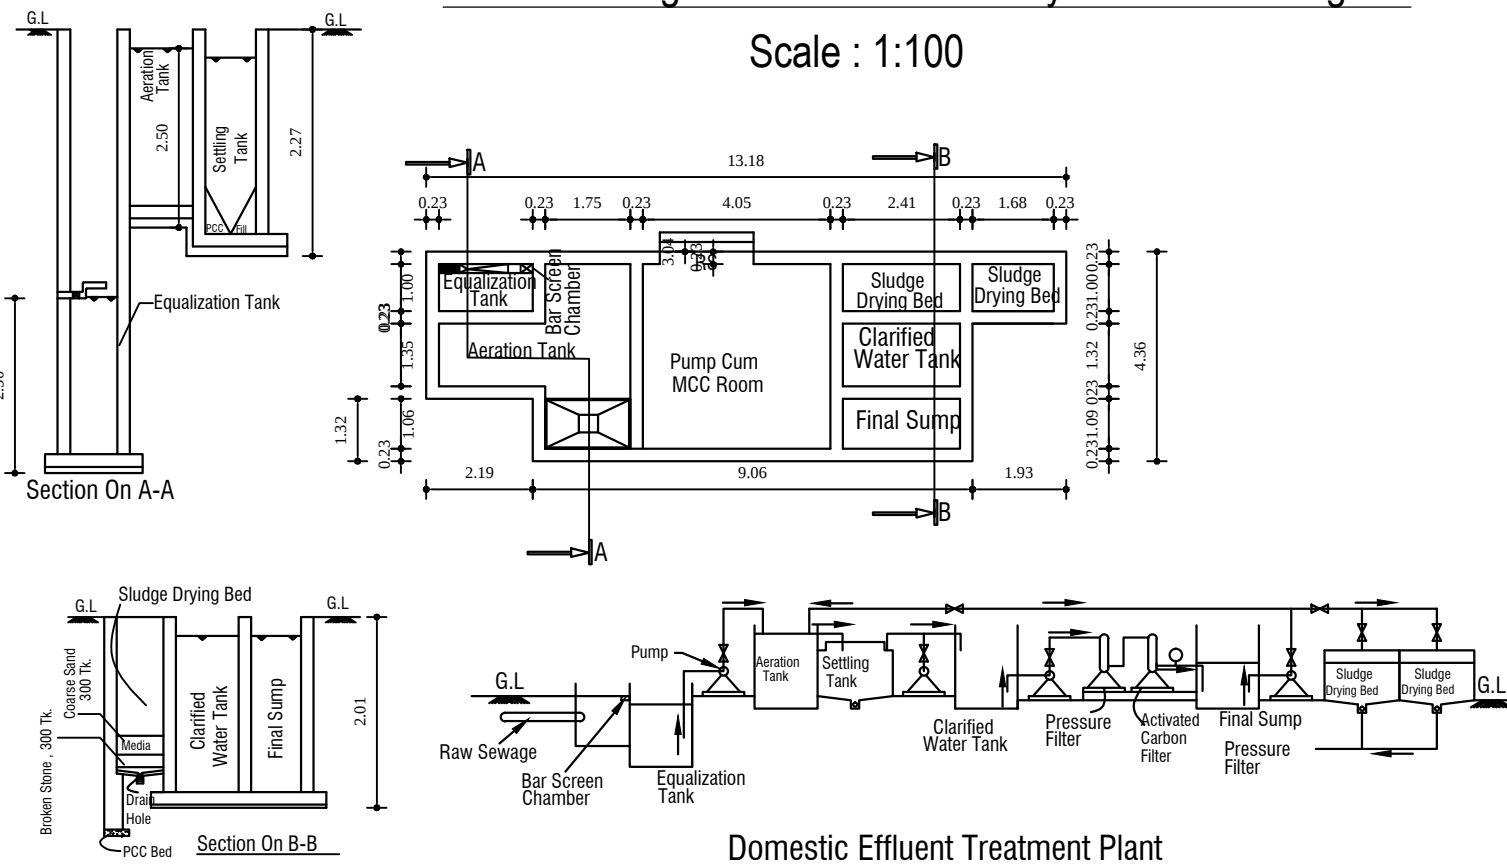
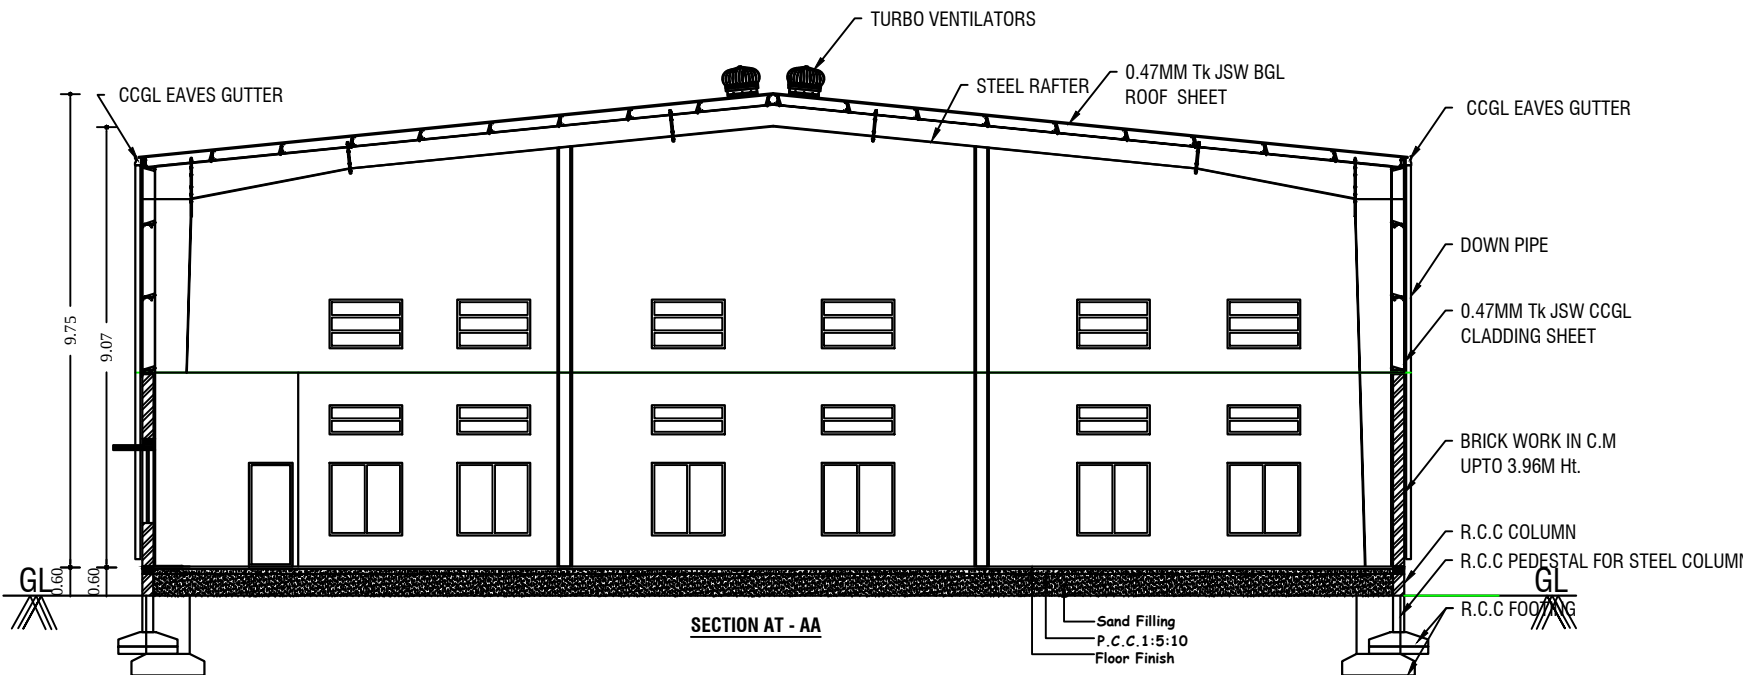
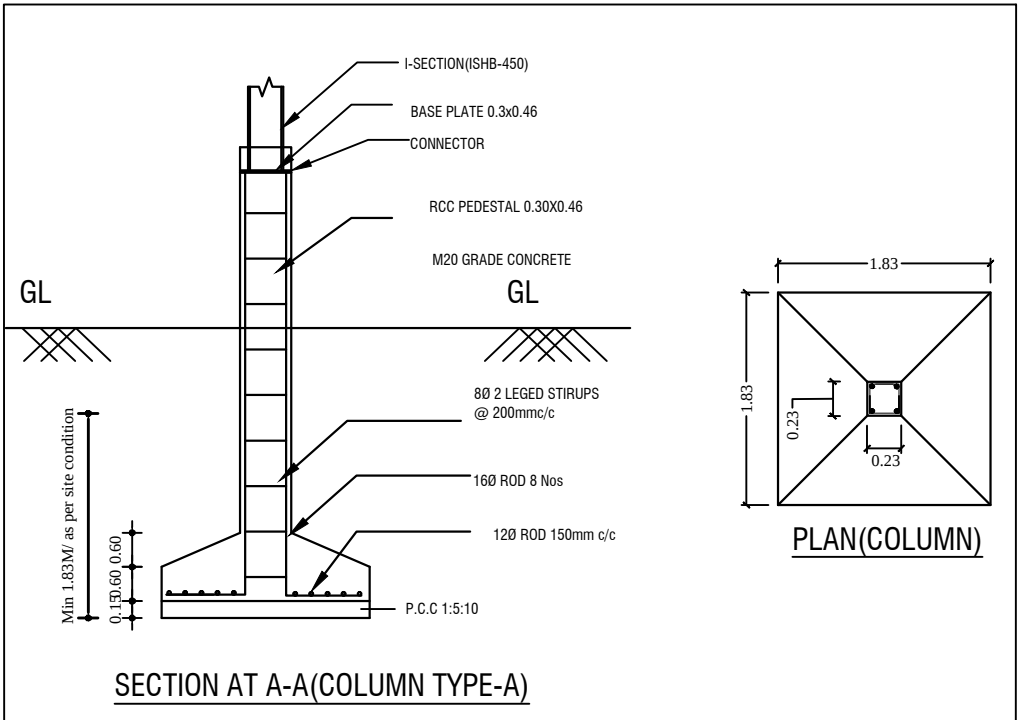


Plan of Sewage Treatment Plant & Hydraulic Flow Diagram

Scale : 1:100

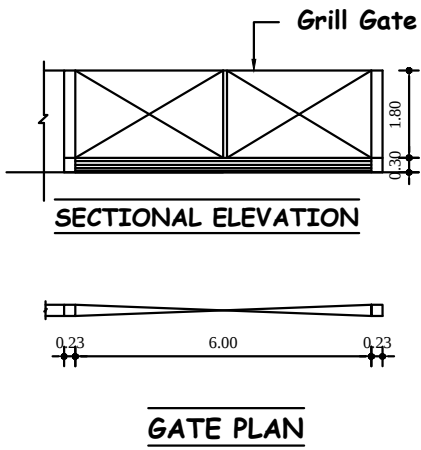

Domestic Effluent Treatment Plant Hydraulic Flow Diagram

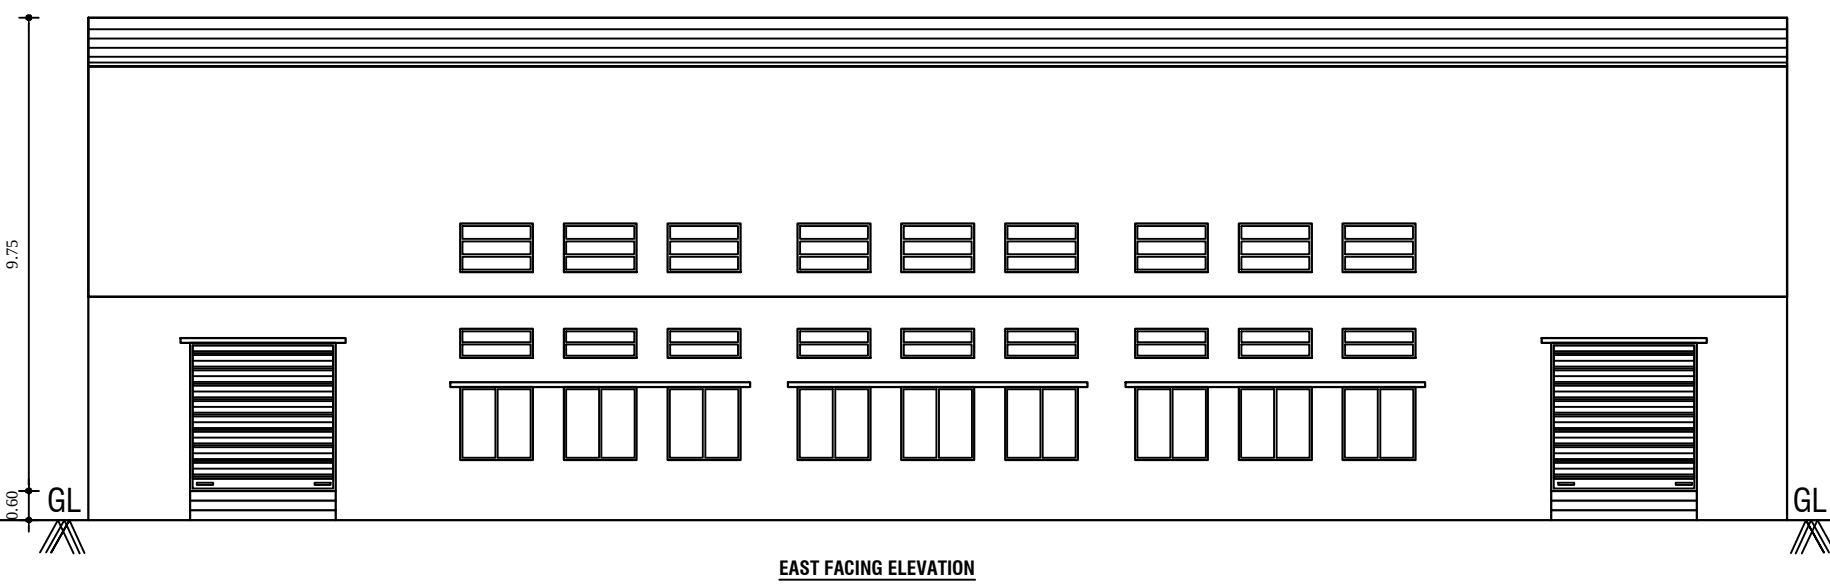

District Town And Country Planning Office
Villupuram District
Online Application No: SWP/BPA/0011104/2023
BUILDING APPROVAL:
B.P.A.D.T.C.P(V.D) No: 29/2023
INDUSTRIAL TECHNICAL APPROVAL issued.

Dr. R. Saranya M.E.,
District Town and Country Planning Officer
Villupuram District

Supervisor Draughtsman Grade - II
District Town and Country Planning Office
Villupuram District

N	ALL DIMENSIONS ARE IN METER	SCALE: 1:100	SHEET: 1/1
MAIN BLOCK- DETAILED PLAN & SITE PLAN			

DETAILED PLAN AND SITE PLAN SHOWING THE PROPOSED CONSTRUCTION OF INDUSTRIAL BUILDING IN PLOT NO.12&13, SIDCO INDUSTRIAL ESTATE S.F.No. 70/5(PART) OF PATTANAM VILLAGE & PANCHAYAT, TINDIVANAM TALUK, (DTCP APPROVAL NO: 30/2014) VILLUPURAM DISTRICT.

ORANGE CATEGORY-CODE :2999.
APPLICANT : M/S ADESSPENNO

SITE AREA DETAILS		FLOOR SPACE INDEX (F.S.I.)		SHEDS DESIGN (AS PER DTCP APPROVAL)	
VILLAGE	S.F.No	TOTAL BUILDING AREA	TOTAL BUILDING AREA	EMERGENCY LIGHT	
PATTANAM	70/5(PART)	1100.00	1100.00	FIRE ALARM SYSTEM	
BUILDING AREA		1100.00	1100.00	FIRE ALARM	
Floor Name	1000 SQ FT	1000 SQ FT	1000 SQ FT	FIRE EXTINGUISHER	
GROUND FLOOR	1100.00	1100.00	1100.00		
TOTAL	1100.00	1100.00	1100.00		

JOINERY DETAILS		TYPES OF VEHICLE PARKING		REQUIRED NOS		PROVIDED NOS	
ITEM	QTY	ITEM	QTY	CYCLE	18	21	
1	1	2	1	TWO WHEELER	18	18	
2	1	3	1	LORRY PARKING	02	02	
3	1	4	1	DA PARKING	-	01	
4	1	5	1	DA TWO WHEELER PARKING	-	01	
5	1	6	1				
6	1	7	1				
7	1	8	1				
259	1	260	1				
260	1						