



PLAN SHOWING THE PROPOSED CONSTRUCTION OF A DWELLING G.F CONCRETE ROOF HOUSE AT SY NO:261/12A1B&261/11A3B, PATTA NO:1473,

KALAMPUTHU STREET, KALANGUDIRUPPU VILLAGE, UDANGUDI SELECTION GRADE TOWN PANCHAYAT, TIRUCHENDUR TALUK, THOOTHUKUDI DISTRICT.


NAME OF THE APPLICANT: Mrs. AMRINBANU S (W/O) Mr.H MUBARAK ALI

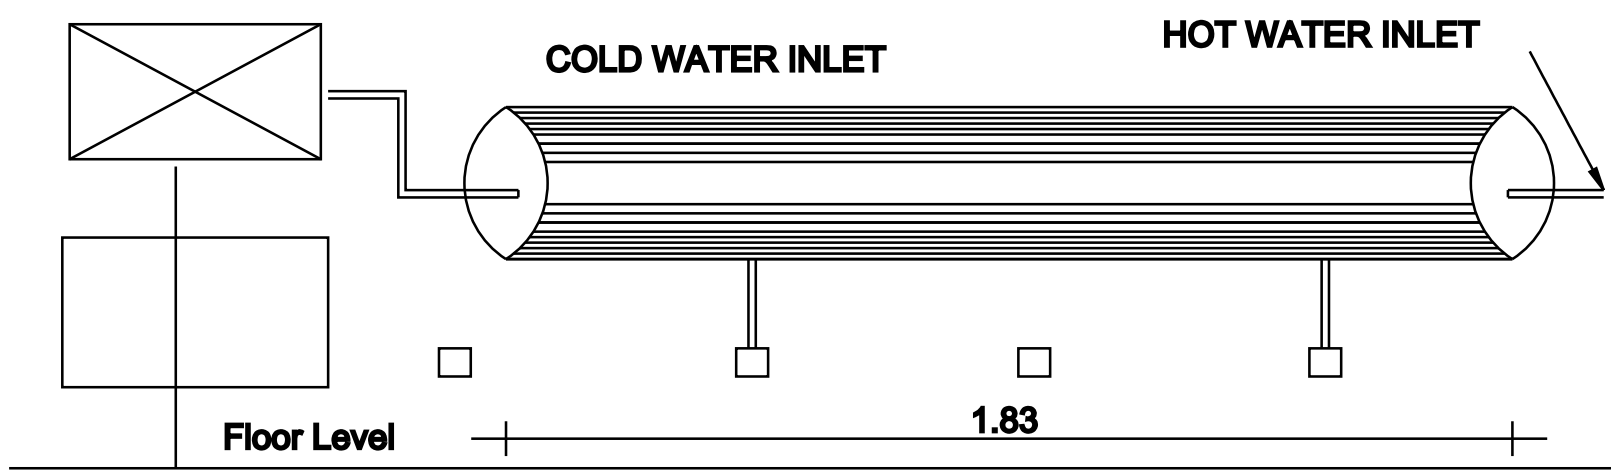


DETAILS OF SOLAR HOT WATER SYSTEM

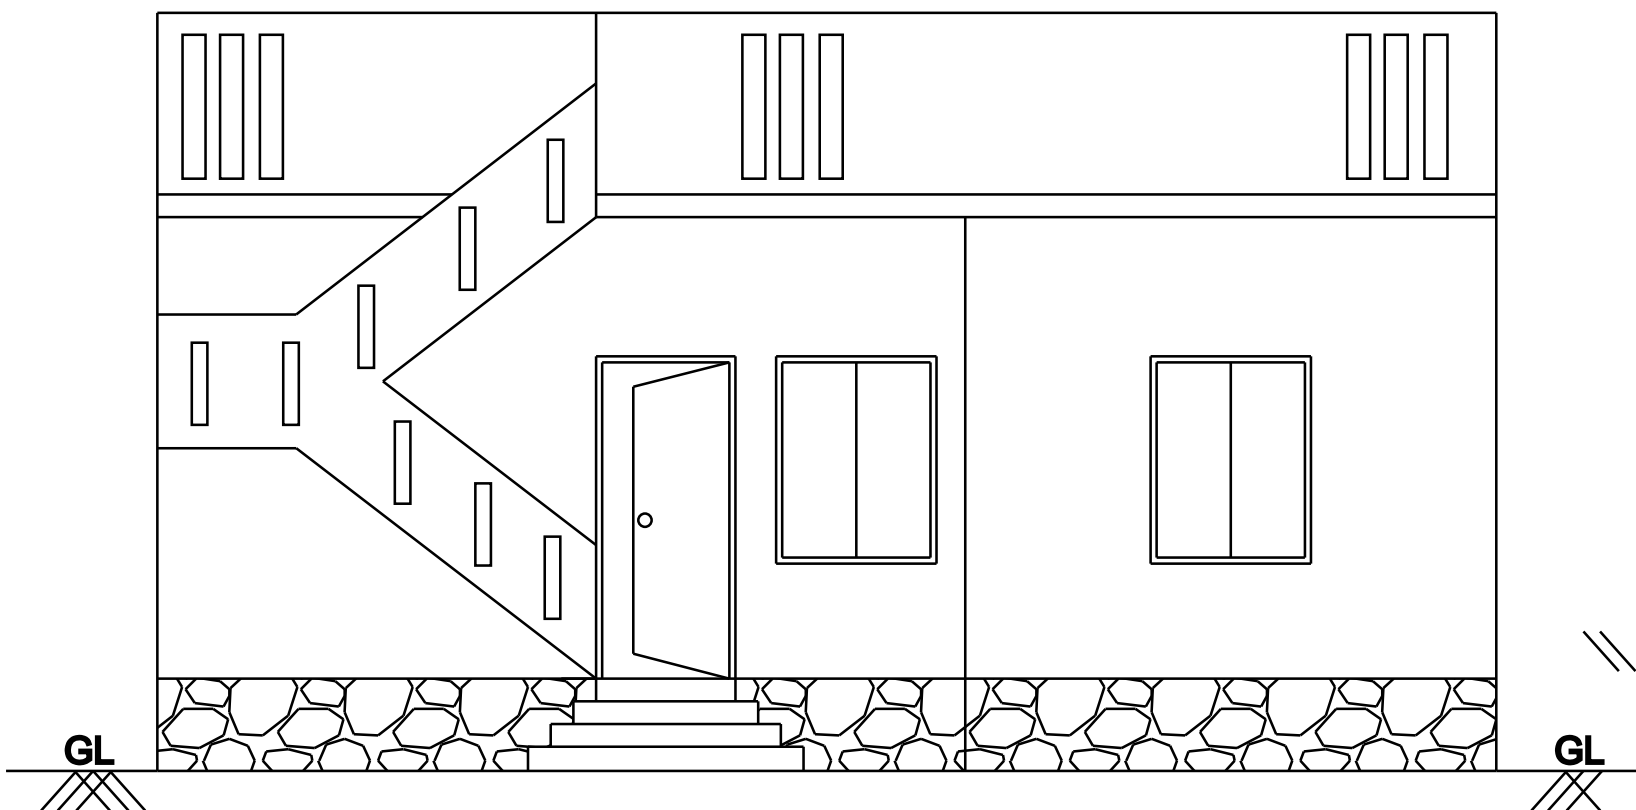

FRONT ELEVATION

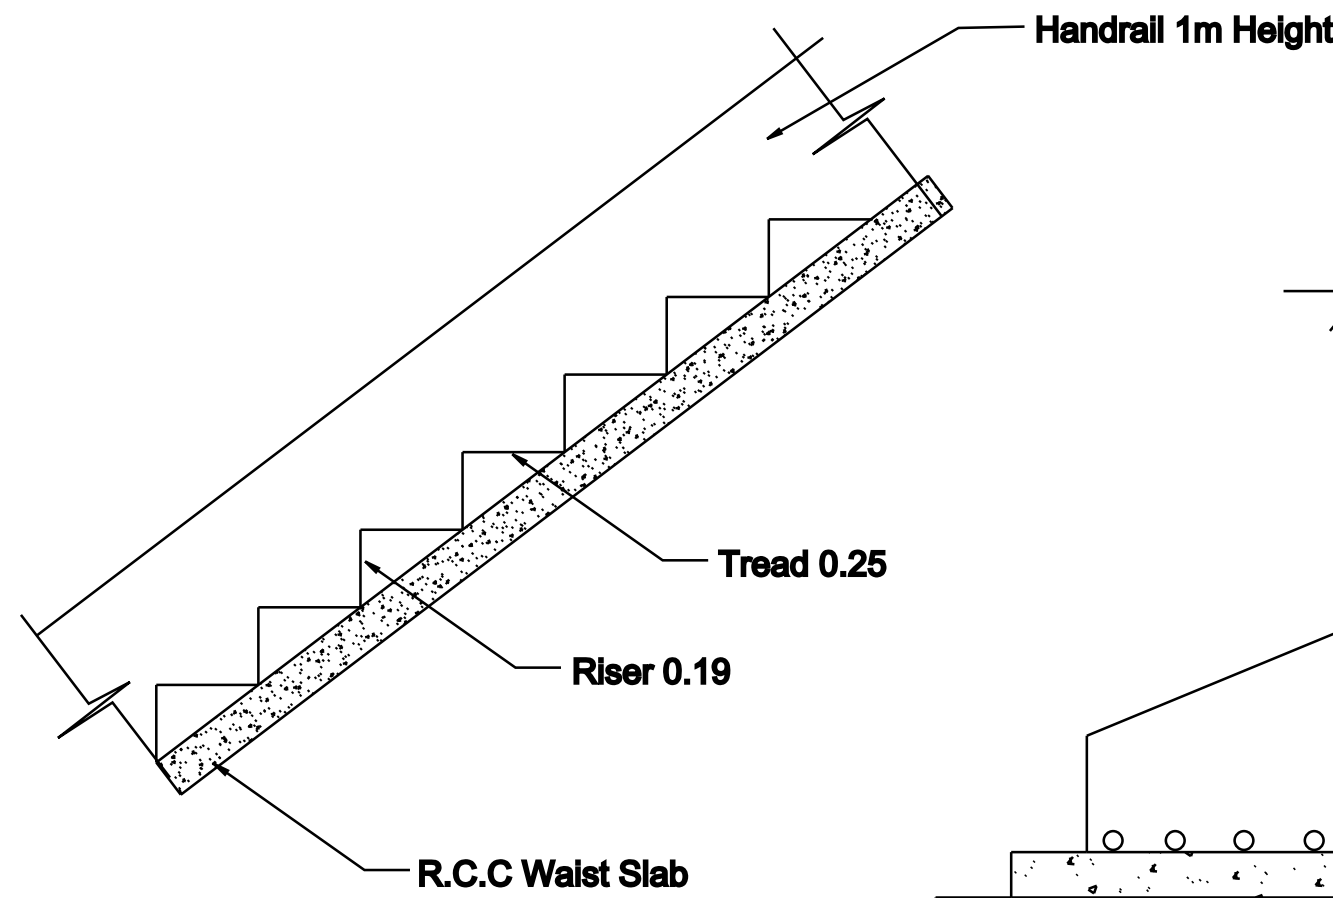

STAIR DETAILS


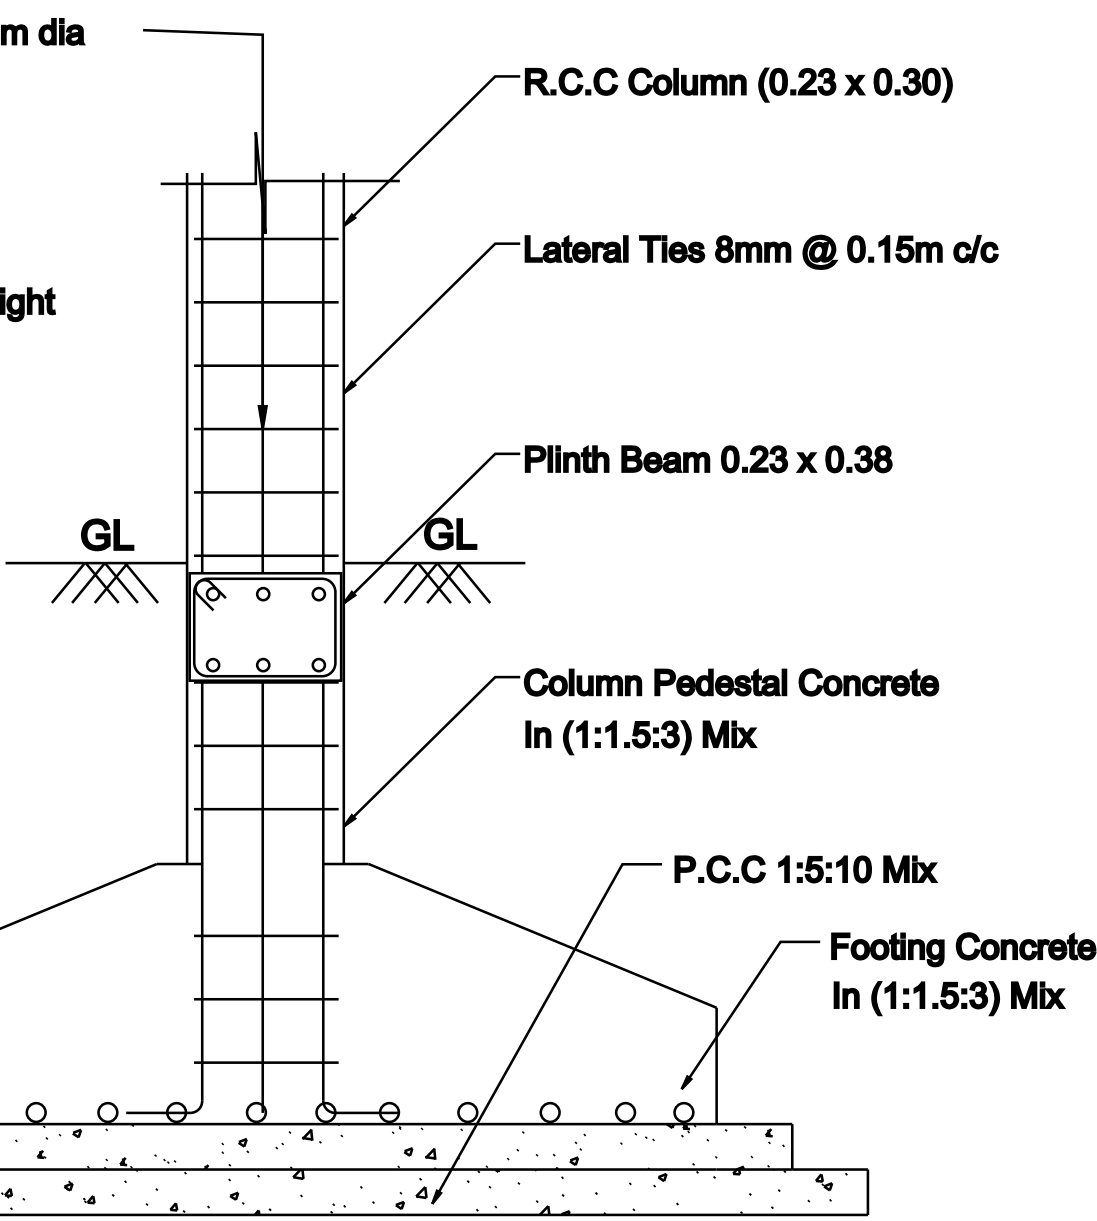


COLUMN FOOTING DETAILS


NOTE:
Rain Water to be Provided
Waste Water To Garden
Percolation Pit to be Provided
Solar System to be Provided

FLOOR SPACE INDEX
FSI= 53.64/60.95=0.88<2


PLOT COVERAGE
PC= 53.64/60.95=88.00 %

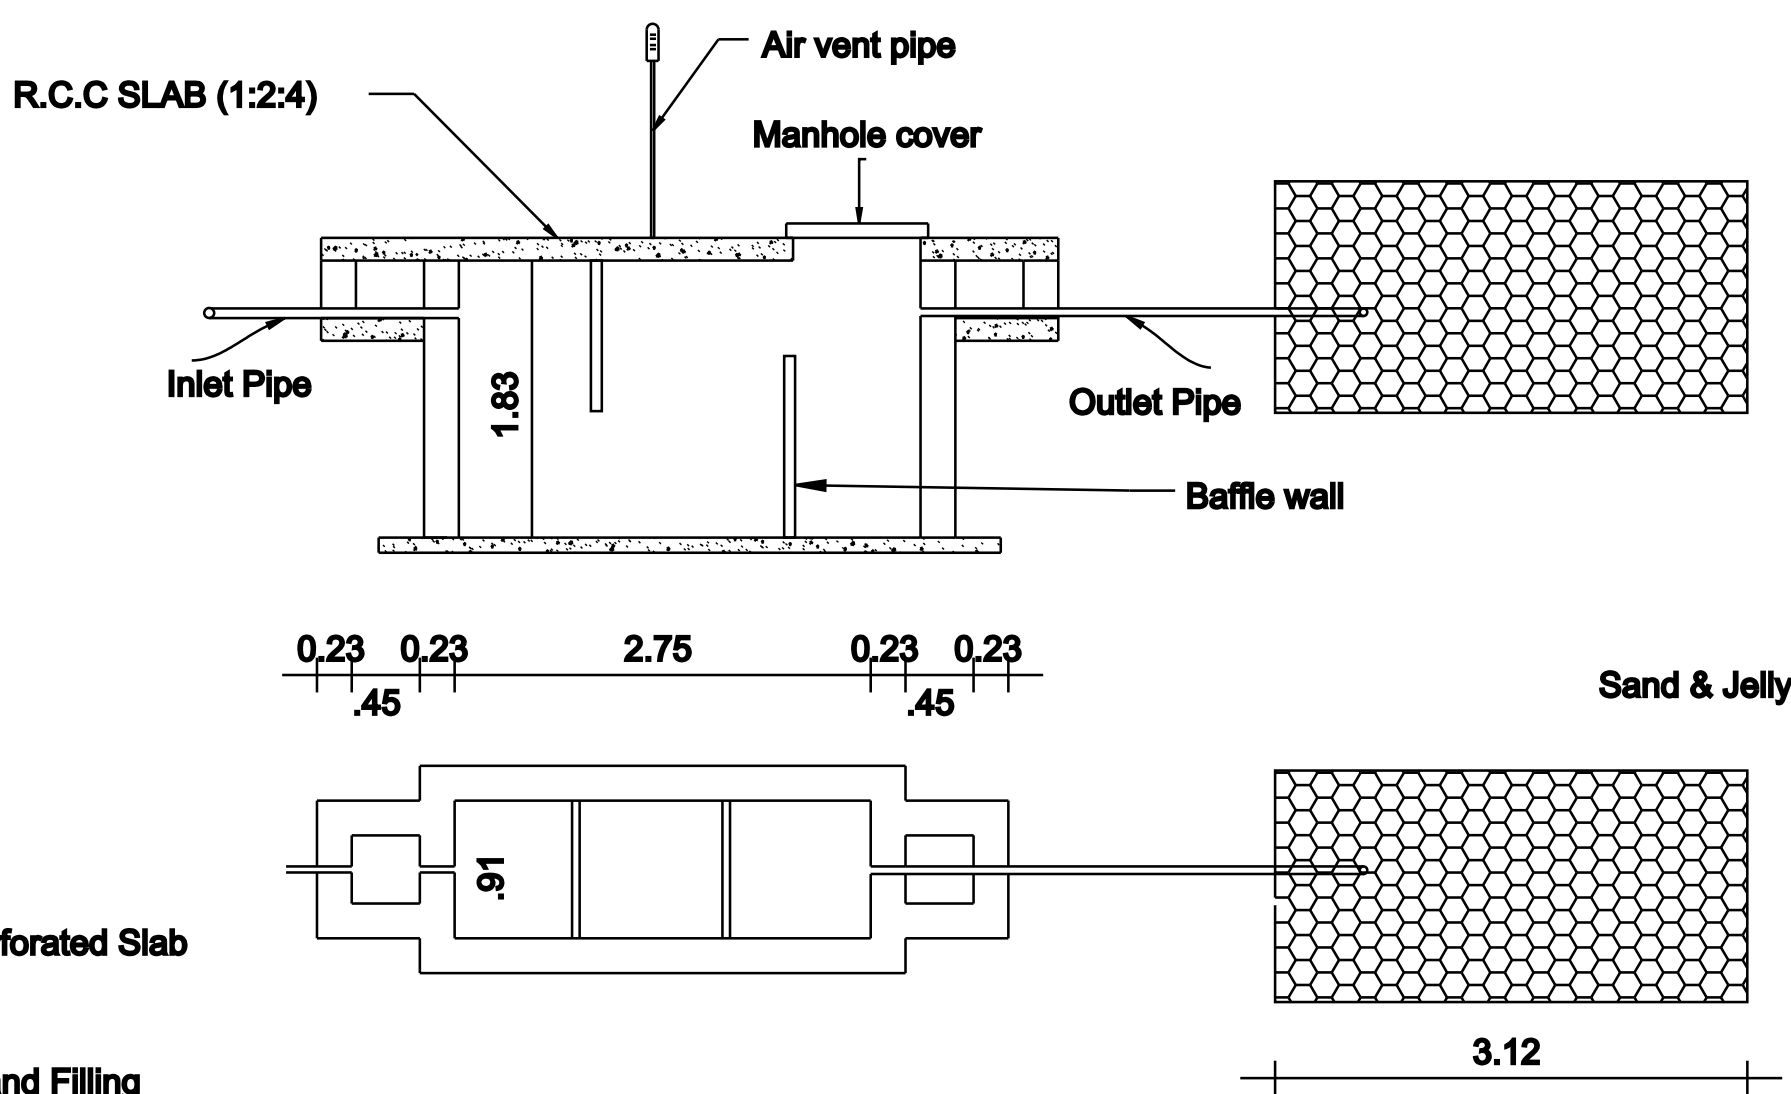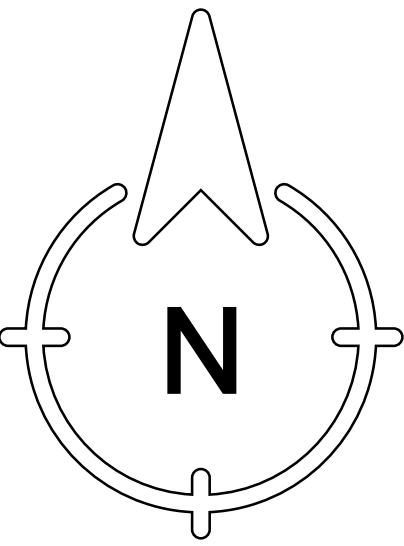


SEPTIC TANK & TRENCH

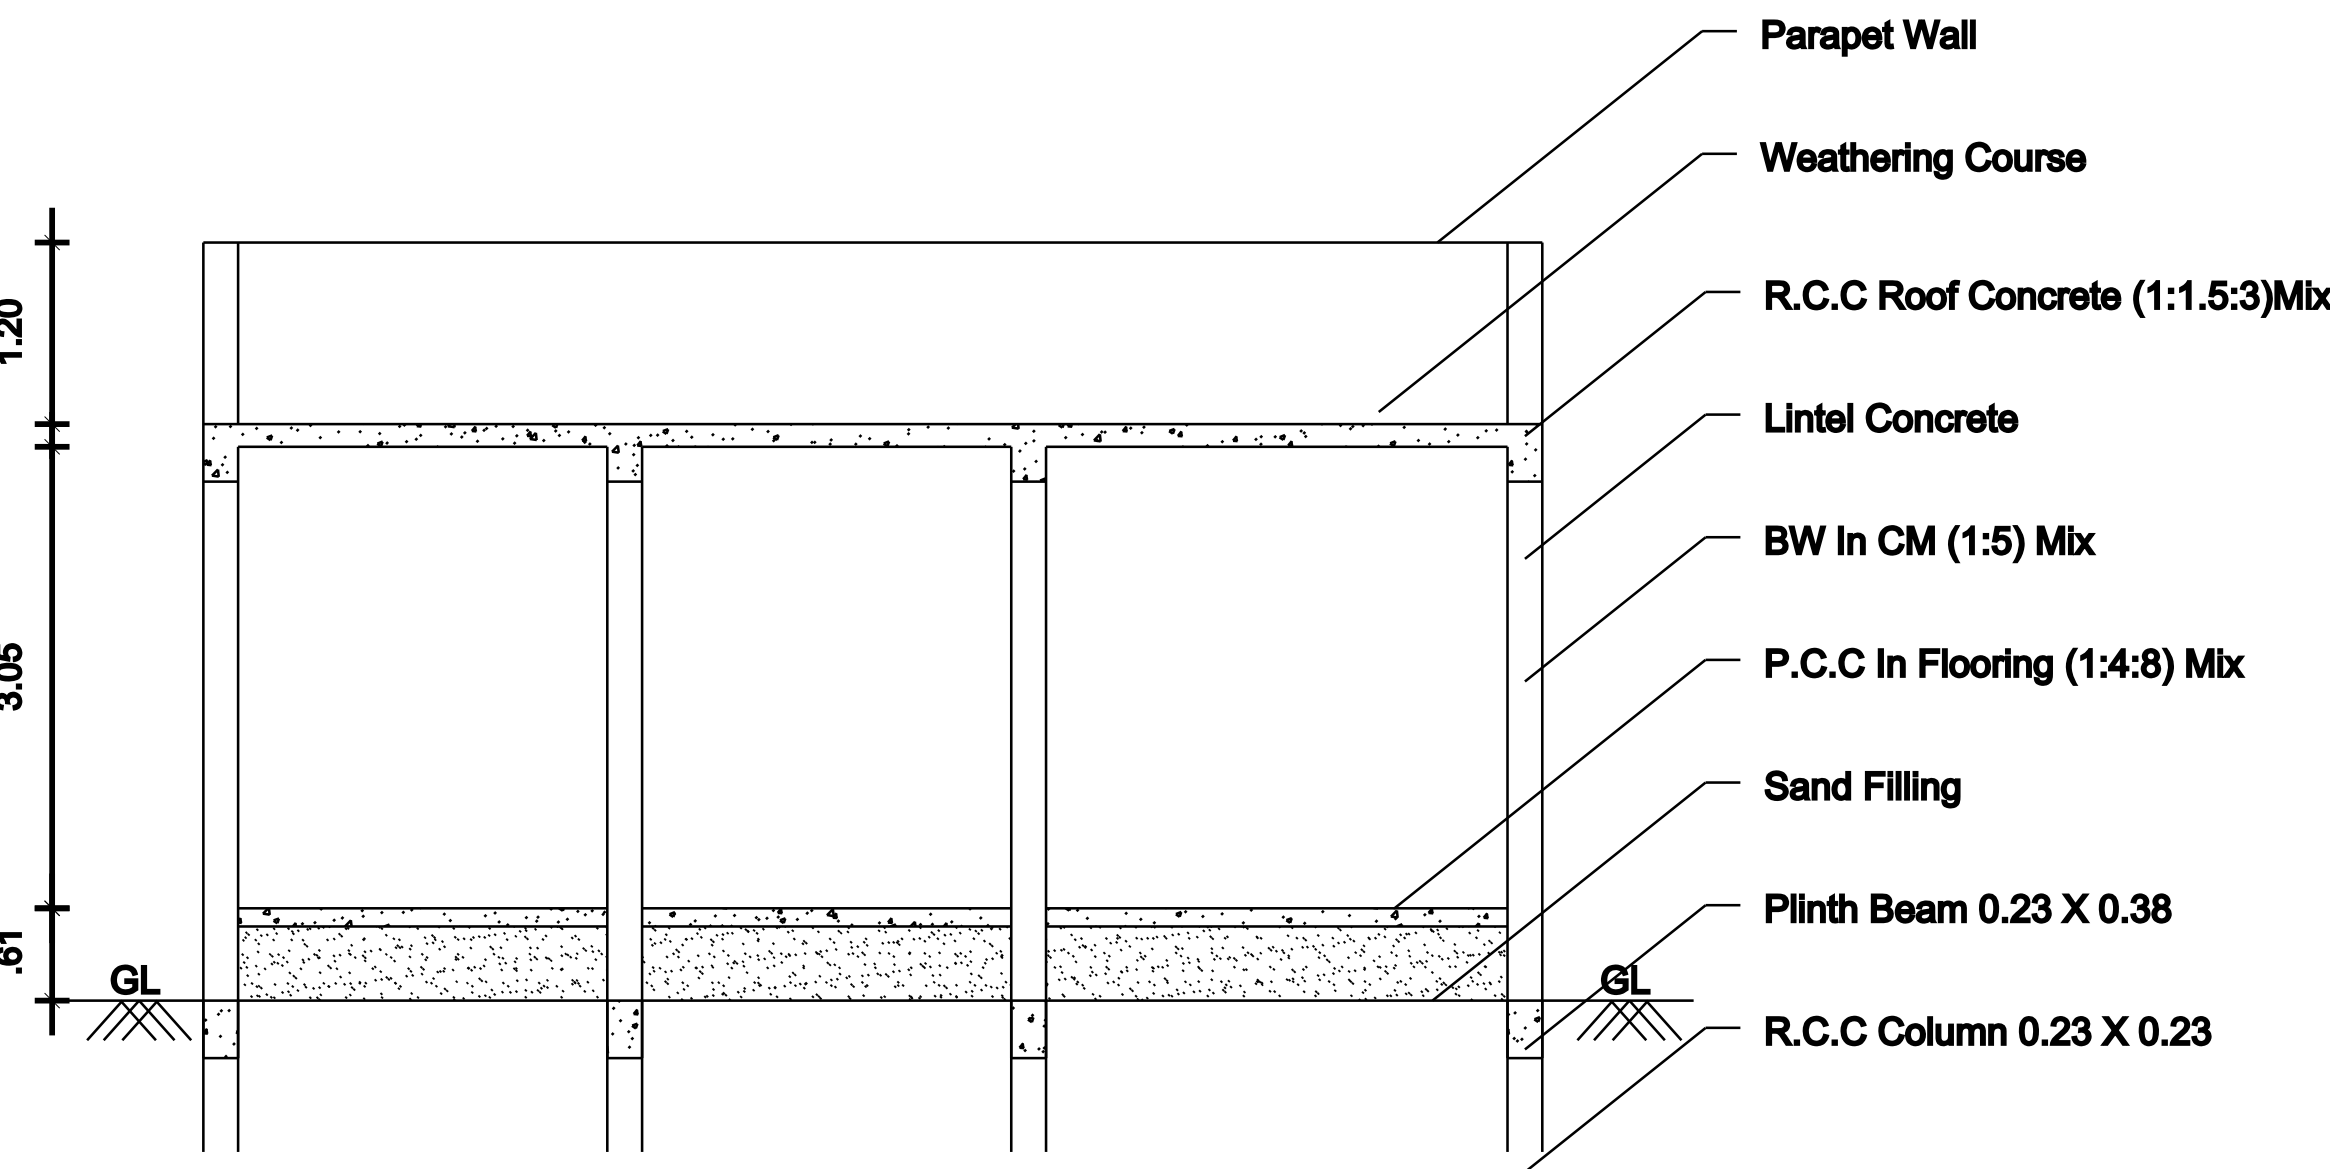


SECTION ON 'AB'

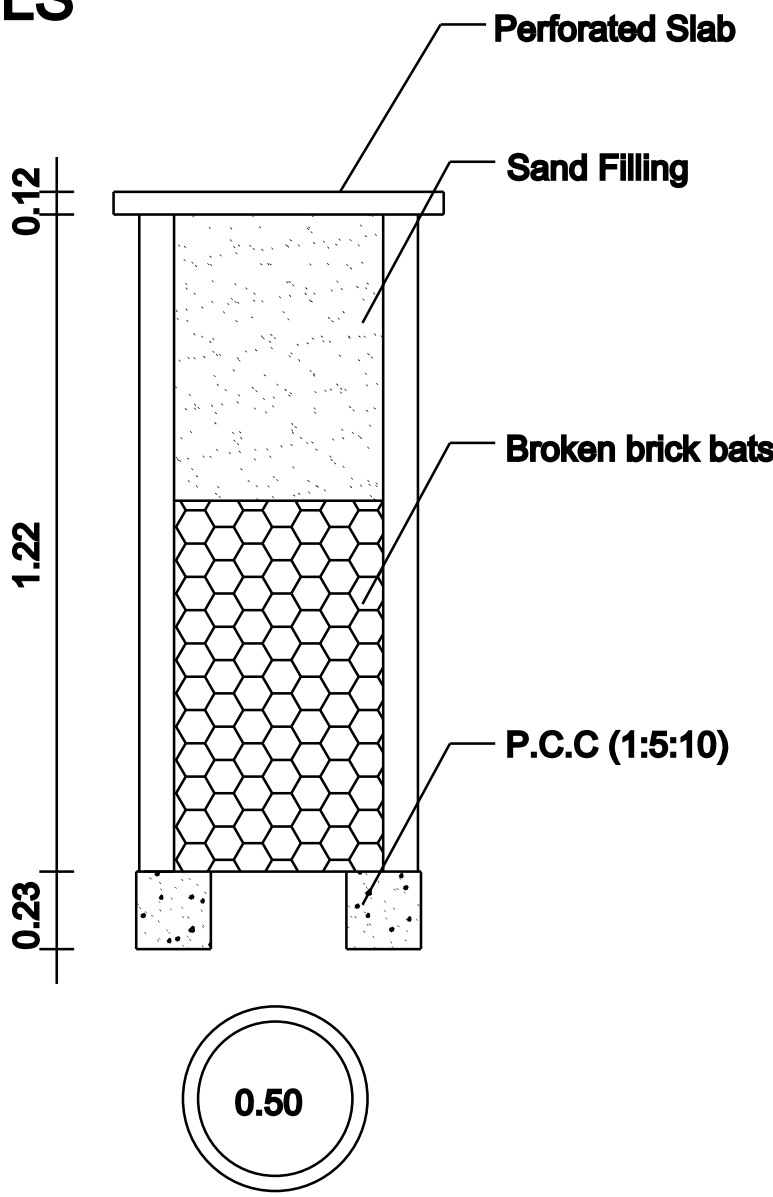


RAIN WATER COLLECTION WELL

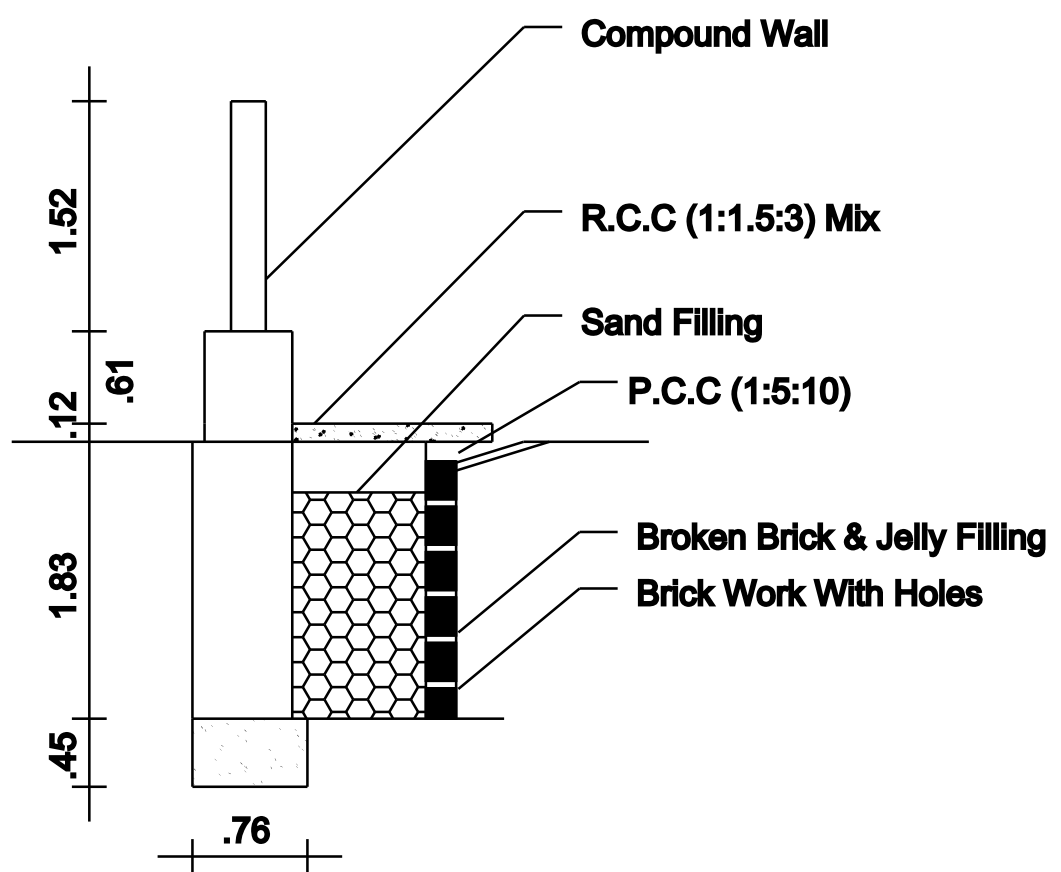

RAIN WATER HARVEST DETAILS

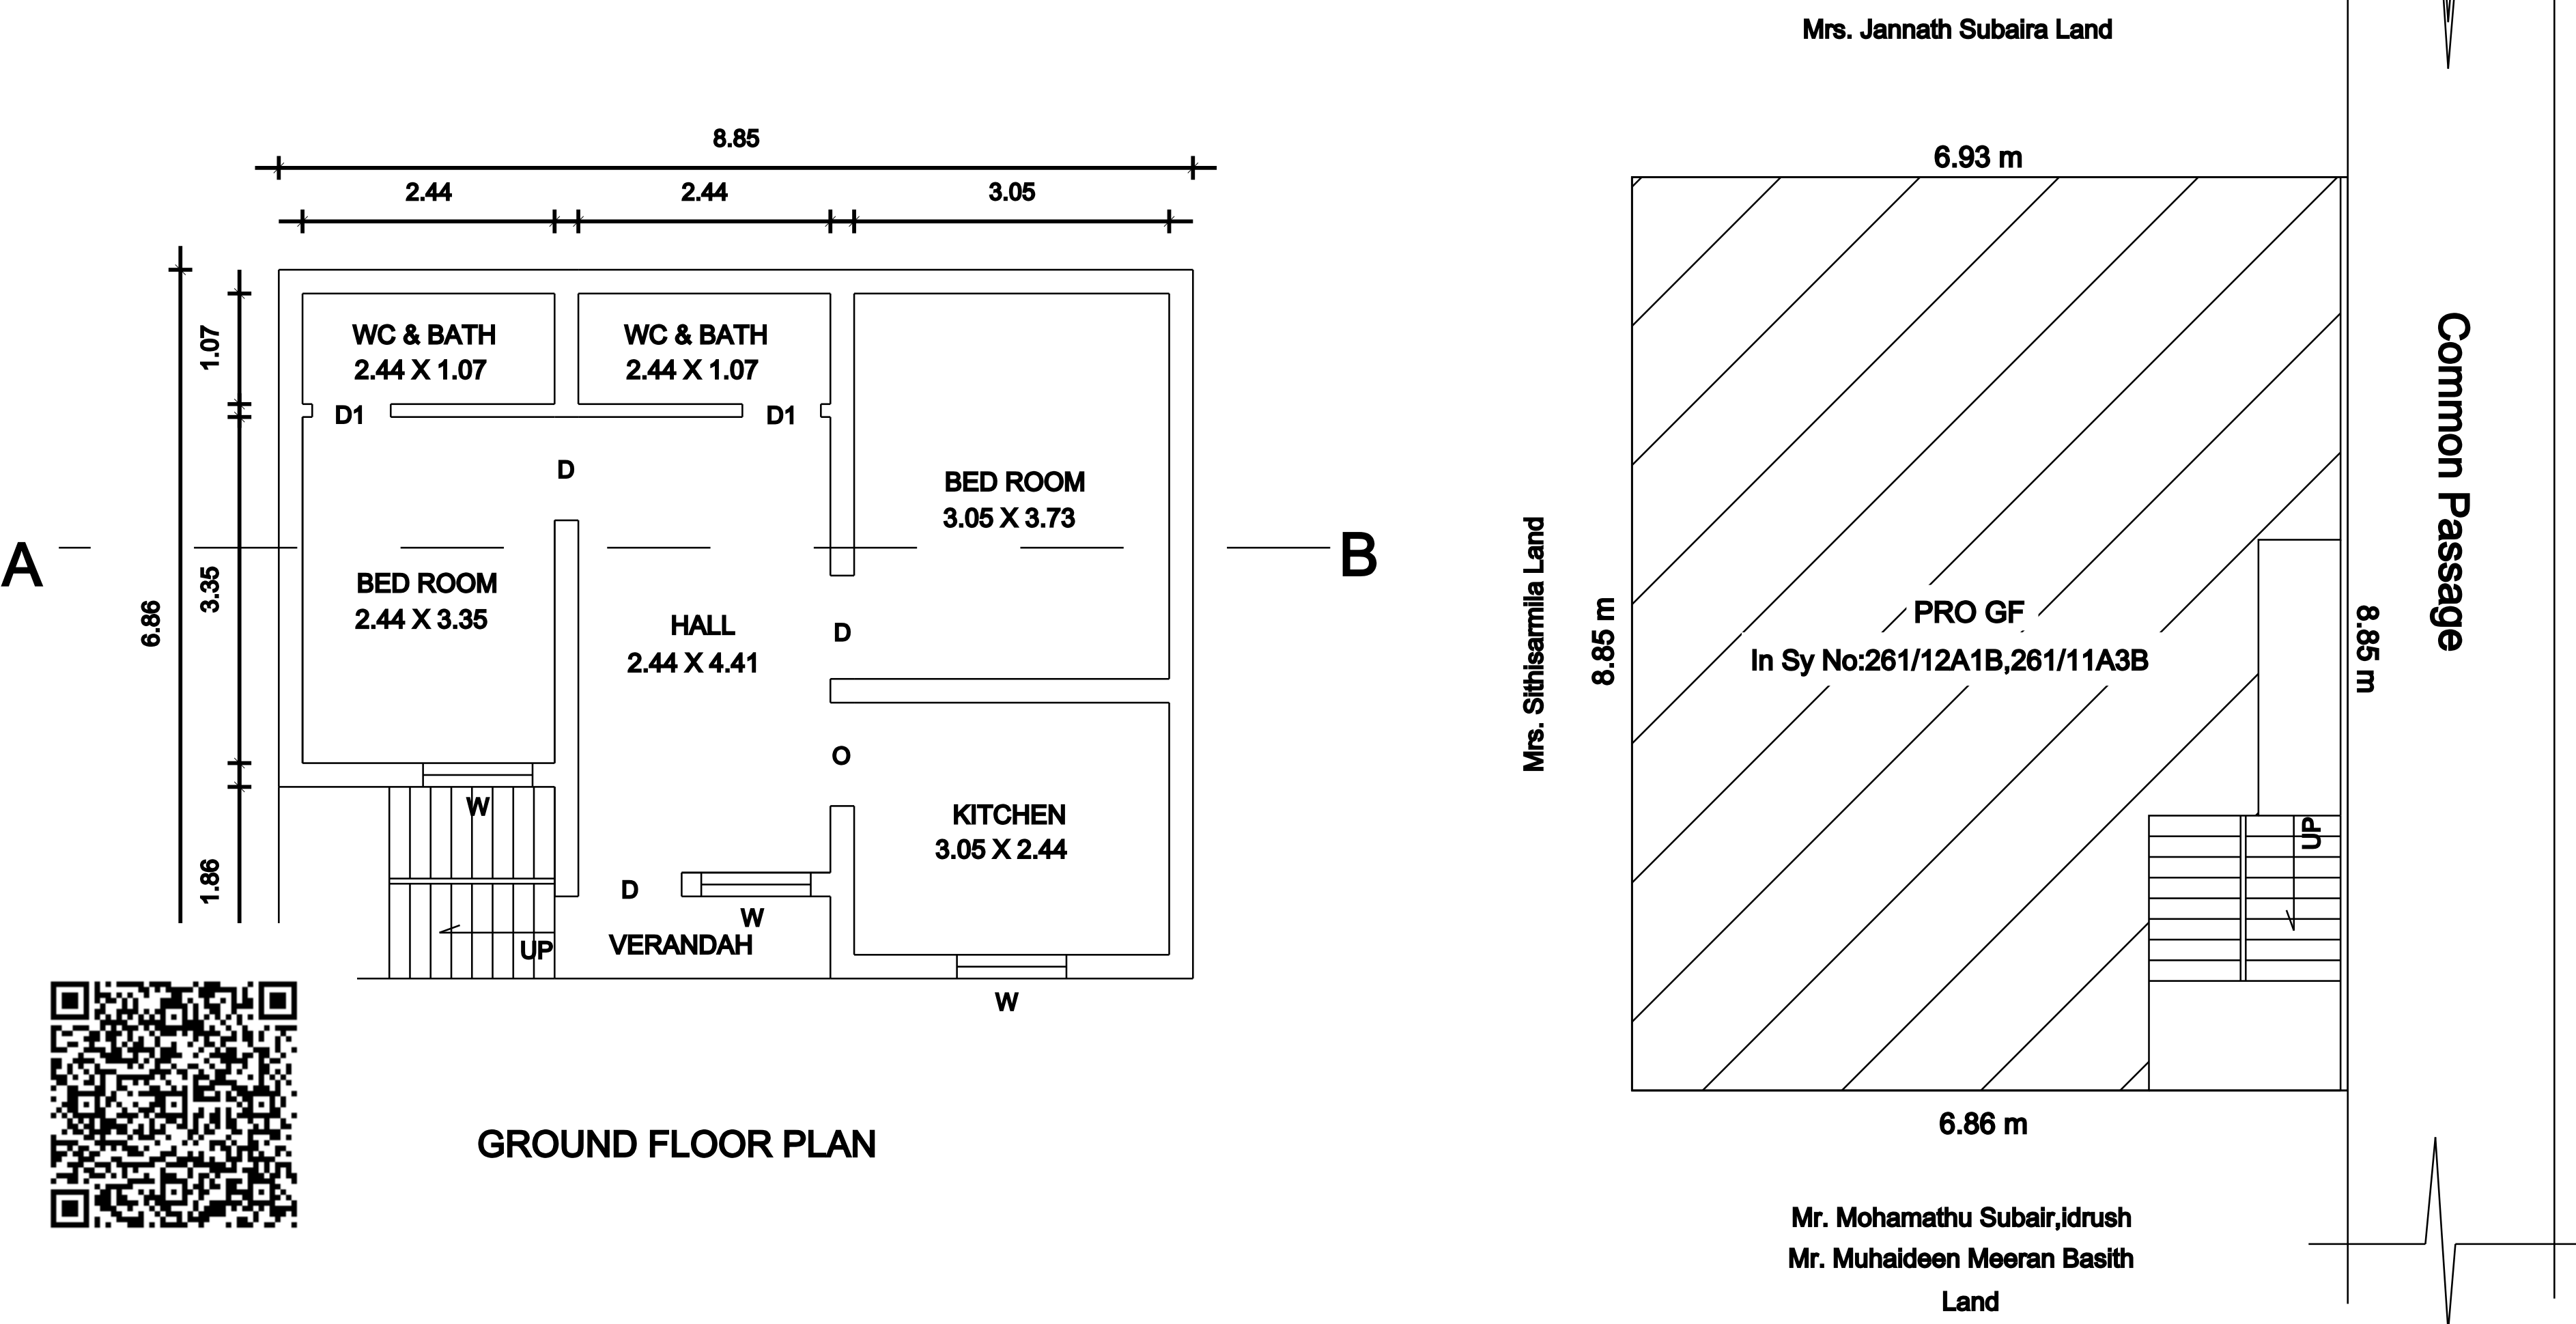

GROUND FLOOR PLAN

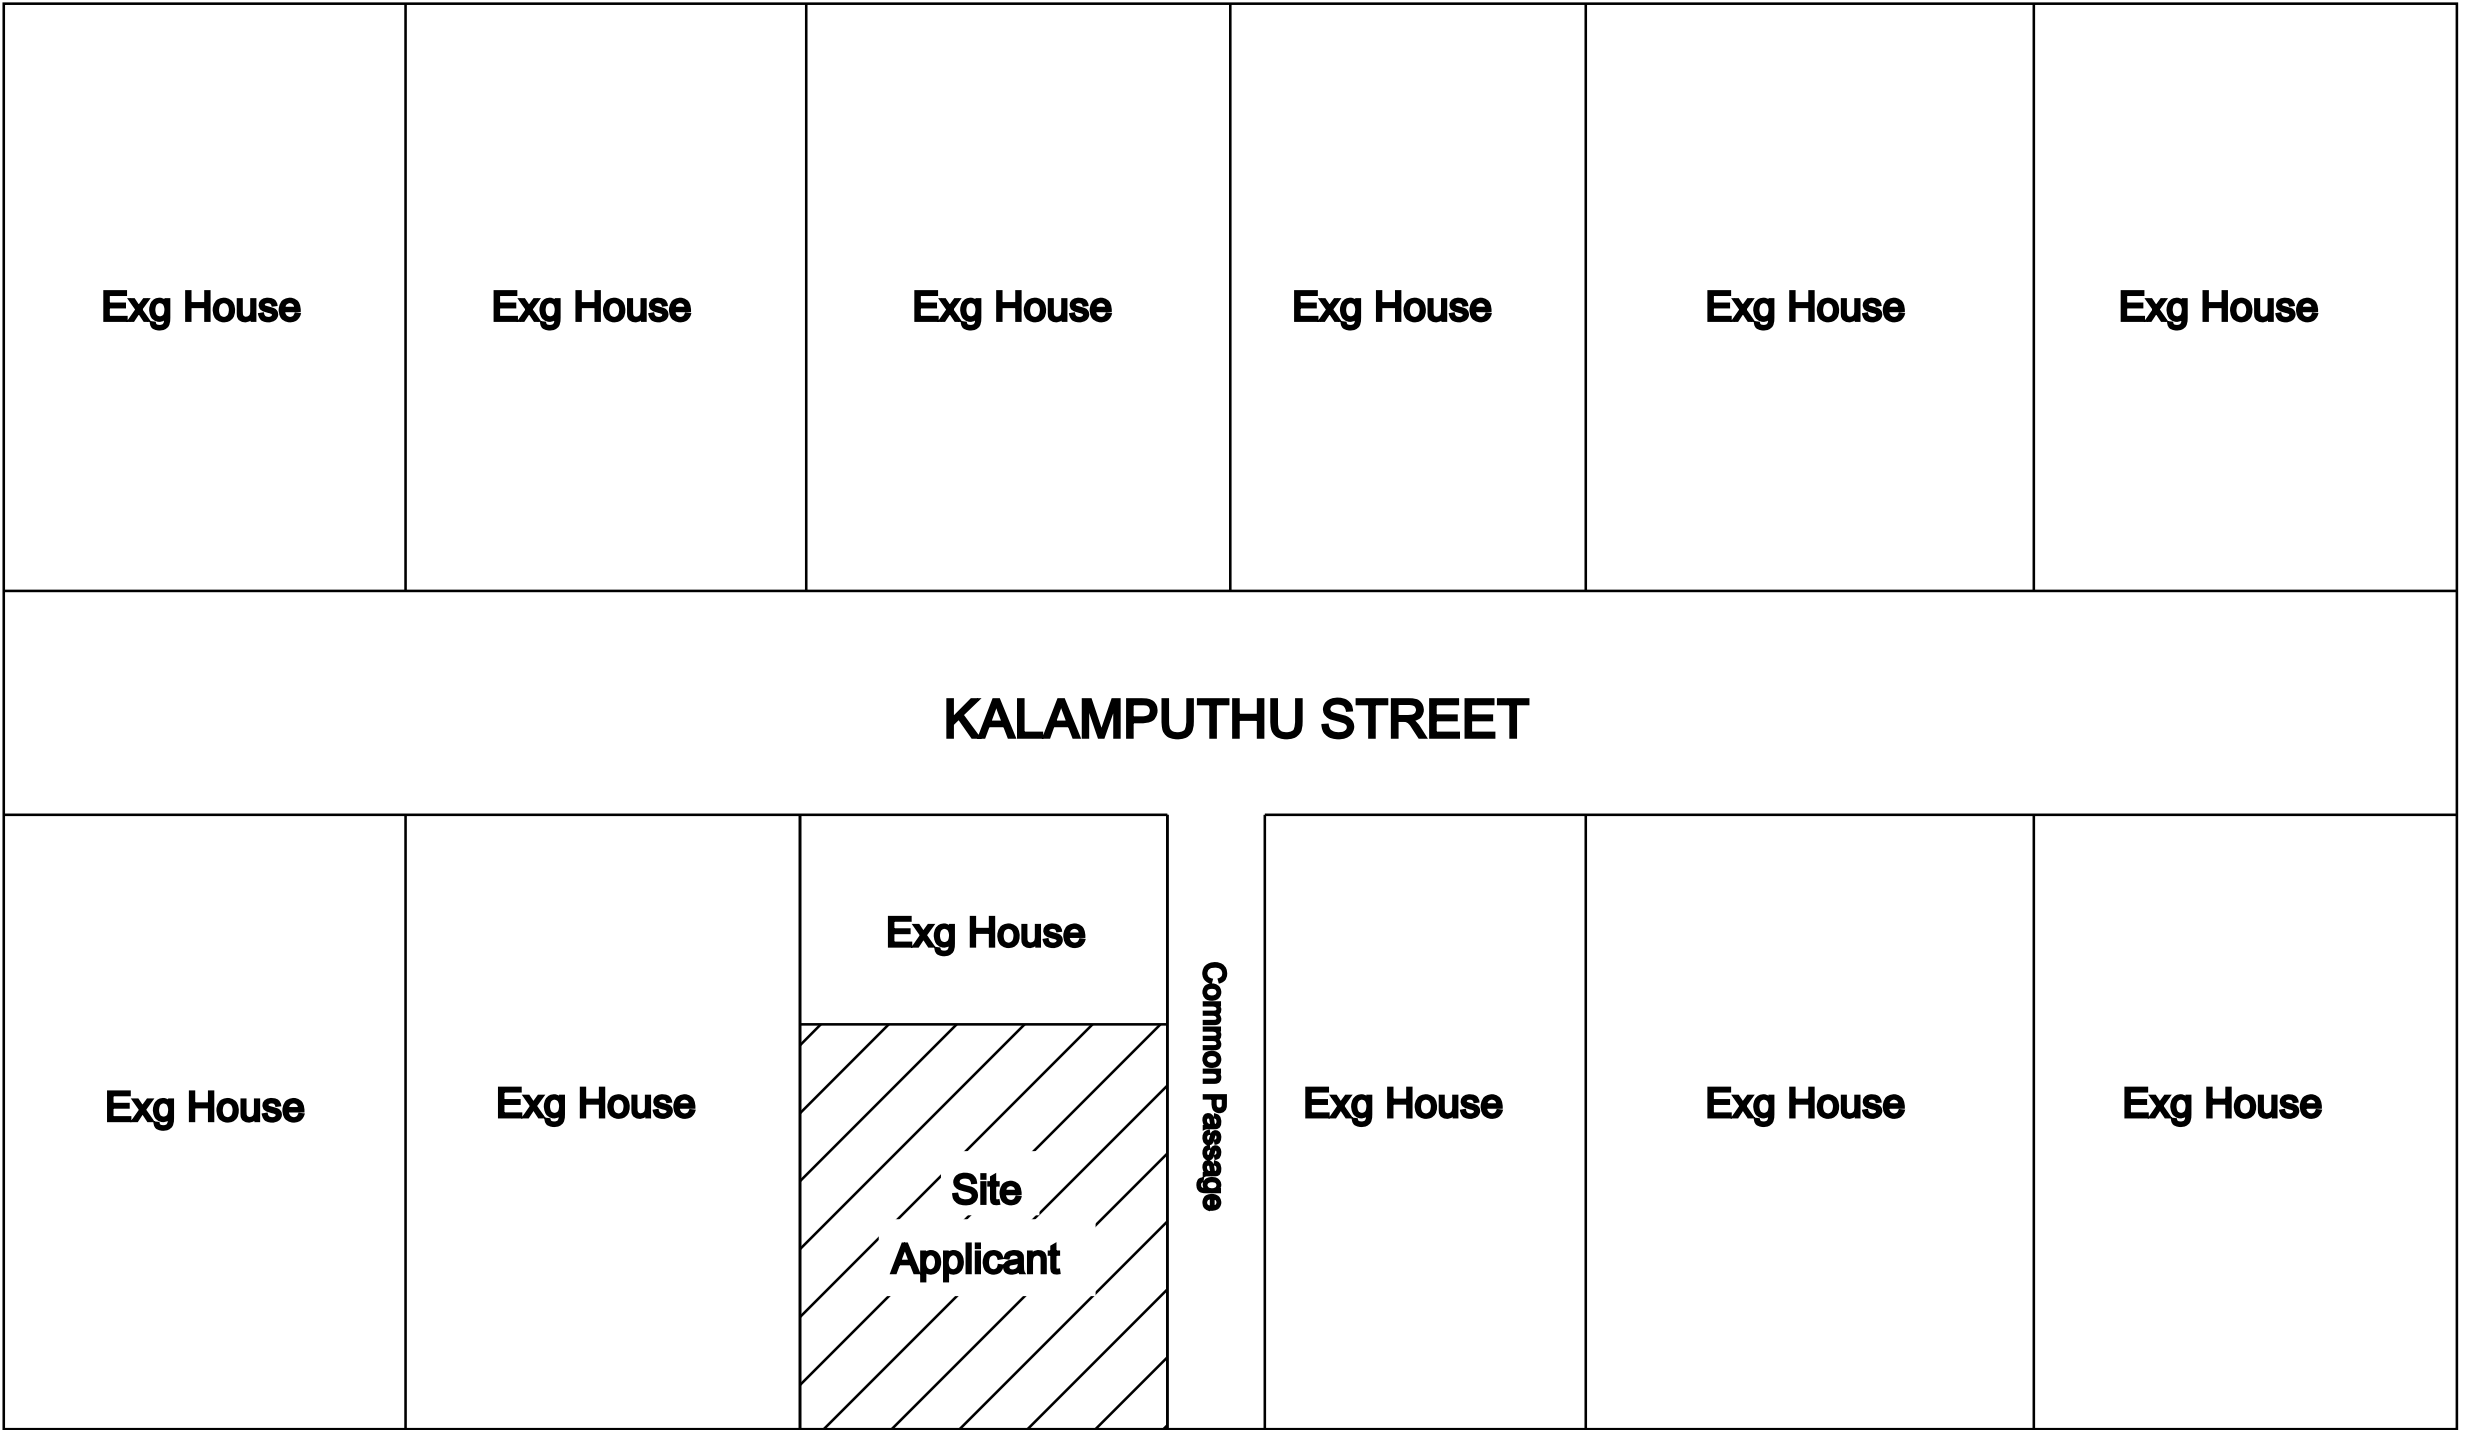

KEY PLAN

AREA STATEMENT

	Site Area(1.50 Cents)	60.95 Sq.m	656.12 Sq.ft
	Pro Ground Floor Area	53.64 Sq.m	577.37 Sq.ft
	Open Area	07.31 Sq.m	078.75 Sq.ft

JOINERY DETAILS

D	DOOR	1.00	2.13
D1	DOOR	0.76	2.13
W3	WINDOW	1.06	1.37
KW	KITCHEN WINDOW	1.22	1.06
V	VENTILATOR	0.91	0.61

OFFICE USE

APPLICANT

Handwritten signature

Er.R.MOHAMED IRSATH

Register Engineer in DRDA-UDY/2022/05

Municipality Engineer -139/LS/2022/00002058

Licensed Surveyor & Consulting Engineer

Build-Up Construction,

18, Periya Street, Udangudi-628203

Cell:9750953055, 9629271761

REGISTERED ENGINEER

ALL DIMENSIONS ARE IN METER (Scale:1:100)