



PLAN SHOWING THE PROPOSED CONSTRUCTION OF R.C.C ROOF GROUND FLOOR RESIDENTIAL BUILDING AT SITE NO:21,
R.S.F.NO:720/8A1A3, (OLD S.F NO:1960, 1961A,), KANDHASAMY NAGAR, KARUR MAIN ROAD, KALIPALAYAM, KOLATHUPALAYAM
VILLAGE & TOWN PANCHAYAT, DHARAPURAM TALUK, TIRUPPUR DISTRICT.


APPLICANT : Mrs. S.SAJITHABANU W/O ABIBULLARAGUMAN,

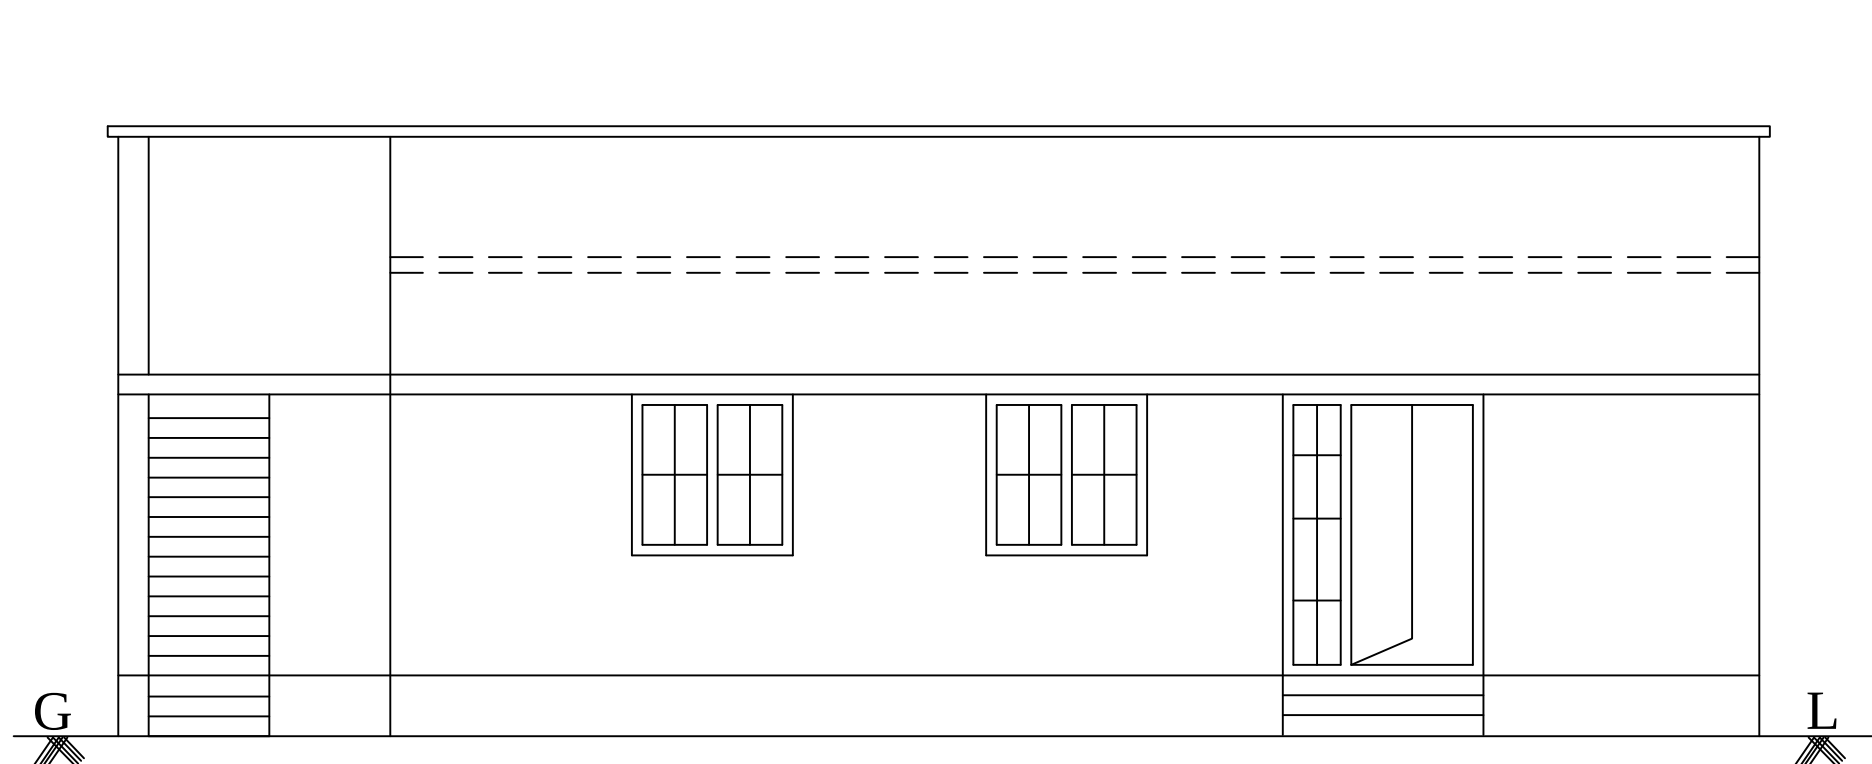



FRONT ELEVATION

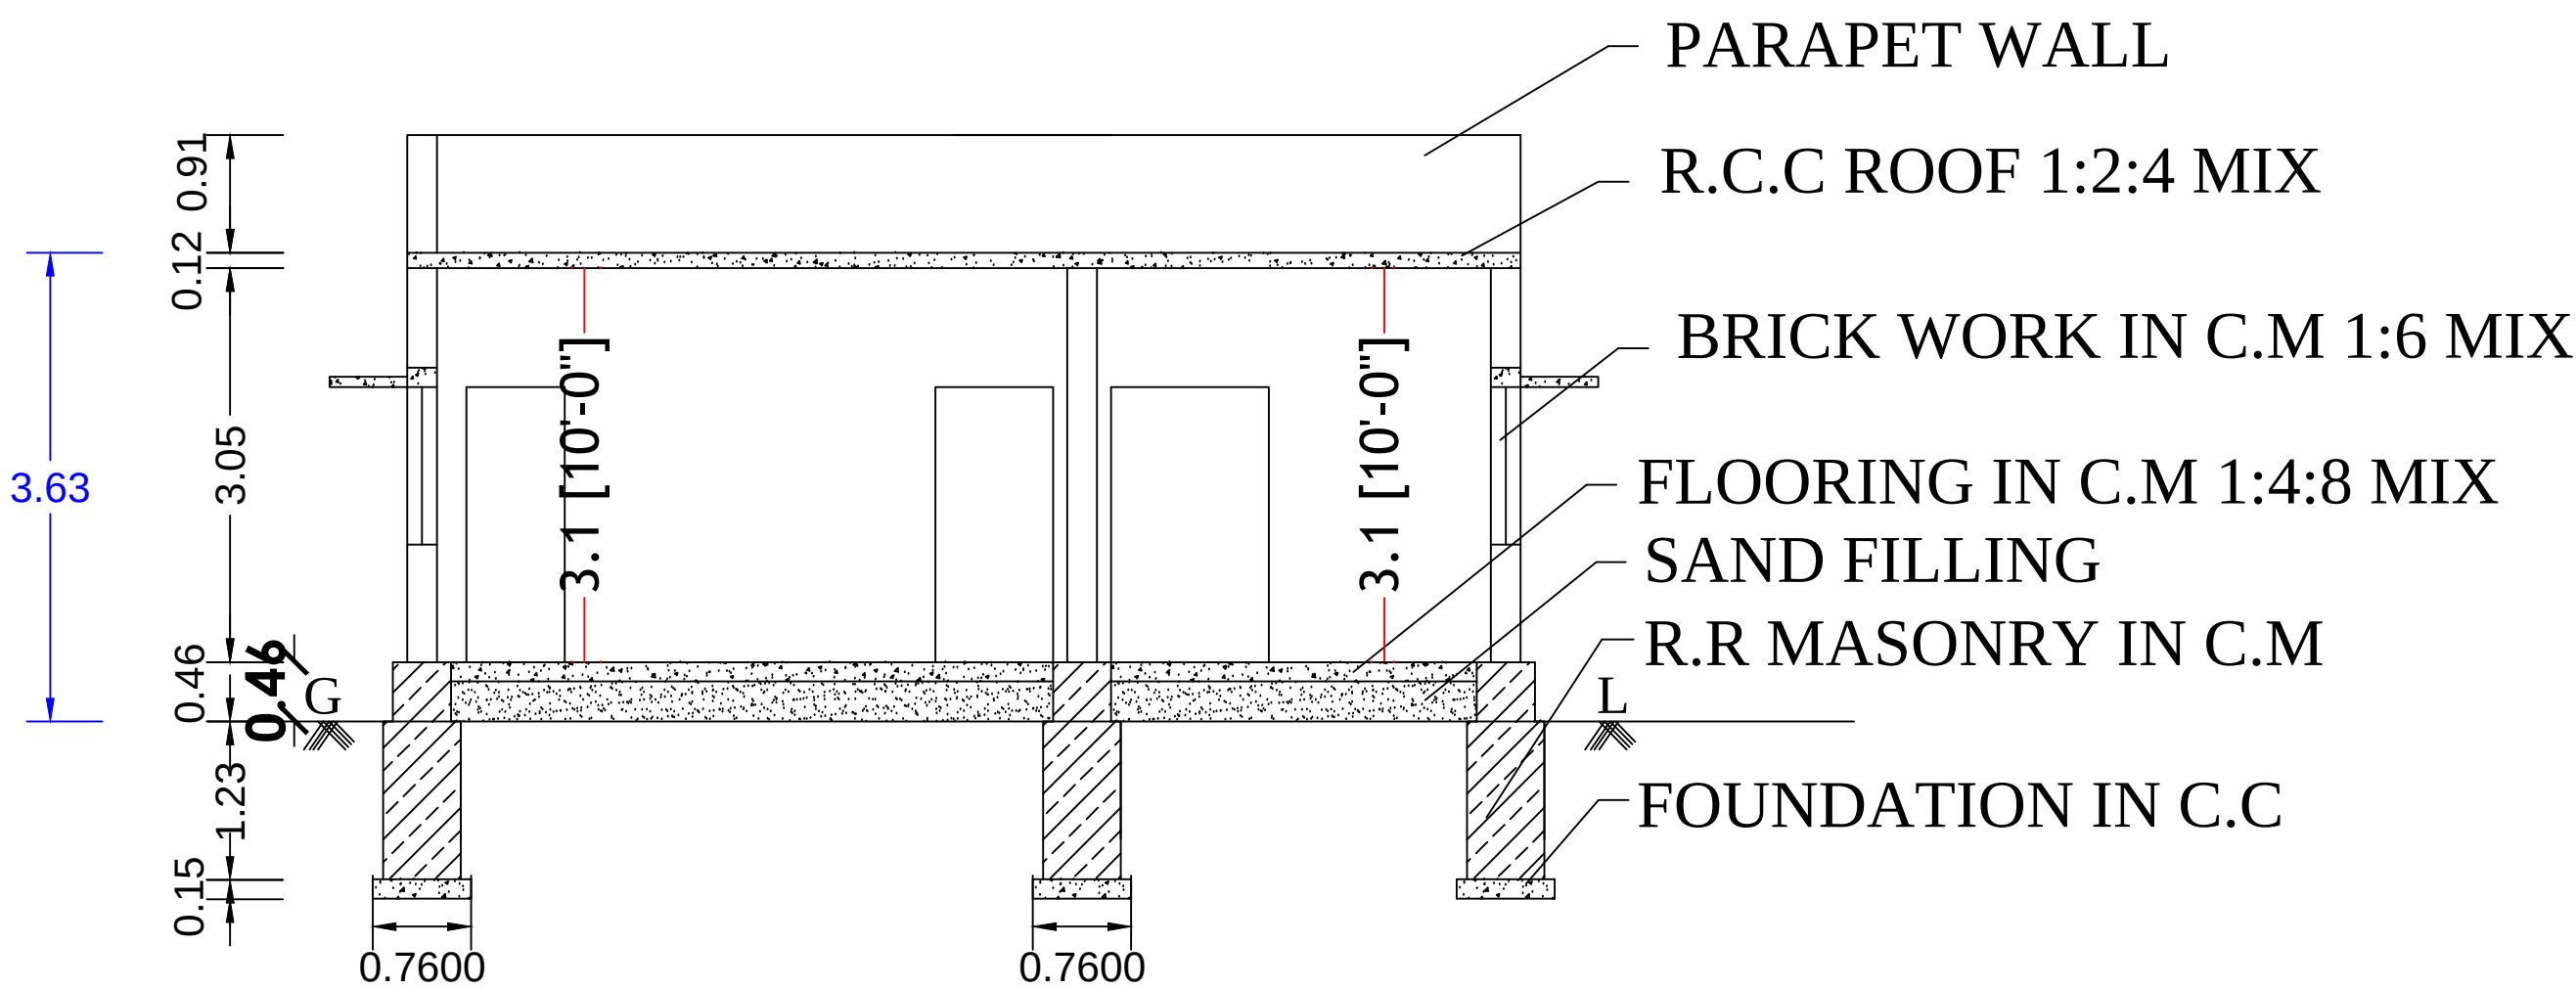


SECTION AA'

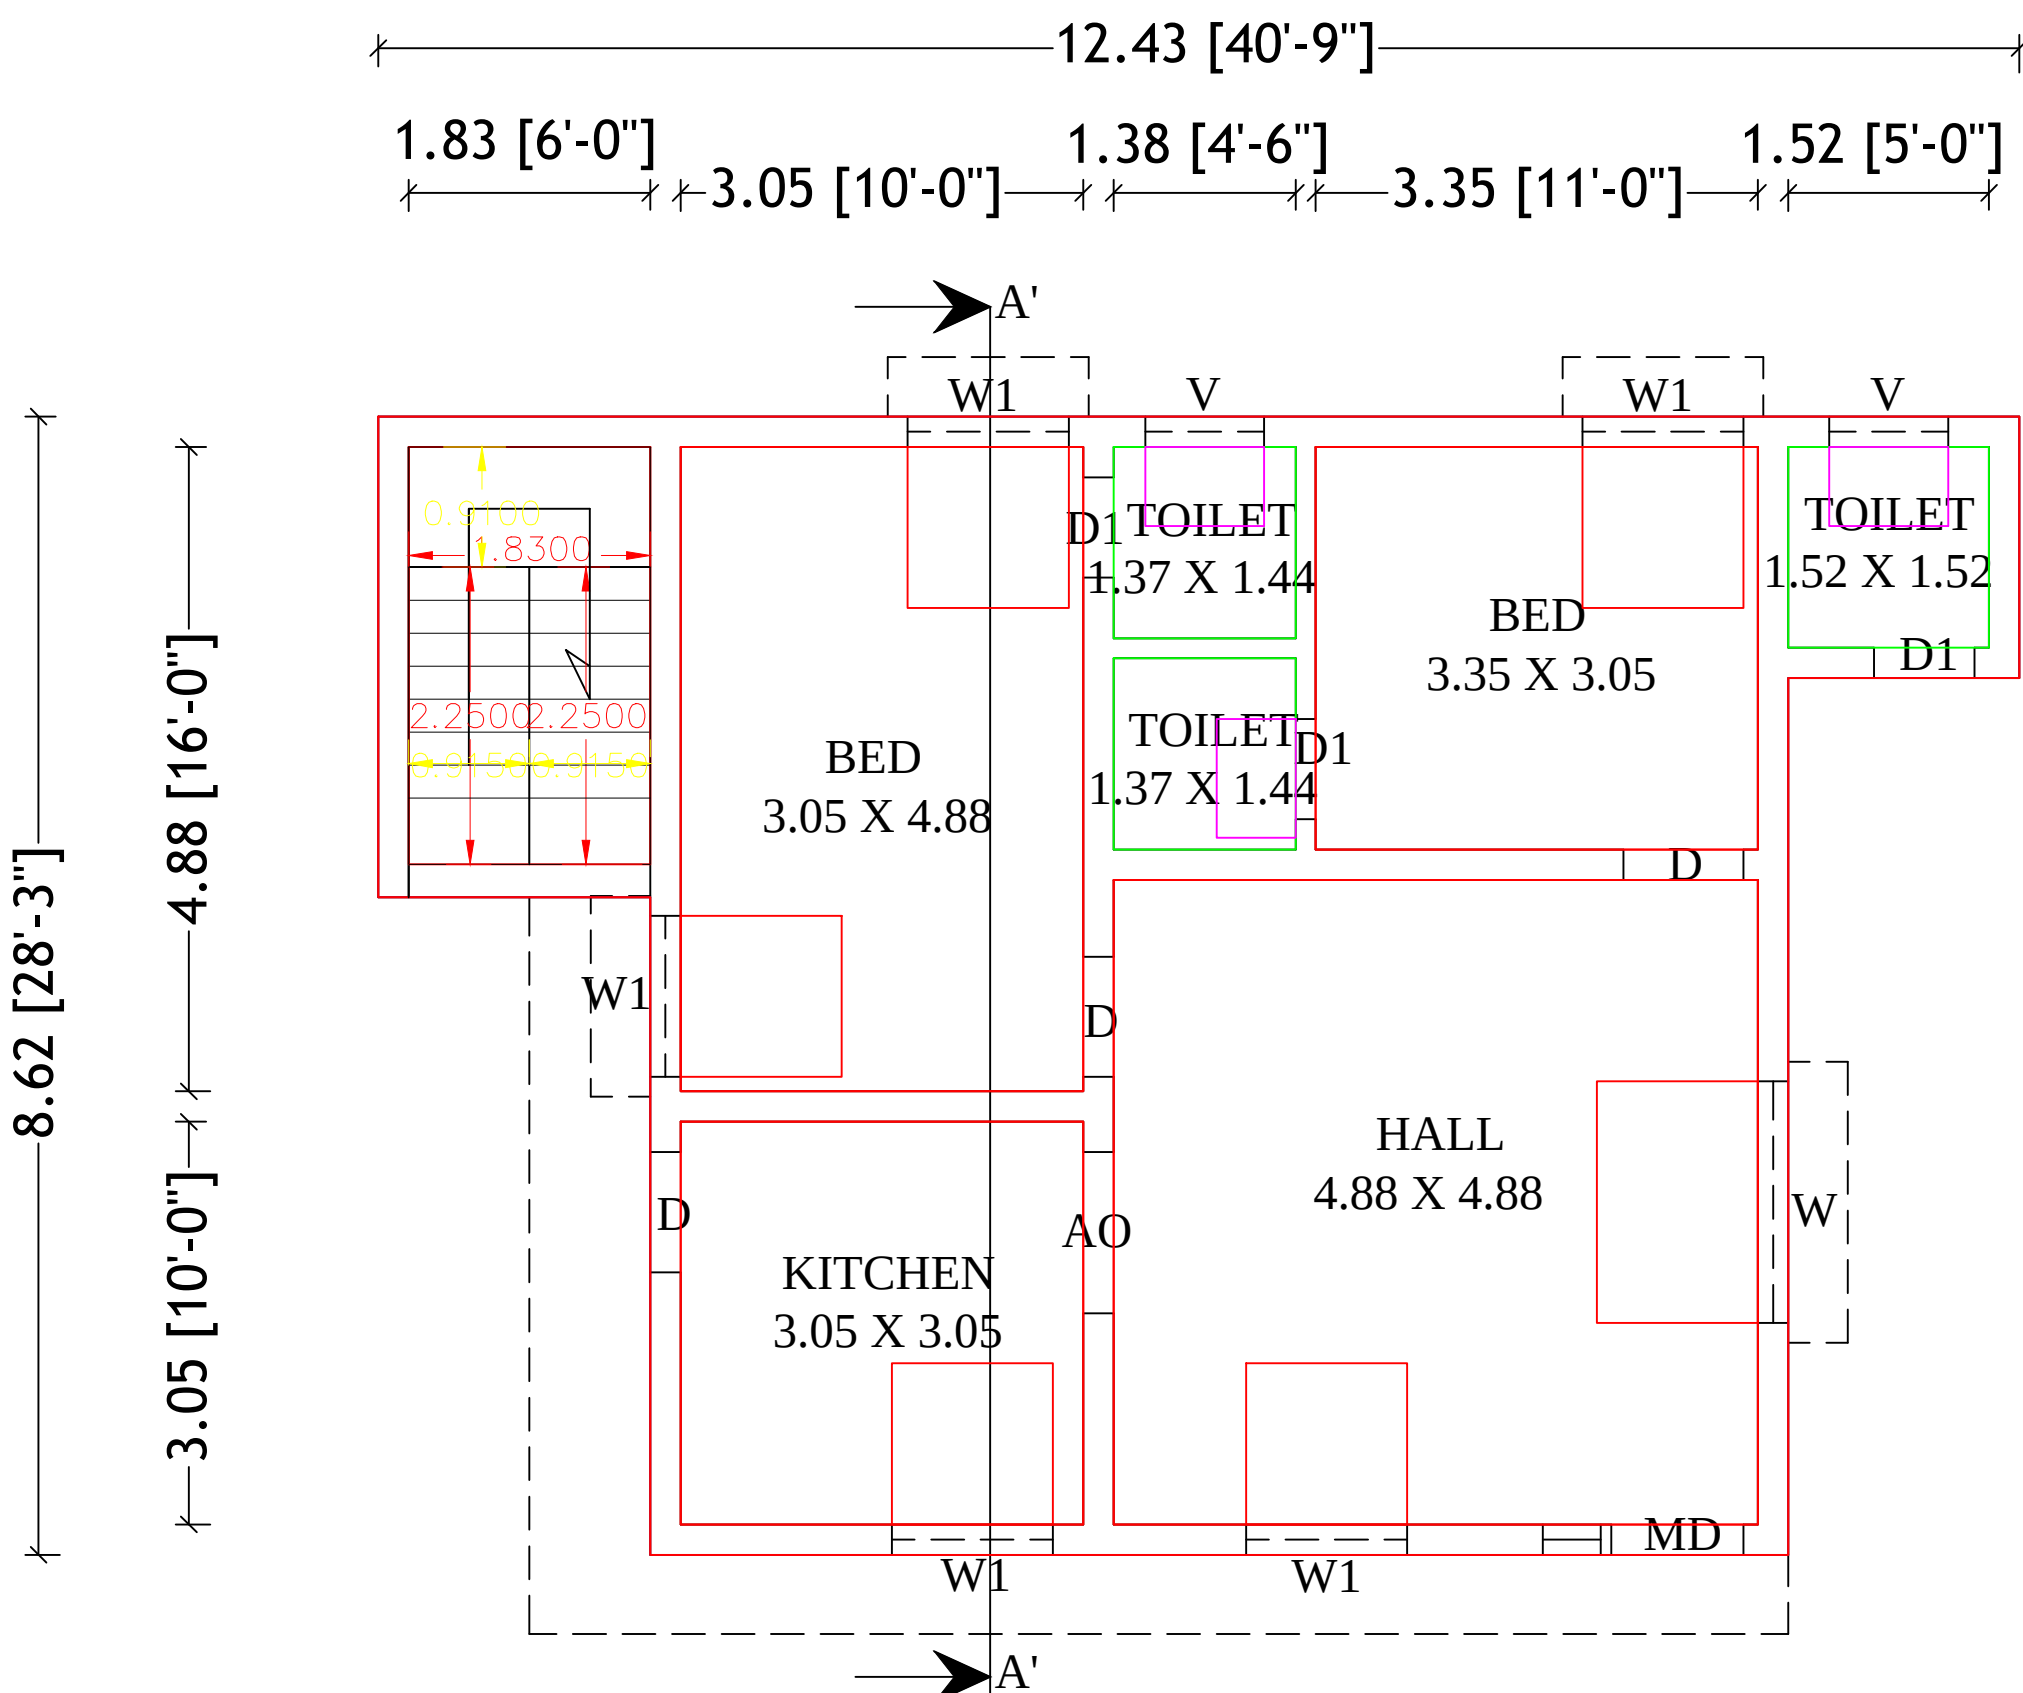


GROUND FLOOR PLAN

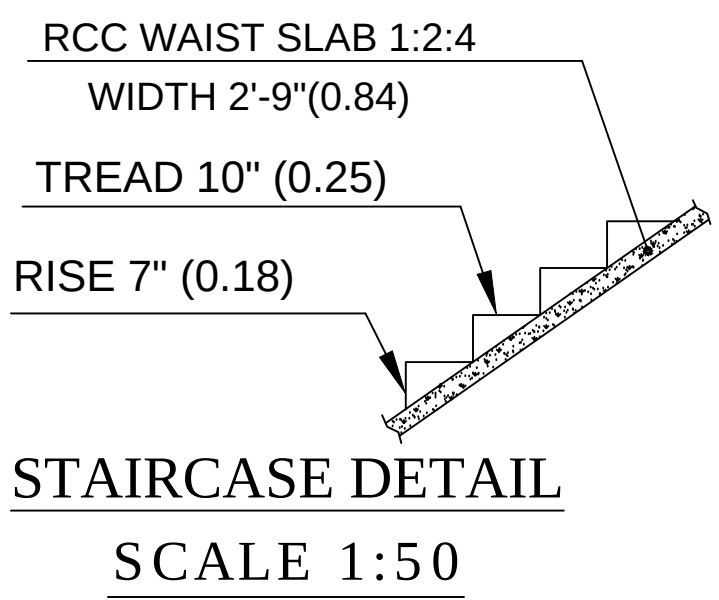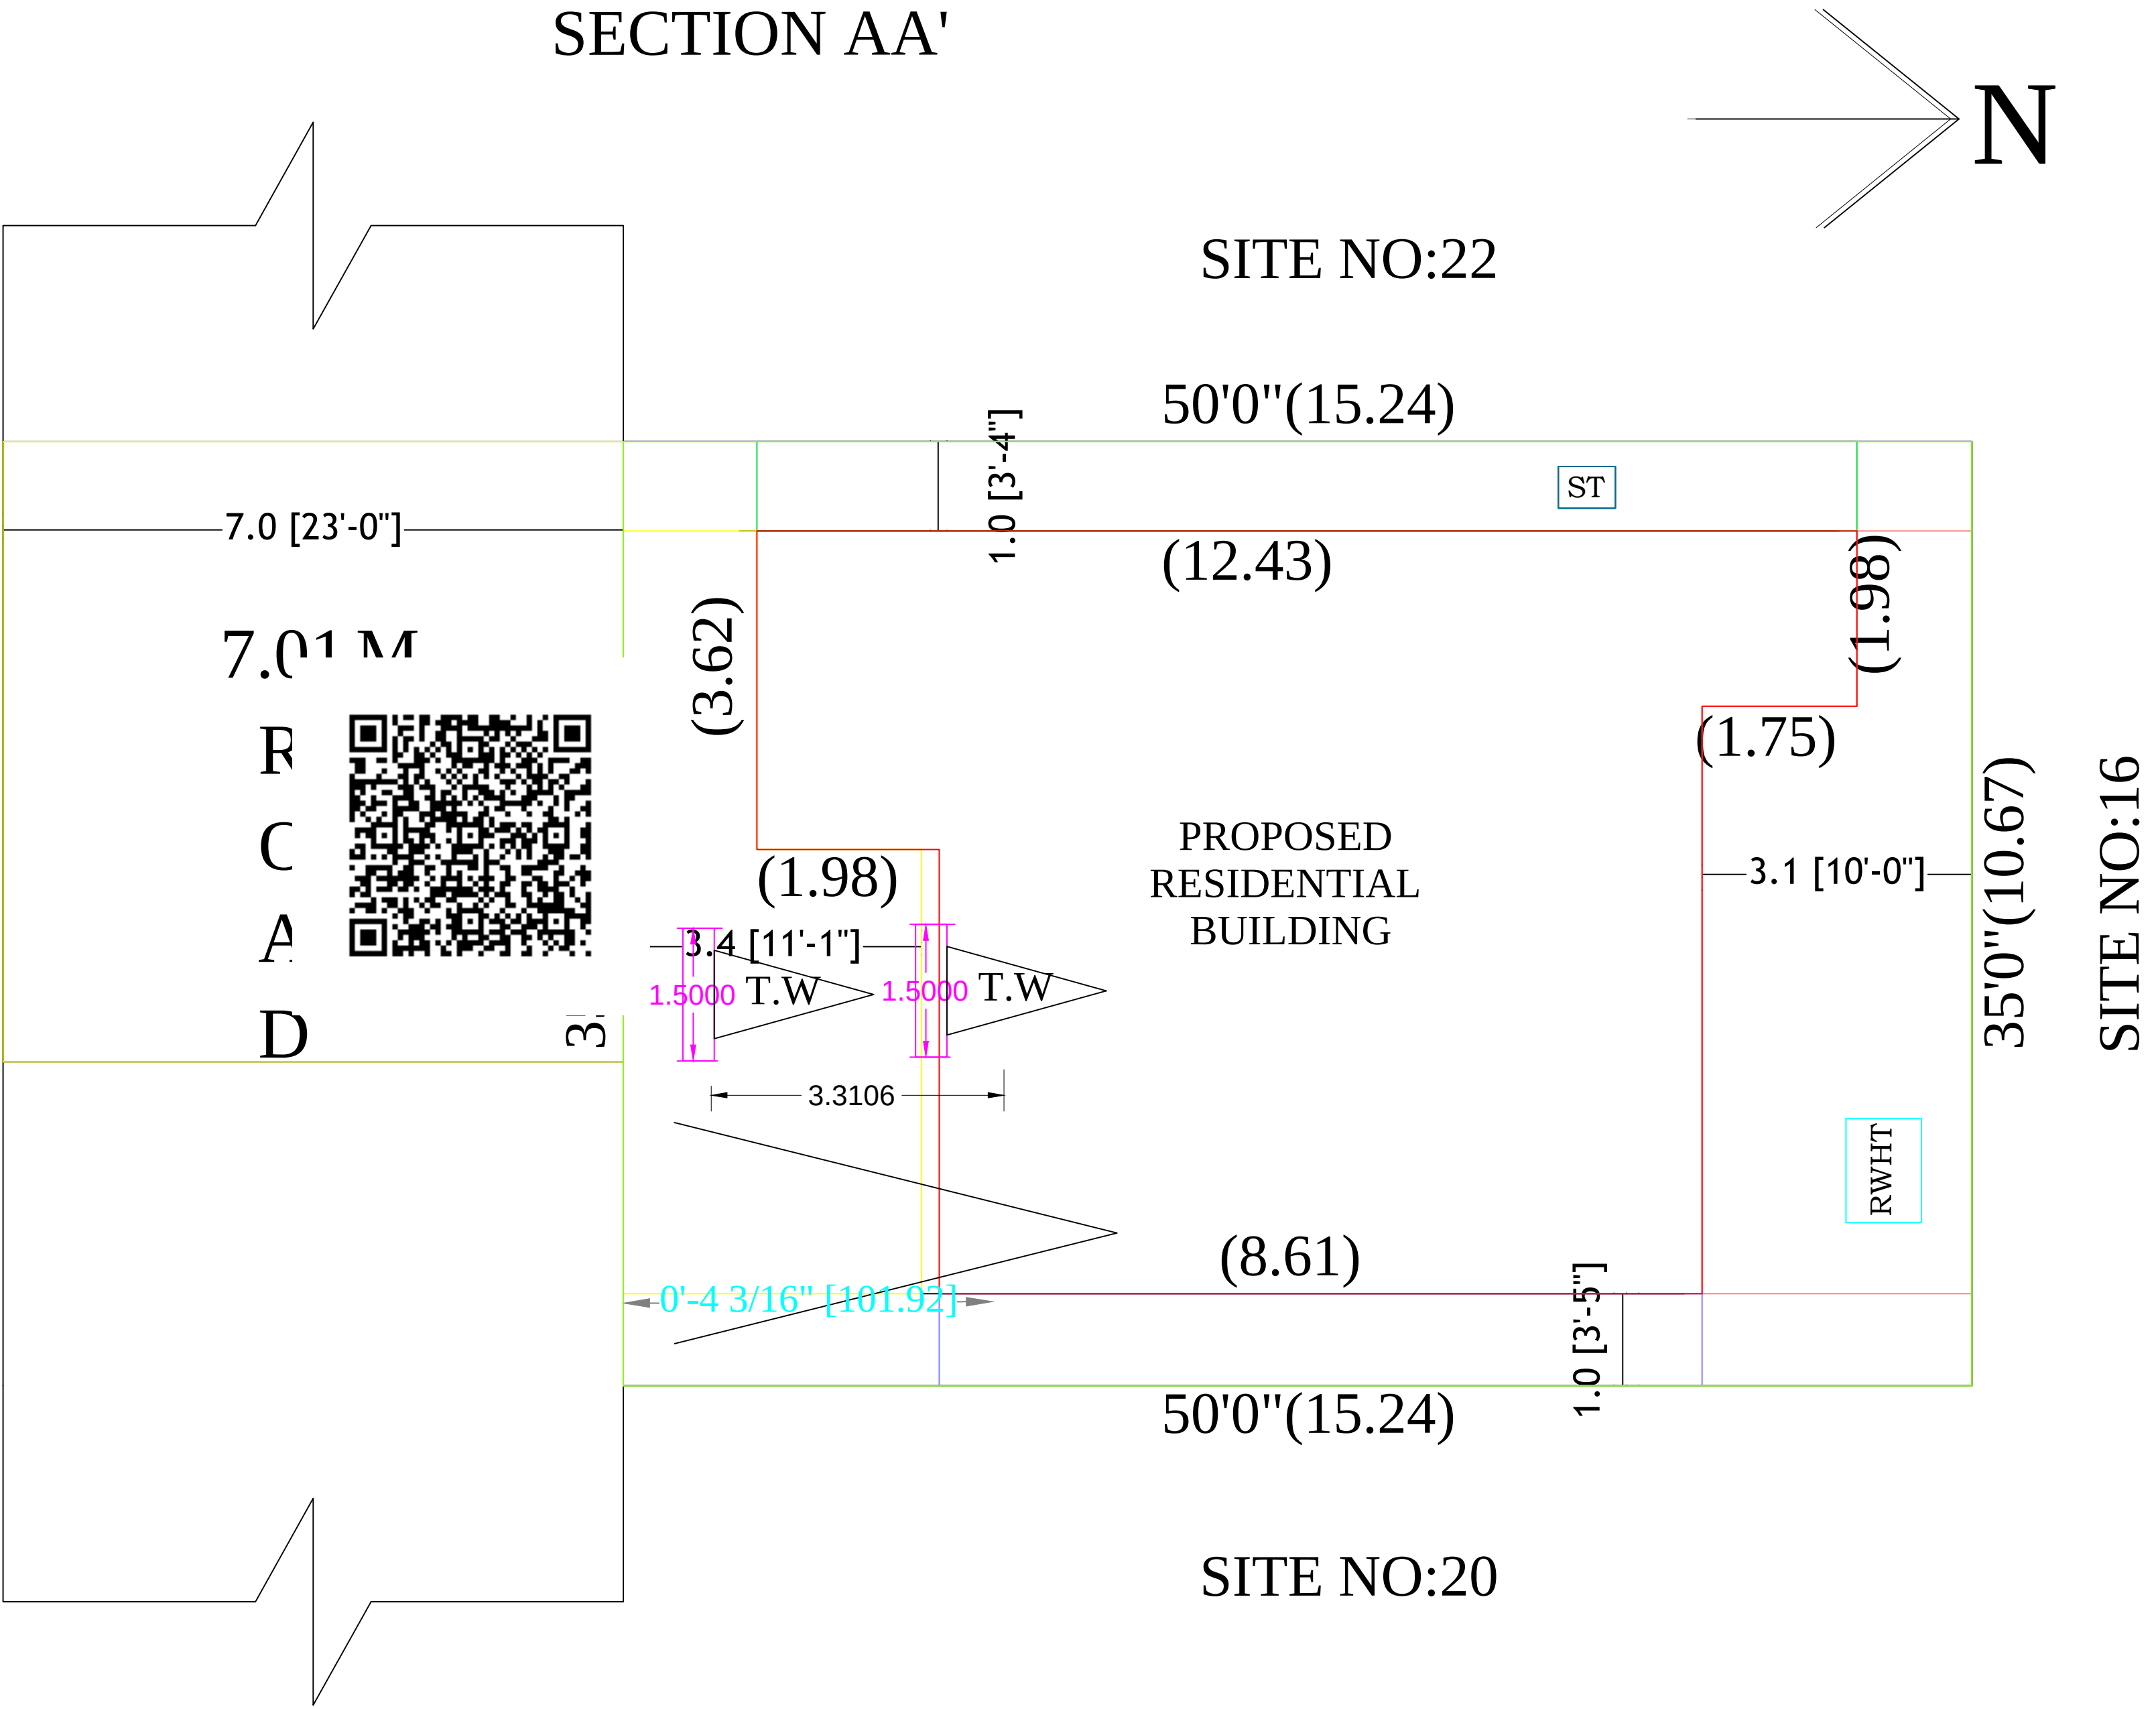


STAIRCASE DETAIL
SCALE 1:50

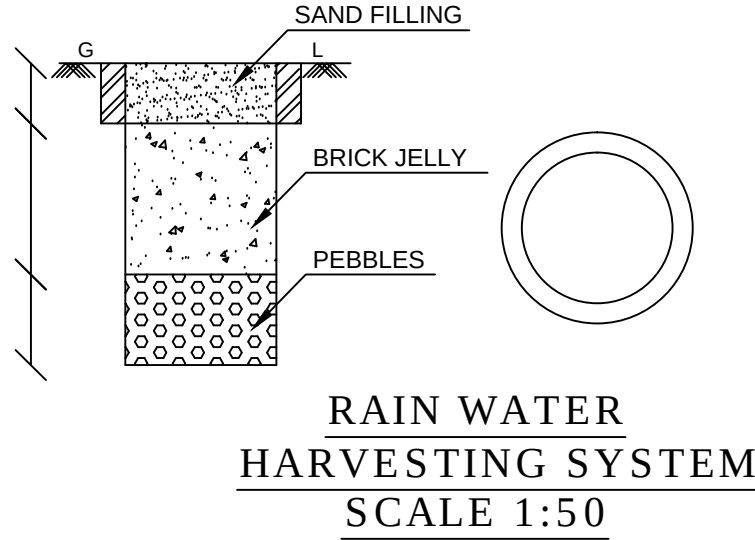


RAIN WATER
HARVESTING SYSTEM
SCALE 1:50

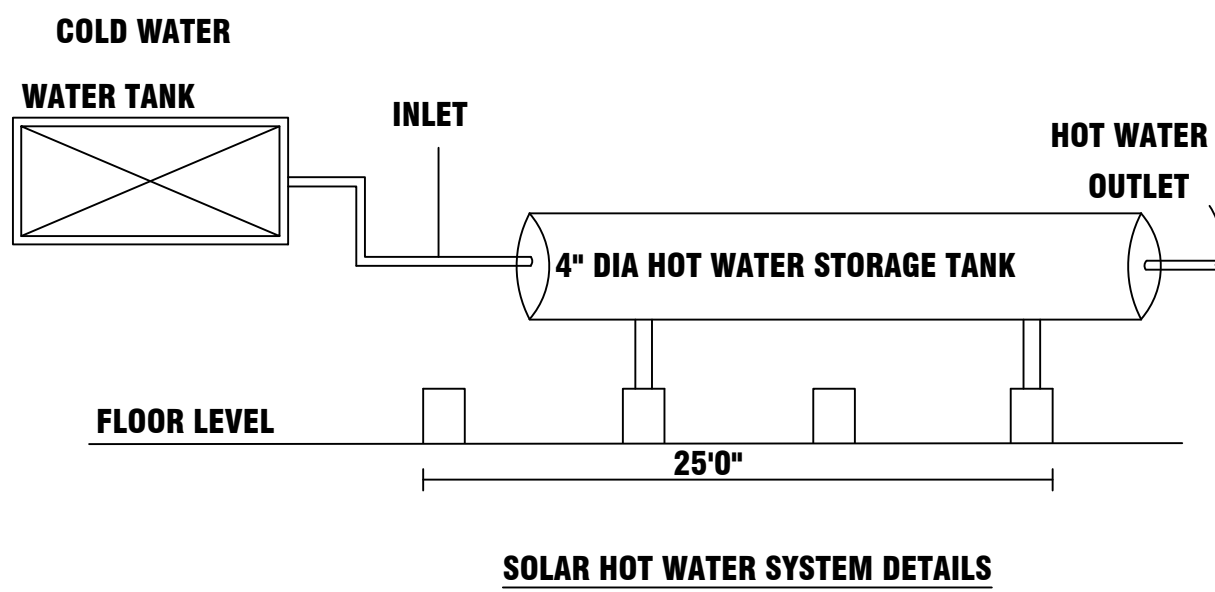


SOLAR HOT WATER SYSTEM DETAILS

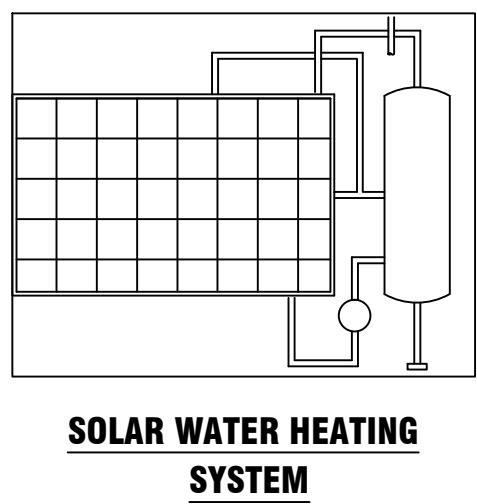

SOLAR WATER HEATING
SYSTEM

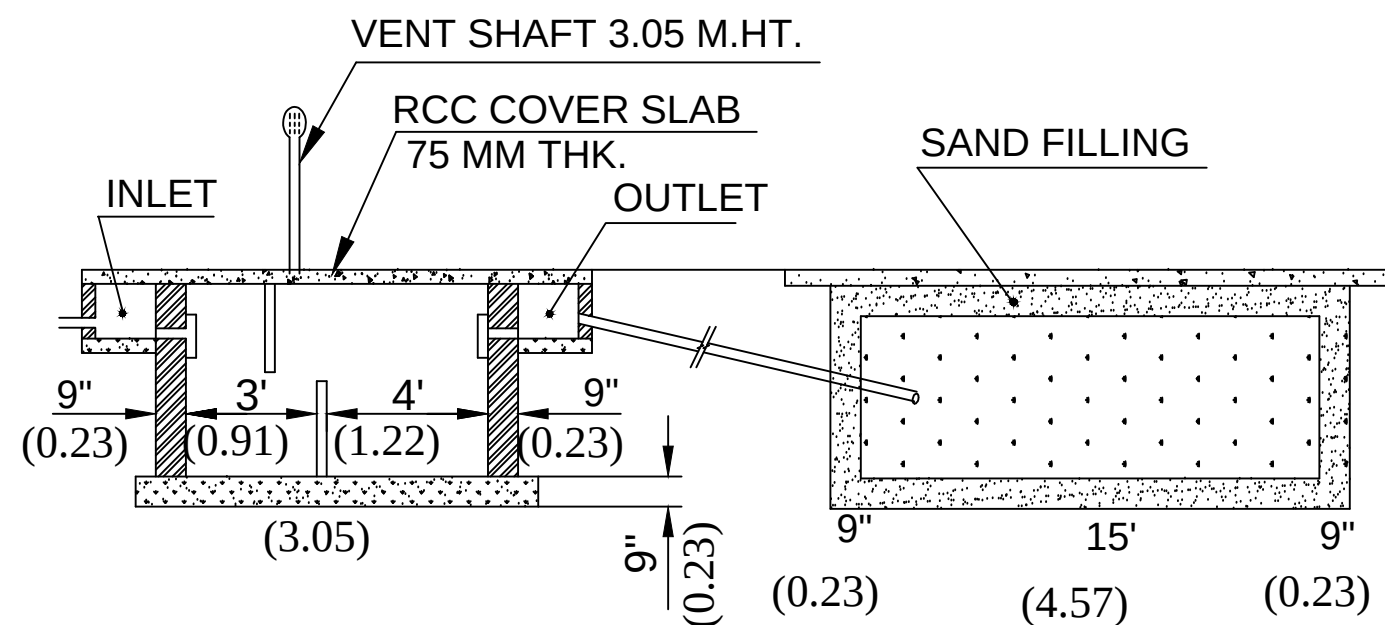

SECTION ON SEPTIC TANK & DISP-TRENCH

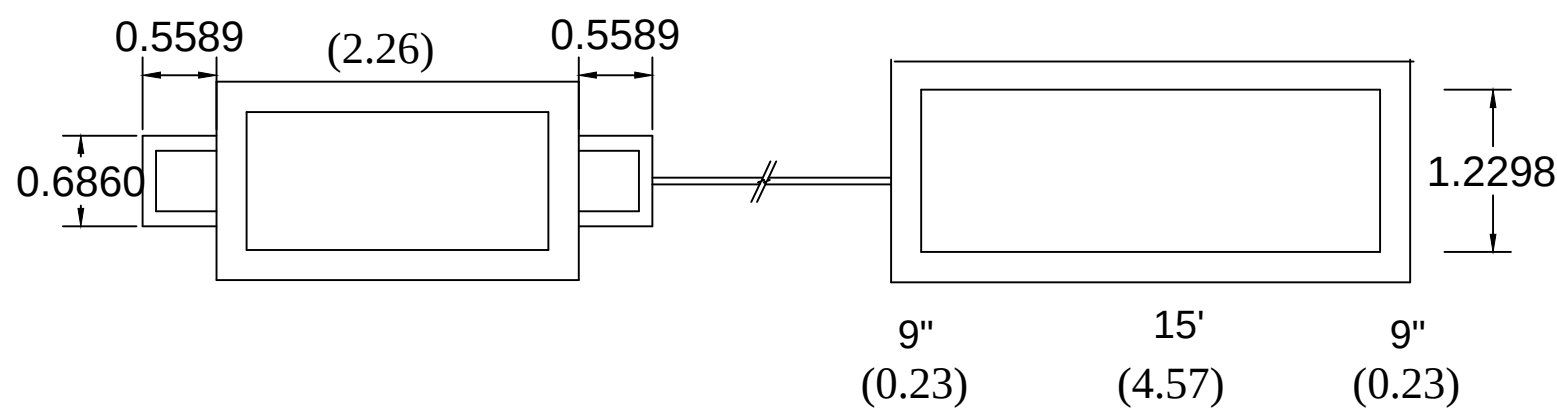

PLAN ON SEPTIC TANK & DISP-TRENCH

SCHEDULE OF JOINERIES			
REFERENCE		IN FEET	IN MEET
MD	MAIN DOOR	5'0"X7'0"	1.52X2.13
D	DOOR	3'0"X7'0"	0.91X2.13
D1	DOOR	2'6"X7'0"	0.76X2.13
O	OPEN	3'3"X7'0"	1.00X2.13
W1	WINDOW	4'0"X4'0"	1.22X 1.22
W	WINDOW	5'0"X4'0"	1.52X1.22
V	VENTILATOR	3'0"X2'0"	0.91X0.60
EX	EXHAUST FAN	12" DIA	
AREA OF CALCULATION		SQ.FT	SQ.MT
AREA OF PLOT		1750.00	162.60
PROPOSED GROUND FLOOR BUILDING		917.39	85.26
OPEN SPACE		832.61	77.38
1. L.P. GAS WILL BE USED FOR KITCHEN			
2. BORE WELL WITH MOTAR, WATER TANK AND PANCHAYAT WATER SUPPLY WILL BE PROVIDED			
3. SULLAGE WASTE FROM TOILET WILL BE CONNECTED INTO SEPTIC TANK.			
4. RAIN WATER PERCOLATION BED 1.0m WIDE PROVIDED AS PER GO (MS) NO: 138 DATED 11-02-02.			
5. RAIN WATER TAKEN TO THE BORE WELL THROUGH 150MM DIA PIPES			
6. SOLAR WATER HEATER WILL BE PROVIDED.			
7. ALL DIMENSIONS ARE IN METRE.			
8. AT KITCHEN EXHAUST FAN TO BE PROVIDED.			

REFERENCE	
BOUNDRY LINE	☐
PROPOSED BLDG	☐

[Signature]

APPLICANT

[Signature]
Er.V.RAJASEKAR,DCE.,Lbs.,
Registered Engineer,
Municipality Reg.No : 154/LS/2020/00001
Udumalpet Road,Kurunji Nagar,
DHARAPURAM,Tiruppur Dist.
Cell : 98439 62675

ENGINEER