

SITE AND DETAILED PLAN SHOWING THE PROPOSED CONSTRUCTION OF RCC ROOF GROUND FLOOR RESIDENTIAL BUILDING IN SITE NO. 8, KURINJI NAGAR, R.S.NO.730/4A, (OLD S.F.NO.2204/3 & 2205/3), PATTA NO. 1709, KOLATHUPALAYAM TOWN PANCHAYAT, DHARAPURAM TALUK, TIRUPPUR DISTRICT.

APPLICANT:
Mr.S.MOHAMED YUSSUF
S/o SAGUL AMEED

ந.க.எண் 347/2017, dated 04.09.2024

SHEET_1

N

NOTE:

ALL DIMENSION 'S ARE IN METRE
SCALE 1:100

SCHEDULE OF JOINERIES

SYMBOLS	DESCRIPTION	SIZE IN FEET	SIZE IN METRES
M.D	M.DOOR	3'6"X7'0"	1.07X2.13
W	WINDOW	5'0"X4'0"	1.37X1.22
W1	WINDOW	6'0"X6'0"	1.82X1.80
D1	DOOR	2'9"X7'0"	0.83x2.13
D	DOOR	3'0"X7'0"	0.91x2.13
V1	VENTILATOR	3'0"X2'0"	0.91X0.61

AREA DETAILS IN SQFT IN SQM

AREA OF THE SITE	1650.00	153.29
AREA OF G. FLOOR	646.48	60.06
CARPET AREA IN G.F	537.23	49.91

PARKING PROVIDED

BIKE SPACE	2
------------	---

COLOUR INDEX


	SITE BOUNDARY
	PROPOSED RCC ROOF BUILDING
	ROAD
	RAIN WATER PERCULATION PIT

S. Jaganathan


APPLICANT:

Er.A.N.JAFAR SATHICK, D.C.E., (B.E.,(LBS)
Reg.No.154/LS/2023/00003
Engineer & Licenced Building Surveyor,
NOOR ENGINEERING CONSULTANTS
38,Rajandra Nagar, DHARAPURAM - 638 656.
CELL : 9940712342, 74185 12286


ENGINEER/L.B.S

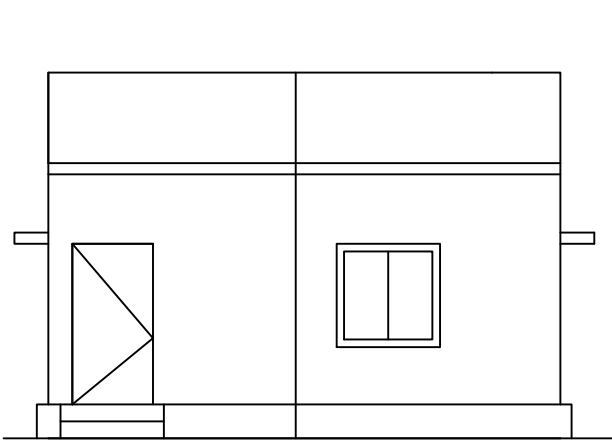


FRONT ELEVATION

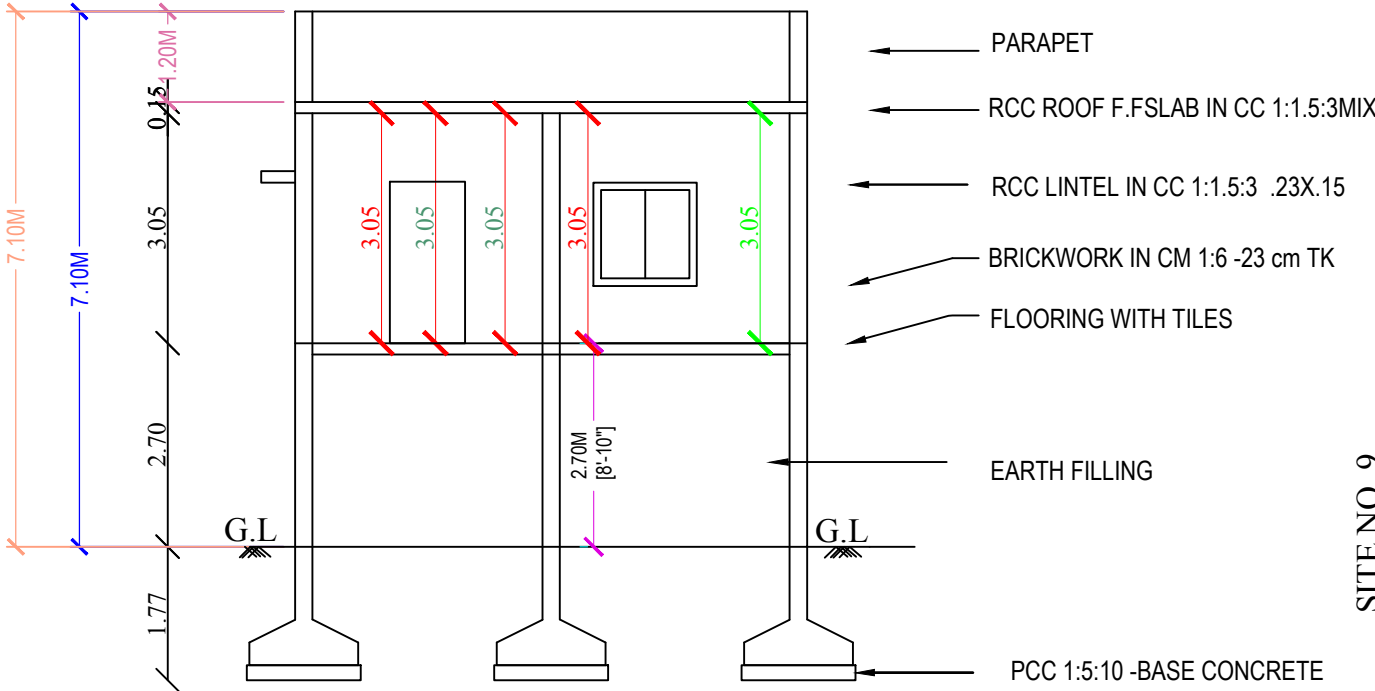


SECTION AA

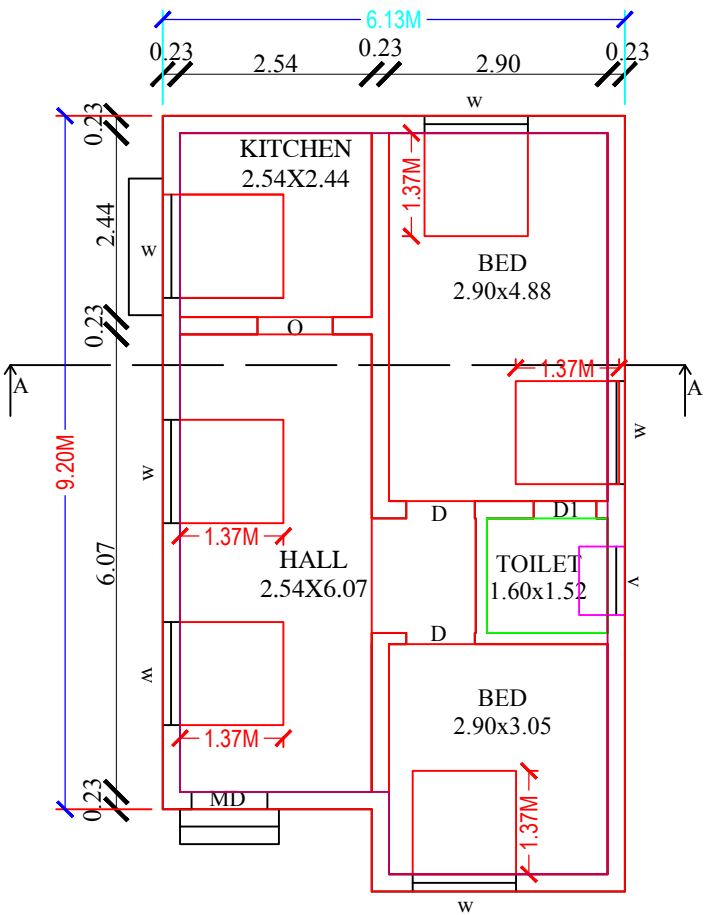

FLOOR PLAN

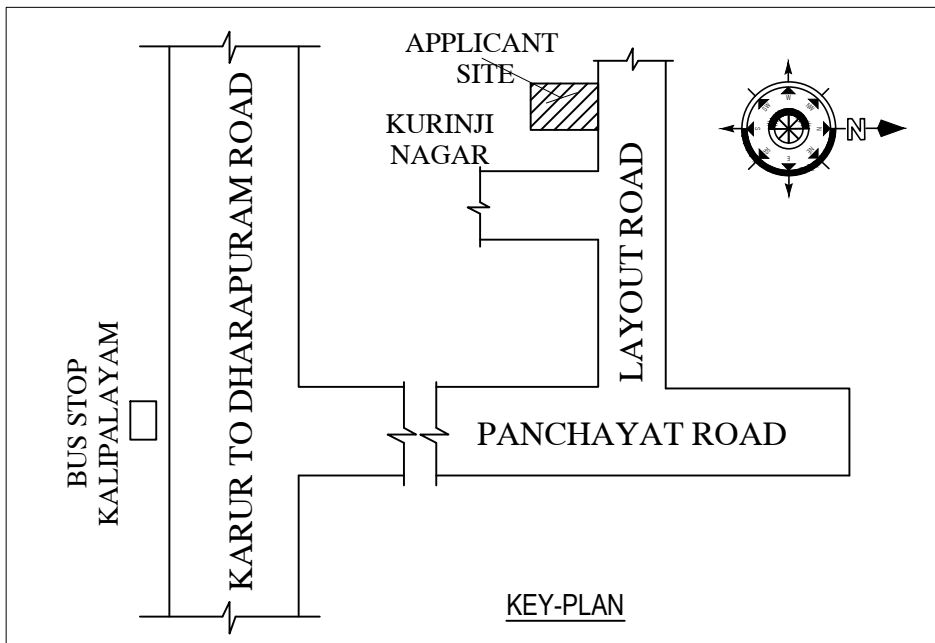


KEY-PLAN

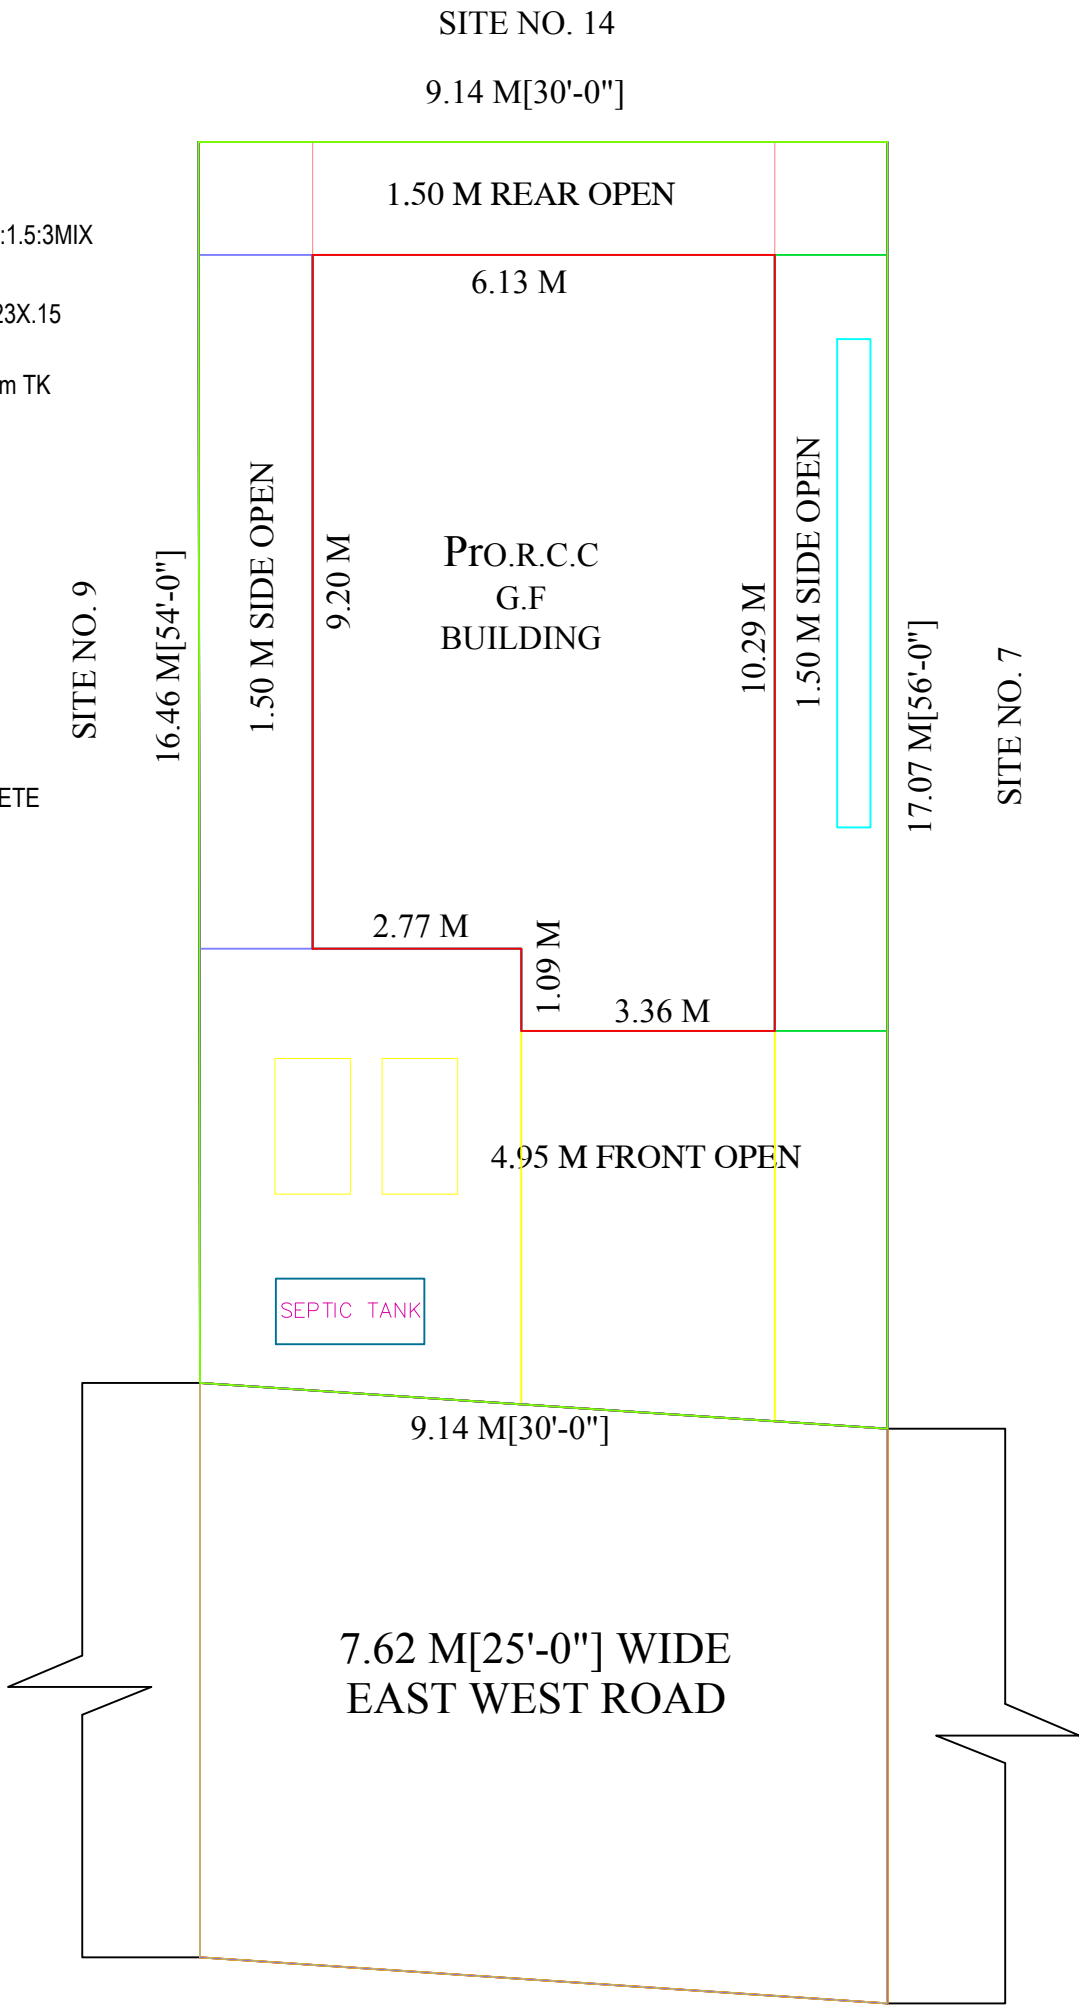


SITE PLAN




MAIN GATE

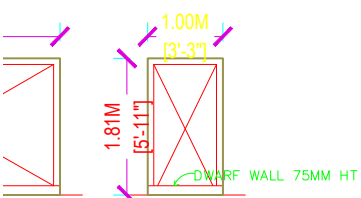


WICKET GATE

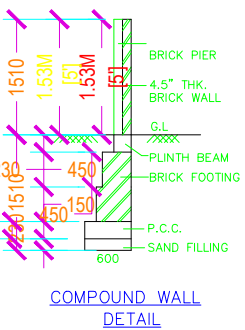


COMPOUND WALL
DETAIL

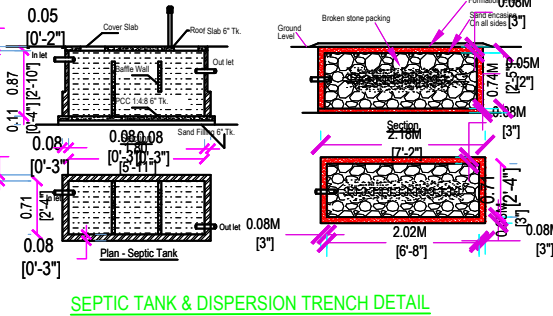


SEPTIC TANK & DISPERSION TRENCH
DETAIL

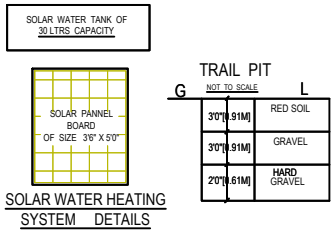

SOLAR WATER HEATING
SYSTEM DETAILS

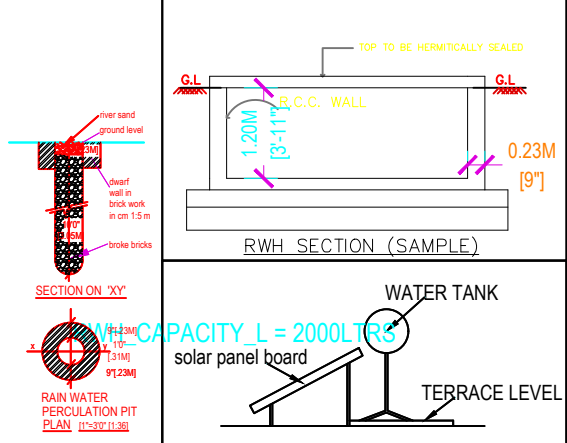

RAIN WATER PERCULATION PIT
PLAN

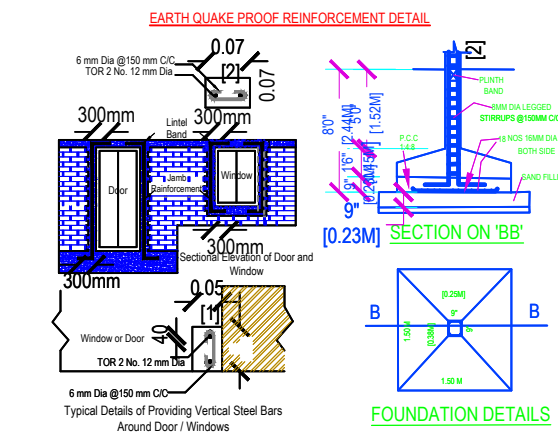

FOUNDATION DETAILS