



PLAN SHOWING THE PROPOSED CONSTRUCTION OF R.C.C. ROOF GROUND FLOOR & FIRST FLOOR RESIDENTIAL BUILDING
AT SITE No :14, R.S.F No: 121/1A, 121/2A1, (OLD S.F. No: 1927), ROYAL GARDEN, KARUR ROAD, KOLATHUPALAYAM
VILLAGE AND TOWN PANCHAYAT, DHARAPURAM TALUK, TIRUPPUR DISTRICT,

APPROVED LAYOUT IN LP/R(CN)NO:58/2020


APPLICANT : Mr.D.MANOJKUMAR, S/o.DURAISAMY.,

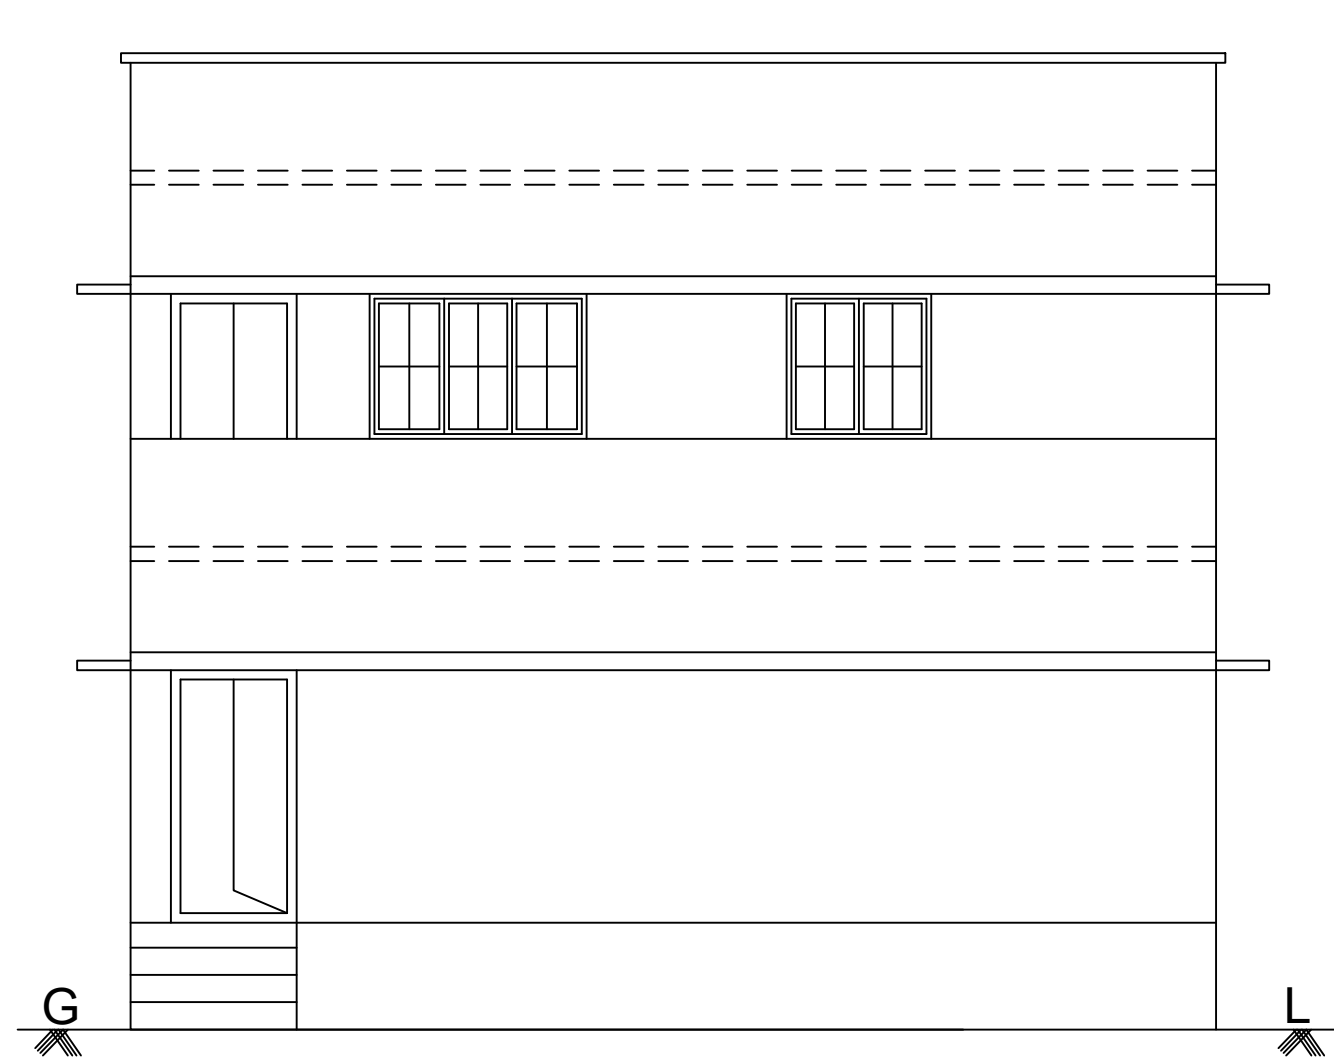


FRONT ELEVATION

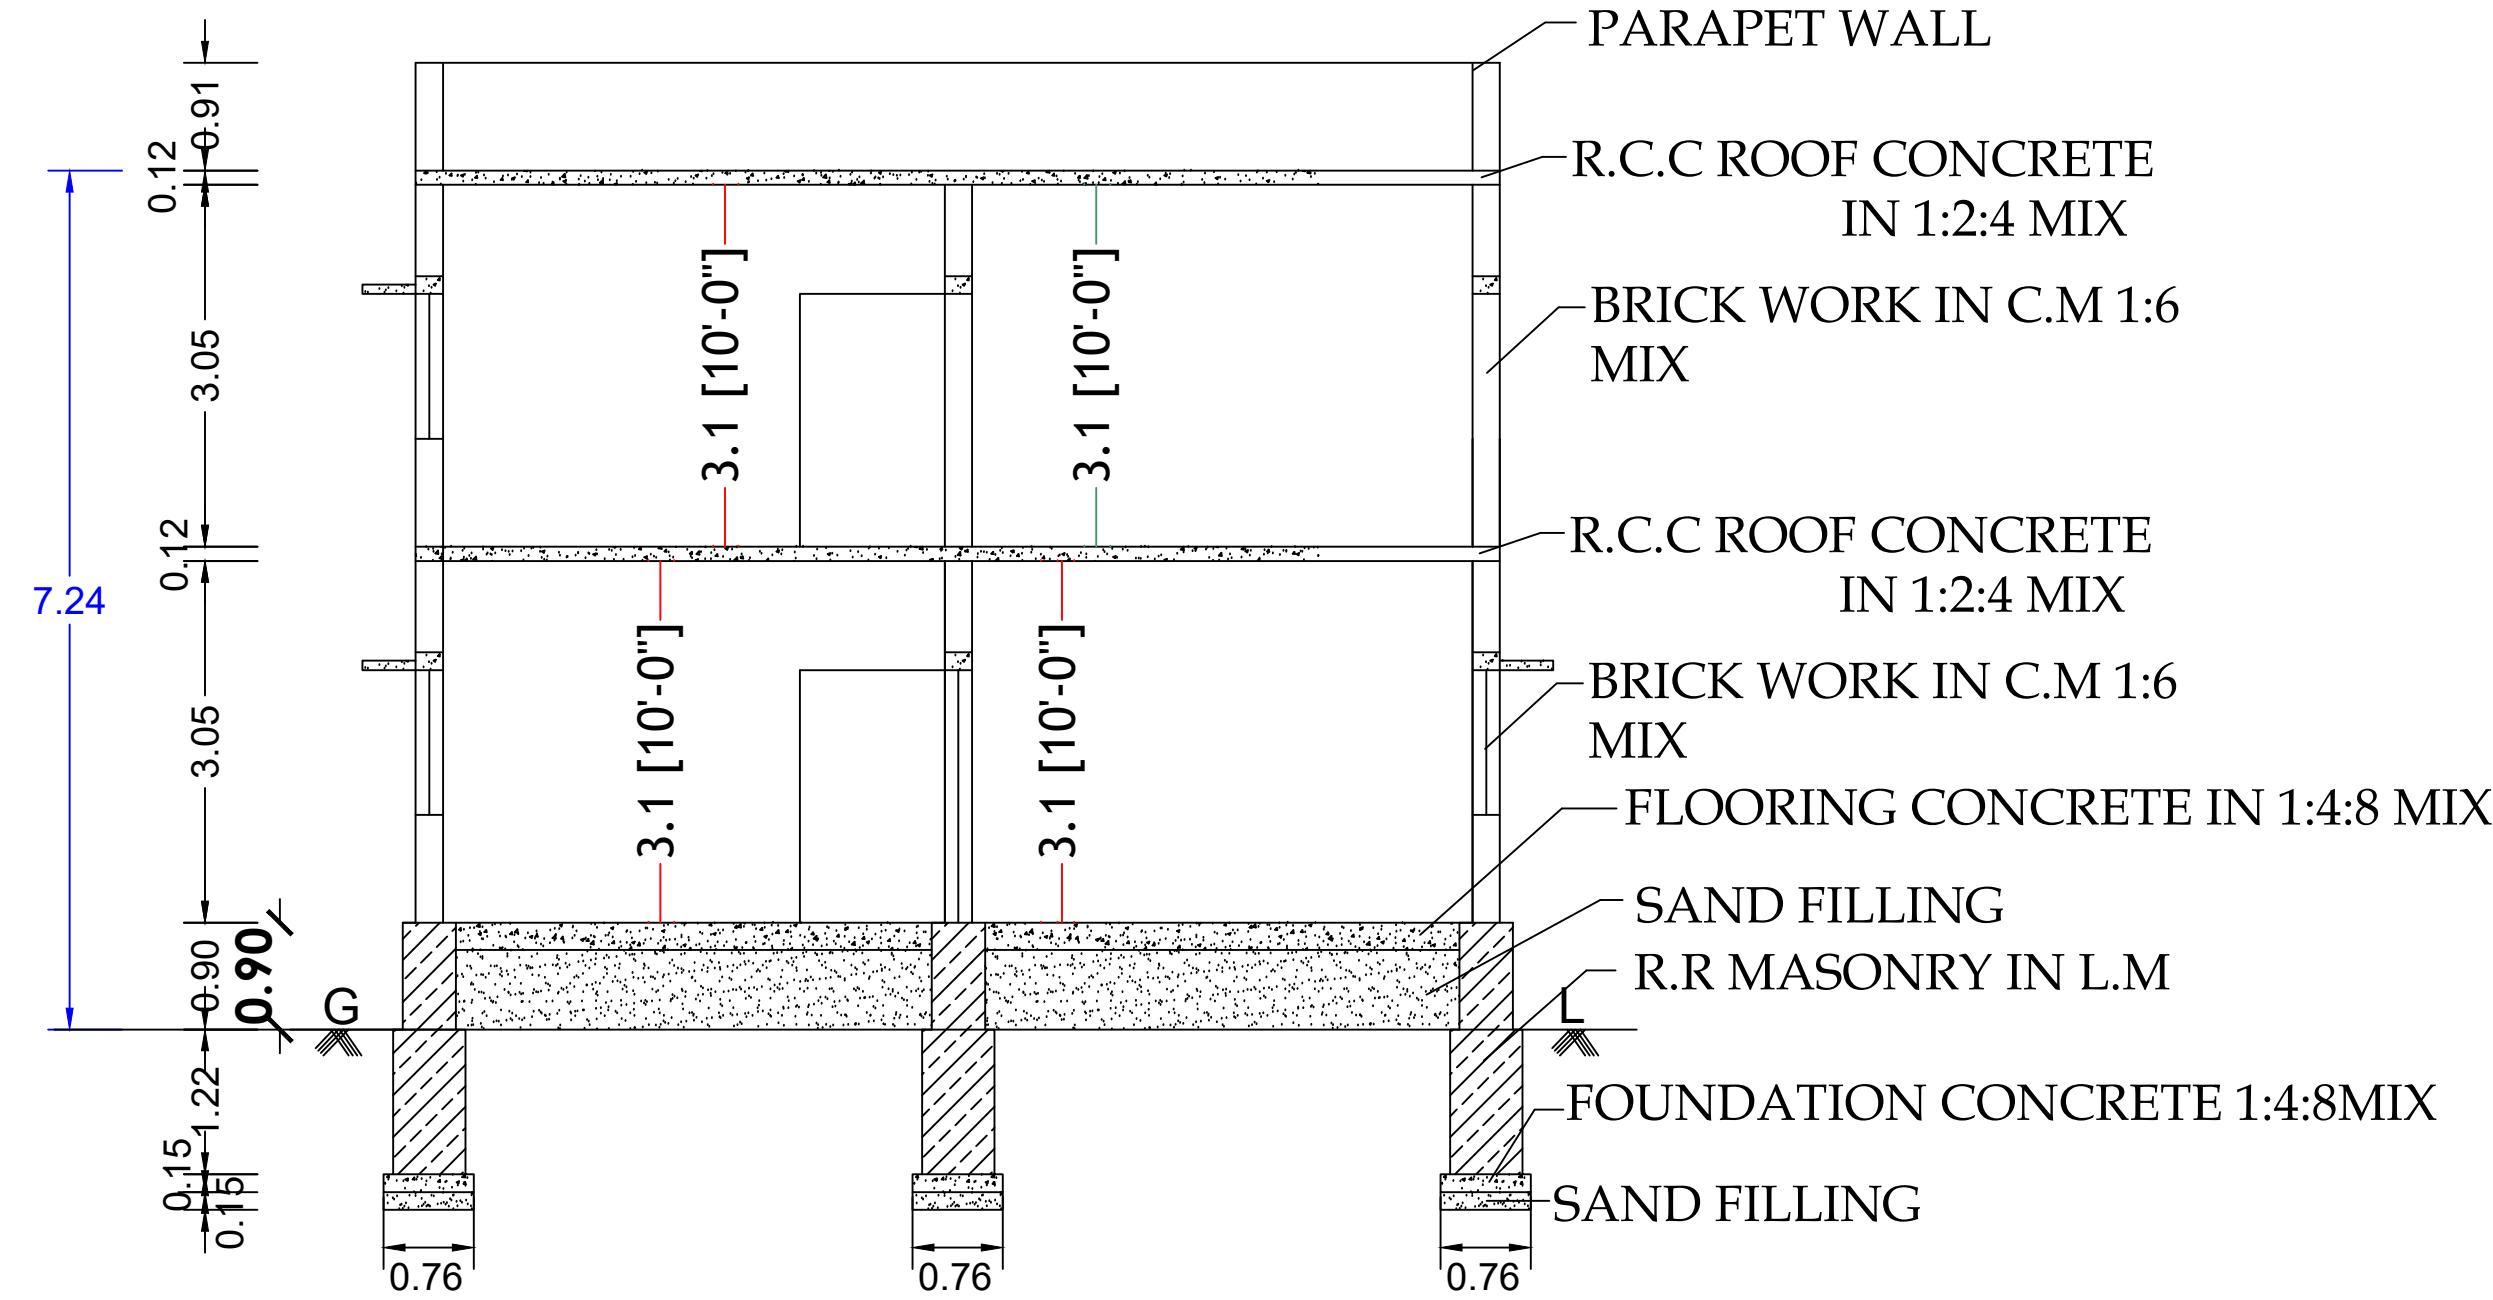


SECTION ON 'AA'

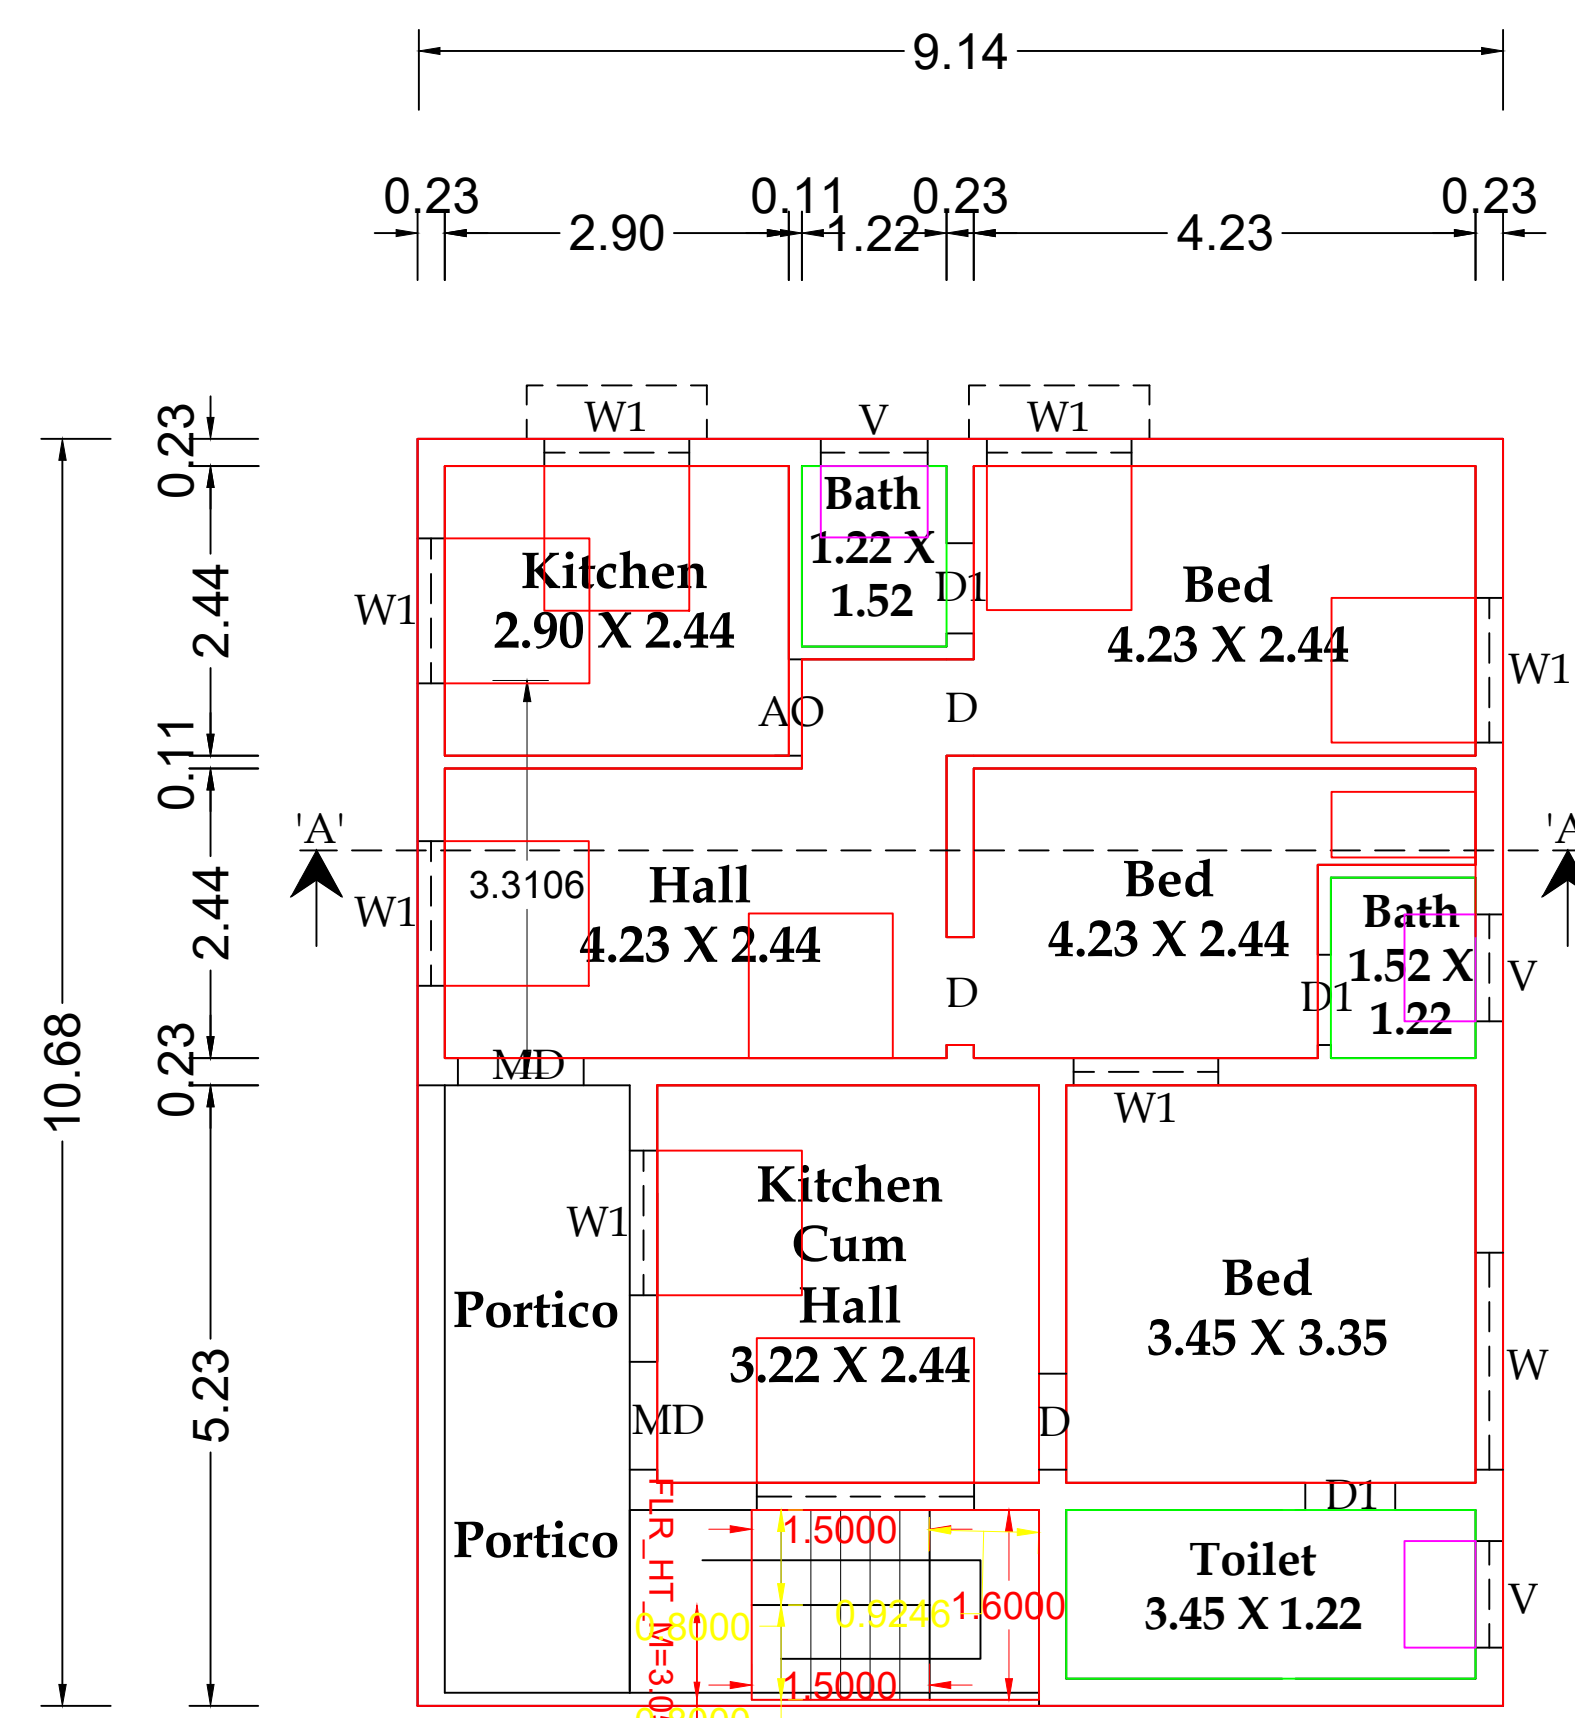


GROUND FLOOR PLAN

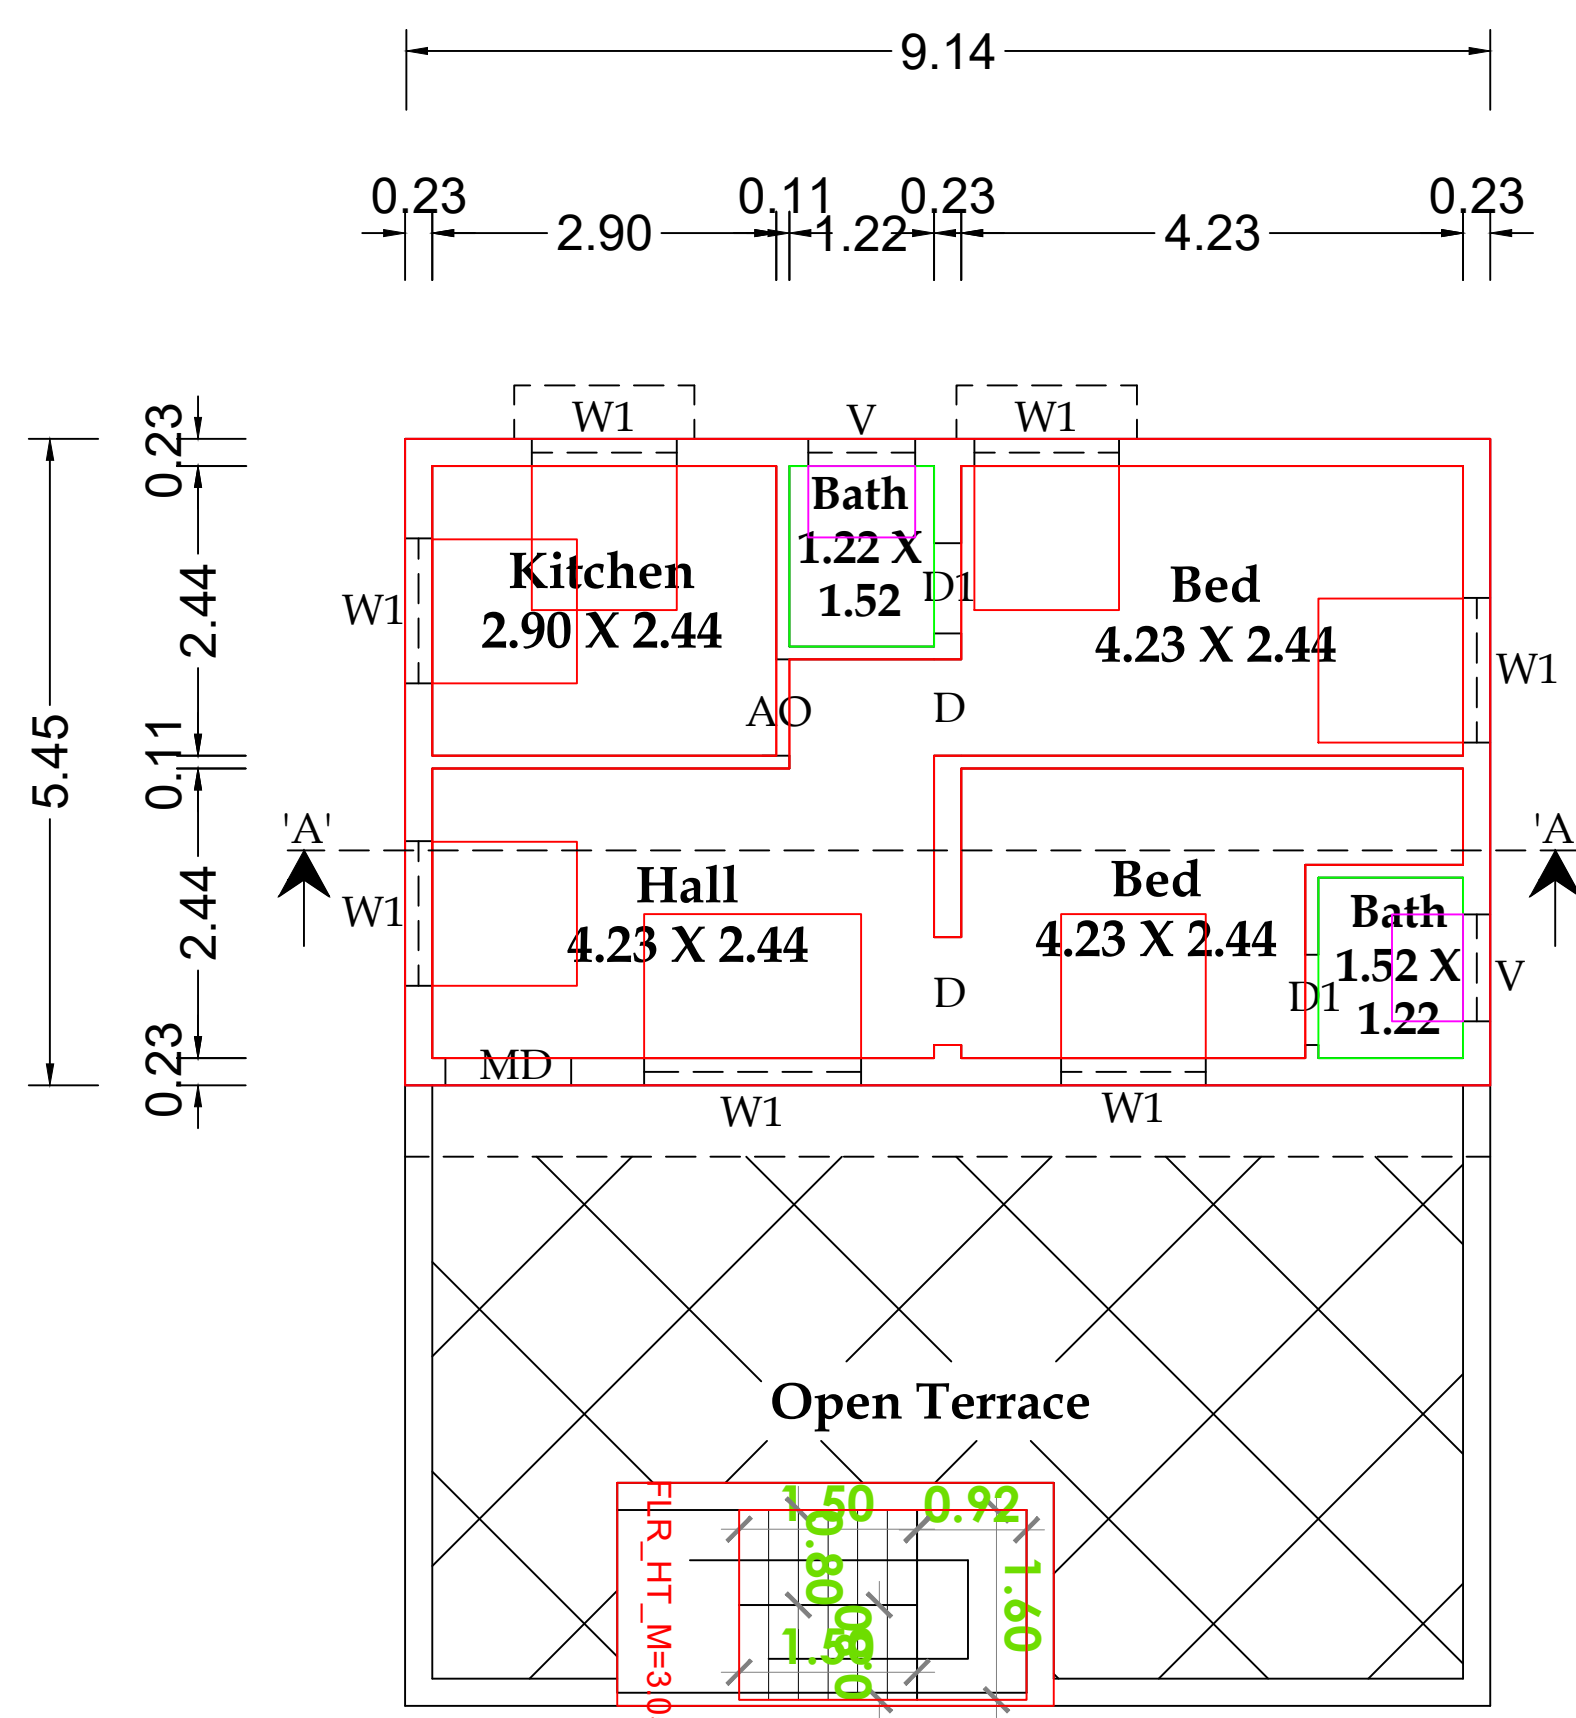

FIRST FLOOR PLAN

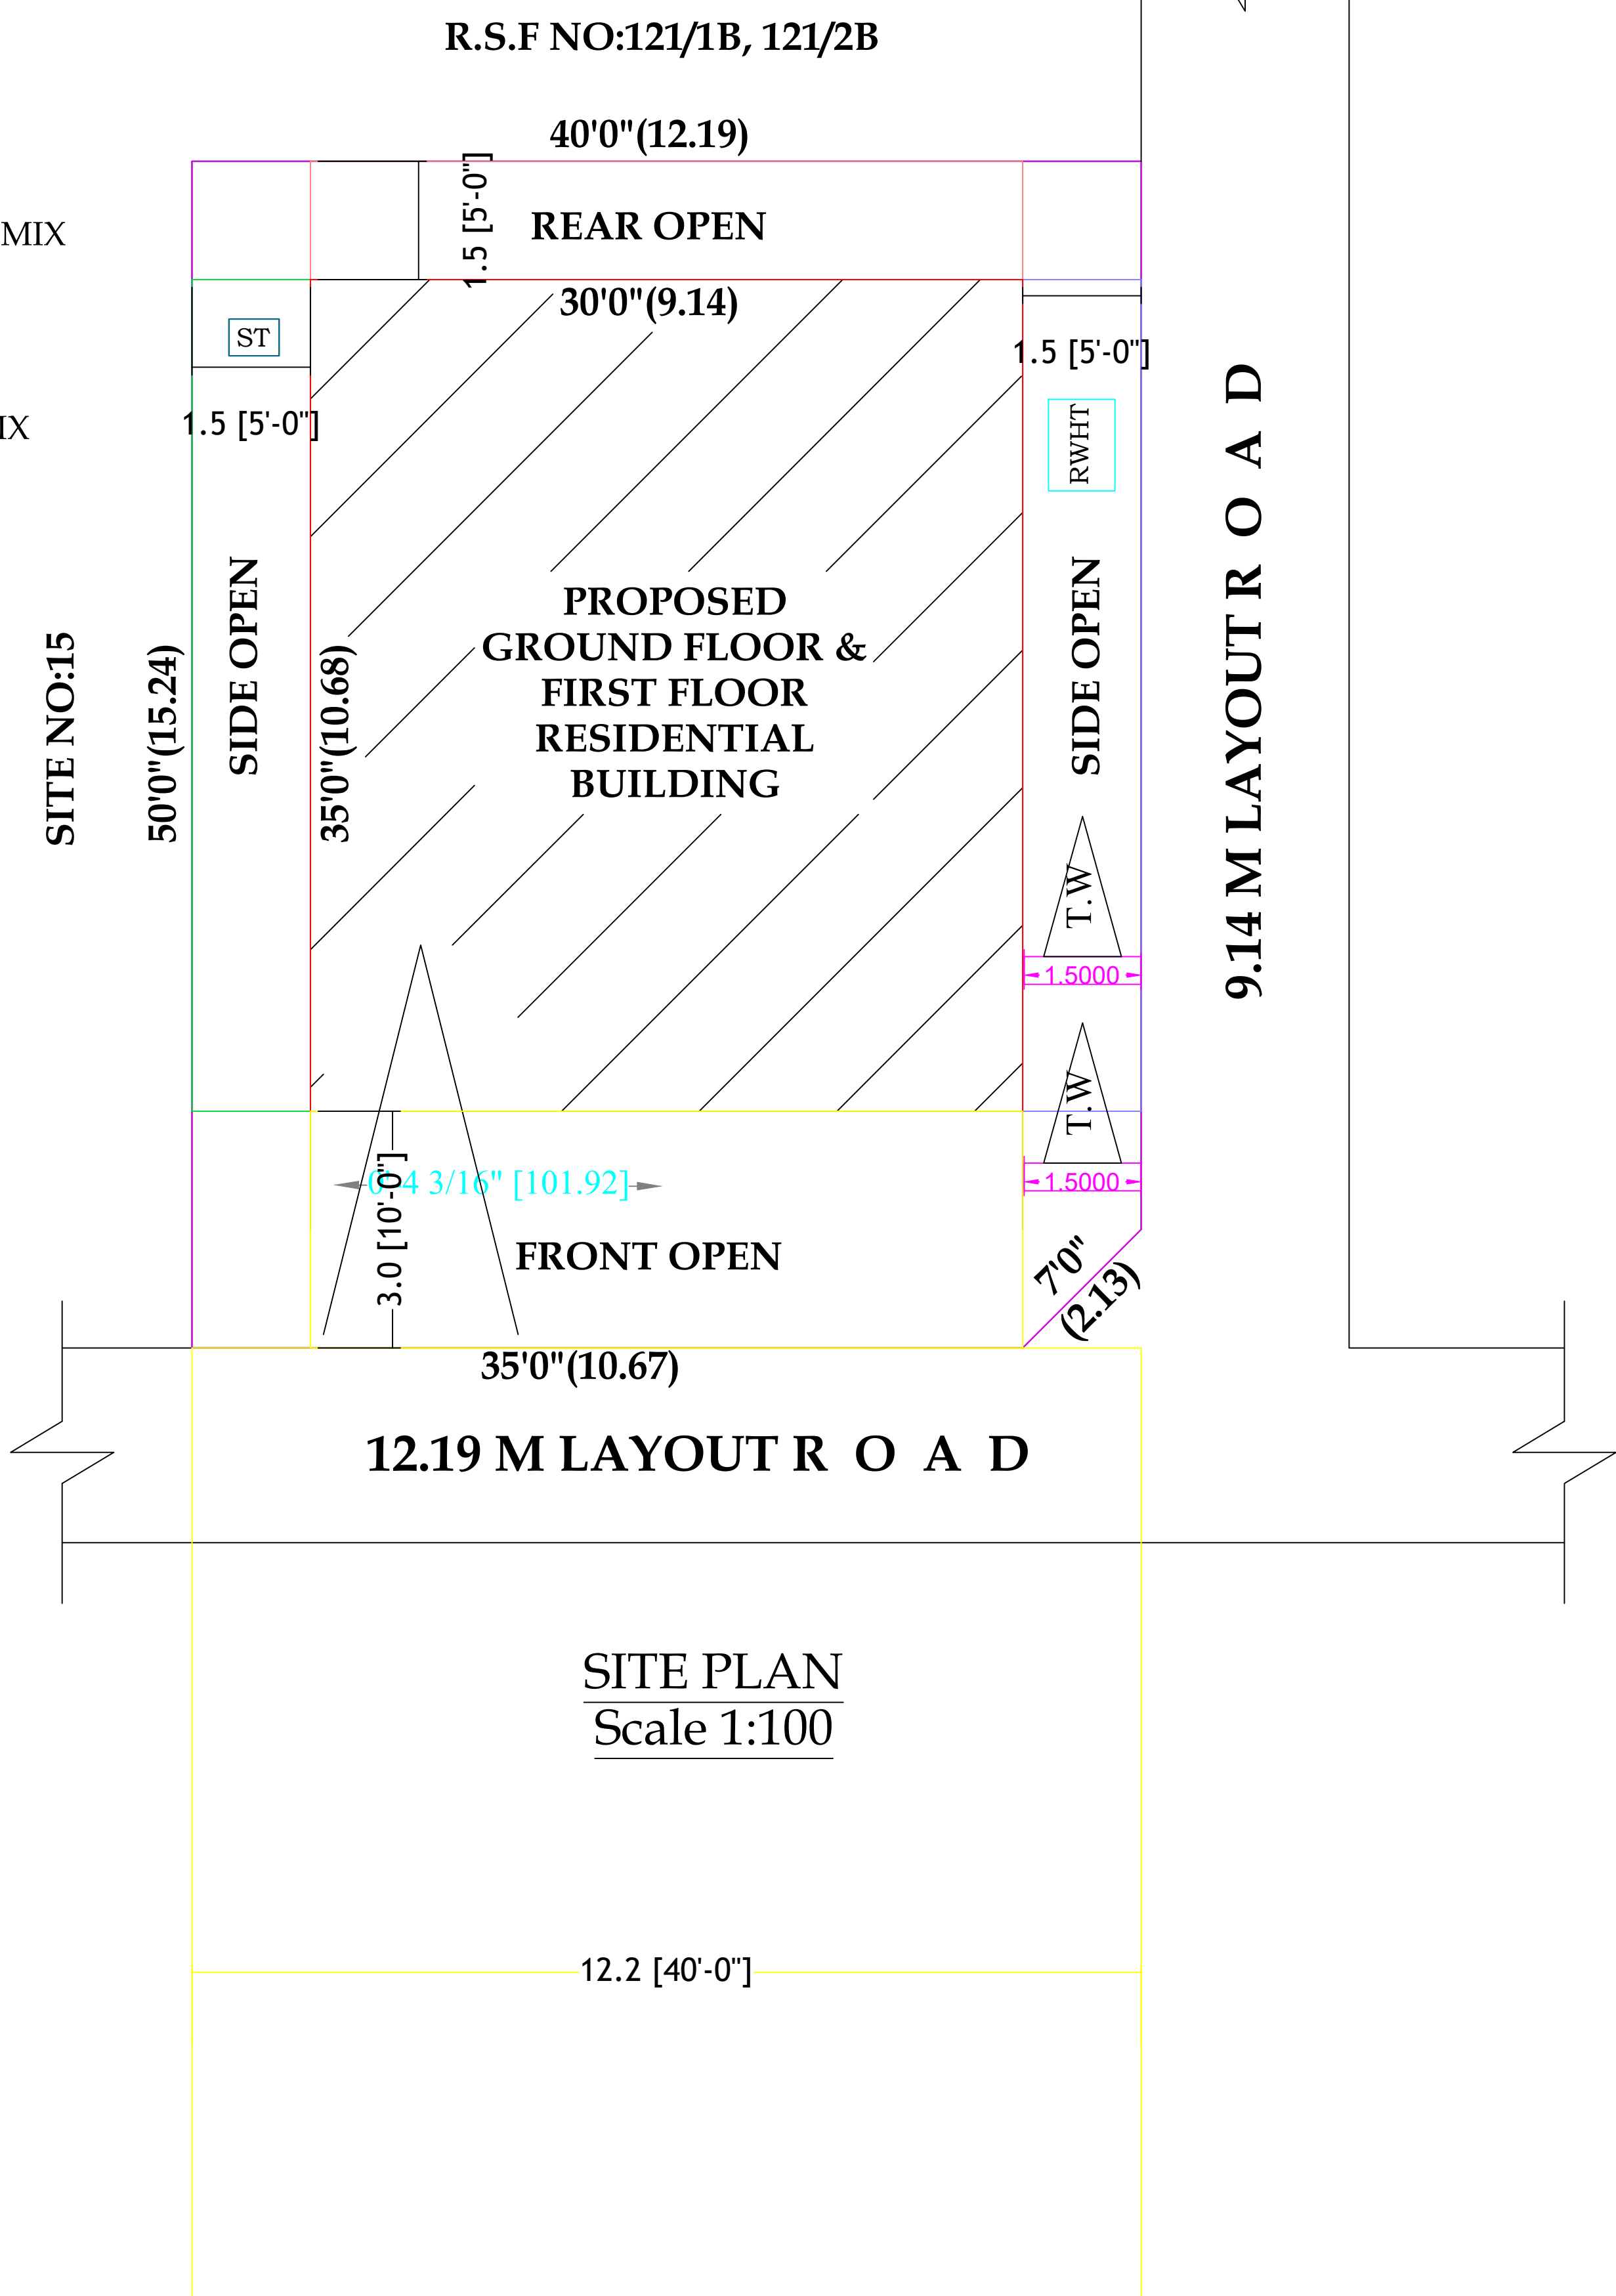

SITE PLAN
Scale 1:100

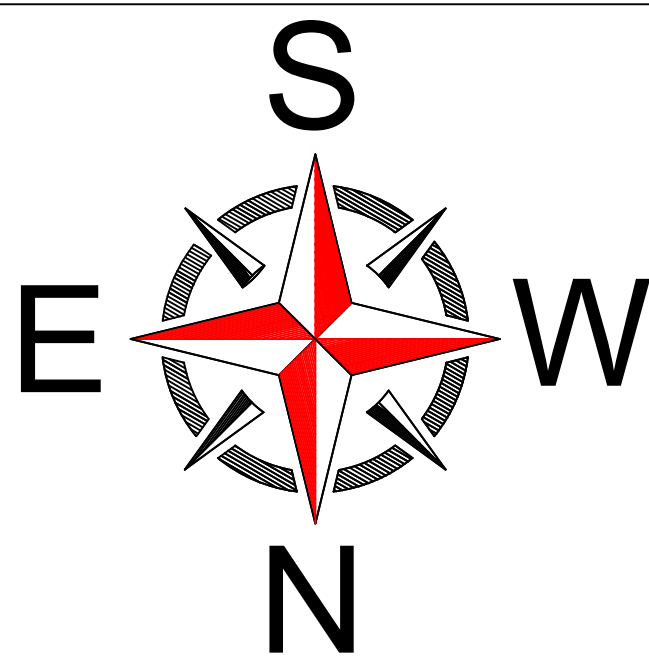

Schedule of Joinery

MD	Main Door	1.52 × 2.13
D	Door	1.00 × 2.13
D1	Door	0.76 × 2.13
W1	Window	1.22 × 1.22
W2	Window	0.91 × 1.22
KW	Kitchen Window	1.22 × 1.06
V	Ventilator	0.76 × 0.76

EX EXHAUST FAN 12" DIA

Area Reference	Sq.ft	Sq.mt
Area of the Site	1988.00	184.69
Area Of The Ground Floor Building	1051.85	97.72
Area Of The First Floor Building	611.28	56.79
Area of the Open Space	936.15	86.97

1. L.P. GAS WILL BE USED FOR KITCHEN
2. BORE WELL WITH MOTAR, WATER TANK AND MUNICIPAL WATER SUPPLY WILL BE PROVIDED
3. SULLAGE WASTE FROM TOILET WILL BE CONNECTED INTO SEPTIC TANK.
4. RAIN WATER PERCOLATION BED 1.0m WIDE PROVIDED AS PER GO (MS) NO: 138 DATED 11-02-02.
5. RAIN WATER TAKEN TO THE BORE WELL THROUGH
6. SOLAR WATER HEATER WILL BE PROVIDED.
7. ALL DIMENSIONS ARE IN METRE.
8. AT KITCHEN EXHAUST FAN TO BE PROVIDED. 150MM DIA PIPES

Colour Index


- Site Boundary Existing Road
Proposed Building

D. Manoj Kumar


APPLICANT

Er.V.RAJASEKAR,DCE.,Lbs.,
Registered Engineer,
Municipality Reg.No : 154/LS/2020/00001
Udumalpet Road, Kurunji Nagar,
DHARAPURAM, Tiruppur Dist.
Cell : 98439 62675


ENGINEER

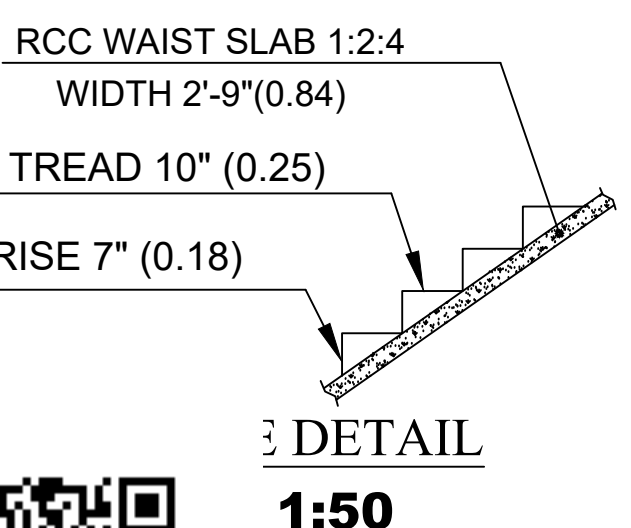


DETAIL
1:50

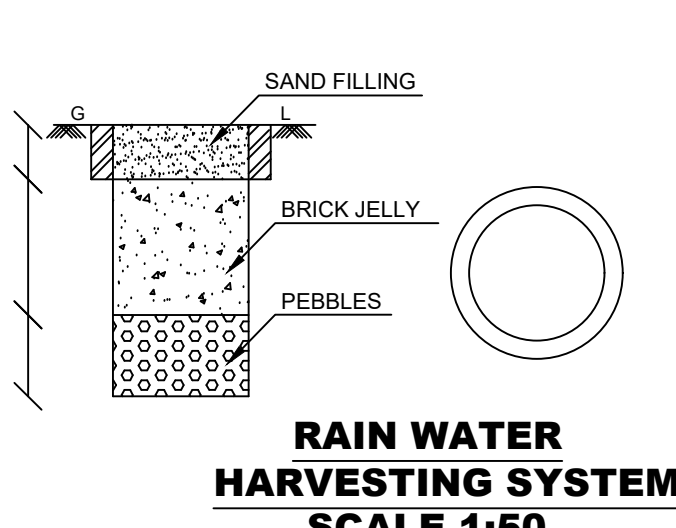


RAIN WATER
HARVESTING SYSTEM
SCALE 1:50

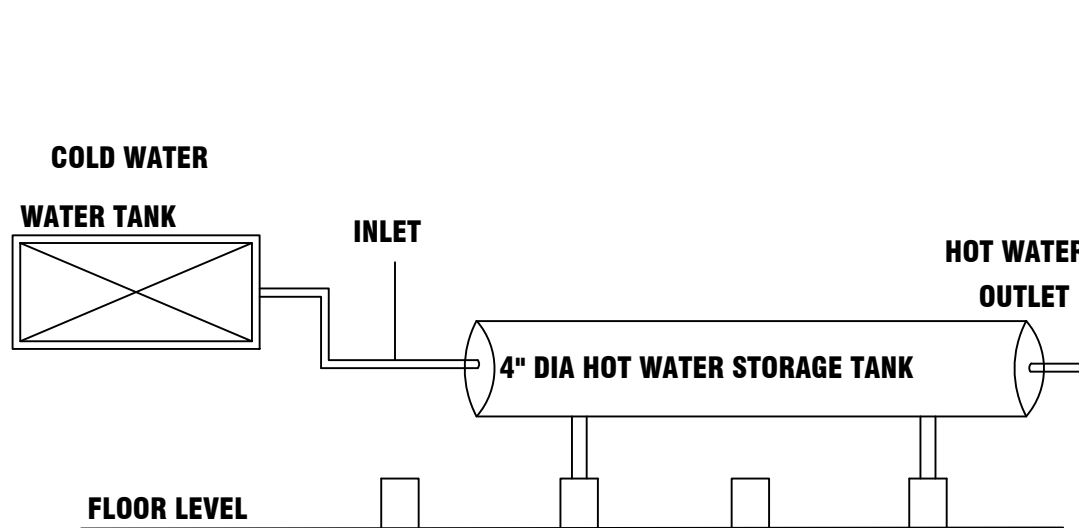


COLD WATER
WATER TANK

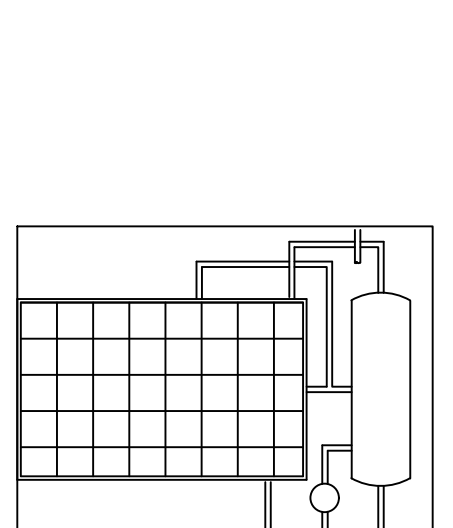


SOLAR WATER HEATING
SYSTEM

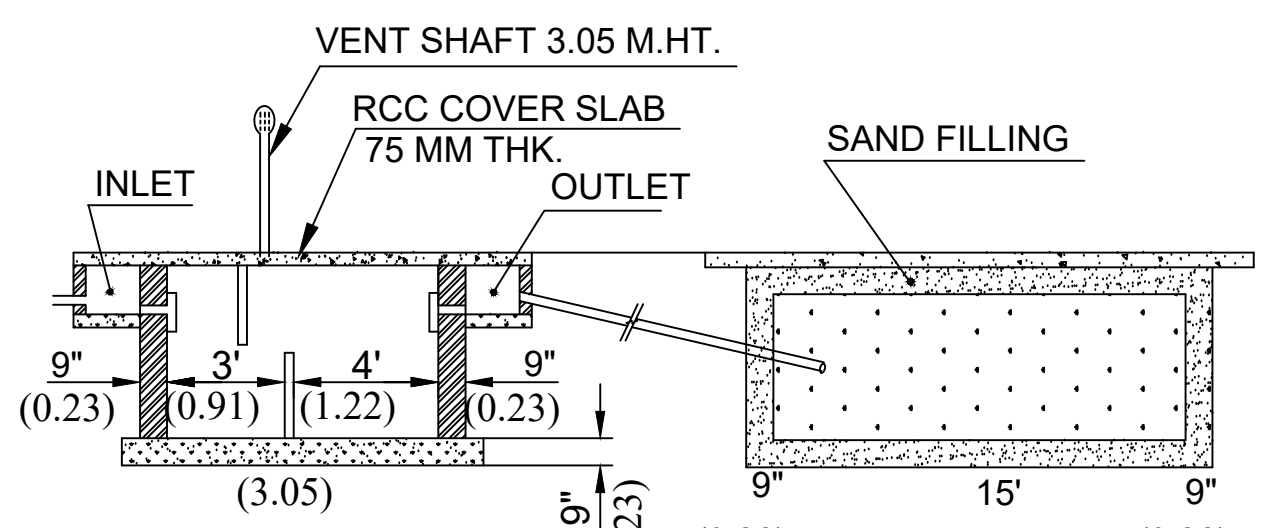

SECTION ON SEPTIC TANK & DISP-TRENCH

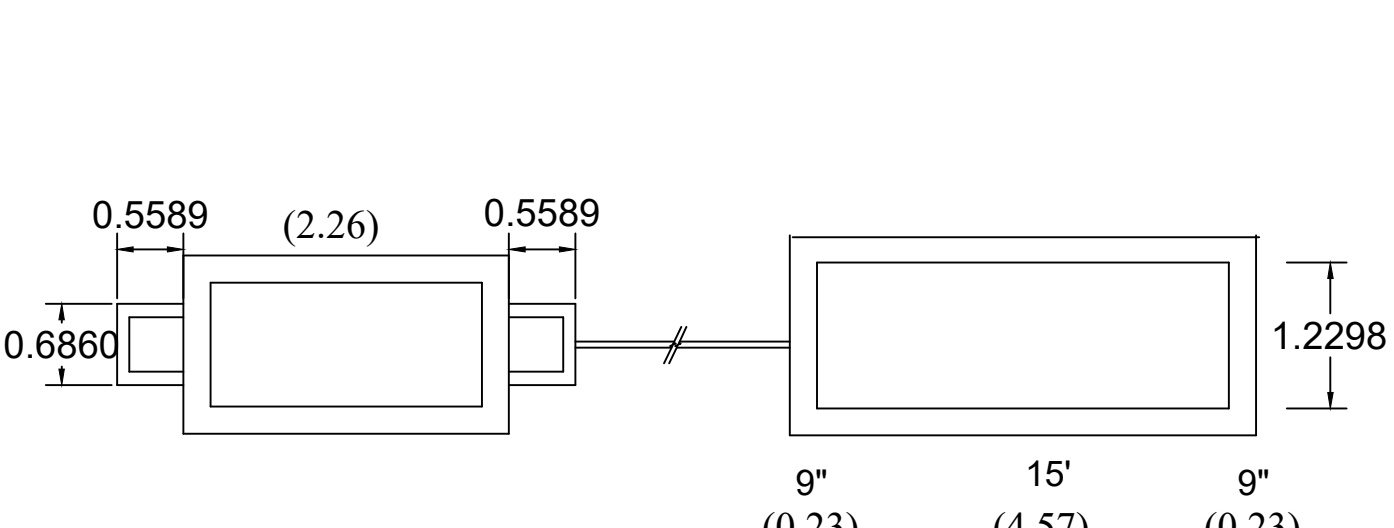

PLAN ON SEPTIC TANK & DISP-TRENCH

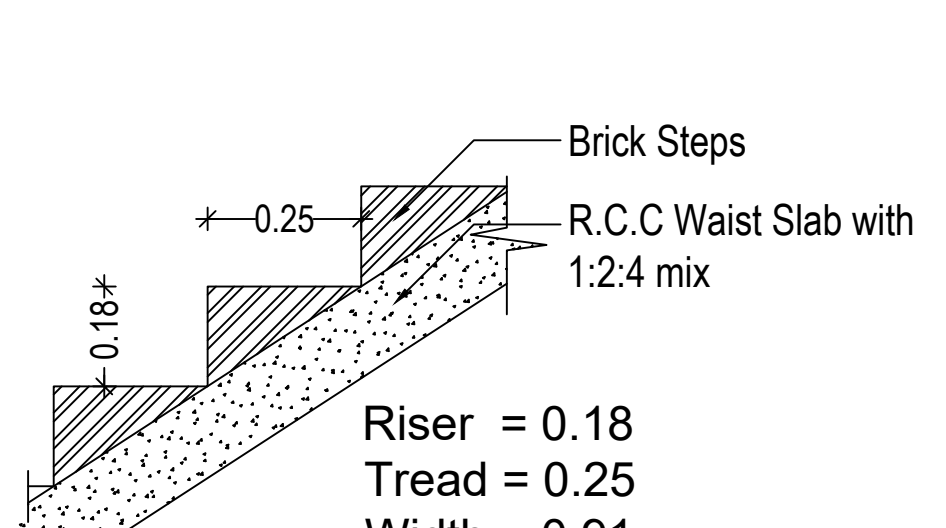

STAIR DETAILS
(NOT TO SCALE)