
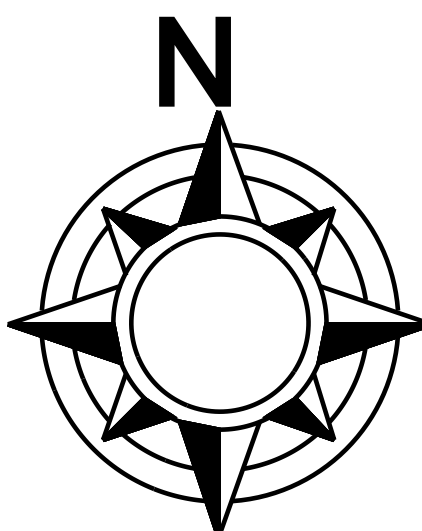



PLAN SHOWING THE PROPOSED CONSTRUCTION OF GROUND FLOOR
NATHAM S.No. - 1049 / 11A2 & 1049 / 12A2 , PATTA NO.- 2970,MARAKKANAM SOUTH,
MARAKKANAM TALUK,VILLUPURAM DISTRICT.

APPLICANT : Mr. THANIKAN S/O.MUNUSAMY.


SCALE - 1:100			
ALL DIMENSIONS AREA IN METER			
SHEET NO: 01 / 01			
AREA STATEMENT			
AREA DETAILS :-			In Sq.m
SITE AREA AS PER DOCUMENT			161.27
SITE AREA AS PER PATTA			161.27
SUPERIMPOSED PLOT AREA			161.27
FLOOR DETAILS	FSI	NON-FSI	TOTAL BUILUP AREA
GROUND FLOOR	79.71	-	79.71
TOTAL	79.71	-	79.71
FLOOR SPACE INDEX [F.S.I] = 79.71 / 161.27 = 0.49			
PLOT COVERAGE [P.C] =(79.71 / 161.27)x100 = 49.00 %			
SCHEDULE OF JOINERY			
TYPE	DESCRIPTION		SIZE IN M
M.D	MAIN DOOR		3.50 x 2.10
D1	DOOR		0.91 x 2.10
D2	DOOR		0.76 x 2.10
W	WINDOW		1.50 x 1.50
V	VENTILATOR		0.90 x 0.60
COLOUR REFERENCES			
SITE BOUNDARY SHOWN IN			
PROPOSED BUILDING SHOWN IN			
DRIVEWAY SHOWN IN			
EXISTING ROAD SHOWN IN			
APPLICANT :			
			
REGISTERED ENGINEER:			
			

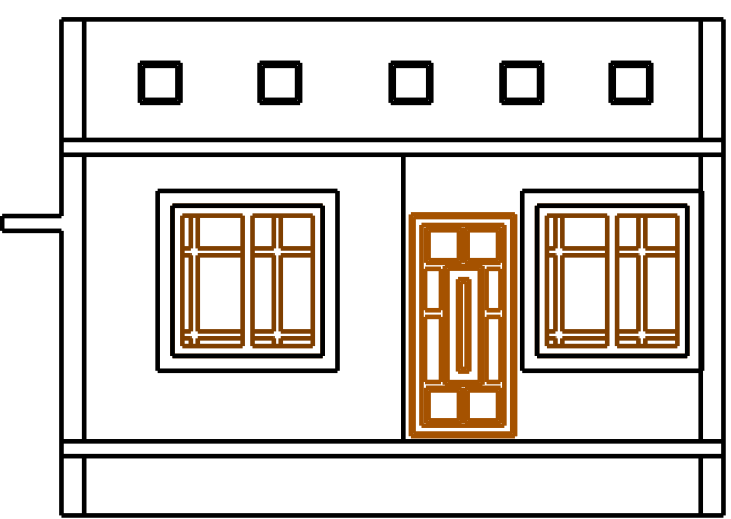


ELEVATION

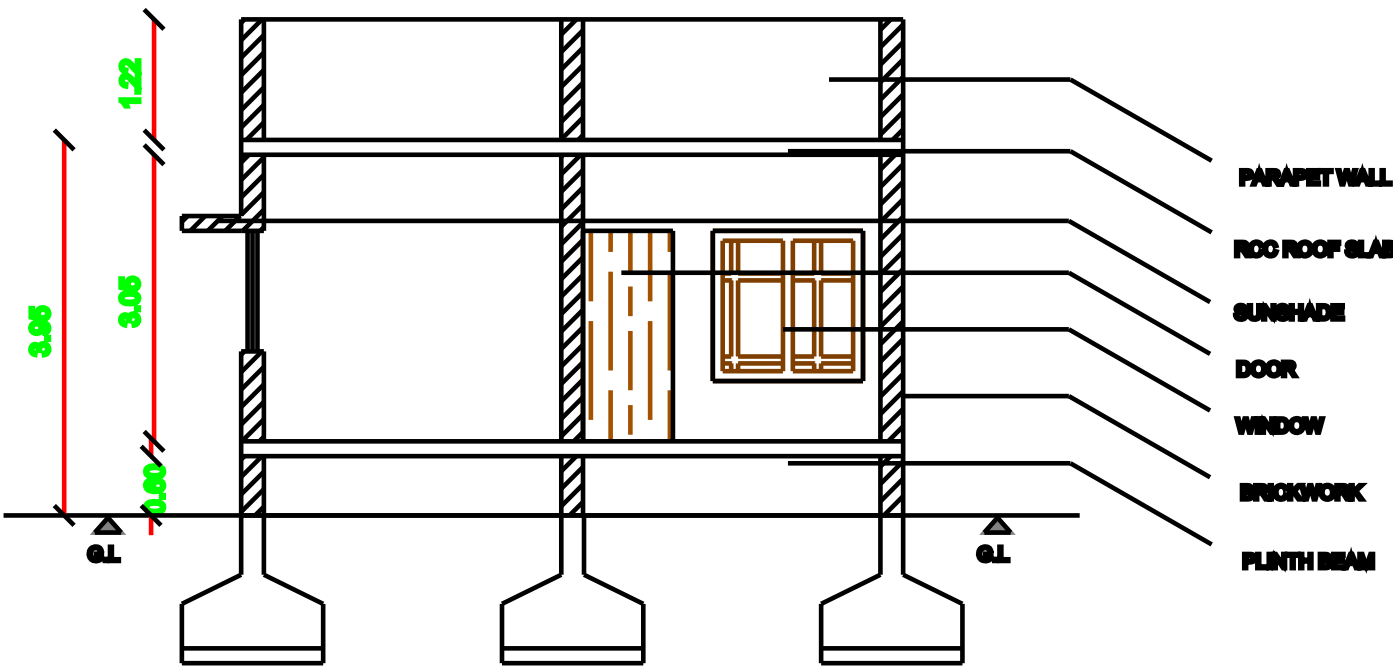


SECTION ON A-A

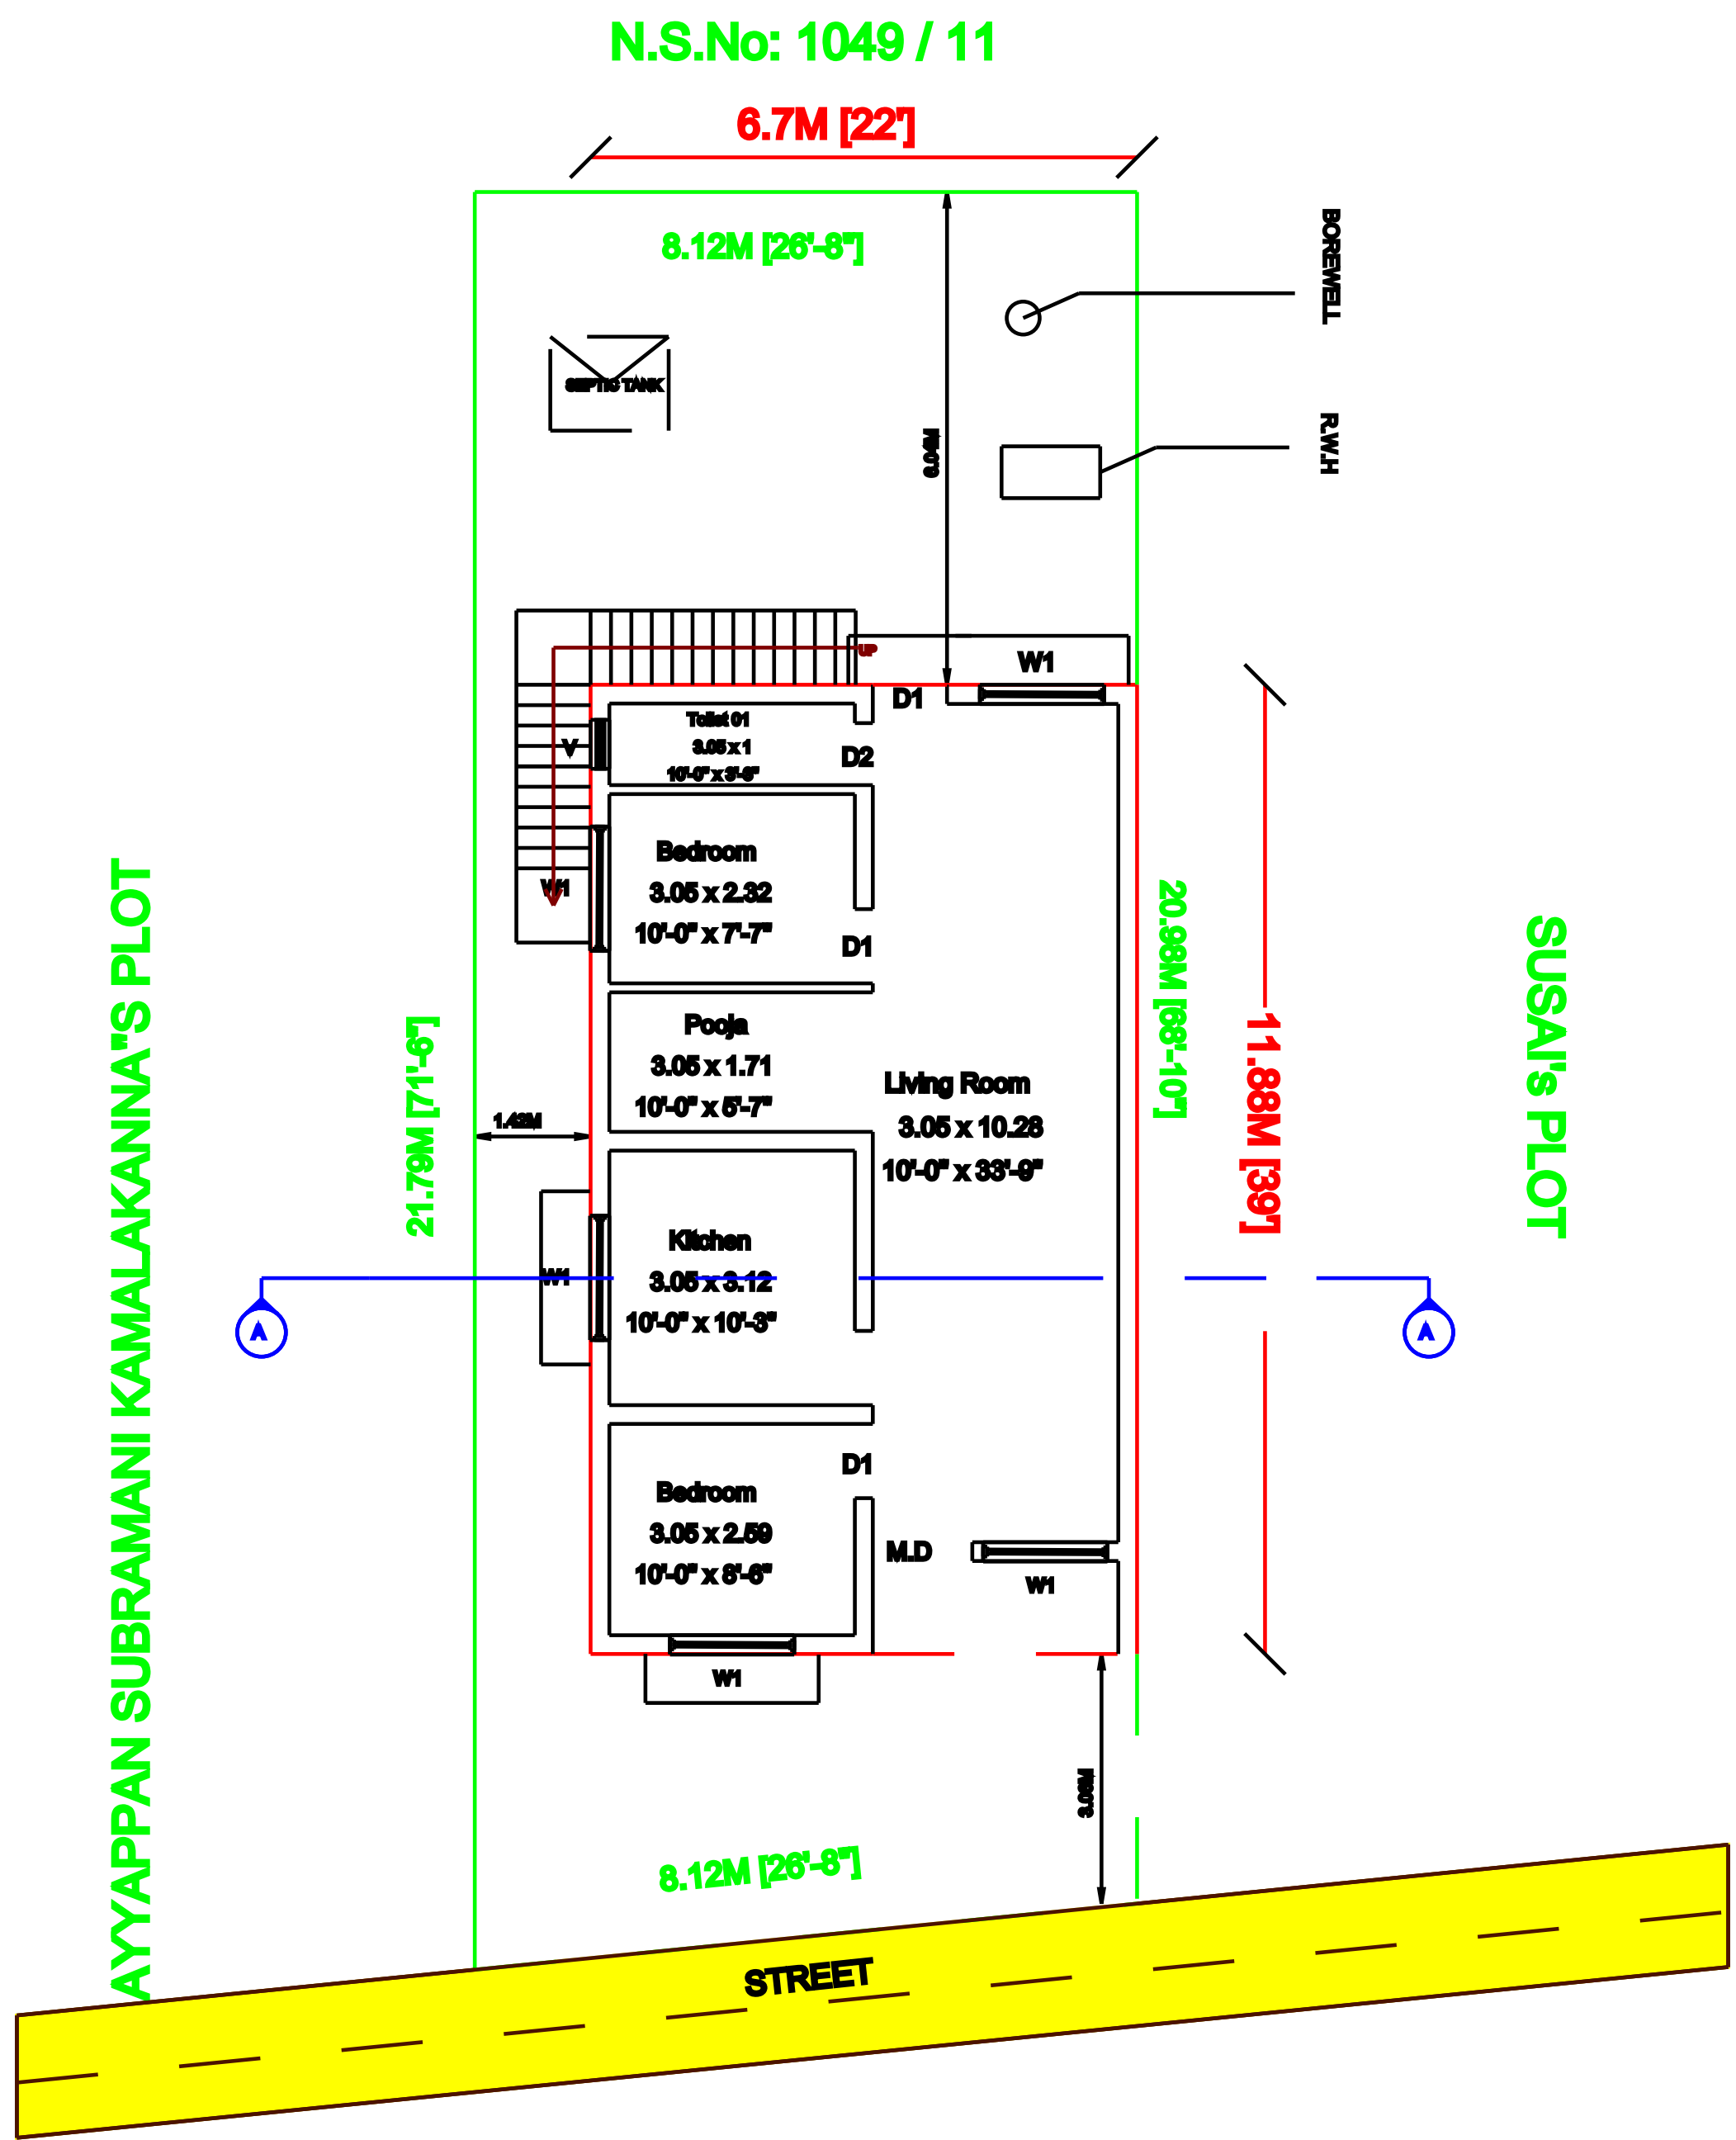


M GROUND FLOOR PLAN

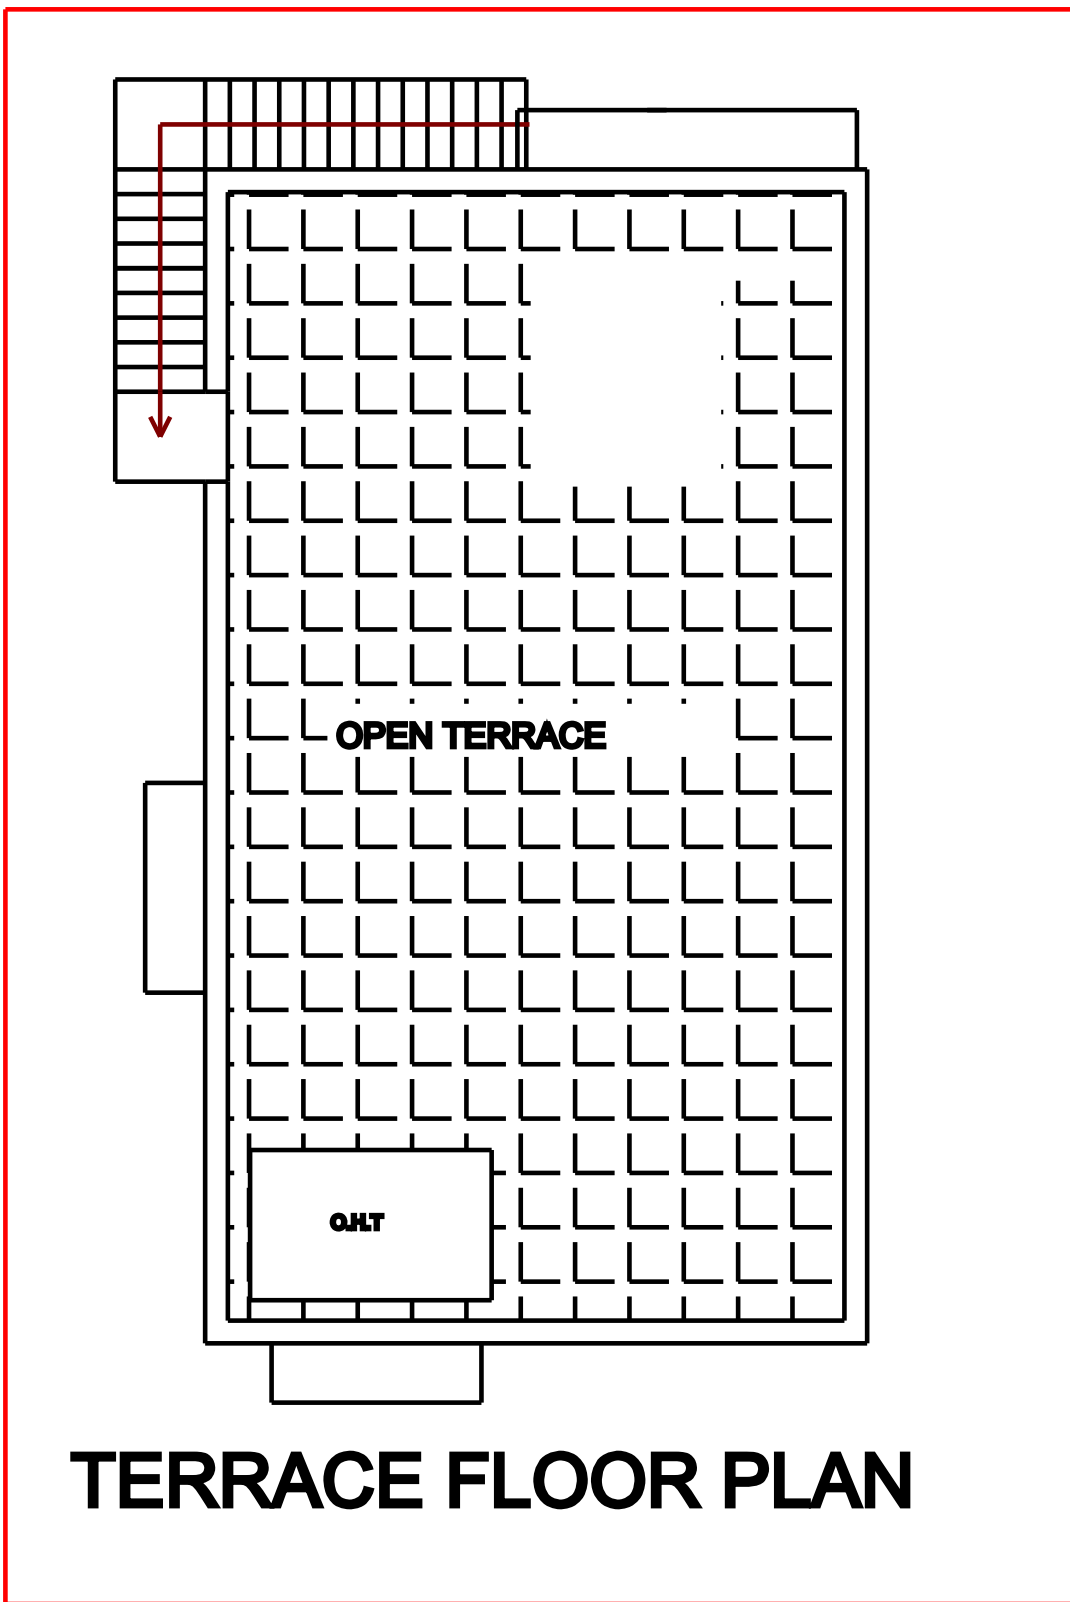

TERRACE FLOOR PLAN

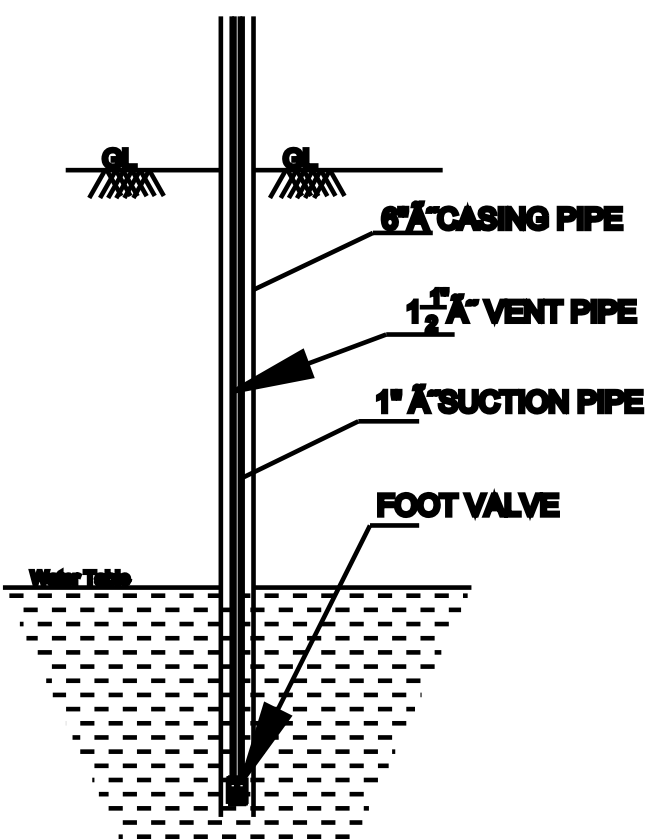


SEC. OF BOREWELL

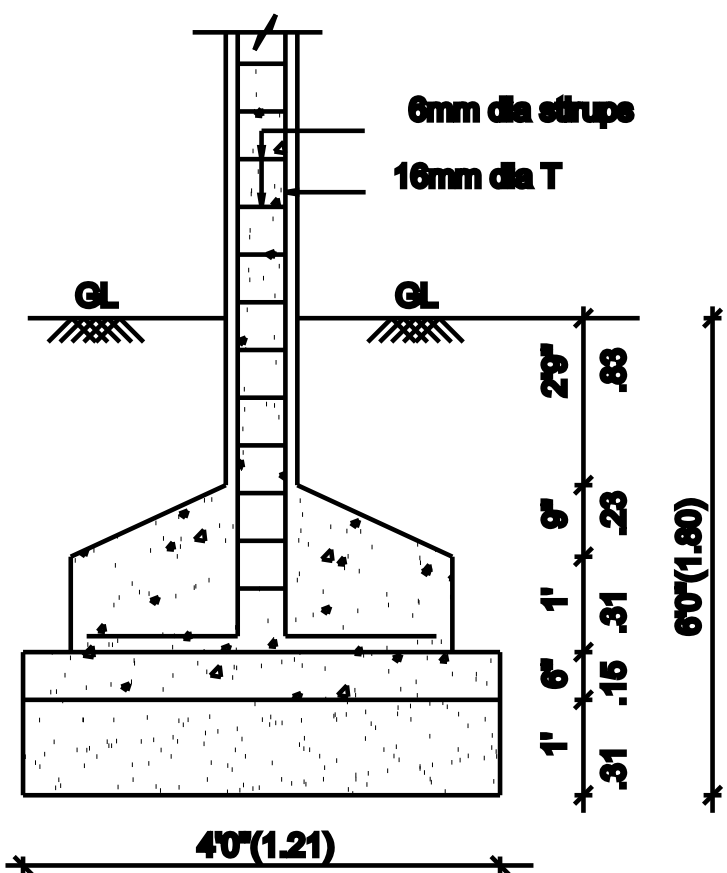


COLUMN FOUNDATION DETAIL


SCALE (1:50)

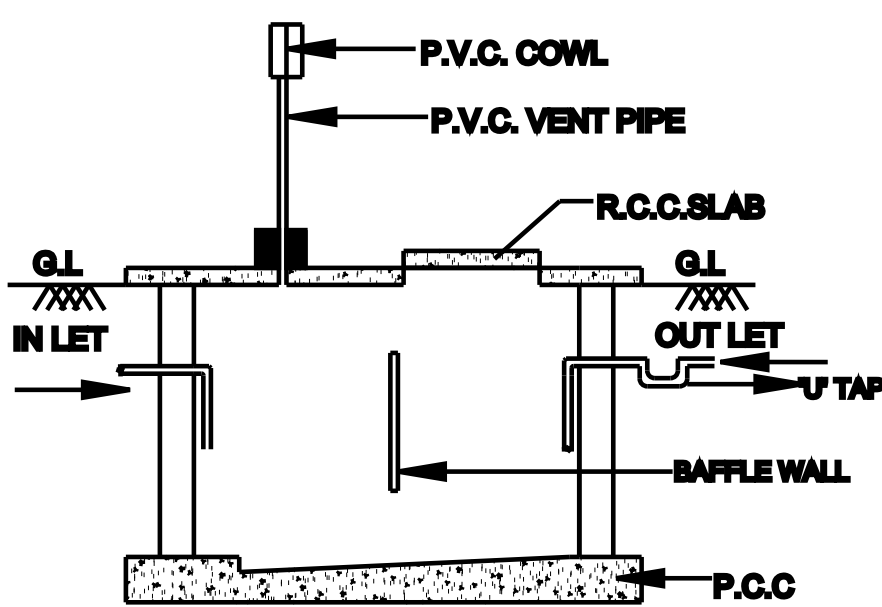


SEC. OF SEPTIC TANK

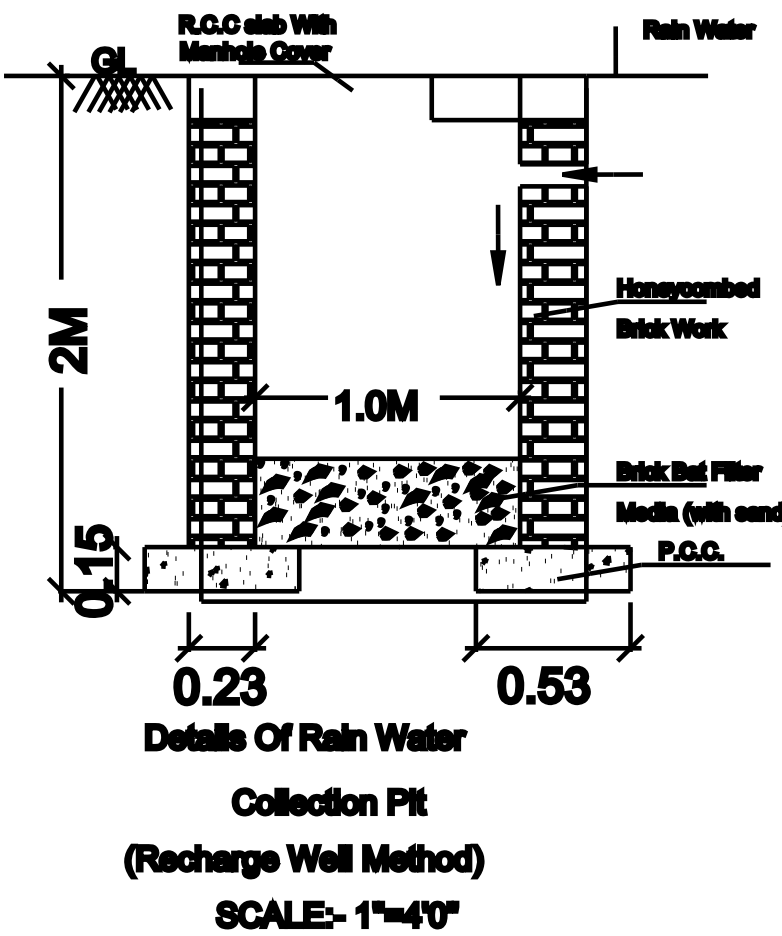


SCALE:- 1"=4'0"

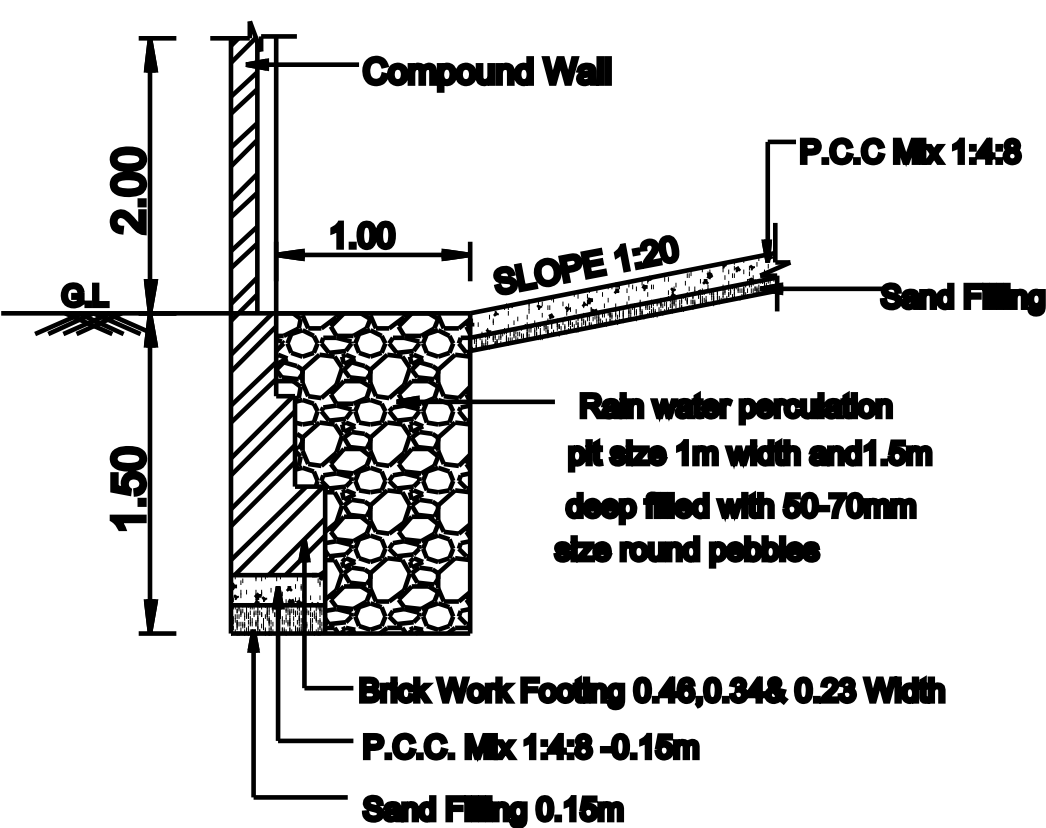

RAINWATER HARVESTING TRENCH

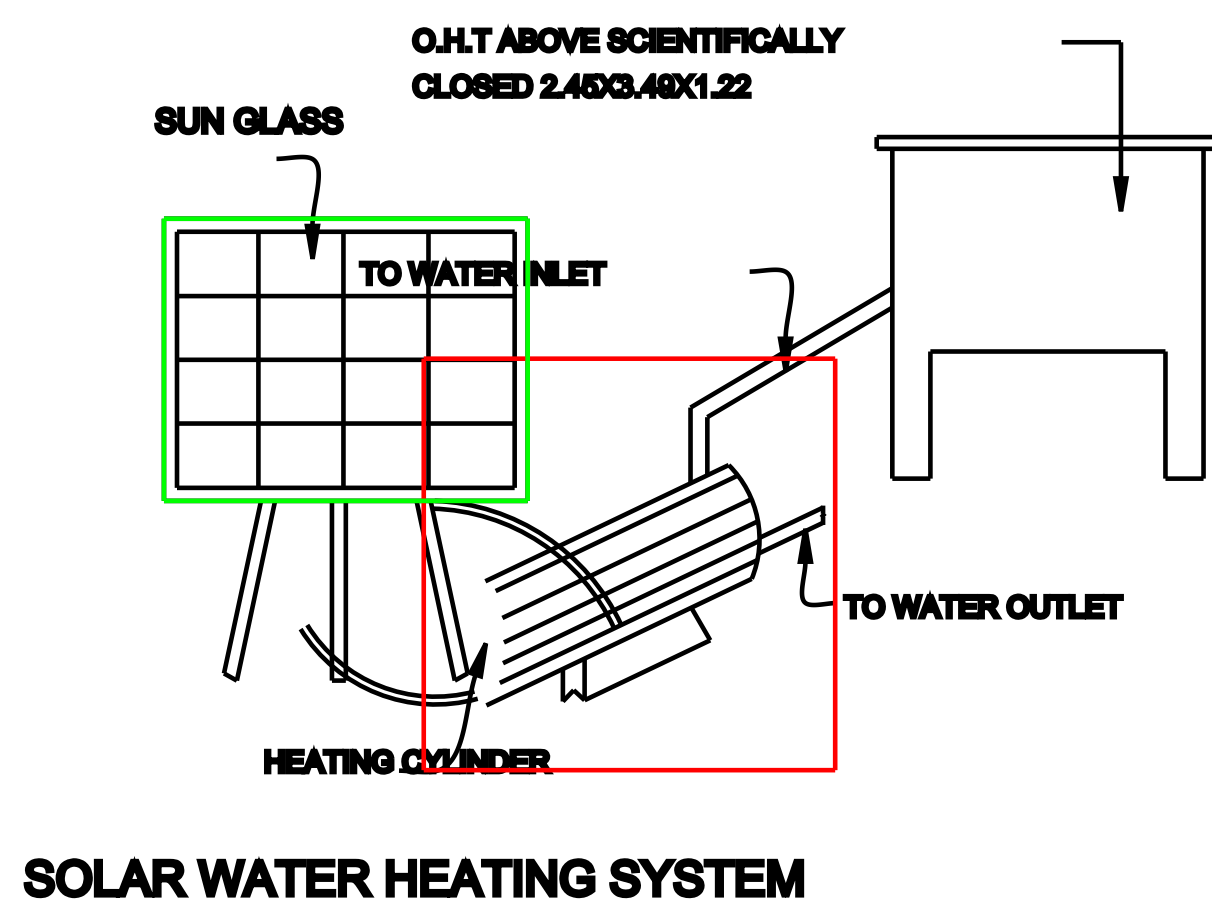


SOLAR WATER HEATING SYSTEM

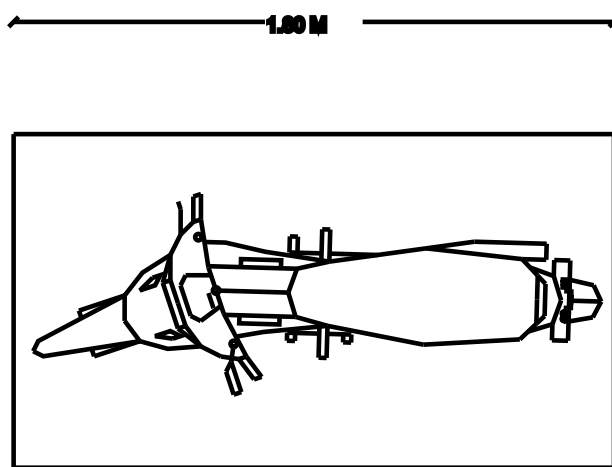

PARKING REQUIRED

NO.OF CAR POCKETS - 1 Nos

NO.OF BIKE POCKETS - 2 Nos

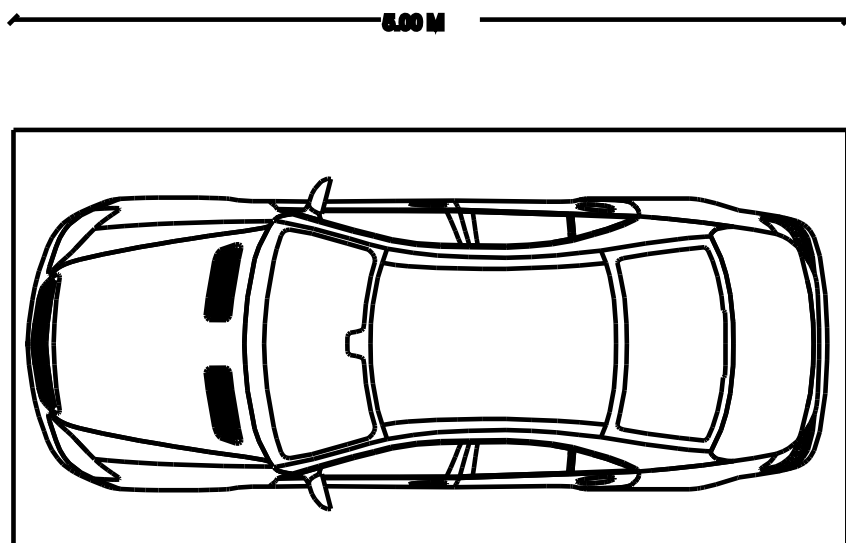

PARKING PROVIDED

NO.OF CAR POCKETS - 1 Nos

NO.OF BIKE POCKETS - 2 Nos