



PLAN SHOWING THE PROPOSED ADDITIONAL CONSTRUCTION OF FIRST FLOOR R.C.C. ROOF RESIDENTIAL BUILDING IN S.F.NO.38/4A1A1, PATT


NO.3040 AT VALAJANAGARAM VILAGE AND PANCHAYAT OF ARIYALUR TALUK & DISTRICT. (SCALE 1:100)

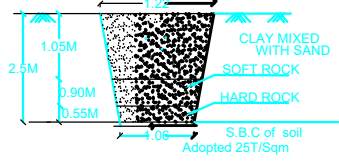


TRIAL PIT DETAILS

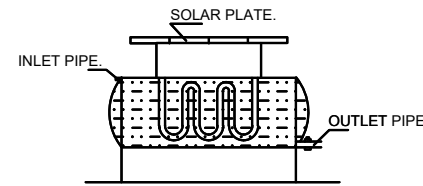


SOLAR WATER HEATER

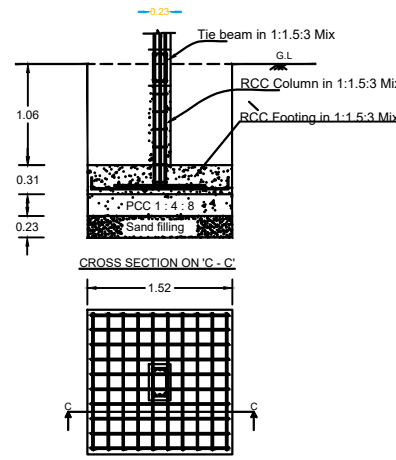

COLOUMN FOUNDATION

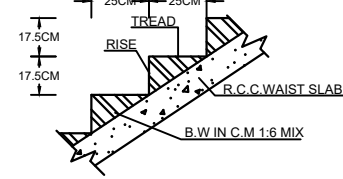

SECTION OF STAIRCASE

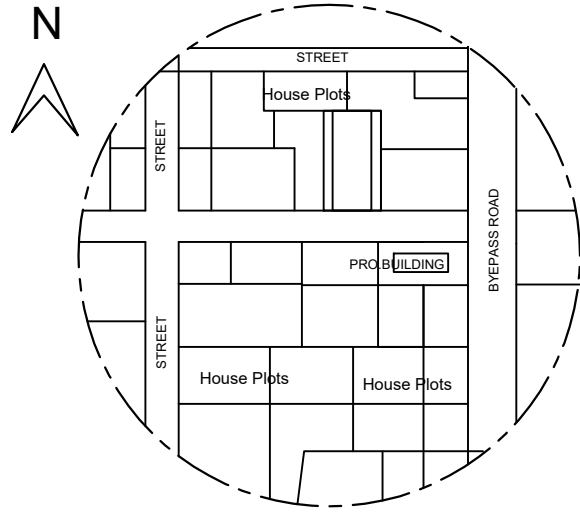

TOPO PLAN

APPRC



- SULLAGE WASTE FROM TOILET WILL BE CONNECTED INTO STP.
- BORE WELL WITH MOTAR WATER TANK AND CORPORATION WATER SUPPLY
- RAIN WATER PERCOLATION PIT PROVIDED @1/30 Sqm OF PLINTH AREA@6M C/C
- RAIN WATER PERCOLATION BED 1.0m WIDE WILL BE PROVIDED AROUND THE BUILDING AS PER GO (MS) NO: 138 DATED 11-10-02.
- RAIN WATER TAKEN TO THE BORE WELL THROUGH 150MM DIA PIPES.
- RAIN WATER COLLECTED FROM OPEN TERRACE SHALL BE COLLECTED THROUGH PIPES AND LED INTO A FILTER PIT (SIZE 60 X 60 X 60 CM) WITH APPROPRIATE FILTER MATERIAL AND THEN LED INTO COLLECTION TANK.
- SOLAR WATER HEATER LINE ARRANGEMENTS WILL BE PROVIDED.
- ALL DIMENSIONS ARE IN METRE & FEET.
- FE - FIRE EXTINGUISHER PROVIDED.

SCHEDULE OF JOINERIES

TYPE	REFERENCE	SIZE IN METER
MD	MAIN DOOR	1.06 x 2.13
D	FLUSH DOOR	1.00 x 2.13
D1	FLUSH DOOR	0.76 x 2.13
D2	FLUSH DOOR	1.00 x 1.98
O	OPEN	1.00 x 2.13
W1	WINDOW	1.53 x 1.52
W2	WINDOW	1.22 x 1.52
W3	WINDOW	0.91 x 1.52
KW	KITCHEN WINDOW	1.53 x 1.22
V	VENTILATOR	0.91 x 0.76
J	JALLY	0.91 x 1.83

AREA DETAILS

<u>DESCRIPTION</u>		<u>SQ.M</u>
PLOT AREA (AS PPER DOCUMENT)		278.68
PLOT AREA (AS PER FMB)		278.68
SUPER IMPOSED PLOT AREA		278.68
<u>DESCRIPTION</u>	<u>AREA (IN SQ.M)</u>	<u>AREA (IN SQ.FT)</u>
<u>PROPOSED BUILDING PLINTH AREA</u>		
EX. GROUND FLOOR AREA	171.59	1846.99
PRO.FIRST FLOOR AREA	171.59	1846.99
TOTAL AREA	343.19	3693.98
OPEN SPACE AREA	107.09	1152.72

PLOT COVERAGE	=	$\frac{171.59}{278.68}$	X 100	=	61.53 %
F.S.I	=	$\frac{343.19}{278.68}$		=	1.23

PARKING

- TWO WHEELER PARKING SPACE 5 NOS PROVIDED.
- CAR PARKING SPACE 2 NOS PROVIDED.

NOTES:

- FIRE EXTINGUISHER ● FE
- ALL DIMENSION ARE IN METER
- SCALE - 1:100
- WASTE WATER UTILISED FOR GARDEN PURPOSE.
- SOLAR WATER HEATER PROVIDED IN TERRACE FLOOR.



A.S.A Constructions
Chinna Aranmanai Street, Ariyalur.
Mobile : 9443303157, 9943425641


APPLICANT

Mrs. THAMIZHARASI,
W/O. Mr. GANESAN.


ENGINEER

[Signature]


Er.D.SEETHA, M.E(Struct).,
LICENSED SURVEYOR NO:329
REGISTERED ENGINEER GRADE -1
RE/PLBR/APR 2019/014

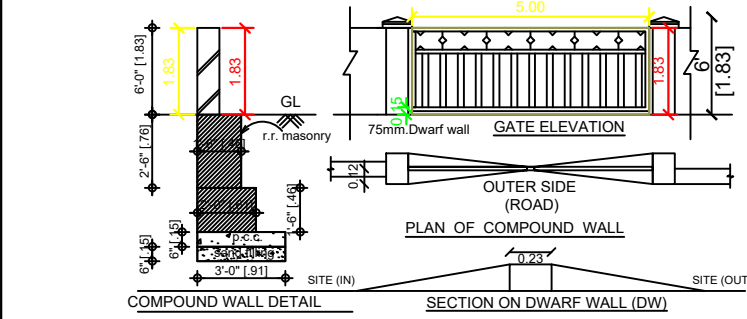


ELEVATION

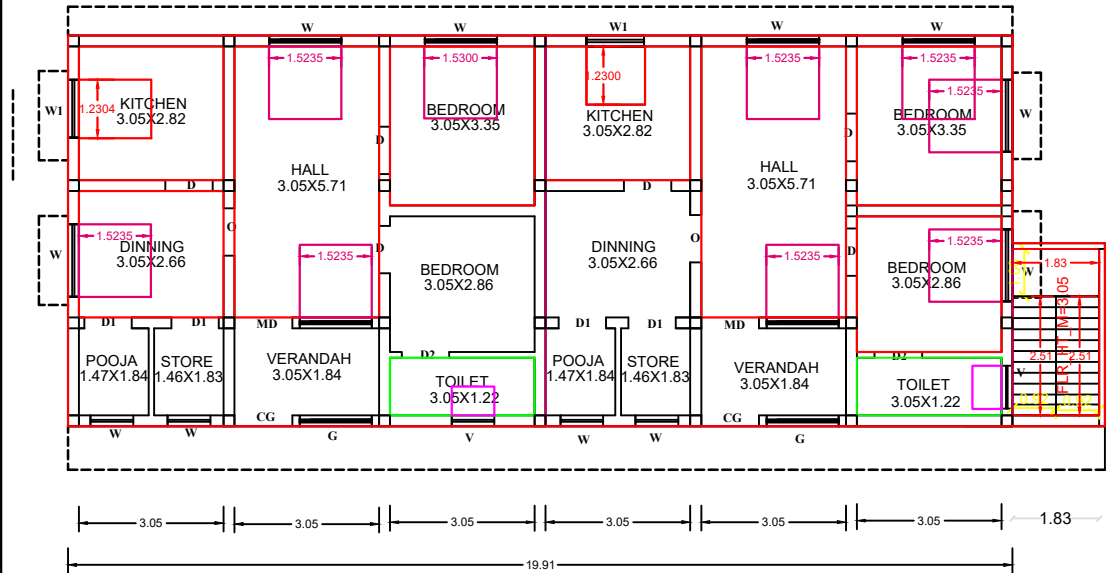


PRO. FIRST FLOOR PLAN

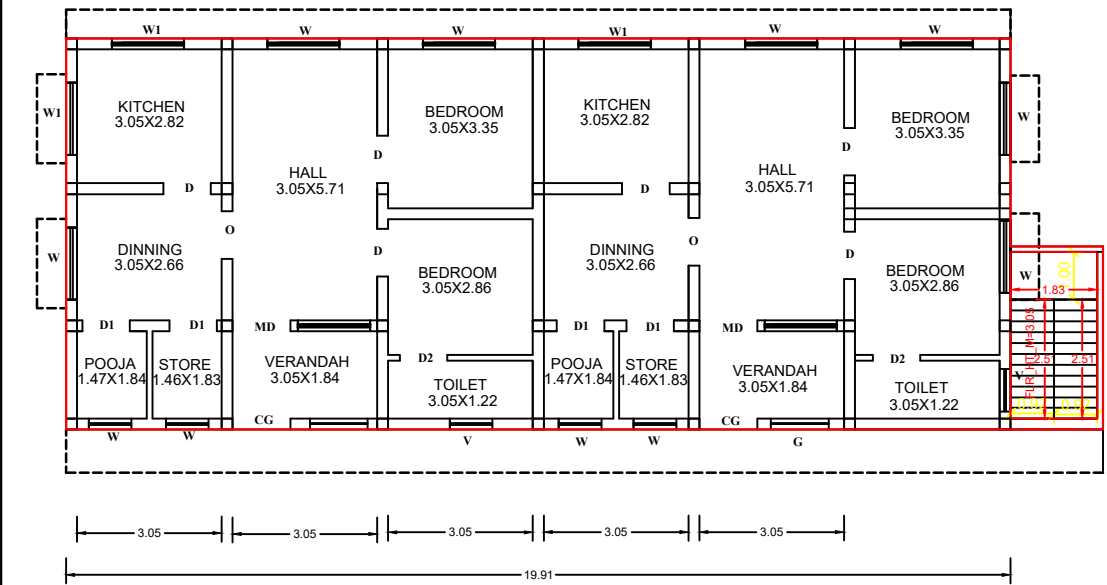


EX.GROUND FLOOR PLAN

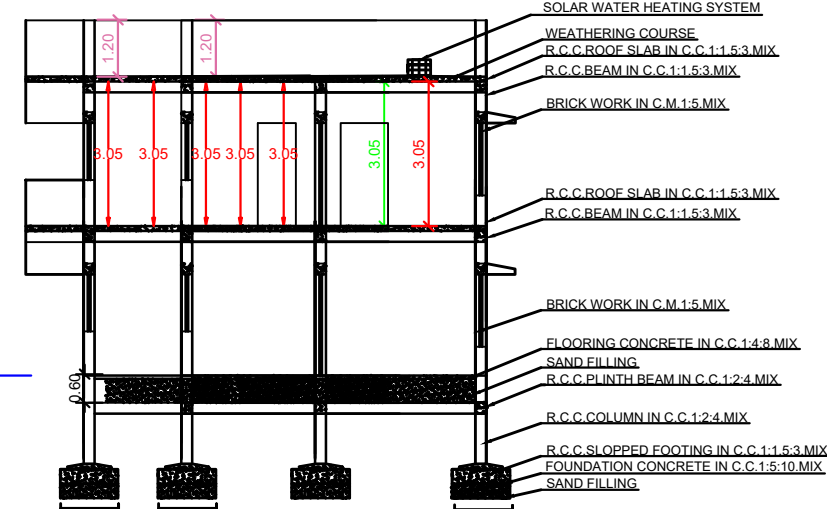


BORE WELL DETAIL

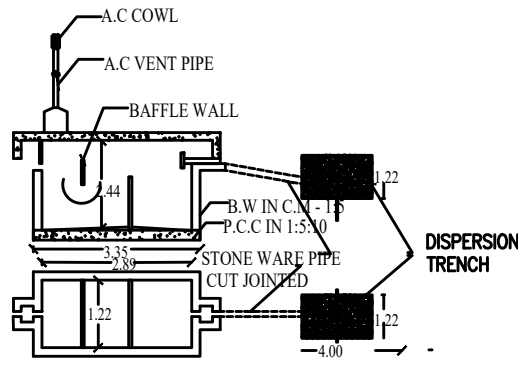


SEPTIC TANK DETAILS

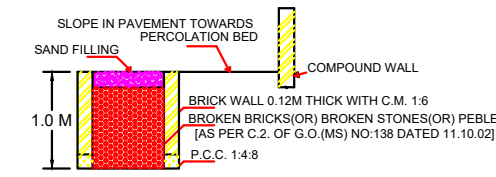

SECTION OF RAIN WATER PERCOLATION BED

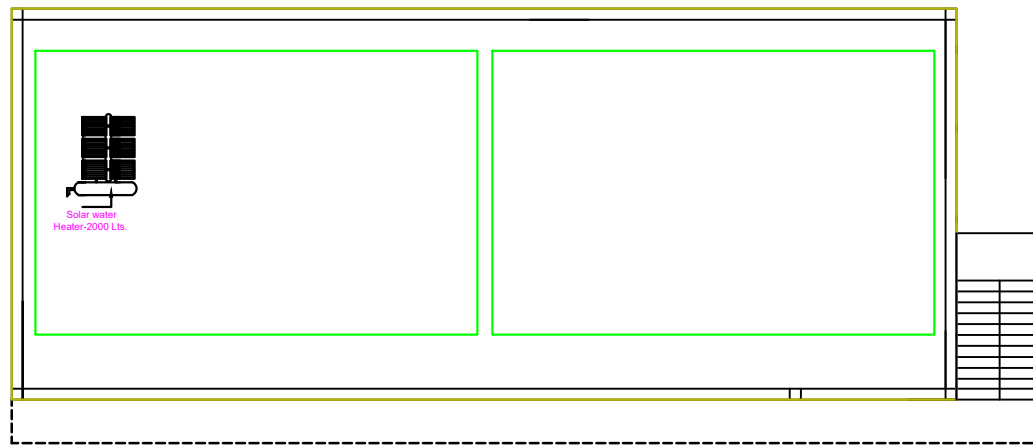

TERRACE FLOOR PLAN

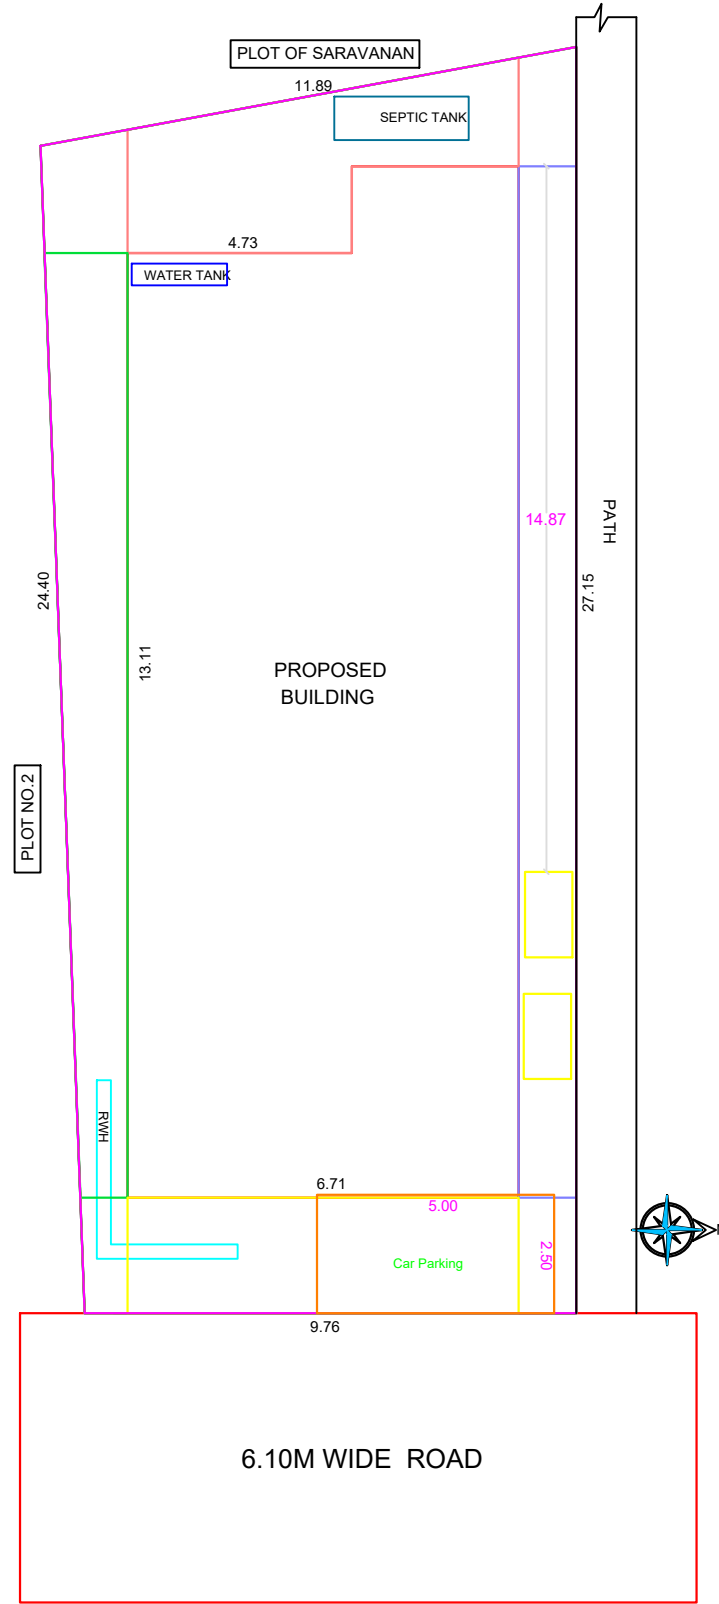

SITE PLAN