




PLAN SHOWING THE PROPOSED CONSTRUCTION OF GROUND & FIRST FLOOR RESIDENTIAL BUILDING IN SF.NO: 39/14,39/16 ,PATTA NO: 3941, KURUVADI VILLAGE & PANCHAYAT, AT ARIYALUR TALUK & DISTRICT.

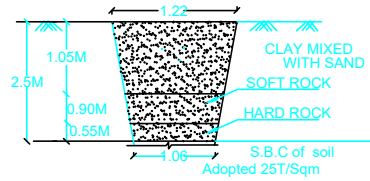


TRIAL PIT DETAILS

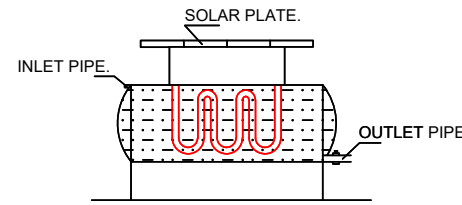


SOLAR WATER HEATER

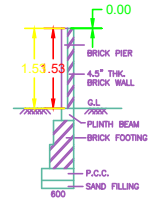


COMPOUND WALL DETAIL

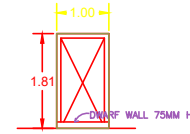



WIKET GATE ELEVATION

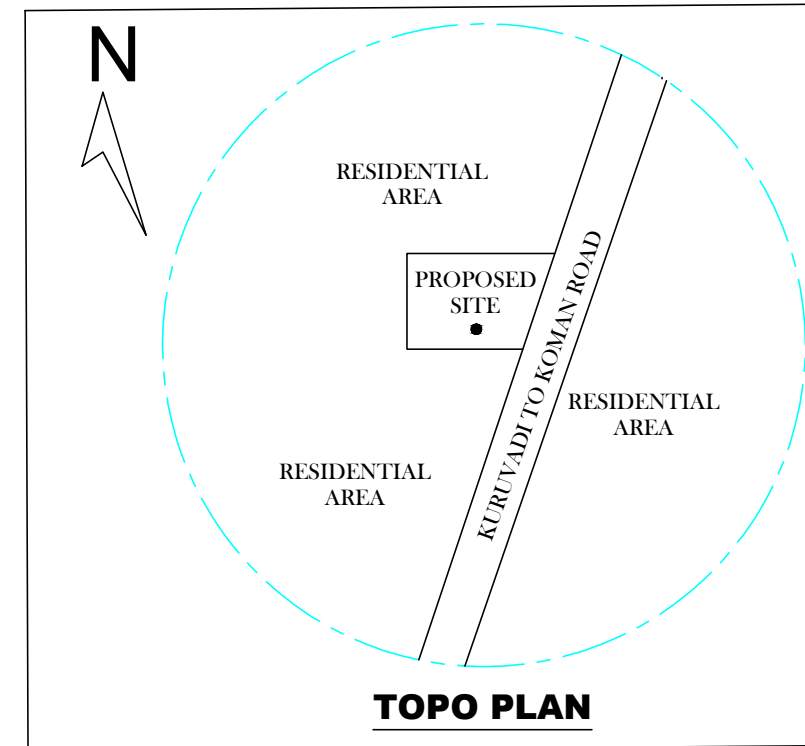


TOPO PLAN

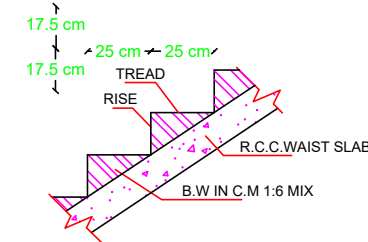

SECTION OF STAIRCASE

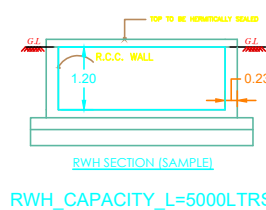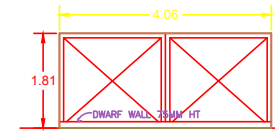
**RWH**

MAIN GATE ELEVATION

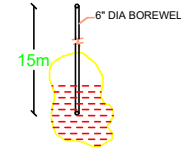


BORE WELL DETAIL


1. SULLAGE WASTE FROM TOILET WILL BE CONNECTED INTO STP.
2. BORE WELL WITH MOTAR WATER TANK AND CORPORATION WATER SUPPLY
3. RAIN WATER PERCOLATION PIT PROVIDED @1/30 Sqm OF PLINTH AREA@6M C/C
4. RAIN WATER TAKEN TO THE BORE WELL THROUGH 150MM DIA PIPES.
5. RAIN WATER COLLECTED FROM OPEN TERRACE SHALL BE COLLECTED THROUGH PIPES AND LED INTO A FILTER PIT (SIZE 60 X 60 X 60 CM) WITH APPROPRIATE FILTER MATERIAL AND THEN LED INTO COLLECTION TANK.
6. SOLAR WATER HEATER LINE ARRANGEMENTS WILL BE PROVIDED.
7. ALL DIMENSIONS ARE IN METRE & FEET.
8. FE - FIRE EXTINGUISHER PROVIDED.

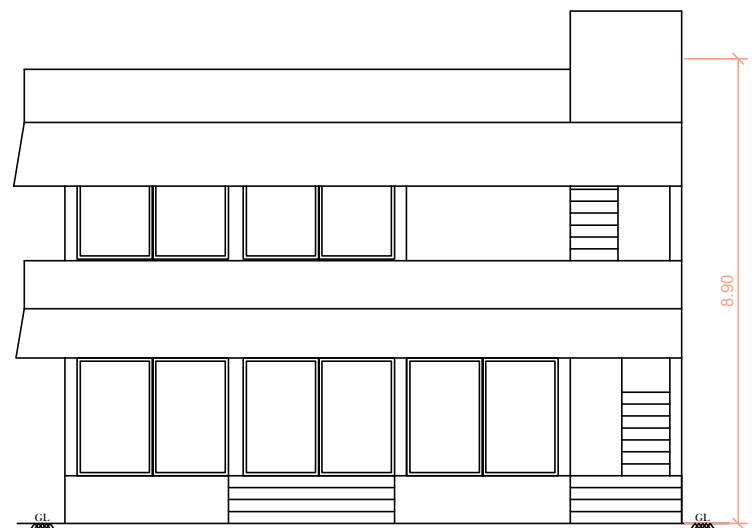


ELEVATION

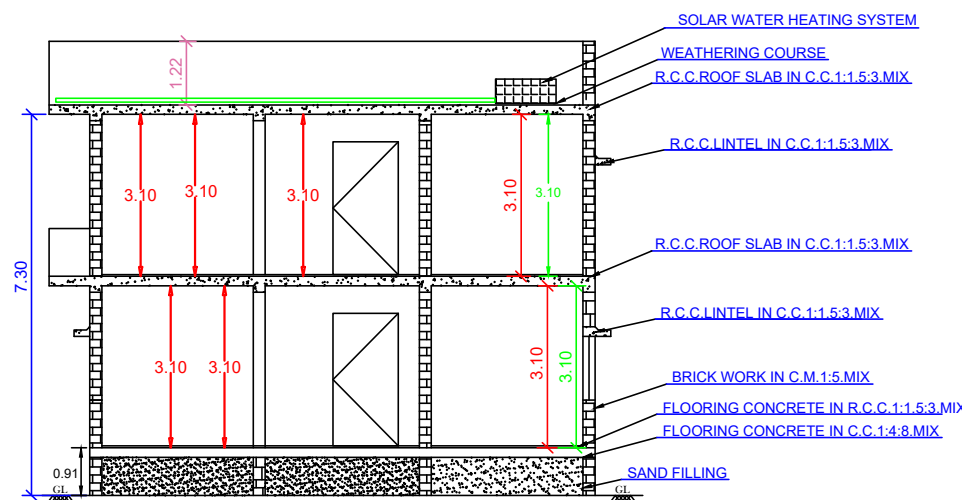


SECTION - AB

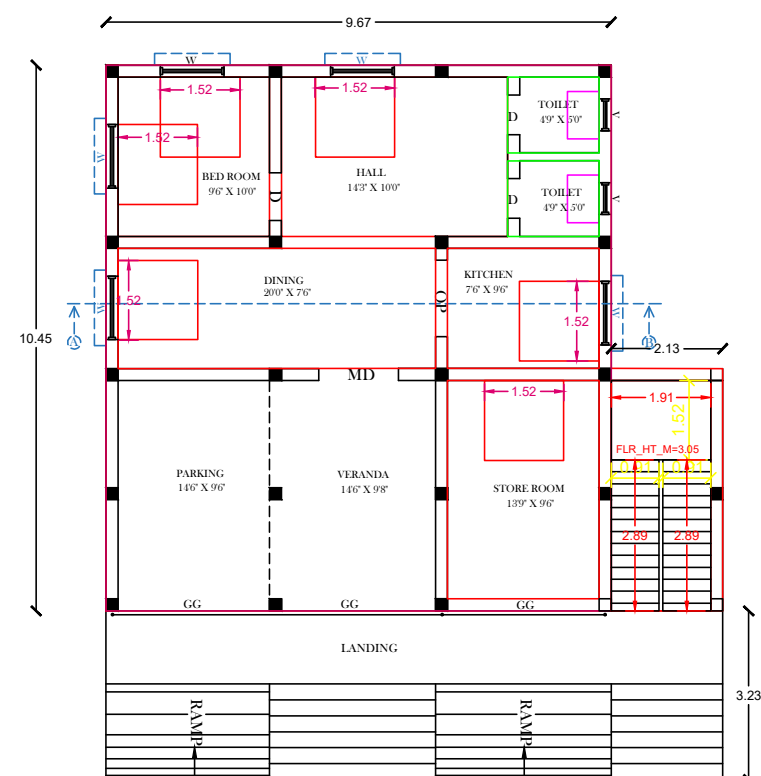

PROPOSED BUILDING GROUND FLOOR

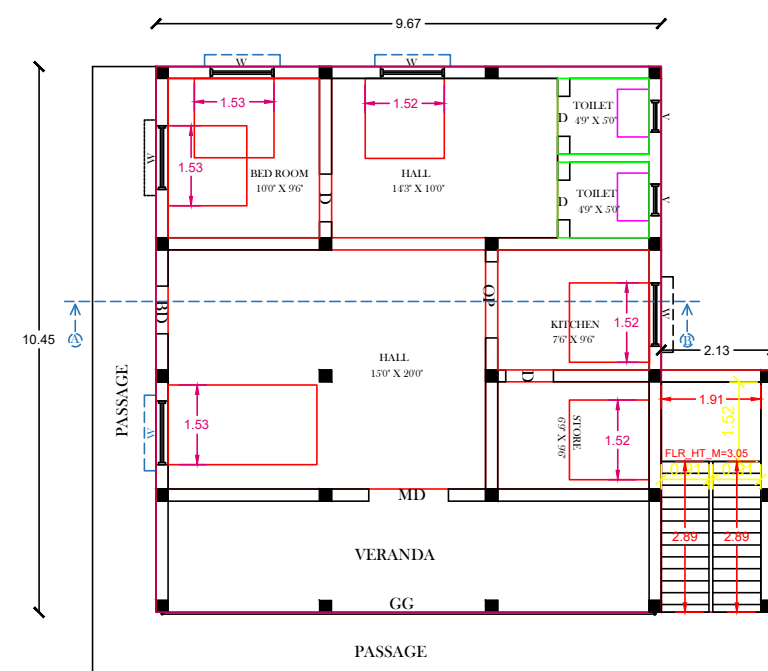

PROPOSED BUILDING FIRST FLOOR

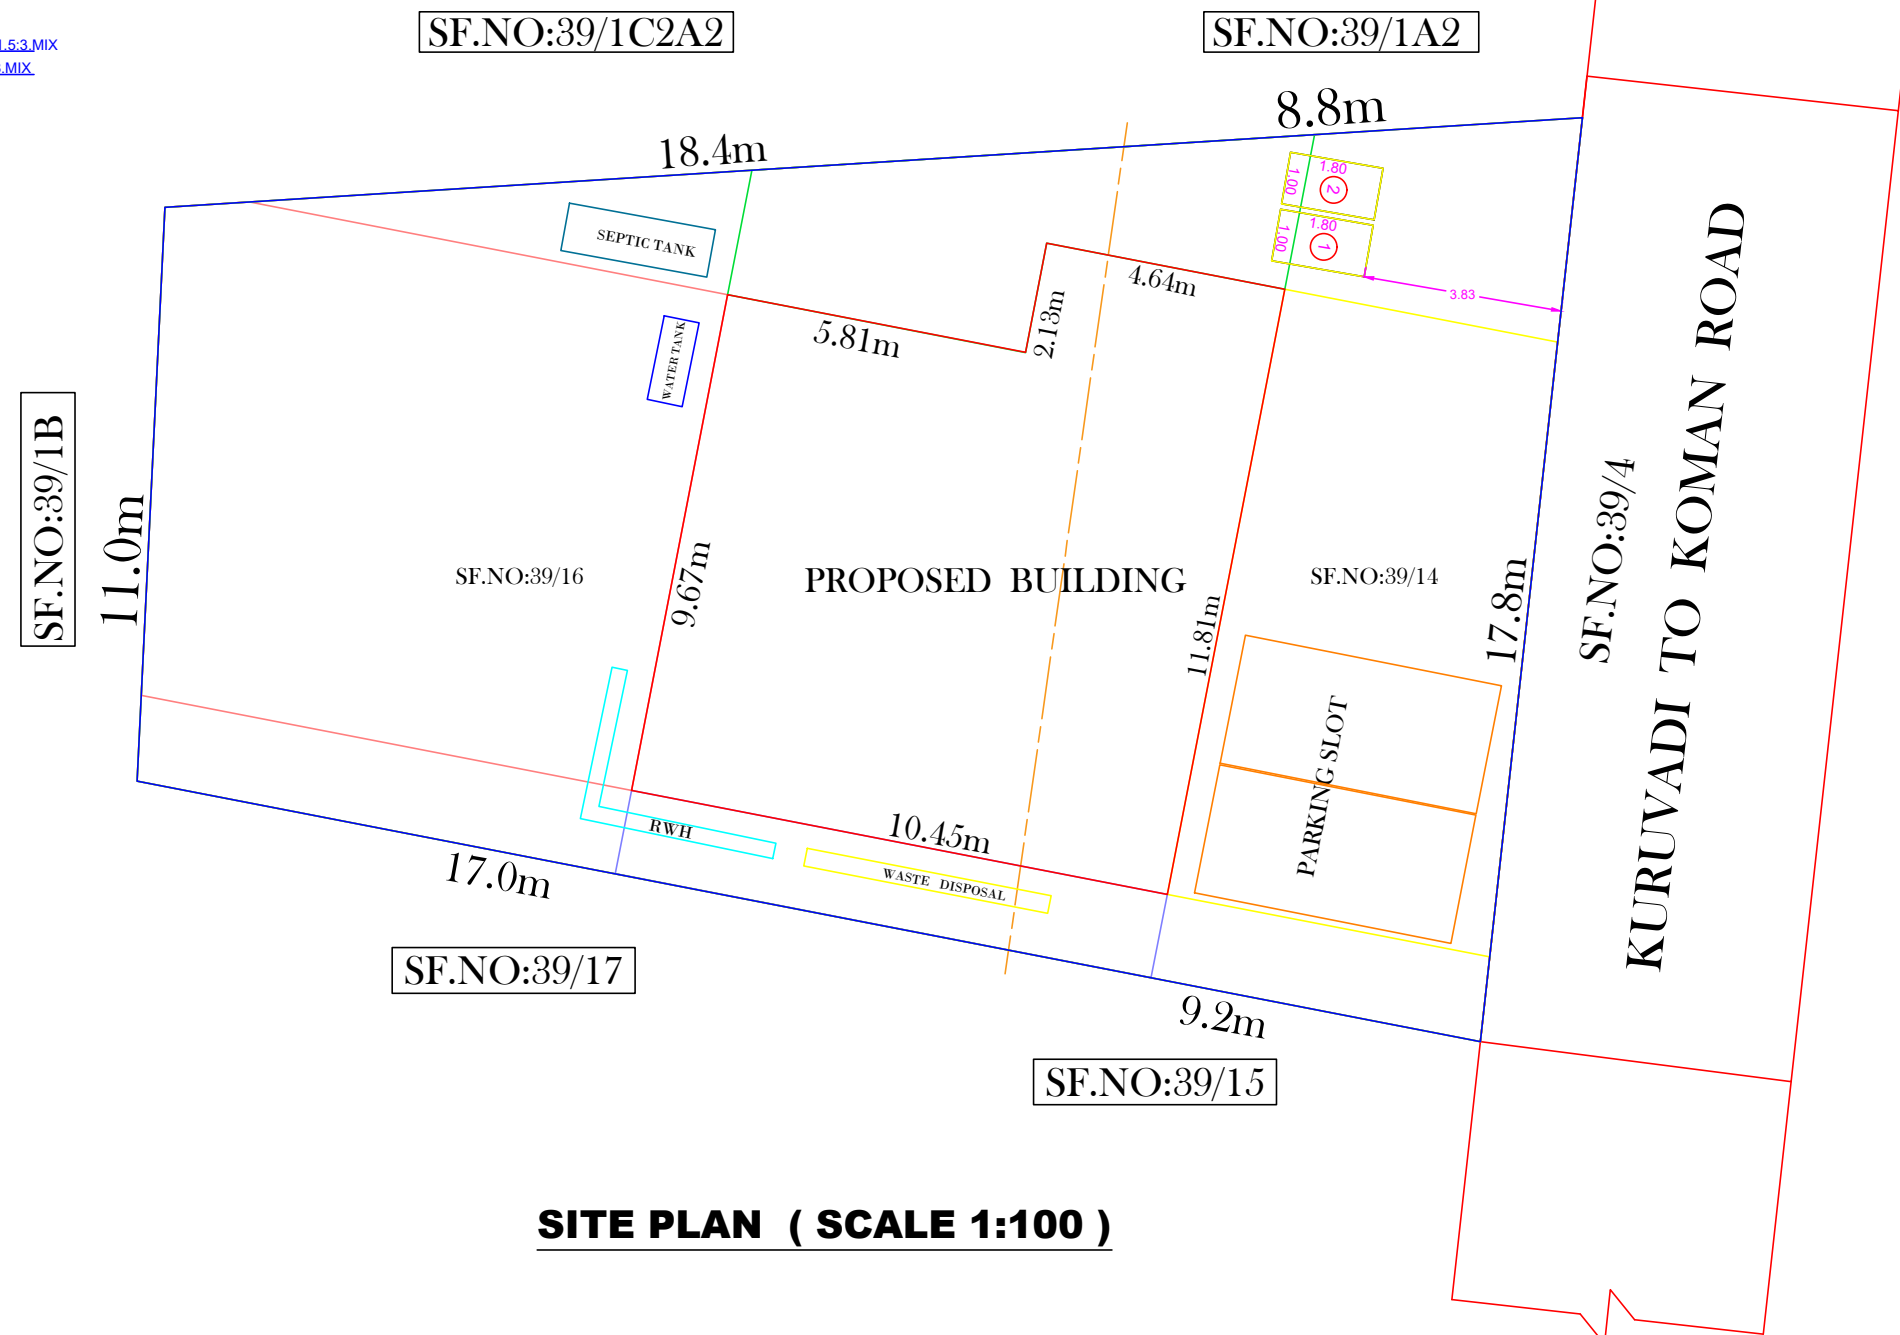

SITE PLAN (SCALE 1:100)



SIZE IN METER

1.06 x 2.13
1.00 x 2.13
0.76 x 2.13
1.00 x 1.98
1.00 x 2.13
1.53 x 1.52
1.22 x 1.52
0.91 x 1.52
1.53 x 1.22
0.91 x 0.76
0.91 x 1.83

V	VENTILATOR	0.91 x 0.76
J	JALLY	0.91 x 1.83

AREA DETAILS		
DESCRIPTION		SQ. M
PLOT AREA (AS PPER DOCUMENT)		381.10
PLOT AREA (AS PER FMB)		381.10
SUPER IMPOSED PLOT AREA		381.10
DESCRIPTION	AREA (IN SQ.M)	AREA (IN SQ. FT)
PROPOSED BUILDING PLINTH AREA		
GROUND FLOOR AREA	111.00	1194.80
FIRST FLOOR AREA	111.00	1194.80
TOTAL AREA	222.00	2389.60
OPEN SPACE AREA	270.10	2907.35

PLOT COVERAGE	=	$\frac{111.00}{381.10}$	X 100 =	29.12 %
F.S.I	=	$\frac{222.00}{381.10}$	=	0.58

PARKING

1. TWO WHEELER PARKING SPACE 5 NOS PROVIDED.
2. CAR PARKING SPACE 2 NOS PROVIDED.

NOTES:

1. FIRE EXTINGUISHER  FE
2. ALL DIMENSION ARE IN METER
3. SCALE - 1:100
4. WASTE WATER UTILISED FOR GARDEN PURPOSE.
5. SOLAR WATER HEATER PROVIDED IN TERRACE FLOOR.

APPROVING AUTHORITY:-

APPLICANT

RAJESH S/O RAJENDRAN

P. Rajesh.

ENGINEER

Er. A. ASHOK, DCE.,
DTPC REGISTERED ENGINEER
RE/PBLR/OCT2019/086
AS CONSTRUCTIONS
NEW MUNICIPALITY OFFICE(OPP)
ARIYALUR, Cell: 9360172160