



PLAN OF PROPOSED CONSTRUCTION OF RCC ROOF GROUND FLOOR
RESIDENTIAL BUILDING IN R.S NO.194/1 O 2, OLD SURVEY NO.194/1 O,
PATTA NO.3063 AT VADAKKU VELI, PAPPAKUDI NORTH VILLAGE, MELANIKULI
PANCHAYAT,UDAIYARPALAYAM TALUK, ARIYALUR DISTRICT,612903.

OWNER: Mr.C.VELMURUGAN S/O CHINNAYAN.

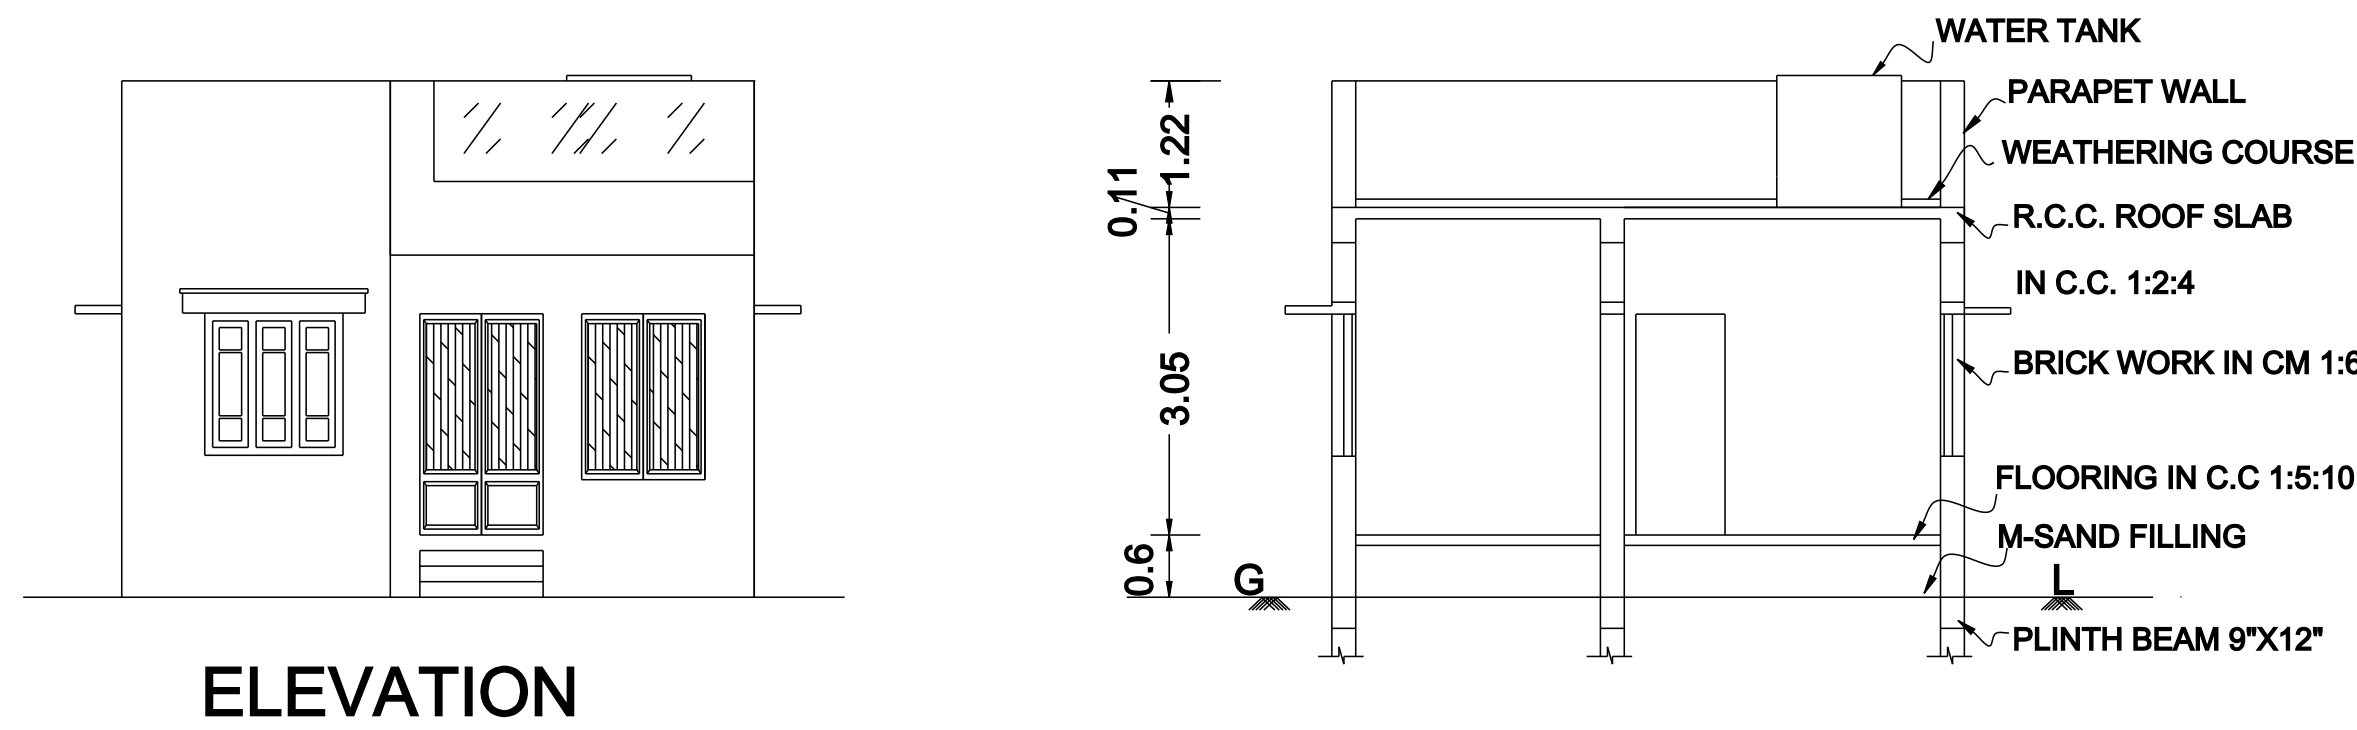


SECTION AT 'AB'

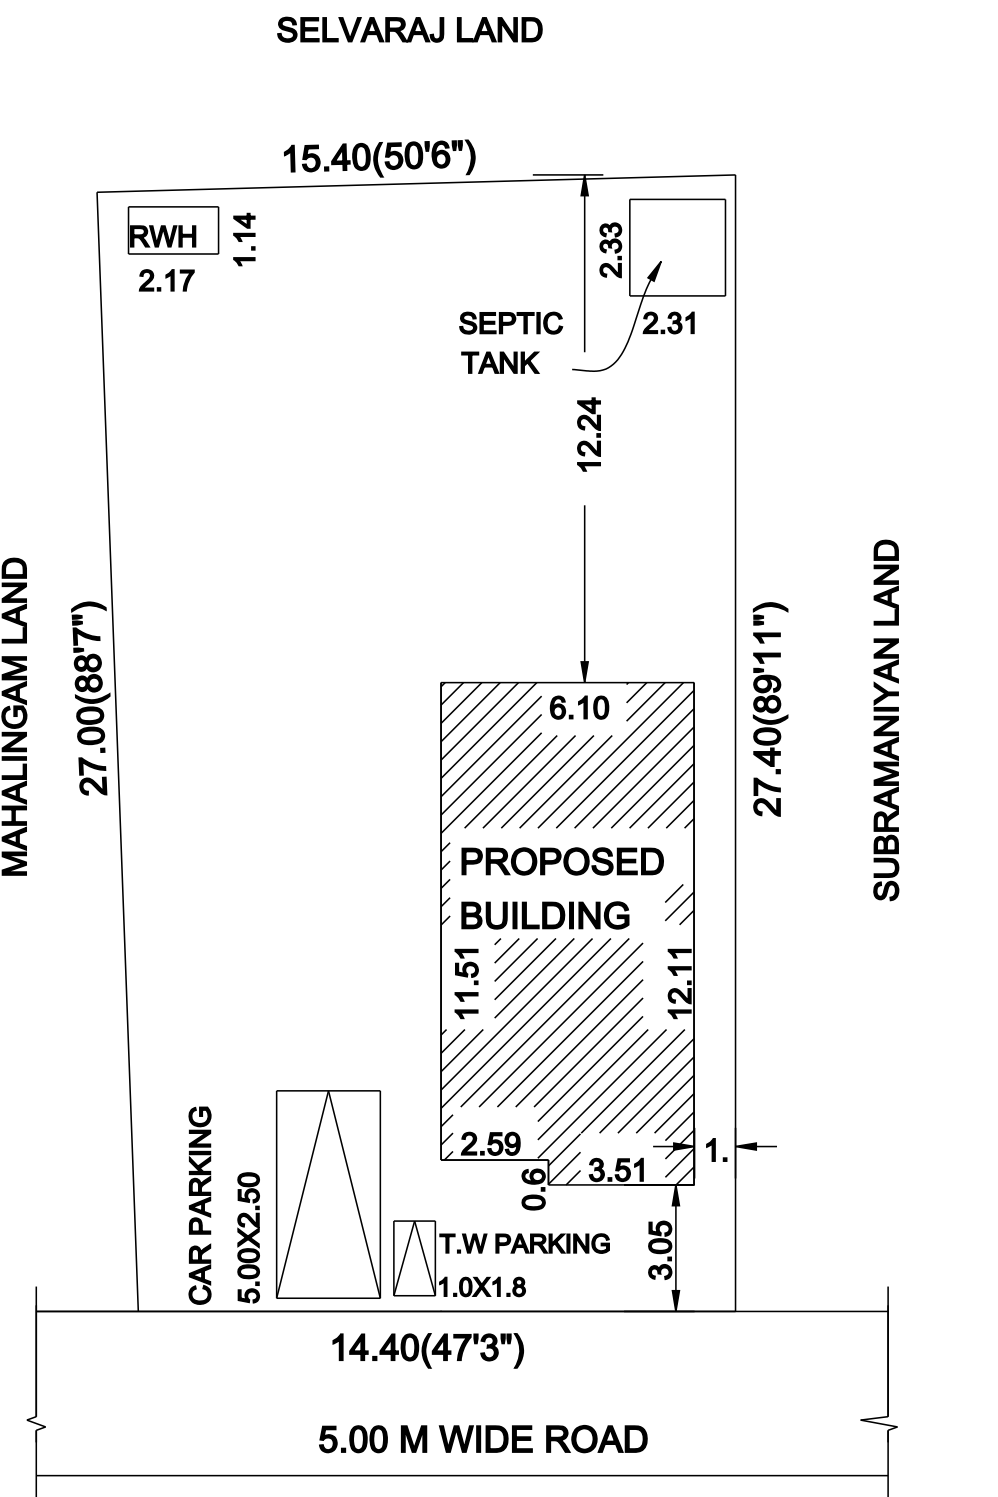


SITE PLAN

SCALE 1:400

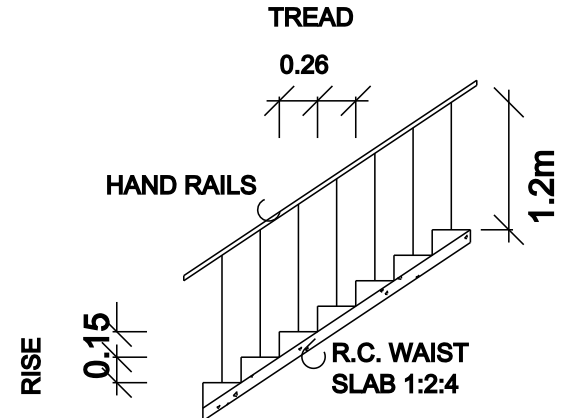


STAIRCASE

DETAILS

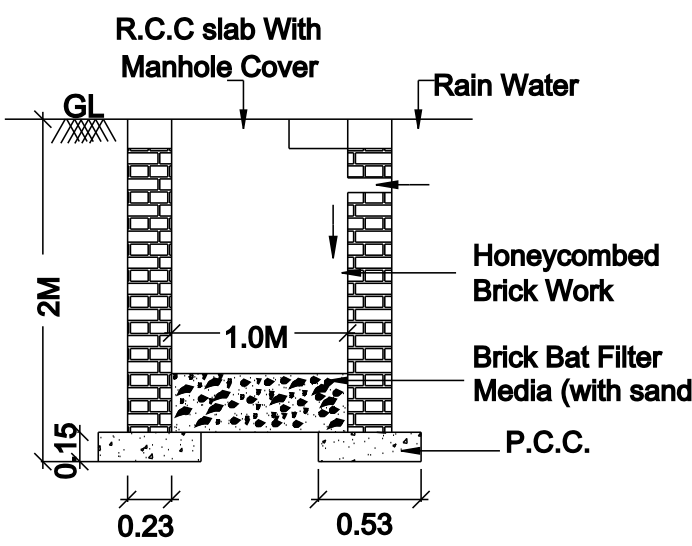


DETAILS OF RAIN
WATER COLLECTION PIT


SCALE:- 1"=4'0"

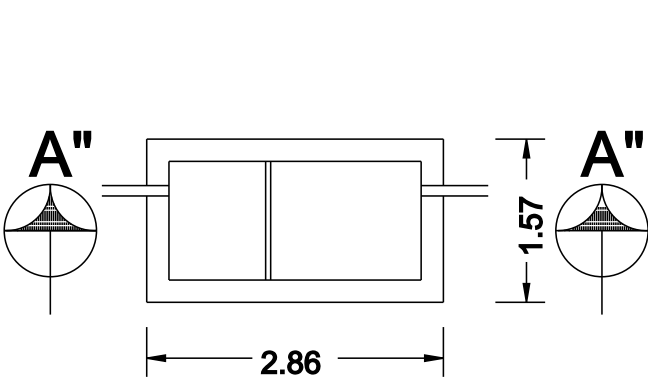


PLAN OF
SEPTIC TANK

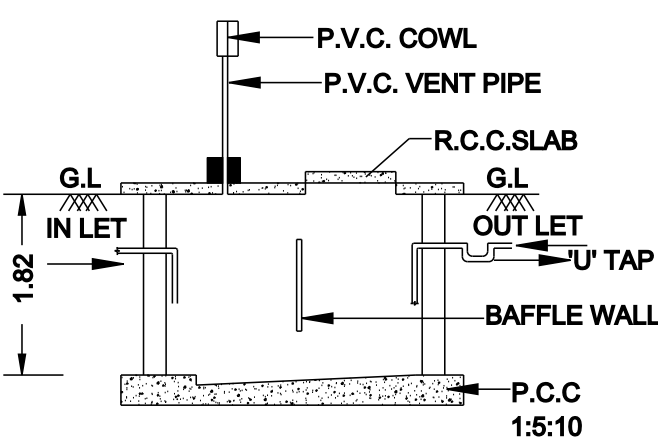

SEC. OF SEPTIC
TANK"AA"

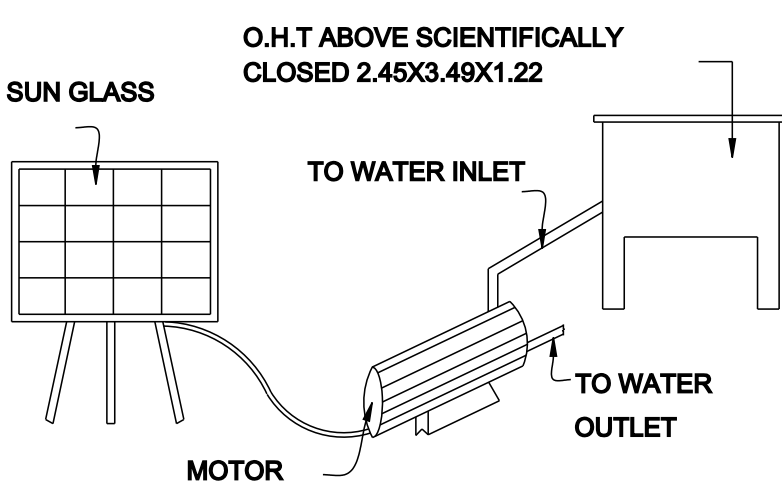

SOLAR WATER
HEATING SYSTEM

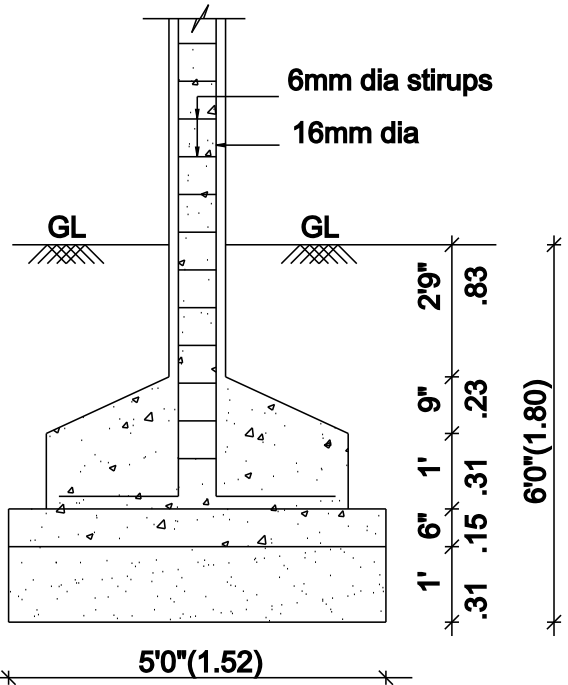


FOUNDATION
DETAIL

SCALE (1:50)

TOPO PLAN

NOT TO SCALE

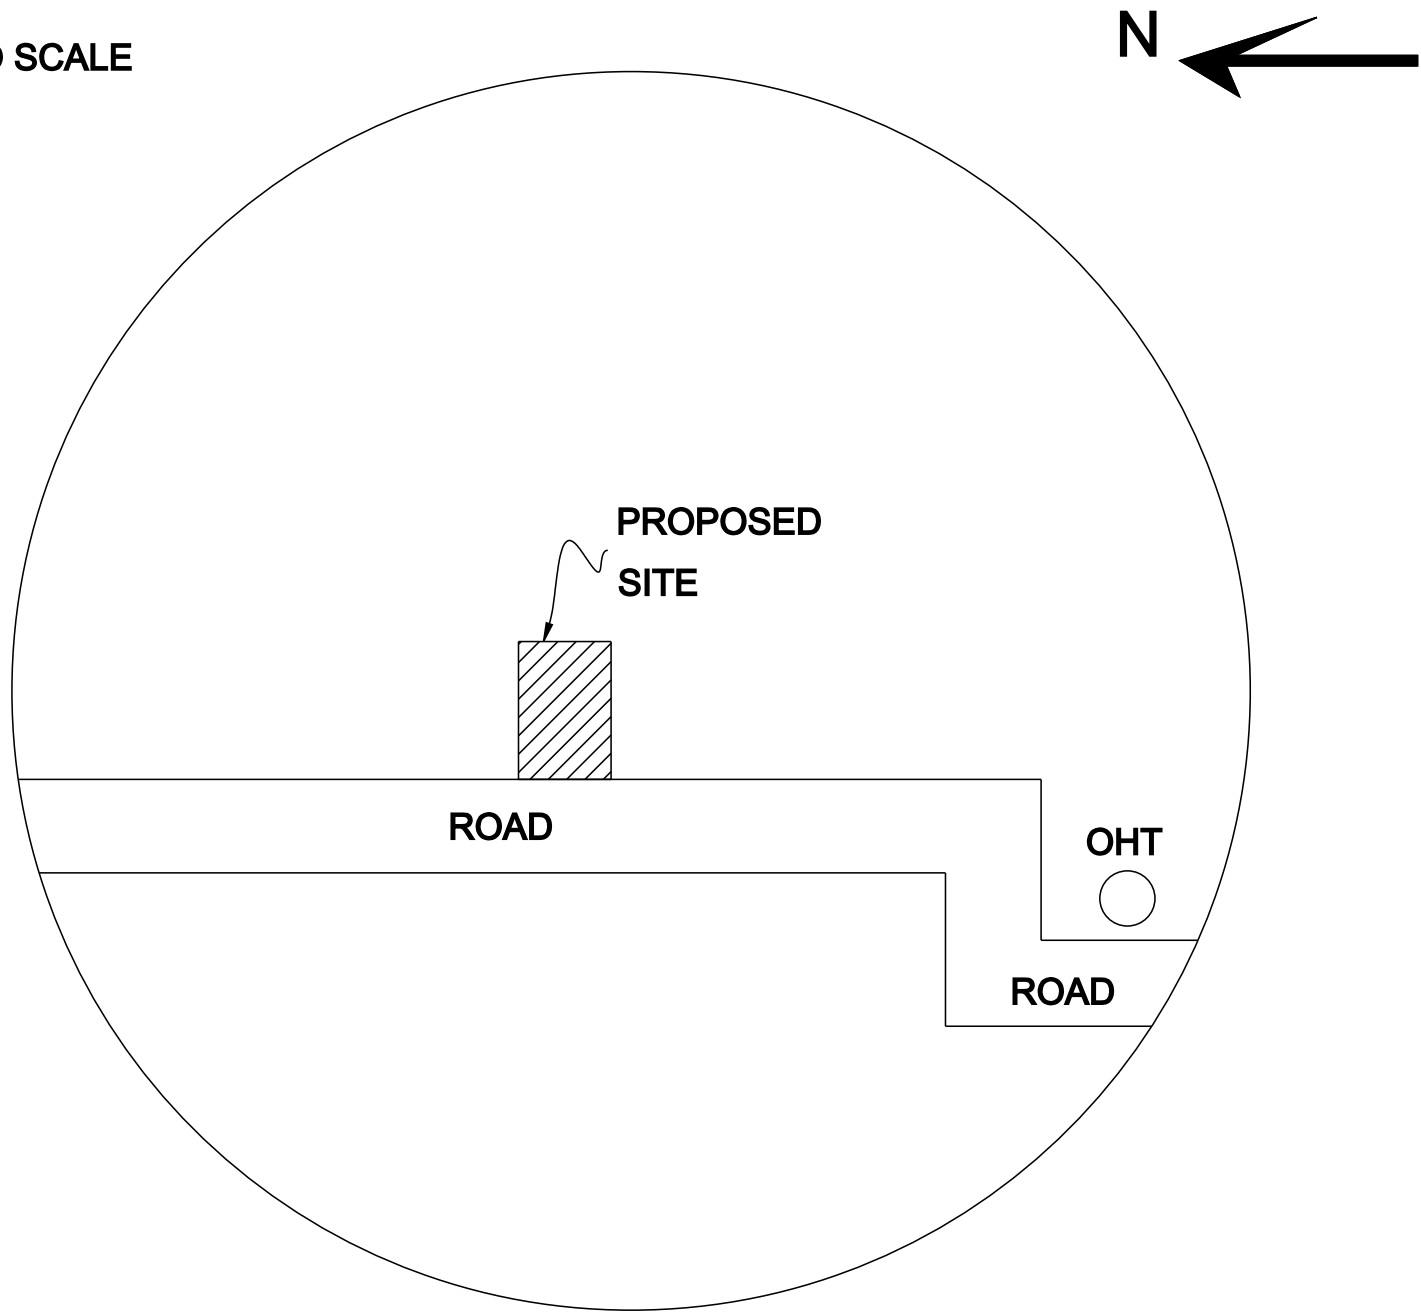

SCALE - 1:100
ALL DIMENSIONS AREA IN METER

AREA STATEMENT	AREA IN Sq.ft	AREA IN Sq.m
SITE EXTENT AS PER DOCUMENT	4360.00	405.05
SITE EXTENT AS PER FMB/PLR	4361.25	405.17
SITE EXTENT AS PER PATTA	4359.42	405.00
SITE EXTENT AS PER SITE	4361.25	405.17
PLINTH AREA:PROPOSED GROUND FLOOR	778.45	72.32
TOTAL BUILT UP AREA	778.45	72.32
TOTAL CARPET AREA	690.51	64.15
OPEN AREA	3581.55	332.73

FLOOR SPACE INDEX :0.178 PLOT COVERAGE:17.86%

SCHEDULE OF JOINERIES

TYPE	DESCRIPTION	SIZE IN M
MD	MAIN DOOR	1.22 X 2.13
D	DOOR	0.91 X 2.13
D1	DOOR	0.76 X 2.13
W	WINDOW	1.22 X 1.37
W1	WINDOW	1.22 X 0.90
V	VENTILATOR	0.90 X 0.80

COLOUR CODE :

BUILDING	
ROAD	
BOUNDARY	

STAIR DETAILS

WIDTH	- 3'0"(0.91)
TREAD	- 10.25"(0.26)
RISE	- 6"(0.15)

OWNER / APPLICANT :

C. Velmurugan
(VELMURUGAN)

REGISTERED ENGINEER

Er.A.GANAPATHY, B.TECH, F.I.I.V.C.Engg.,
Govt. Registered Engineer (RE/Gr.III/005/2022),
Chartered Engineer (M - 110749/15),
Approved Valuer (CAT - I - F - 6977),
4,Muthu Vinayagar Street, Periyar Nagar,
Kattumannarkoil, Cuddalore District - 608 301,
Mobile : 9443576912, 9976964704
Mail : ganapathy.a9@gmail.com.

Er.A.GANAPATHY, B.TECH, F.I.I.V.C.Engg.,
Govt. Registered Engineer (RE/Gr.III/005/2022),
Chartered Engineer (M-110749/15),
Approved Valuer (CAT-I-F-6977),
4,Muthu Vinayagar Street, Periyar Nagar,
KATTUMANNARKOIL, 9443576912 / 9976964704