
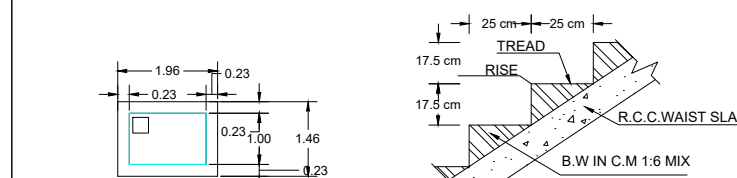


APPROVING AUTHORITY


PLAN SHOWING THE PROPOSED CONSTRUCTION OF G+1 R.C.C. ROOF COMMERCIAL CUM RESIDENTIAL BUILDING IN S.F.NO.358/25B, PATTA NO.460, OF VIKRAMANGALAM VILLAGE AND AMBAPUR PANCHAYATH,UDAYARPALAYAM TALUK AND ARIYALUR DISTRICT.

(SCALE 1:100)

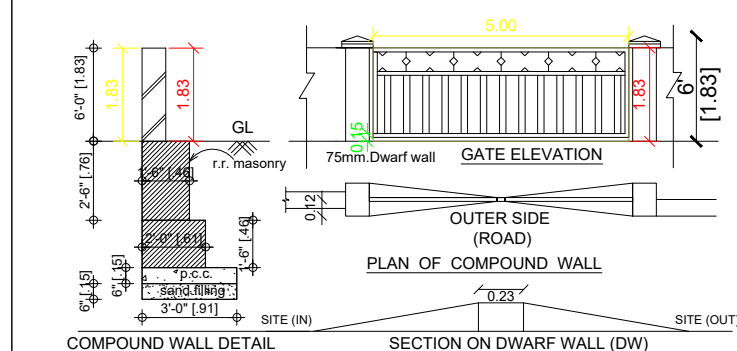


PLAN
RWHT CAPACITY L=5000LTRS
DETAILS OF COLLECTION SUMP FOR RAIN
WATER HARVESTING OF ROOF TOP RAIN WATER

SECTION OF STAIRCASE

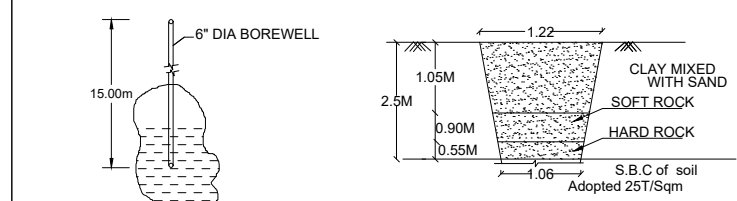


BORE WELL DETAIL

TRIAL PIT DETAILS


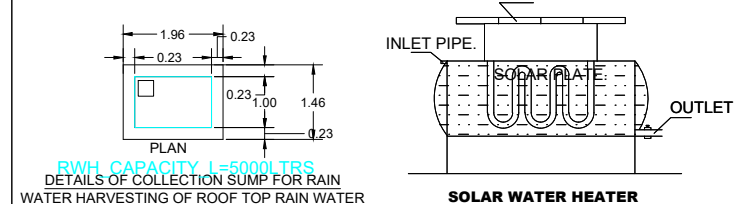


DETAILS OF COLLECTION SUMP FOR RAIN
WATER HARVESTING OF ROOF TOP RAIN WATER

SOLAR WATER HEATER

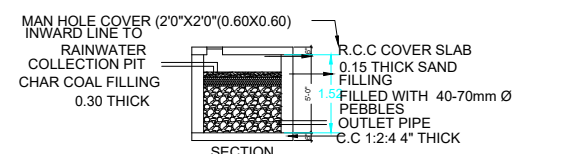


SECTION OF RAIN WATER PERCOLATION BED

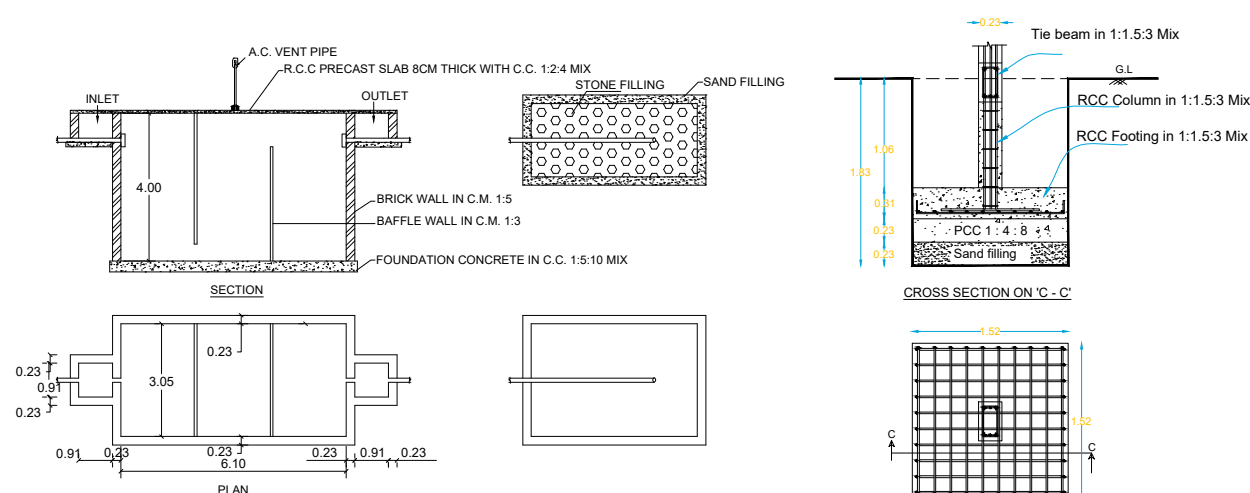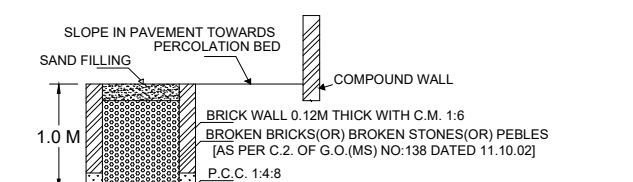


PLAN & SECTION OF SEPTIC TANK & DISPERSION TRENCH

COLOUMN FOUNDATION DETAILS

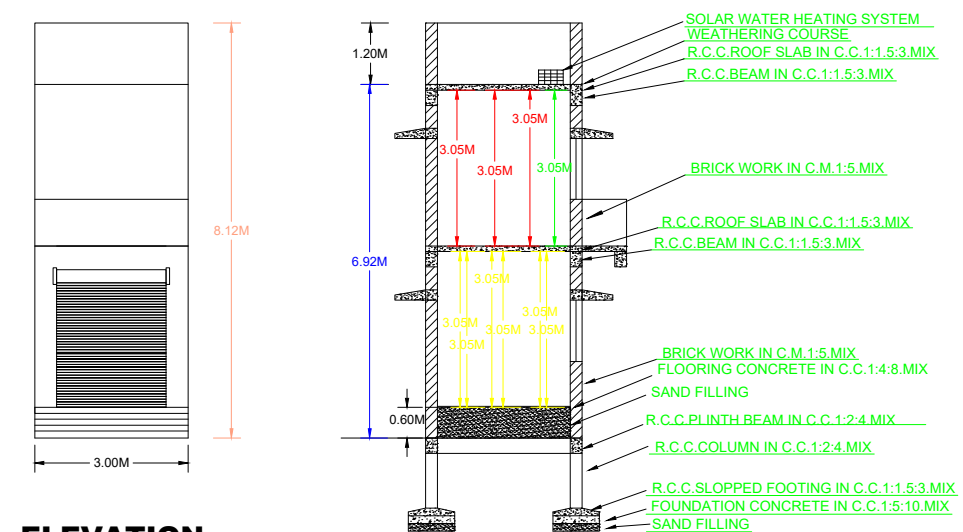


ELEVATION

SECTION ON 'AA'

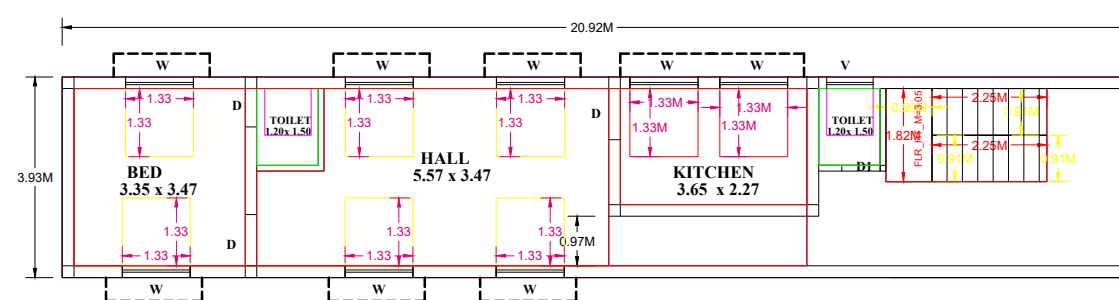



FIRST FLOOR PLAN

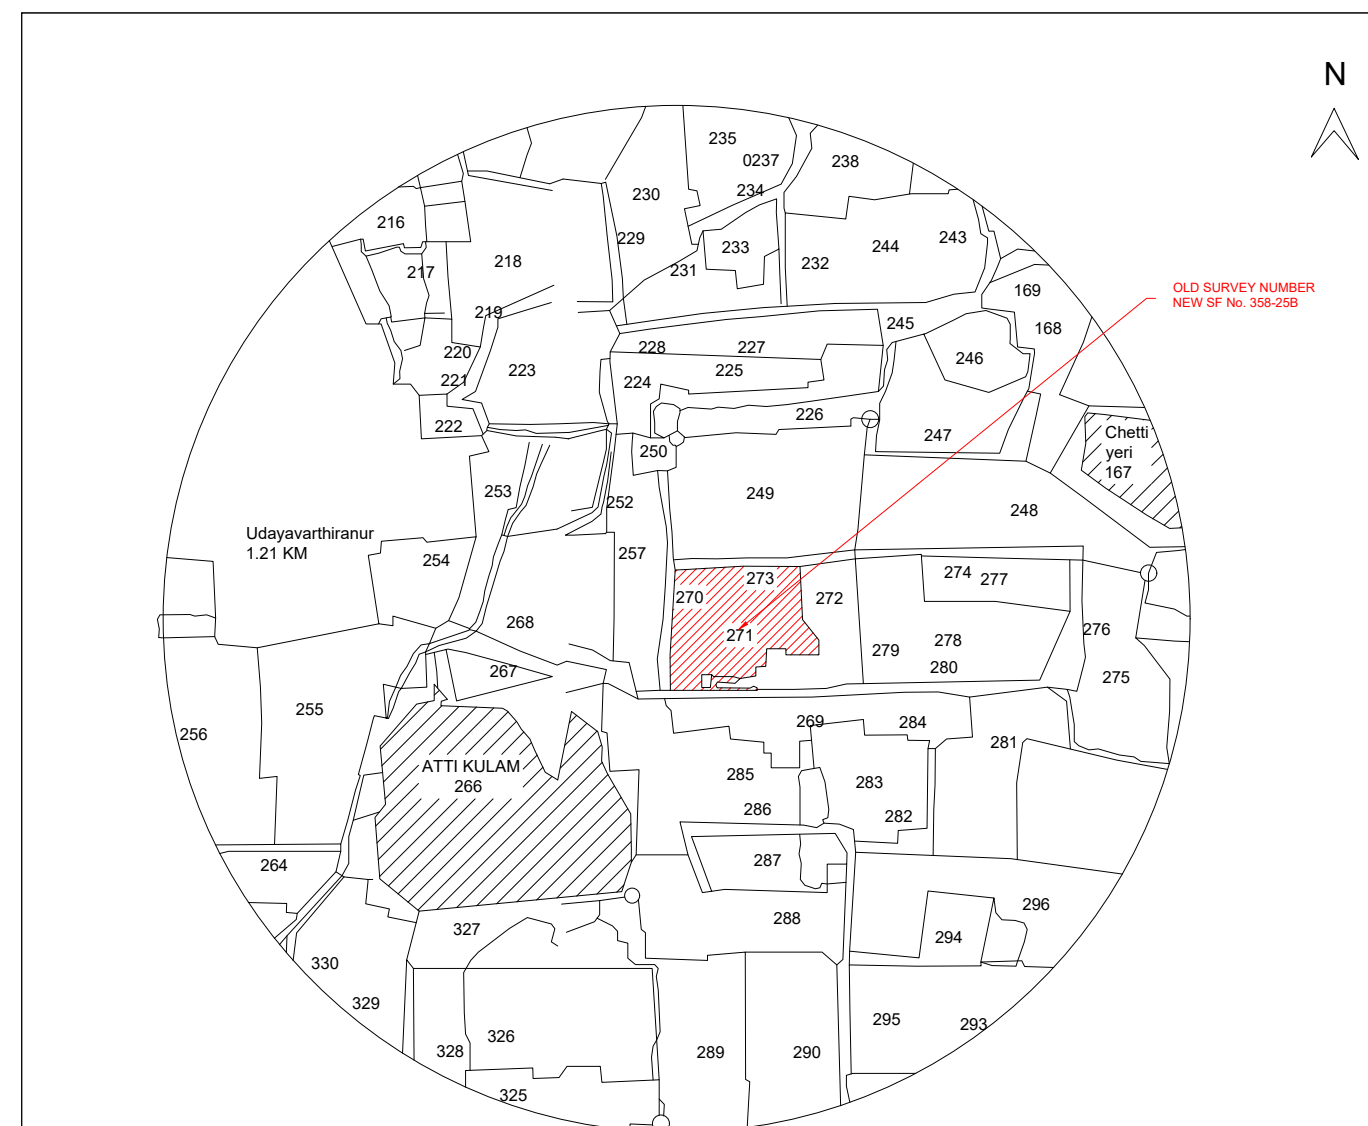

TOPO PLAN


1. SULLAGE WASTE FROM TOILET WILL BE CONNECTED INTO STP.
2. BORE WELL WITH MOTOR WATER TANK AND CORPORATION WATER SUPPLY
3. RAIN WATER PERCOLATION PIT PROVIDED @1/30sq M OF PLINTH AREA@6 C/C
4. RAIN WATER PERCOLATION BED 1m wide will BE PROVIDED AROUND THE BUILDING AS PER GO (MS) NO. 138 DATED 11-10-02.
5. RAIN WATER TANK (RWT) OF 10000 LITRE CAPACITY 150MM DIA PIPES.
6. RAIN WATER COLLECTED FROM OPEN TERRACE SHALL BE COLLECTED THROUGH PIPES AND LED INTO A FILTER PIT (SIZE 60 X 60 X 60 CM WITH APPROPRIATE FILTER MATERIAL) AND THEN LED INTO COLLECTION TANK.
7. RAIN WATER HEATER LINE ARRANGEMENTS WILL BE PROVIDED.
8. ALL DIMENSIONS ARE IN METRE & FEET.
9. FE : FIRE EXTINGUISHER PROVIDED.

ROAD MAP

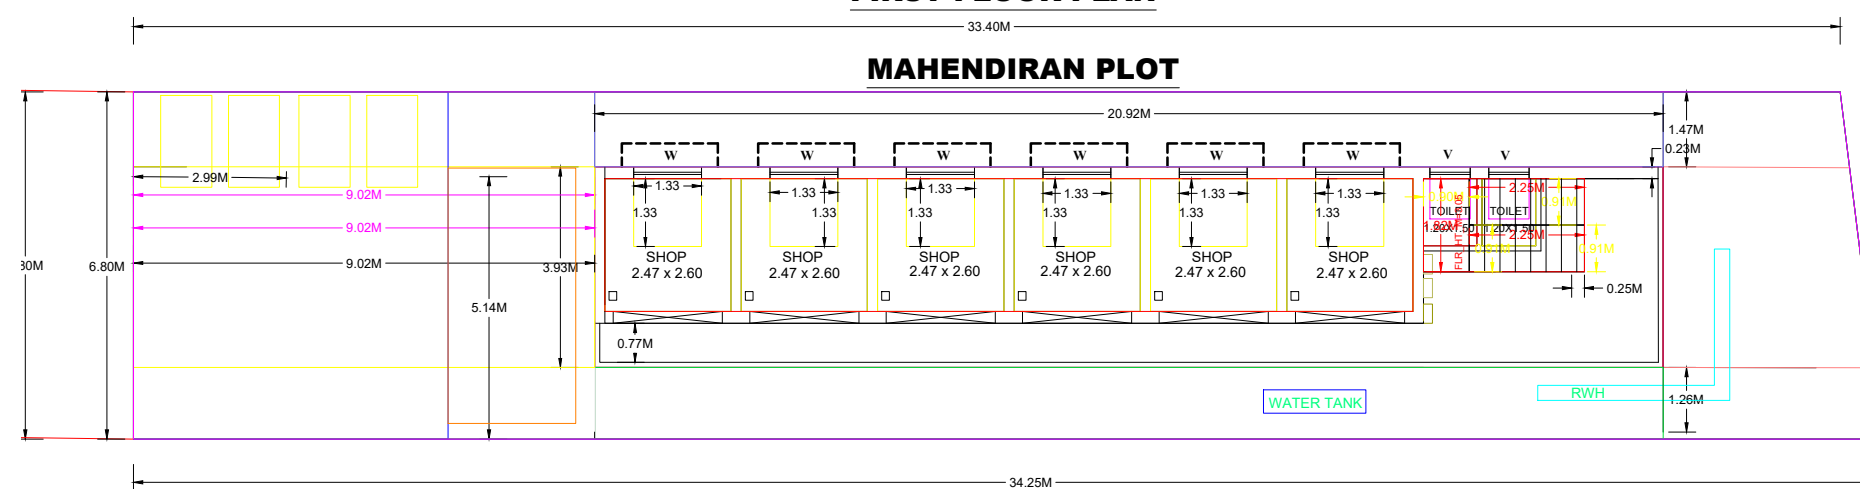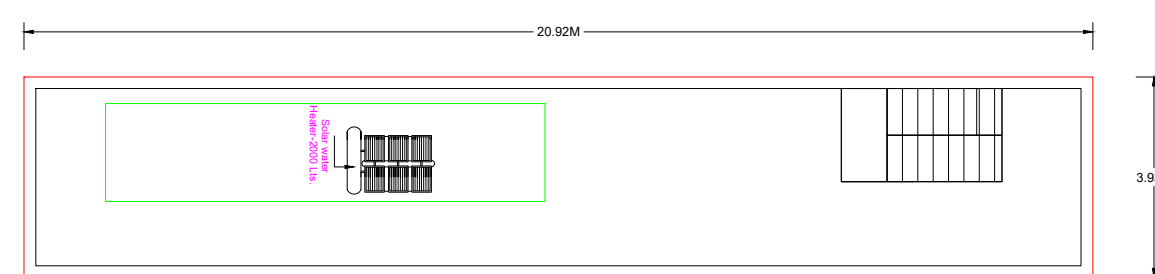

MOHAN PLOT

SITE CUM GROUND FLOOR PLAN

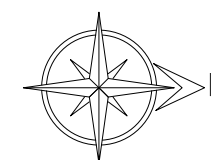

**GOVINDHA AASARI AND KRISHNA PATHAR
LAND**

APPLICANT**MAHENDIRAN S/O MURUGESAN**

④. மெகந்திரம்

ENGINEER

P. Rajapandian
Er.P.RAJAPANDIAN, B.E.,
CONSULTING CIVIL ENGINEER,
LS.No.090/LS/2020/00005
IDEALSURE CONSTRUCTION FIRM,
KALLANKURICHI ROAD,
KAYARLABATH, ARYIYALUR - 621 704.
CELL : 99434 18030