




PLAN SHOWING THE PROPOSED CONSTRUCTION OF GROUND AND FIRST FLOOR R.C.C. ROOF RESIDENTIAL BUILDING IN S.F.NO.60/18, PATTANAMANGALAM AT KEEZHAIYUR VILLAGE, MELAPALUR PANCHAYAT OF ARIYALUR TALUK AND DISTRICT. (SCALE 1:100)

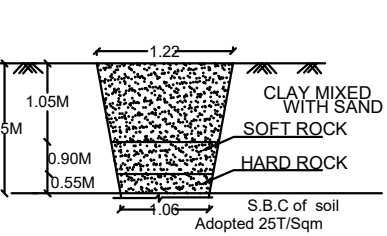


TRIAL PIT DETAILS

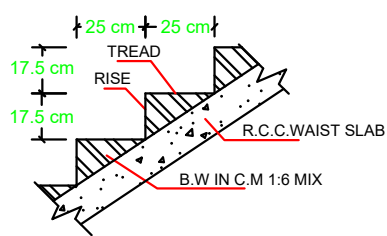

SECTION OF STAIRCASE

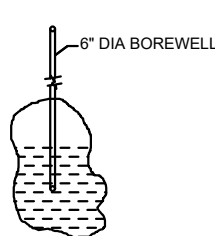

BORE WELL DETAIL

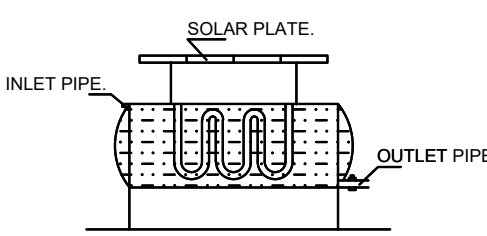

SOLAR WATER HEATER

- SULLAGE WASTE FROM TOILET WILL BE CONNECTED INTO STP.
- BORE WELL WITH MOTAR WATER TANK AND CORPORATION WATER SUPPLY
- RAIN WATER PERCOLATION PIT PROVIDED @1/30 Sqm OF PLINTH AREA@6M C/C
- RAIN WATER PERCOLATION BED 1.0m WIDE WILL BE PROVIDED AROUND THE BUILDING AS PER GO (MS) NO: 138 DATED 11-10-02.
- RAIN WATER TAKEN TO THE BORE WELL THROUGH 150MM DIA PIPES.
- RAIN WATER COLLECTED FROM OPEN TERRACE SHALL BE COLLECTED THROUGH PIPES AND LED INTO A FILTER PIT (SIZE 60 X 60 X 60 CM) WITH APPROPRIATE FILTER MATERIAL AND THEN LED INTO COLLECTION TANK.
- SOLAR WATER HEATER LINE ARRANGEMENTS WILL BE PROVIDED.
- ALL DIMENSIONS ARE IN METRE & FEET.
- FE - FIRE EXTINGUISHER PROVIDED.

SCHEDULE OF JOINERIES:

TYPE	REFERENCE	SIZE IN METER
MD	MAIN DOOR	1.06 x 2.13
D	FLUSH DOOR	1.00 x 2.13
D1	FLUSH DOOR	0.76 x 2.13
D2	FLUSH DOOR	1.00 x 1.98
O	OPEN	1.00 x 2.13
W1	WINDOW	1.53 x 1.52
W2	WINDOW	1.22 x 1.52
W3	WINDOW	0.91 x 1.52
KW	KITCHEN WINDOW	1.53 x 1.22
V	VENTILATOR	0.91 x 0.76
J	JALLY	0.91 x 1.83

AREA DETAILS

DESCRIPTION	SQ.M
PLOT AREA (as per Document)	800.00
PLOT AREA (as per FMB)	800.00
SUPER IMPOSED PLOT AREA	800.00

PROPOSED BUILDING PLINTH AREA

DESCRIPTION	F.S.I AREA (in SQ.M)	F.S.I AREA (in SQ.FT)
GROUND FLOOR AREA	46.80	503.75
FIRST FLOOR AREA	46.80	503.75
OPEN SPACE	706.40	7603.68

PLOT COVERAGE	=	46.80	X	100	=	5.85%
F.S.I	=	93.60			=	0.117

PARKING

1. TWO WHEELER PARKING SPACE 1 NOS PROVIDED.

NOTES:

- FIRE EXTINGUISHER ● FE
- ALL DIMENSION ARE IN METER
- SCALE - 1:100
- WASTE WATER UTILISED FOR GARDEN PURPOSE.
- SOLAR WATER HEATER PROVIDED IN TERRACE FLOOR.








A.S.A Constructions
Chinna Aranmanai Street, Ariyalur.
Mobile : 9443303157, 9943425641

APPLICANT

[Signature]
Mr.ALLAN SEBASTIAN DIVYA SHARON,
S/O.Mr.ALLAN SUNDERRAJ.

ENGINEER

[Signature]
Er.D.SEETHA, M.E(Struct).,
LICENSED SURVEYOR NO:329
REGISTERED ENGINEER GRADE -1
RE/PLBR/APR 2019/014

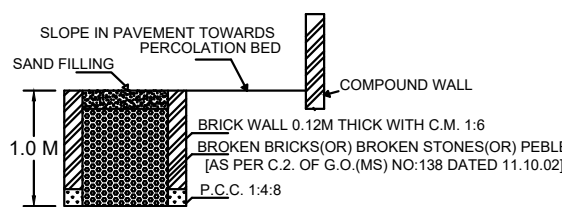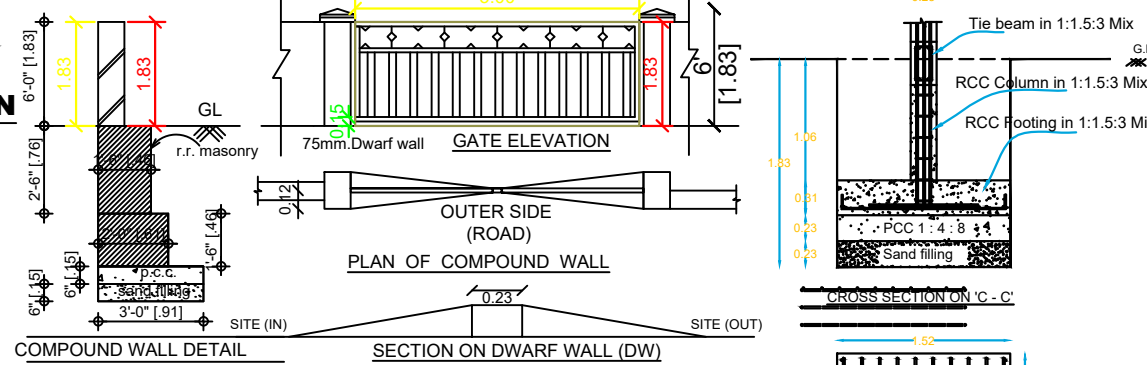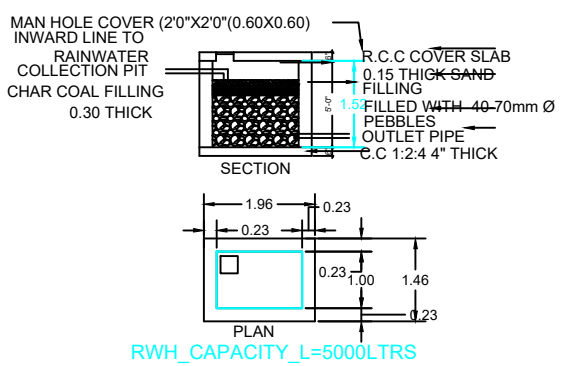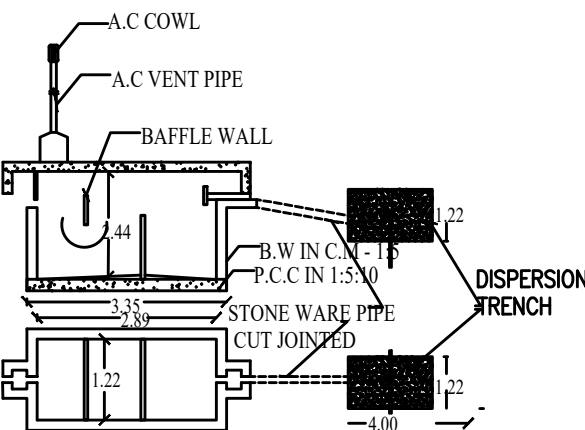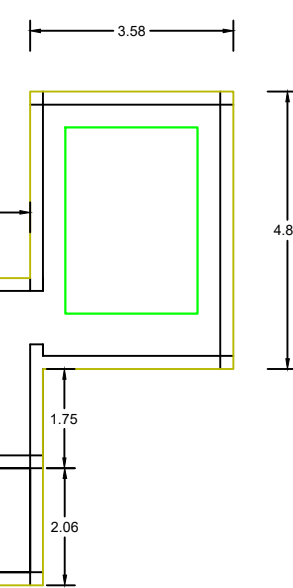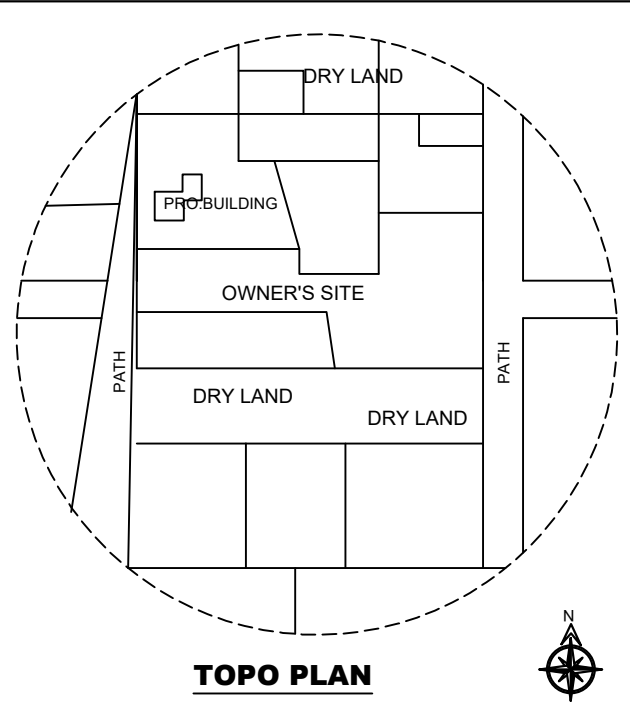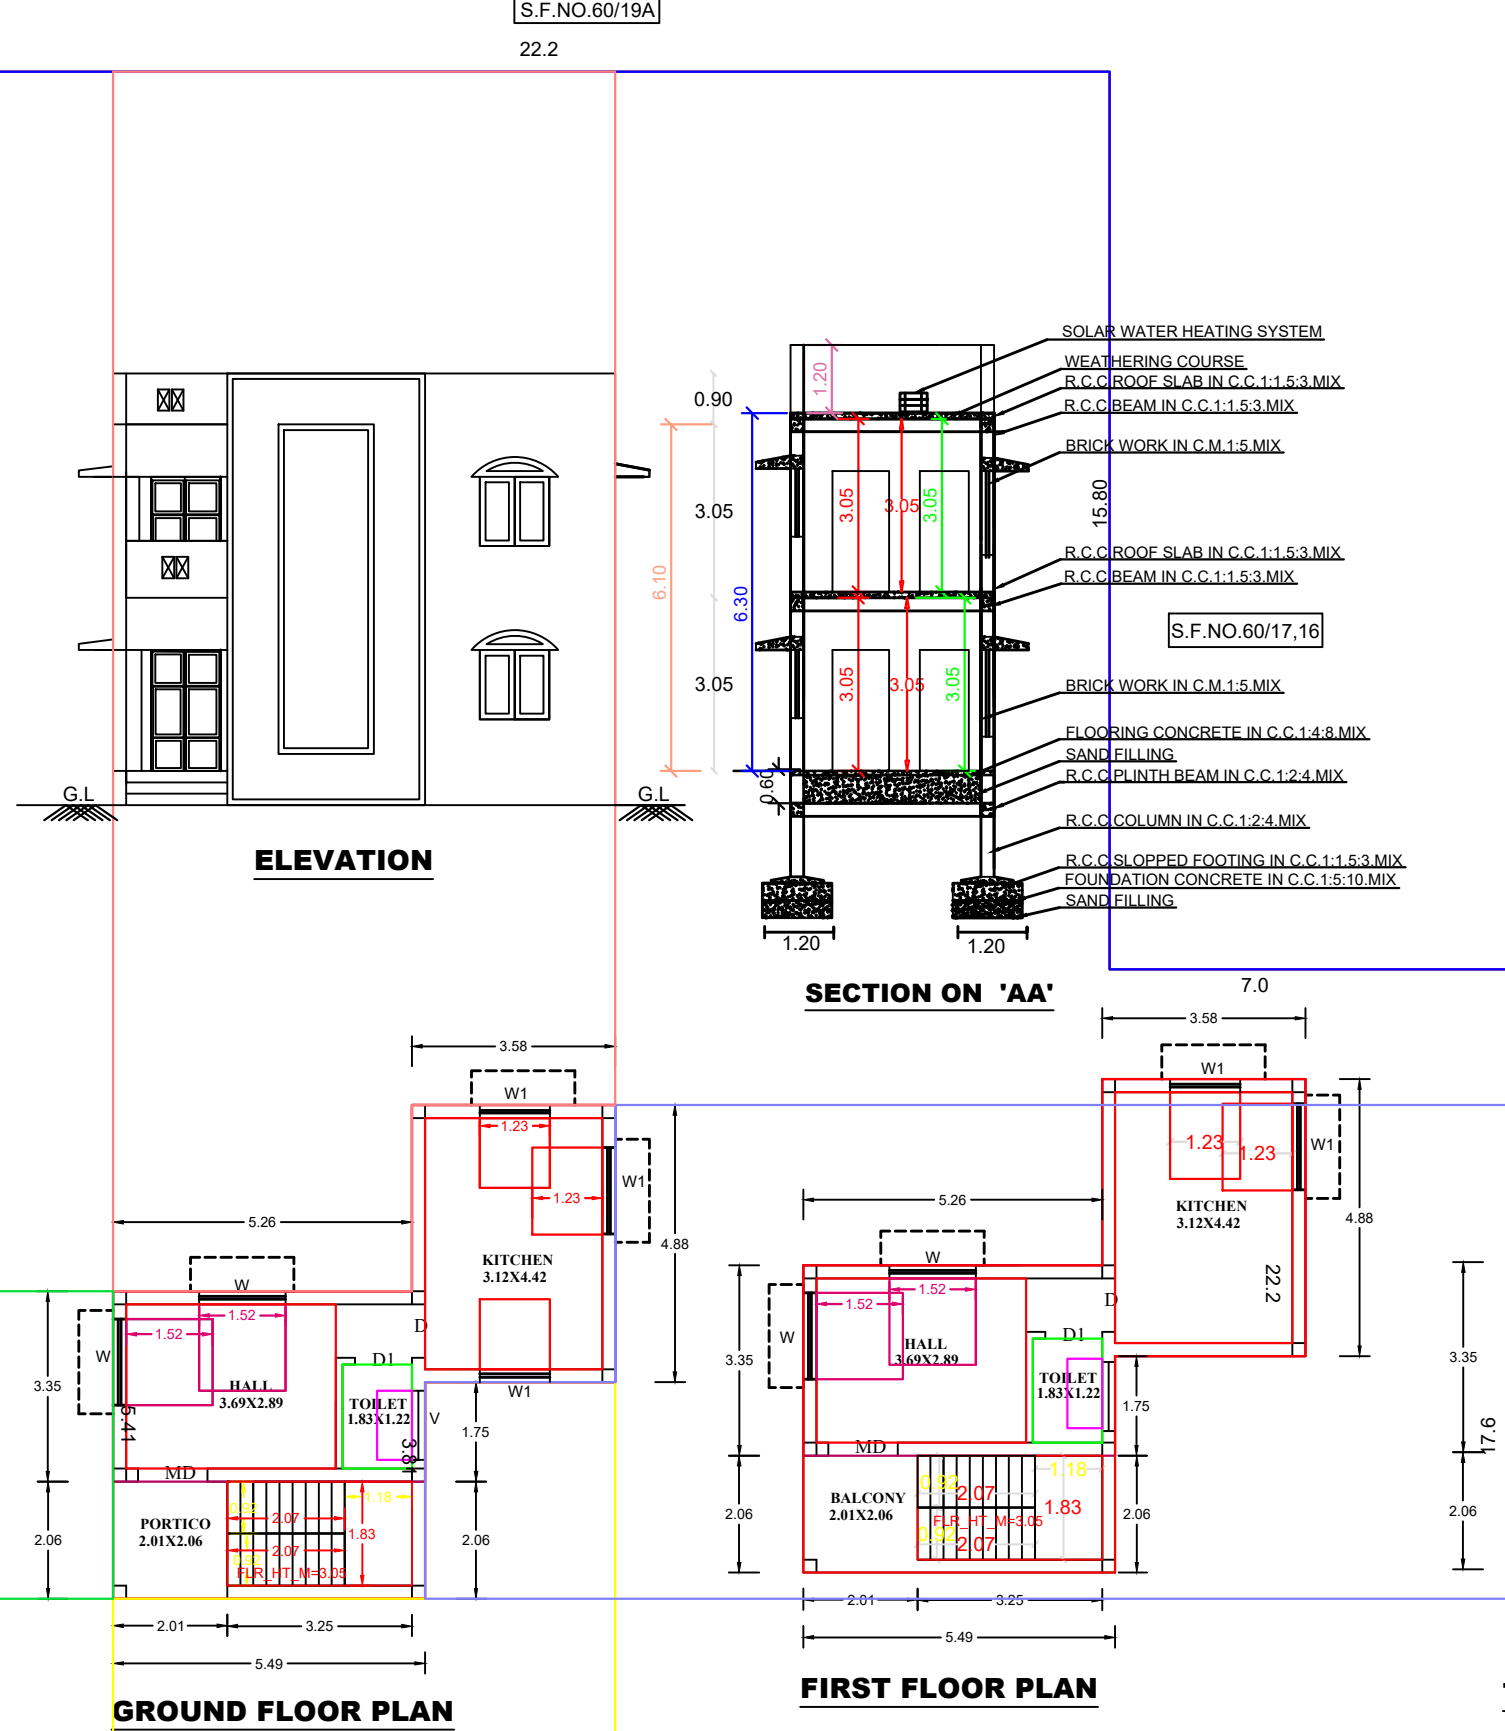

COLOUMN FOUNDATION

DETAILS



SITE PLAN

