


PLAN SHOWING THE PROPOSED CONSTRUCTION OF A RCC ROOF COMMERCIAL CUM RESIDENTIAL BUILDING IN NEW S.F.NO.234/3B,  
OLD S.F.NO.234/3, PATTA NO. 3379 AT VALAJANAGARAM GROUP, VENKATAKRISHNAPURAM VILLAGE PANCHAYAT, ARIYALUR TALUK & DISTRICT.  
SCALE 1:100

Name of Applicant :- Mr.K.Chinnaiyan, S/o.Mr.Kanthasamy

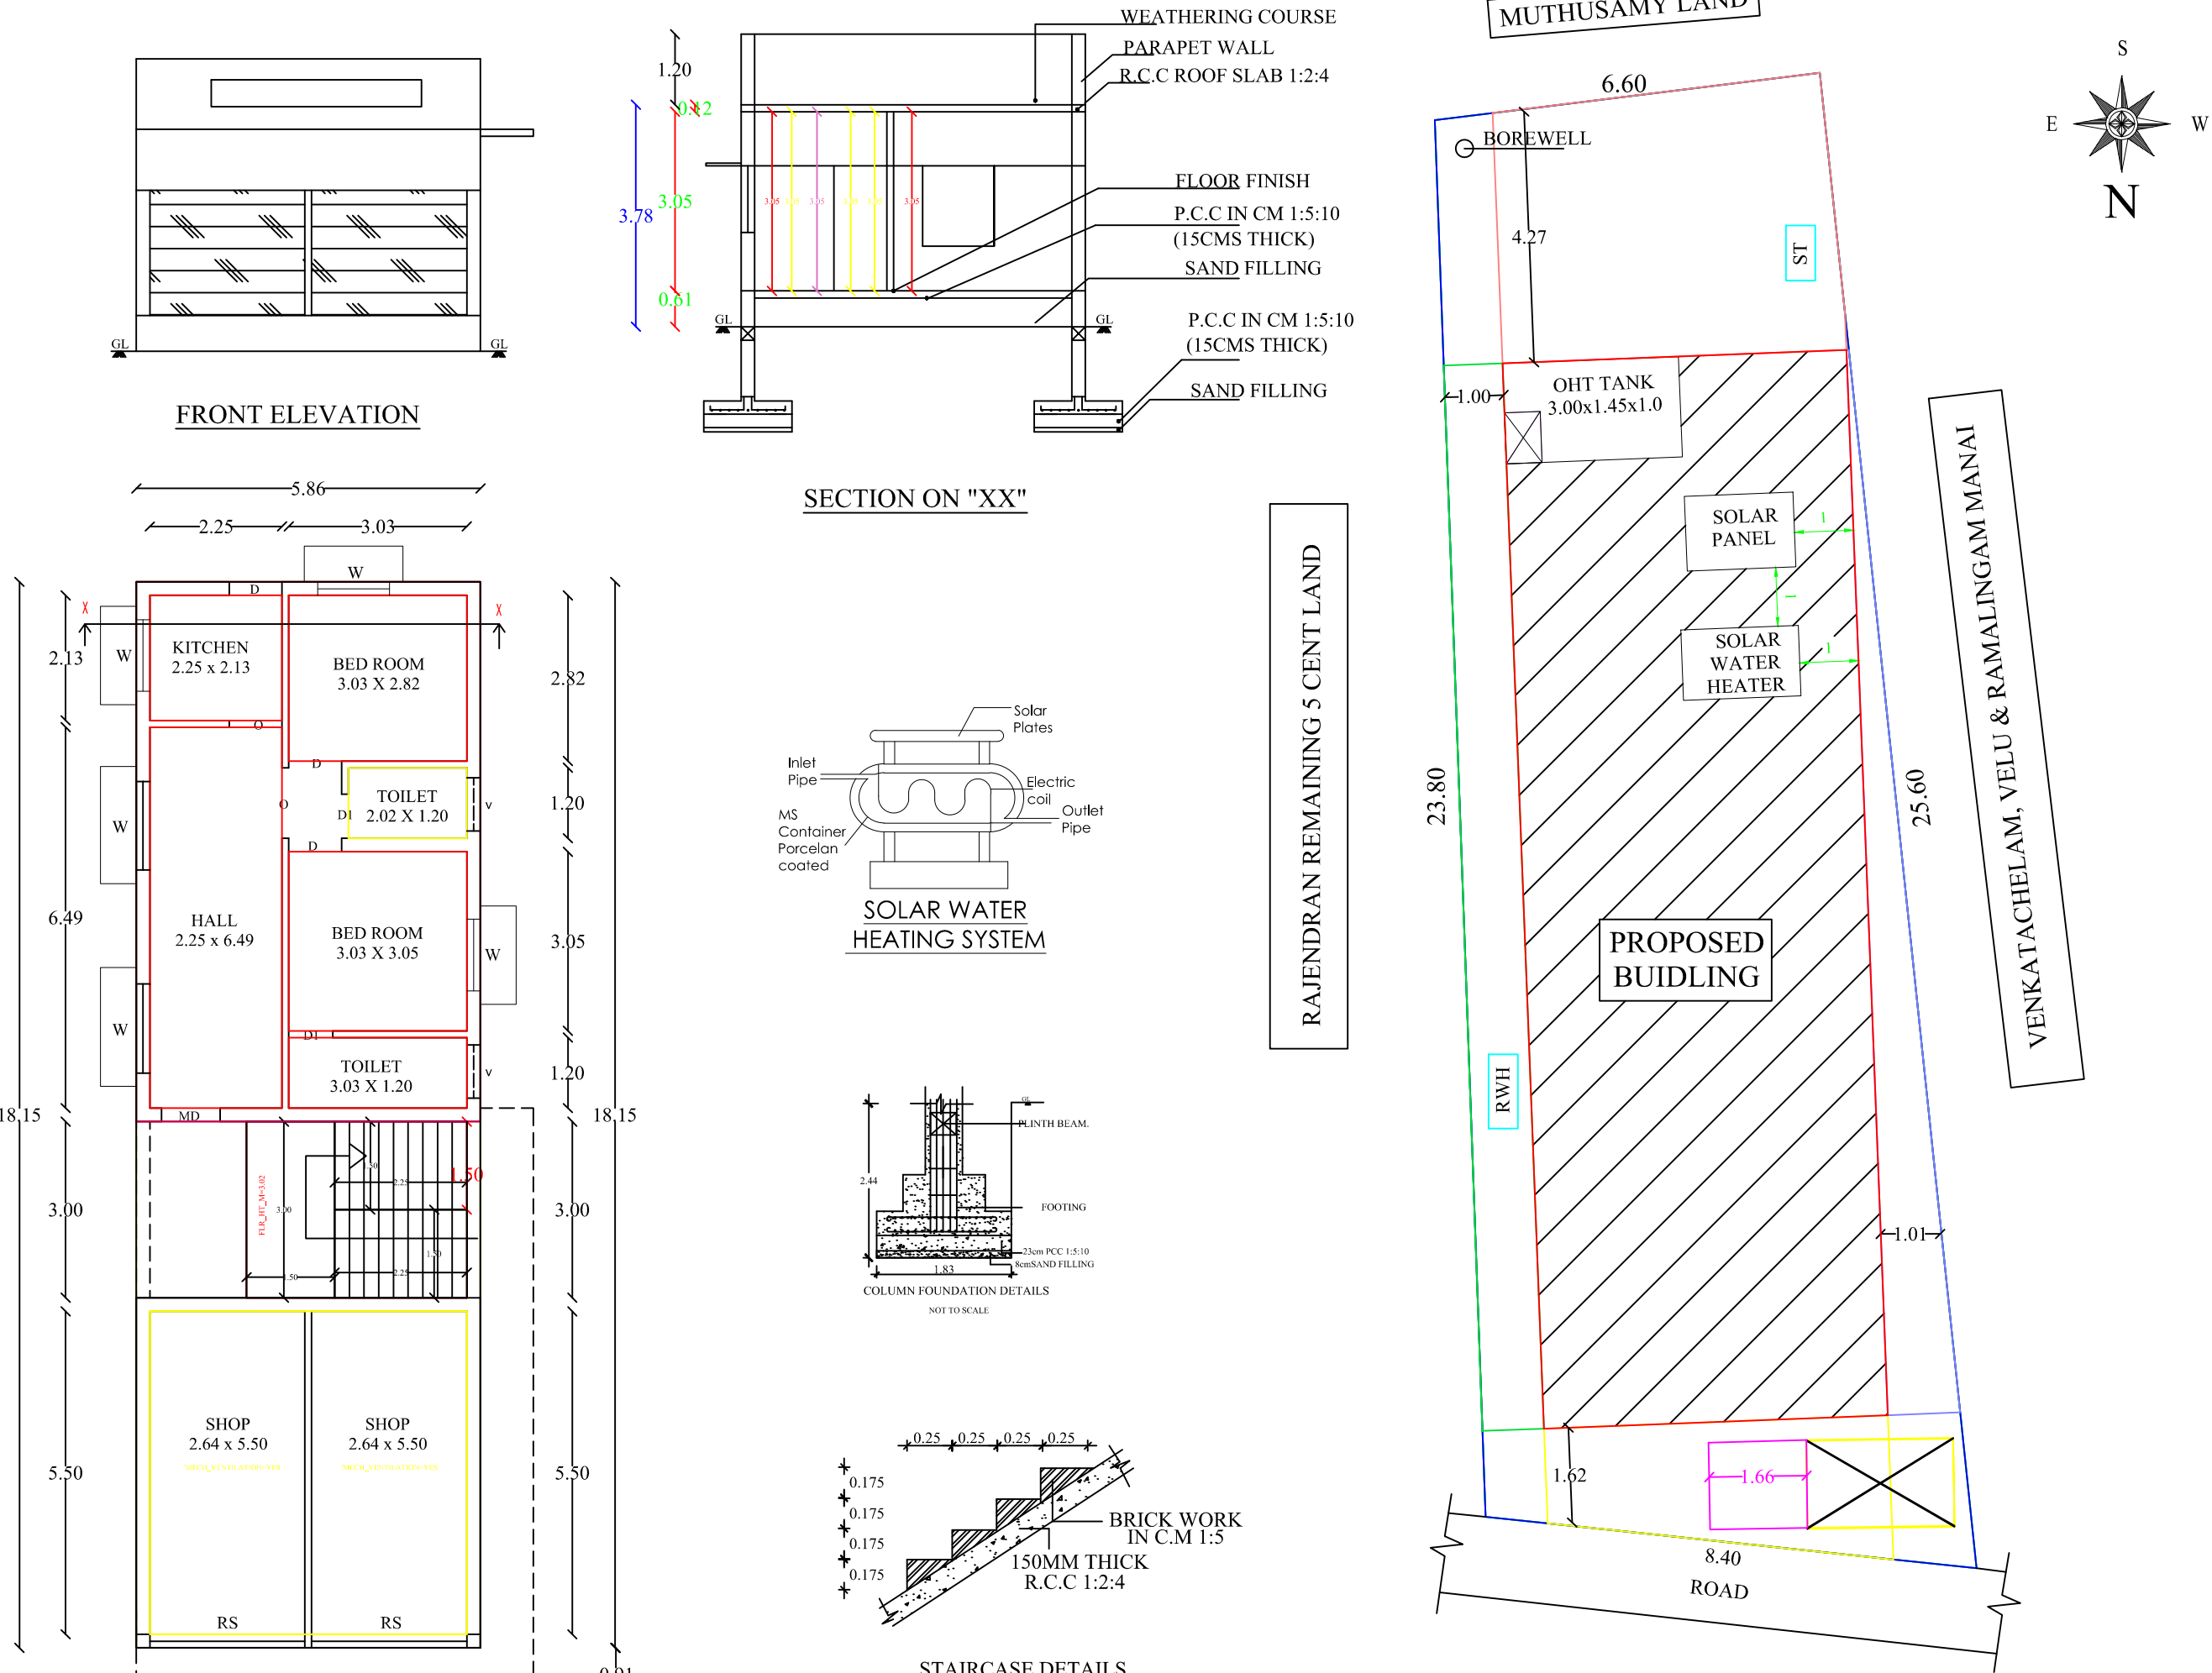

1ND FLOOR PLAN

SITE PLAN  
SCALE 1:100

KEYPLAN PLAN  
(NOT TO SCALE)

JOINERIES DETAILS

|            |    |             |
|------------|----|-------------|
| MAIN DOOR  | MD | 1.22 x 2.14 |
| DOOR       | D  | 0.91 x 2.14 |
| DOOR       | D1 | 0.76 x 2.14 |
| WINDOW     | W  | 1.22 x 1.37 |
| WINDOW     | W1 | 1.22 x 1.07 |
| VENTILATOR | V  | 0.61 x 0.61 |

AREA CALCULATION

| DESCRIPTION      | AREA IN Sq.M | AREA IN Sq.Ft. |
|------------------|--------------|----------------|
| AREA OF THE SITE | 202.52       | 2180.00        |
| PRO. GF HOUSE    | 53.81        | 579.21         |
| PRO. GF SHOPS    | 52.46        | 564.68         |
| OPEN SPACE       | 96.25        | 1036.11        |

COLOUR INDEX

|          |  |          |  |
|----------|--|----------|--|
| BOUNDARY |  | PROPOSAL |  |
| EXISTING |  | ROAD     |  |

NOTES

- \* All Dimensions are in Meters
- \* Scale - 1:100
- \* Sewer line connected with SEPTIC TANK
- \* Kitchen, Bath & Wash basin water will be separated and connected with rain water recharge pit

Applicant



Mr.K.Chinnaiyan

Engineer

Er.S.SENTHIL KUMAR, B.E.,M.Tech.(Structural),  
Registered Engineer, Municipality - DTCP,  
Reg.No: 090/LS/2019/00001,  
Regd.No: RCE/PBLR/2019/053, Regd.No: RE/PBLR/2019/018,  
RSB Construction, ARIYALUR.  
Cell No: 9842473689.