

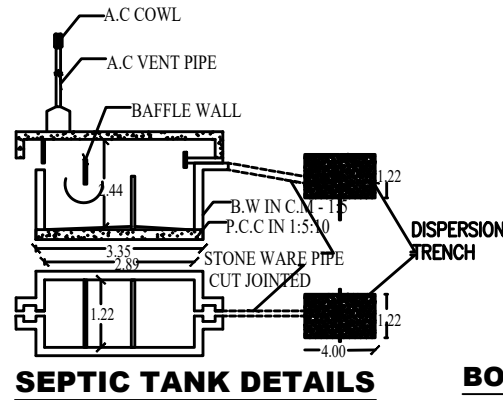
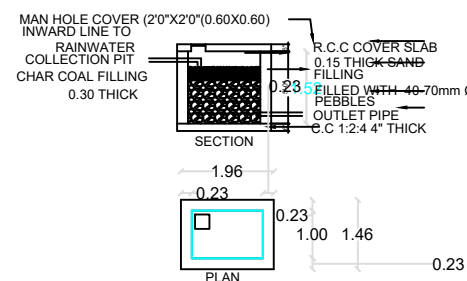
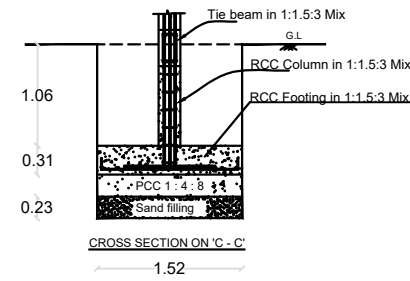



**PLAN SHOWING THE PROPOSED CONSTRUCTION OF GROUND
AND FIRST FLOOR R.C.C. ROOF RESIDENTIAL BUILDING IN
S.F.NO.261/24A, 23A, PATTAN NO.567 AT VILANGUDI VILLAGE OF
ARIYALUR TALUK AND DISTRICT. (SCALE 1:100)**

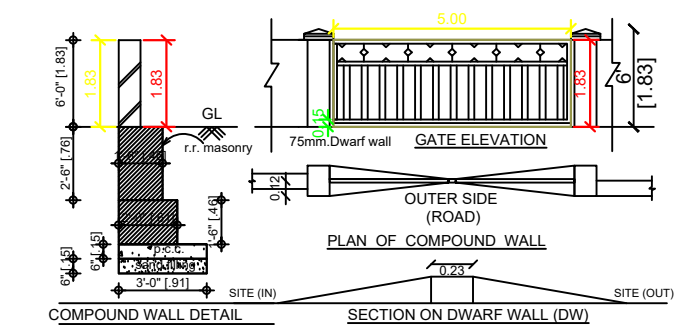


BORE WELL DETAIL

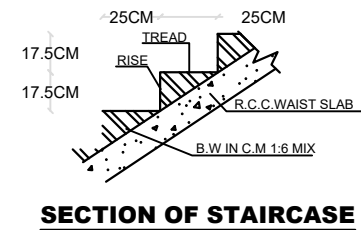


SECTION OF STAIRCASE

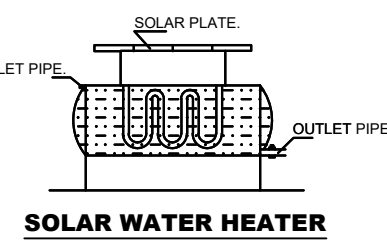


SOLAR WATER HEATER

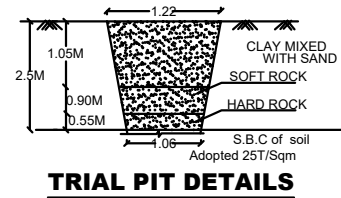


TRIAL PIT DETAILS

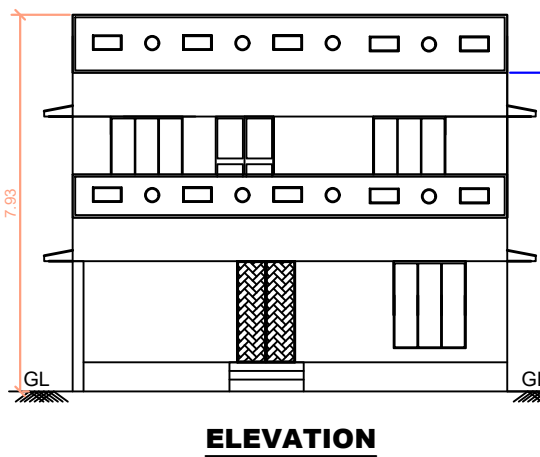


ELEVATION

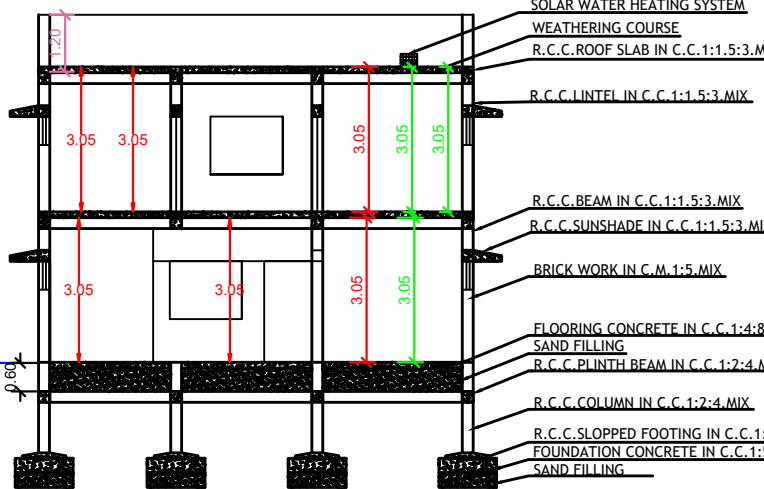


SECTION ON 'AA'

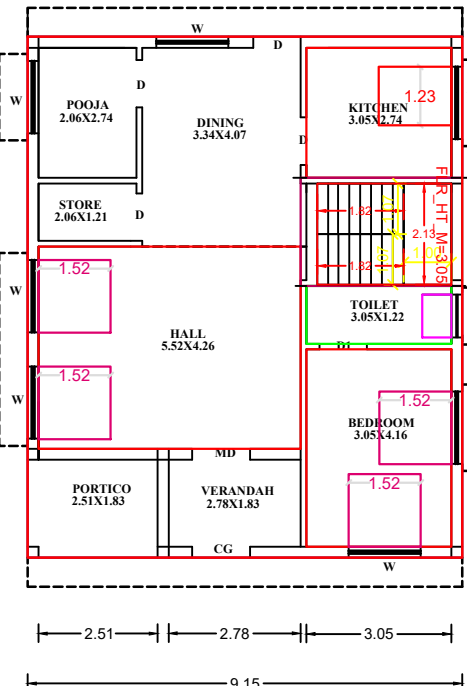


GROUND FLOOR PLAN

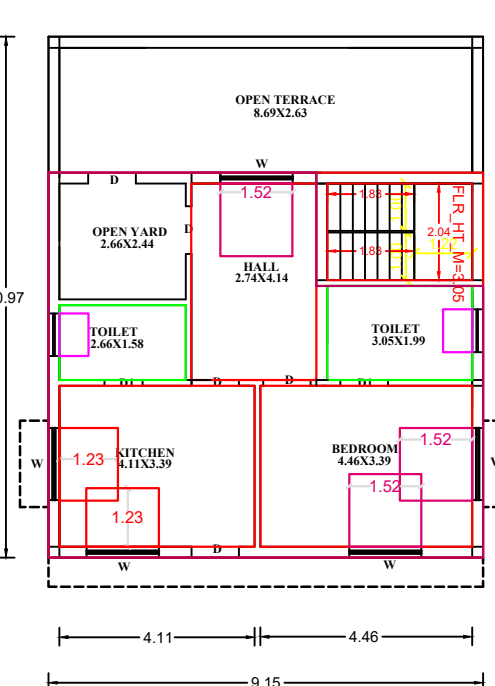


FIRST FLOOR PLAN

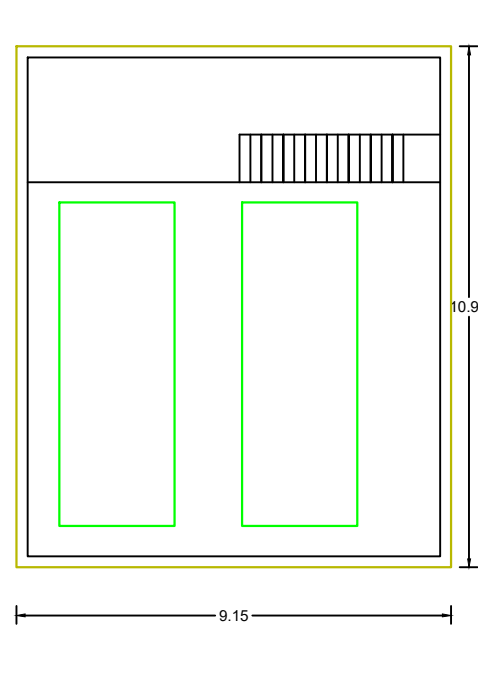

TERRACE FLOOR PLAN

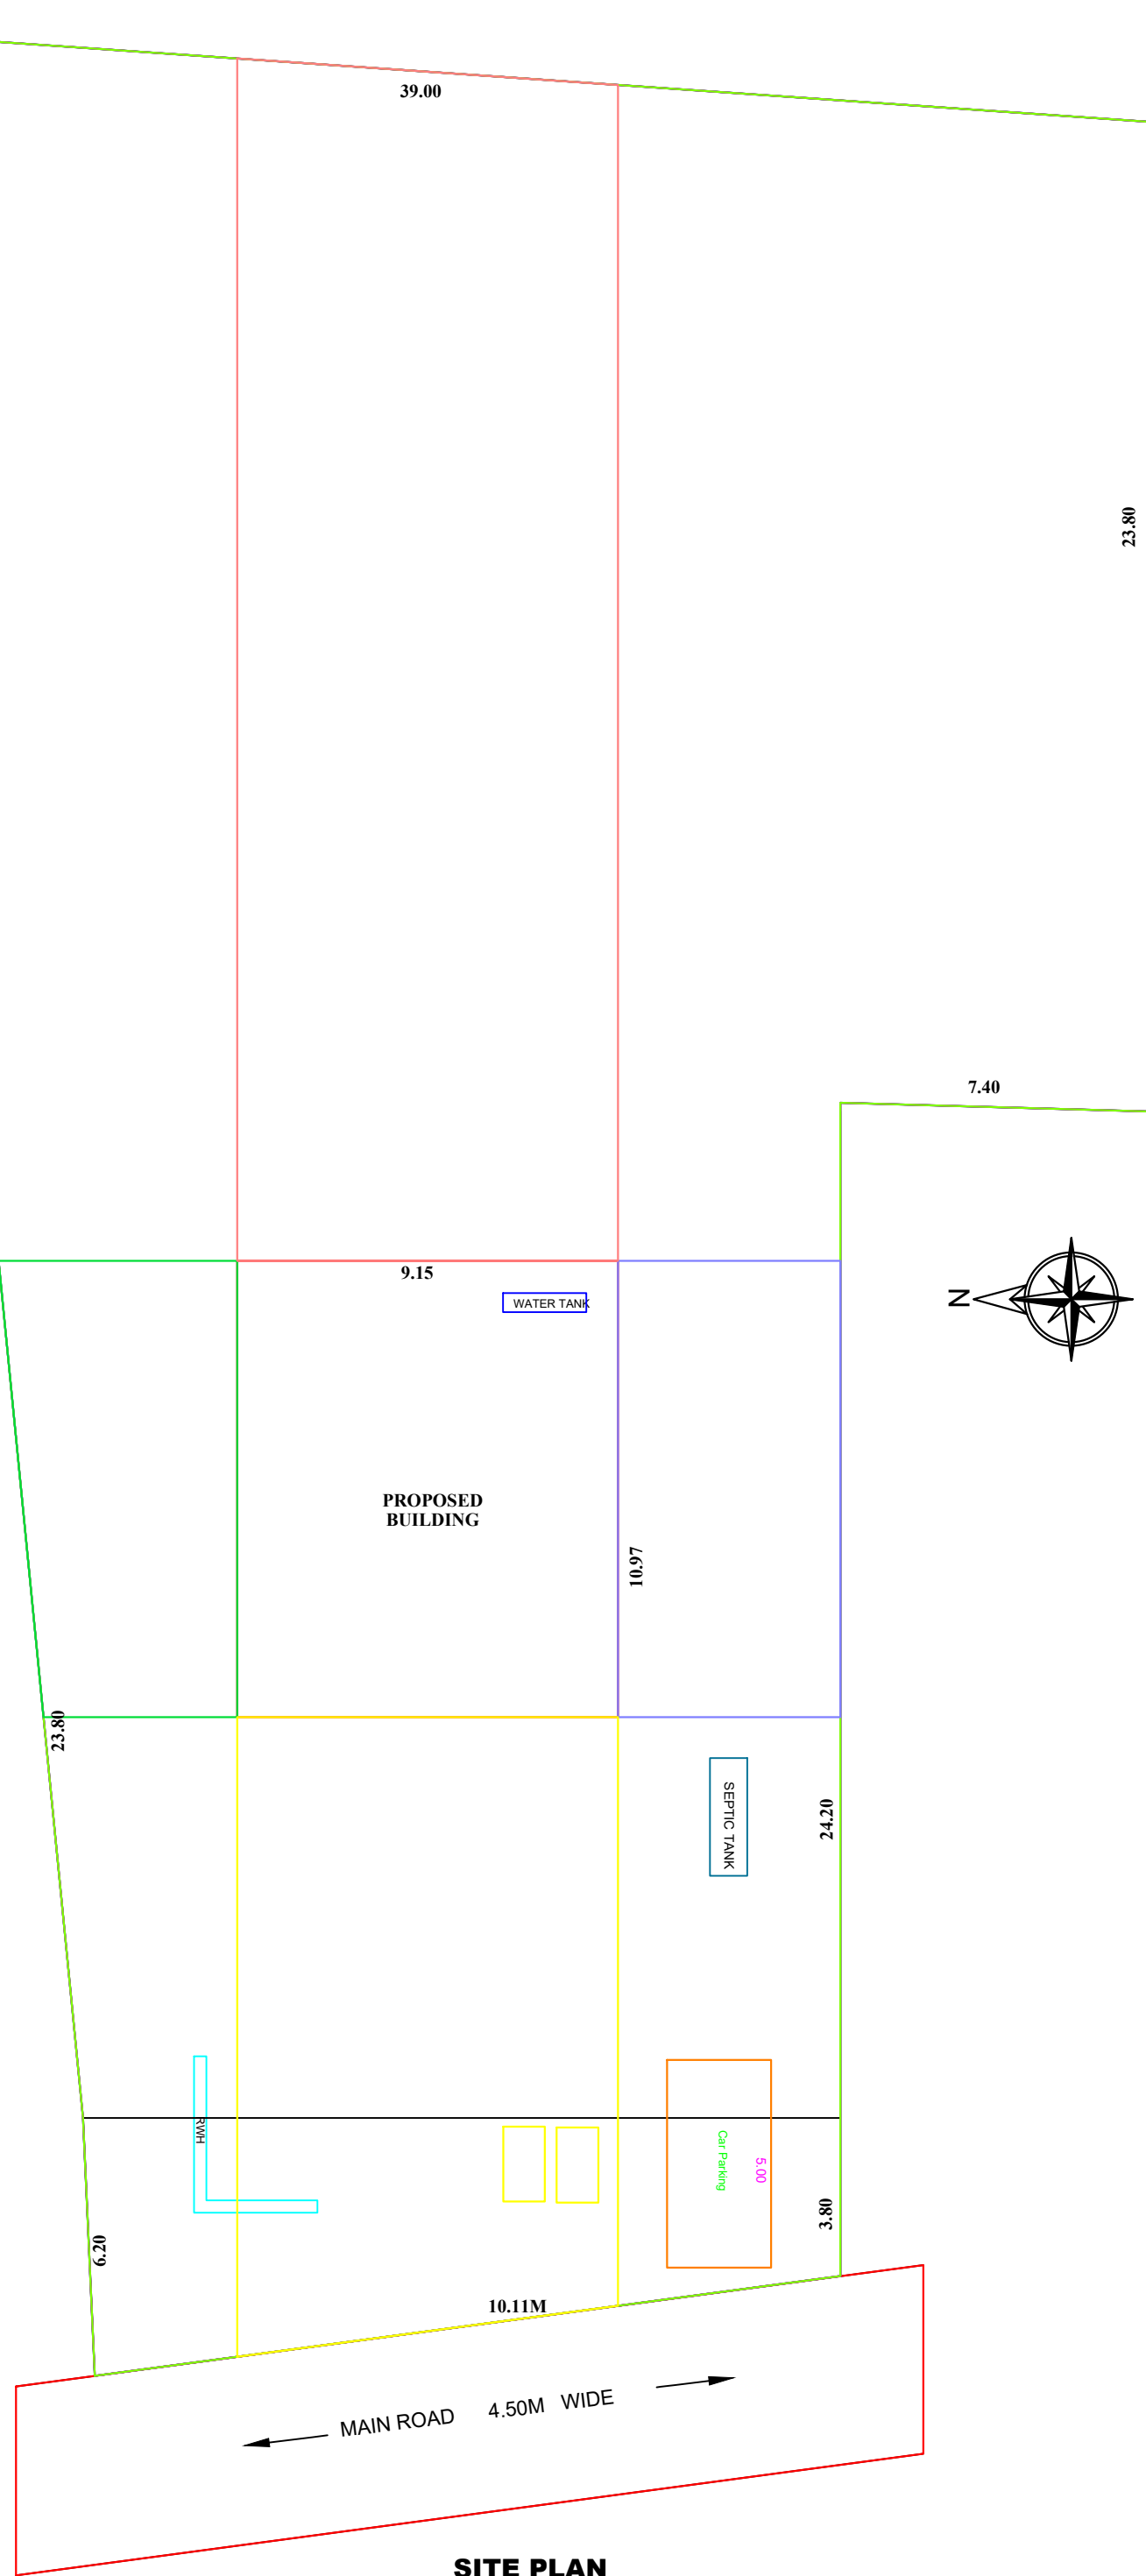

SITE PLAN

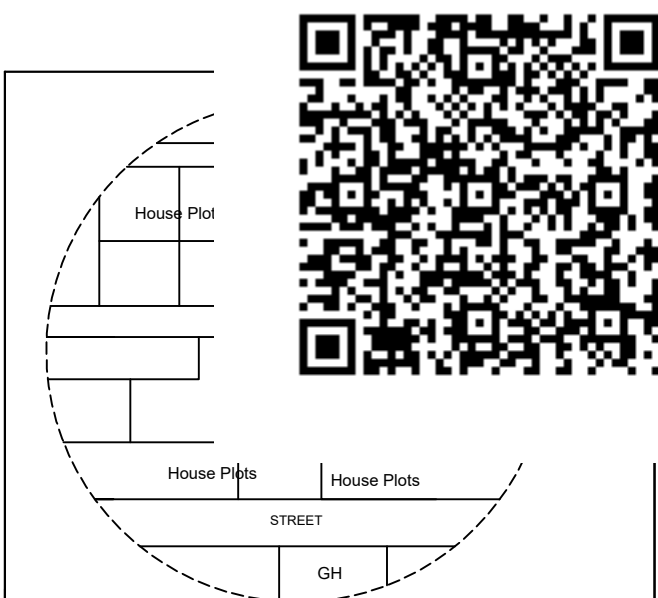

TOPO PLAN

REFERENCE

S.NO	DESCRIPTION	TYPE	SIZE
1.	MAIN DOOR	MD	1.20 X 2.10
2.	DOOR	D	1.00 X 2.10
3.	DOOR 1	D1	0.80 X 2.10
4.	WINDOW	W	1.50 X 1.20
5.	WINDOW 1	W1	1.50 X 0.90
6.	FRENCH WINDOW	FW	1.50 X 1.80
7.	VENTILATOR	V	1.20 X 0.46
8.	GRILL	G	1.20 X 2.10

AREA DETAILS

S.NO	DESCRIPTION	AREA IN SQ M	AREA IN SQ FT
1.	PLOT AREA	1584.00	17050.18
2.	GROUND FLOOR	100.38	1080.50
3.	FIRST FLOOR	74.21	798.80
4.	VACANT AREA	1483.62	15969.68

PLOT COVERAGE	=	$\frac{100.38}{1584.00} \times 100$	=	6.34%
F.S.I	=	$\frac{174.59}{1584.00}$	=	0.11

PARKING

1. TWO WHEELER PARKING SPACE 2 NOS PROVIDED.

NOTES:

1. FIRE EXTINGUISHER
2. ALL DIMENSION ARE IN METRE
3. SCALE - 1:100
4. WASTE WATER UTILISED FOR GARDEN PURPOSE.
5. SOLAR WATER HEATER PROVIDED IN TERRACE FLOOR.

1. SULLAGE WASTE FROM TOILET WILL BE CONNECTED INTO STP.
2. BORE WELL WITH MOTAR WATER TANK AND CORPORATION WATER SUPPLY
3. RAIN WATER PERCOLATION PIT PROVIDED @1/30 Sqm OF PLINTH AREA@6M C/C
4. RAIN WATER PERCOLATION BED 1.0m WIDE WILL BE PROVIDED AROUND THE BUILDING AS PER GO (MS) NO: 138 DATED 11-10-02.
5. RAIN WATER TAKEN TO THE BORE WELL THROUGH 150MM DIA PIPES.
6. RAIN WATER COLLECTED FROM OPEN TERRACE SHALL BE COLLECTED THROUGH PIPES AND LED INTO A FILTER PIT (SIZE 60 X 60 X 60 CM) WITH APPROPRIATE FILTER MATERIAL AND THEN LED INTO COLLECTION TANK.
7. SOLAR WATER HEATER LINE ARRANGEMENTS WILL BE PROVIDED.
8. ALL DIMENSIONS ARE IN METRE & FEET.
9. FE - FIRE EXTINGUISHER PROVIDED.

A.A.S. CONSTRUCTIONS,
CHINNA ARANMANAI STREET
MOBILE : 9443303157, 9943425641

Applicant

As per
Mr. SELVAM,
S/O. Mr. ARUNACHALAM

ENGINEER

Er.D. SEETHA
Er.D. SEETHA M.E(Struct).,
LICENSED SURVEYOR NO:329
REGISTERED ENGINEER GRADE - I
RE/PLBR/APR 2019/014