



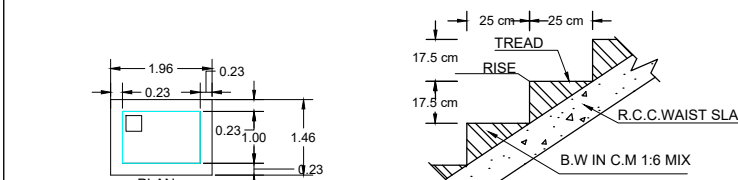


PLAN SHOWING THE PROPOSED CONSTRUCTION OF G+1 R.C.C. ROOF COMMERCIAL AND RESIDENTIAL BUILDING IN S.F.NO.256/2B, PATTA NO.3102, OF UDAYAVAR THIANUR VILLAGE AND AMBAPUR PANCHAYATH, UDAYARPALAYAM TALUK AND ARIYALUR DISTRICT.

(SCALE 1:100)

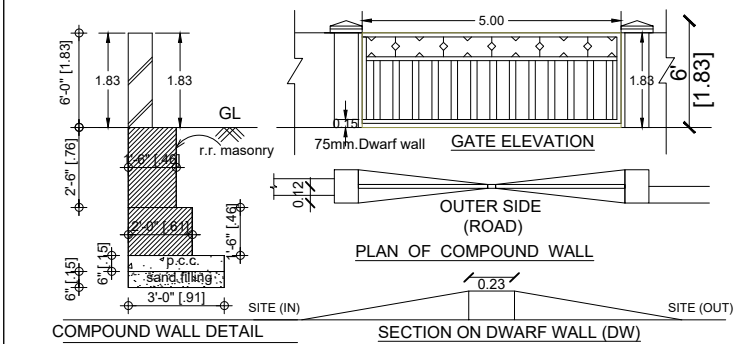


SECTION OF STAIRCASE

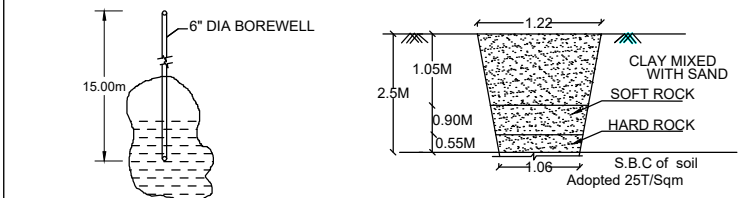



BORE WELL DETAIL

TRIAL PIT DETAILS

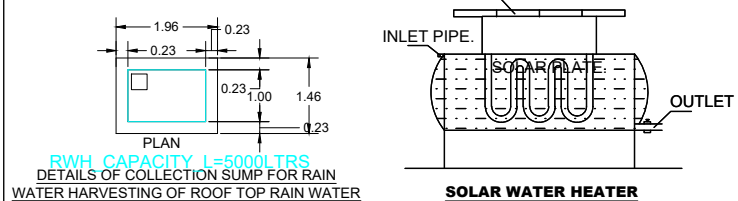


PLAN


SOLAR WATER HEATER

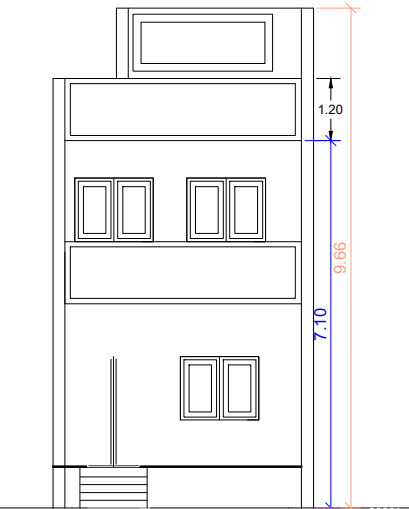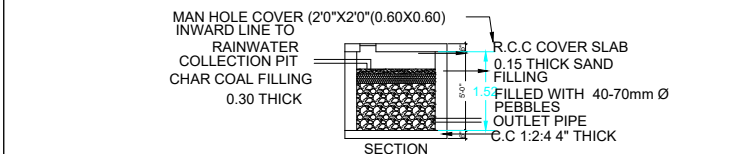


ELEVATION

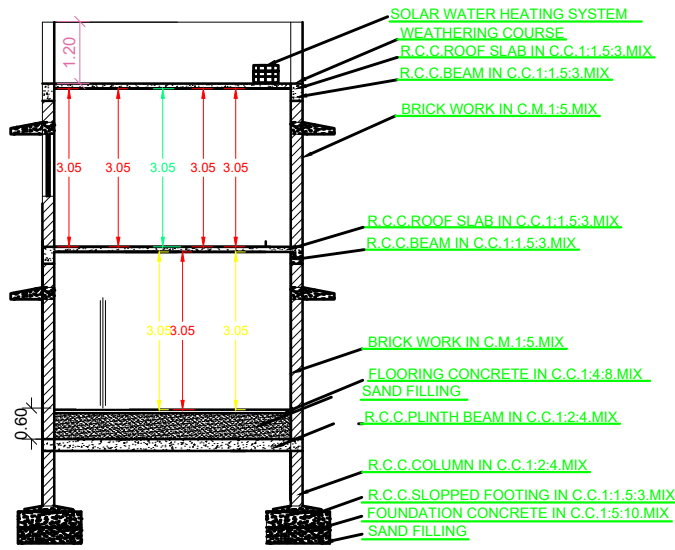


SECTION ON 'AA'

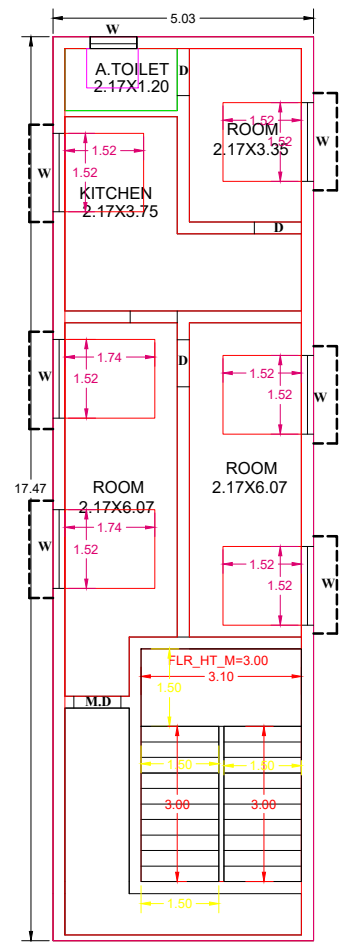


FIRST FLOOR PLAN

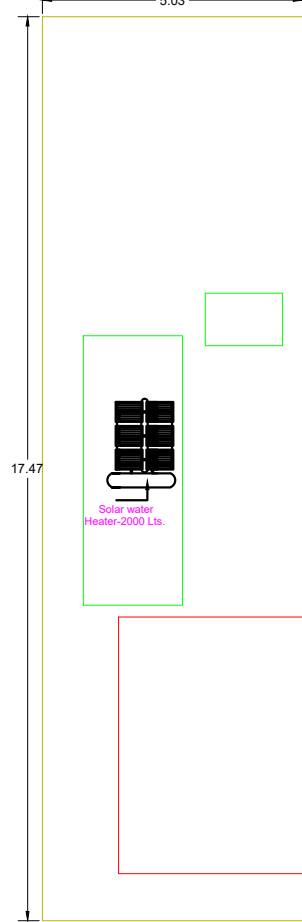


TERRACE PLAN

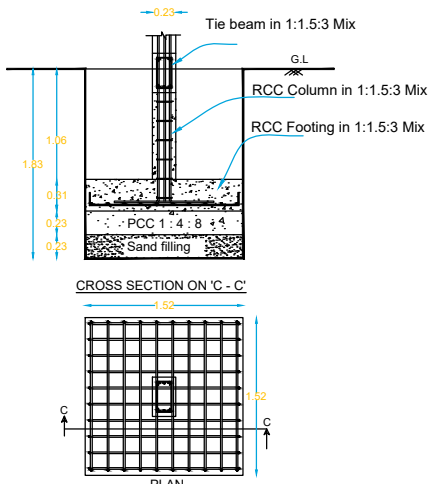

COLOUMN FOUNDATION DETAILS

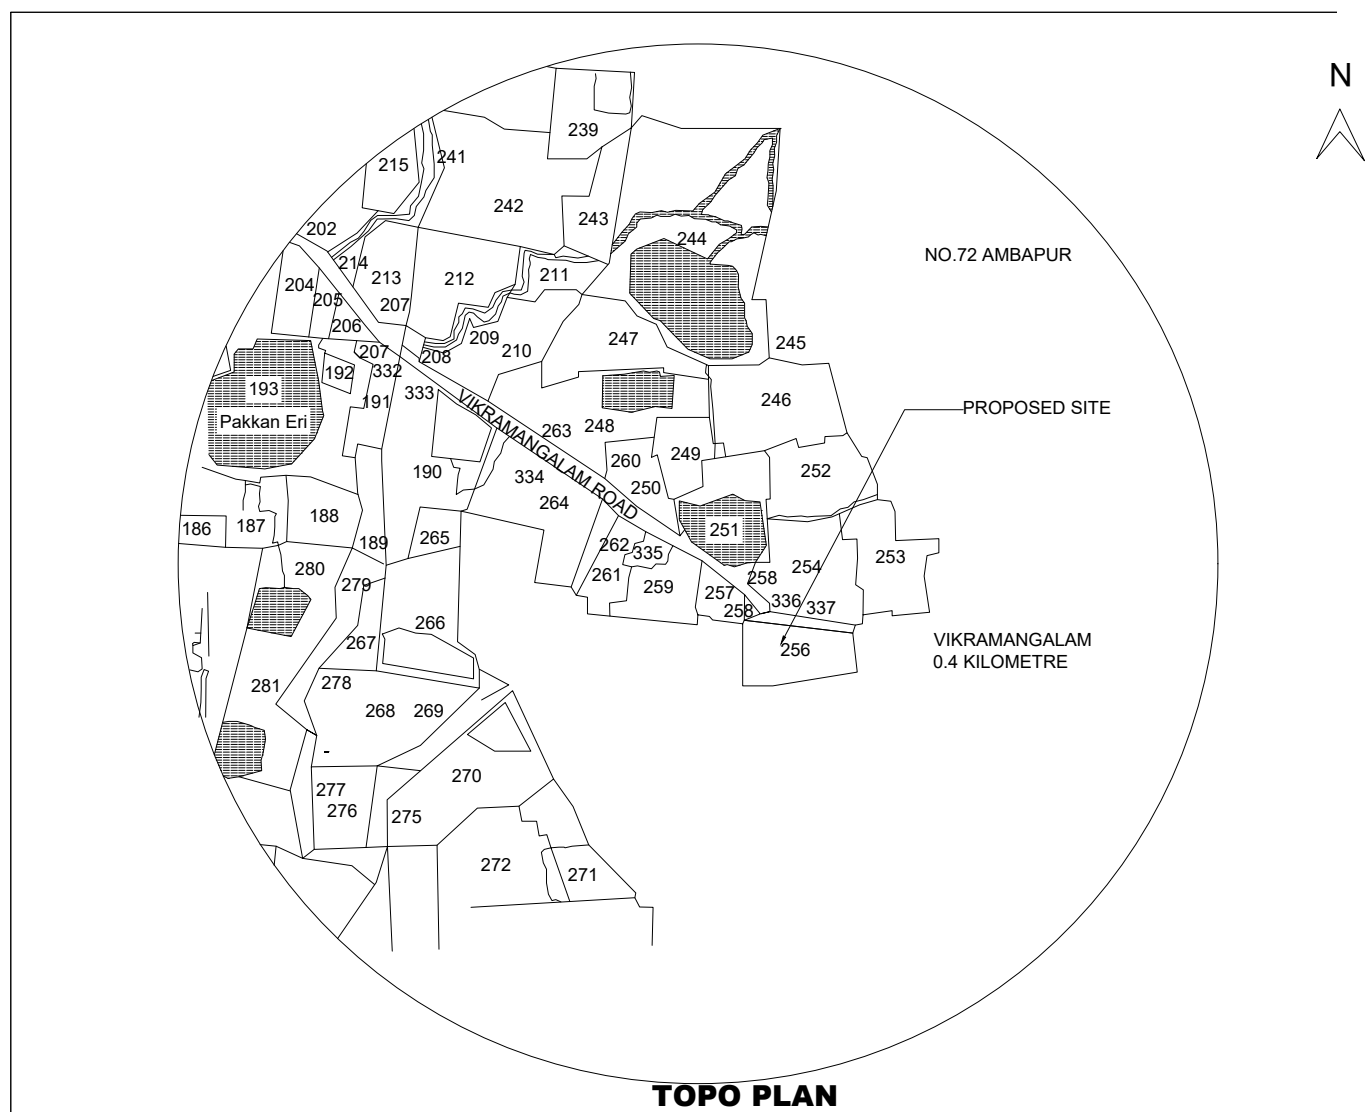

TOPO PLAN

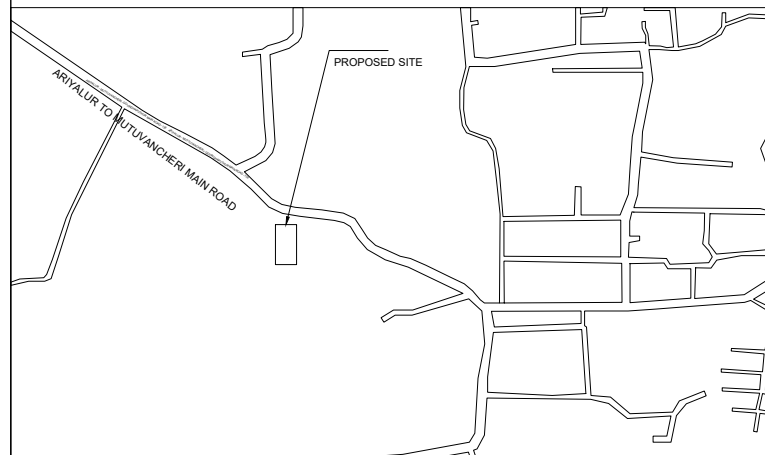

ROAD MAP

1. SULLAGE WASTE FROM TOILET WILL BE CONNECTED INTO STP.
2. BORE WELL WITH MOTAR WATER TANK AND CORPORATION WATER SUPPLY.
3. RAIN WATER PERCOLATION PIT PROVIDED @1/30 Sqm OF PLINTH AREA@6M C/C
4. RAIN WATER PERCOLATION BED 1.0m WIDE WILL BE PROVIDED AROUND THE BUILDING AS PER GO (MS) NO: 138 DATED 11-10-02.
5. RAIN WATER TAKEN TO THE BORE WELL THROUGH 150MM DIA PIPES.
6. RAIN WATER COLLECTED FROM OPEN TERRACE SHALL BE COLLECTED THROUGH PIPES AND LED INTO A FILTER PIT (SIZE 60 X 60 X 60 CM) WITH APPROPRIATE FILTER MATERIAL AND THEN LED INTO COLLECTION TANK.
7. SOLAR WATER HEATER LINE ARRANGEMENTS WILL BE PROVIDED.
8. ALL DIMENSIONS ARE IN METRE & FEET.
9. FE - FIRE EXTINGUISHER PROVIDED.

SCHEDULE OF JOINERIES:

TYPE	REFERENCE	SIZE IN METER
MD	MAIN DOOR	1.06 x 2.13
D	FLUSH DOOR	1.00 x 2.13
D1	FLUSH DOOR	0.76 x 2.13
D2	FLUSH DOOR	1.00 x 1.98
O	OPEN	1.00 x 2.13
W1	WINDOW	1.53 x 1.52
W2	WINDOW	1.22 x 1.52
W3	WINDOW	0.91 x 1.52
KW	KITCHEN WINDOW	1.53 x 1.22
V	VENTILATOR	0.91 x 0.76
J	JALLY	0.91 x 1.83

AREA DETAILS

DESCRIPTION	SQ.M
PLOT AREA (as per Document)	405.00
PLOT AREA (as per FMB)	405.00
SUPER IMPOSED PLOT AREA	405.00

DESCRIPTION	F.S.I AREA (in SQ.M)	NON F.S.I AREA (in SQ.M)
-------------	----------------------	--------------------------

DESCRIPTION	83.30	-
PROPOSED GROUND FLOOR	83.30	-
PROPOSED FIRST FLOOR AREA	87.90	-
HEAD ROOM AREA	-	-
TOTAL AREA	171.20	17.66
OPEN SPACE AREA	317.10	

PLOT COVERAGE	=	87.90 / 405.00	X	100	=	21.70%
F.S.I	=	171.20 / 405.00			=	0.42

NOTES:

1. FIRE EXTINGUISHER 9 FE
2. ALL DIMENSION ARE IN METER
3. SCALE - 1:100
4. WASTE WATER UTILISED FOR GARDEN PURPOSE.
5. SOLAR WATER HEATER PROVIDED IN TERRACE FLOOR


APPLICANT

SAKTHIVEL S/O RAJENDRAN

R. Sathivel

ENGINEER

P. Rajapandian
Dr.P.RAJAPANDIAN, B.E.,
CONSULTING CIVIL ENGINEER,
LS.No.090/LS/2020/00005
IDEALSURE CONSTRUCTION FIRM,
KALLANKURICHI ROAD,
KAYARLABATH, ARIYALUR - 621 704.
CELL : 99434 18030

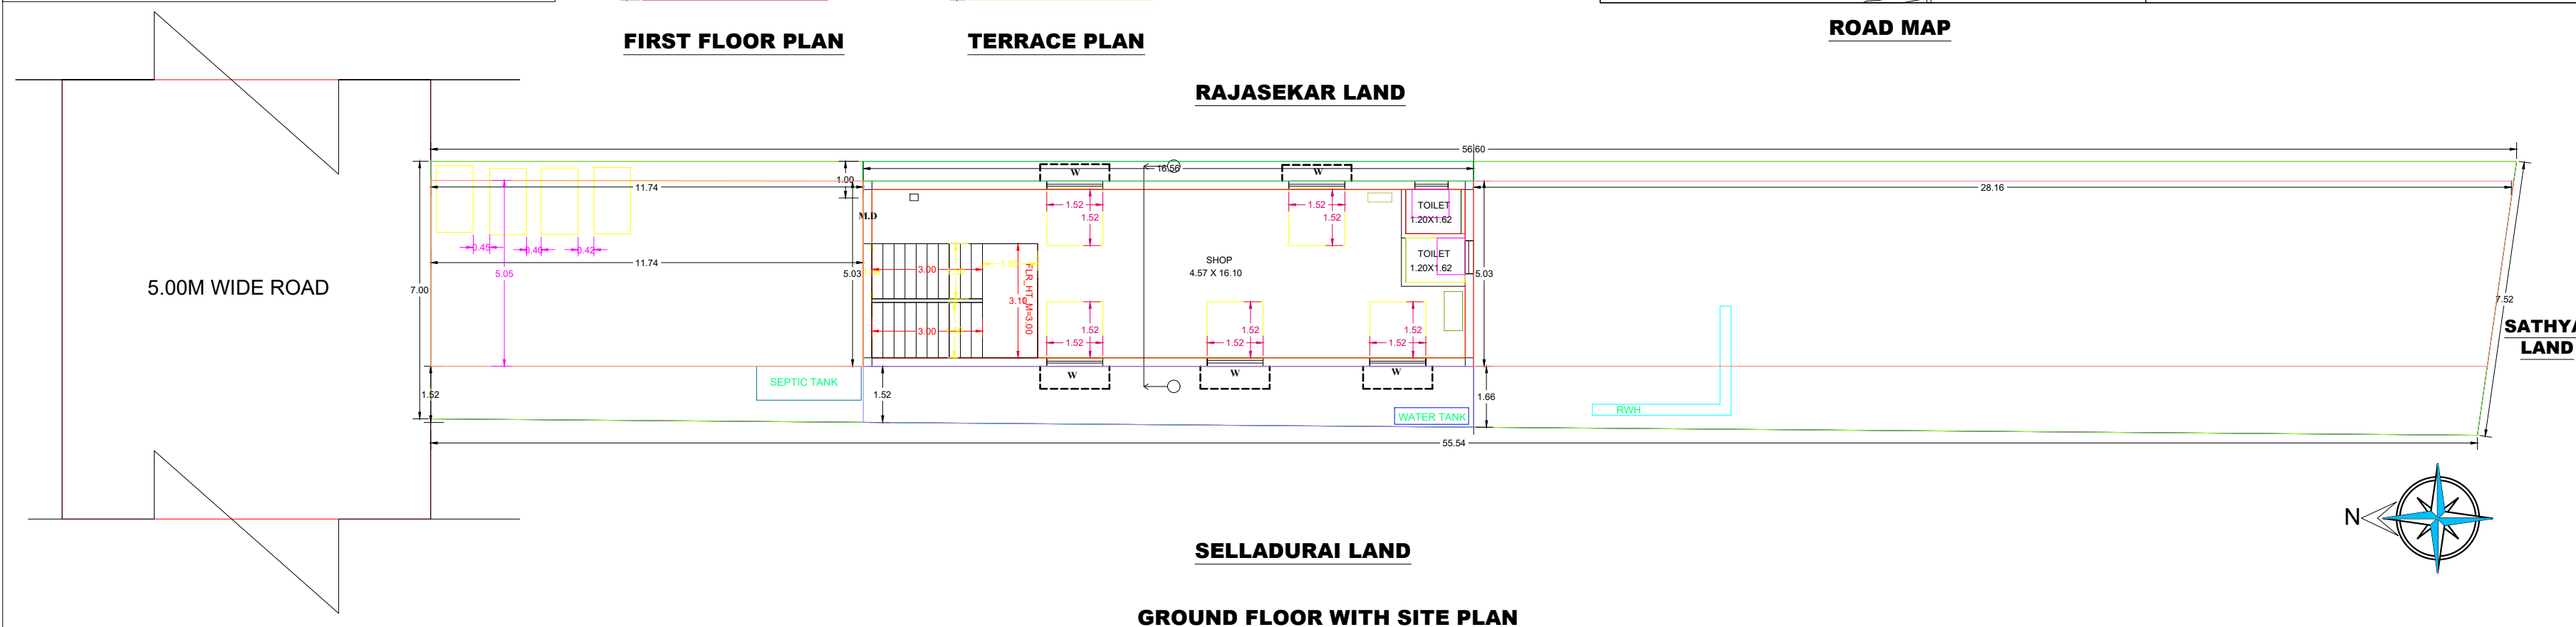

GROUND FLOOR WITH SITE PLAN