



PLAN SHOWING THE PROPOSED GROUND FLOOR CONSTRUCTION OF R.C.C ROOF RESIDENTIAL BUILDING
IN R.S.NO. 181/35 , PATTA NO:5171 ,AT "SRI SARASWATHI NAGAR" KEEZHAPALUVUR VILLAGE PANCHAYAT,
THIRUMANUR -UNION , ARIYALURE - TALUK, ARIYALURE - DISTRICT.

OWNER NAME: Mr.A.RAJESHKUMAR, S/O .ARUMUGAM.

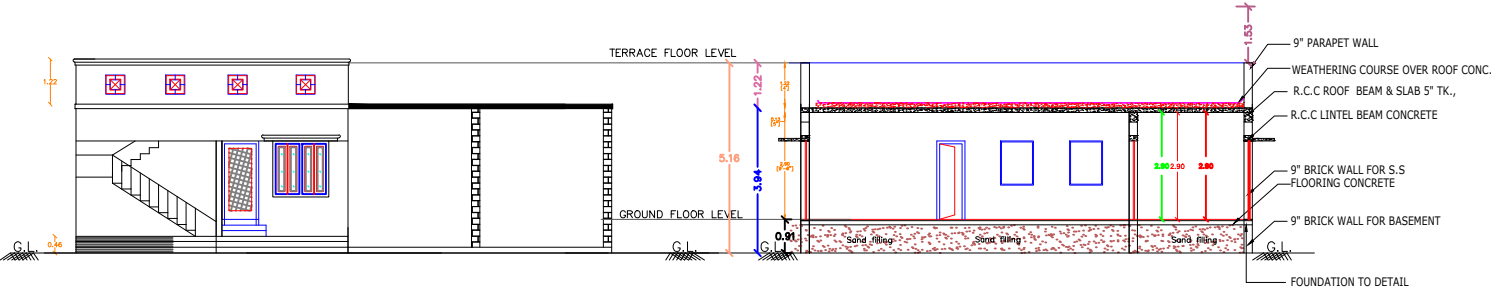


FRONT ELEVATION


SECTION ON 'A-A'

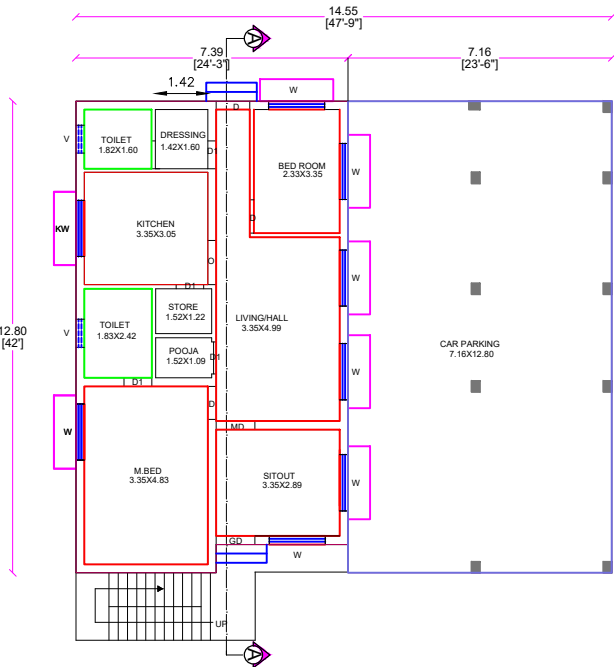


GROUND FLOOR PLAN

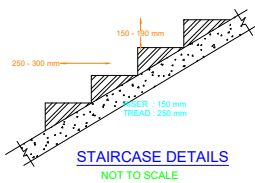


STAIRCASE DETAILS
NOT TO SCALE

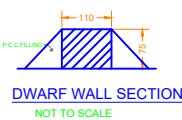


DWARF WALL SECTION
NOT TO SCALE

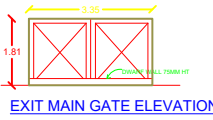


EXIT MAIN GATE ELEVATION

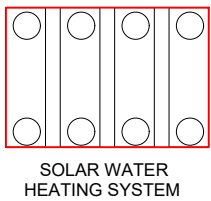


SOLAR WATER
HEATING SYSTEM

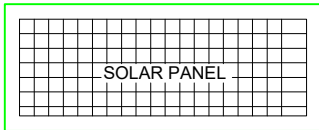

SOLAR PANEL

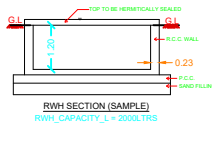


RWV SECTION (SAMPLE)
RWV_CAPACITY = 2000LTRS

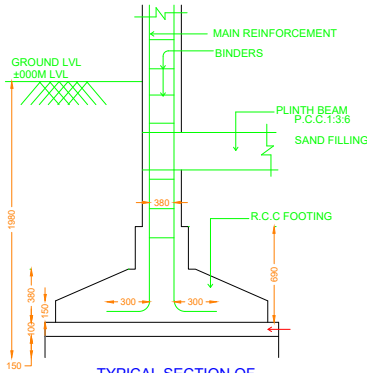


TYPICAL SECTION OF
R.C.C COLUMN FOUNDATION
SCALE : 1" = 2'-0"

KEY PLAN
SCALE:1"=132'0"

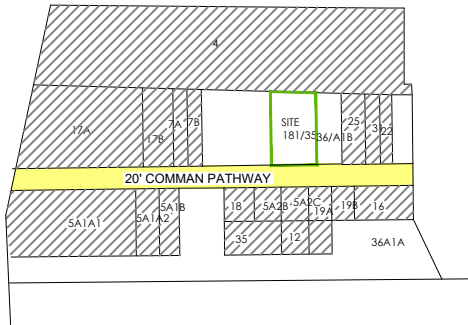


SITE PLAN
SCALE:1:150


PLOT NO:19,20

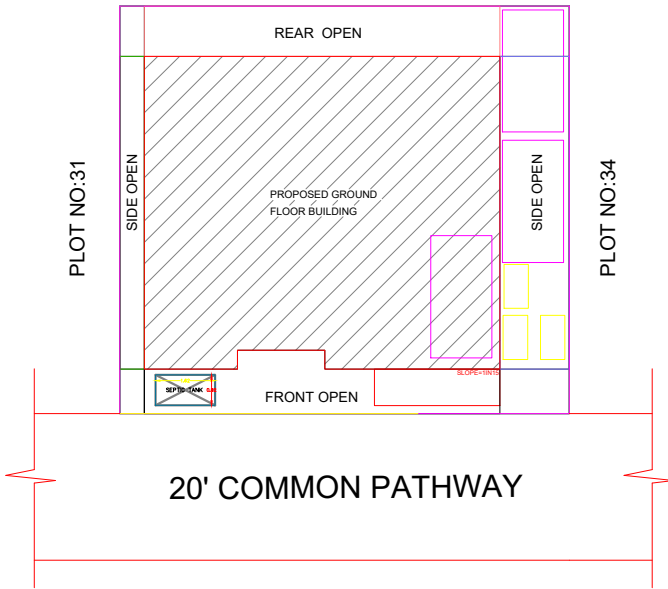


20' COMMON PATHWAY

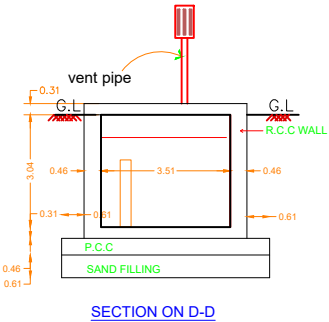


SECTION ON D-D

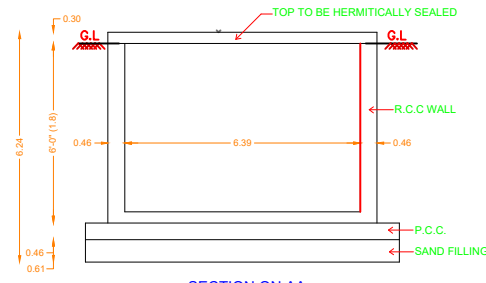

SECTION ON AA

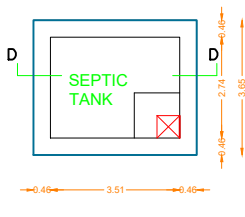

PLAN OF SEPTIC TANK

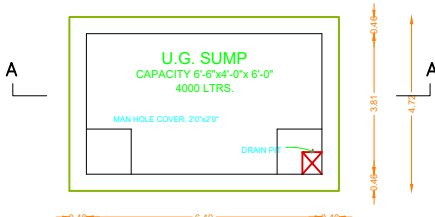

SUMP DETAIL
SCALE 1"=4'0"



SHEET NO=01

COLOUR INDEX:

BOUNDARY - PROPOSED - ROAD -

JOINERY DETAILS :-

S.No.	Description	Feet	Meter	S.No.	Description	Feet	Meter
01	MD - MAIN DOOR	3'3" X 7'0"	1.00 X 2.13	05	W1 - WINDOW	4'0" X 4'6"	1.22 X 1.37
02	D - DOOR	3'0" X 7'0"	0.91 X 2.13	06	W2 - WINDOW	3'0" X 4'6"	0.91 X 1.37
03	D1 - DOOR	2'6" X 7'0"	0.76 X 2.13	07	KW - WINDOW	5'0" X 4'6"	1.52 X 1.37
04	W - WINDOW	5'0" X 4'6"	1.52 X 1.37	08	V - VENTILATOR	2'6" X 2'6"	0.76 X 0.76

--- SPECIFICATION ---

AREA DETAILS :-	In Sq.m	In Sq.ft
AS PER DOC	307.00	3304.50
AS PER PATTA	307.00	3304.50
AS PER DWG./SPLAY	307.00	3304.50

--- AREA CALCULATION ---

FLOOR AREA	F.S.I AREA	NON-F.S.I AREA	TOTAL AREA
in Sq.m	in Sq.ft	in Sq.m	in Sq.ft
GROUND FLOOR	91.83	988.45	91.65
FIRST FLOOR	---	---	---
SECOND FLOOR	---	---	---
HEAD ROOM	---	---	---
TOTAL AREA	91.83	988.45	91.65

FLOOR SPACE INDEX =	183.40	= 0.5973 < 2.0
PLOT COVERAGE =	98.06	X 100 = 59.73%

DWELLING AREA STATEMENT

FLOORS	NO OF DWELLING UNITS	TYPES
GROUND FLOOR	01	10.22
FIRST FLOOR	---	---

--- PARKING DETAILS ---

PARKING TYPE	REQUIRED	PROVIDED
CAR PARKING	02	03
TWO WHEELER	03	03

HEIGHT OF THE BUILDING : 3.94 M

SCALE - 1 : 100


*All dimensions are in feet & inches,those with in brackets are in M.
*Sewage line connected to Septic Tank main line

A. Rajeshkumar

(Mr.RAJESHKUMAR.A)
APPLICANT / OWNER


Er.K.R.SUMITHRA,B.E.,
Registered Engineer (RE),
Register No: RE25/01/006.
KR BUILDERS & PLANNERS
Gandhiji Road,
Keeramangalam - 614 624.
Mob: 9092877431

REGISTERED ENGINEER

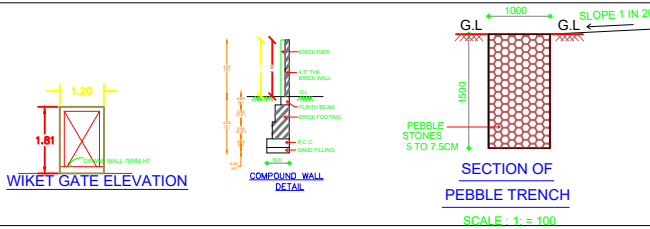

SECTION OF
PEBBLE TRENCH
SCALE : 1" = 100

 WIKET GATE ELEVATION



COMPOUND WALL
DETAIL