

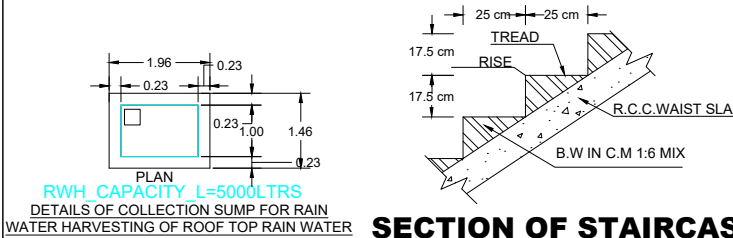


PLAN SHOWING THE PROPOSED CONSTRUCTION OF MUTHU GLOBAL ENTERPRISE AS AC SHEET ROOF COMMERCIAL BUILDING IN S.F.NO.517/8A1 OF KALLANKURICHI VILLAGE AND PANCHAYATH, ARIYALUR TALUK AND ARIYALUR DISTRICT.


(SCALE 1:100)

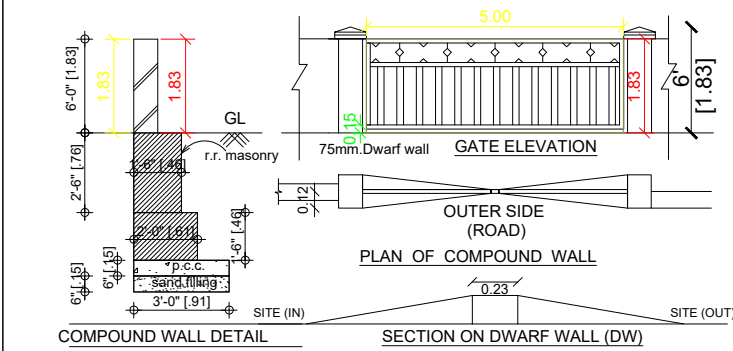



SECTION OF STAIRCASE

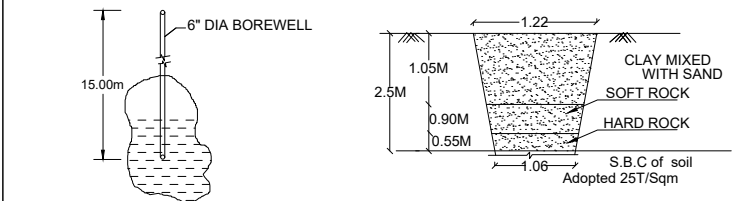


BORE WELL DETAIL TRIAL PIT DETAILS

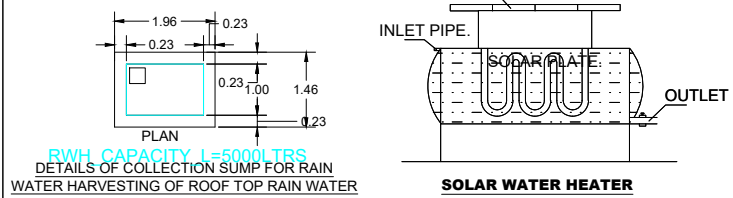


SOLAR WATER HEATER

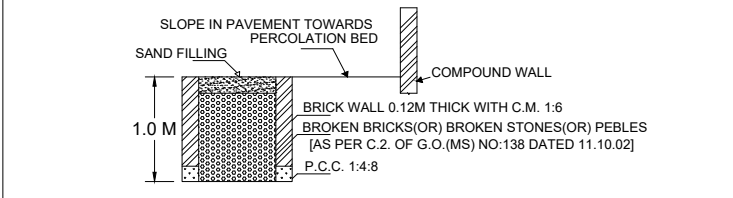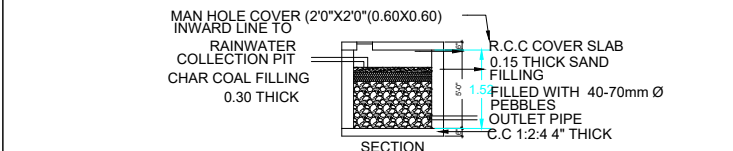


SECTION OF RAIN WATER PERCOLATION BED

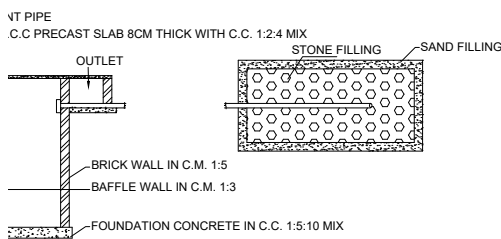


EPTIC TANK & DISPERSION TRENCH

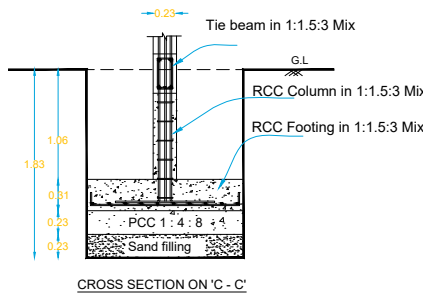


COLOUMN FOUNDATION DETAILS

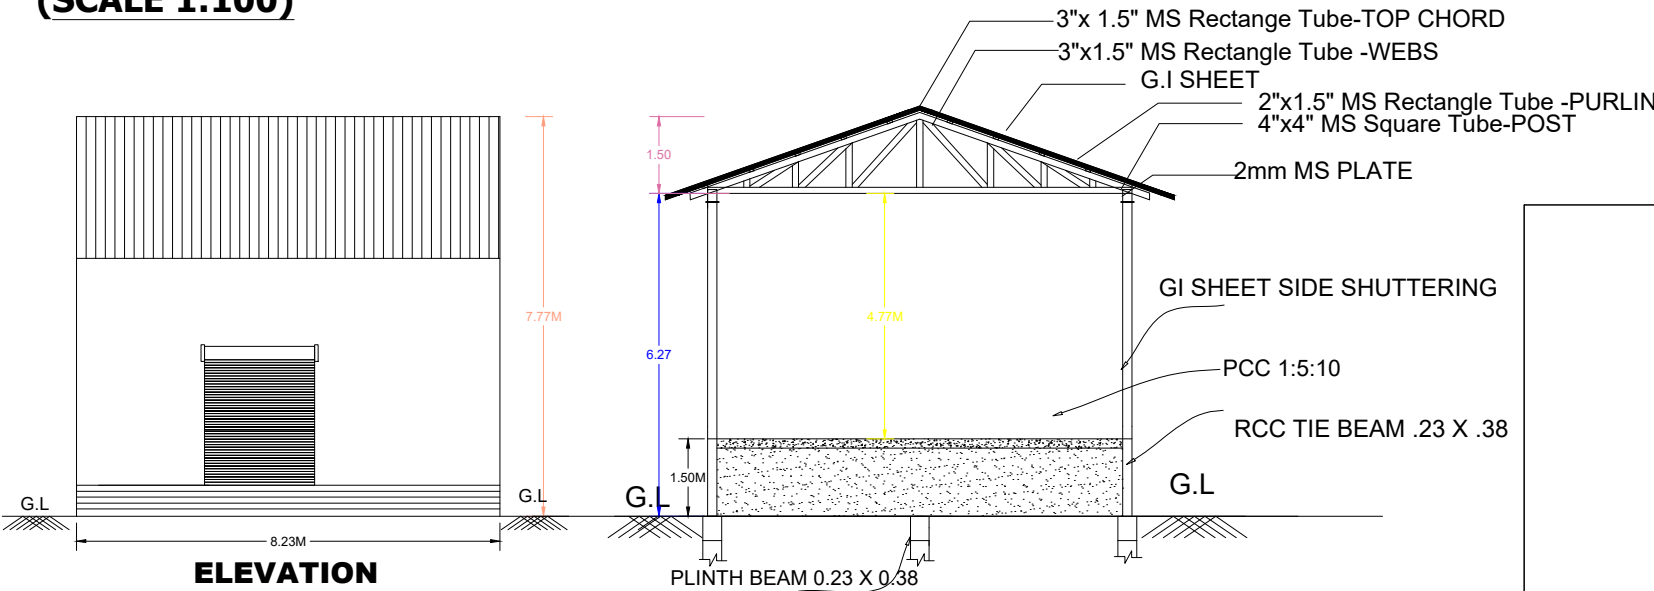


SECTION ON 'A - A'

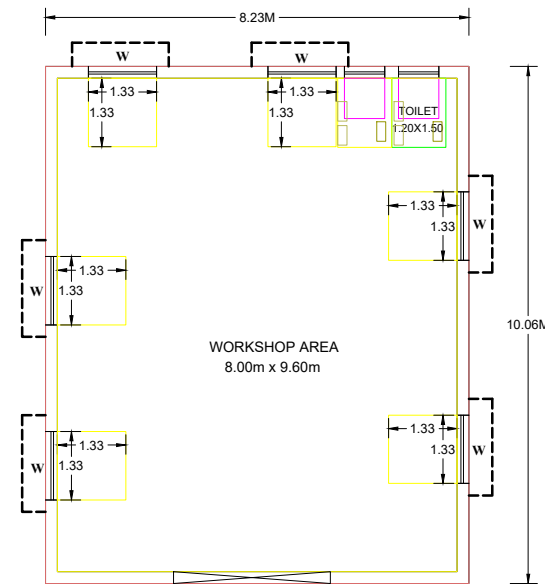

GROUND FLOOR PLAN

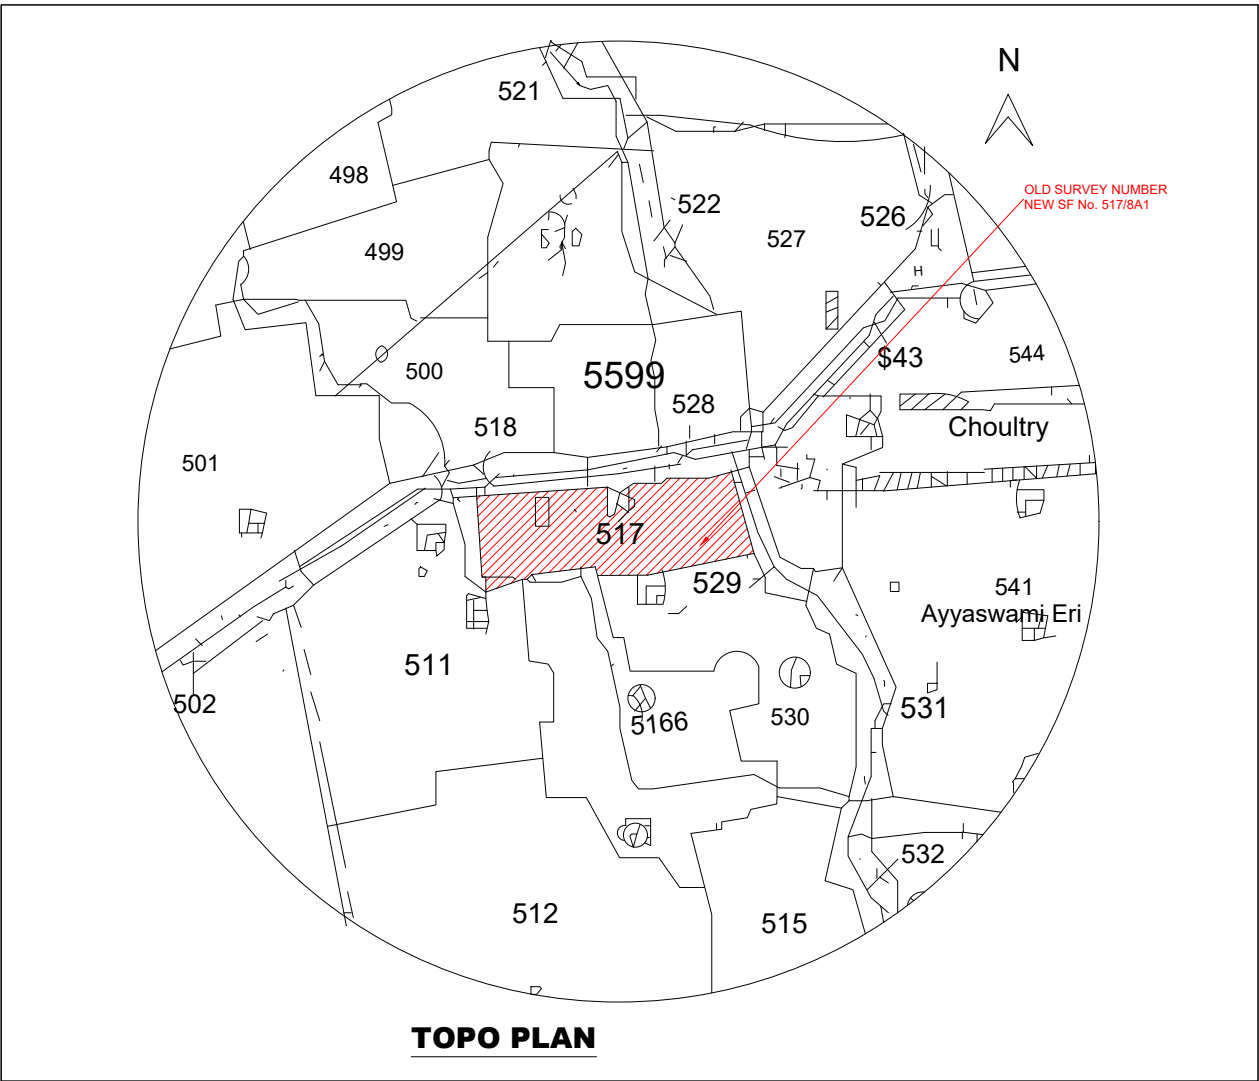

TOPO PLAN

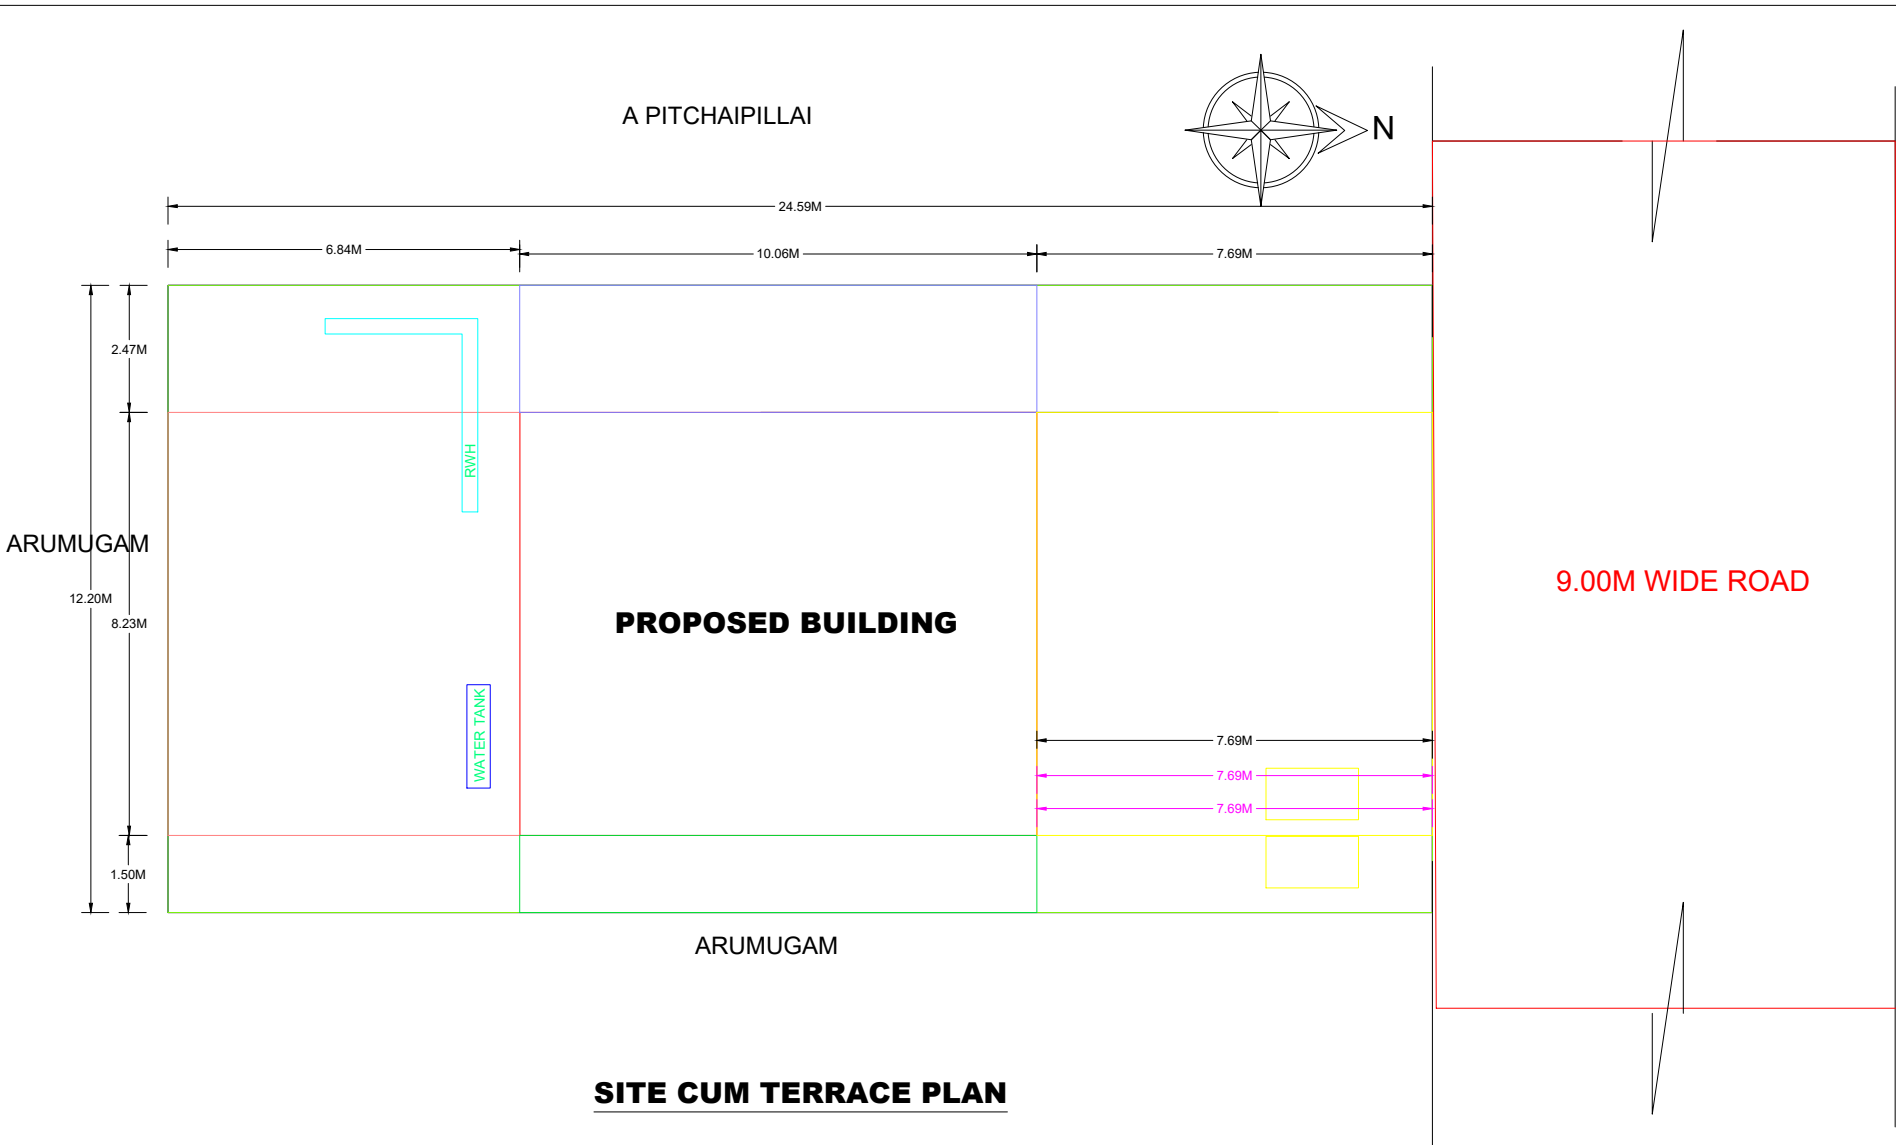

SITE CUM TERRACE PLAN

APPROVING AUTHORITY

SCHEDULE OF JOINERIES:

TYPE	REFERENCE	SIZE IN METER
S	SHUTTERS	2.14 x 2.13
D	FLUSH DOOR	1.00 x 2.13
D1	FLUSH DOOR	0.75 x 2.13
O	OPEN	0.97 x 2.13
W	WINDOW	1.33 x 1.33
V	VENTILATOR	0.79 x 0.91

AREA DETAILS

DESCRIPTION		SQ.M
PLOT AREA (as per Document)		300.00
PLOT AREA (as per FMB)		300.00
SUPER IMPOSED PLOT AREA		300.00
DESCRIPTION	F.S.I AREA (in SQ.M)	NON F.S.I AREA (in SQ.M)
BUILDING PLINTH AREA		
PROPOSED GROUND FLOOR	82.79	-
TOTAL AREA	82.79	-
OPEN SPACE AREA	217.21	

PLOT COVERAGE	=	82.79	X	100	=	27.59%
F.S.I	=	82.79			=	0.72

- NOTES:
1. FIRE EXTINGUISHER
 2. ALL DIMENSION ARE IN METER
 3. SCALE - 1:100
 4. WASTE WATER UTILISED FOR GARDEN PURPOSE.
 5. SOLAR WATER HEATER PROVIDED IN TERRACE FLOOR.

LAND OWNER: A PITCHAIPIILLAI

APPLICANT:

MANIMEGALAI W/O VIJAYAKUMAR

V. Manimegalai

ENGINEER

Er.P.RAJAPANDIAN, B.E.,
CONSULTING CIVIL ENGINEER,
LS.No.090/LS/2020/00005
IDEALSURE CONSTRUCTION FIRM,
KALLANKURICHI ROAD,
KAYARLABATH, ARIYALUR - 621 704.
CELL : 99434 18030