



PLAN SHOWING THE PROPOSED CONSTRUCTION OF RCC ROOF GROUND FLOOR RESIDENTIAL BUILDING IN NEW R.S.NO.82/9B, OLD R.S.NO.82/10,9B, PATTa NO.6771 AT SENDURAI VILLAGE & PANCHAYAT, SENDURAI TALUK, ARIYALUR DISTRICT.

Name of Applicant :- 1. Mr.A.Isaiamudhan, S/o.Mr.Akilan (Minor)
2.Mrs.S.Ambiga, W/o.Mr.Akilan (Guardian)



(SCALE 1:100)

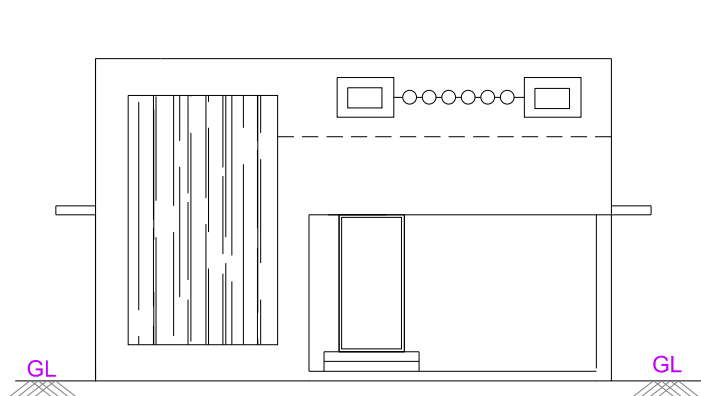

FRONT ELEVATION

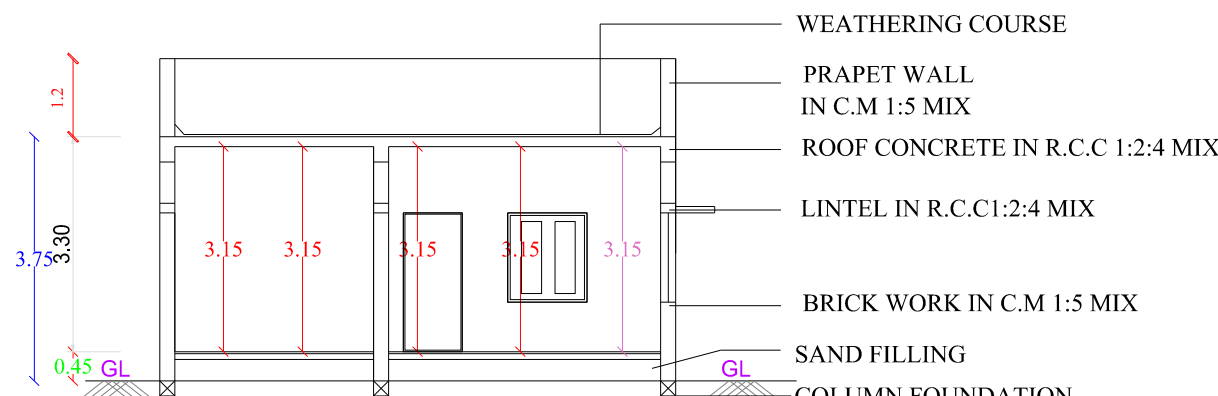


SECTION -XX

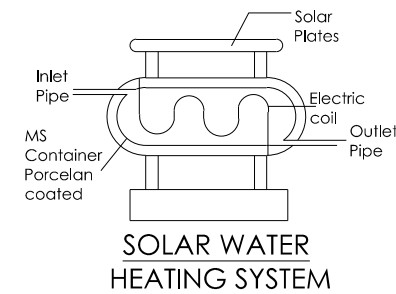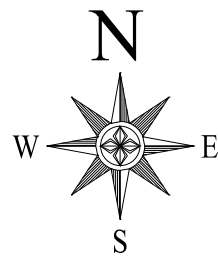


SOLAR WATER HEATING SYSTEM


IBRAKIM RAWUTHAR LAND

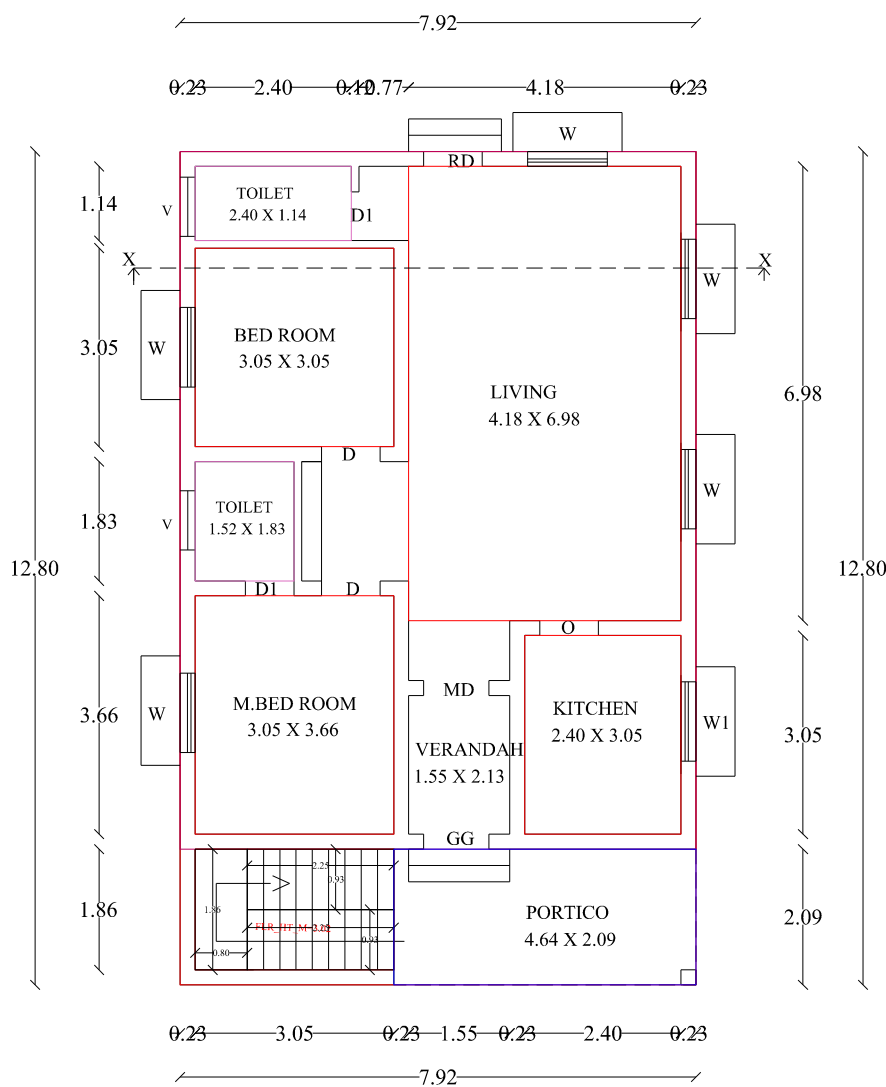


GROUND FLOOR PLAN

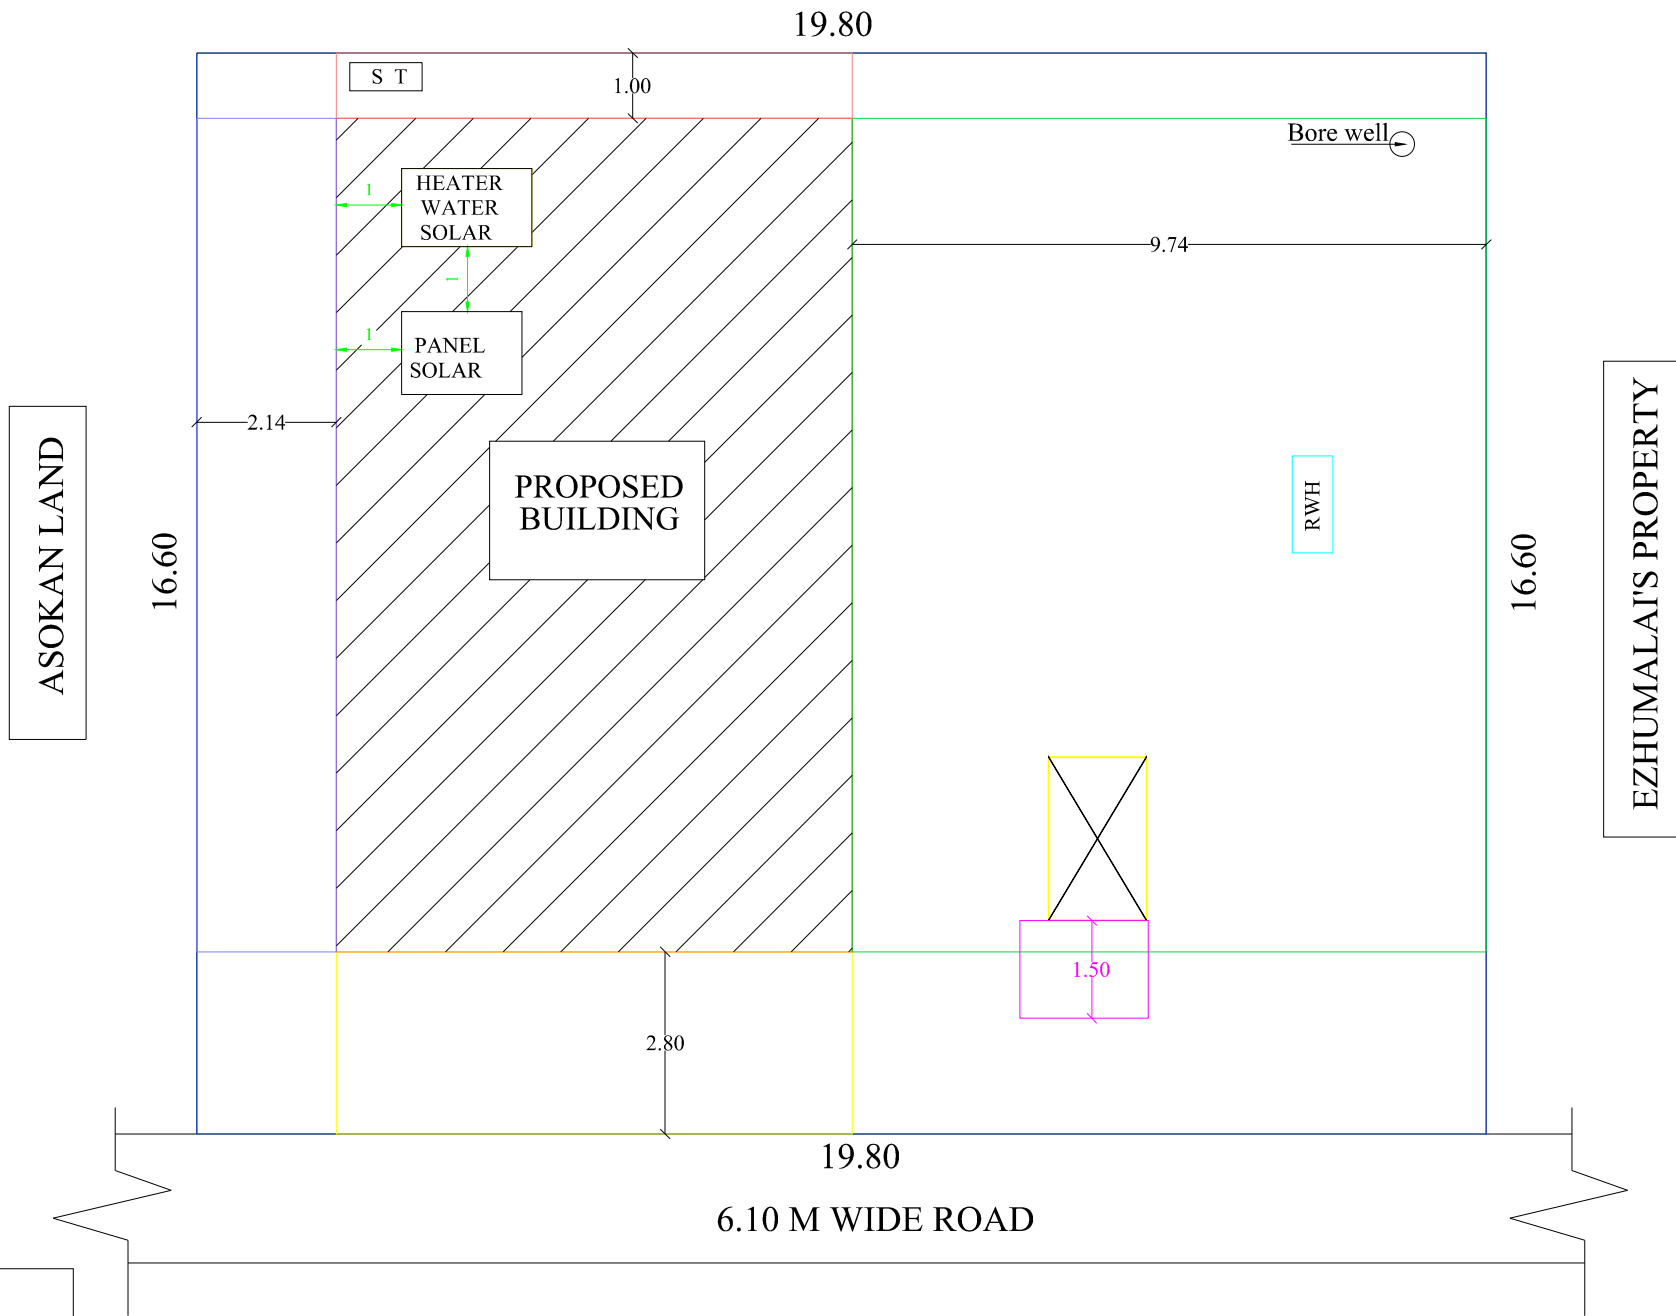


SITE PLAN
(SCALE 1:100)

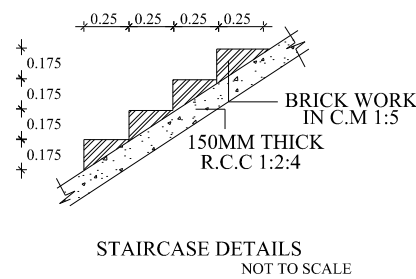


STAIRCASE DETAILS
NOT TO SCALE

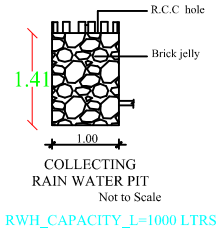

COLLECTING RAIN WATER PIT
NOT TO SCALE

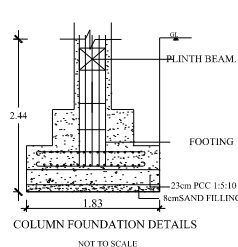

COLUMN FOUNDATION DETAILS
NOT TO SCALE

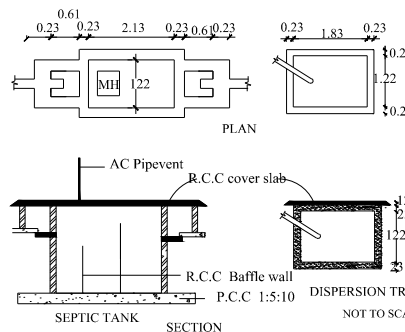

SEPTIC TANK
NOT TO SCALE

JOINERIES DETAILS

MAIN DOOR	MD	1.22 x 2.14
DOOR	D	0.91 x 2.14
DOOR	D1	0.76 x 2.14
WINDOW	W	1.22 x 1.37
WINDOW	W1	1.22 x 1.07
VENTILATOR	V	0.91 x 0.61

AREA CALCULATION

DESCRIPTION	AREA IN Sq.M	AREA IN Sq.Ft.
AREA OF THE SITE	322.63	3472.80
PRO. GROUND FLOOR	101.38	1091.25
OPEN SPACE	221.25	2381.55

COLOUR INDEX

BOUNDARY		PROPOSAL	
EXISTING		ROAD	

NOTES

- * All Dimensions are in Meters
- * Scale - 1:100
- * Sewer line connected with SEPTIC TANK
- * Kitchen, Bath & Wash basin water will be separated and connected with rain water recharge pit

Applicant


S. Ambiga

Mrs.S.Ambiga (Guardian)

Engineer

Er.S.SENTHIL KUMAR, B.E., M.Tech.(Structural),
Registered Engineer, Municipality - DTCP,
Reg.No: 090/LS/2019/00001,
Regd.No: RCE/PBLR/2019/053, Regd.No: RE/PBLR/2019/018,
RSB Construction, ARIYALUR.
Cell No: 9842473689.

Pro Site

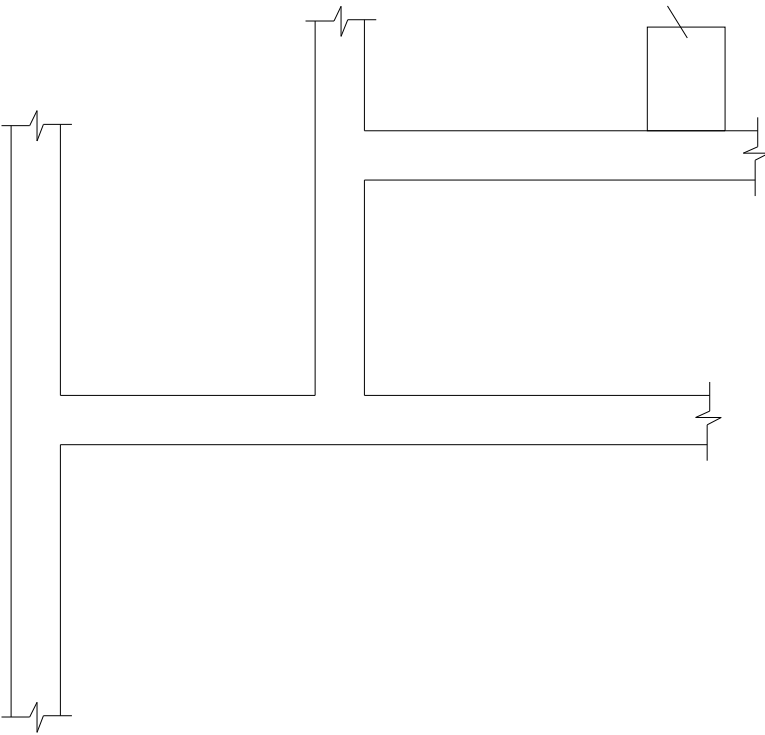

KEYPLAN PLAN
(NOT TO SCALE)

