




PLAN SHOWING THE PROPOSED CONSTRUCTION OF RESIDENTIAL BUILDING IN SF.NO: 124/3N,124/4E,124/6,125/2H AT ARIYALUR NORTH VILLAGE,ERUTHUKARANPATTI PANCHAYAT,[ANNA NAGAR] ARIYALUR TALUK ,ARIYALUR DISTRICT

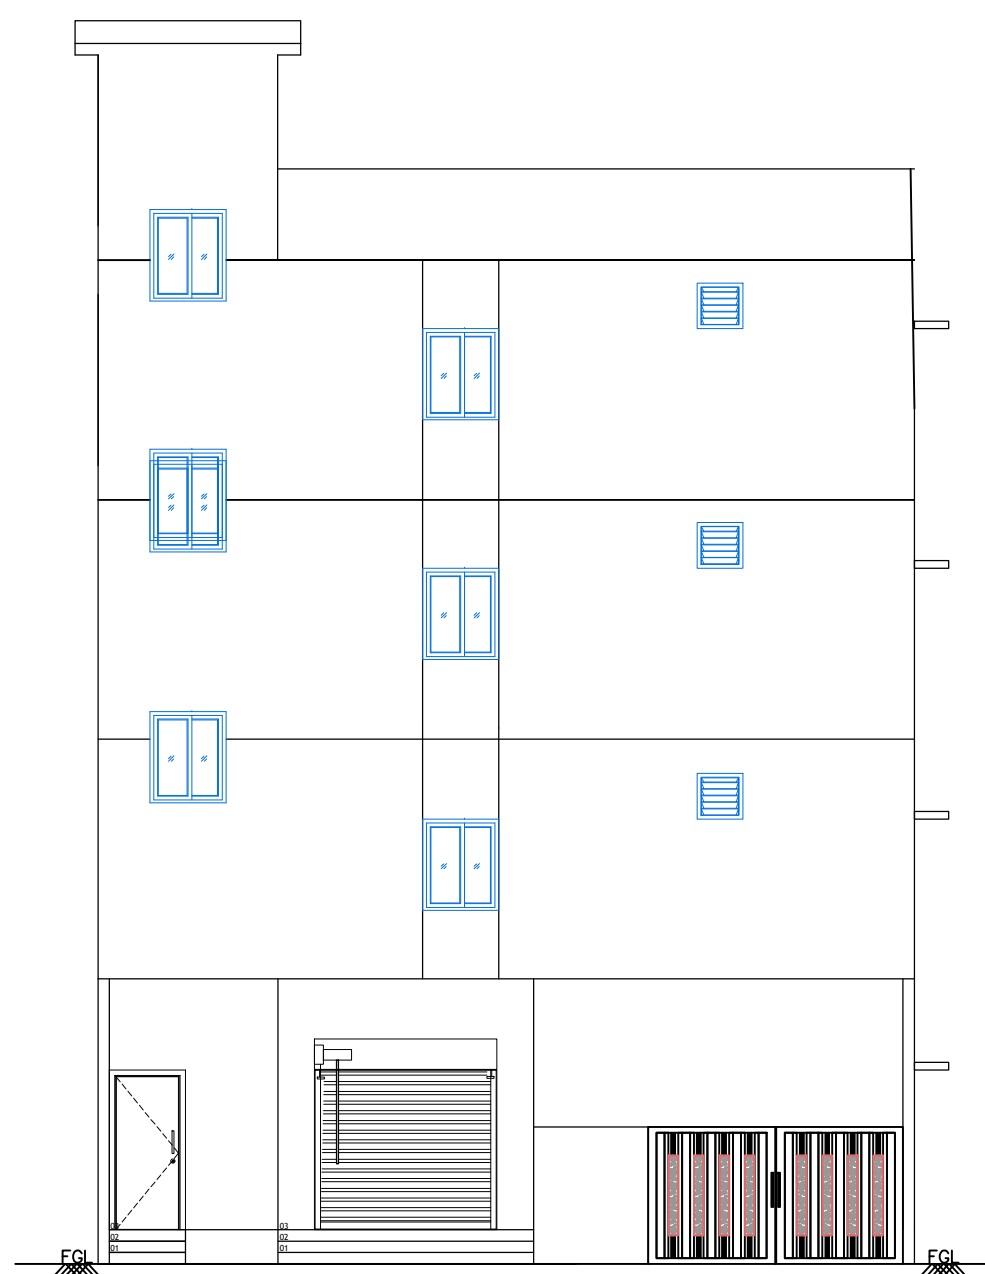


ELEVATION

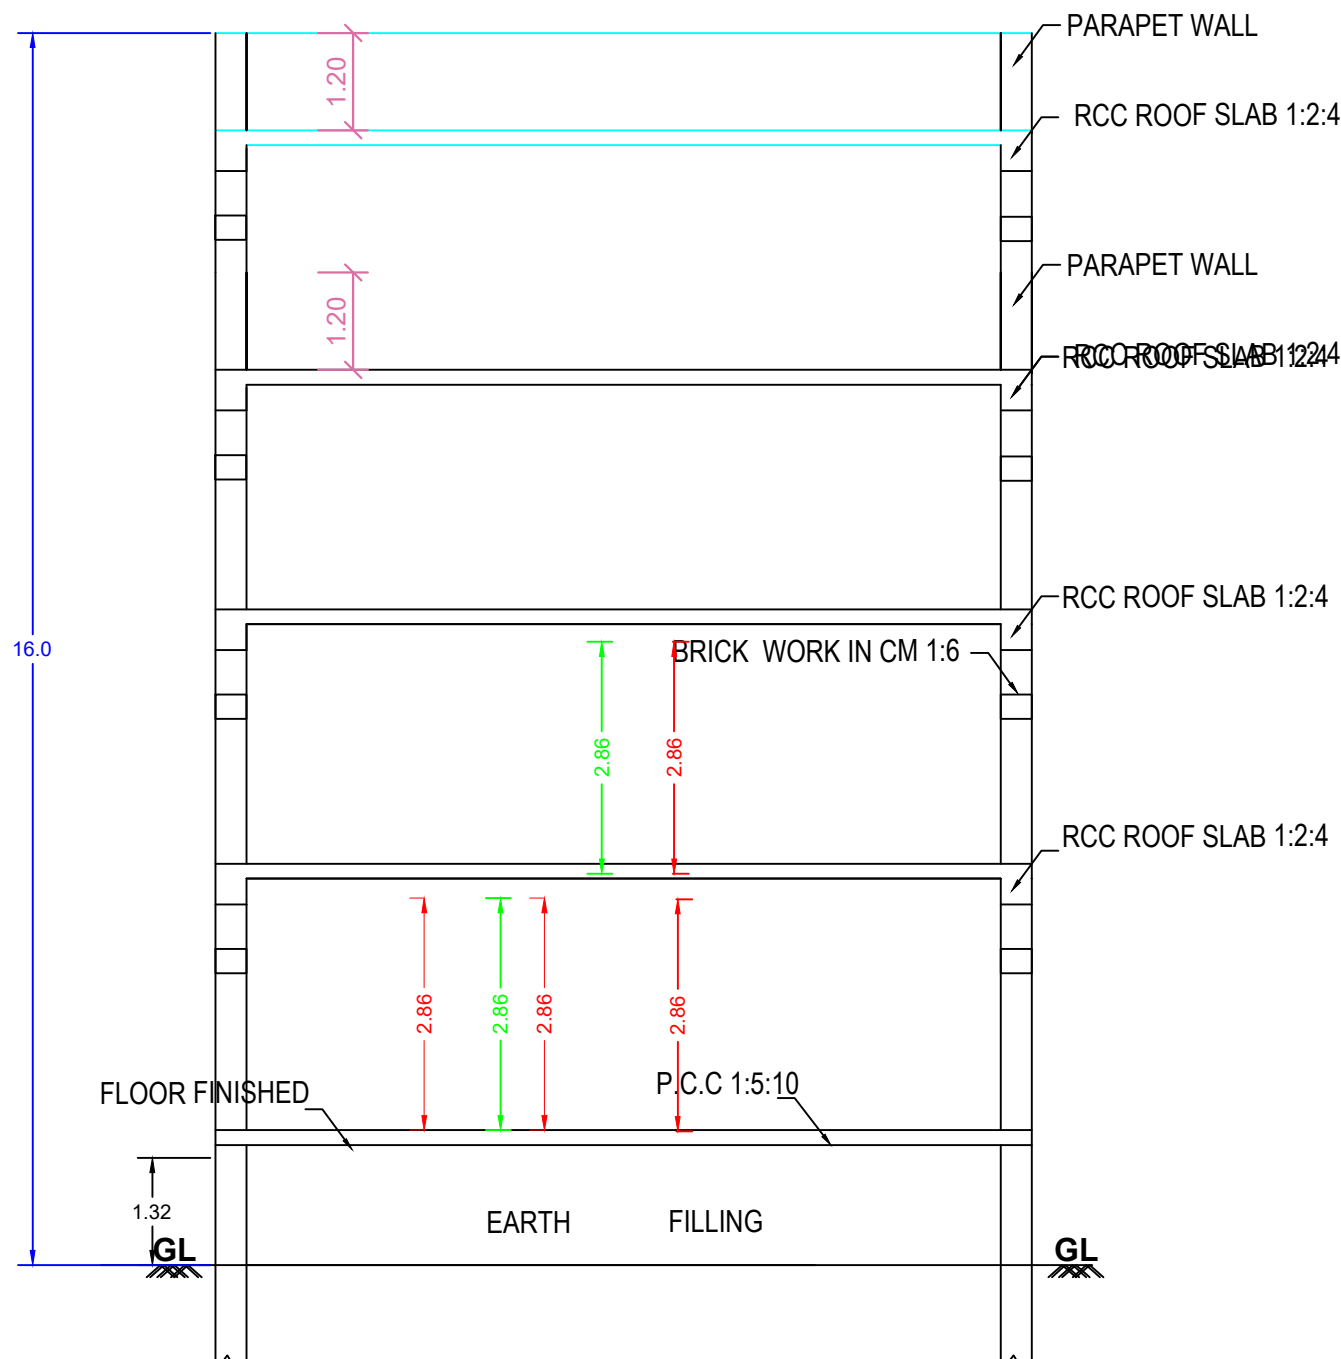

SECTION ON -AB

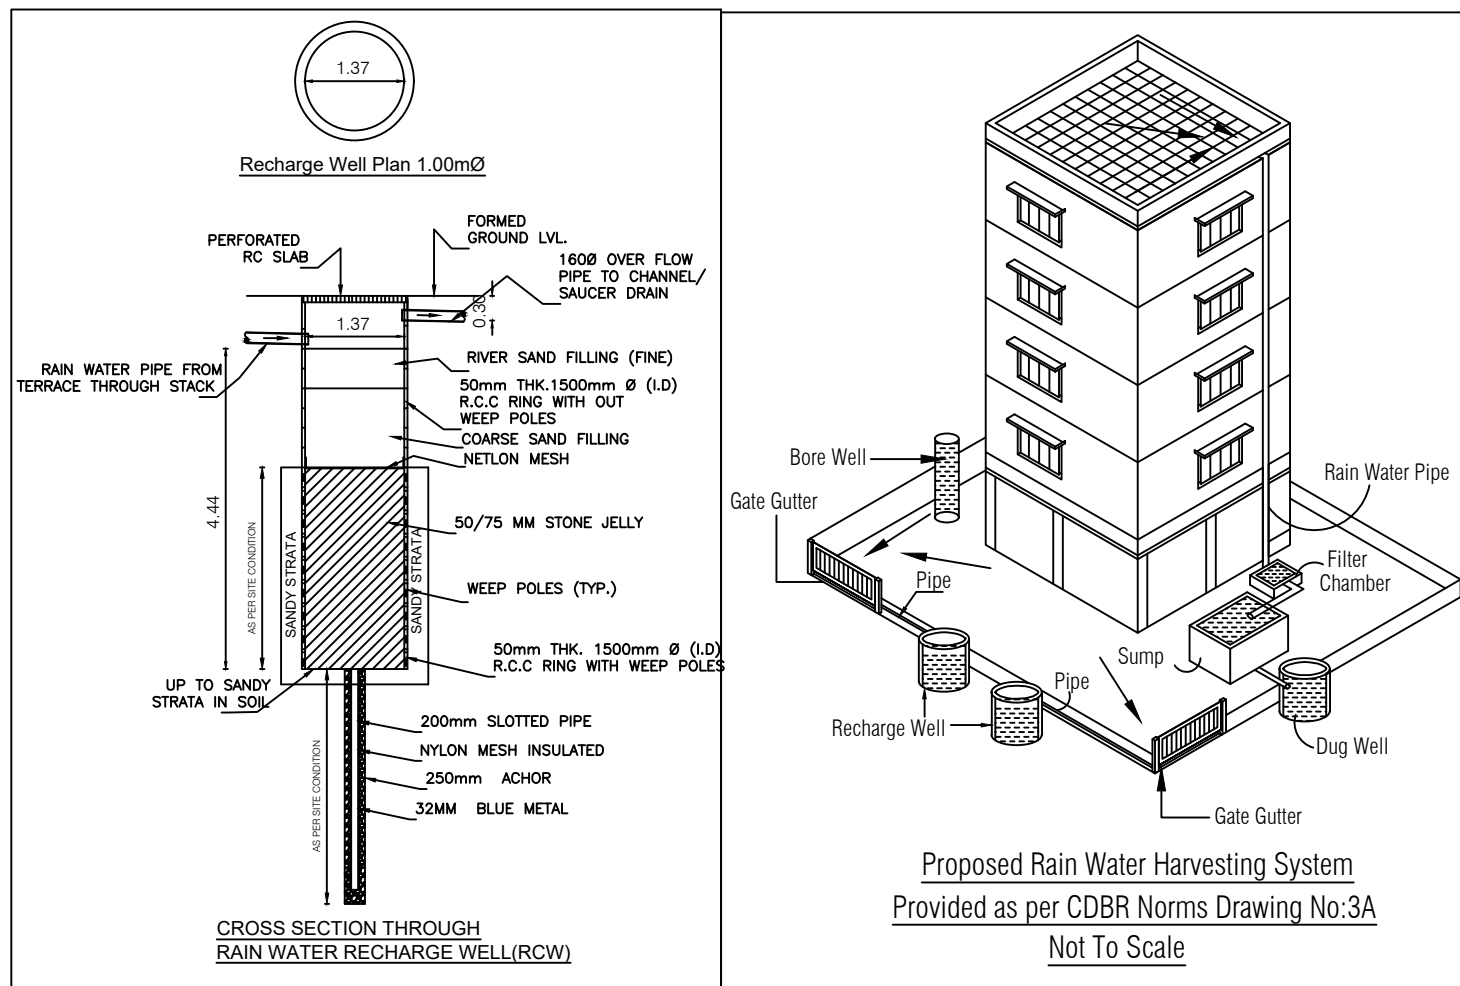


RAIN WATER HARVESTING:

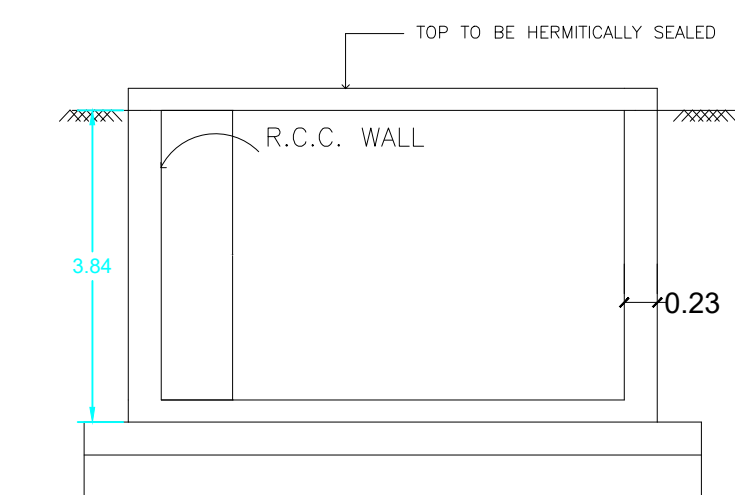


RWH_CAPACITY_L=5000LTRS
RWH_CAPACITY_L=5000LTRS



SOLAR SYSTEM

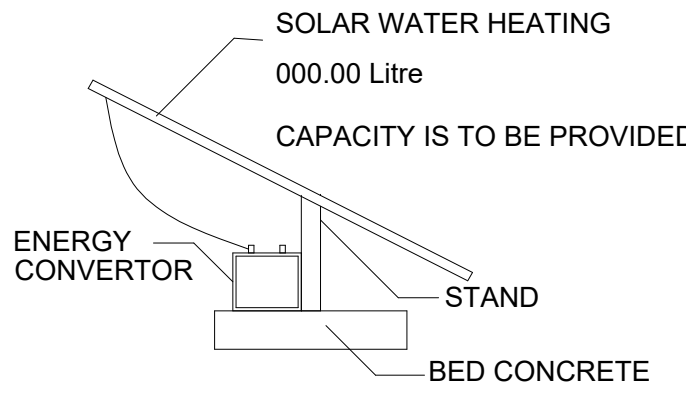


LONGITUDINAL SECTION

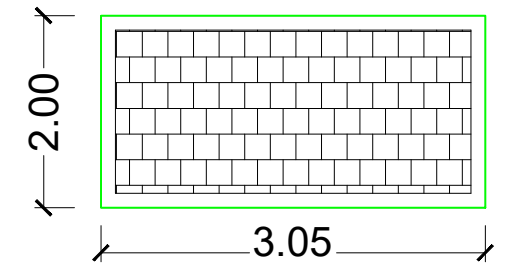


PERCOLATION PIT

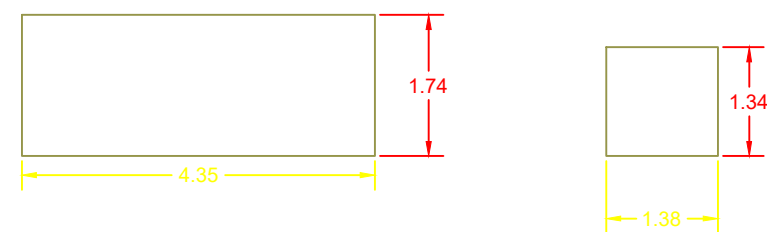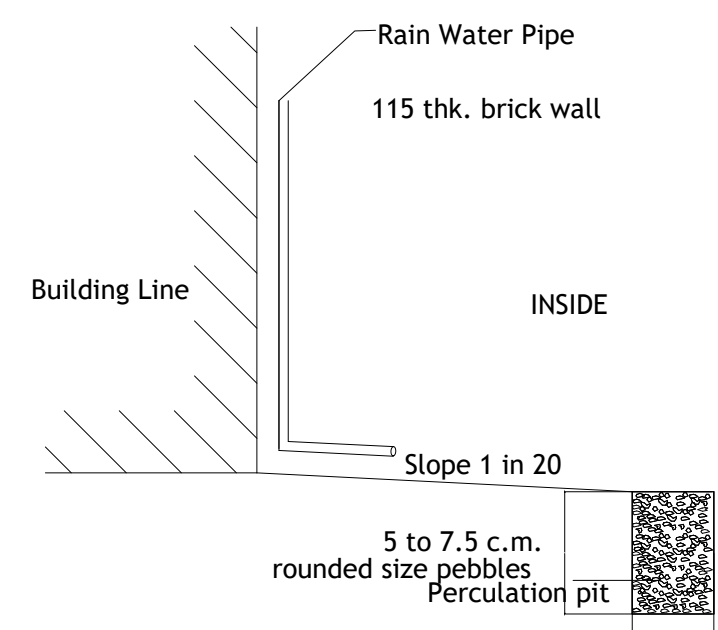

FOUNDATION DETAILS

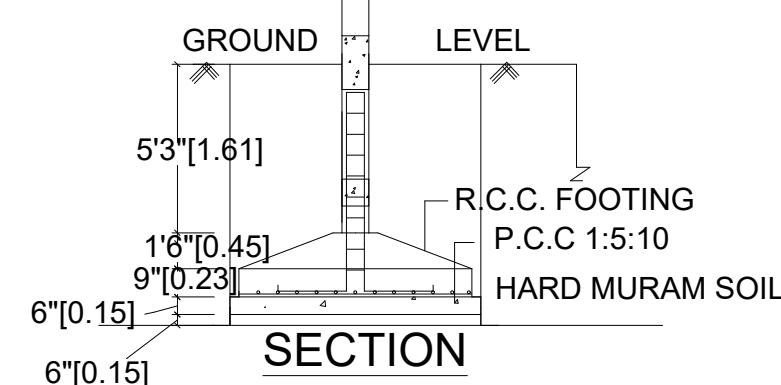


SECTION

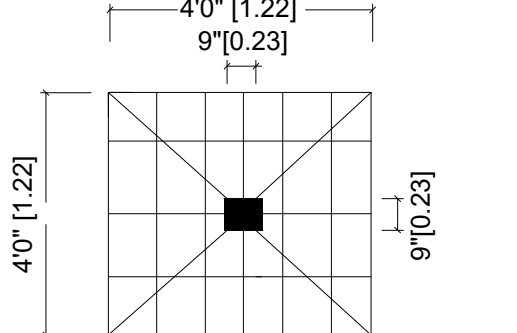


PLAN

COLUMN SIZE = 0'9" X 0'9"

SEPTIC TANK:

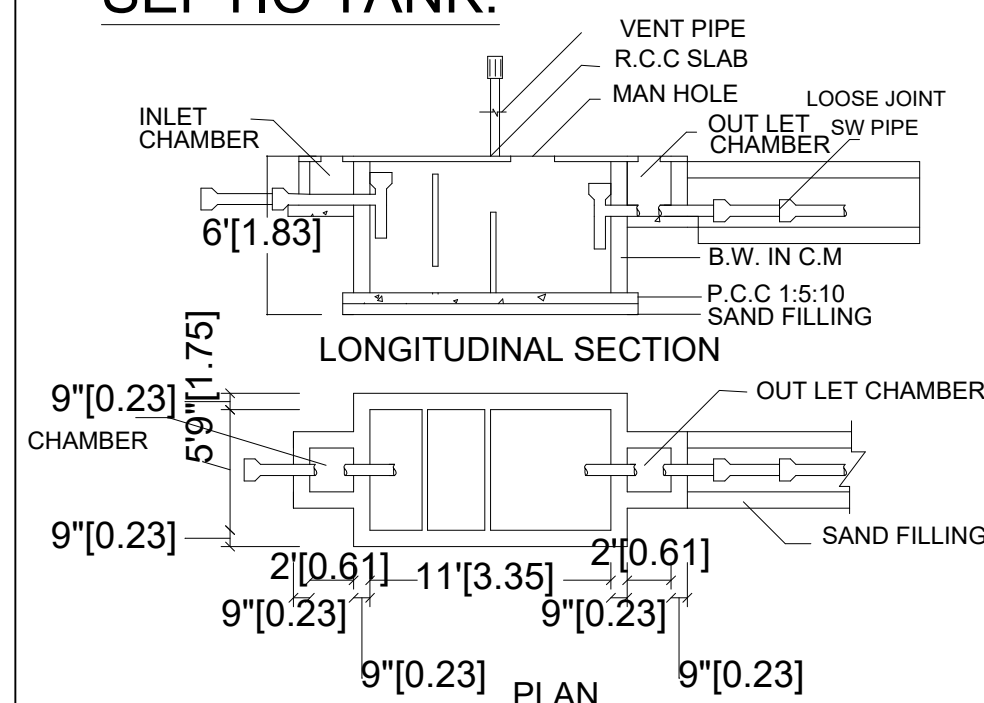

STAIR CASE DETAILS:-

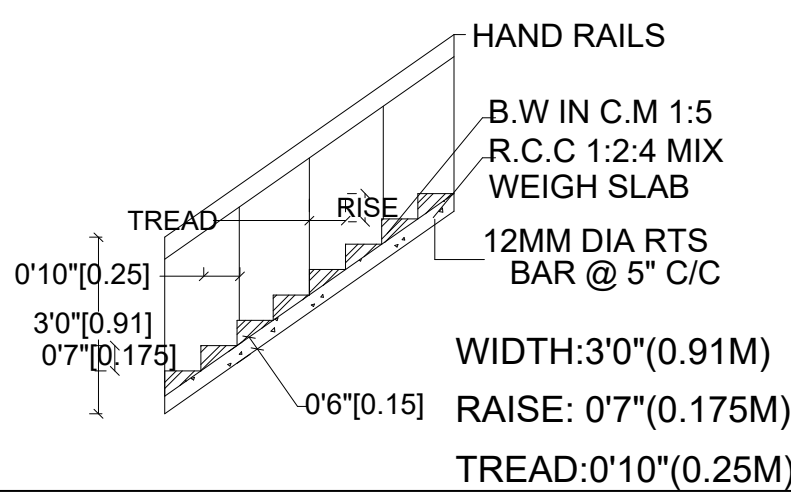


SCALE :-

ALL DIMENSIONS ARE IN FEET & METER
SCALE 1 : 100 OR 1" = 8'0"

KEY PLAN

NOT TO SCALE :-

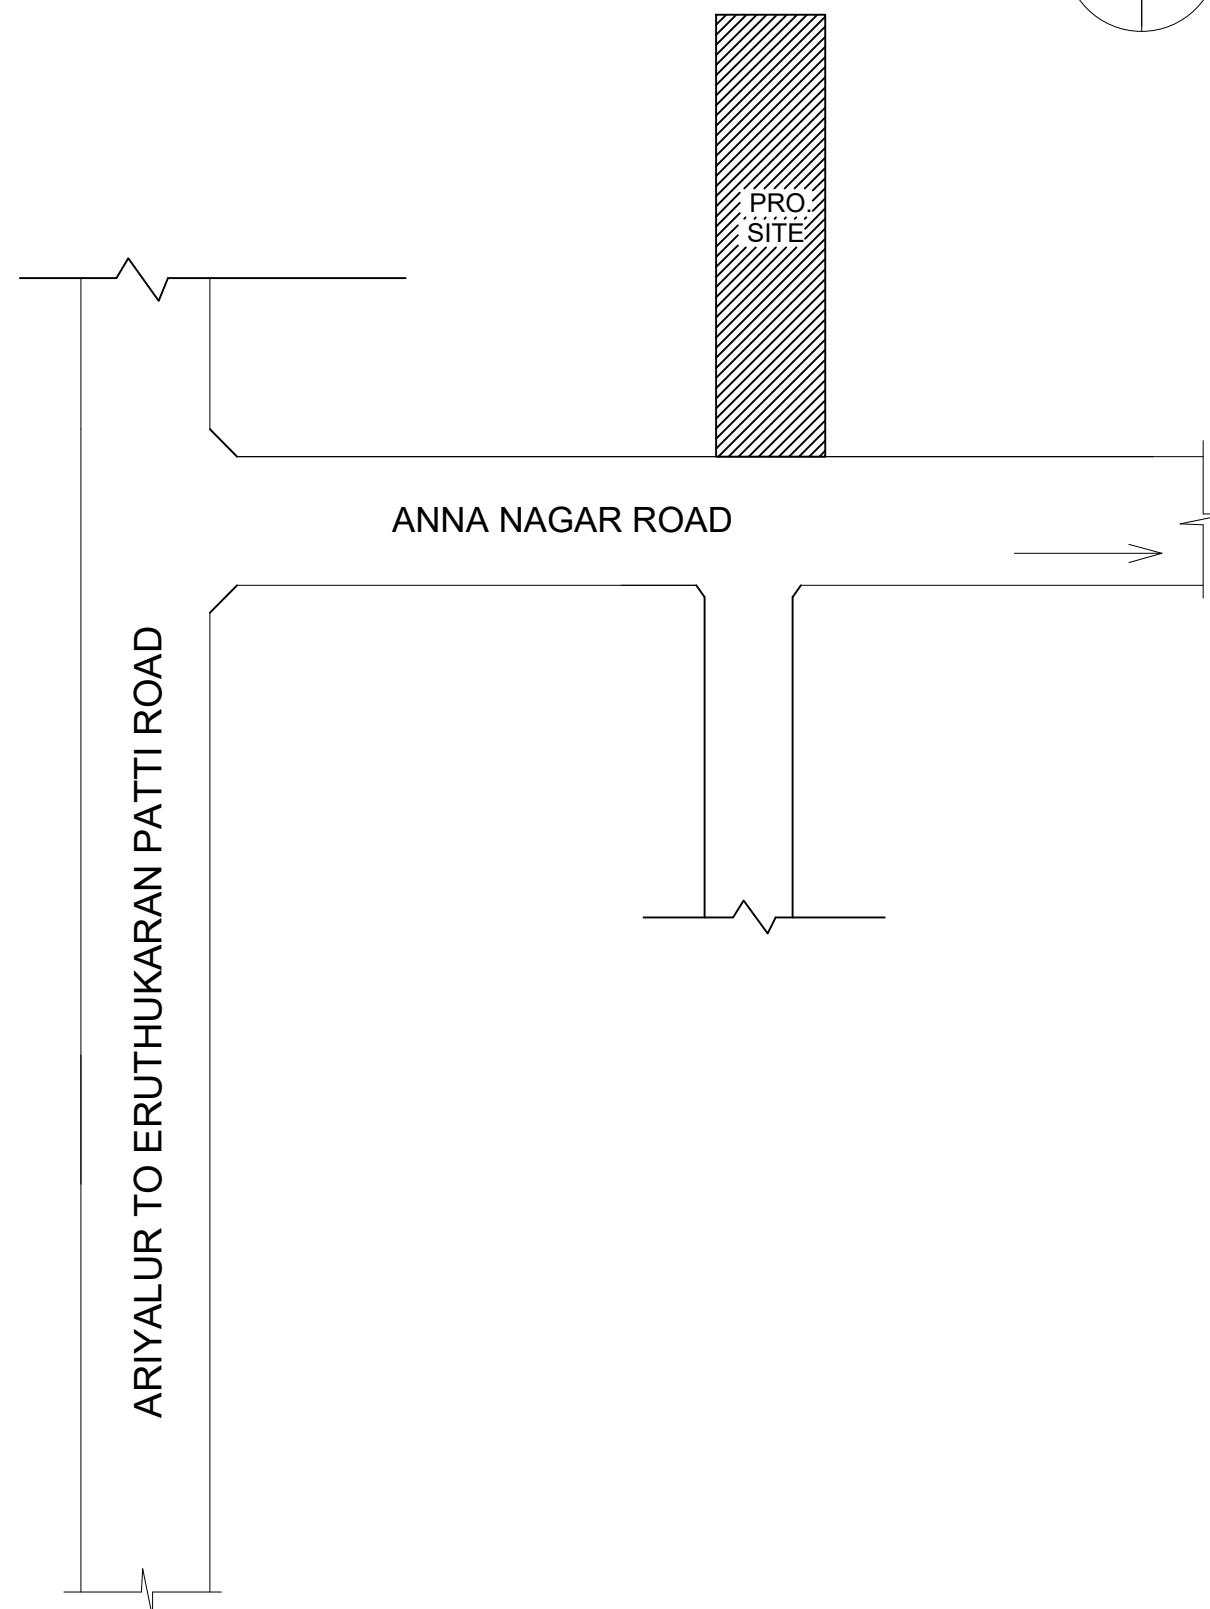


AREA DETAILS :-

1.	AREA OF THE SITE	260.12 Sq.M	2800.00Sq.ft
2.	EXI.GROUND FLOOR AREA	186.91Sq.M	2011.89Sq.M
3.	EXI.FIRST FLOOR AREA	186.91Sq.M	2011.89Sq.M
4.	EXI.SECOND FLOOR AREA	186.91Sq.M	2011.89Sq.M
5.	PRO.THIRD FLOOR AREA	186.91Sq.M	2011.89Sq.M

JOINERY DETAILS :-

S.NO	DESCRIPTION	SIZE IN M
1	ROLLING SHUTTER-R.S	2.14 X 2.14
2	DOOR - D	0.91 X 2.14
3	DOOR - D1	0.76 X 2.14
4	WINDOW - W	1.83 X 1.52
5	VENTILATOR - V	0.91 X 0.61

APPLICANT:-

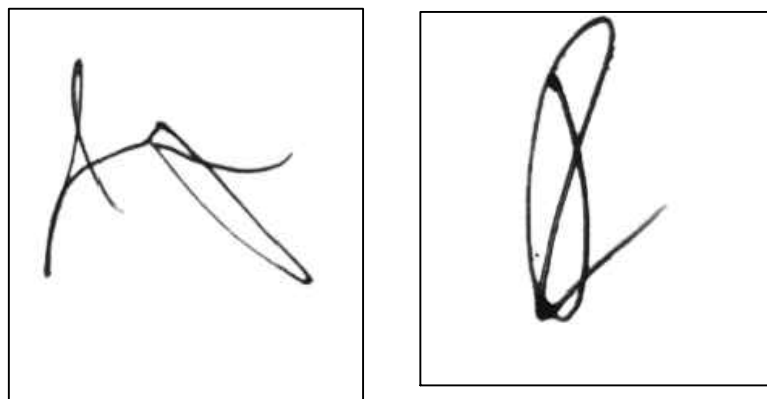


ENGINEER:-


S.Arj
Er.S.ARUNKUMAR,DCE.,
DTCP Registered Engineer
No.AYR/RE/GR.III/2024/003
KANDHAN PLANNERS & CONSTRUCTION
Sendurai Road, Ariyalur - 621 704.
Cell : 76399 55729.

PLOT NO.45
RESIDENTIAL BUILDING


PLOT NO.43
RESIDENTIAL BUILDING

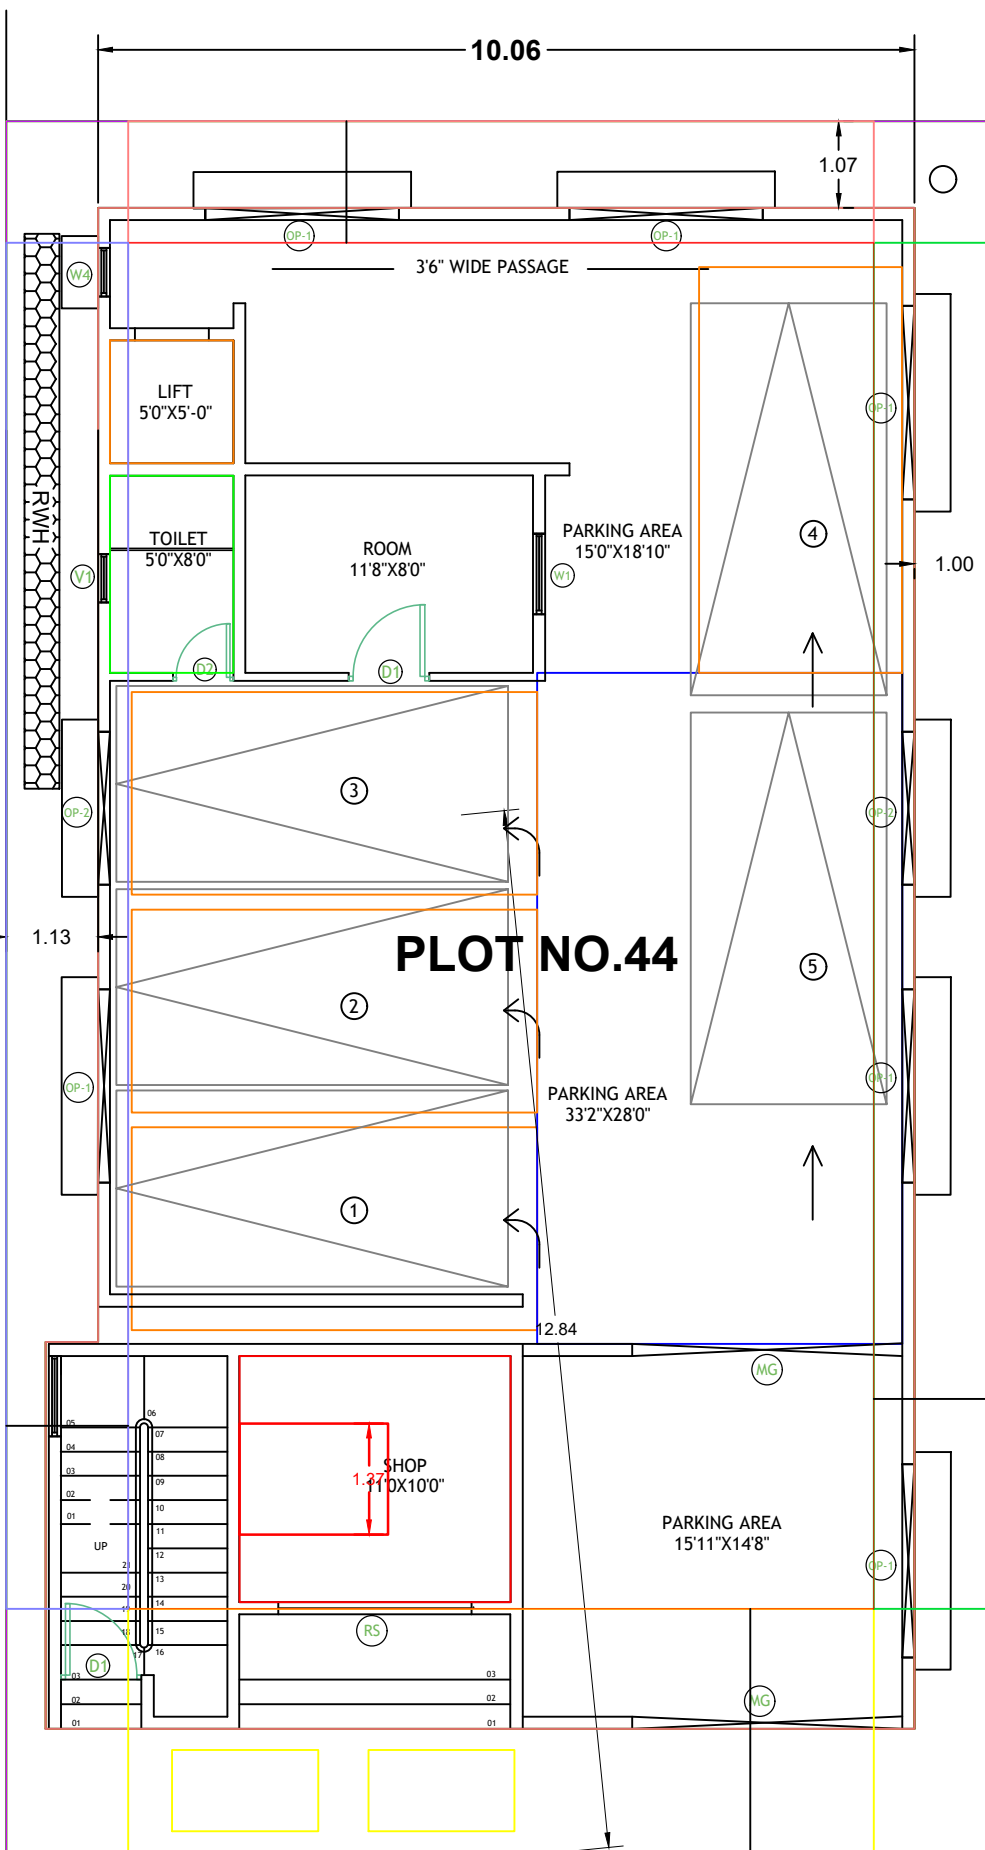


EXI.GROUND FLOOR PLAN

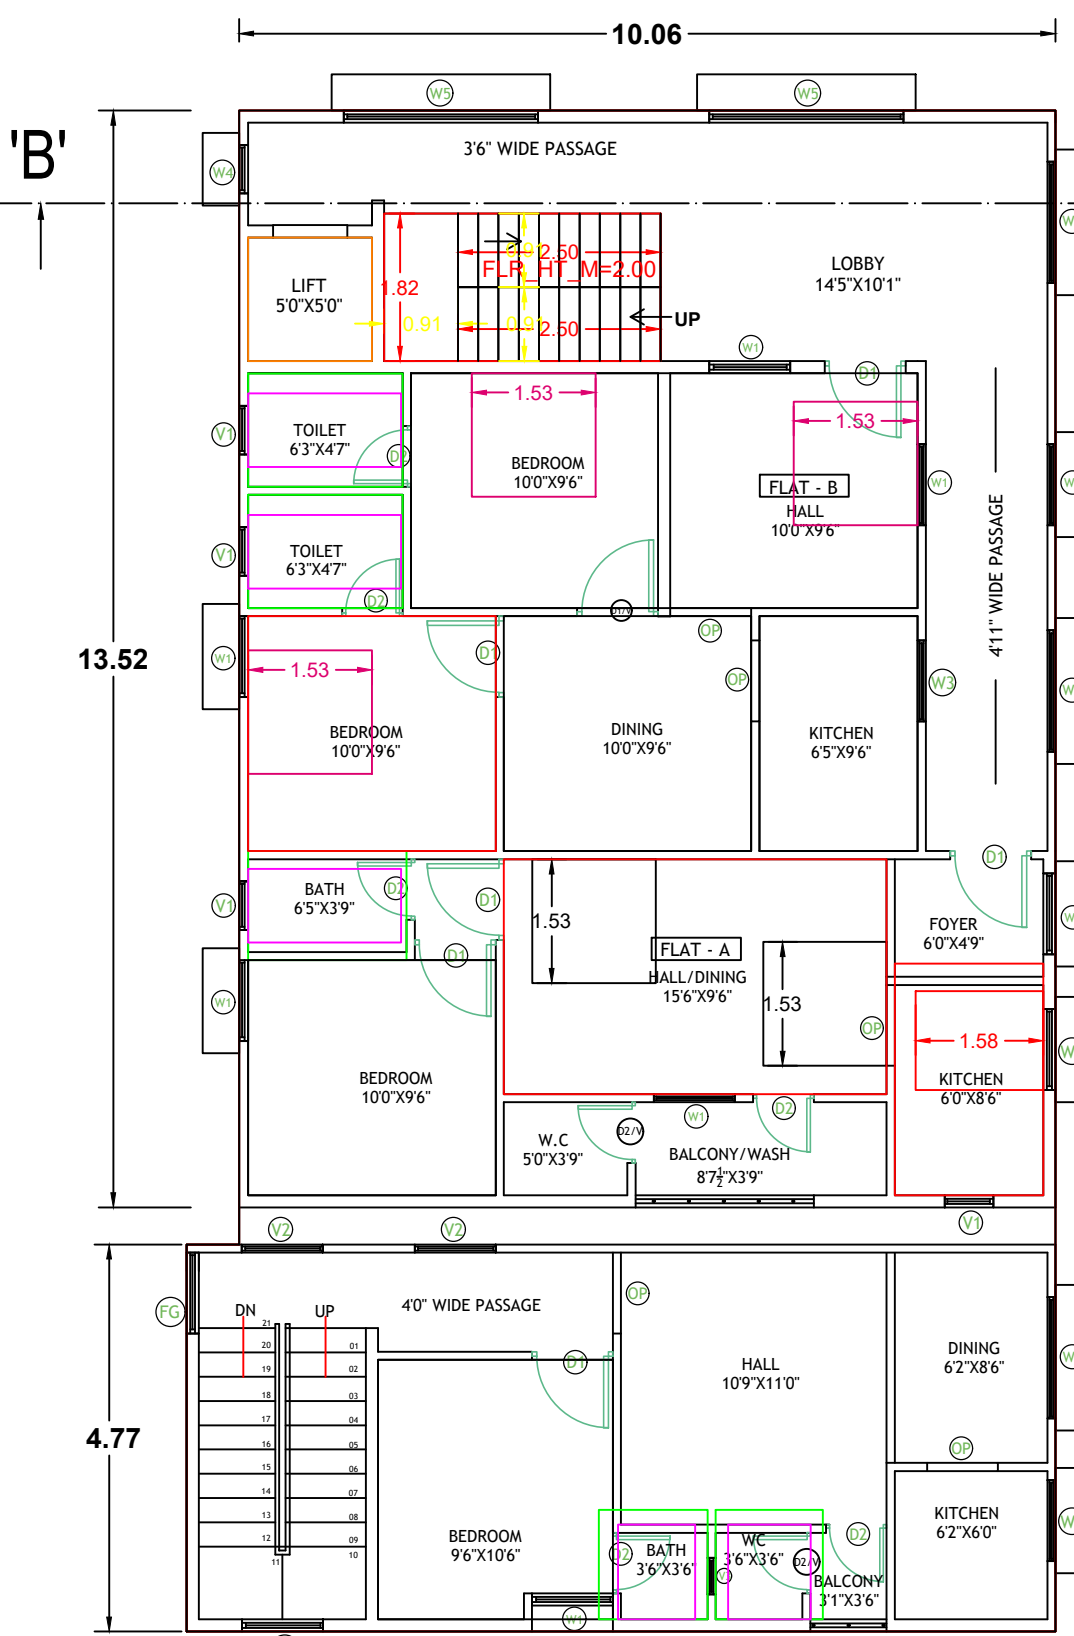

EXI.FIRST FLOOR PLAN

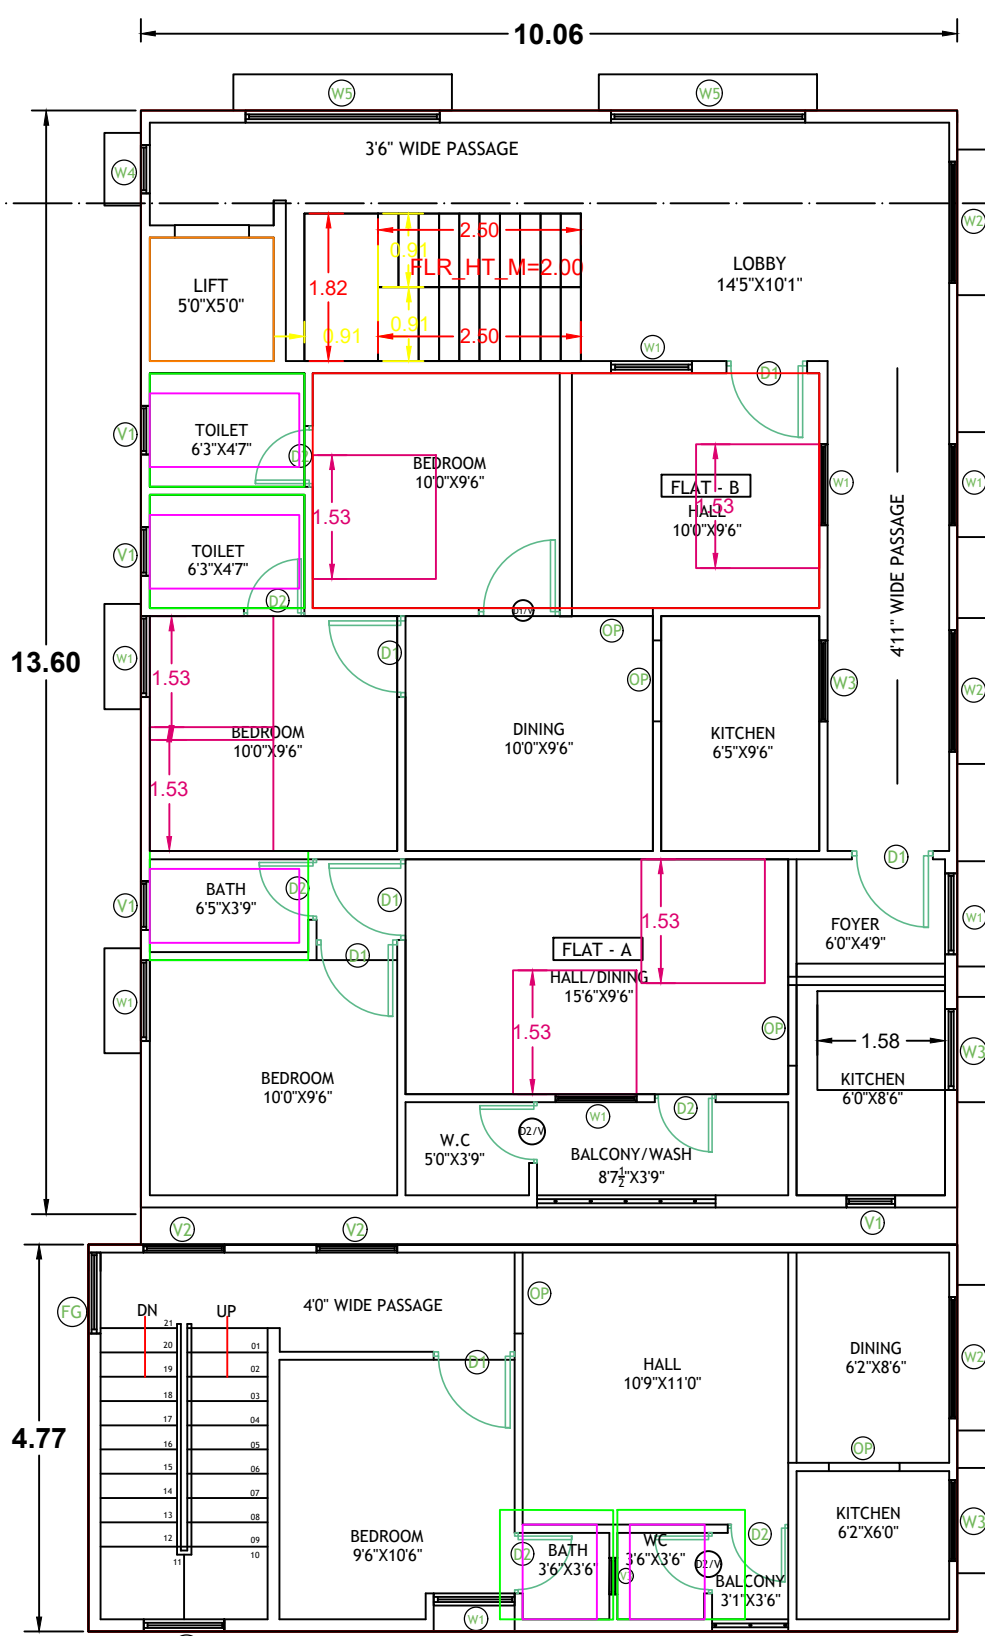

EXI.SECOND FLOOR PLAN

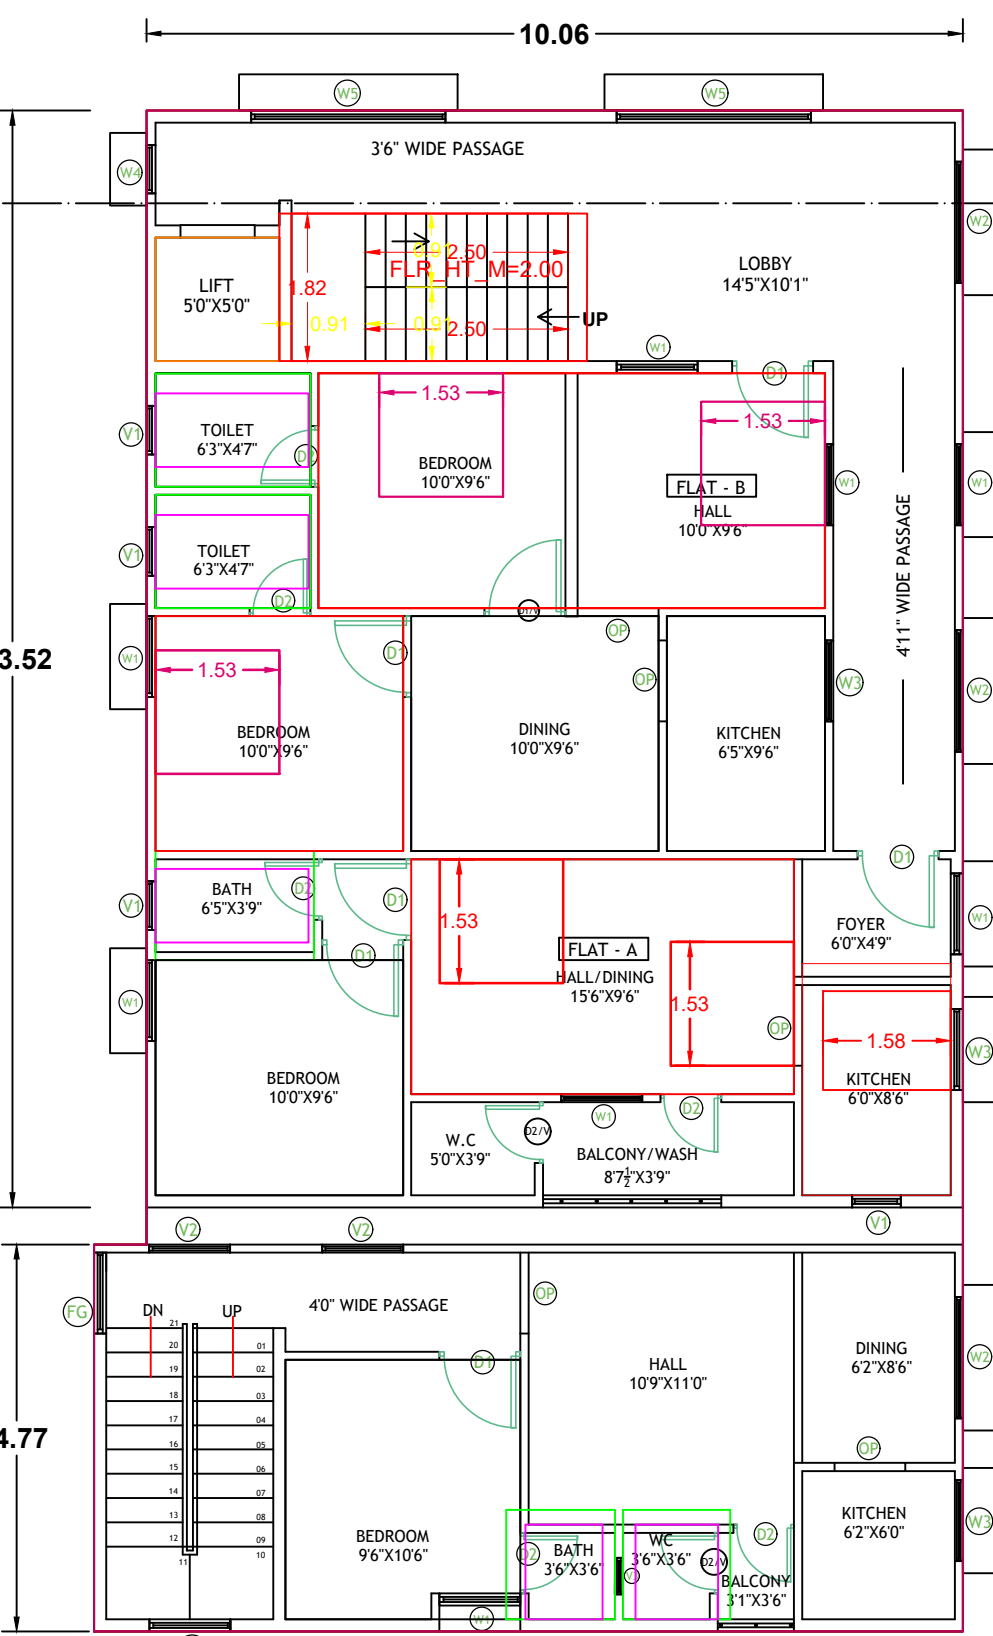

PRO.THIRD FLOOR PLAN

SITE PLAN