



PLAN SHOWING THE PROPOSED CONSTRUCTION OF GROUND AND FIRST FLOOR RCC ROOF COMMERCIAL BUILDING IN S.F.NO.149/30B,

PATTA NO.3768, AT "AZHAGAMMAL NAGAR" (ARIYALUR NORTH) VILLAGE, ERUTHUKKARANPATTI PANCHAYAT OF ARIYALUR TALUK AND DISTRICT.


(SCALE 1:100)

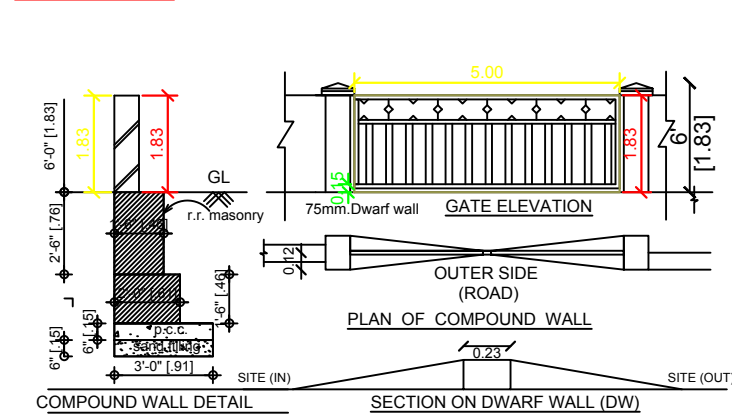


DETAILS OF COMPOUND WALL

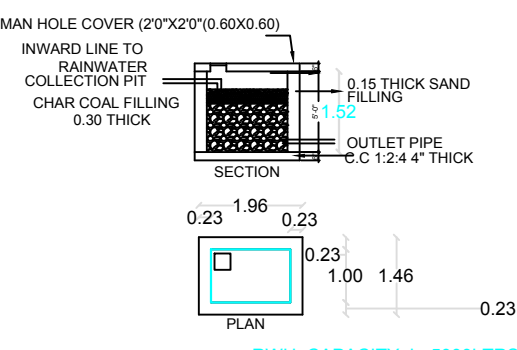


DETAILS OF RAINWATER HARVESTING

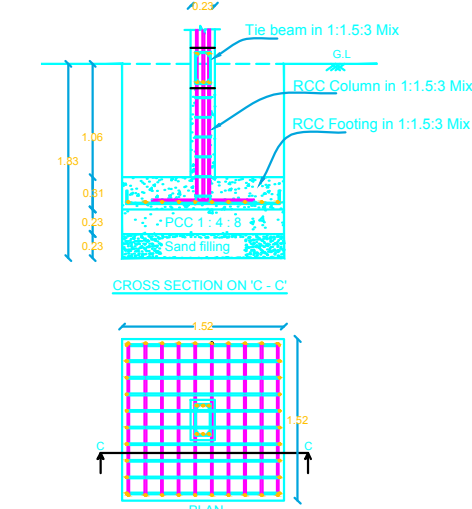


COLOUMN FOUNDATION DETAILS

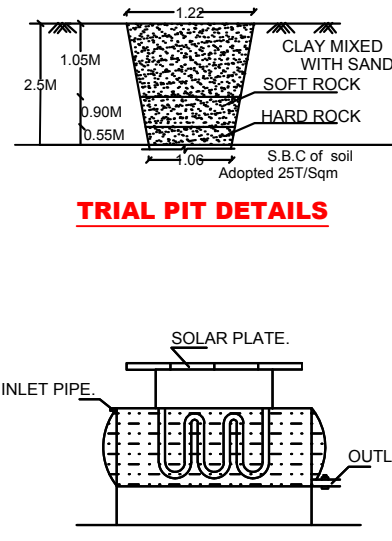

SOLAR WATER HEATER

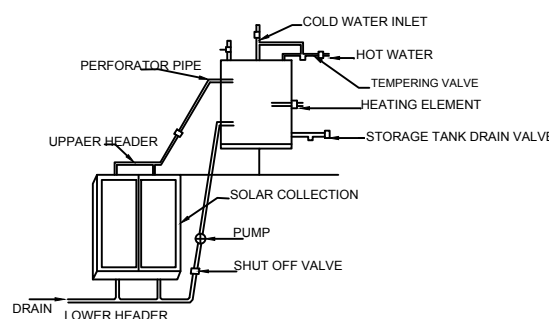


DETAILS OF SOLAR WATER HARVESTING (NTS)

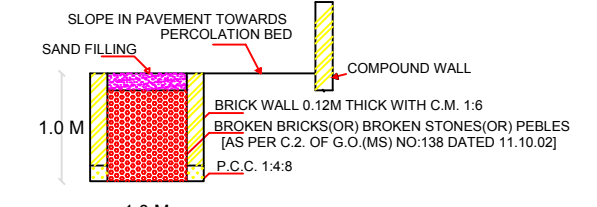

SECTION OF RAIN WATER PERCOLATION BED

NOTES:

- SULLAGE WASTE FROM TOILET WILL BE CONNECTED INTO STP.
- BORE WELL WITH MOTAR WATER TANK AND CORPORATION WATER SUPPLY
- RAIN WATER PERCOLATION PIT PROVIDED @1/30 Sqm OF PLINTH AREA@6M C/C
- RAIN WATER PERCOLATION BED 1.0m WIDE WILL BE PROVIDED AROUND THE BUILDING AS PER GO (MS) NO: 138 DATED 11-10-02.
- RAIN WATER TAKEN TO THE BORE WELL THROUGH 150MM DIA PIPES.
- RAIN WATER COLLECTED FROM OPEN TERRACE SHALL BE COLLECTED THROUGH PIPES AND LED INTO A FILTER PIT (SIZE 60 X 60 X 60 CM) WITH APPROPRIATE FILTER MATERIAL AND THEN LED INTO COLLECTION TANK.
- SOLAR WATER HEATER LINE ARRANGEMENTS WILL BE PROVIDED.
- ALL DIMENSIONS ARE IN METRE & FEET.
- FE - FIRE EXTINGUISHER PROVIDED.

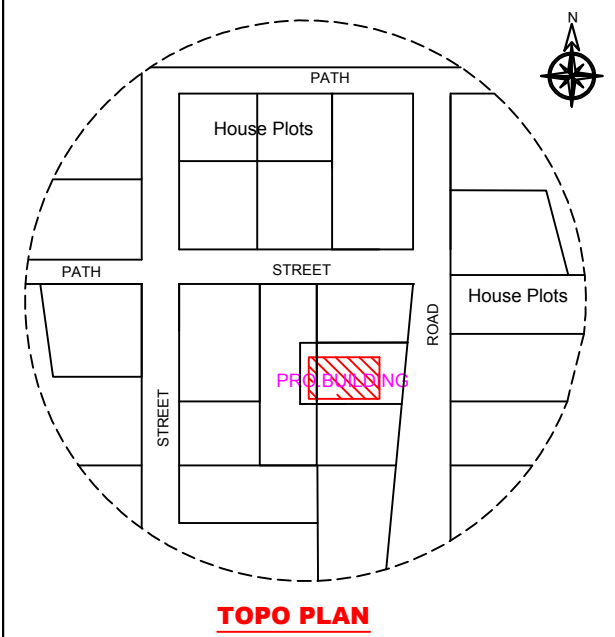

TOPO PLAN

SCHEDULE OF JOINERIES:

TYPE	REFERENCE	SIZE IN METER
MD	MAIN DOOR	1.20 x 2.13
D	FLUSH DOOR	1.00 x 2.13
D1	FLUSH DOOR	0.76 x 2.13
D2	FLUSH DOOR	1.00 x 1.98
O	OPEN	1.00 x 2.13
W1	WINDOW	1.53 x 1.52
W2	WINDOW	1.22 x 1.52
W3	WINDOW	0.91 x 1.52
KW	KITCHEN WINDOW	1.53 x 1.22
V	VENTILATOR	0.91 x 0.76
J	JALLY	0.91 x 1.83

AREA DETAILS

DESCRIPTION	SQ.M
PLOT AREA (as per Document)	203.00
PLOT AREA (as per FMB)	203.00
SUPER IMPOSED PLOT AREA	203.00

PROPOSED BUILDING PLINTH AREA

DESCRIPTION	F.S.I AREA (in SQ.M)	F.S.I AREA (in SQ.Ft)
AREA DETAILS	Sq.M	Sq.Ft
GROUND FLOOR AREA	90.99	979.41
FIRST FLOOR AREA	90.99	979.41
TOTAL AREA	181.98	1958.83
OPEN SPACE	112.01	1205.67

PLOT COVERAGE	=	90.99 / 203.00	X 100	=	44.82%
F.S.I	=	181.98 / 203.00		=	0.89

NOTES:

- FIRE EXTINGUISHER ● FE
- ALL DIMENSION ARE IN METER
- SCALE - 1:100
- WASTE WATER UTILISED FOR GARDEN PURPOSE.
- SOLAR WATER HEATER PROVIDED IN TERRACE FLOOR.

PARKING

- TWO WHEELER PARKING SPACE 3 NOS PROVIDED.



A.S.A Constructions
Chinna Aranmanai Street, Ariyalur.
Mobile : 9443303157, 9943425641

APPLICANT


C. Mah
Mrs.MEGALA,
W/O.Mr.CHINNADURAI.

ENGINEER


[Signature]
Er.D.SEETHA, M.E(Struct),MBA.,
LICENSED SURVEYOR NO:329
REGISTERED ENGINEER GRADE -1
RE/PLBR/APR 2019/014




FRONT ELEVATION

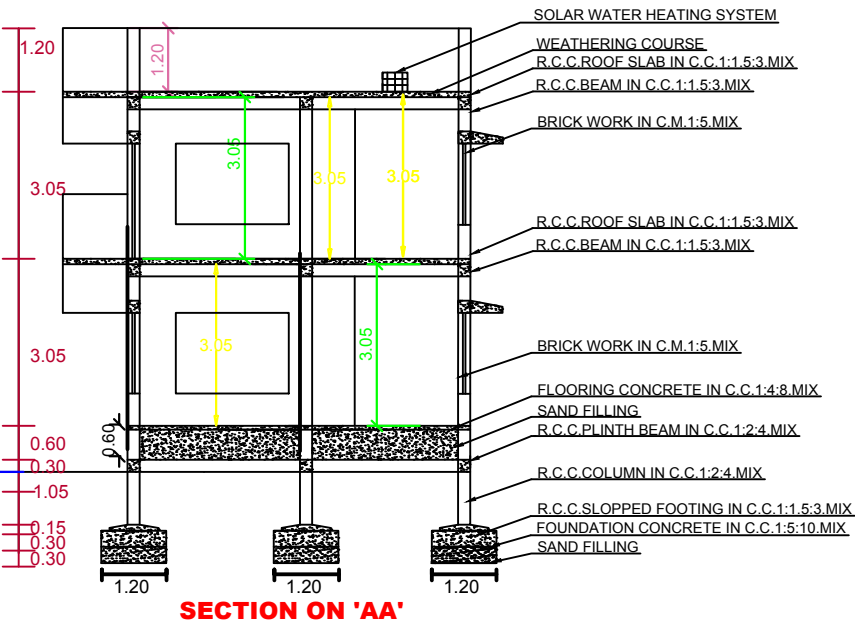


SECTION ON 'AA'

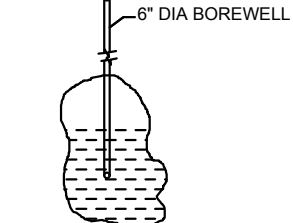


BORE WELL DETAIL

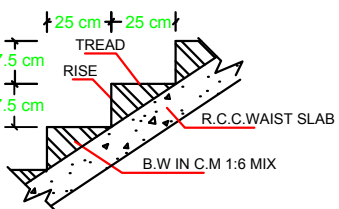


SECTION OF STAIRCASE

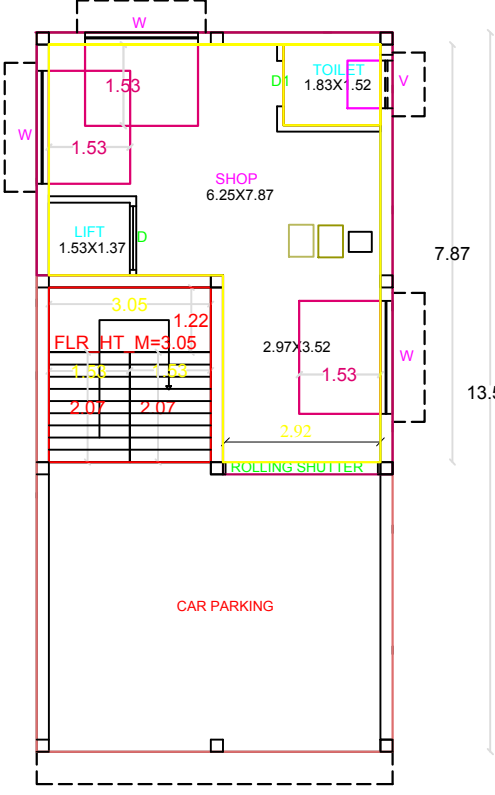


GROUND FLOOR AREA

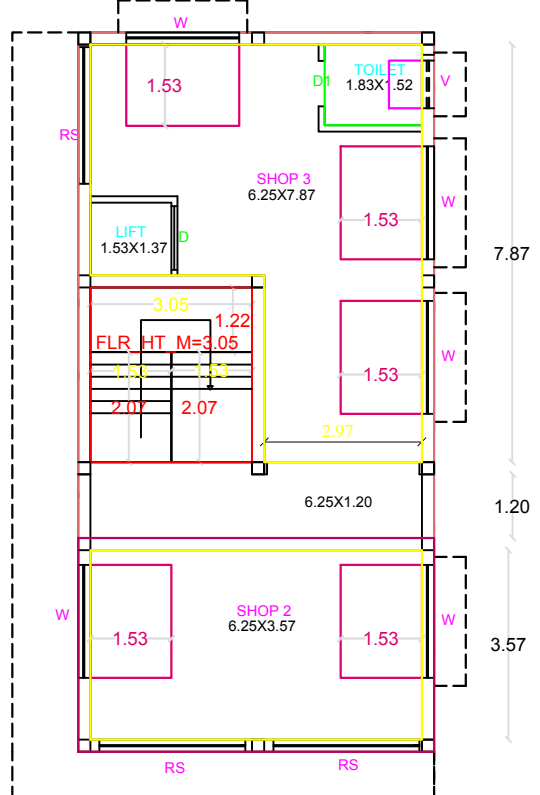

FIRST FLOOR AREA

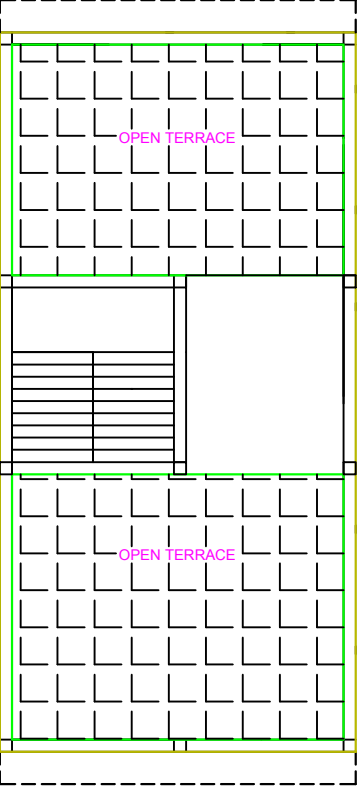

TERRACE FLOOR AREA

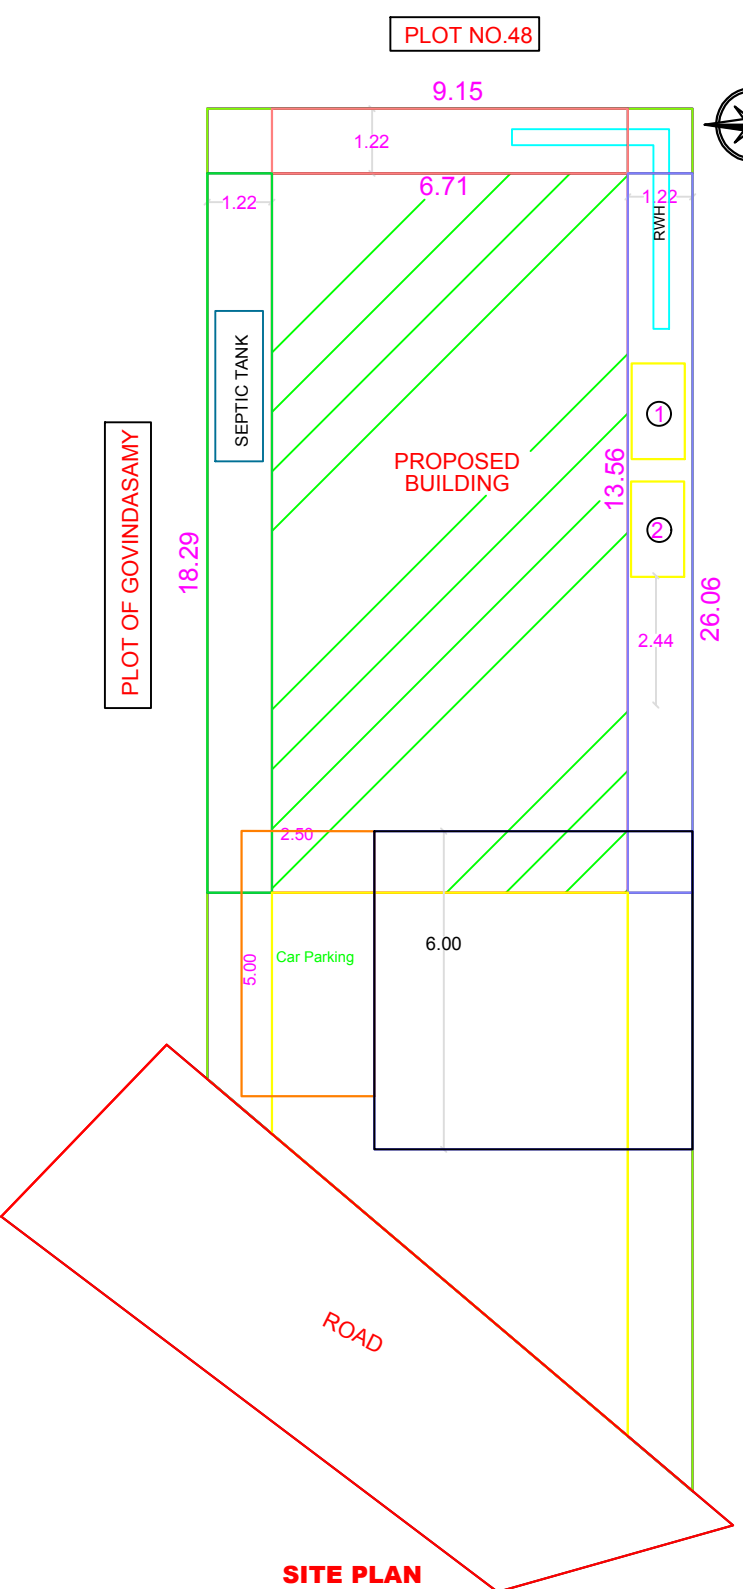

SITE PLAN

