


PLAN SHOWING THE PROPOSED CONSTRUCTION OF RESIDENTIAL BUILDING IN S.NO:97/4A 1

NEW .S.NO:97 /4A1E , PLOT NO:22 , PATTA NO:3108 AT ALR NAGAR , THAMARAIPADI VILLAGE


& PANCHAYAT, DINDIGUL EAST TALUK & DINDIGUL DIST.

APPLICANT: A.MURUGAN , S/o.ARUMUGAM.

SCALE : 1 : 100

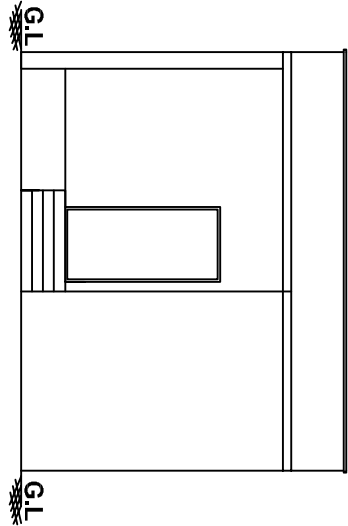



ELEVATION

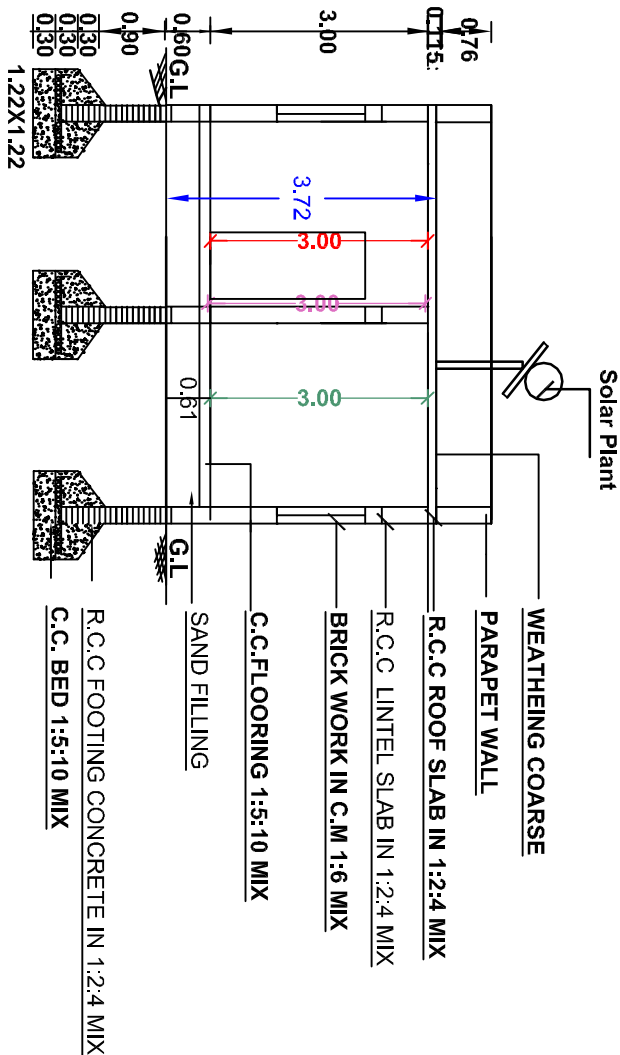


SECTION ON AB

KEY PLAN :


(SCALE 1:5000)

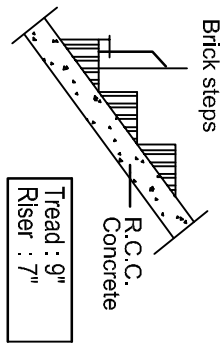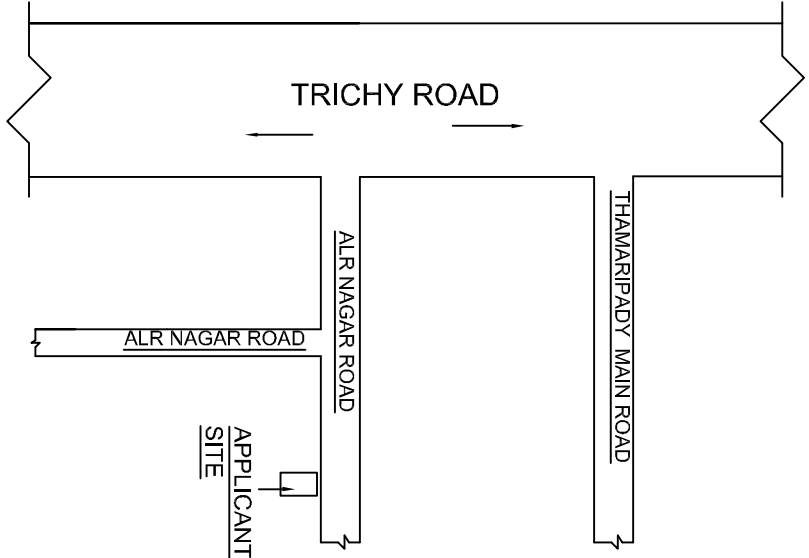

STAIRCASE DETAILS

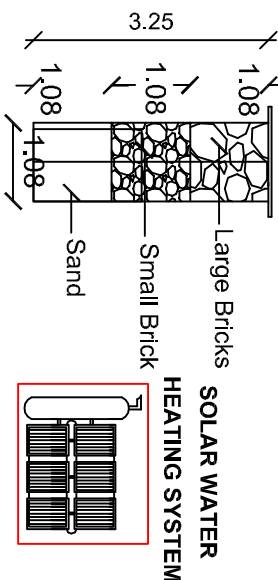


SECTION OF RAIN WATER

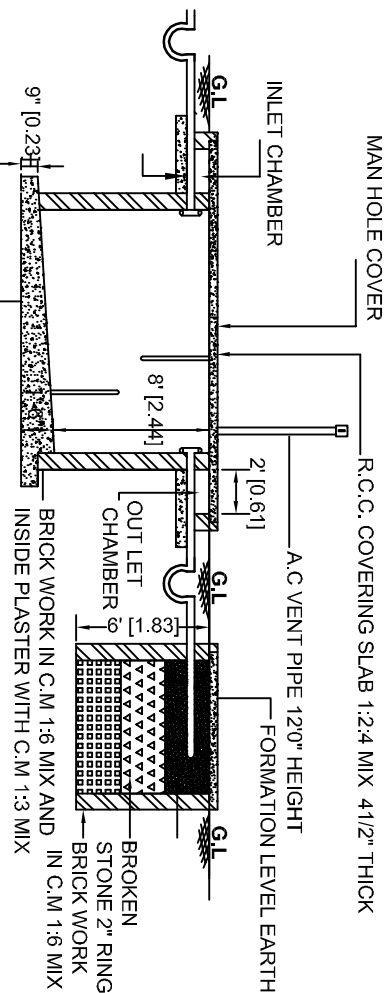

SECTION OF SEPTIC TANK AND DISPERSION TRENCH

SITE PLAN :

(SCALE 1:200)

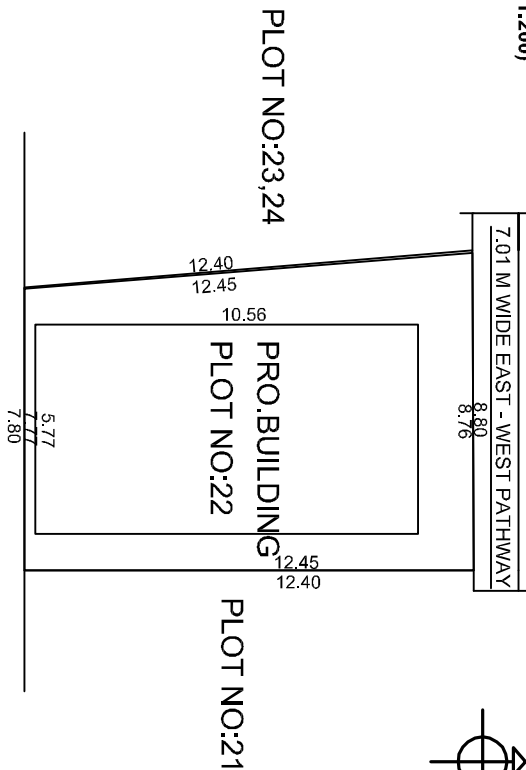

SCHEDULE OF JOINERIES

S.NO.	DESCRIPTION	FEET	METRE
MD	MAIN DOOR	4'0" X 7'0"	1.22 X 2.13
D	DOOR	3'0" X 7'0"	0.91 X 2.13
D1	DOOR	2'6" X 7'0"	0.76 X 2.13
W	WINDOW	4'0" X 4'0"	1.22 X 1.22
W1	WINDOW	3'0" X 4'0"	0.91 X 1.22
V	VENTILATOR	3'0" X 3'0"	0.91 X 0.91

Parking Calculation Building Area

Required Two Wheller Parking :2Nos.
Provided Two Wheller Parking :2 Nos.

PRO. AREA DETAILS	Sq.Ft.	Sq.M.
TOTAL SITE AREA (FMB)	1108.28	103.00
TOTAL SITE AREA (DOCUMENT)	1107.00	102.89
SUPER IMPOSED PLOT BOUNDARY	1107.00	102.89
PRO. GROUND FLOOR	656.04	60.97
OPEN SPACE	450.96	41.92

APPLICANT:

A.MURUGAN

DRAWN:

J. CHARLES J EYAKUMAR

I.CHARLES JEYAKUMAR, D.C.E., D.Cadd.,
Registered Engineer Grade - III
Reg.No:078/LS/2019/00029
AJK Constructions,
A4/8, Sheriff Complex, Opp.To.St.Joseph Hospital,
Trichy Road, Dindigul -624001
CELL No. 94420 68387
E-mail id: jeyakumar8387@gmail.com