



PLAN SHOWING THE PROPOSED CONSTRUCTION OF RCC ROOF GROUND FLOOR DWELLING HOUSE IN S.NO:1718/1F, PADIYUR VILLAGE AND PANCHAYAT, VEDASANDUR TALUK,DINDIGUL DISTRICT.


APPLICANT: Mrs.SUDARMATHI W/O MR.MURUGESAN

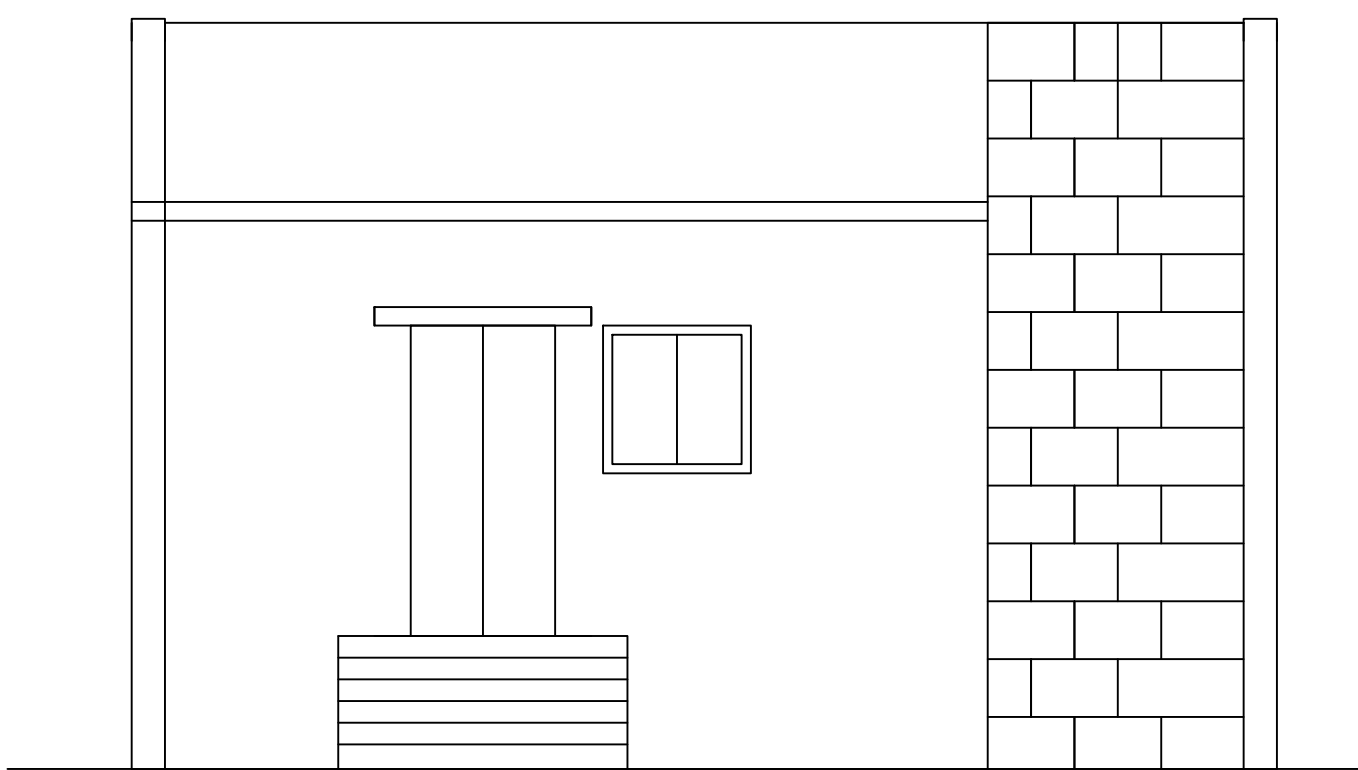


ELEVATION

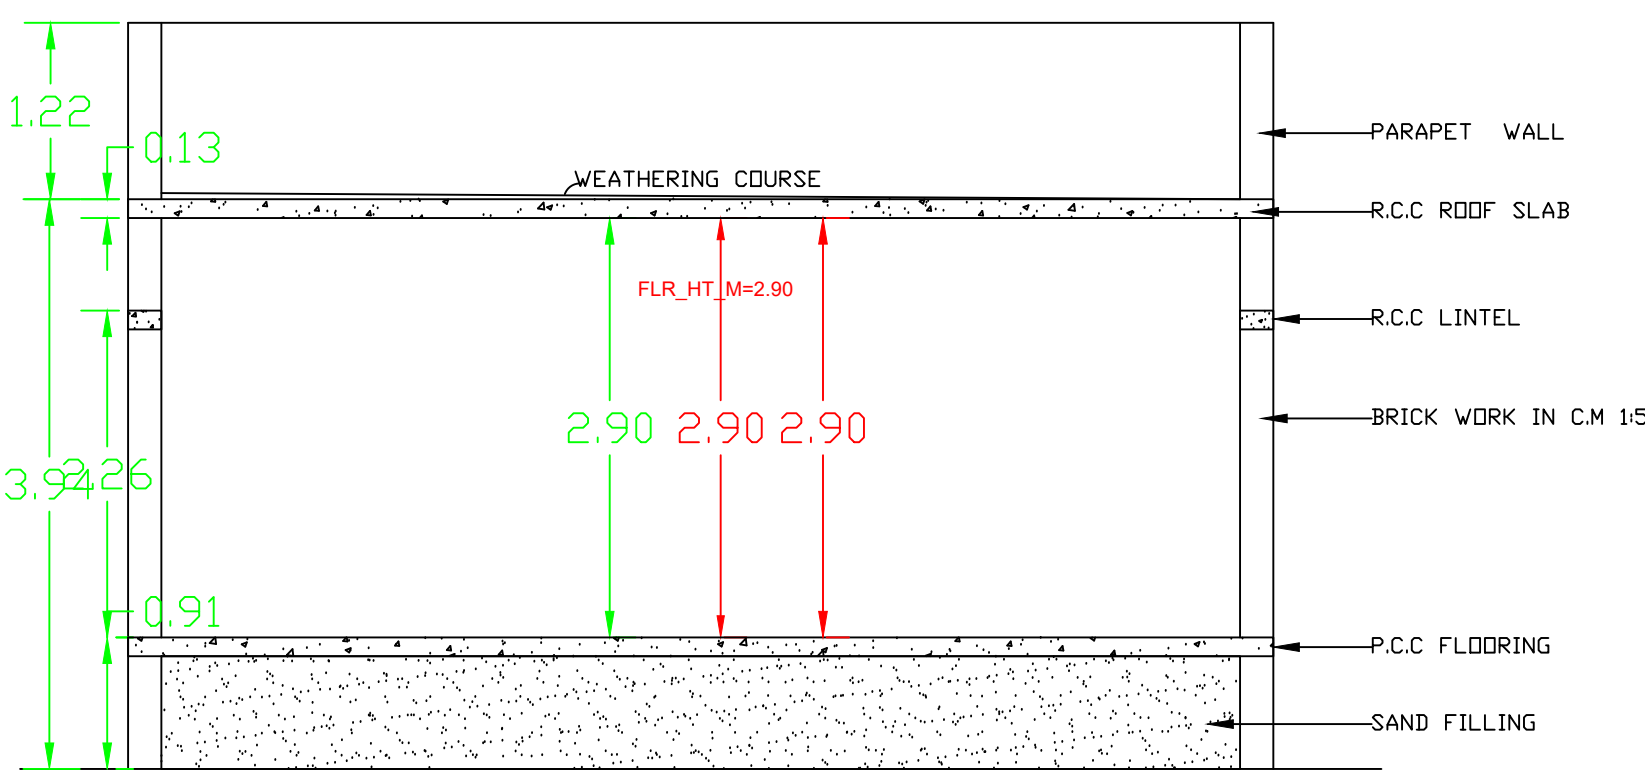


SECTION

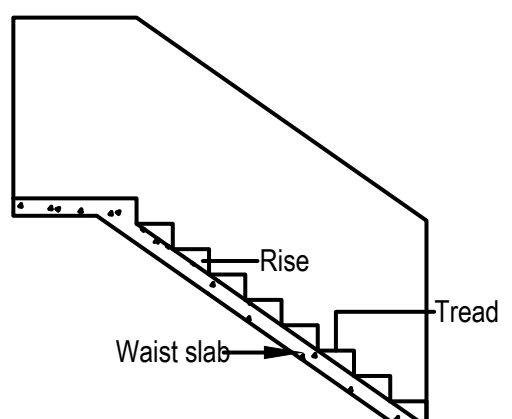


DETAILS OF STAIR CASE

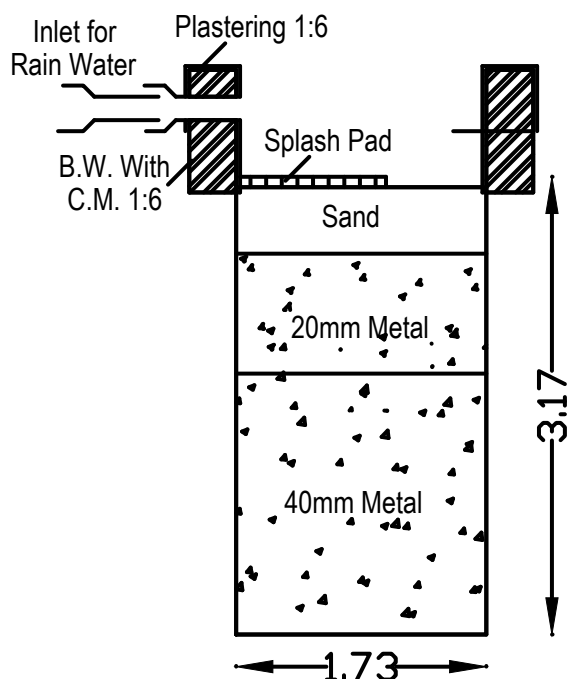


RAIN WATER PERCOLATION PIT

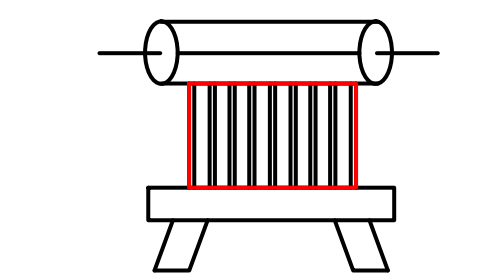


SOLAR WATER HEATER

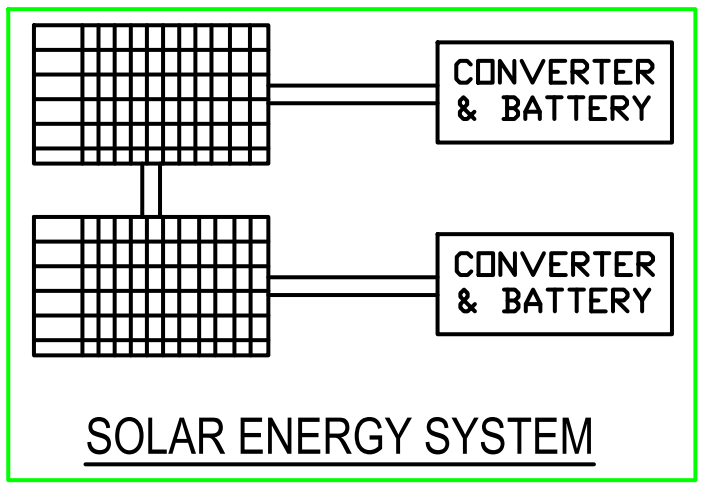


SOLAR ENERGY SYSTEM

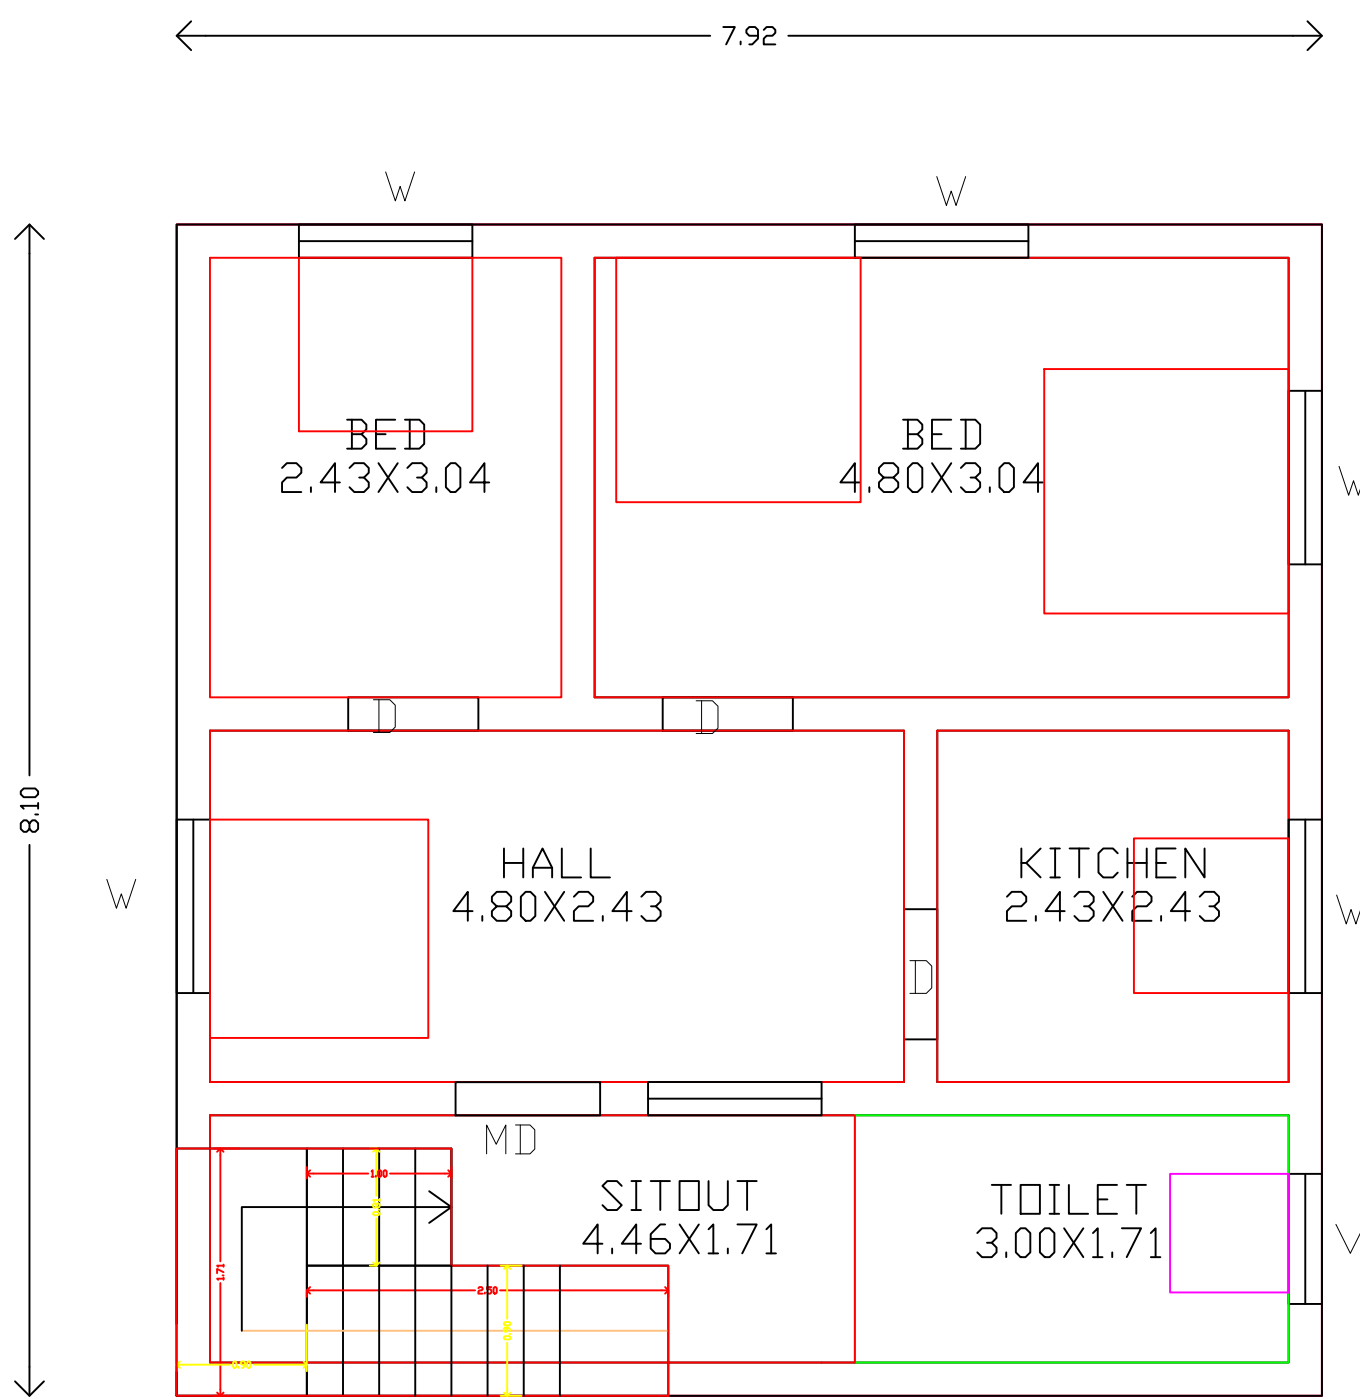


PROPOSED GROUND FLOOR PLAN

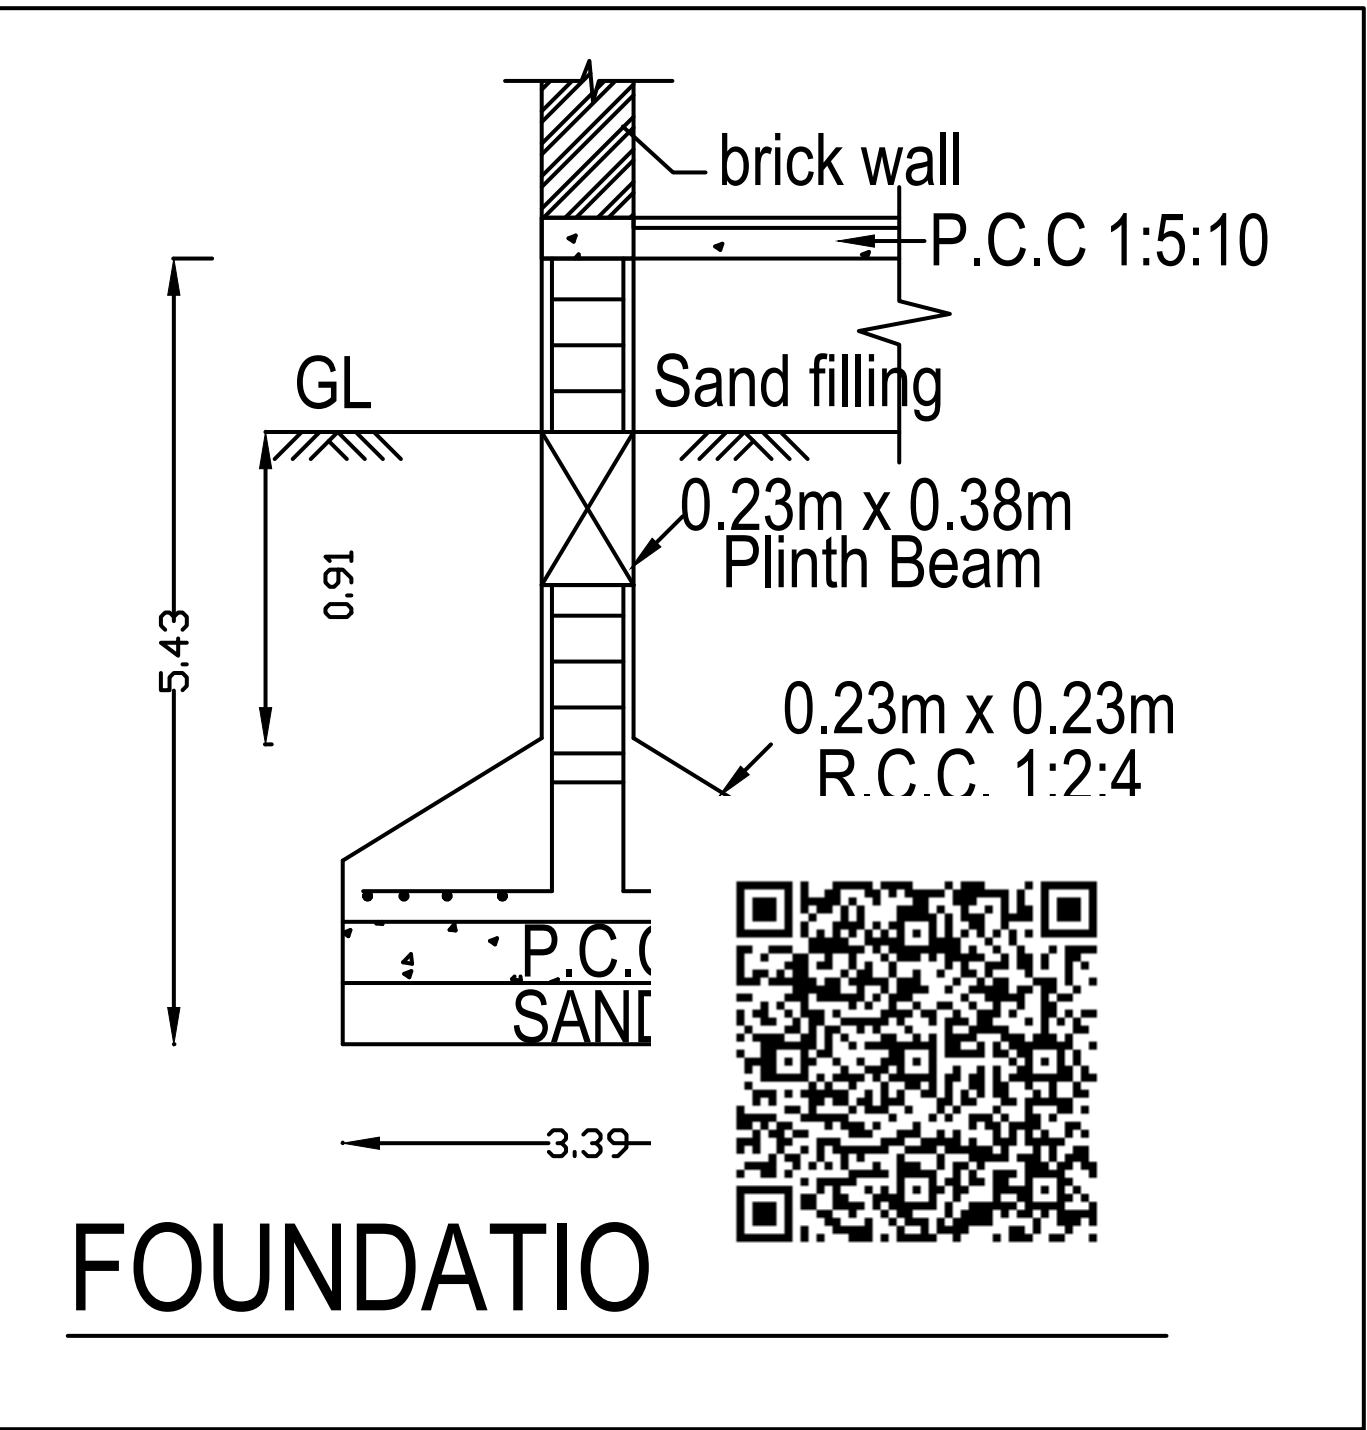


FOUNDATIO

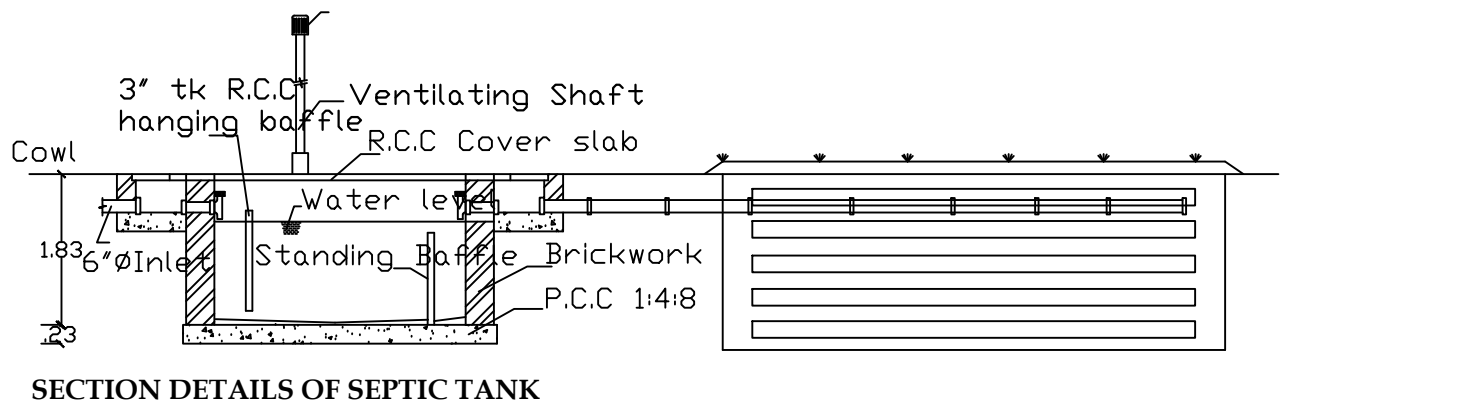


SECTION DETAILS OF SEPTIC TANK

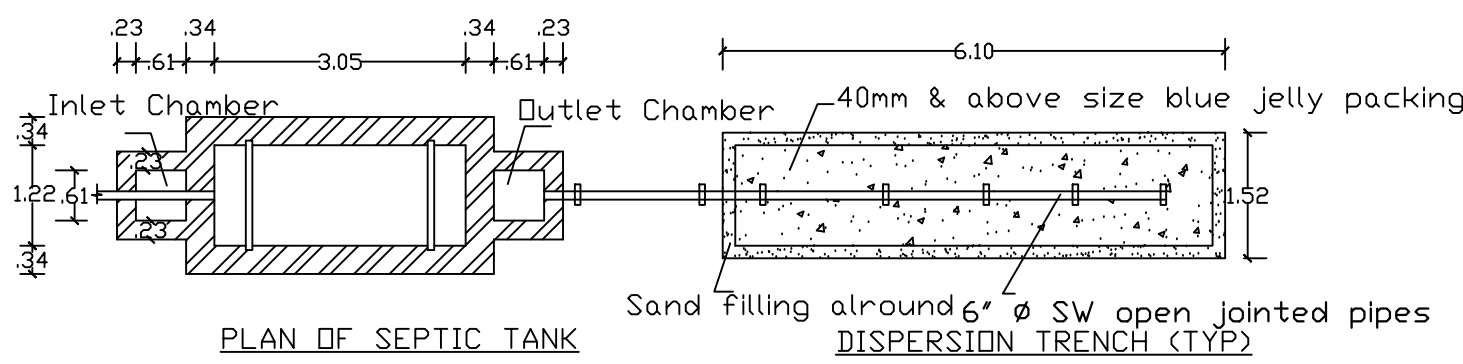

DETAILS OF SEPTIC TANK & DISPERSION TRENCH

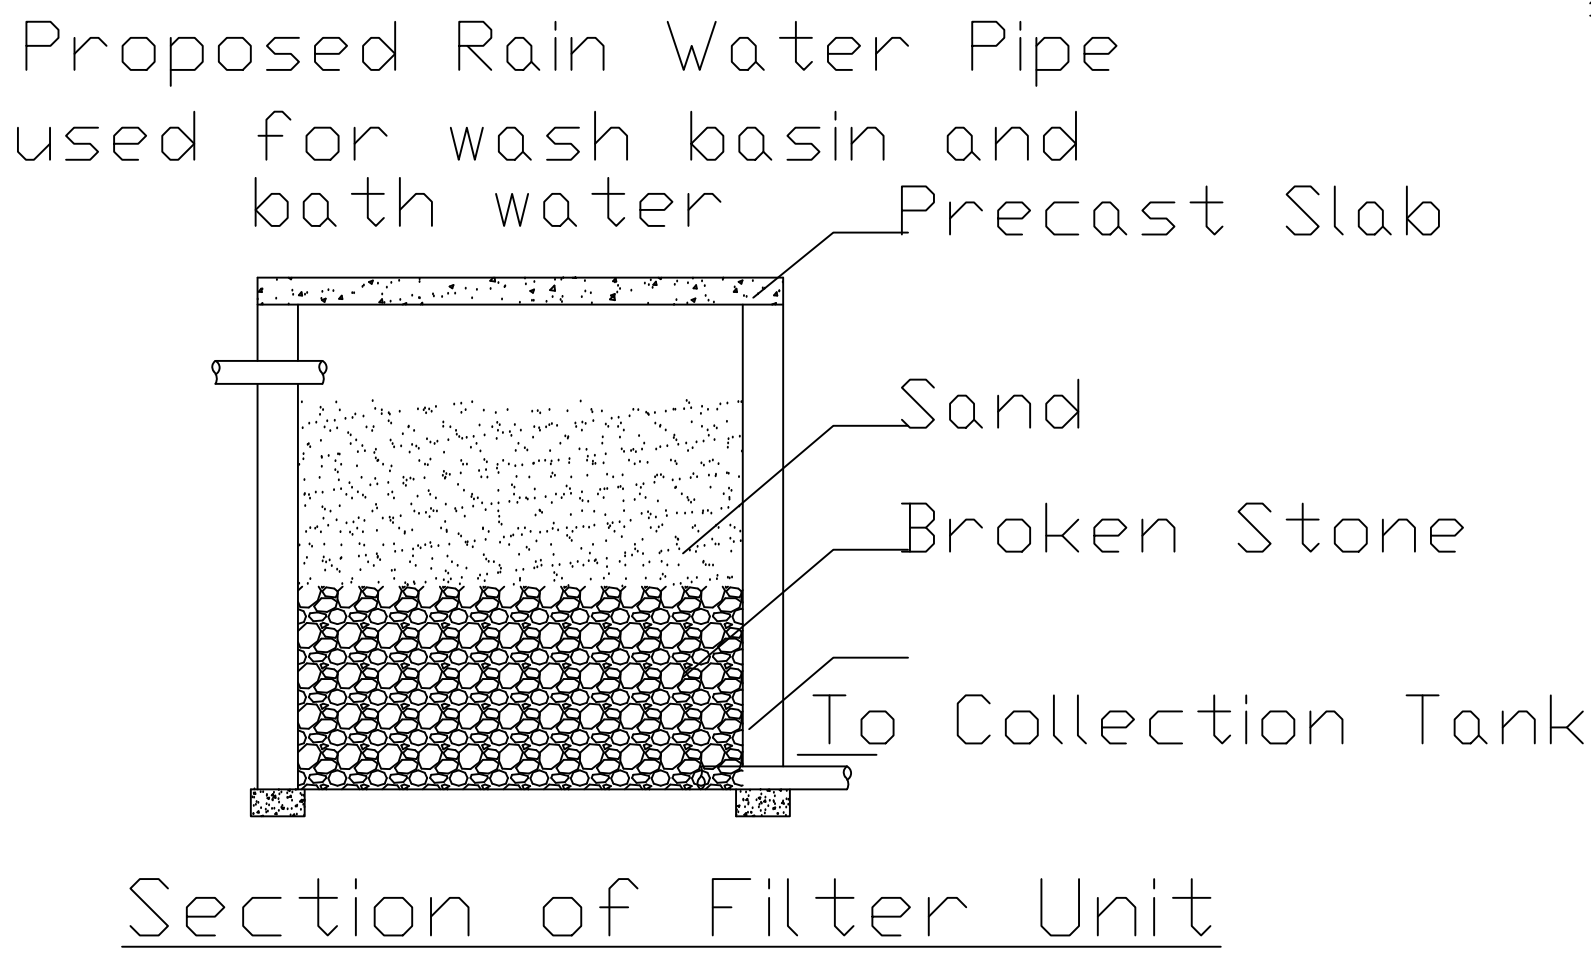

Section of Filter Unit

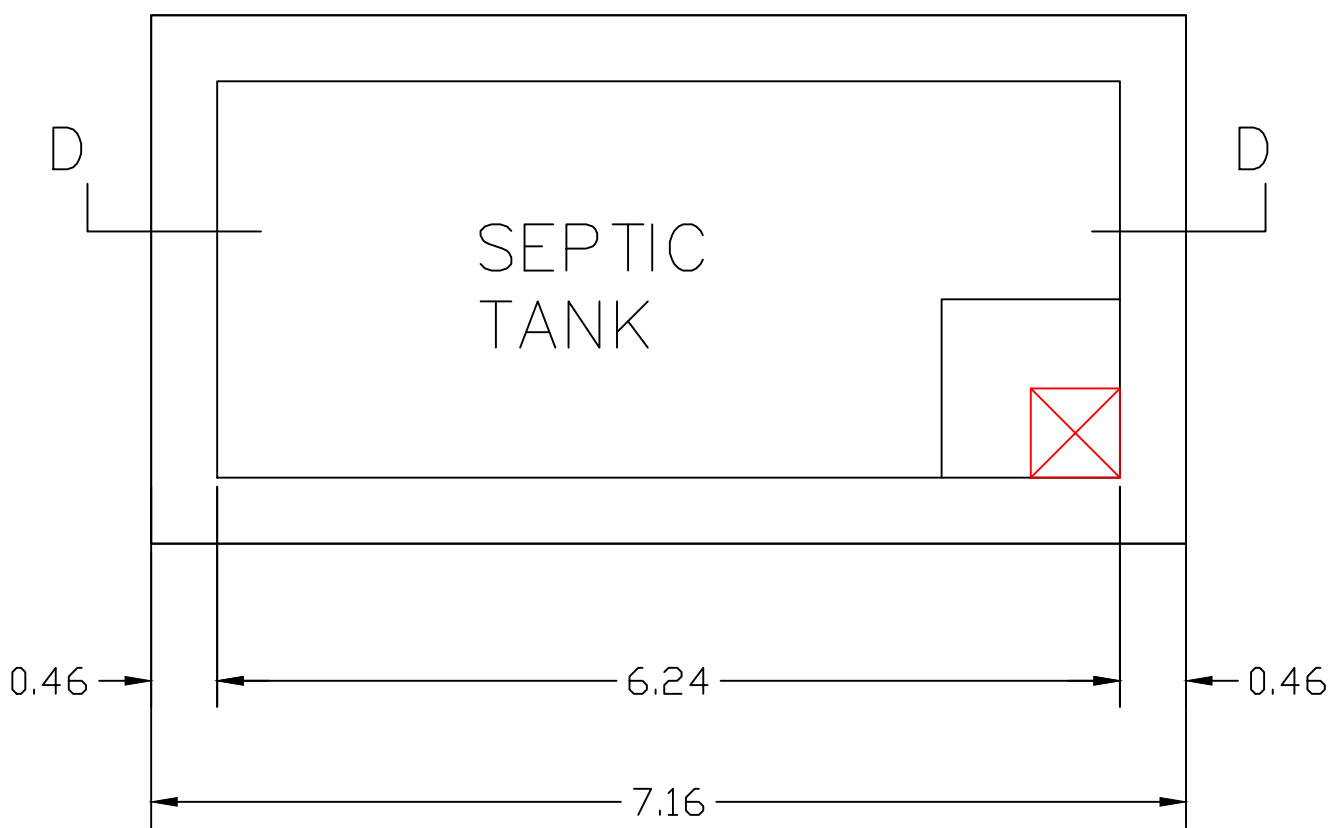

PLAN OF SEPTIC TANK
SCALE 1"=2'0"



SITE PLAN

OFFICE USE

COLOUR INDEX.

○ Site Bountry ○ Pro.Cons.(G.F)

AREA DETAILS

	Sq.Ft	Sq.Mt
Site Area	33441.10	3106.78

Plinth Area	608.44	56.53
Ground Floor(Pro.)		

First Floor (Pro.)		
--------------------	--	--

Floor Area		
Ground Floor (Pro.)		

First Floor (Pro.)		
--------------------	--	--

Open Area		
-----------	--	--

FLOOR SPACE INDEX = $\frac{56.53}{3106.78} = 0.01 < 2.0\%$

REFERENCE

G.D Main Door	3'6" X 7'0"	1.06 X 2.13
D.Door	3'0" X 7'0"	0.91 X 2.13
D1.Door	2'6" X 7'0"	0.76 X 2.13
Window	6'0" X 5'0"	1.52 X 1.52

APPLICVANT

P. Sudarmathi

(SUDARMATHI)

ENGINEER

ALEX
ALEX CONSTRUCTION LLC.
ENGINEERS & CONTRACTORS
REGISTERED ENGINEER
LIC No : 078/LS/2020/00033

ER.A.M.ALEX NICHOLAS., B.E
Registered Engineer, GRADE-II
Reg.No:078/LS/2021/00017
DINDIGUL CITY MUNICIPAL CORPORATION
V.G.S COMPLEX,KULATHUR(PO)
DINDIGUL-624005
Mob:97154-437464