




ELEVATION

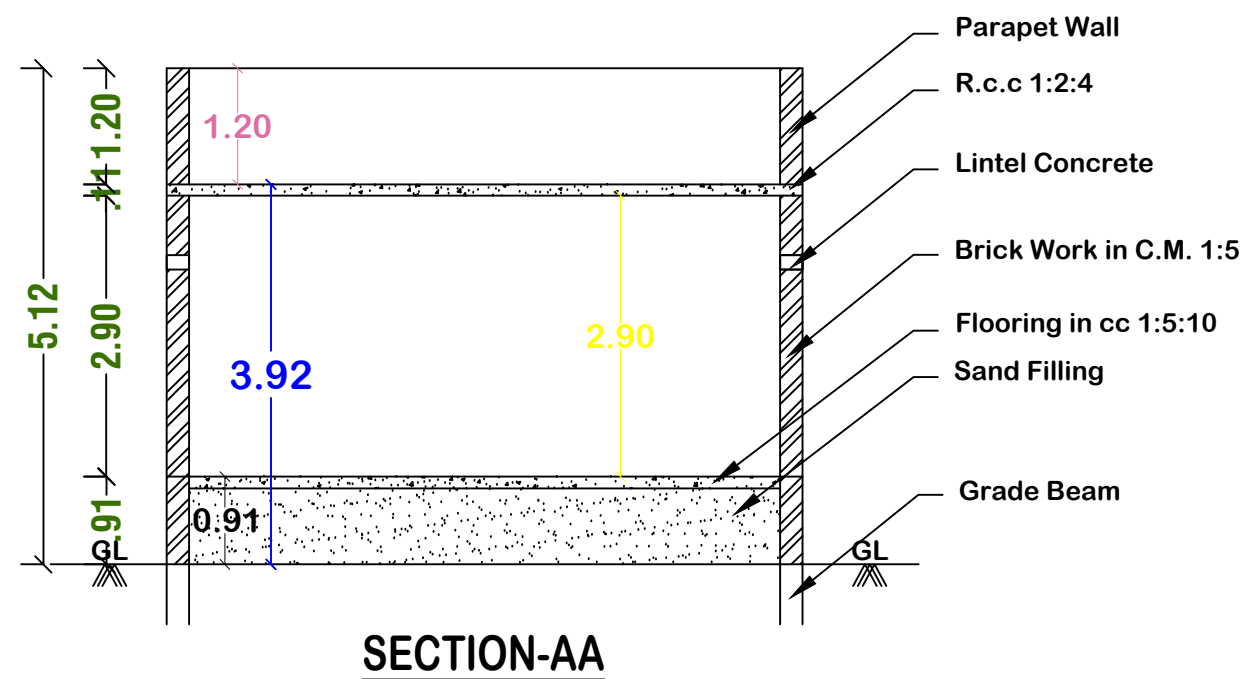


SECTION-AA

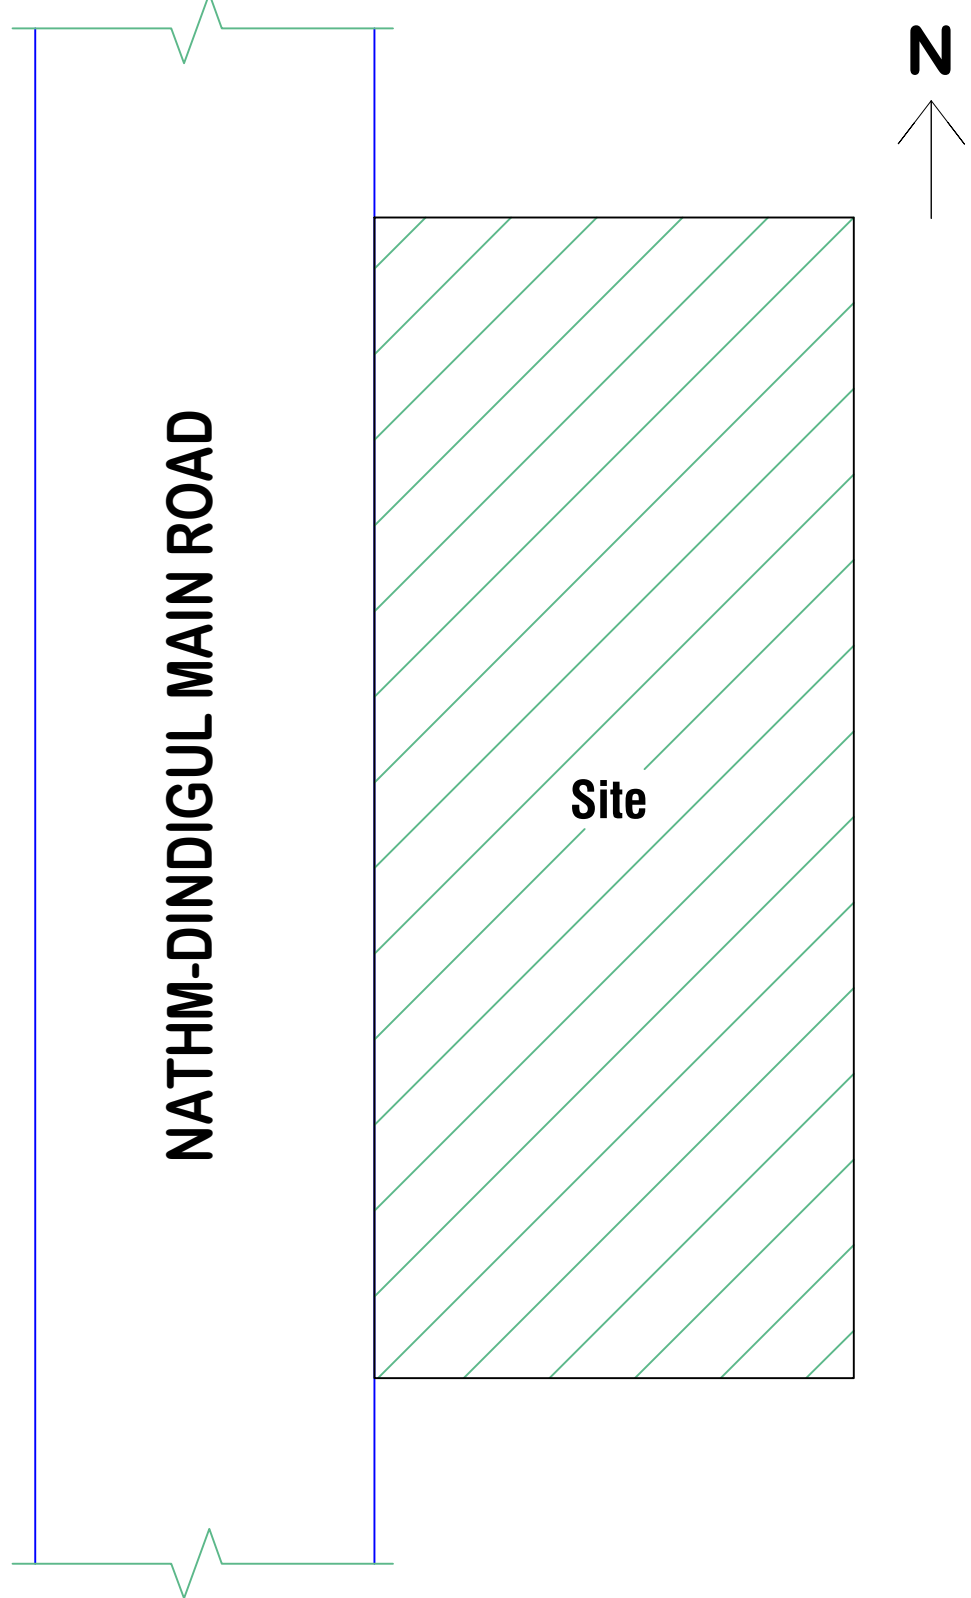


KEY PLAN (N.T.S)

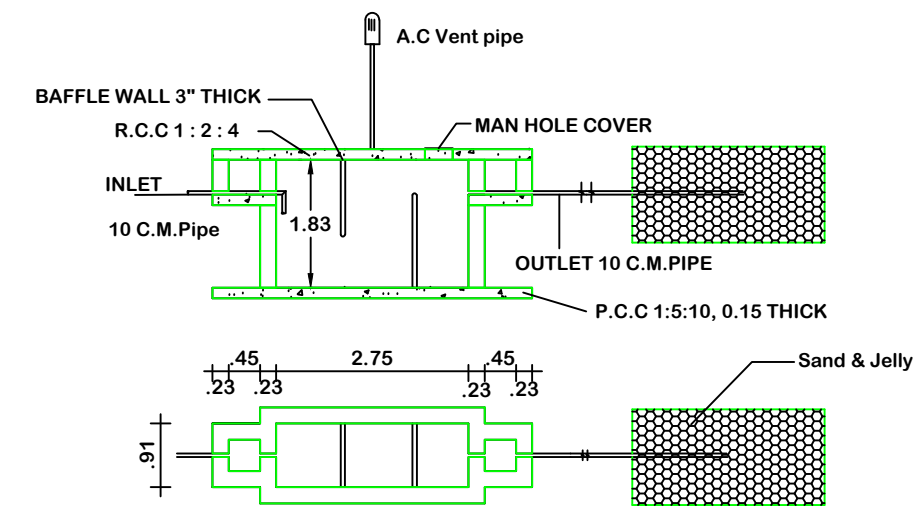


SEPTIC TANK AND TRENCH

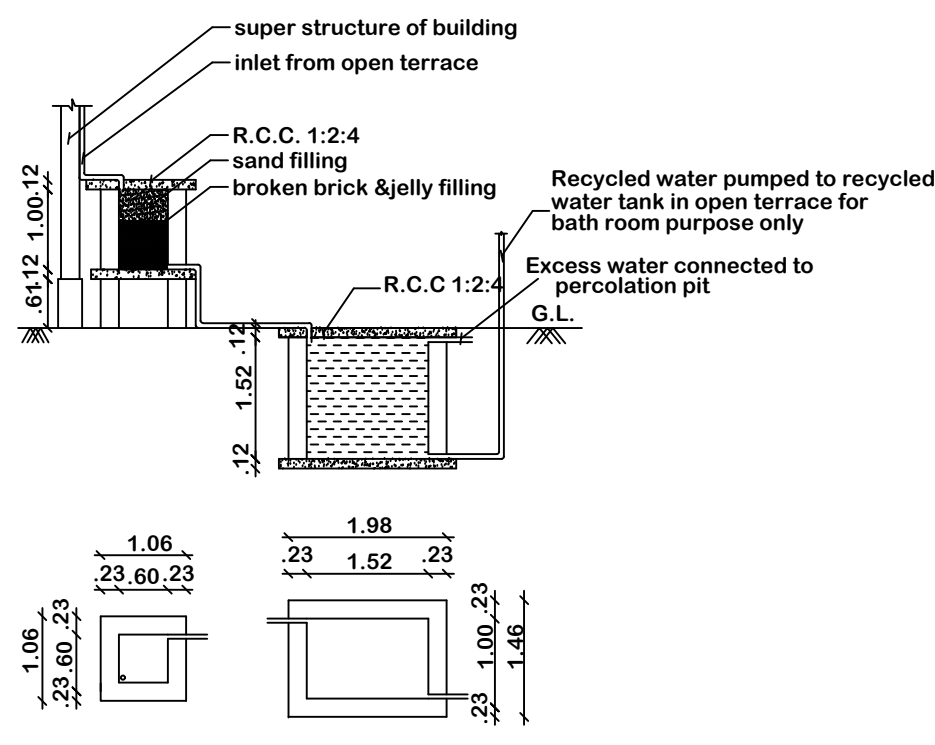


Sump and Filter Bed

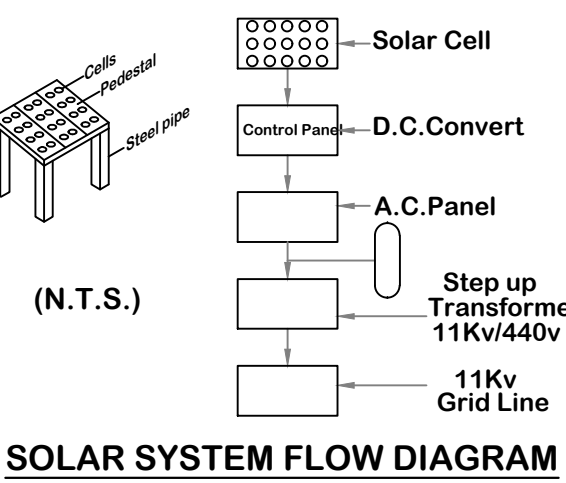


SOLAR SYSTEM FLOW DIAGRAM

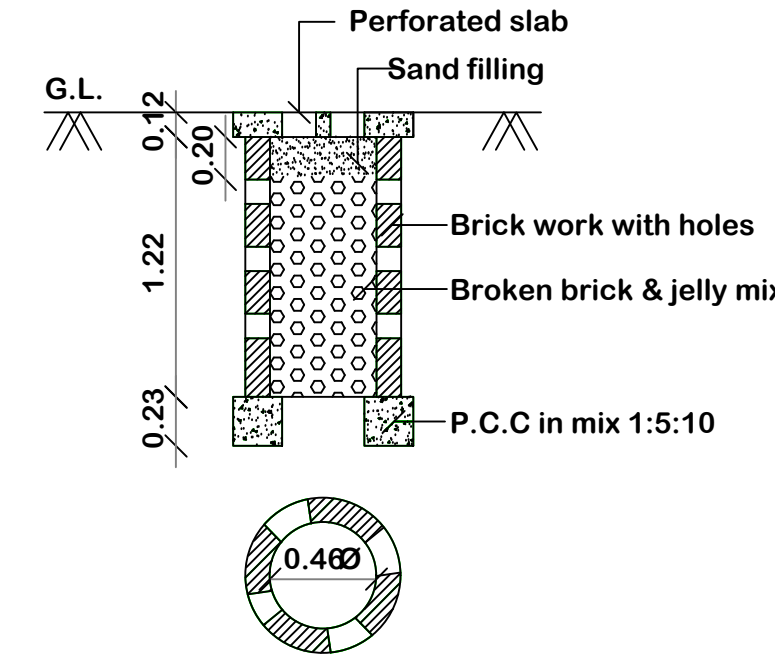

PERCOLATION PIT FOR 30 Sq. m.
(Scale:- 1:50)

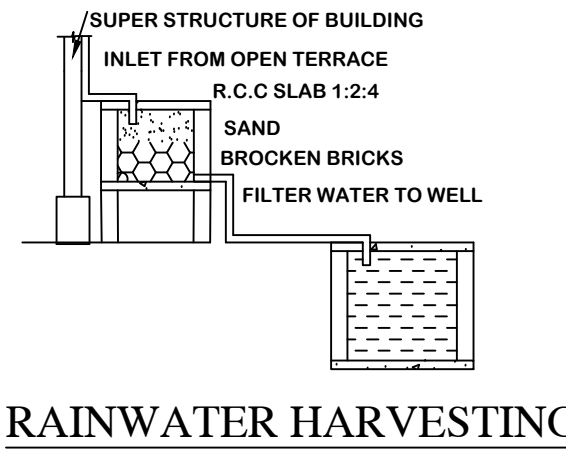


RAINWATER HARVESTING

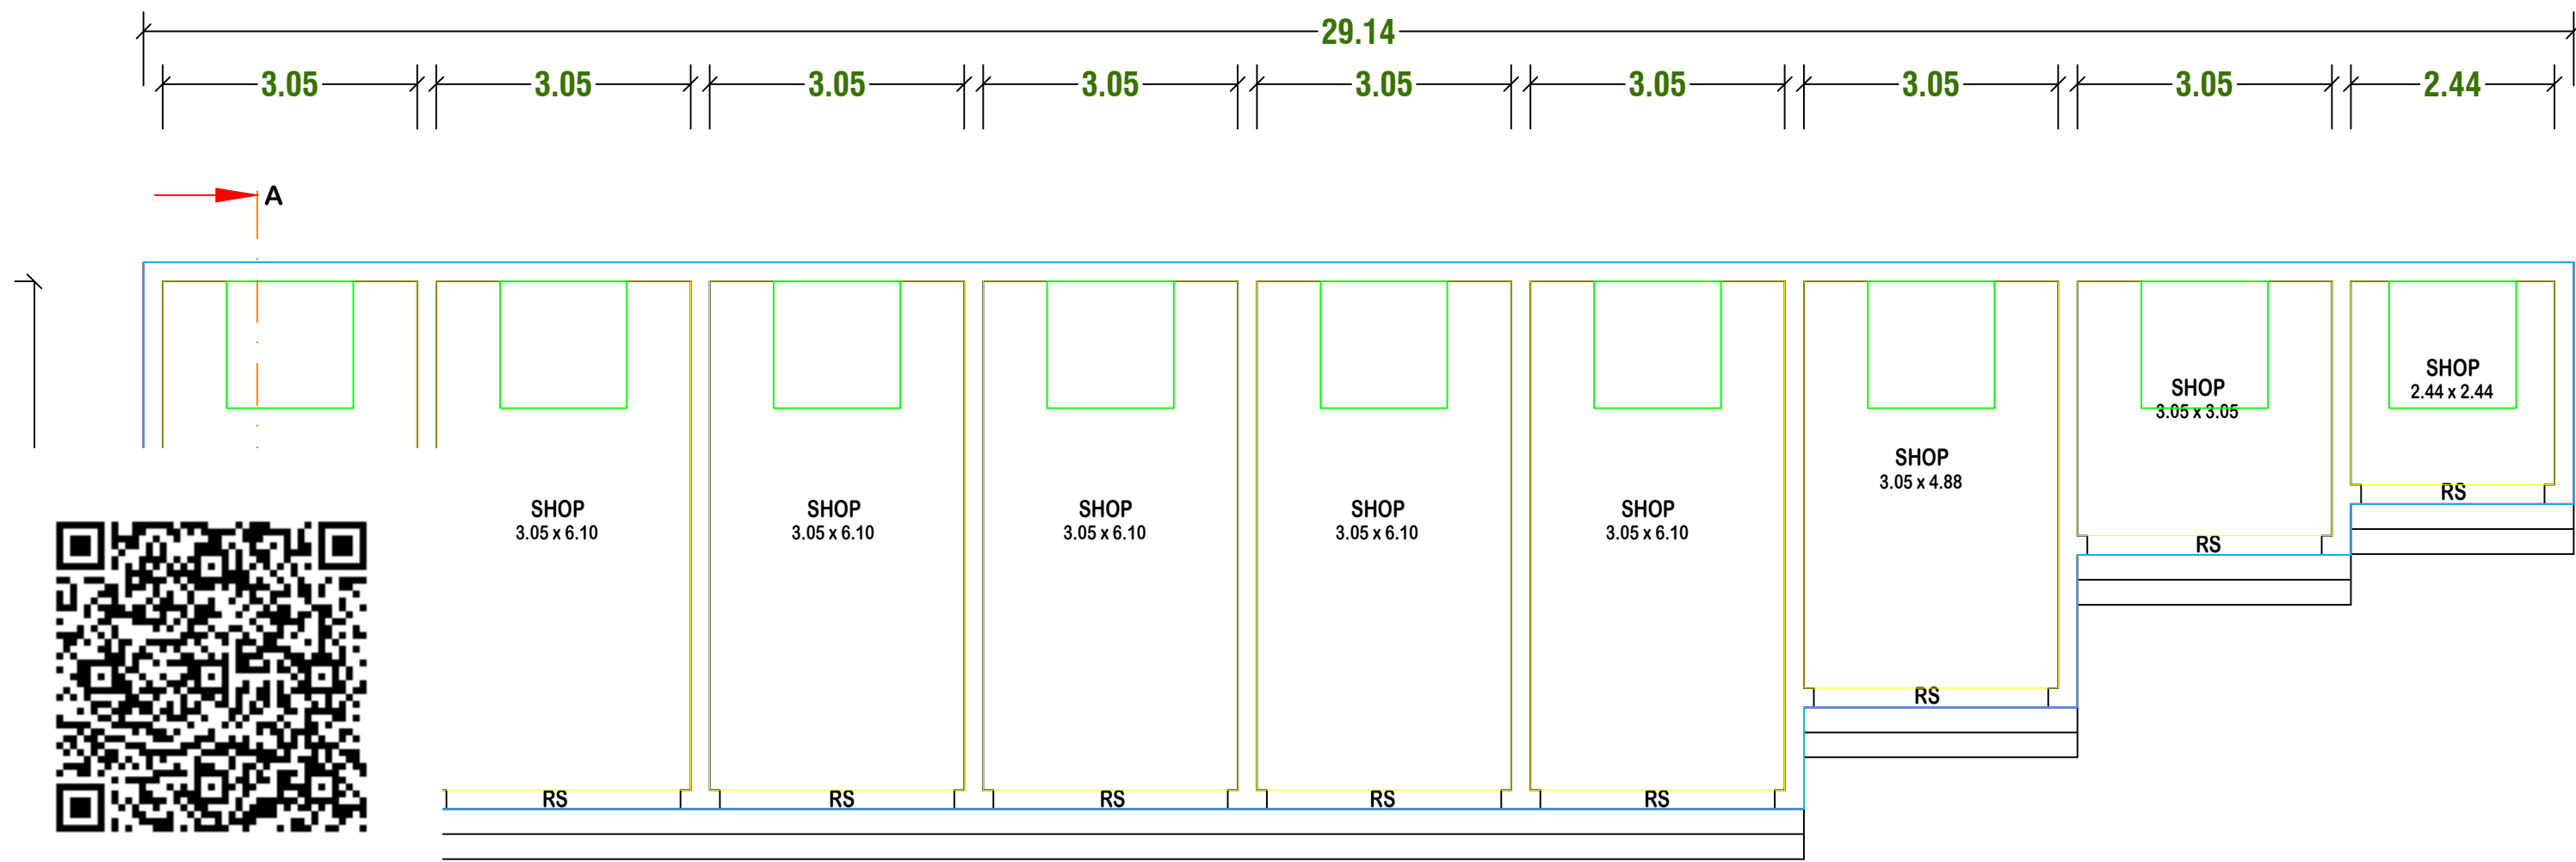


PLAN


ROAD

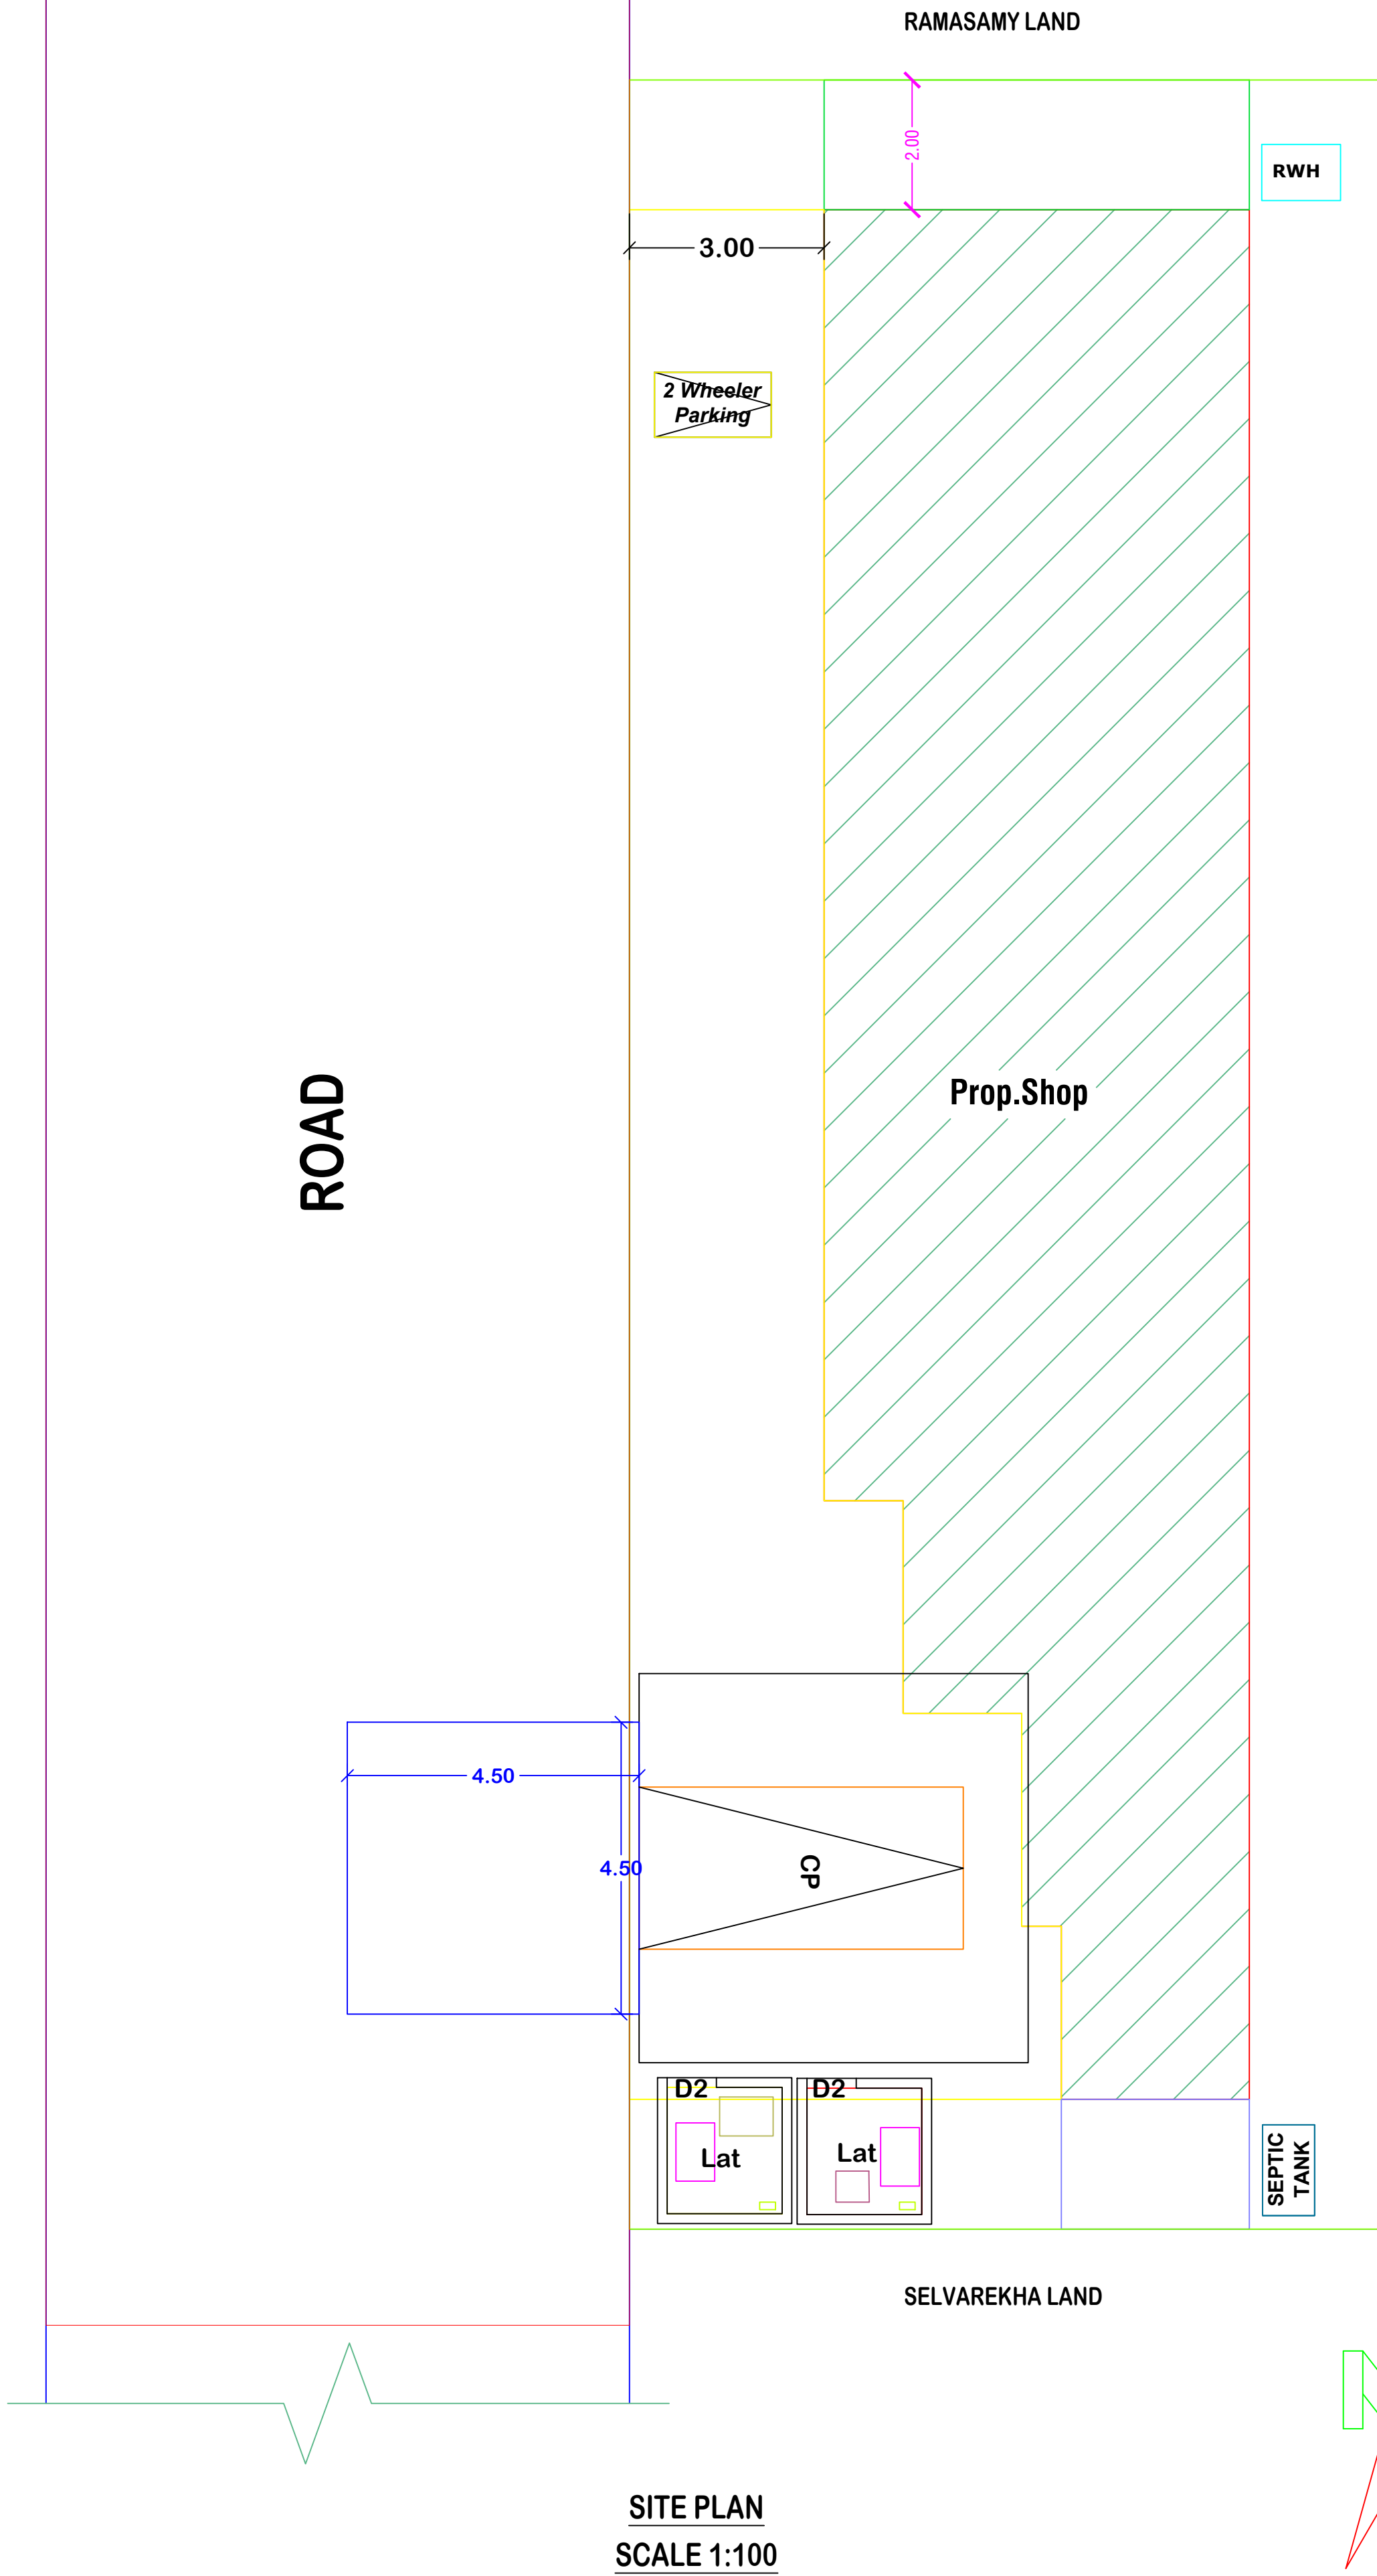

SITE PLAN
SCALE 1:100

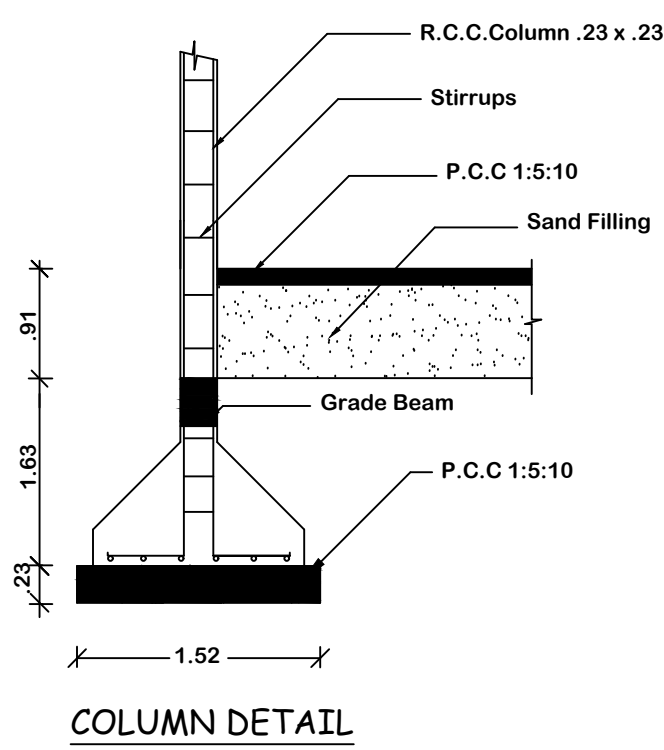

COLUMN DETAIL

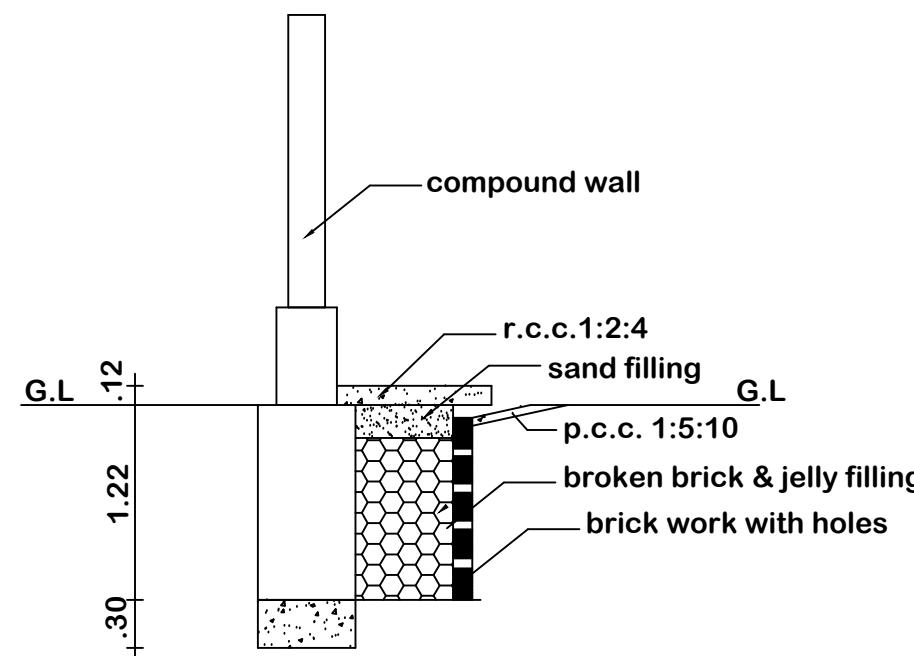

PLINTH BOUNDARY PERCOLATION PIT

PLAN SHOWING THE PROPOSED CONSTRUCTION OF RCC ROOF
COMMERCIAL BUILDING IN GROUND FLOOR IN S.NO: 161/2B1A ,
ULUPPAKUDI , PUNNAPATTY VILLAGE PANCHAYAT, NATHAM
TALUK , DINDIGUL DISTRICT.

NAME OF APPLICANT :- Mr.N.GOPINATH , S/O. Mr.U.S.A.NATARAJAN
Mr.N.ARUNACHALAM , S/O. Mr.U.S.A.NATARAJAN

AREA DETAILS			
REF.	DESCRIPTION	SQ.M	SQ.FT.
□	SITE AREA	930.78	10019
□	PRO. BUILDING AREA IN G.F	167.38	1802
□	OPEN AREA	763.40	8217
□	F.S.I	0.18	

JOINERY DETAILS		
R.S	Rolling Shutter	2.00 x 2.10
MD	Door	1.00 x 2.10
D1	Door	0.91 x 2.10
D2	Door	0.75 x 2.10
W5	Window	1.50 x 1.50
W4	Window	1.20 x 1.50
V3	Ventilator	0.90 x 0.60

ALL DIMENSIONS ARE IN METRE, SCALE 1:100

Note:

Waste Water Used for Garden
Rain Water harvesting Details Provided
Solar System Water tank provided
Rain water harvesting tank to be provided

OFFICE USE

APPLICANT

ENGINEER