



PLAN SHOWING THE PROPOSED CONSTRUCTION OF A RCC ROOF GROUND FLOOR COMMERCIAL GODOWN BUILDING IN NEW S.F NO-2/48 & PATTA NO-1371, AT ULUNDURPET MAIN ROAD, PLOT NO-9, ANBU NAGAR, KATTUNEMILI REVENUE VILLAGE AND PANCHAYAT ULUNDURPET TALUK & KALLAKURICHI DISTRICT-606 107

APPLICANT NAME: Mrs.NANDHINI W/o Mr.DURAI

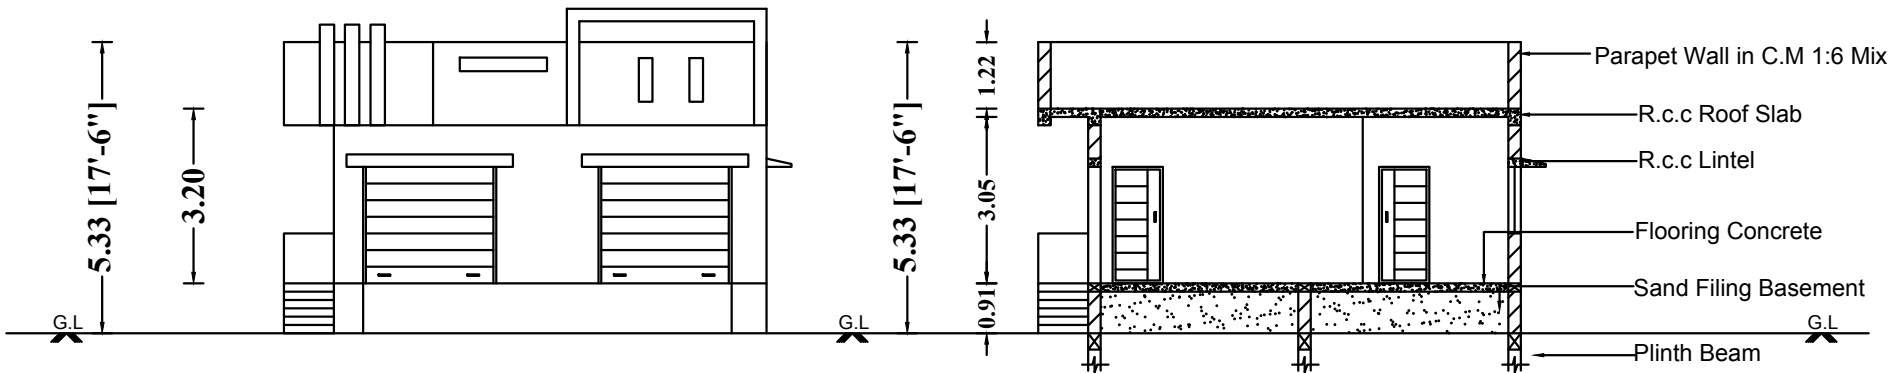


FRONT ELEVATION


SECTION A-A

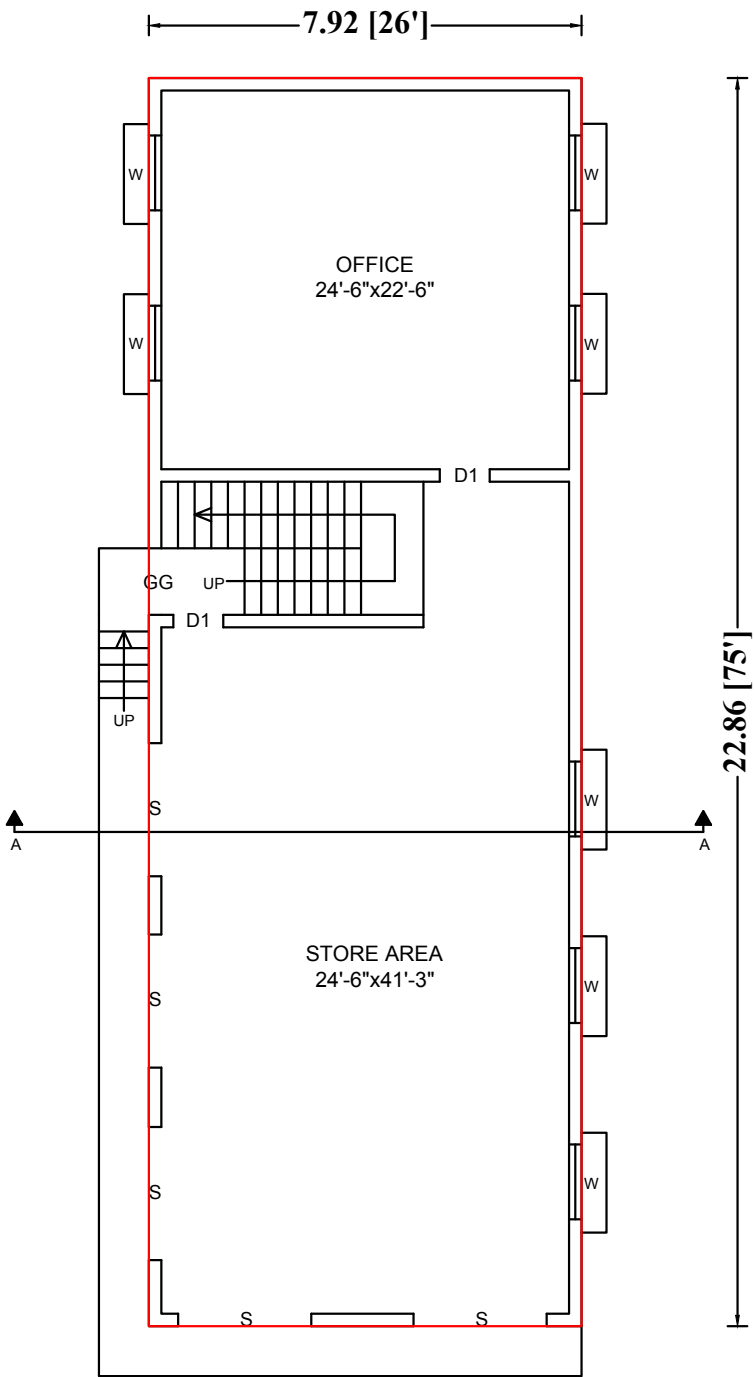

GROUND FLOOR PLAN

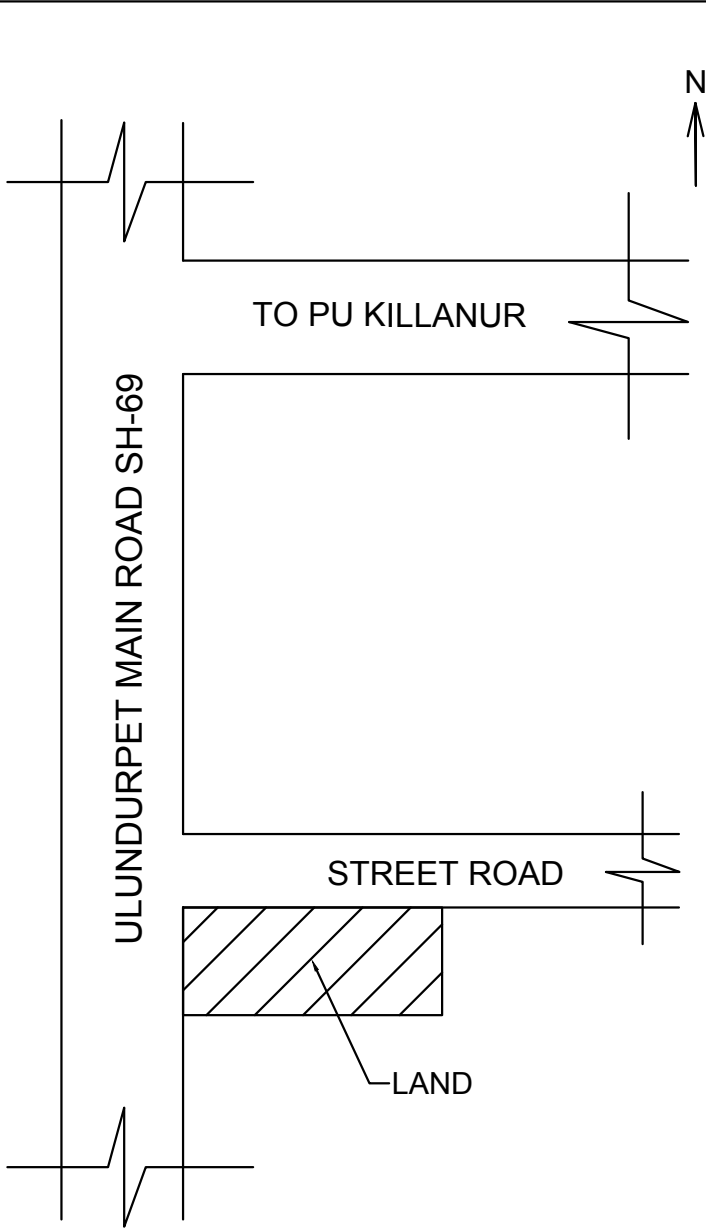

LOCATION PLAN (NOT TO SCALE)

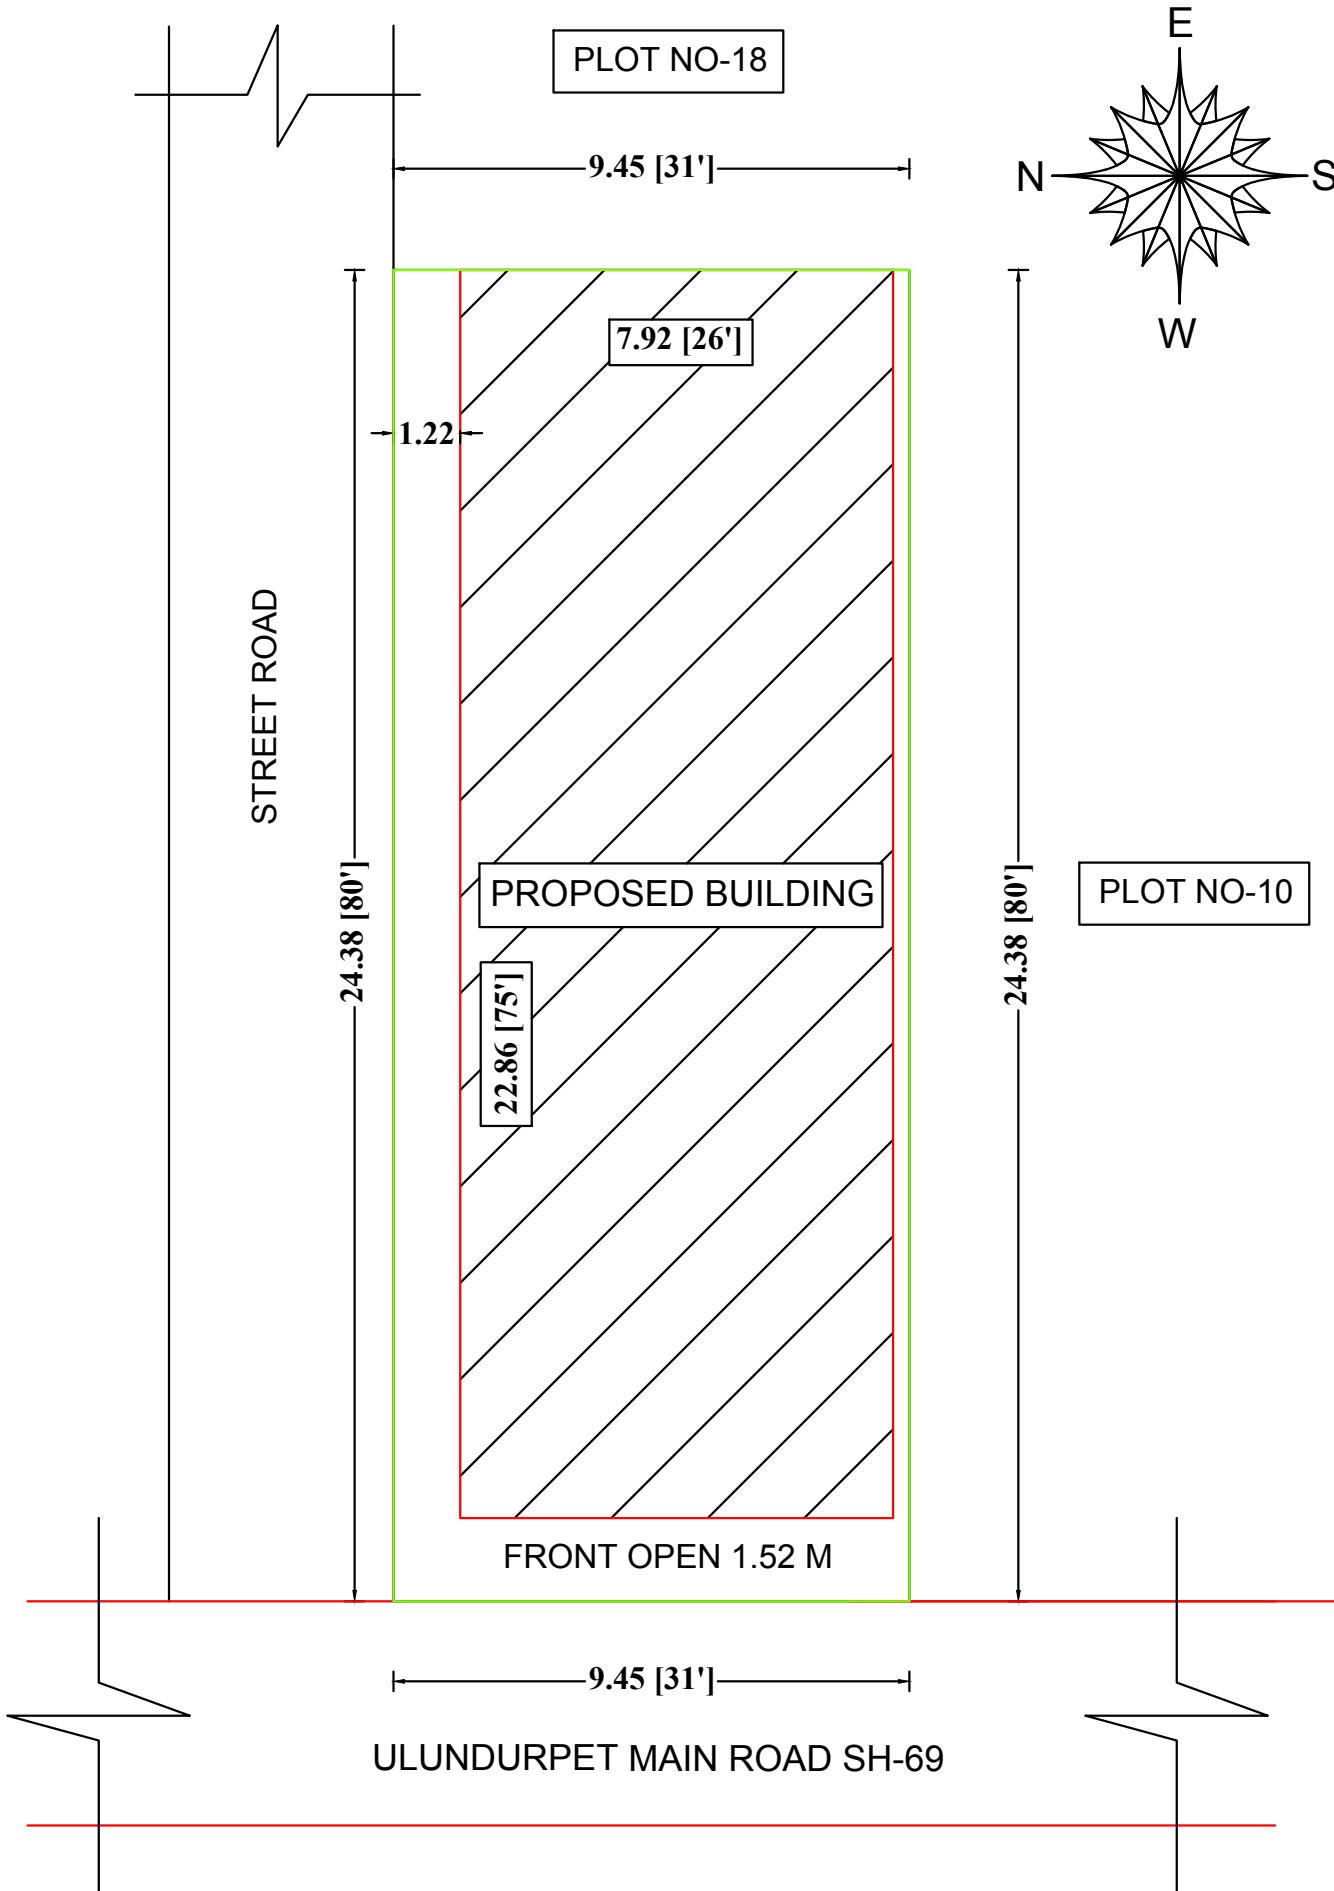

SITE PLAN (SCALE 1:100)

(THIS DRAWING IS DIGITALLY SIGNED)

COLOR INDEX		
	SITE BOUNDARY	
	R.C.C ROOF BUILDING	
	ROAD DETAILS	

PARKING STALL DETAILS		
BIKE SPACE	0	1
SCALE =(1:100)	All Dimensions Are In Meters	
SCHEDULE OF JOINERIES		
DESCRIPTION	SIZE IN FEET	SIZE IN M
Shutter-S	8'0" x 7'0"	2.44 x 2.13
Grill Gate - GG	4'0" x 7'0"	1.22 x 2.13
Door - D	3'0" x 7'0"	0.91 x 2.13
Window - W	4'6" x 4'0"	1.37 x 1.22

AREA OF THE PROPOSED CONSTRUCTION DETAILS		
DESCRIPTION	SQ.FT	SQ.M
Total Site Area (as per Document)	2480.00	230.39
Ground Floor Area (Commercial)	1950.00	181.16
Area of the Open Space	530.00	49.23
Total Builtup Area=181.16 Sqm / 1950.00 Sft		
FSI = Total Builtup Area / Total Site Area =0.786		


D.Nandhini

Mrs.NANDHINI W/o Mr.DURAI


APPLICANT NAME & SIGNATURE




QR CODE

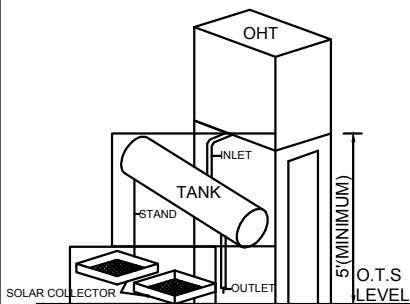


SOLAR WATER HEATING SYSTEM

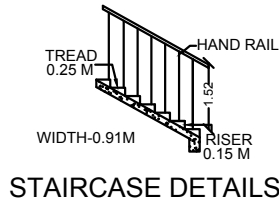


STAIRCASE DETAILS

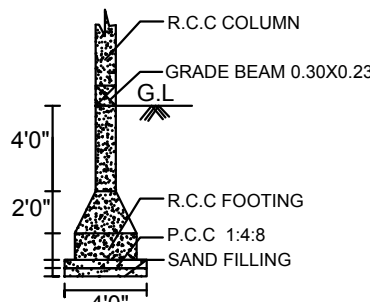


COLOUMN FOUNDATION DETAILS

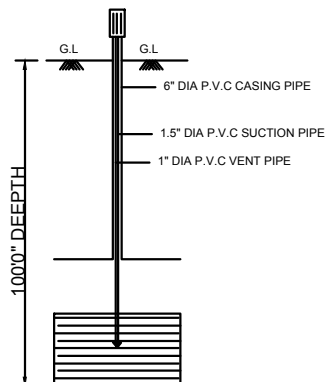

BORE WELL

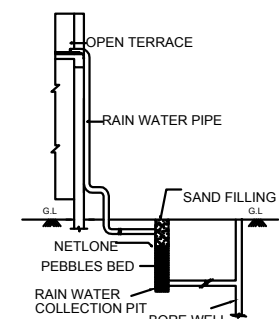

RAIN WATER HARVESTING SYSTEM

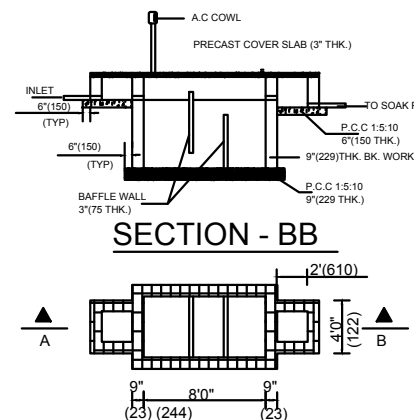

PLAN OF SEPTIC TANK

Er. M. Anand, B.E., M.Tech.,
Civil & Structural Engineer
Registered Engg. (Municipality)
(Reg. No. 176/LS/2022/00001)
ANAND CONSTRUCTIONS
Annai Therasa Nagar, Ulundurpet,
Cell: 94420 40280, 90801 50280

ENGINEER / L.B.S