



PLAN SHOWING THE PROPOSED CONSTRUCTION OF GROUND FLOOR RCC ROOF RESIDENTIAL BUILDING IN S.NO: 141 / 1C1 , WARD NO: ,
POTHURAVUTHANPATTI VILLAGE AND PANCHAYAT , KRISHNARAYAPURAM UNION TALUK , KARUR DISTRICT.
NAME OF APPLICANT :- Mr.P.DHANAPAL , S/O. Mr.PALANISAMY.

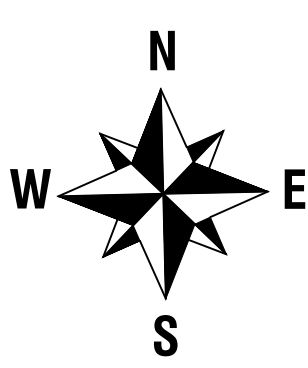



SCHEDULE OF JOINERY			COLOUR INDEX	
MD	MAIN DOOR	1.00 X 2.13	PROPOSED	
A/O	ARCH OPEN	0.91 X 2.13		
D1	DOOR	0.91 X 2.13		
D2	DOOR	0.76 X 2.13	ROAD	
W	WINDOW	1.52 X 1.22		
J	JOLLY	1.52 X 1.22	SITE BOUNDARY	
V	VENTILATOR	0.76 X 0.76		




ELEVATION

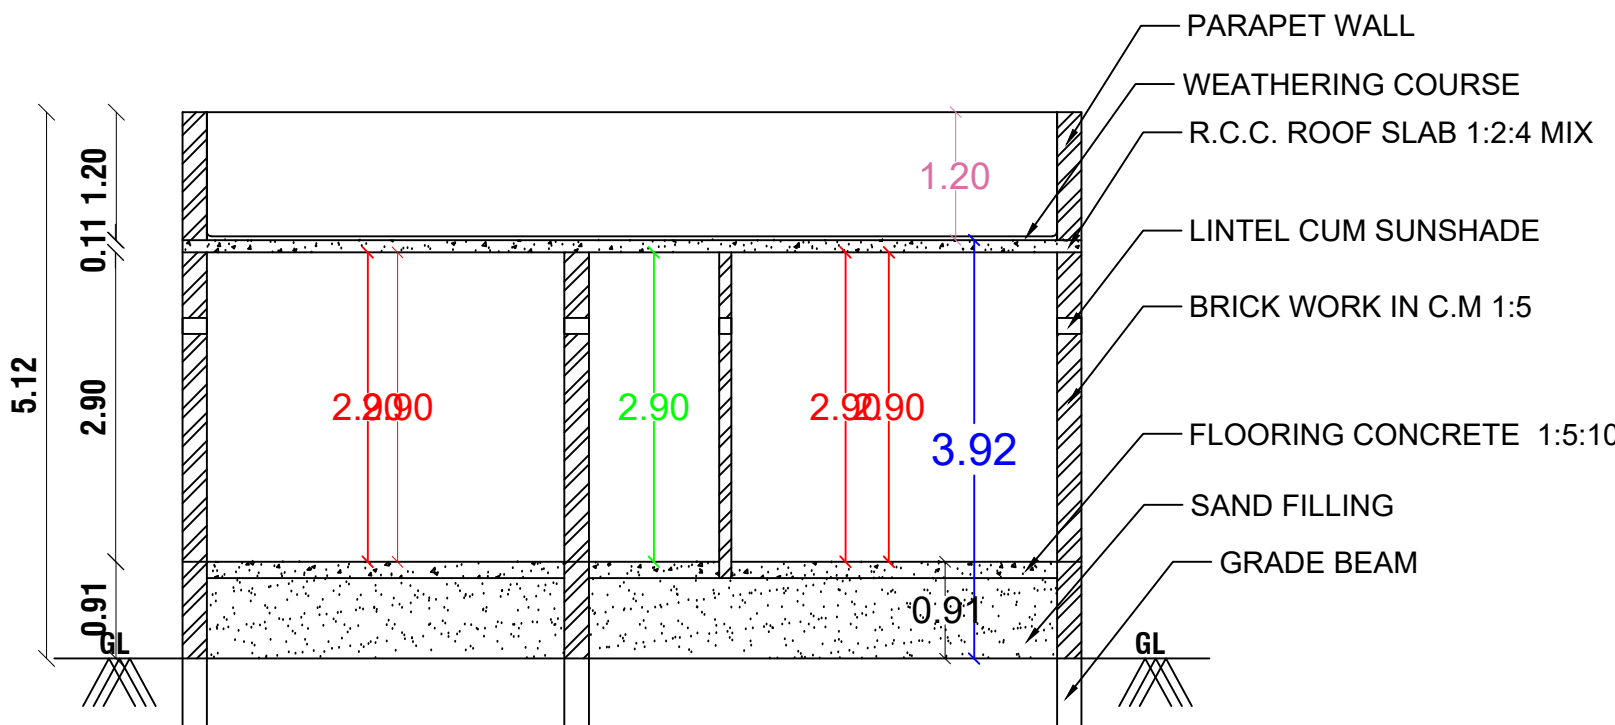







SECTION-AA

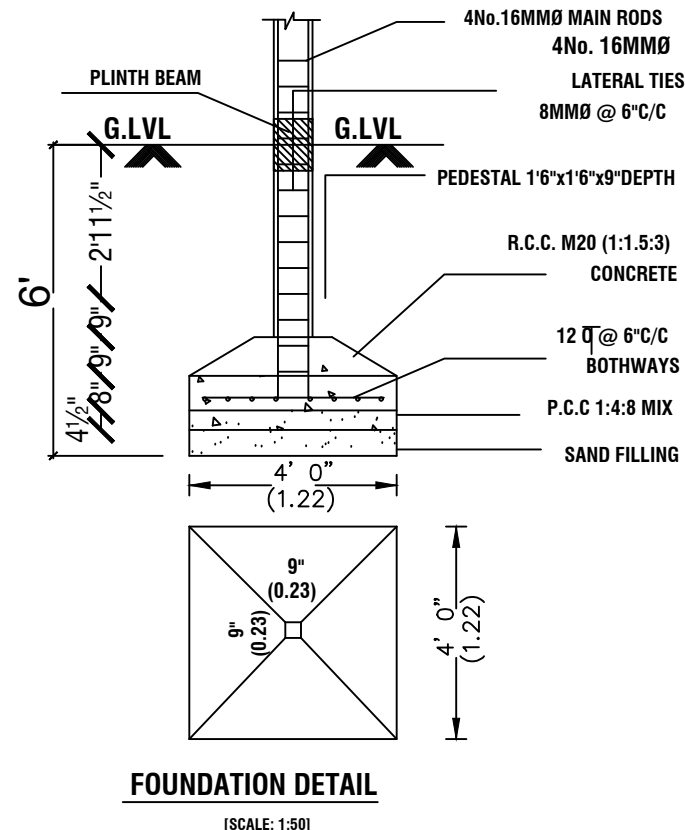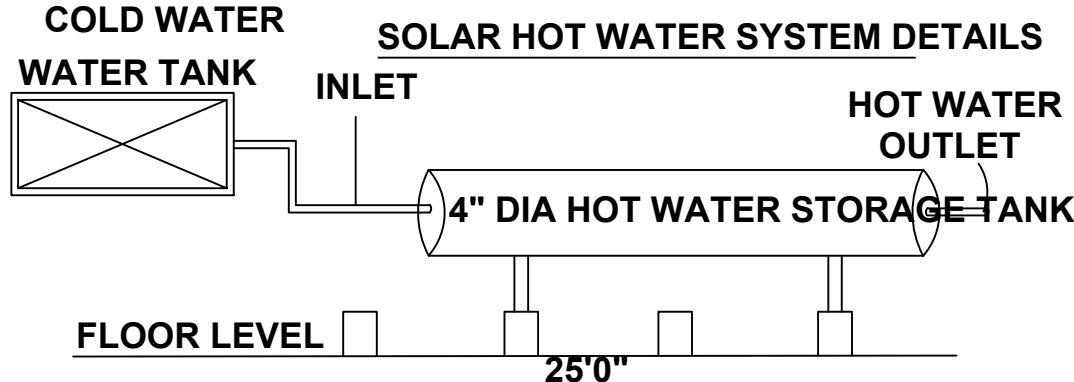

AREA DETAILS		SQ.MT	SQ.FT
PLOT AREA(AS PER DOCUMENT)		1025.00	11033.01
PLOT AREA(AS PER SUPERIMPOSED)		1025.00	11033.01
PLINTH AREA		121.34	1306.09
OPEN SPACE		903.66	9726.92
F.S.I		0.12	

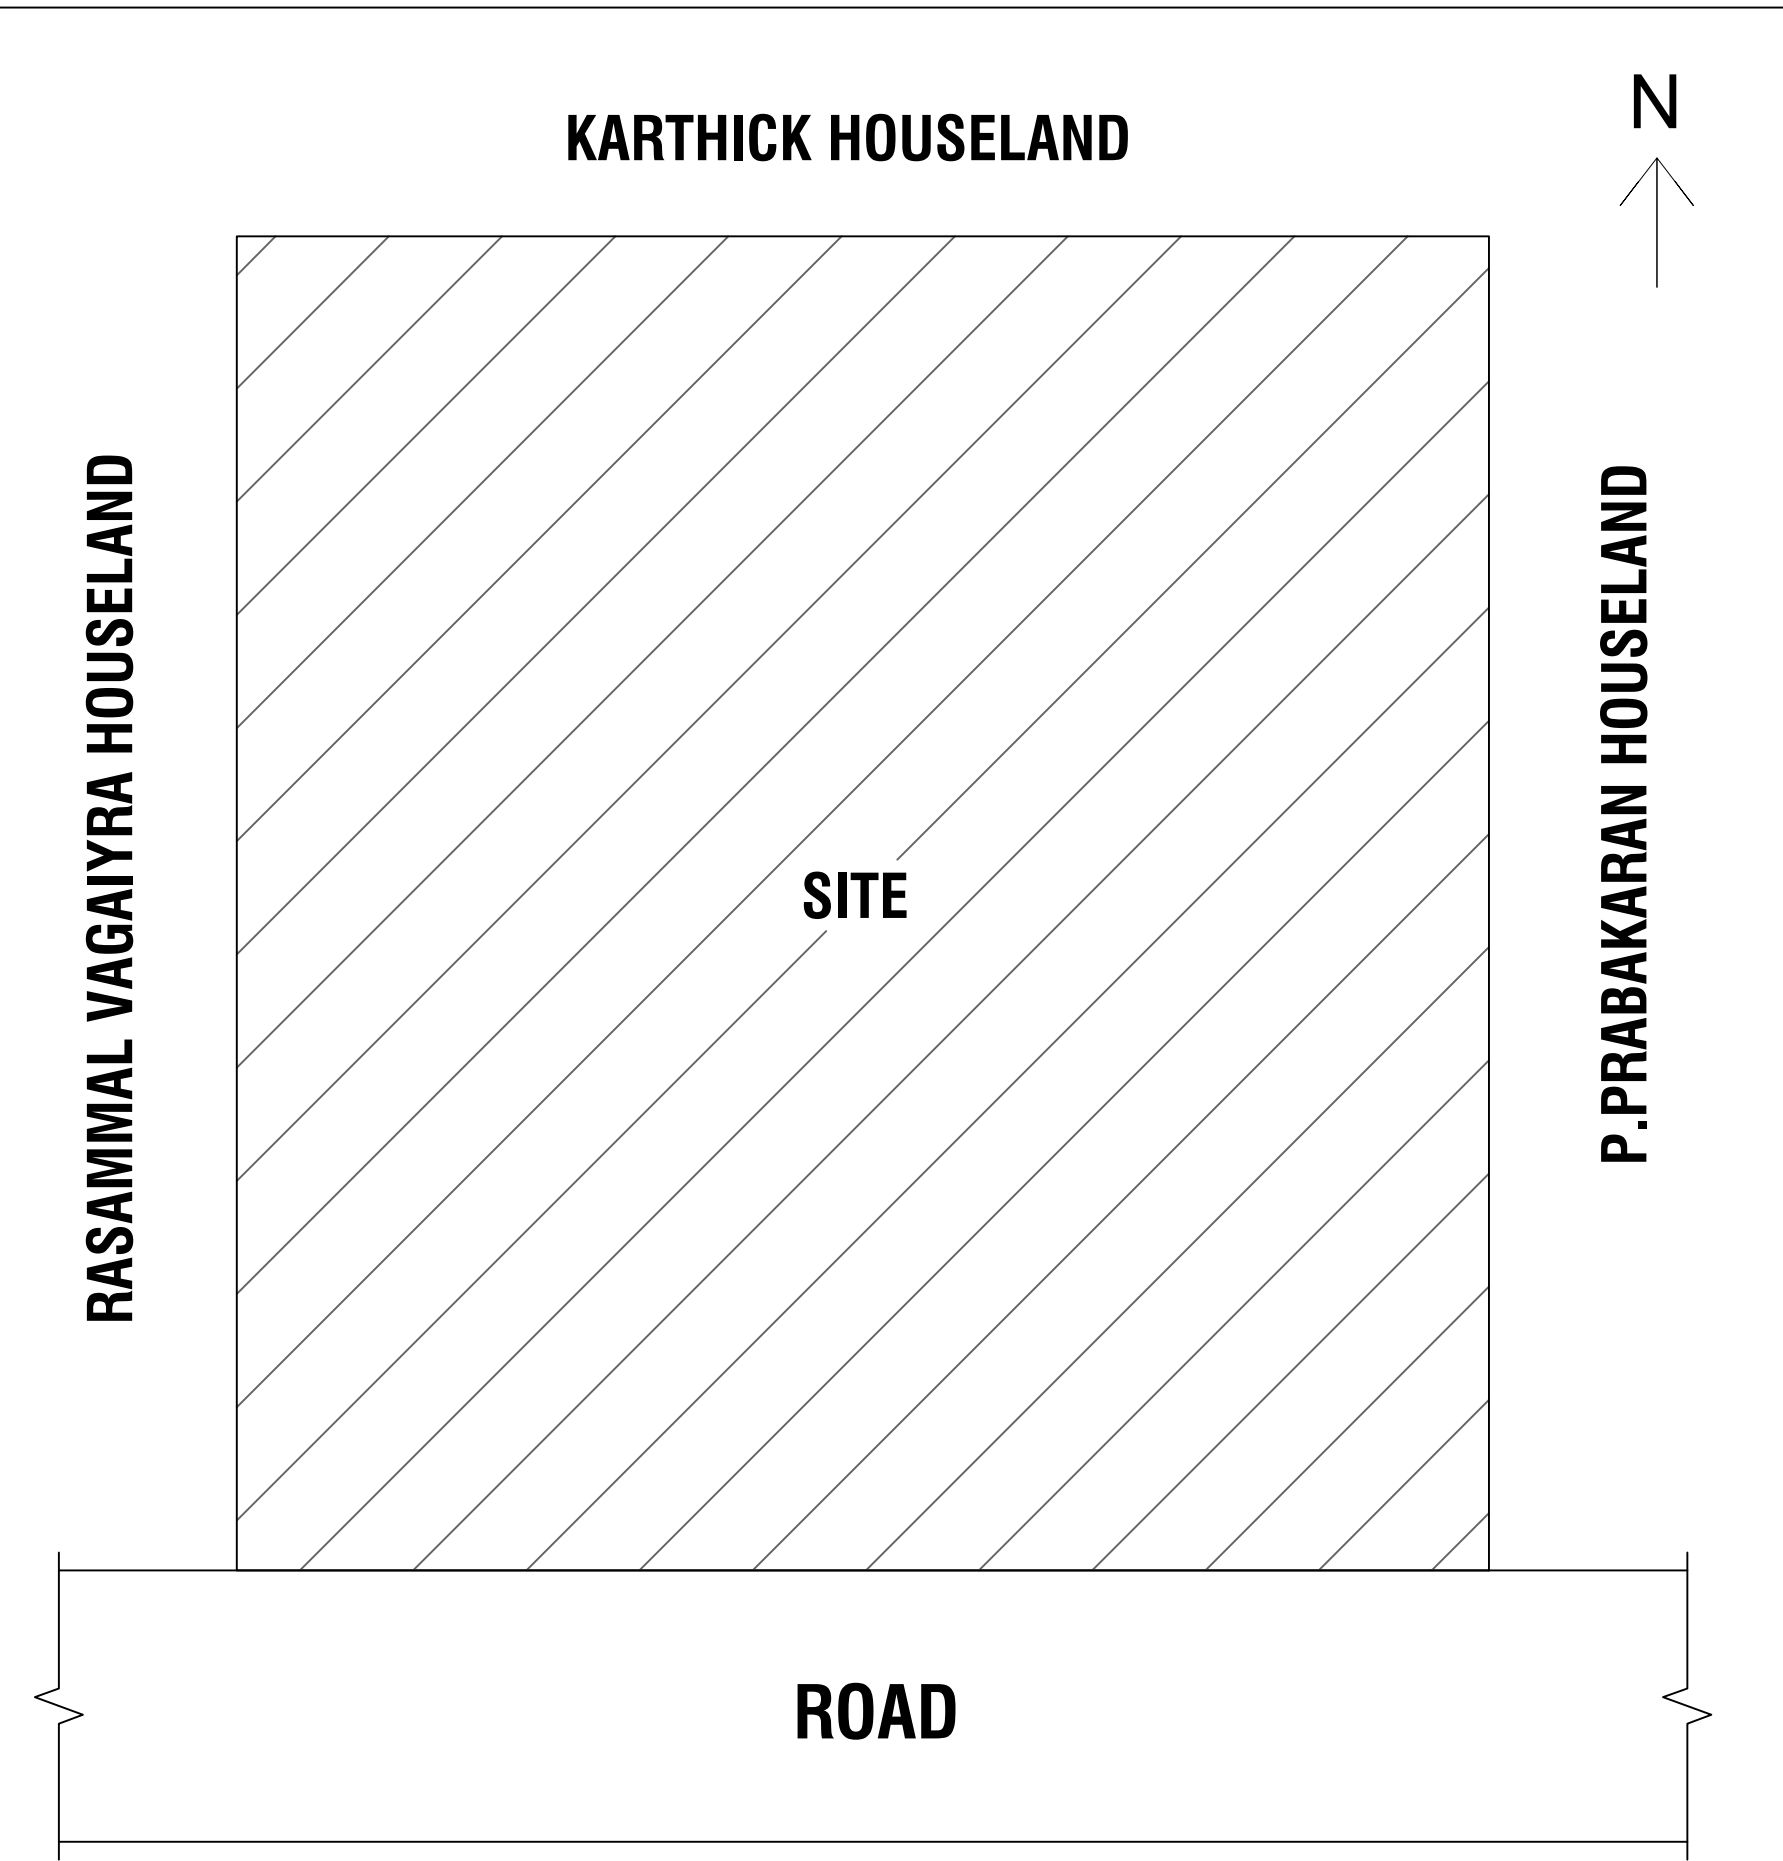

KEY PLAN (N.T.S)

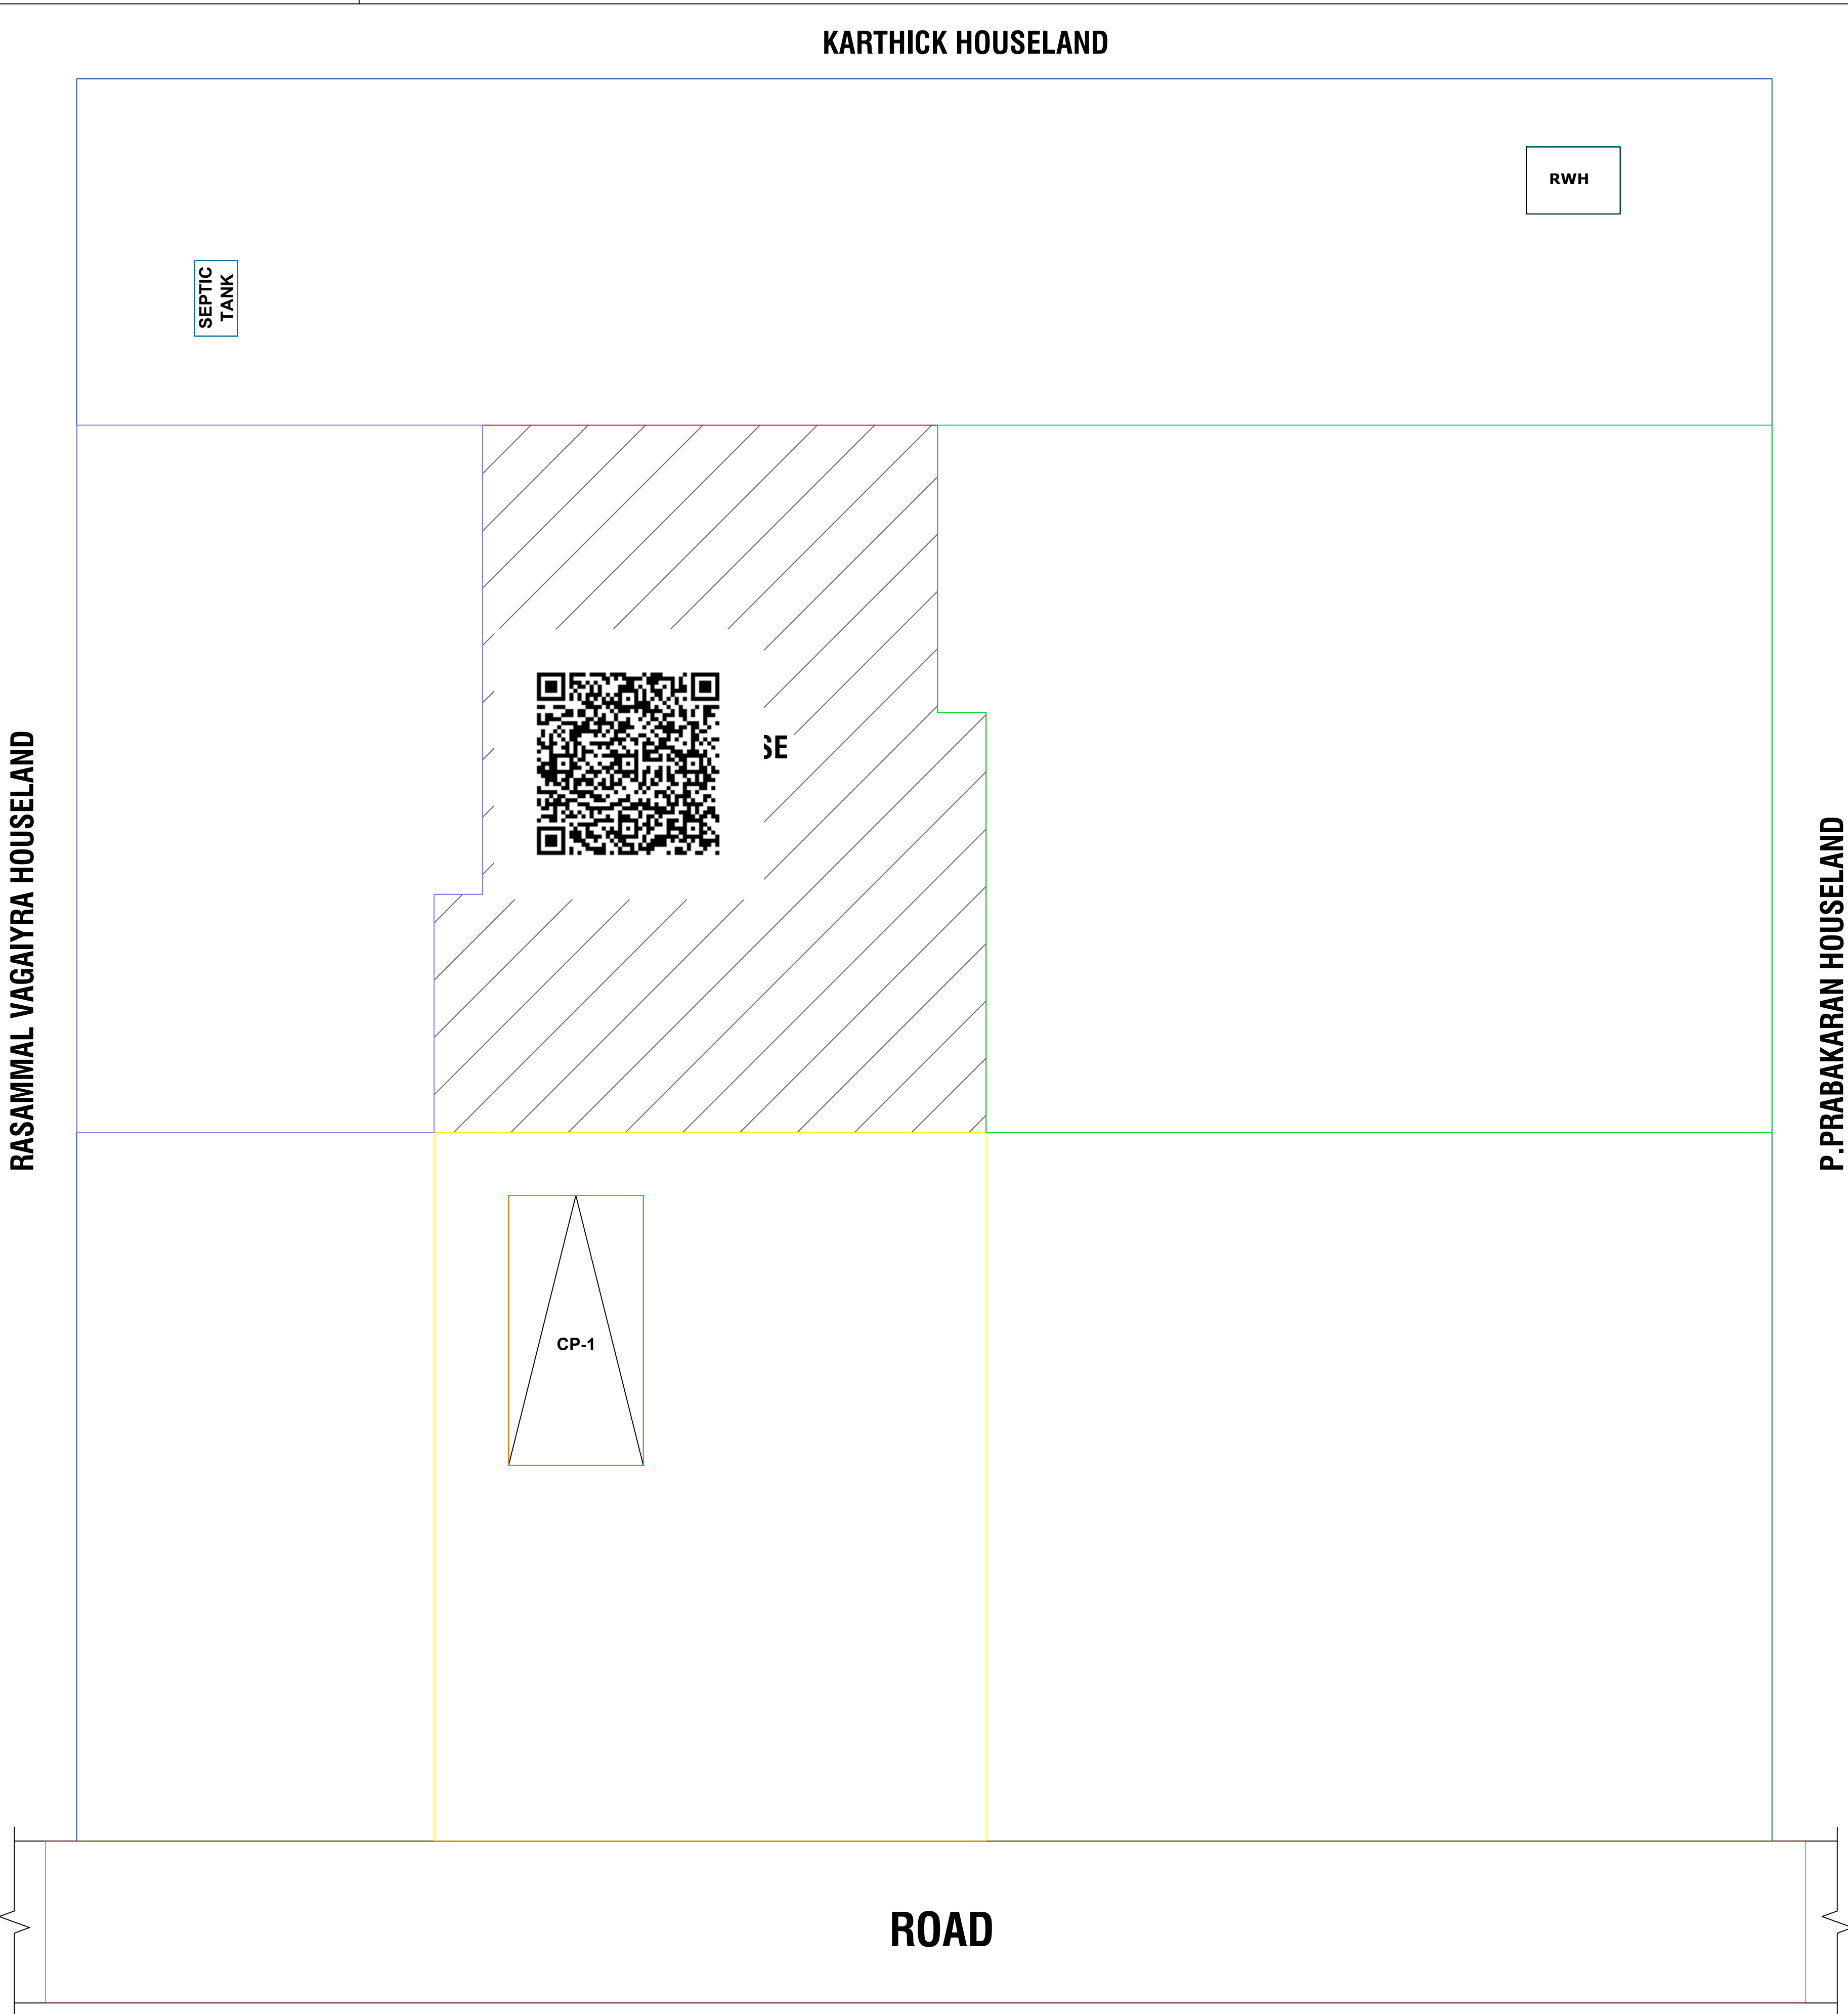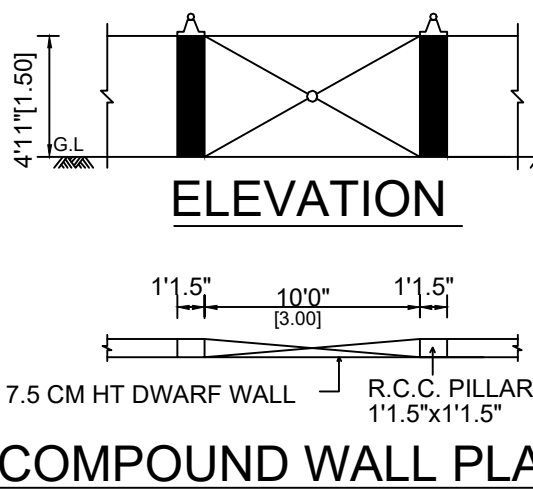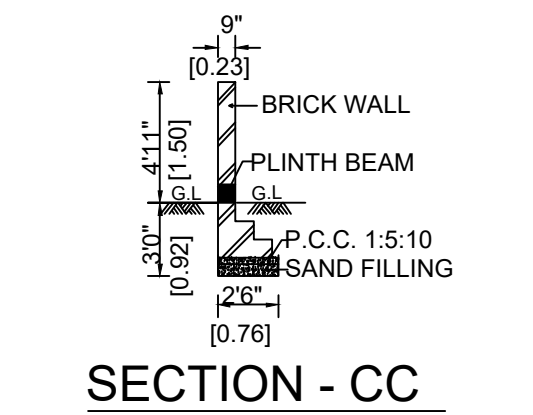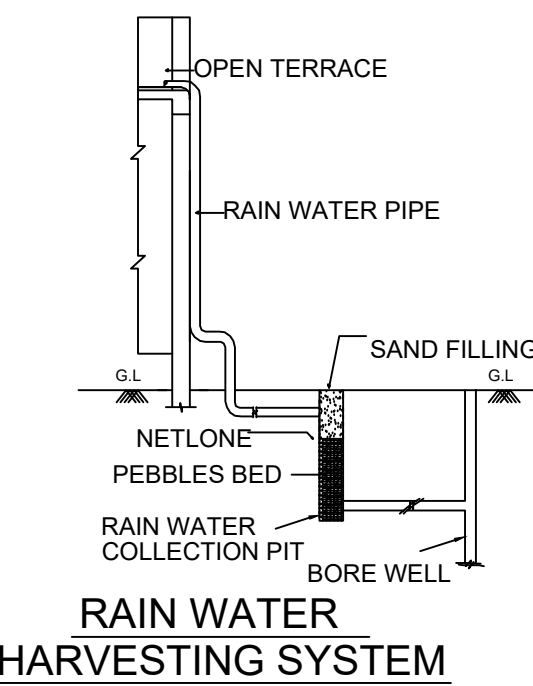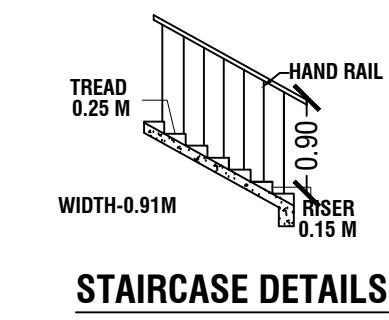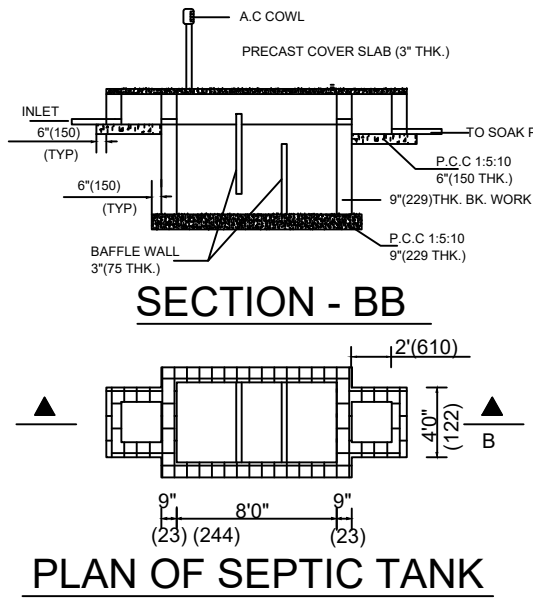

SITE PLAN

SCALE 1:100

NOTE:-
ALL DIMENSIONS ARE IN METRE
ALL ROUND COMPOUND WALL PROVIDED.
RAINWATER PERCOLATION PITS PROVIDED ALL ROUND THE SITE.
S.T.P PROVIDED IN THE SE CORNER OF THE SITE.
SUMP AND FIRE SUMP PROVIDED.
LIGHTNING CONDUCTOR PROVIDED IN THE ROOF.
FIRE EXTINGUISHER & EMERGENCY ALARM IS PROVIDED.
BORE WELL WITH MOTAR, WATER TANK AND
MUNICIPAL WATER SUPPLY WILL BE PROVIDED.
SULLAGE WASTE FROM TOILET WILL BE CONNECTED INTO SEPTIC TANK.
RAIN WATER PERCOLATION BED 1.0m WIDE PROVIDED AS PER GO (MS) NO: 138 DATED 11-02-02.
RAIN WATER TAKEN TO THE BORE WELL THROUGH 150MM DIA PIPES
SOLAR WATER HEATER WILL BE PROVIDED.
AT KITCHEN EXHAUST FAN TO BE PROVIDED.

P. Dhana

OWNER'S SIGNATURE

OFFICE USE

K. Suresh

REGISTERED ENGINEER