


PLAN SHOWING THE PROPOSED CONSTRUCTION OF A R.C.C. ROOF GROUND FLOOR RESIDENTIAL BUILDING IN S.F.NO :1150/37, AT KASPA JEGADABI, JEGADABI VILLAGE PANCHAYAT, KARUR TALUK AND KARUR DISTRICT.

NAME OF THE OWNER : Mr.T.MOORTHY, S/o Mr.THANGAVEL





IES
IN METER
1.21 X 2.13
1.00 X 2.13
0.76 X 2.13
1.00 X 2.13
1.21 X 1.21
1.82 X 1.52
1.00 X 0.61

DETAILED PLAN:
SCALE 1:100

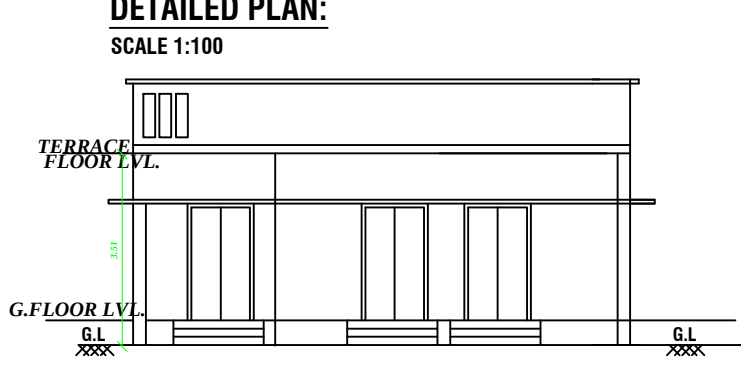


ELEVATION

SECTION "A-A"

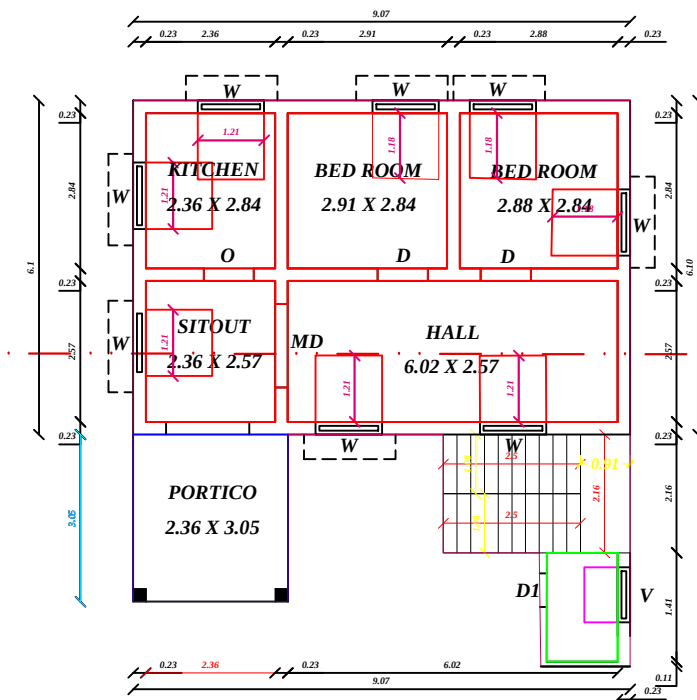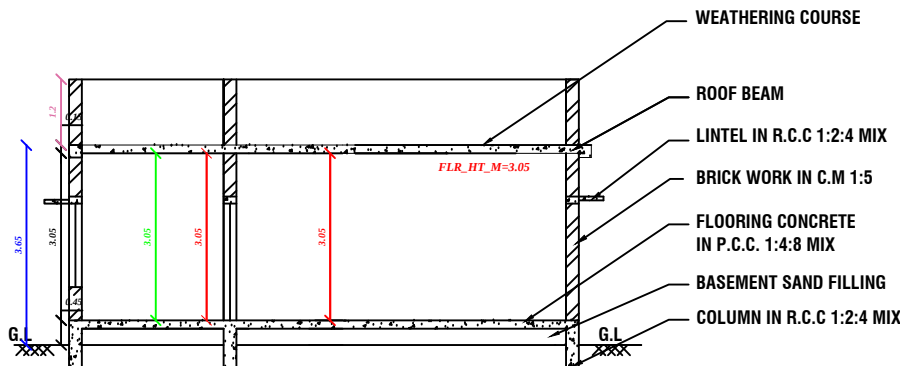


FLOOR - GROUND
PRO. GROUND FLOOR PLAN

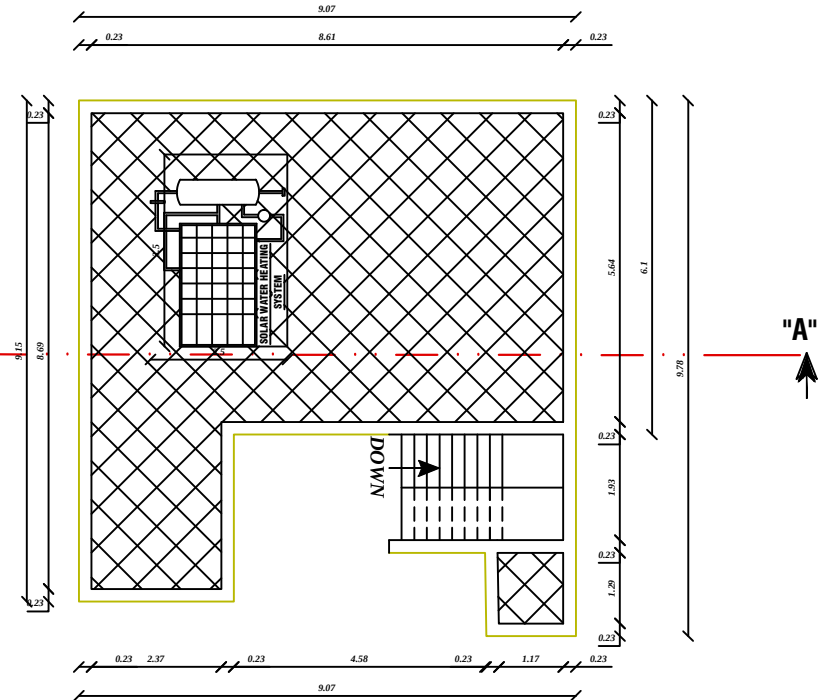


FLOOR - TERRACE
PRO.TERRACE FLOOR PLAN


NOT TO SCALE:

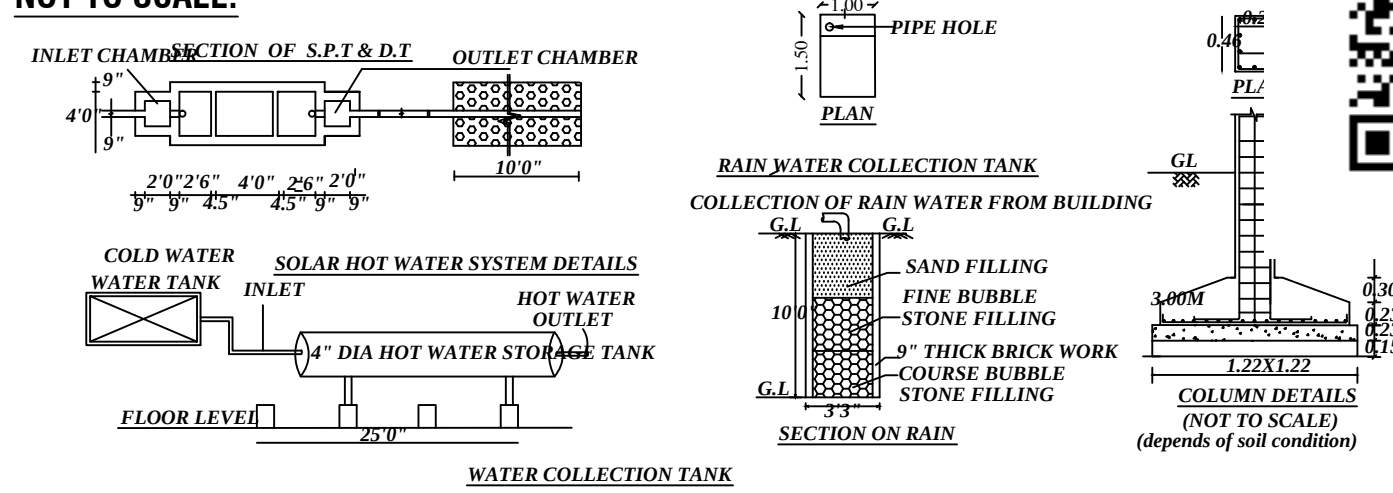


SOLAR WATER HEATING
SYSTEM

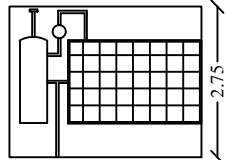


RR MASONRY DETAILS

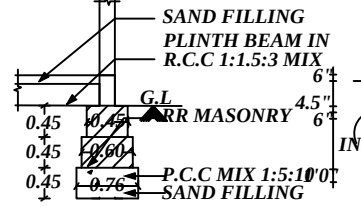

SEPTIC TANK DETAILS

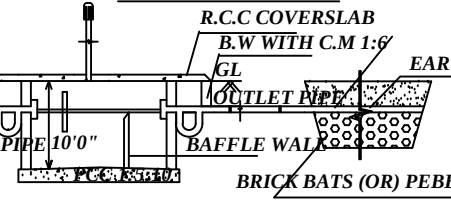


HAND RAILS HT-1.20M

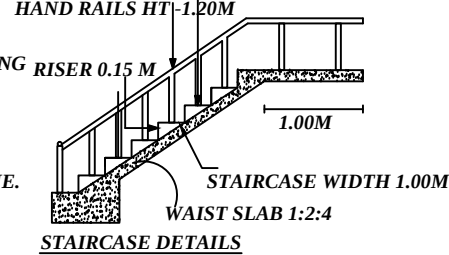

SITE PLAN:PROPOSED

SCALE 1:100

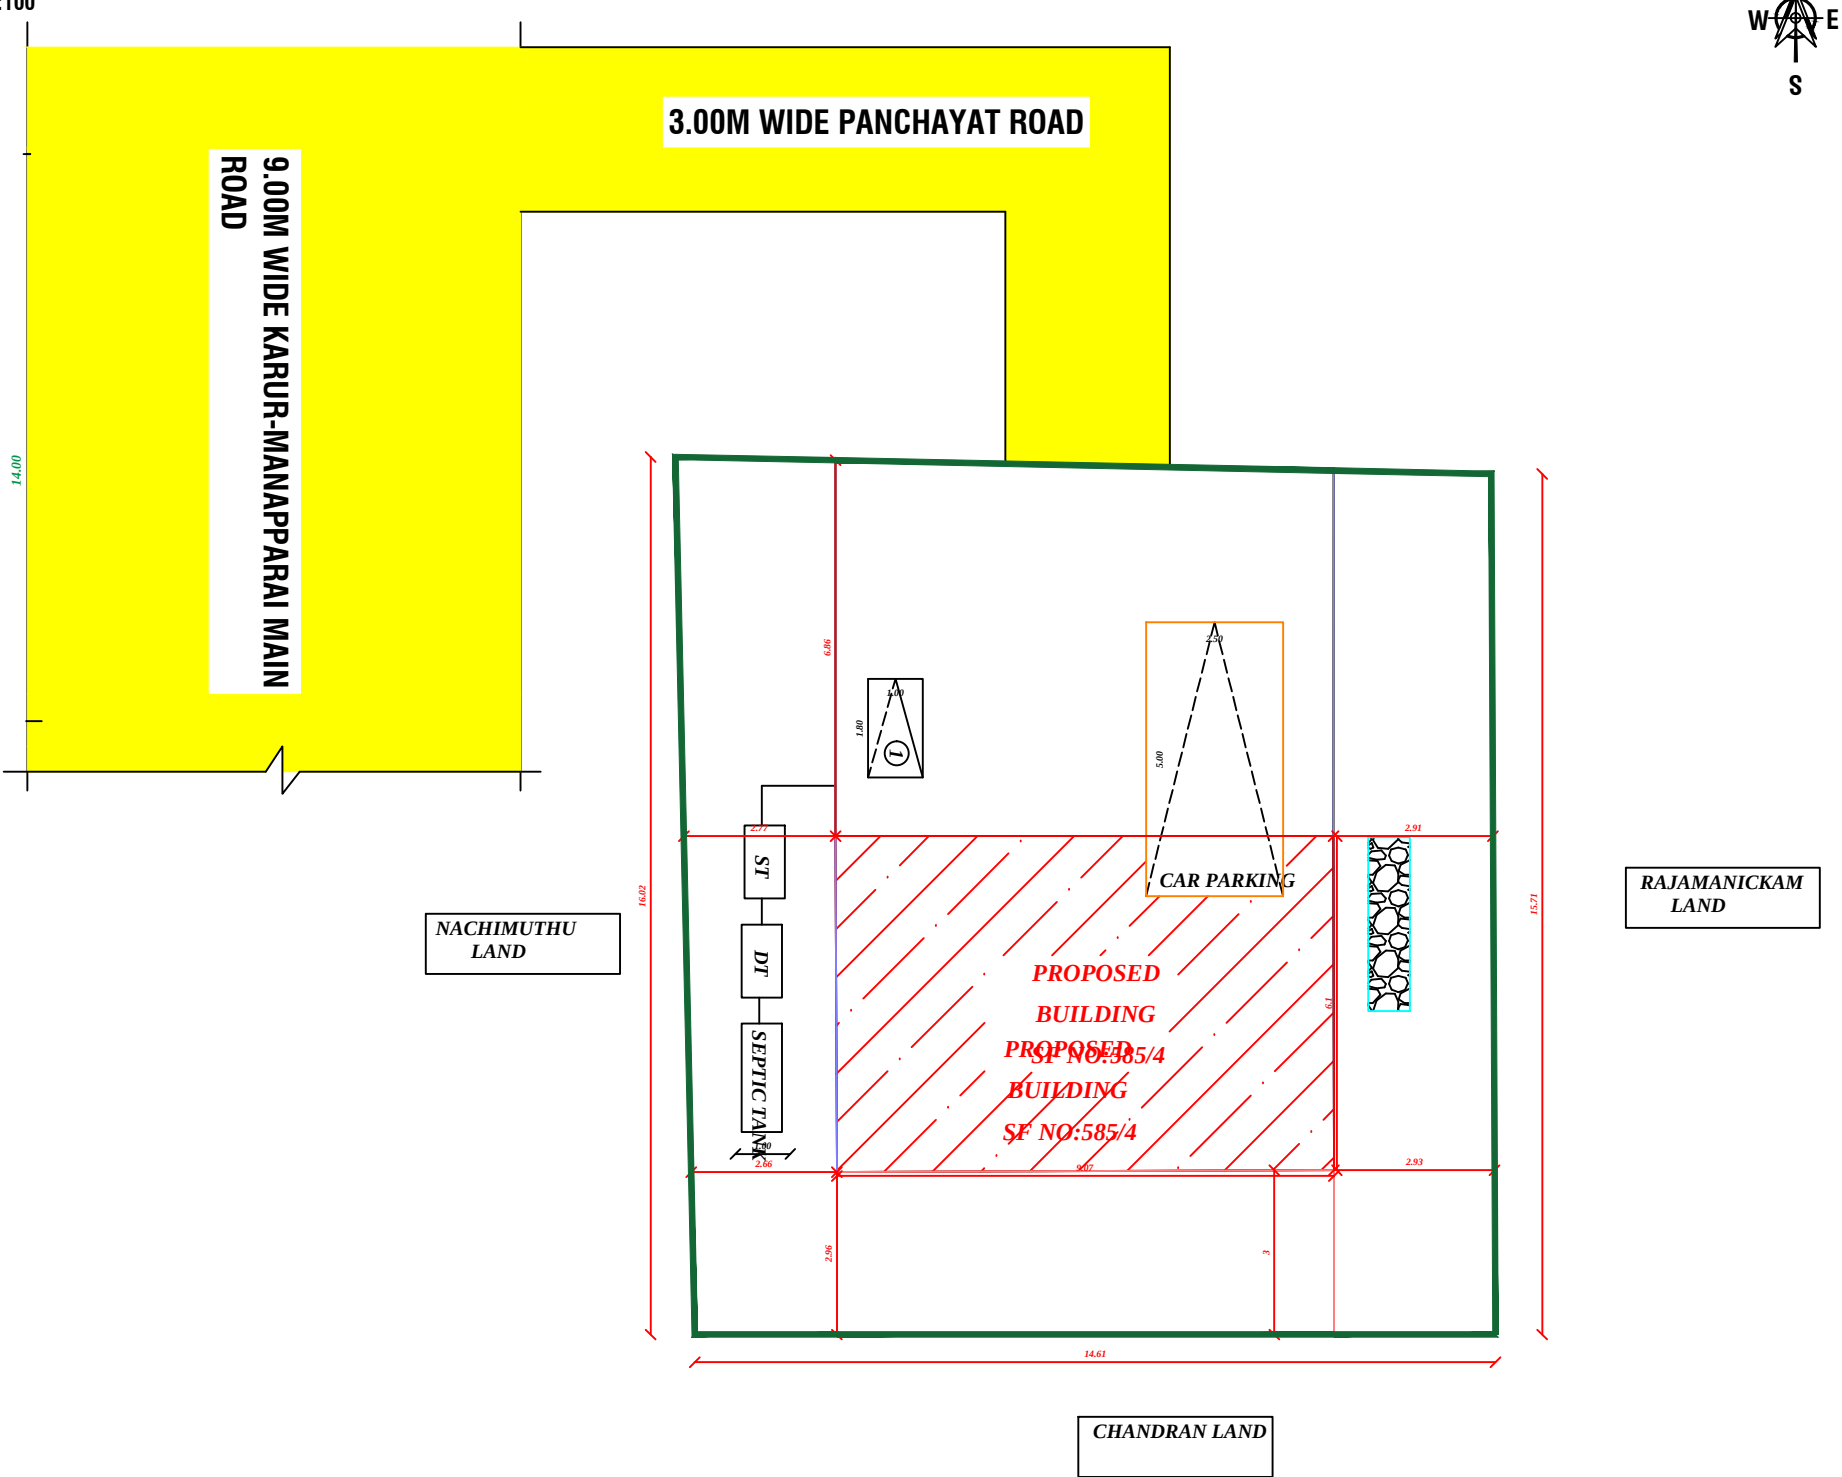

V	VENTILATOR	3'3" X 2'0"	1.00 X 0.61
EX	EXHAUST FAN	12" DIA	
AREA OF CALCULATION		SQ.FT	SQ.M
AREA OF PLOT EXTENT		2508.00	233.00
FMB/TSR PLOT EXTENT		2508.00	233.00
AREA AS PER DOCUMENT		2508.00	233.00
SUPER IMPOSED PLOT BOUNDARY		2508.00	233.00
AREA OF R.C.C BUILDING IN G.F		794.16	73.78
AREA OF OPEN SPACE		1713.84	159.22
CARPET AREA OF G.F		491.16	45.63
PERCENTAGE OF SITE COVERAGE		-	24.41 %
FLOOR SPACE INDEX(NON PREMIUM)		-	0.65
NO.OF DWELLING UNITS		-	1 No's.
HEIGHT OF THE BUILDING		-	3.65M

PARKING DETAILS:

NO.OF OPEN CAR PARKING	-	1 No's.
NO.OF OPEN TWO WHEELER PARKING	-	1 No's.

COLOURS OF INDEX:

EXISTING ROAD SHOWN IN	-	Yellow
BOUNDARY SHOWN IN	-	Green
PRO.BUILDING SHOWN IN	-	Red
RAIN WATER COLLECTION TANK	-	Blue

NAME OF THE OWNER:

Mr.T.MOORTHY, S/o Mr.THANGAVEL

- NOTE:-
- * ALL DIMENSIONS ARE IN METRE
 - * ALL ROUND COMPOUND WALL PROVIDED.
 - * RAINWATER PERCOLATION PITS PROVIDED ALL ROUND THE SITE.
 - * S.T.P PROVIDED IN THE SE CORNER OF THE SITE.
 - * SUMP AND FIRE SUMP PROVIDED.
 - * LIGHTNING CONDUCTOR PROVIDED IN THE ROOF.
 - * FIRE EXTINGUISHER & EMERGENCY ALARM IS PROVIDED.
 - * BORE WELL WITH MOTAR, WATER TANK AND MUNICIPAL WATER SUPPLY WILL BE PROVIDED.
 - * SULLAGE WASTE FROM TOILET WILL BE CONNECTED INTO SEPTIC TANK.
 - * RAIN WATER PERCOLATION BED 1.0m WIDE PROVIDED AS PER GO (MS) NO: 138 DATED 11-02-02.
 - * RAIN WATER TAKEN TO THE BORE WELL THROUGH 150MM DIA PIPES
 - * SOLAR WATER HEATER WILL BE PROVIDED.
 - * AT KITCHEN EXHAUST FAN TO BE PROVIDED.

REGISTERED ENGINEER:

Er.PK.Vijayaivapurimanibaln.,B.E., CIVIL (Val),
Consulting/Registered Engineer,
DTCP.Reg.no:RE/Gr-II/005/Karur/January/2024,
No.23, Pandarinathan street,
Karur - 639 001.
Mobile : 9487764749.
Email : palamalaivanivel@gmail.com