




PLAN SHOWING THE PROPOSED CONSTRUCTION OF A R.C.C. ROOF GROUND FLOOR RESIDENTIAL BUILDING IN S.F.NO : 46/1A4, AT MAHATHANAPURAM NORTH PART VILLAGE AND PANCHAYAT, KRISHNARAYAPURAM UNION, KRISHNARAYAPURAM TALUK AND KARUR DISTRICT.

NAME OF THE OWNER : Mr N.MOHANAPRASADH S/o Mr K.NAGARAJAN.

DETAILED PLAN:
SCALE 1:100

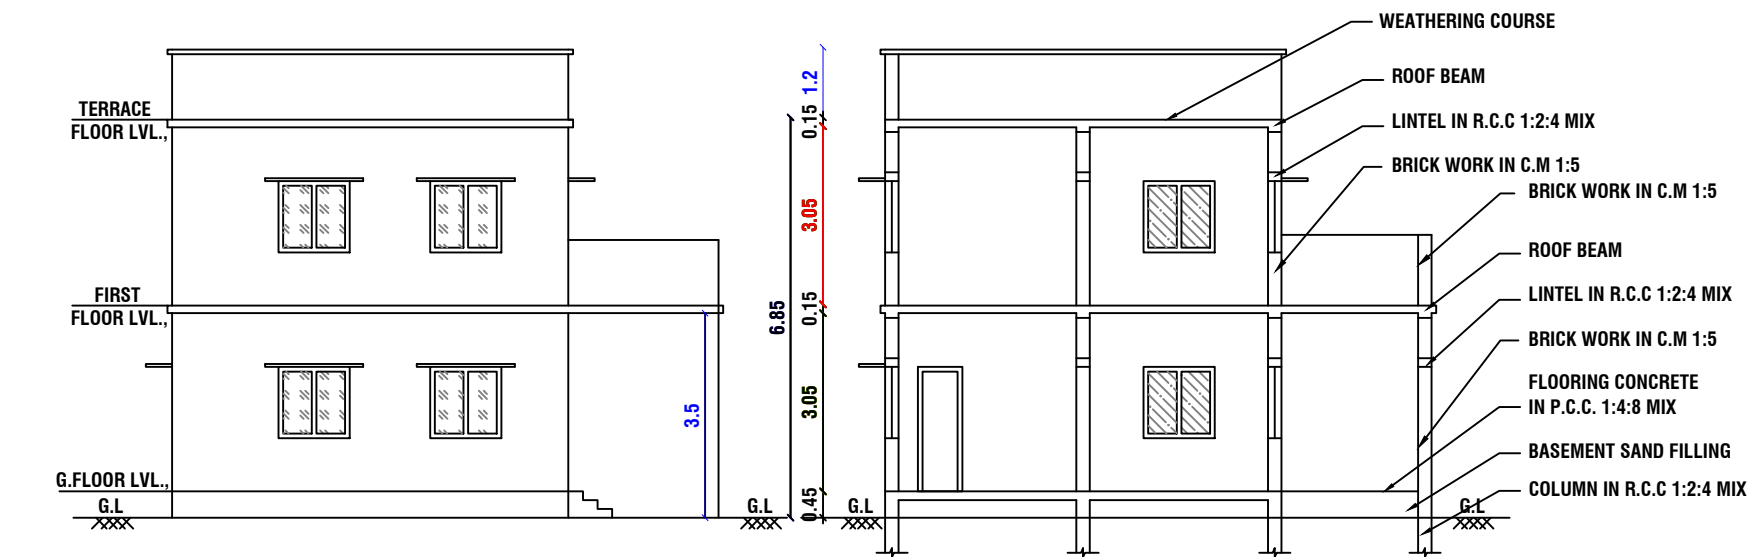


NOT TO SCALE:

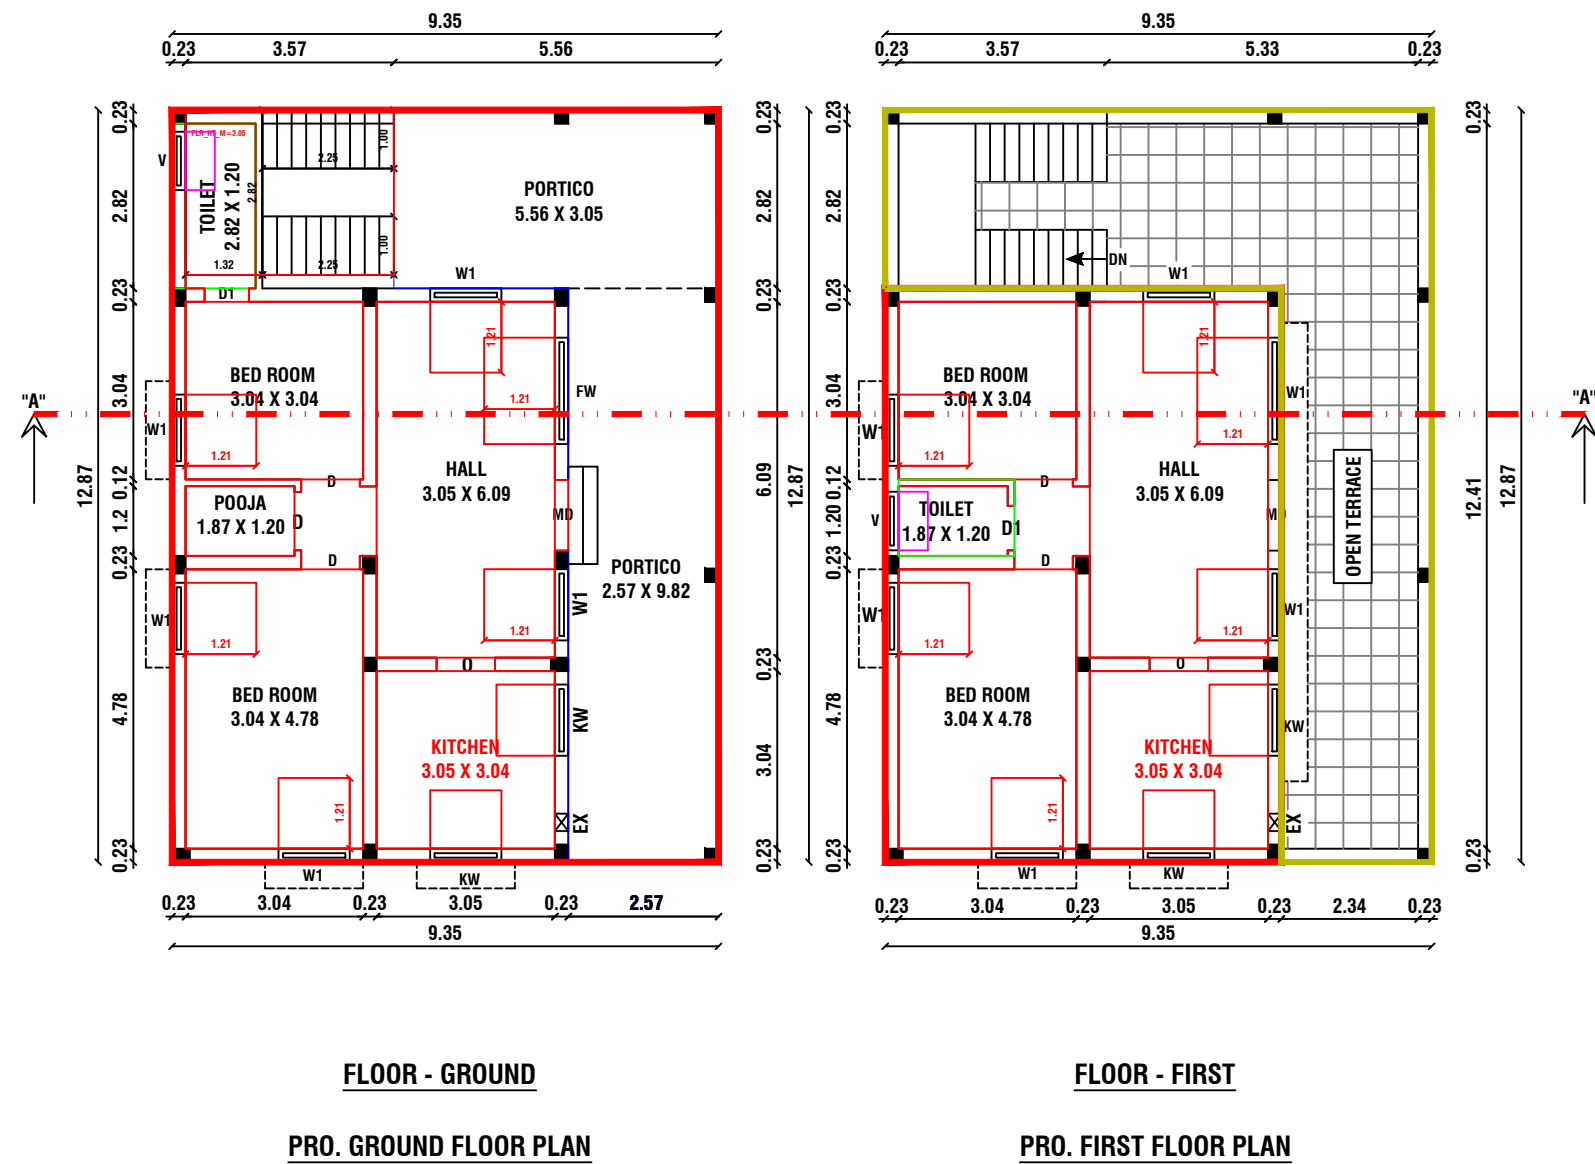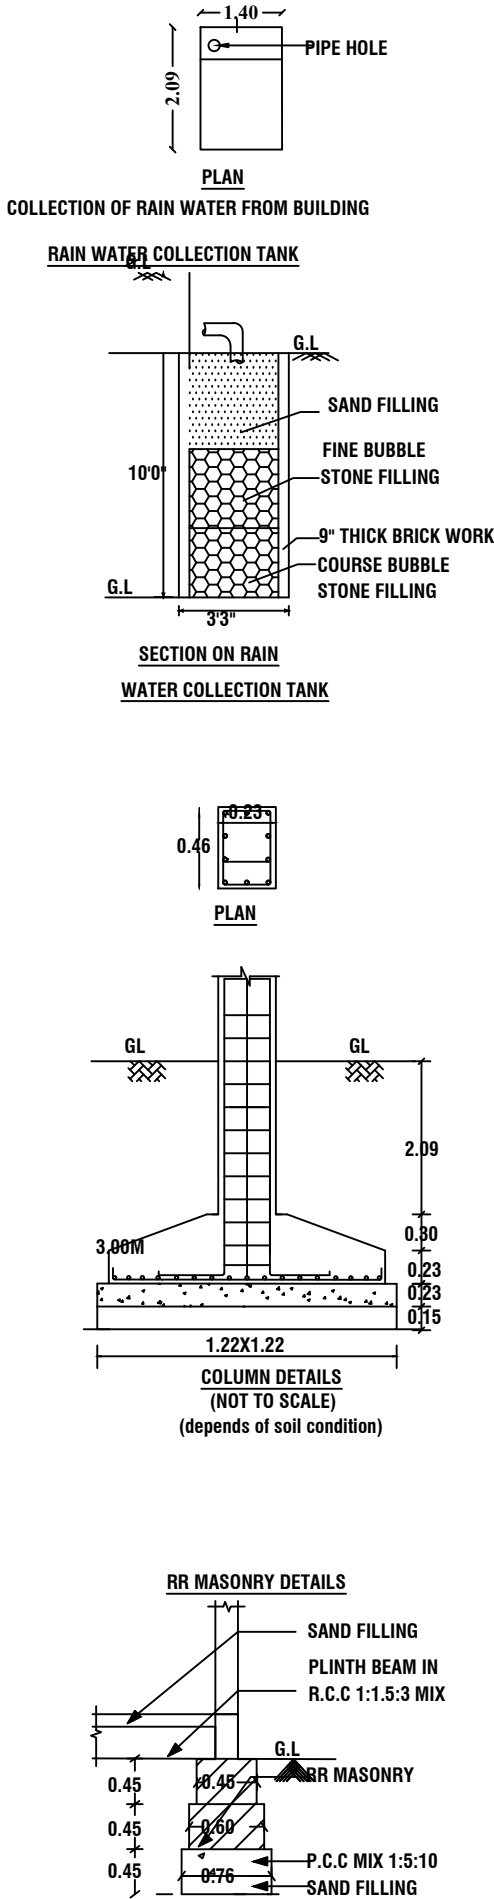

APPROVAL AUTHORITY (For office use only):

SITE PLAN:PROPOSED
SCALE 1:100

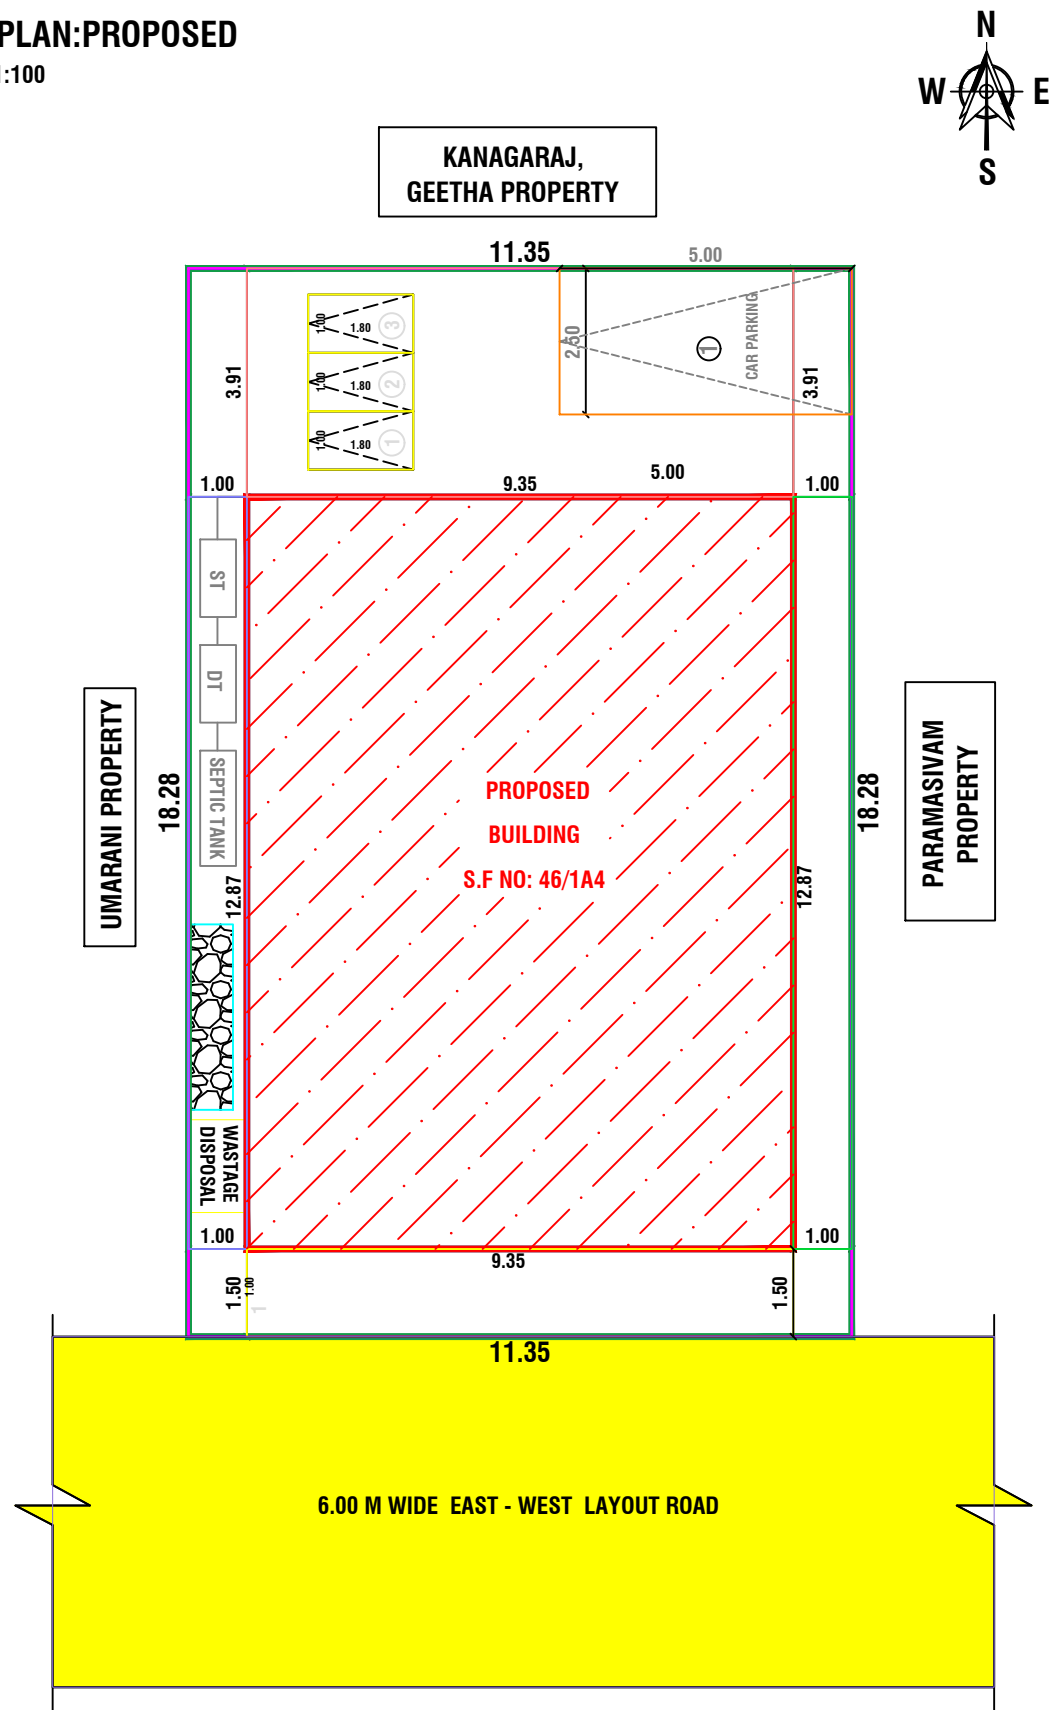

METER
1 X 2.13
10 X 2.13
16 X 2.13
10 X 2.13
12 X 1.21
1 X 1.21
12 X 1.21
10 X 0.61

AREA OF CALCULATION	SQ.FT	SQ.M
AREA OF PLOT EXTENT	2242.50	208.33
FMB/TLR PLOT EXTENT	2242.50	208.33
AREA AS PER DOCUMENT	2242.50	208.33
SUPER IMPOSED PLOT BOUNDARY	2242.50	208.33
AREA OF R.C.C BUILDING IN G.F	1295.23	120.33
AREA OF R.C.C BUILDING IN F.F	716.66	66.58
AREA OF OPEN SPACE	947.27	88.00
CARPET AREA OF G.F	641.85	59.63
CARPET AREA OF F.F	605.47	56.25
AREA OF STAIRCASE HEAD ROOM	134.01	12.45
PERCENTAGE OF SITE COVERAGE	-	57.75%
FLOOR SPACE INDEX[NON PREMIUM]	-	1.65

PARKING DETAILS:

NO.OF OPEN CAR PARKING	-	2 No's.
NO.OF OPEN TWO WHEELER PARKING	-	4 No's.

COLOURS OF INDEX:

EXISTING ROAD SHOWN IN	-	Yellow
BOUNDARY SHOWN IN	-	Green
PRO.BUILDING SHOWN IN	-	Red
RAIN WATER COLLECTION TANK	-	Blue

NAME OF THE OWNER:

Mr N.MOHANAPRASADH S/o Mr K.NAGARAJAN.

NOTE:-

- * ALL DIMENSIONS ARE IN METRE
- * ALL ROUND COMPOUND WALL PROVIDED.
- * RAINWATER PERCOLATION PITS PROVIDED ALL ROUND THE SITE.
- * S.T.P PROVIDED IN THE SE CORNER OF THE SITE.
- * SUMP AND FIRE SUMP PROVIDED.
- * LIGHTNING CONDUCTOR PROVIDED IN THE ROOF.
- * FIRE EXTINGUISHER & EMERGENCY ALARM IS PROVIDED.
- * BORE WELL WITH MOTAR, WATER TANK AND MUNICIPAL WATER SUPPLY WILL BE PROVIDED.
- * SULLAGE WASTE FROM TOILET WILL BE CONNECTED INTO SEPTIC TANK.
- * RAIN WATER PERCOLATION BED 1.0m WIDE PROVIDED AS PER GO (MS) NO: 138 DATED 11-02-02.
- * RAIN WATER TAKEN TO THE BORE WELL THROUGH 150MM DIA PIPES
- * SOLAR WATER HEATER WILL BE PROVIDED.
- * AT KITCHEN EXHAUST FAN TO BE PROVIDED.

REGISTERED ENGINEER:

Er Manivel., B.E., P.G Dip (Val),
Consulting/Registered Engineer,

DTCP.Reg.no:RE/Gr-II/001/Karur/June/2023,
KCMC-Reg.No:082/LS/2022/00003,
1000C, 2nd Floor, Kandavel Tower,
Covai Main road, Karur - 639 001.
Mobile :97870 20309, 8883367961
Email : buildmayan@gmail.com

