
 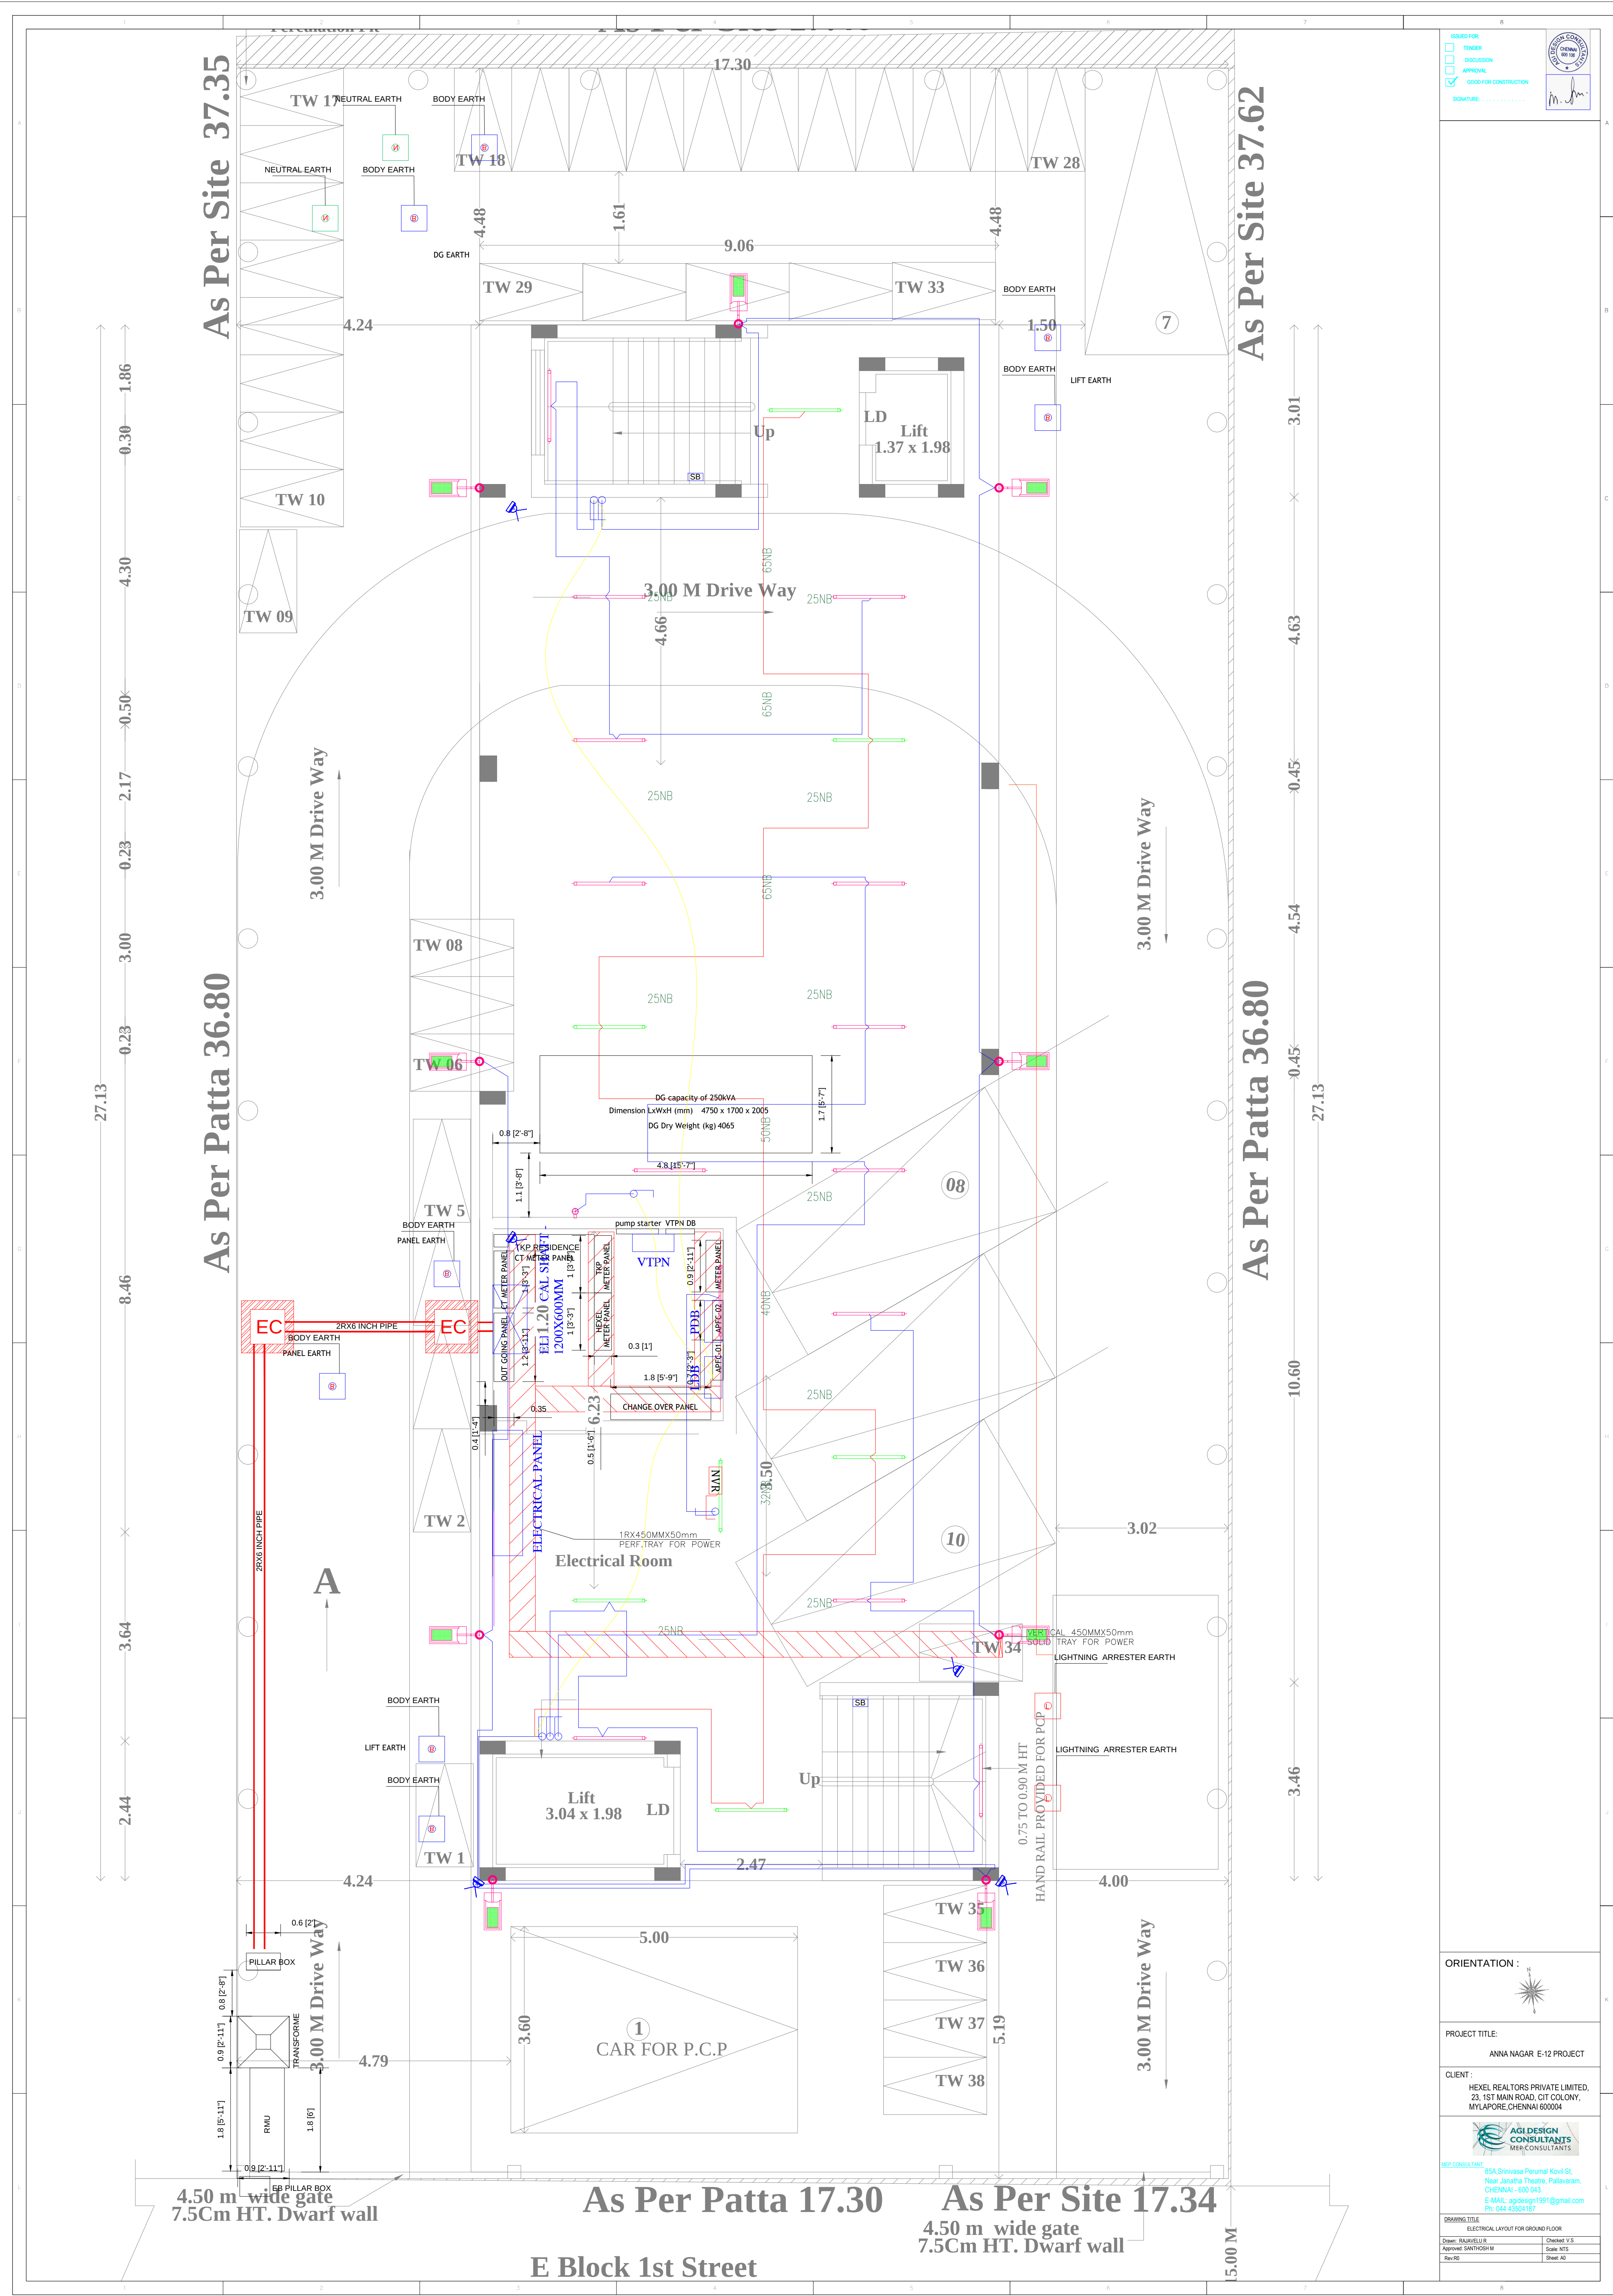




ISSUED FOR:
TENDER
DISCUSSION
APPROVAL
GOOD FOR CONSTRUCTION
SIGNATURE: 

ORIENTATION : 

PROJECT TITLE:
ANNA NAGAR E-12 PROJECT

CLIENT :
HEXEL REALTORS PRIVATE LIMITED,
23, 1ST MAIN ROAD, GT COLONY,
MYLAPORE, CHENNAI 600004

AGI DESIGN CONSULTANTS
MEMBER CONSULTANTS
B5A, Srinivasa Perumal Kovi St,
Near Janatha Theatre, Pallavaram,
CHENNAI - 600 043
E-MAIL: agidesign1991@gmail.com
Ph: 044 43504187

DRAWING TITLE
ELECTRICAL LAYOUT FOR GROUND FLOOR

Drawn: RAJANISULU	Checked: V/S
Approved: SANTOSH M	Scale: NTS
Rev: 01	Sheet: A0